


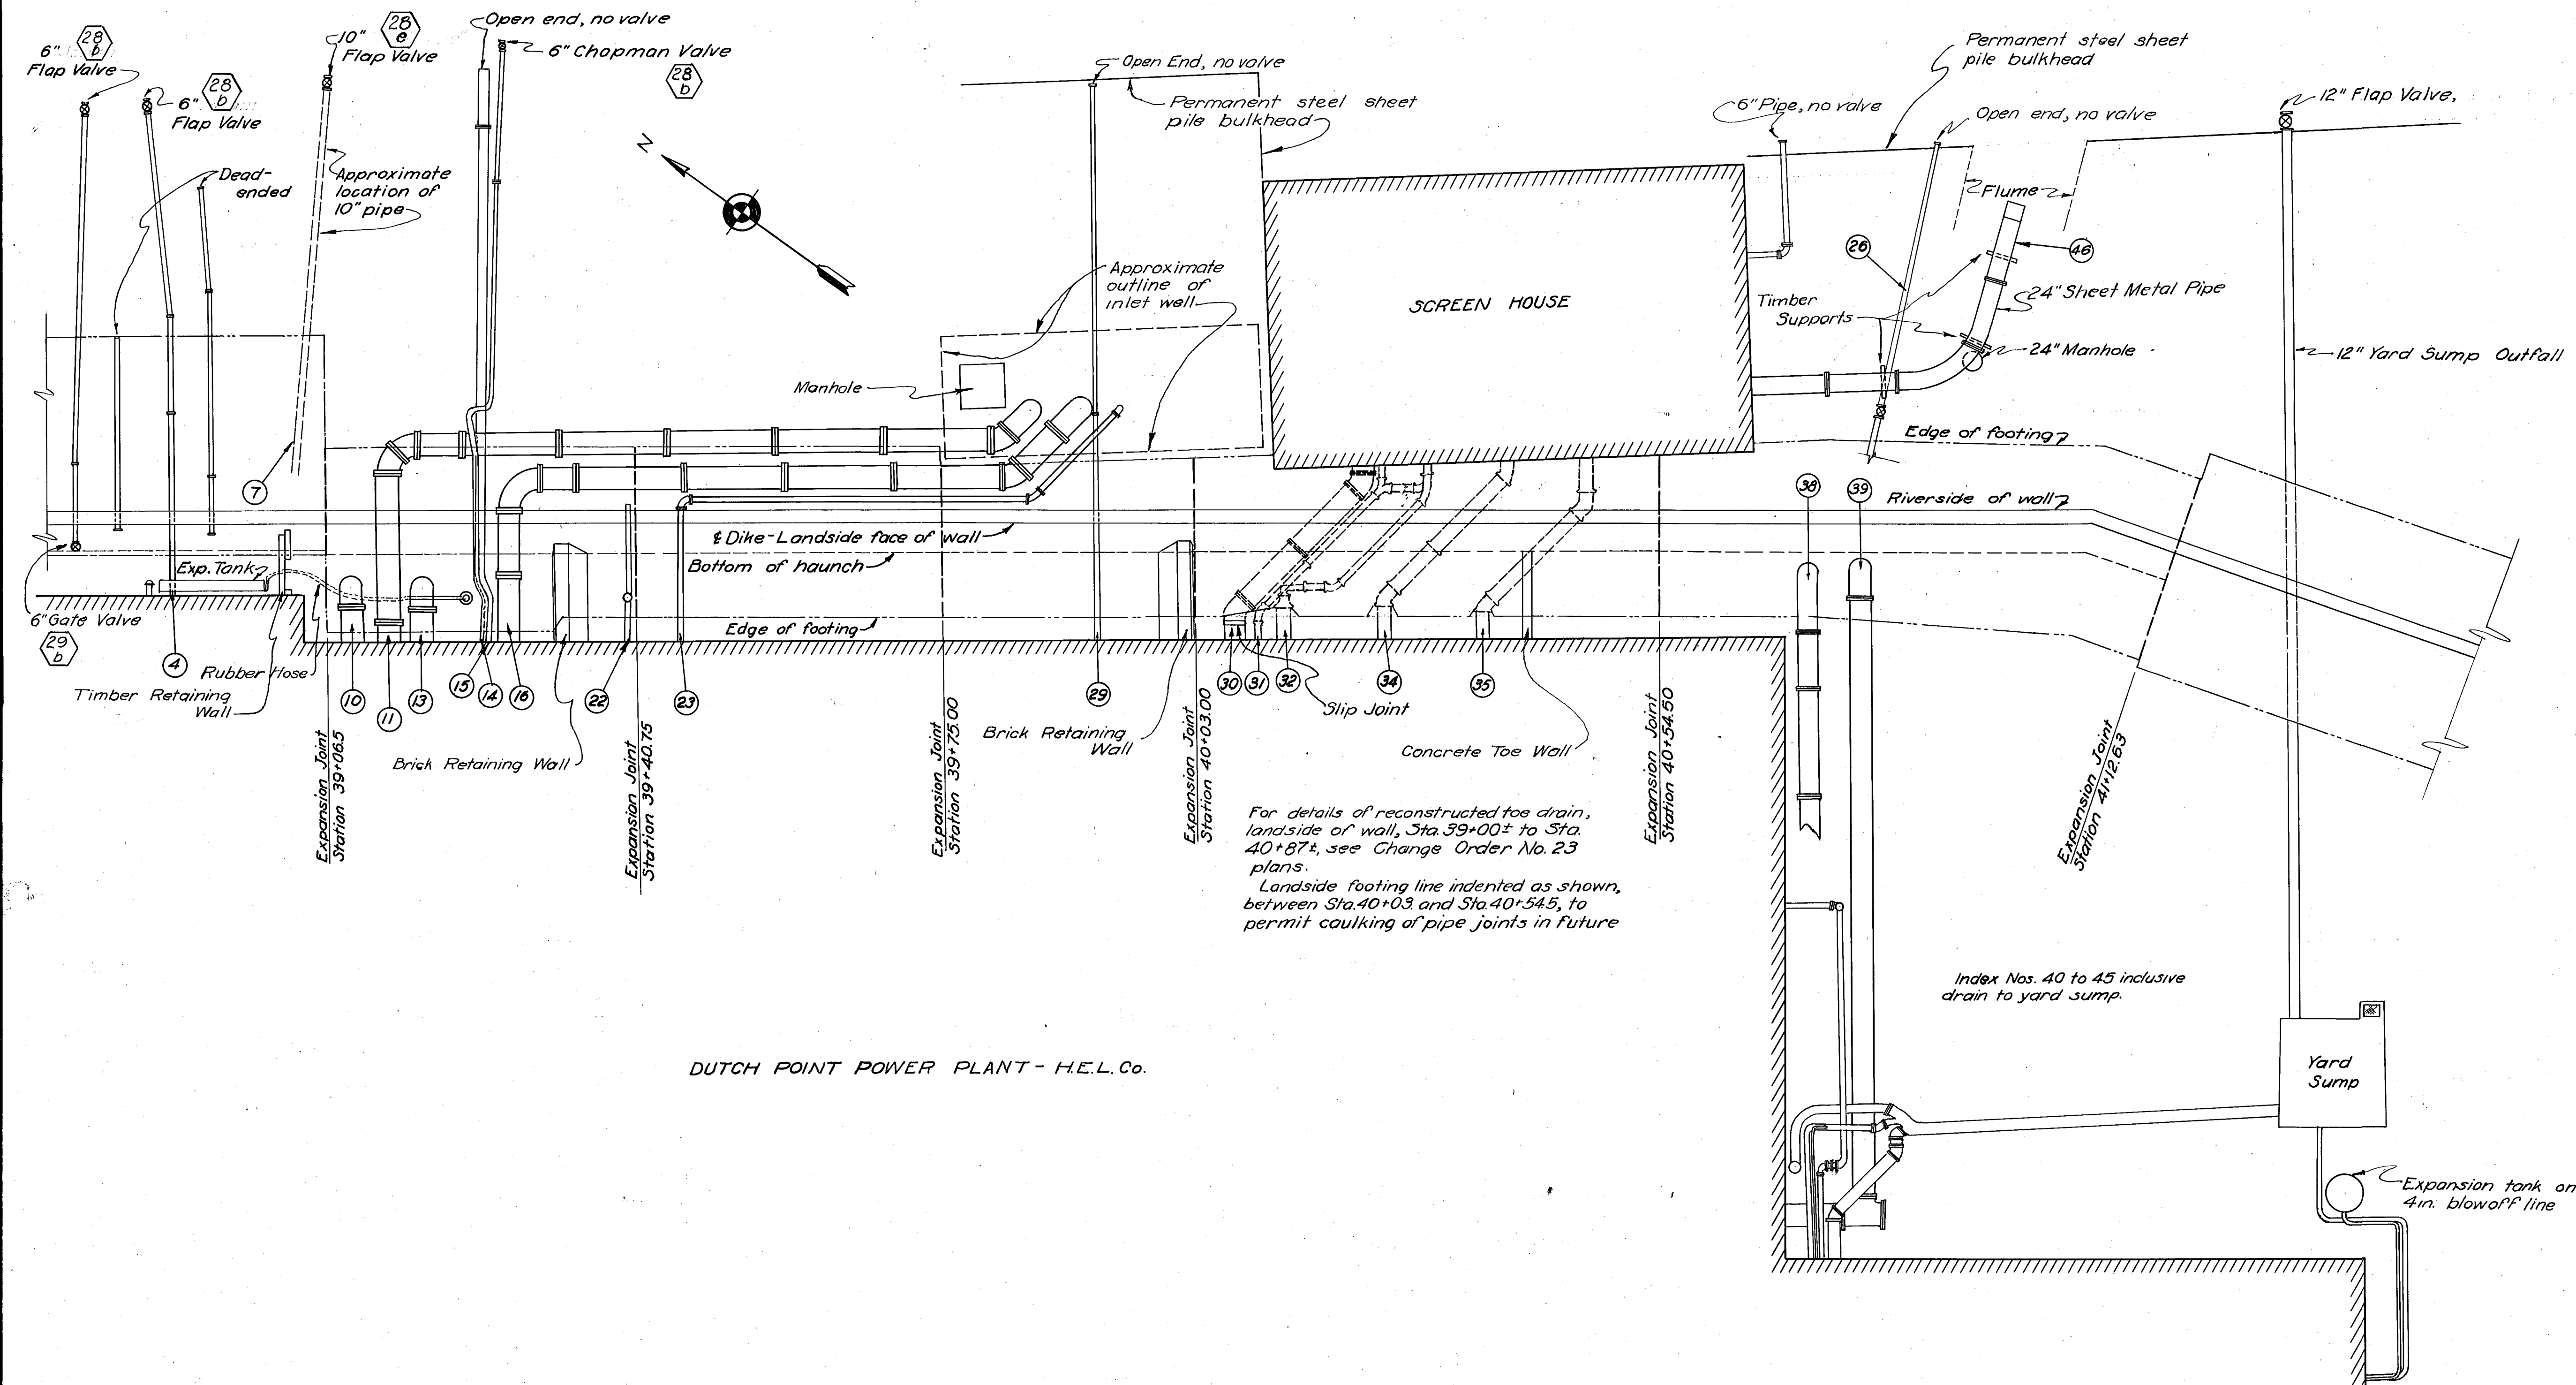

DUTCH POINT POWER PLANT - H.E.L. Co.

PLAN
Scale: 1"=10'

NOTES

Piping layout changed at the request of the Hartford Electric Light Co. All open end pipes shown are controlled by valves inside the station.

For index and profile, see Sheet No. 42 B

KEY	DATE	REVISION	REV. BY	CK. BY	AP. BY
	12-31-45	As built revisions			

THIS SHEET ADDED TO SET

CONNECTICUT RIVER FLOOD CONTROL
HARTFORD DIKE
RIVERFRONT, MORGAN ST. TO STA. 97+05
DETAIL PLAN-DUTCH PT. STATION

CONNECTICUT RIVER CONNECTICUT
IN 137 SHEETS SCALE: 1 IN.=10 FT. SHEET NO. 43A

U.S. ENGINEER OFFICE PROVIDENCE, R.I. DATE: FEB. 1943

SUBMITTED: APPROVAL: RECOMMENDED: APPROVED:

HEAD, DESIGN SECTION CHIEF, ENGINEERING DIV. COE., CORPS OF ENGRS.

PREPARED: DRAWN BY: DISTRICT ENGINEER

RESIDENT ENGINEER CHECKED BY: E.P.C. FILE NO: CT-4-3146

H-15-476 #39

(43A)