


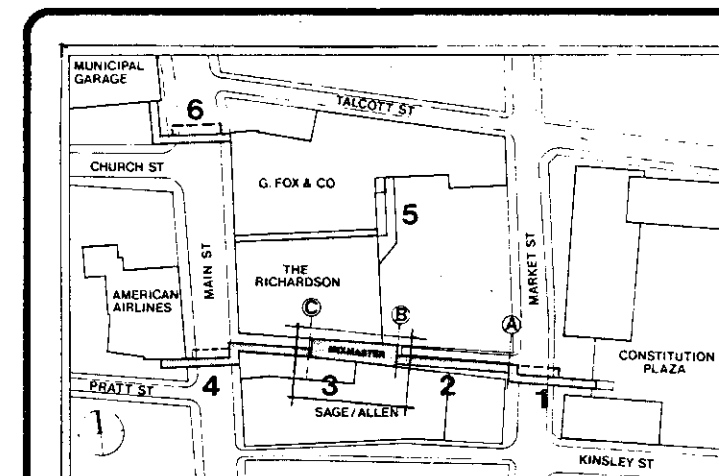

Key Plan
Numbers Indicate Walk System Segments



Issue Dates Prior to Full Release

Date of Issue	Is this identical to last issue?	Issued to	Use restrictions
7/24/79	Yes	N/A	NO BIDDING ELEC. MECH.

Date of Issue	Is this identical to last issue?	Issued to	Use restrictions

Use and Interpretation of This Drawing


THIS DRAWING IS THE PROPERTY OF IRWIN JOSEPH HIRSCH & ASSOCIATES, INC. AND IS TO BE USED ONLY FOR THE PROJECT AND SITE SPECIFICALLY IDENTIFIED HEREON. IT IS NOT TO BE REPRODUCED, COPIED, OR TRANSMITTED IN ANY FORM OR BY ANY MEANS, ELECTRONIC OR MECHANICAL, INCLUDING PHOTOCOPYING, RECORDING, OR BY ANY INFORMATION STORAGE AND RETRIEVAL SYSTEM, WITHOUT THE WRITTEN PERMISSION OF IRWIN JOSEPH HIRSCH & ASSOCIATES, INC. ANY VIOLATION OF THIS NOTICE SHALL BE SUBJECT TO LEGAL ACTION.

THE RELEASE OF THIS DRAWING IS SUBJECT TO THE FOLLOWING CONDITIONS:
1. THE DRAWING IS TO BE USED ONLY FOR THE PROJECT AND SITE SPECIFICALLY IDENTIFIED HEREON.
2. THE DRAWING IS NOT TO BE REPRODUCED, COPIED, OR TRANSMITTED IN ANY FORM OR BY ANY MEANS, ELECTRONIC OR MECHANICAL, INCLUDING PHOTOCOPYING, RECORDING, OR BY ANY INFORMATION STORAGE AND RETRIEVAL SYSTEM, WITHOUT THE WRITTEN PERMISSION OF IRWIN JOSEPH HIRSCH & ASSOCIATES, INC.
3. THE DRAWING IS NOT TO BE USED FOR ANY OTHER PROJECT OR SITE WITHOUT THE WRITTEN PERMISSION OF IRWIN JOSEPH HIRSCH & ASSOCIATES, INC.
4. THE DRAWING IS NOT TO BE USED FOR ANY OTHER PURPOSE WITHOUT THE WRITTEN PERMISSION OF IRWIN JOSEPH HIRSCH & ASSOCIATES, INC.

Revisions after Partial or Full Release

Mark	Date	Nature of Revision	Quantity
1	7/24/79	TO GIVE SAGE ALLEN ORIGINAL SUPPLY LOG TO 3"	NO MARK

Construction Manager
Cronin Construction Services Corporation
Box 14510 Barry Square Station
Hartford, Ct. 06114 203/278-1540

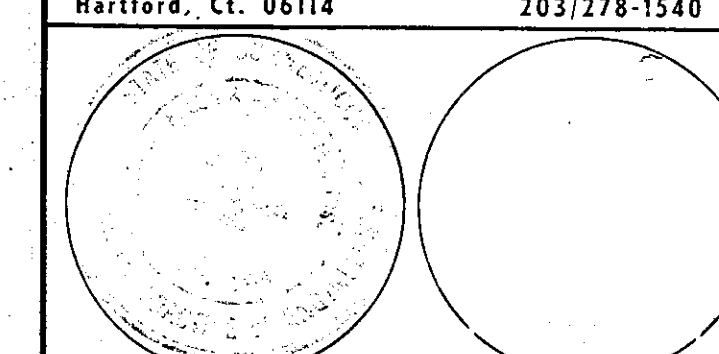

Mechanical Engineers
Koton, Allen & Associates, Inc.
510 Cottage Grove Road
Bloomfield, Ct. 06002 203/243-1701

Landscape Architect
Johnson & Deo
Brownstone Court
Aven. Ct. 06001 203/678-0669




PLANS PREPARED BY
IRWIN JOSEPH HIRSCH & ASSOCIATES, INC.
291 FARMINGTON AVE. / FARMINGTON, CT. 06032
203/677-0273


FIRE 203-278-1540

Hartford Walk System - Mixmaster
Hartford, Connecticut


Project Number: JH-210-II
Drawing Number: SP. 2
Scale: 1/8" = 1'-0"

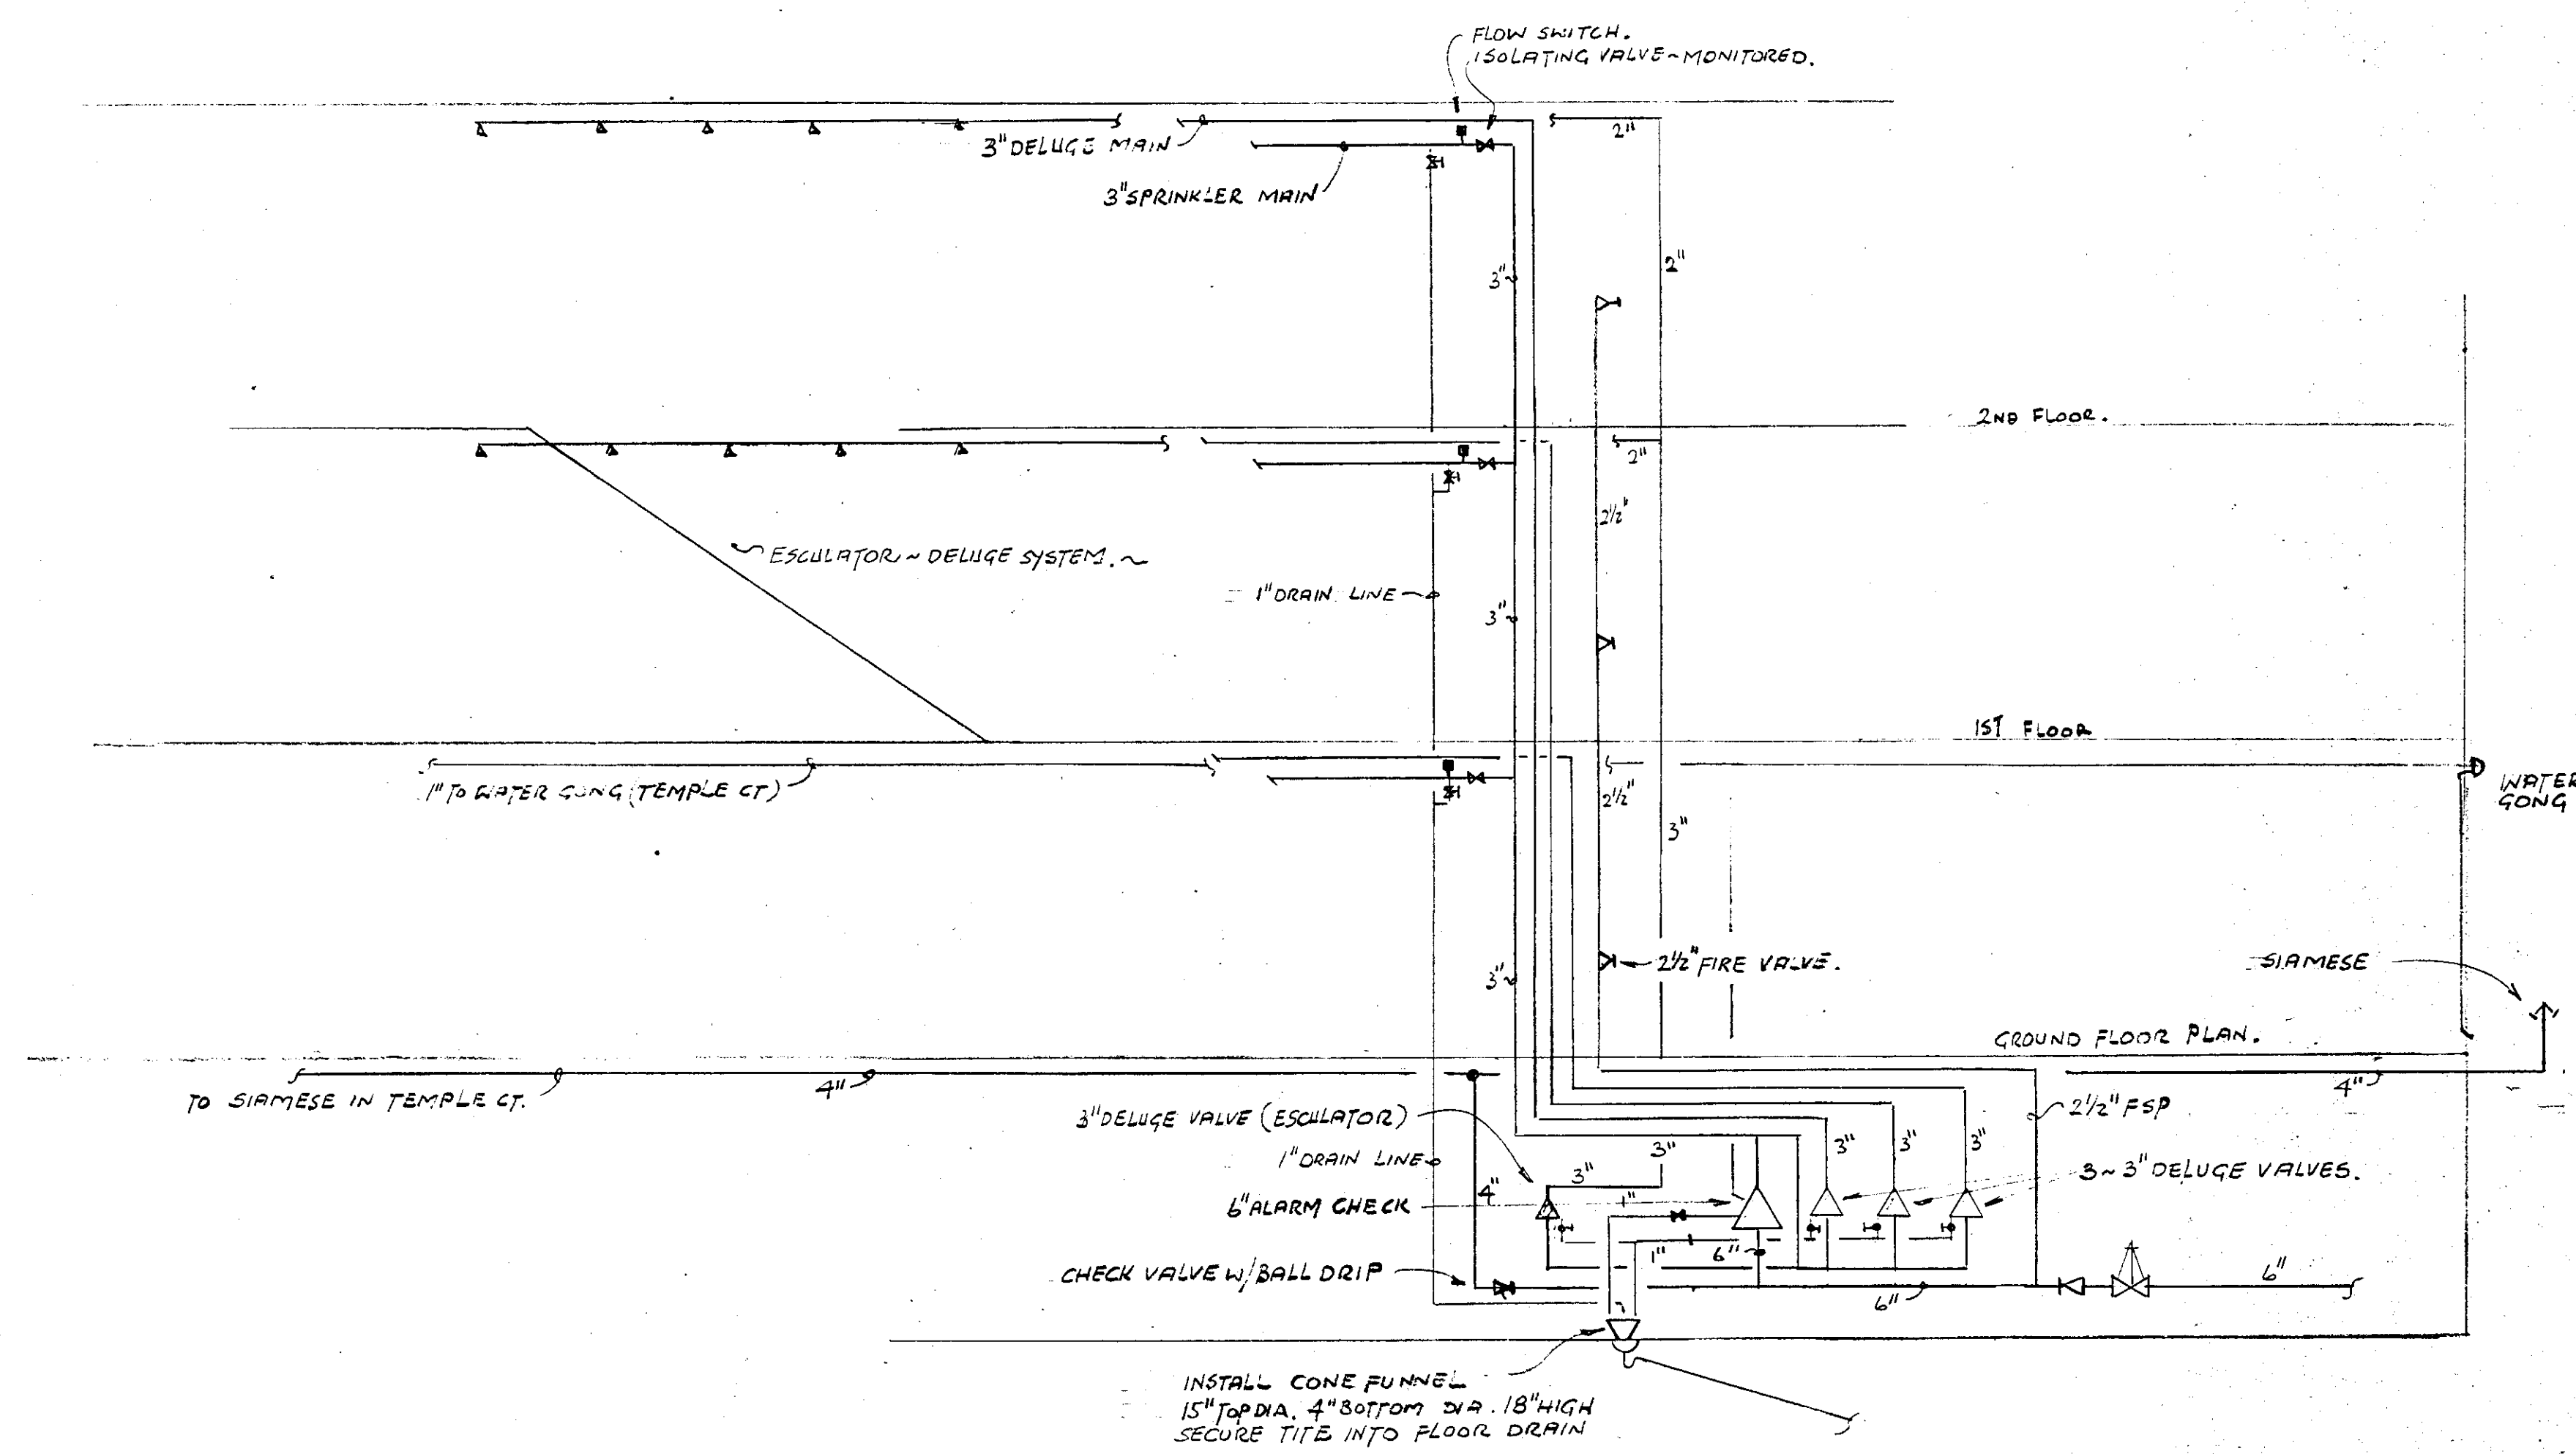

SPRINKLER & STANDPIPE RISER DIAGRAM.

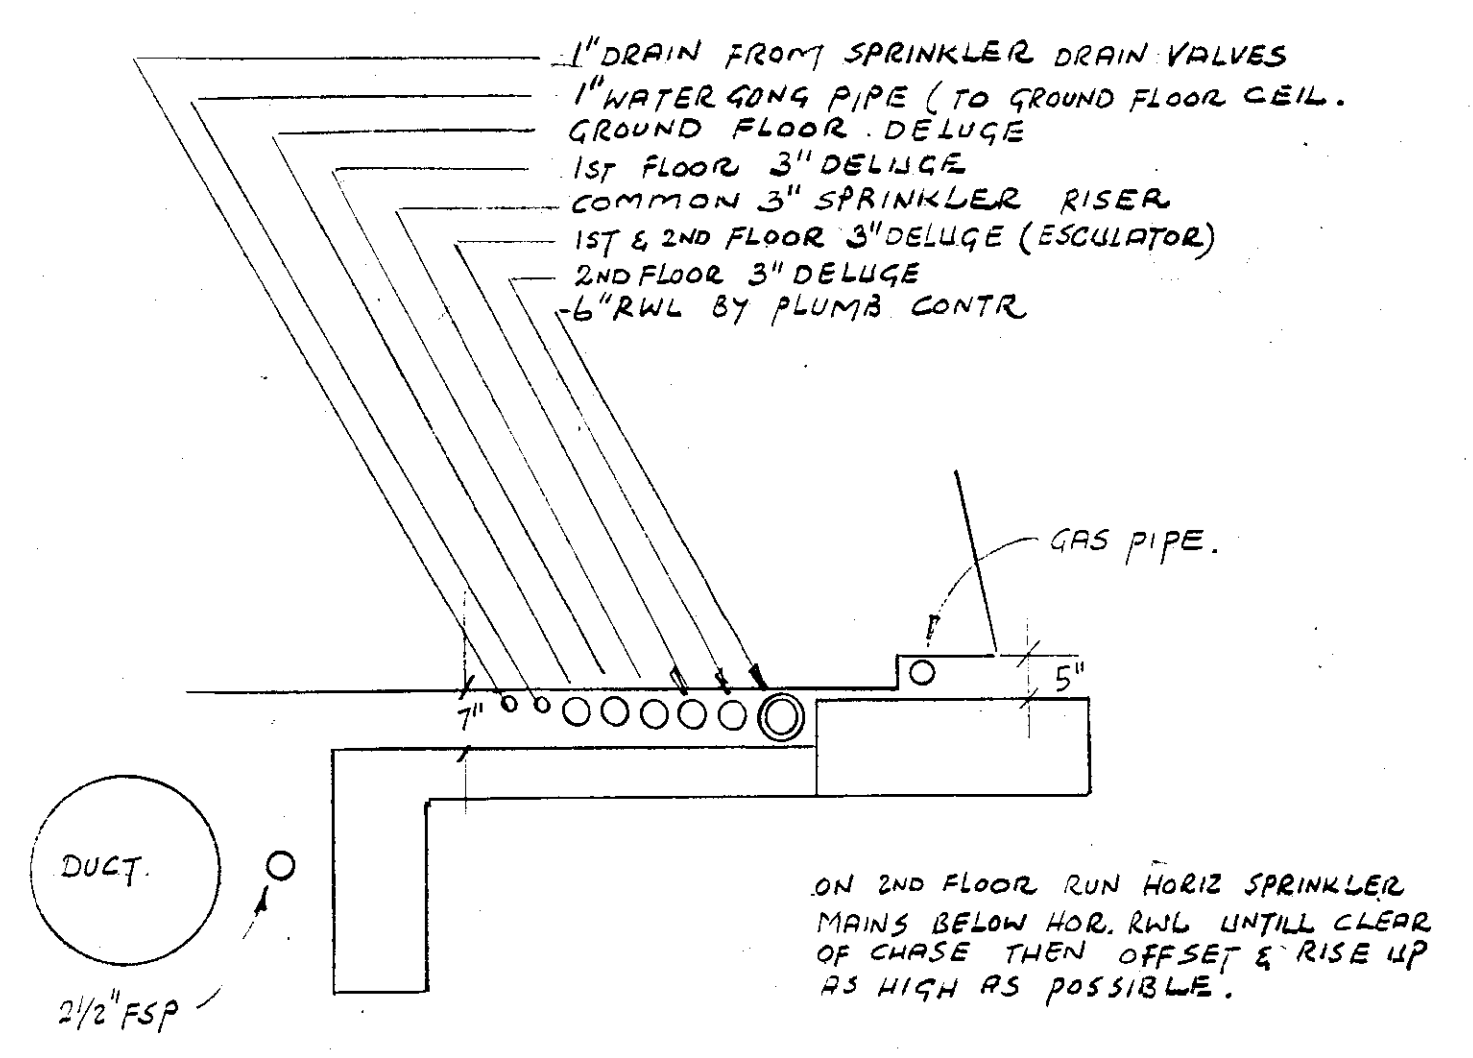

DETAIL OF CHASE SPACE. SCALE 3/8" = 1'-0"

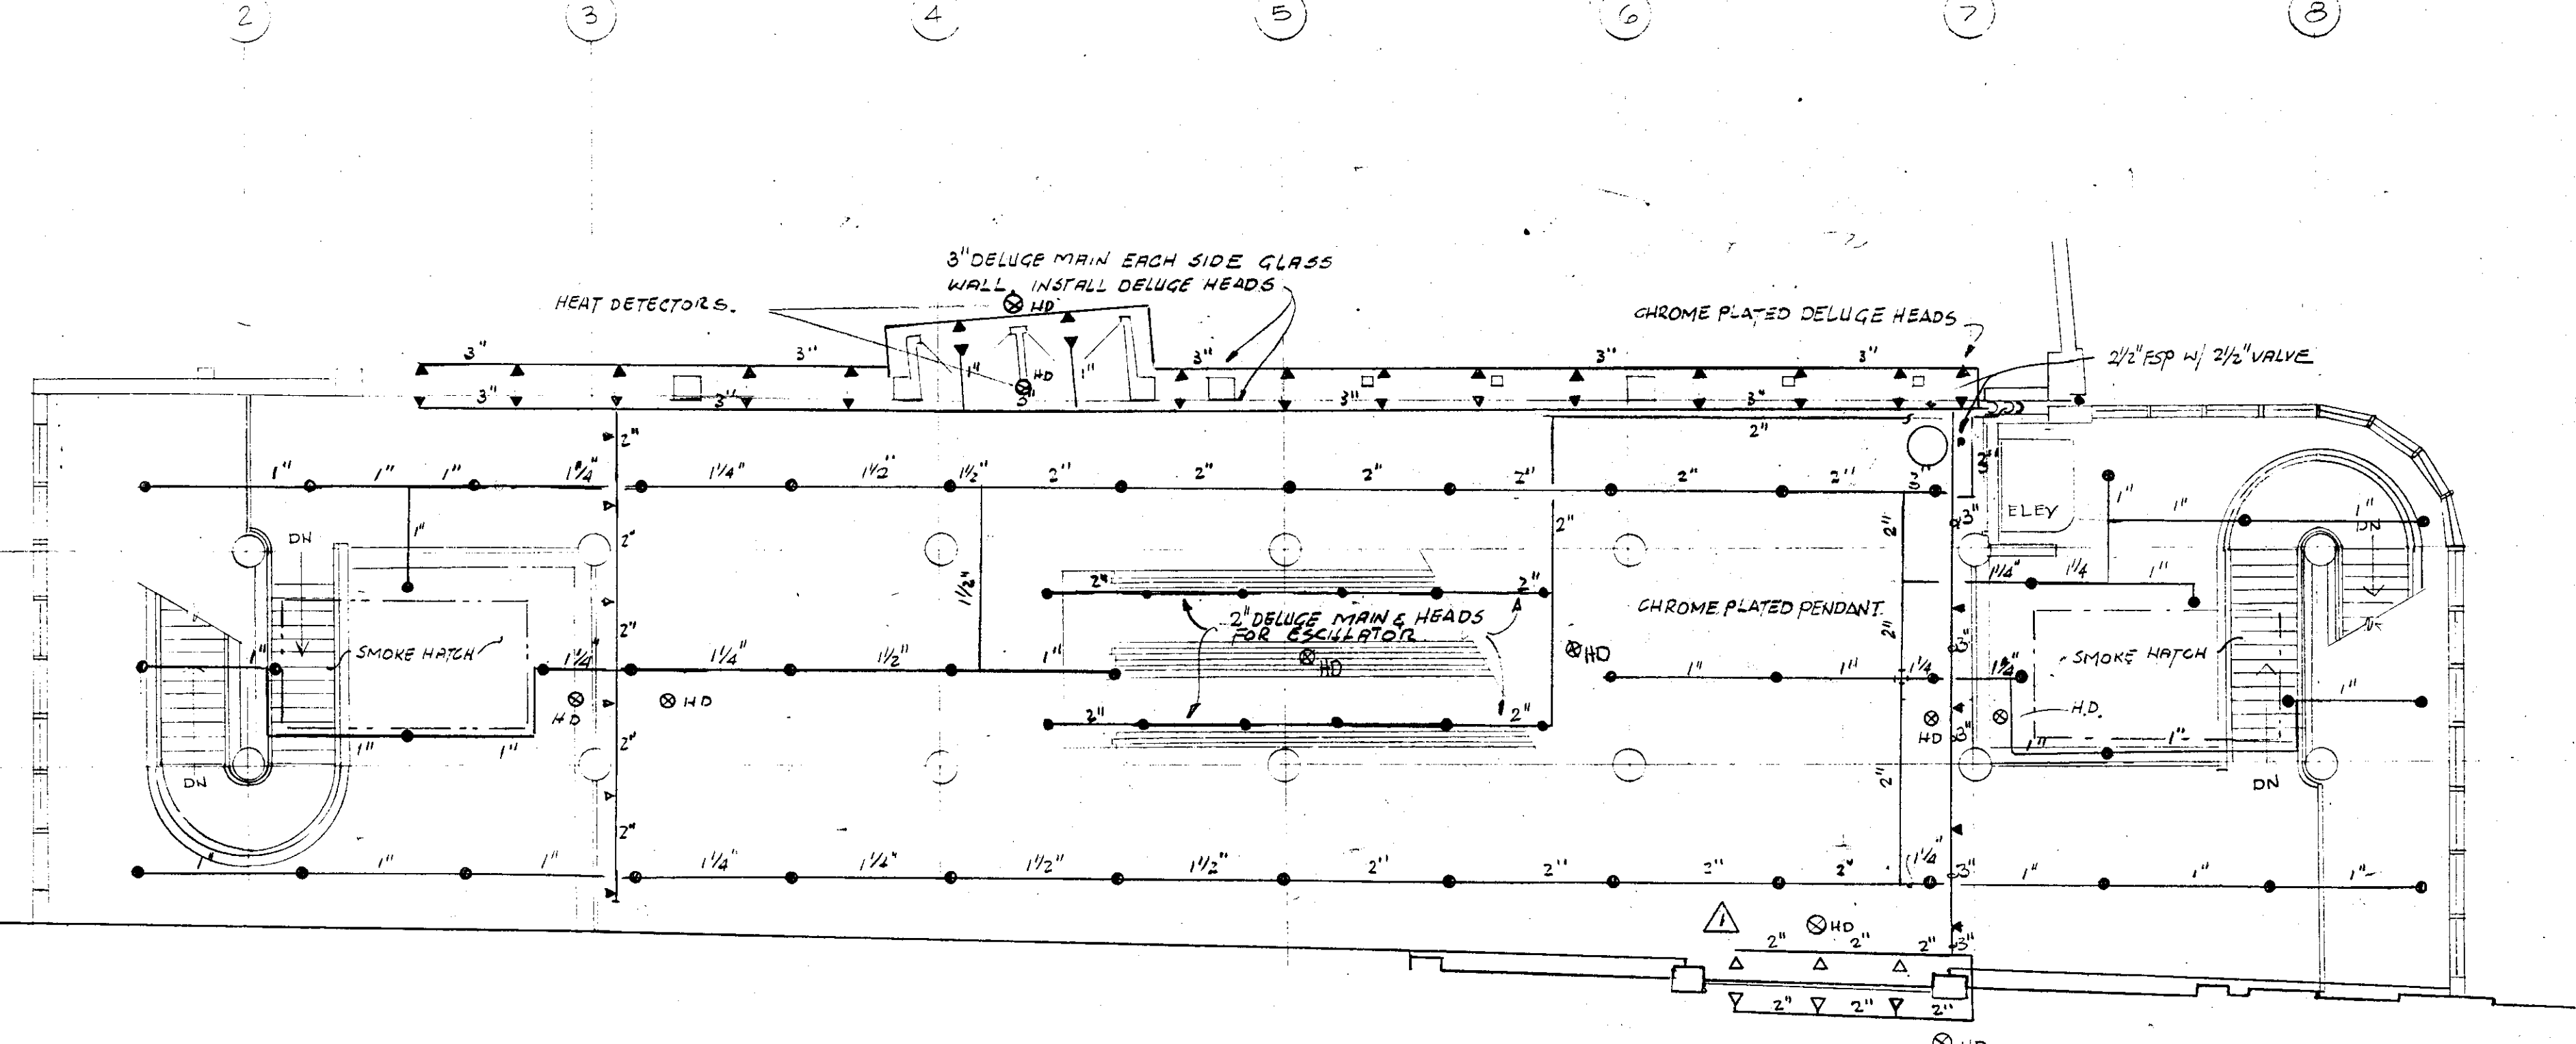

HD DENOTES HEAT DETECTOR LOCATIONS FOR OPERATION OF DELUGE SYSTEMS. (HD BY ELEC. CONTR.)

ALL SPRINKLER PIPING TO BE INSTALLED AS HIGH AS POSSIBLE. RUN THRU CONCRETE BEAMS. SLEEVES BY SPRINKLER CONTR.

SECOND FLOOR PLAN (EL 89.955)
SCALE: 1/8" = 1'-0"