


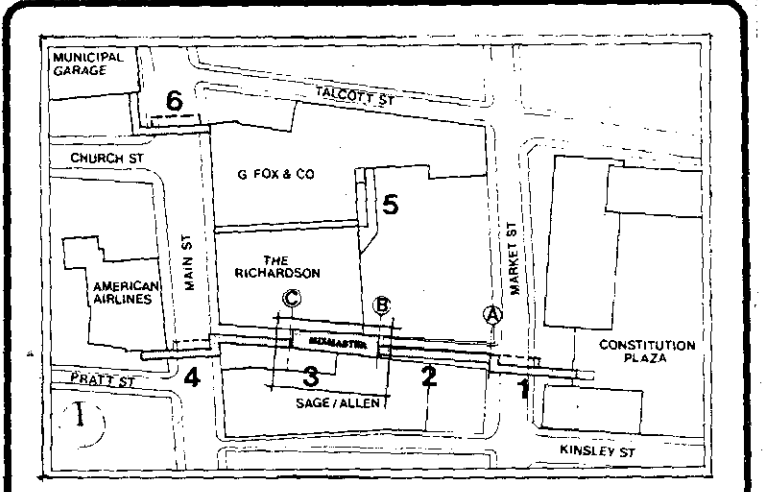

Key Plan
Numbers indicate Walk System Segments

Issue Dates Prior to Full Release

Date of Issue	Is this drawing to be printed?	Issued to	Use restrictions
12/4/77	N/A	BIDDERS	FOR BIDDING ONLY

Use and Interpretation of This Drawing

The user of this drawing is advised that the user of this drawing is responsible for the interpretation of the drawing and for the accuracy of the information derived therefrom. The user of this drawing is advised that the user of this drawing is responsible for the interpretation of the drawing and for the accuracy of the information derived therefrom.

☐ UNLESS OTHERWISE NOTED, ALL DIMENSIONS ARE IN FEET AND INCHES. DIMENSIONS ARE TO FACE UNLESS OTHERWISE NOTED.

☒ ALL DIMENSIONS ARE TO FACE UNLESS OTHERWISE NOTED.

☒ ALL DIMENSIONS ARE TO FACE UNLESS OTHERWISE NOTED.

Revisions after Partial or Full Release

Mark	Date	Nature of revision	Quantity of revisions
1	12/4/77	DELUGE SYSTEM EXTENDED TO GROUND FLOOR	1

Revisions after Partial or Full Release

Mark	Date	Nature of revision	Quantity of revisions
1	12/4/77	DELUGE SYSTEM EXTENDED TO GROUND FLOOR	1

Construction Manager
Cronin Construction Services Corporation
Box 14510, Barry Square Station
Hartford, Ct. 06114 203/278-1540

Mechanical Engineers
Koton, Allen & Associates, Inc.
510 Cottage Grove Road
Bloomfield, Ct. 06002 203/243-1701


Landscape Architect
Johnson & Deo
Bromfield Court
Avon, Ct. 06001 203/678-0669

PLANS PREPARED BY
ARCHITECTS
IRWIN JOSEPH HIRSH & ASSOCIATES, INC.
231 FARMINGTON AVE. / FARMINGTON, CT. 06032
203/677-0273


FIRE PROTECTION SYSTEM

Hartford Walk System - Mixmaster
Hartford, Connecticut


Project Number: 11H-210-II
Drawing Number: SP.1
Scale: 1/8" = 1'-0"

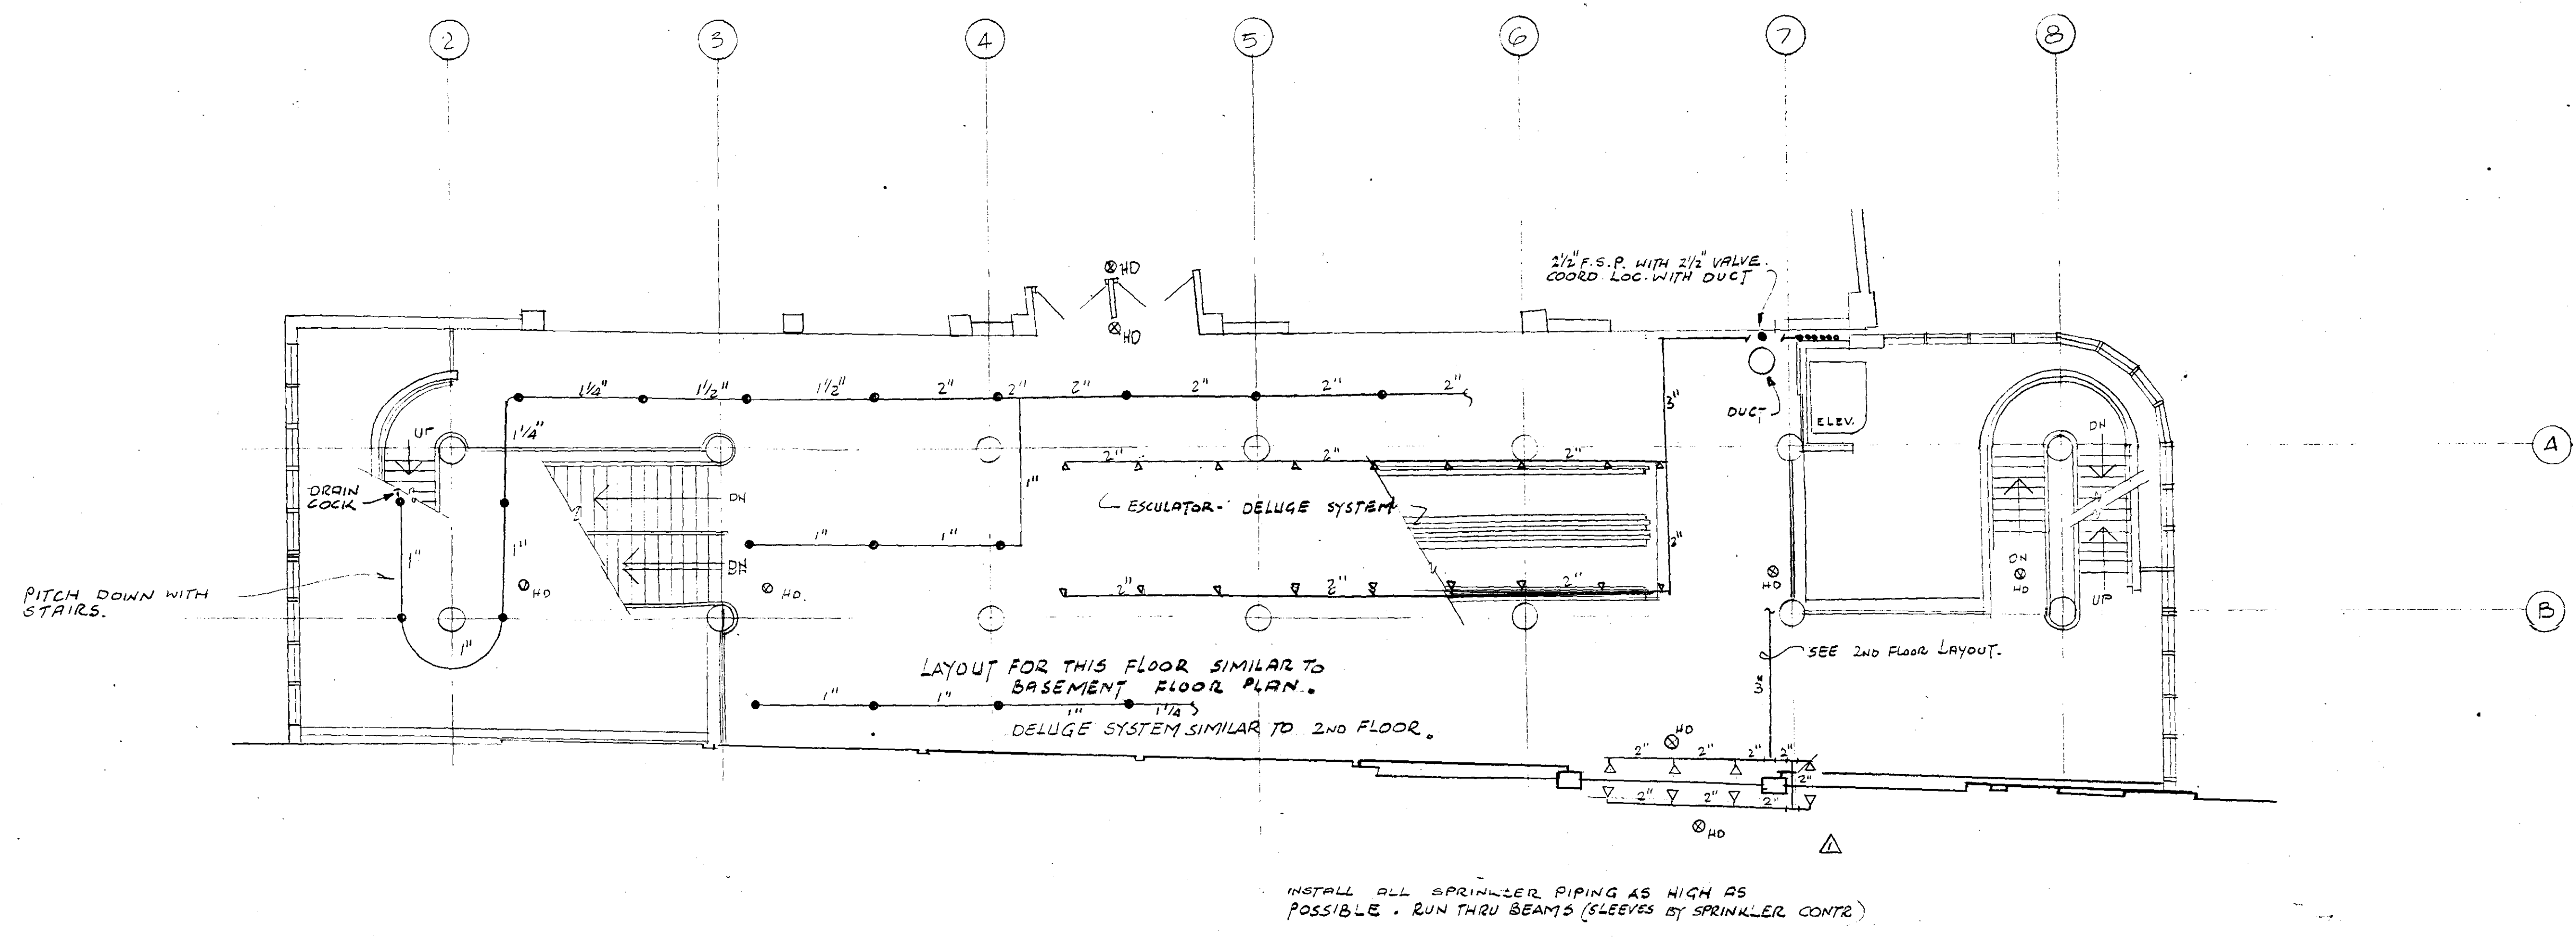

FIRST FLOOR PLAN (CEL 73.285)
SCALE: 1/8" = 1'-0"

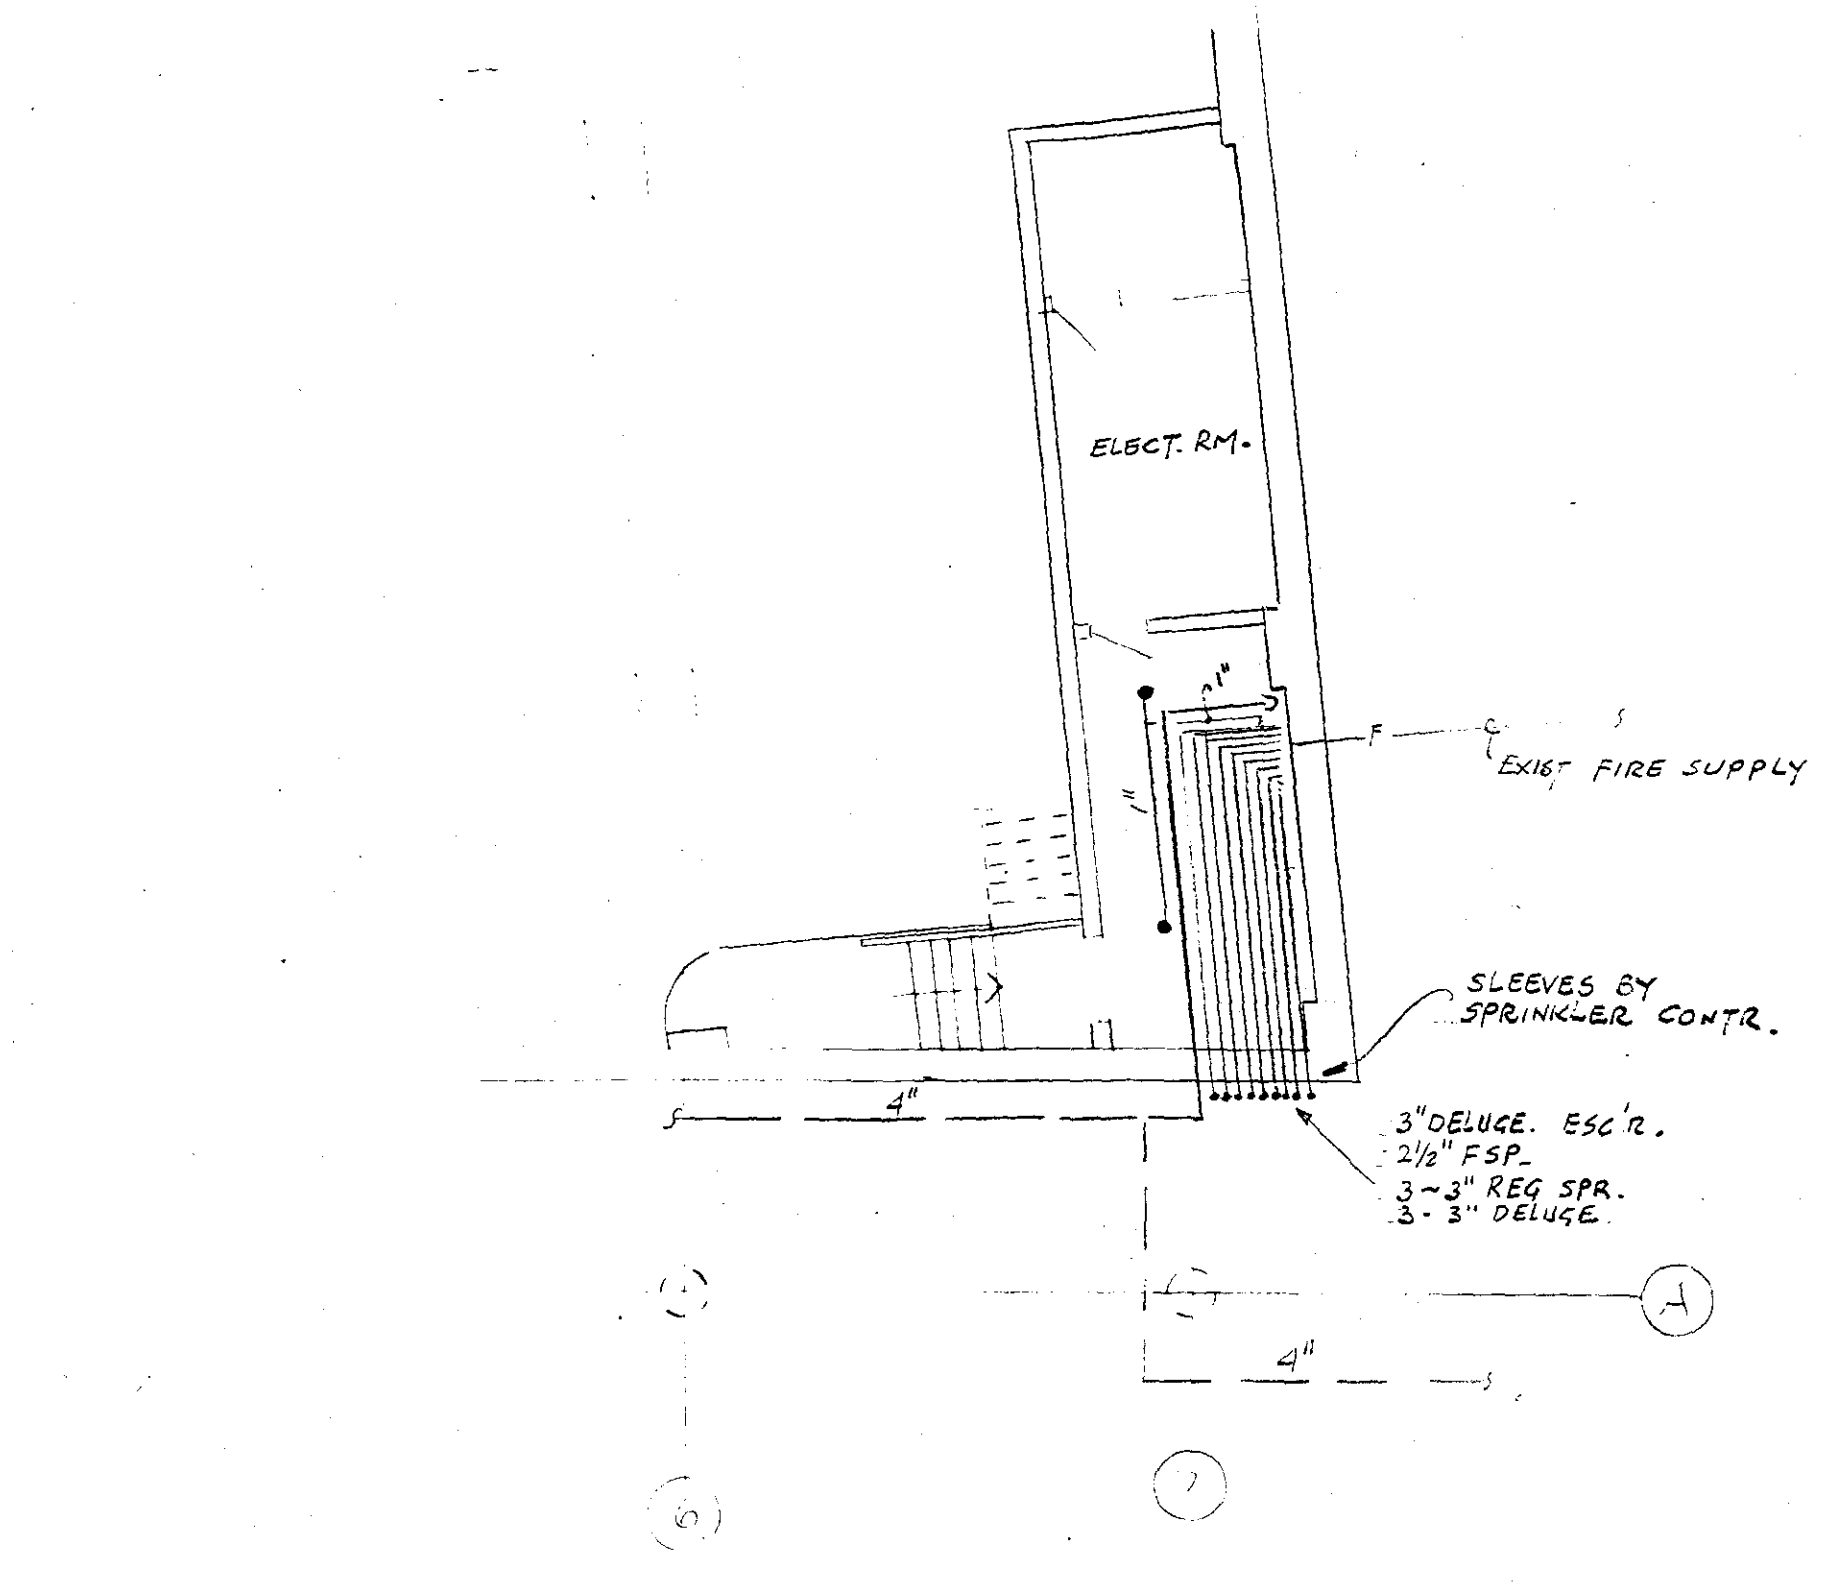

SUB-BASEMENT FLOOR PLAN (CEL 47.140)
SCALE: 1/8" = 1'-0"

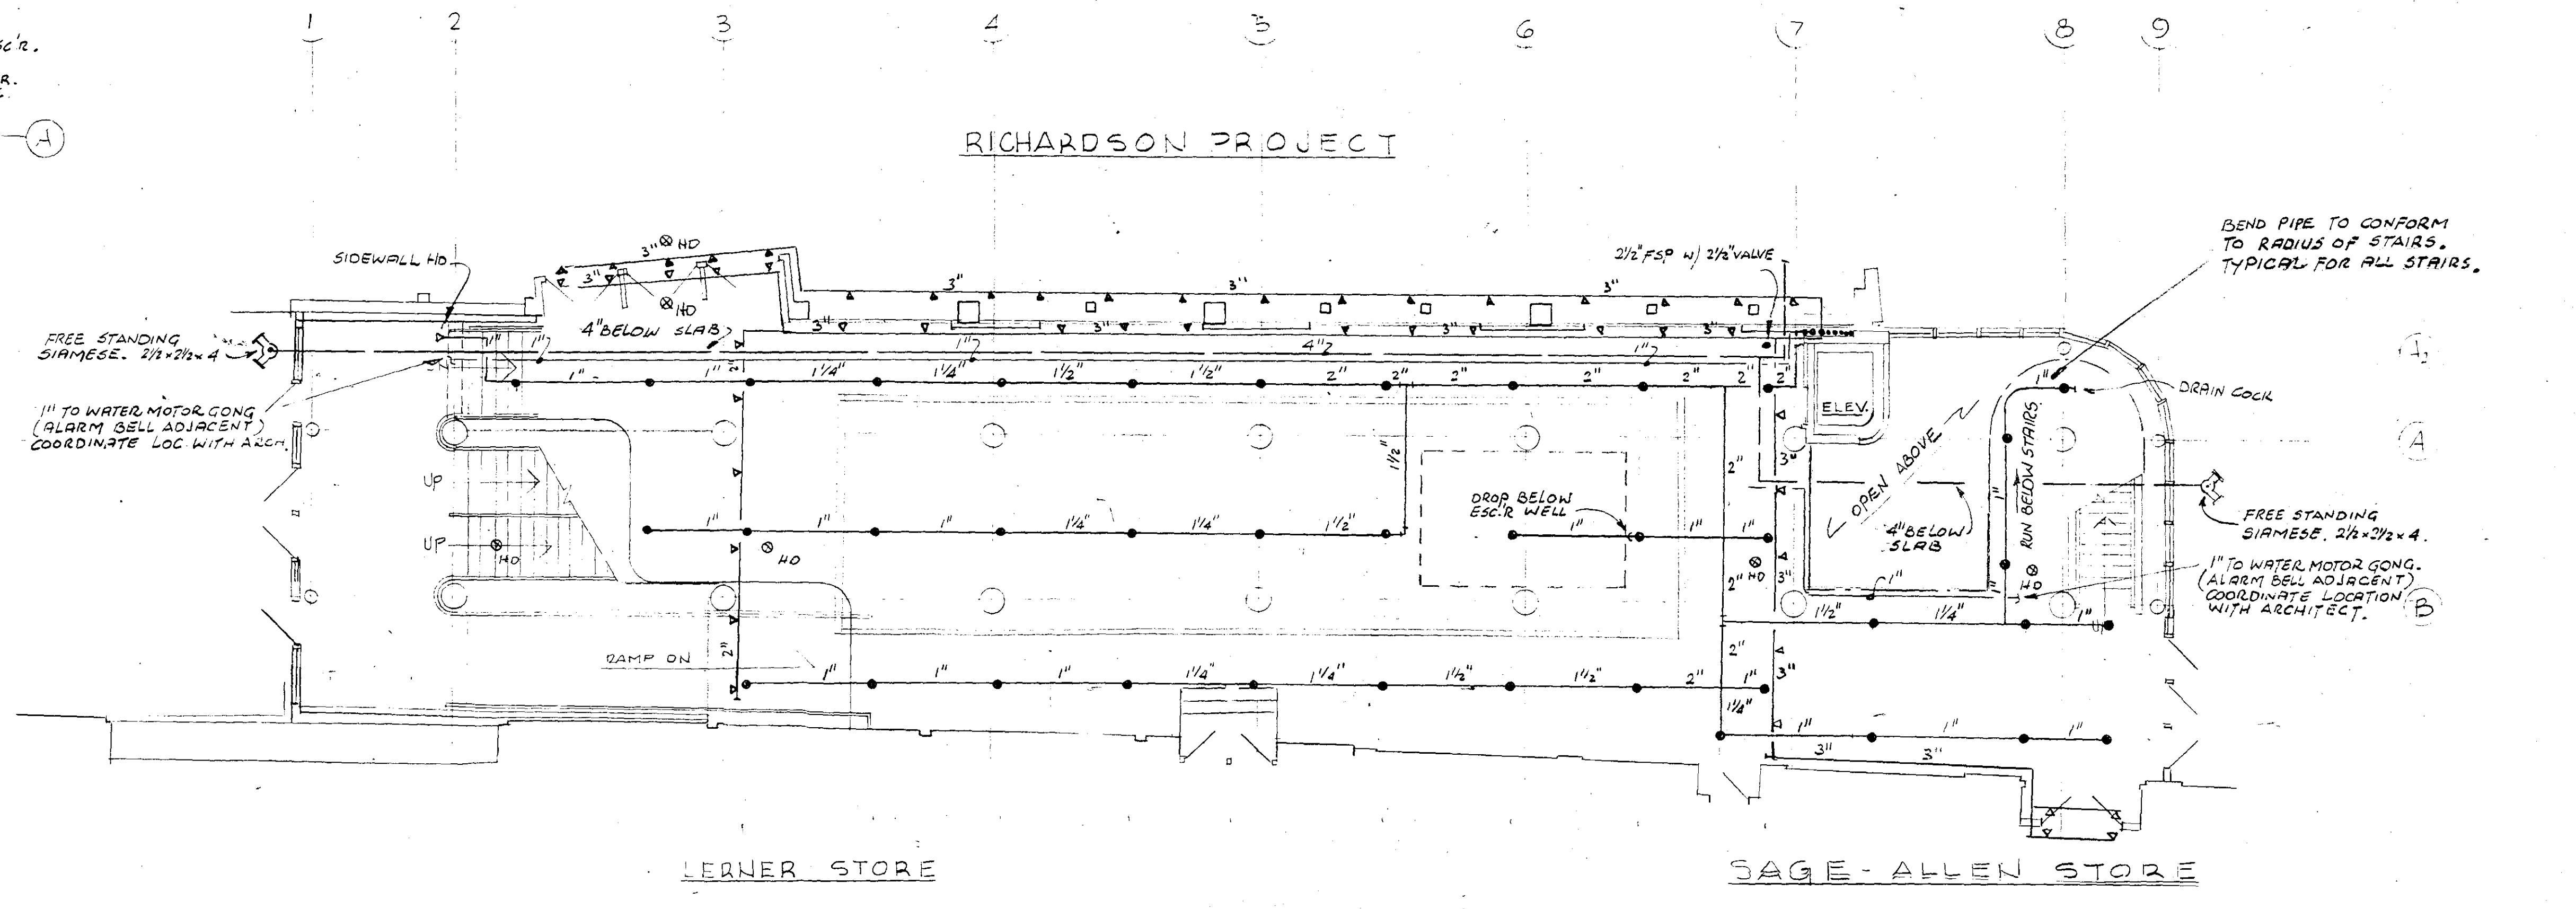

GROUND FLOOR PLAN (CEL 59.720 / 63.685)
SCALE: 1/8" = 1'-0"