

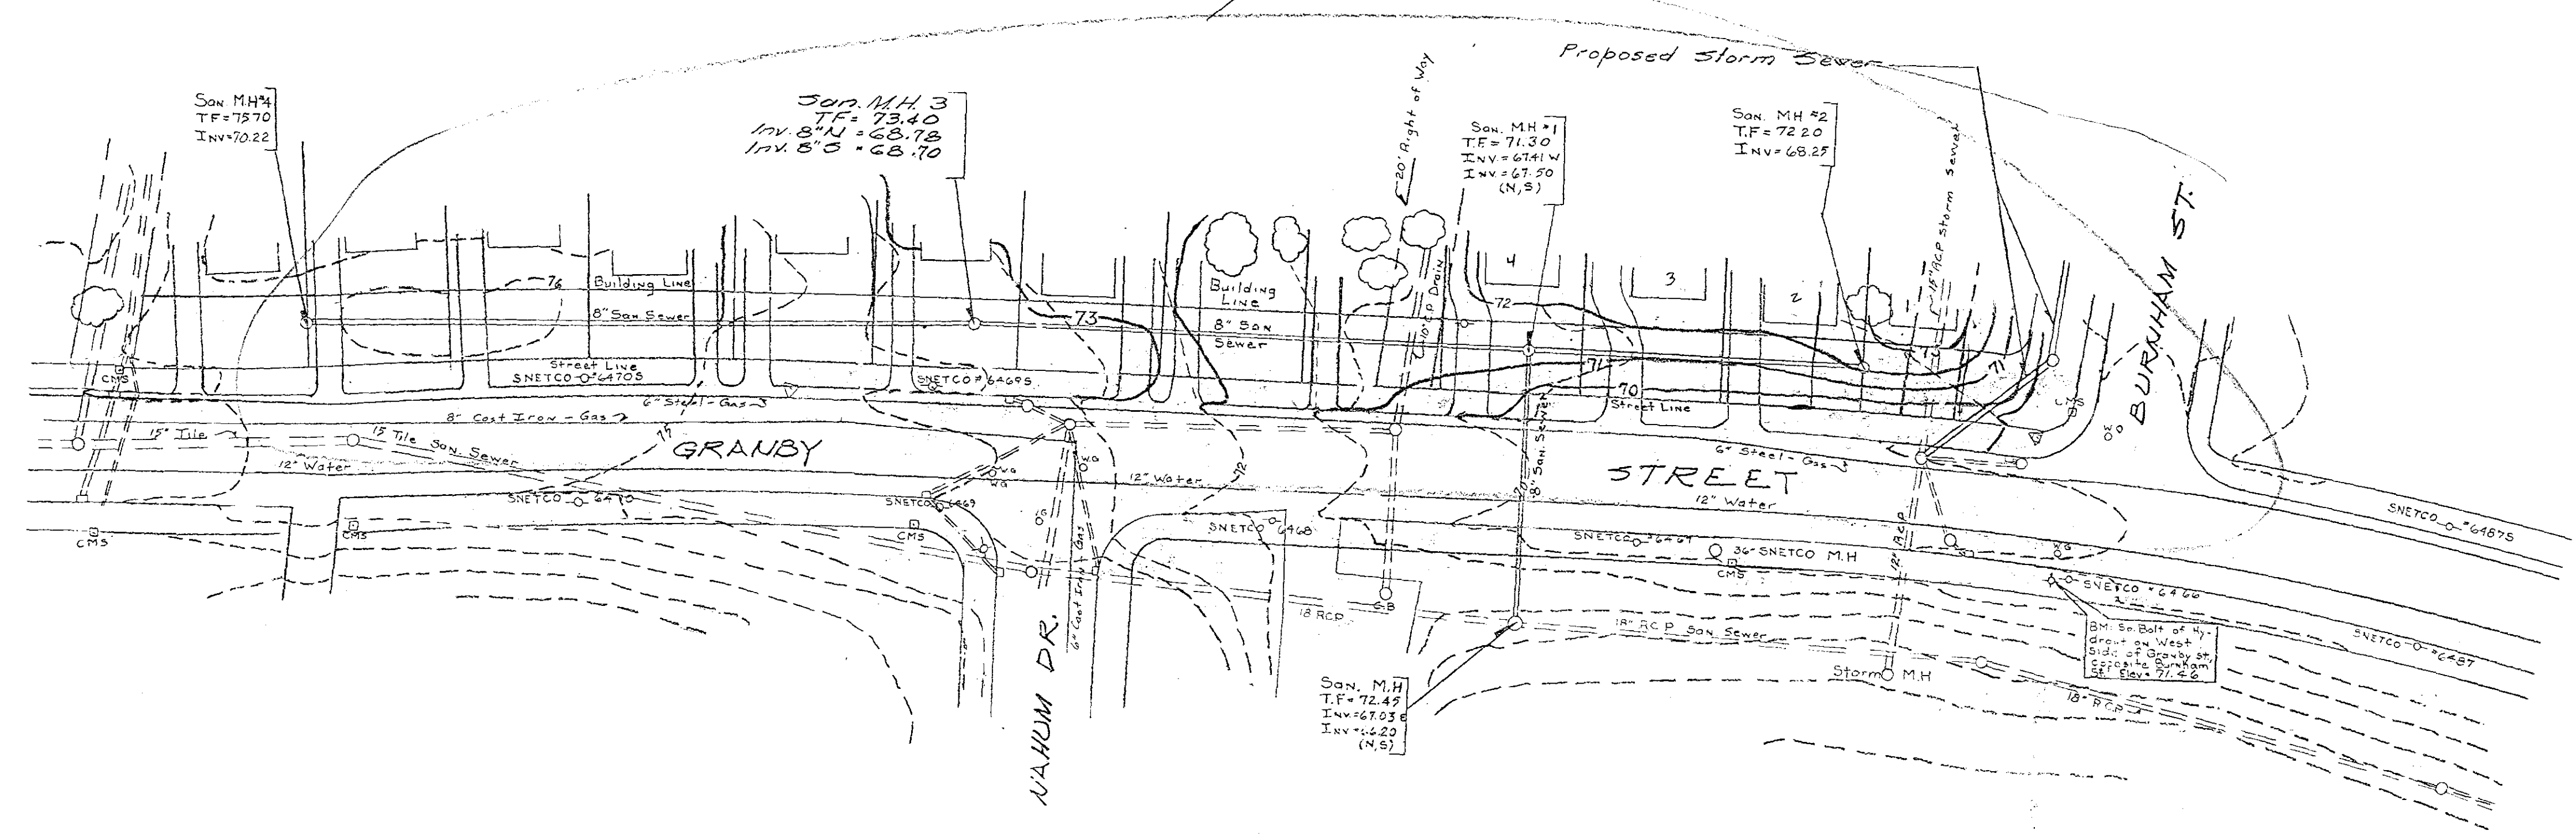
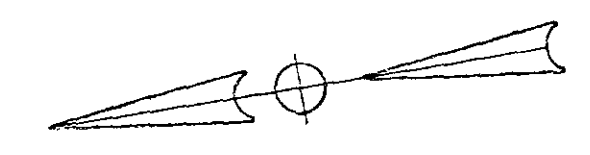


Size all future
this subdivision
dred and shall be
other plans.

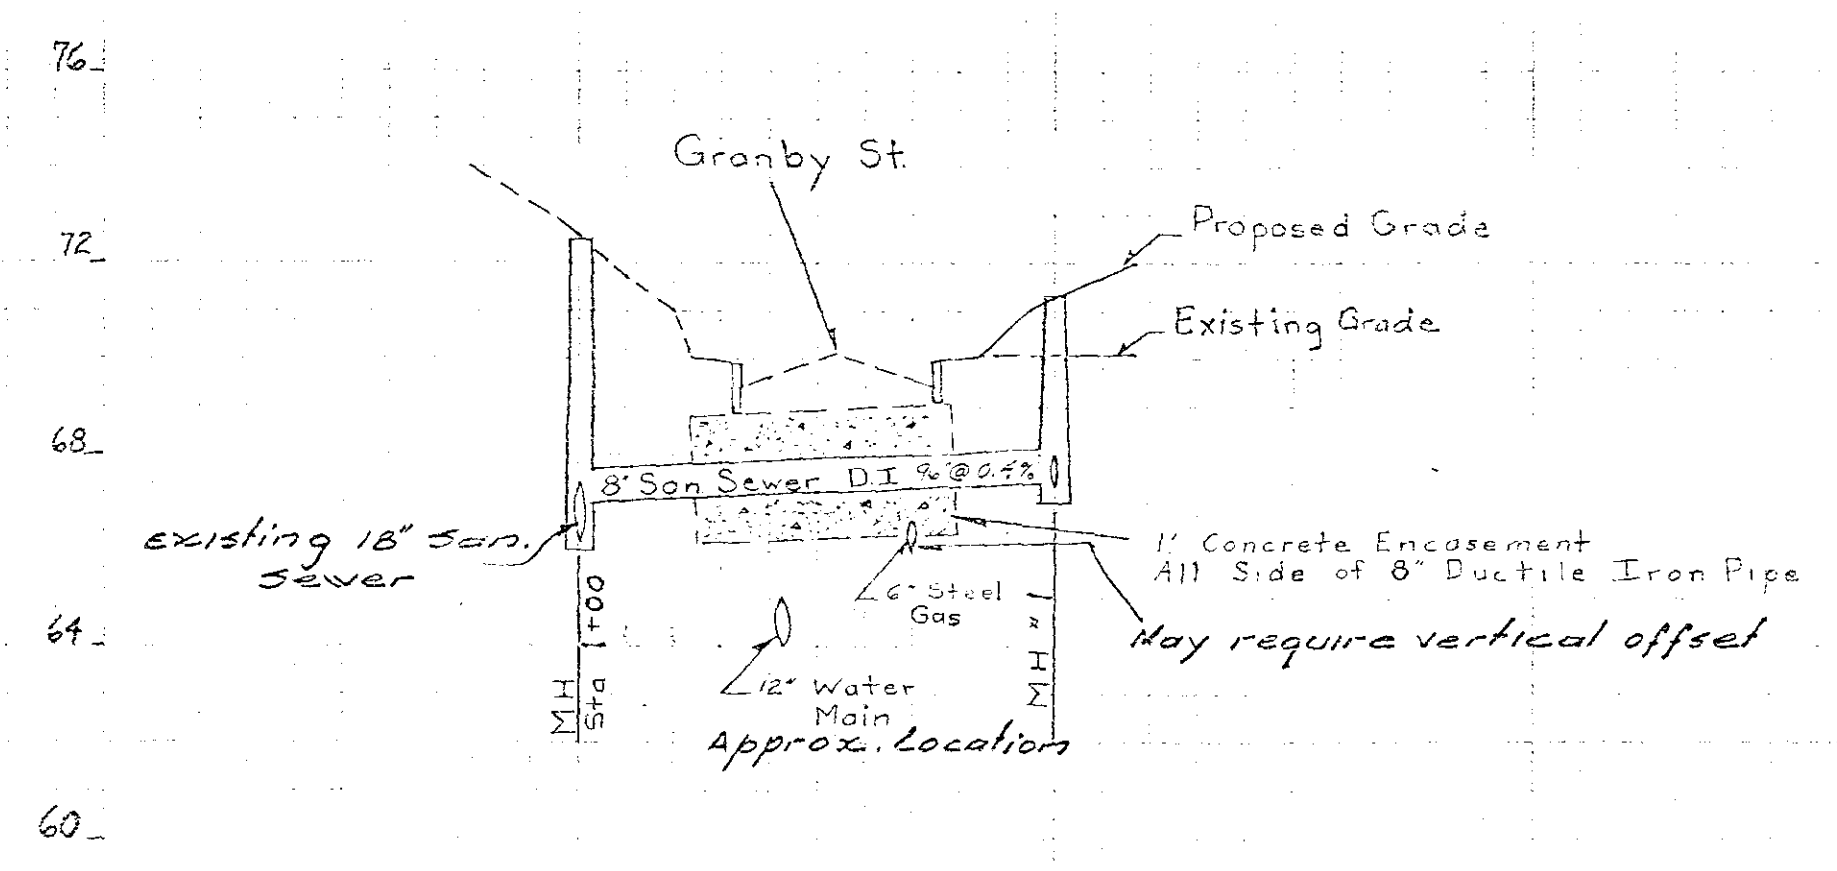

- Legend
- Existing Pipe
 - Manhole
 - Water Gate
 - Proposed Pipe
 - Telephone Pole
 - Fire Hydrant
 - Proposed Contour
 - Existing Contour

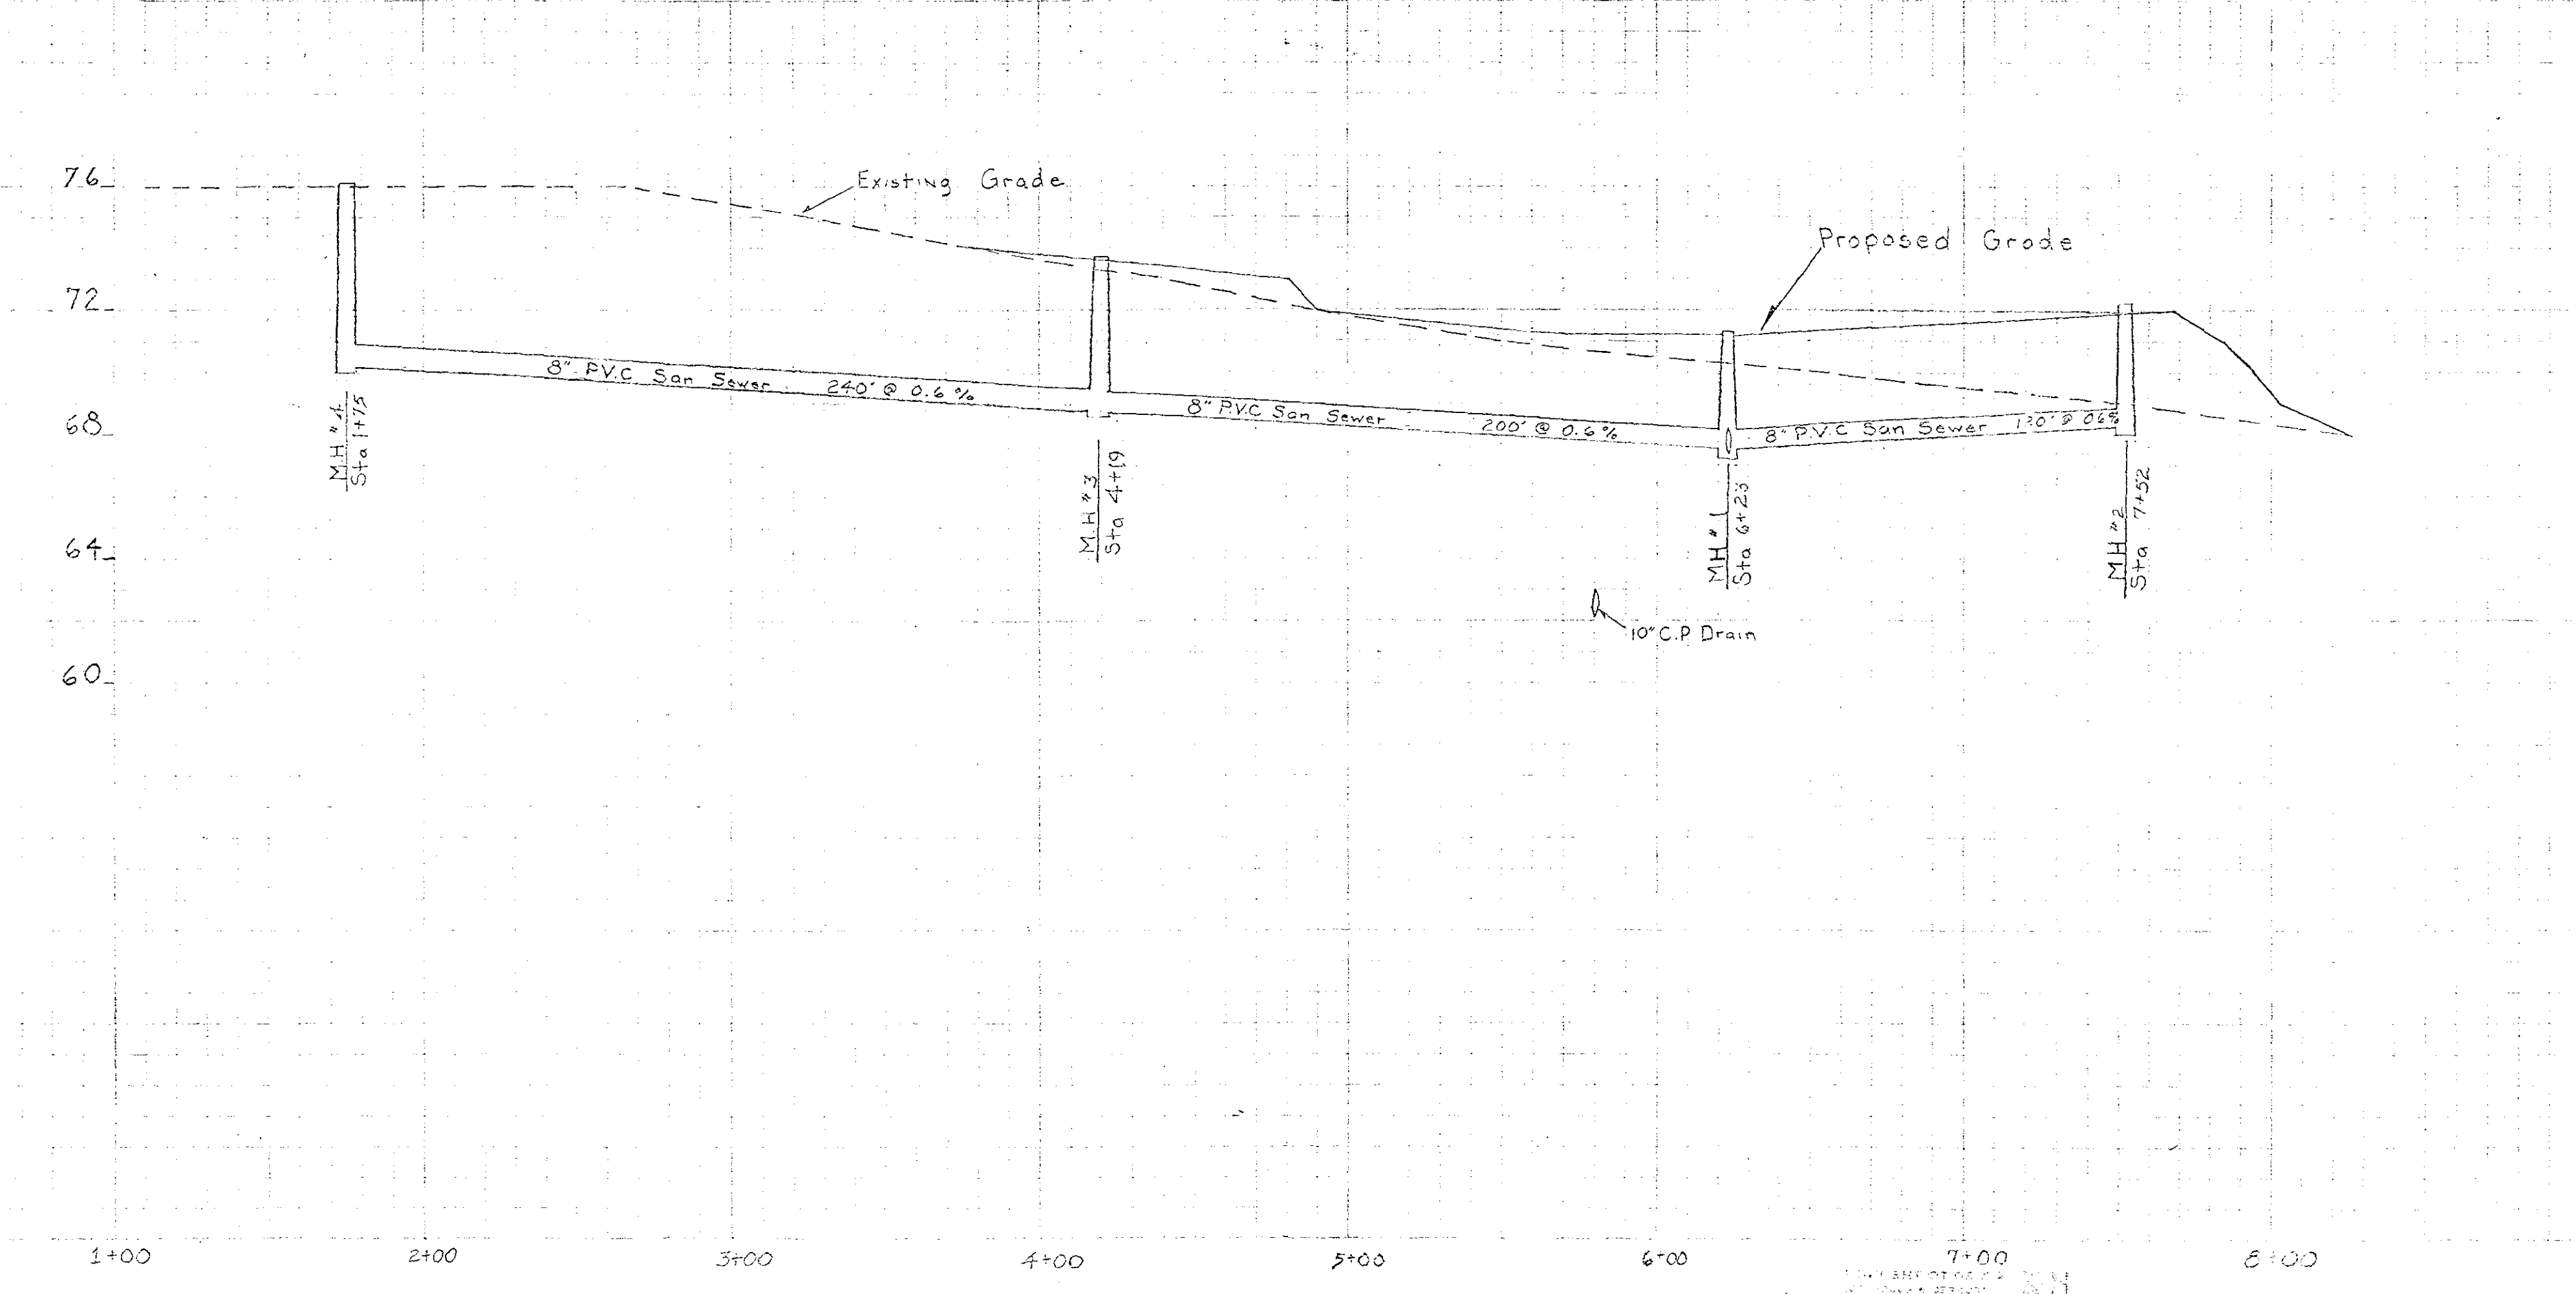

CITY OF HARTFORD, CONNECTICUT DEPARTMENT OF PUBLIC WORKS BUREAU OF ENGINEERING SERVICES		
Plan and Profile Proposed Sanitary Sewer Granby St., Between Burnham and City Line		
SUBMITTED	RECOMMENDED	APPROVED
PROJECT ENGINEER	DIVISION MANAGER	CITY ENGINEER
DRAWN <i>JW</i>	SCALE HORIZ. 1"=40' VERT. 1"=4'	DAYBOOK NO. 011239
CHECKED	DATE	