




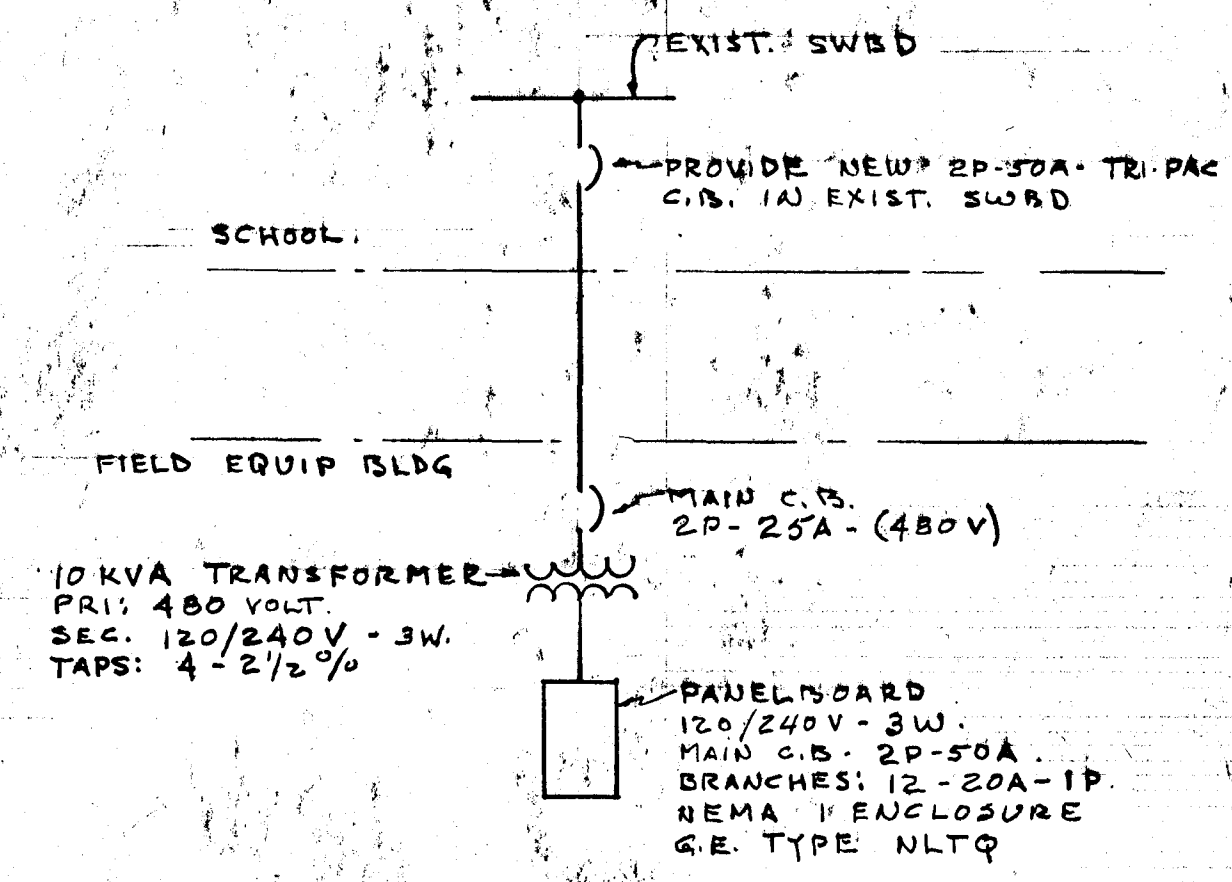


POWER RISER DIAGRAM
NO SCALE

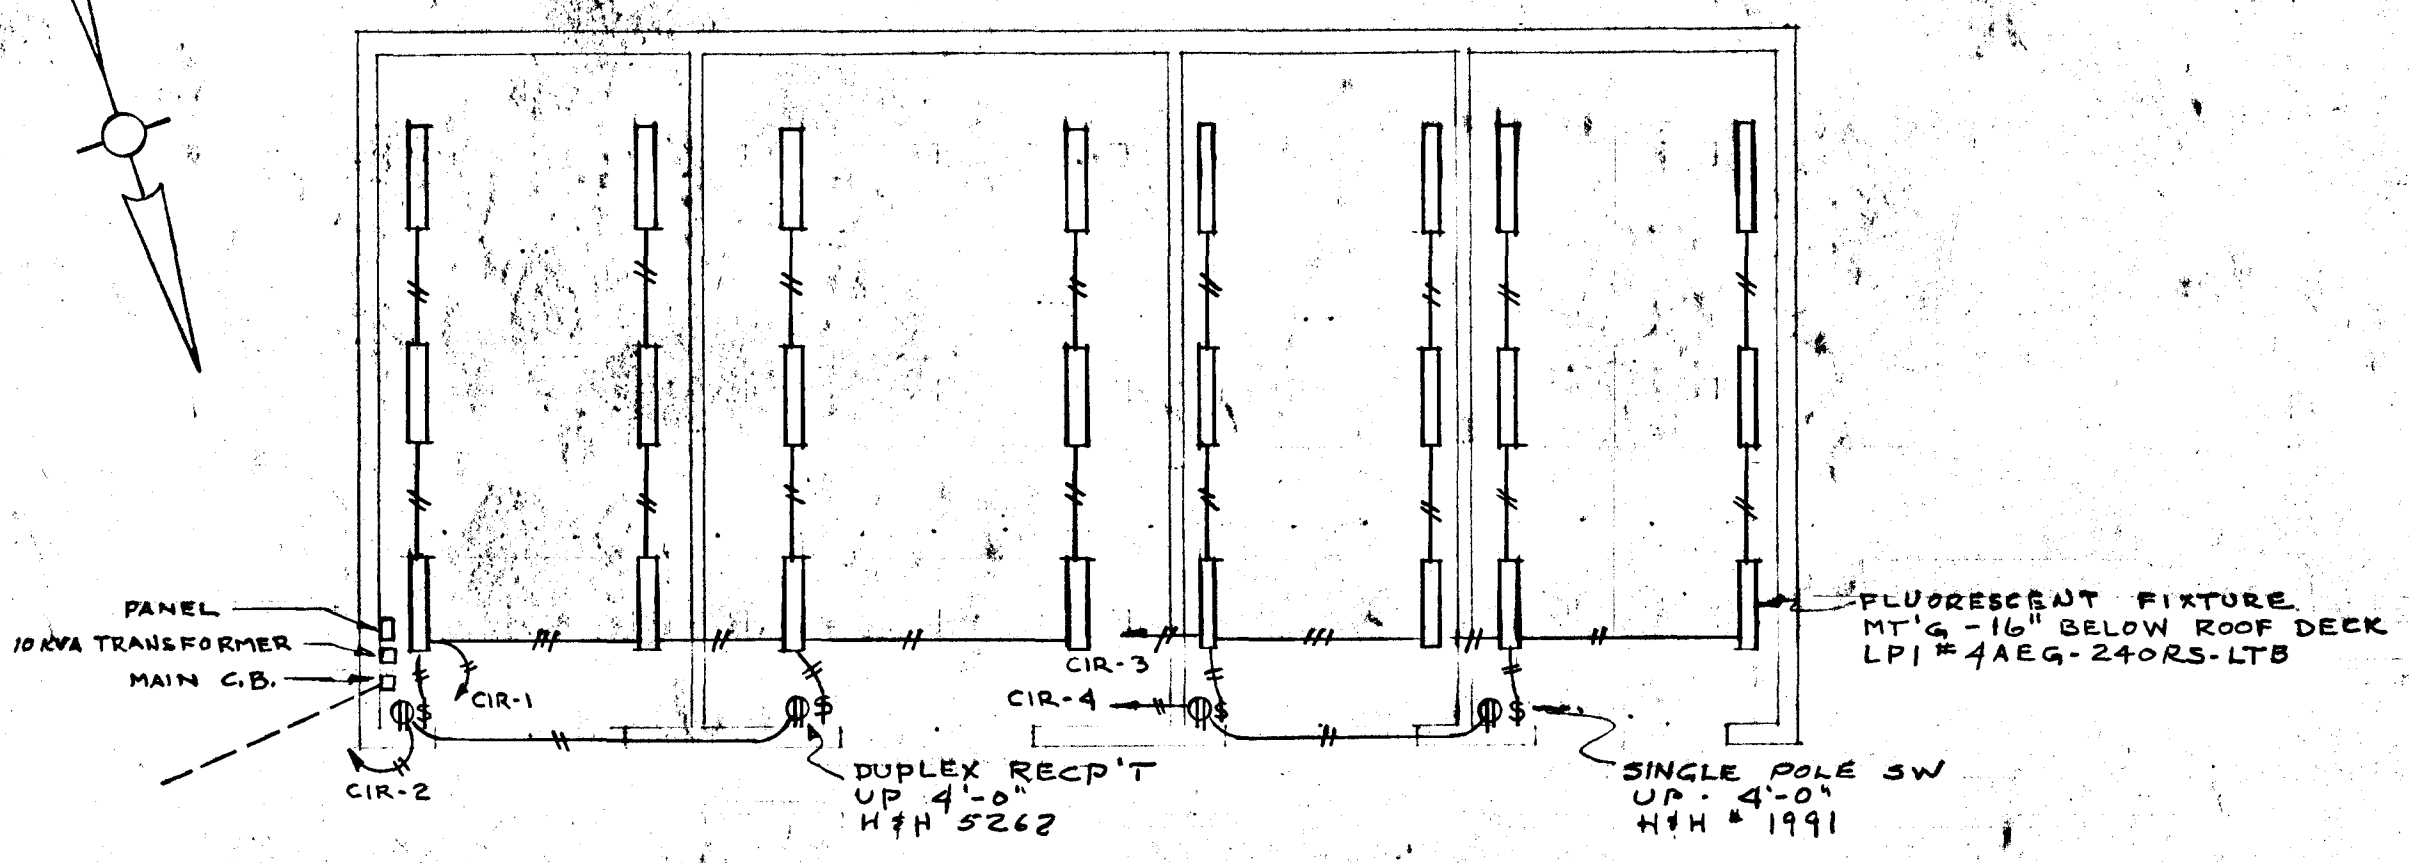

FIELD EQUIP BLDG ELEC FLOOR PLAN
SCALE 1/8" = 1'-0"

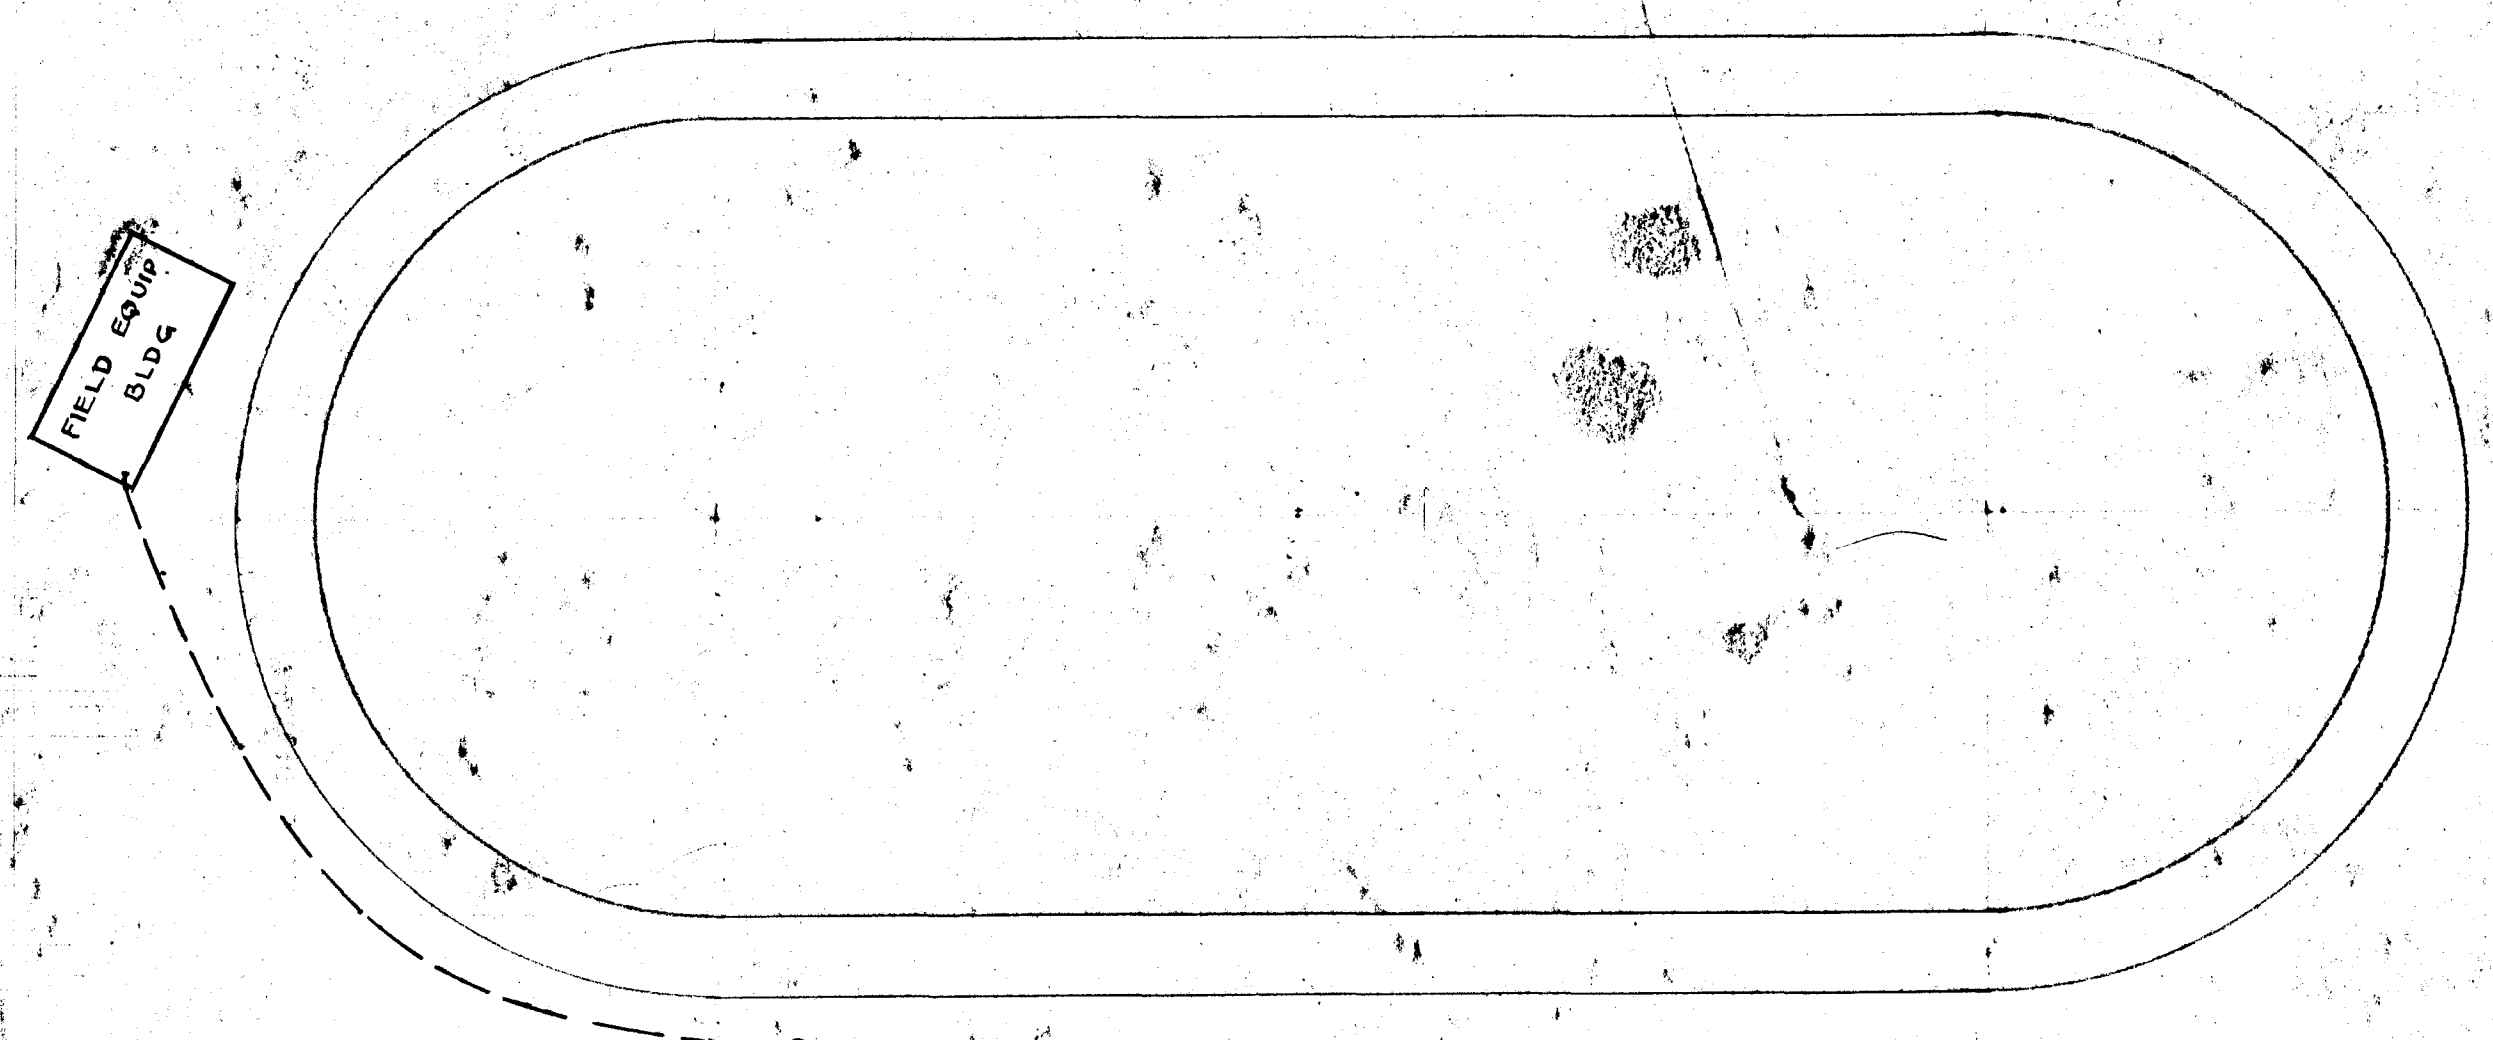

EXISTING 3" CONDUIT FROM FIELD EQUIP
BLDG TO SCHOOL BLDG. PROVIDE 2" 6 THW
AND GROUNDING CONDUCTOR #8

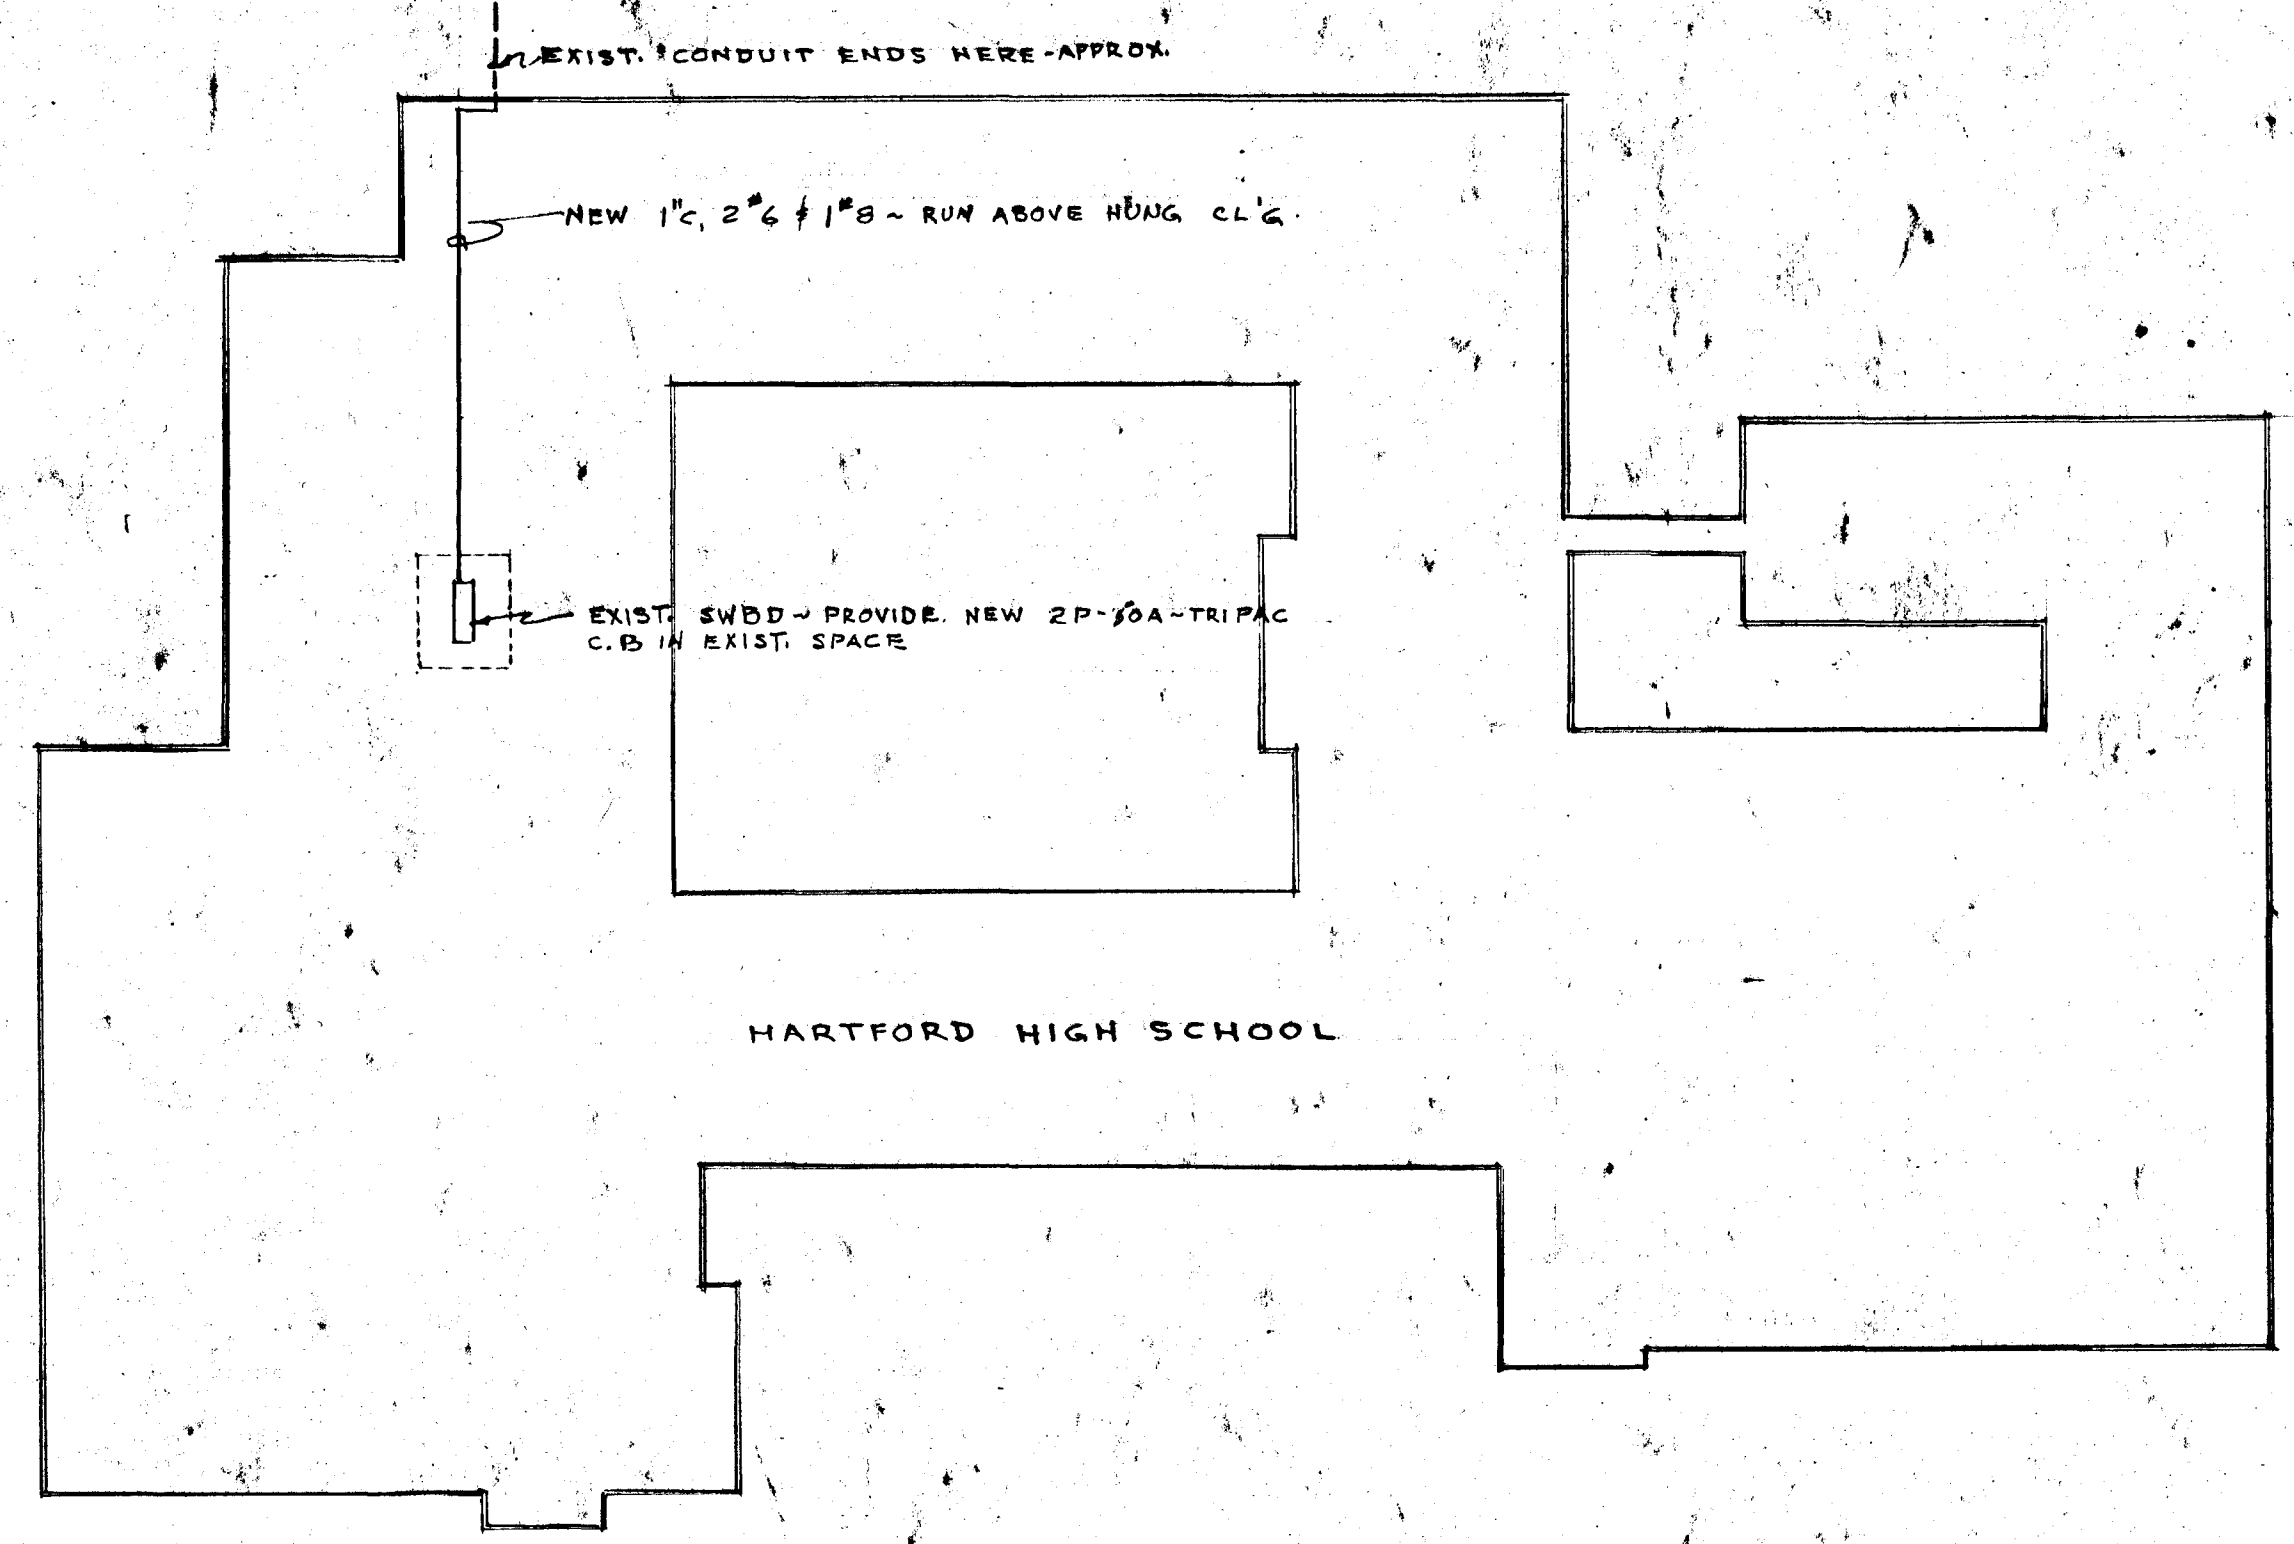

PLOT PLAN
SCALE 1" = 50'

CITY OF HARTFORD, CONNECTICUT DEPARTMENT OF PUBLIC WORKS BUREAU OF PUBLIC BUILDINGS			
ELECTRICAL FOR FIELD EQUIPMENT BUILDING AT H.P.H.S. FOREST ST. HARTFORD CT.			DWG. NO. E 1 SH 1 OF 1
SUBMITTED <i>R.B. Cannon</i>	RECOMMENDED <i>Walter Reed</i>	APPROVED <i>George E. Higgins</i>	
CITY ARCHITECT	CITY ENGINEER		
DRAWN <i>R.G.B.</i>	SCALE	DAYBOOK NO. 010406	
CHECKED	DATE AUGUST 1, 1973.		

VERIFY EXISTING CONDITIONS
AND DIMENSIONS AT BUILDING