


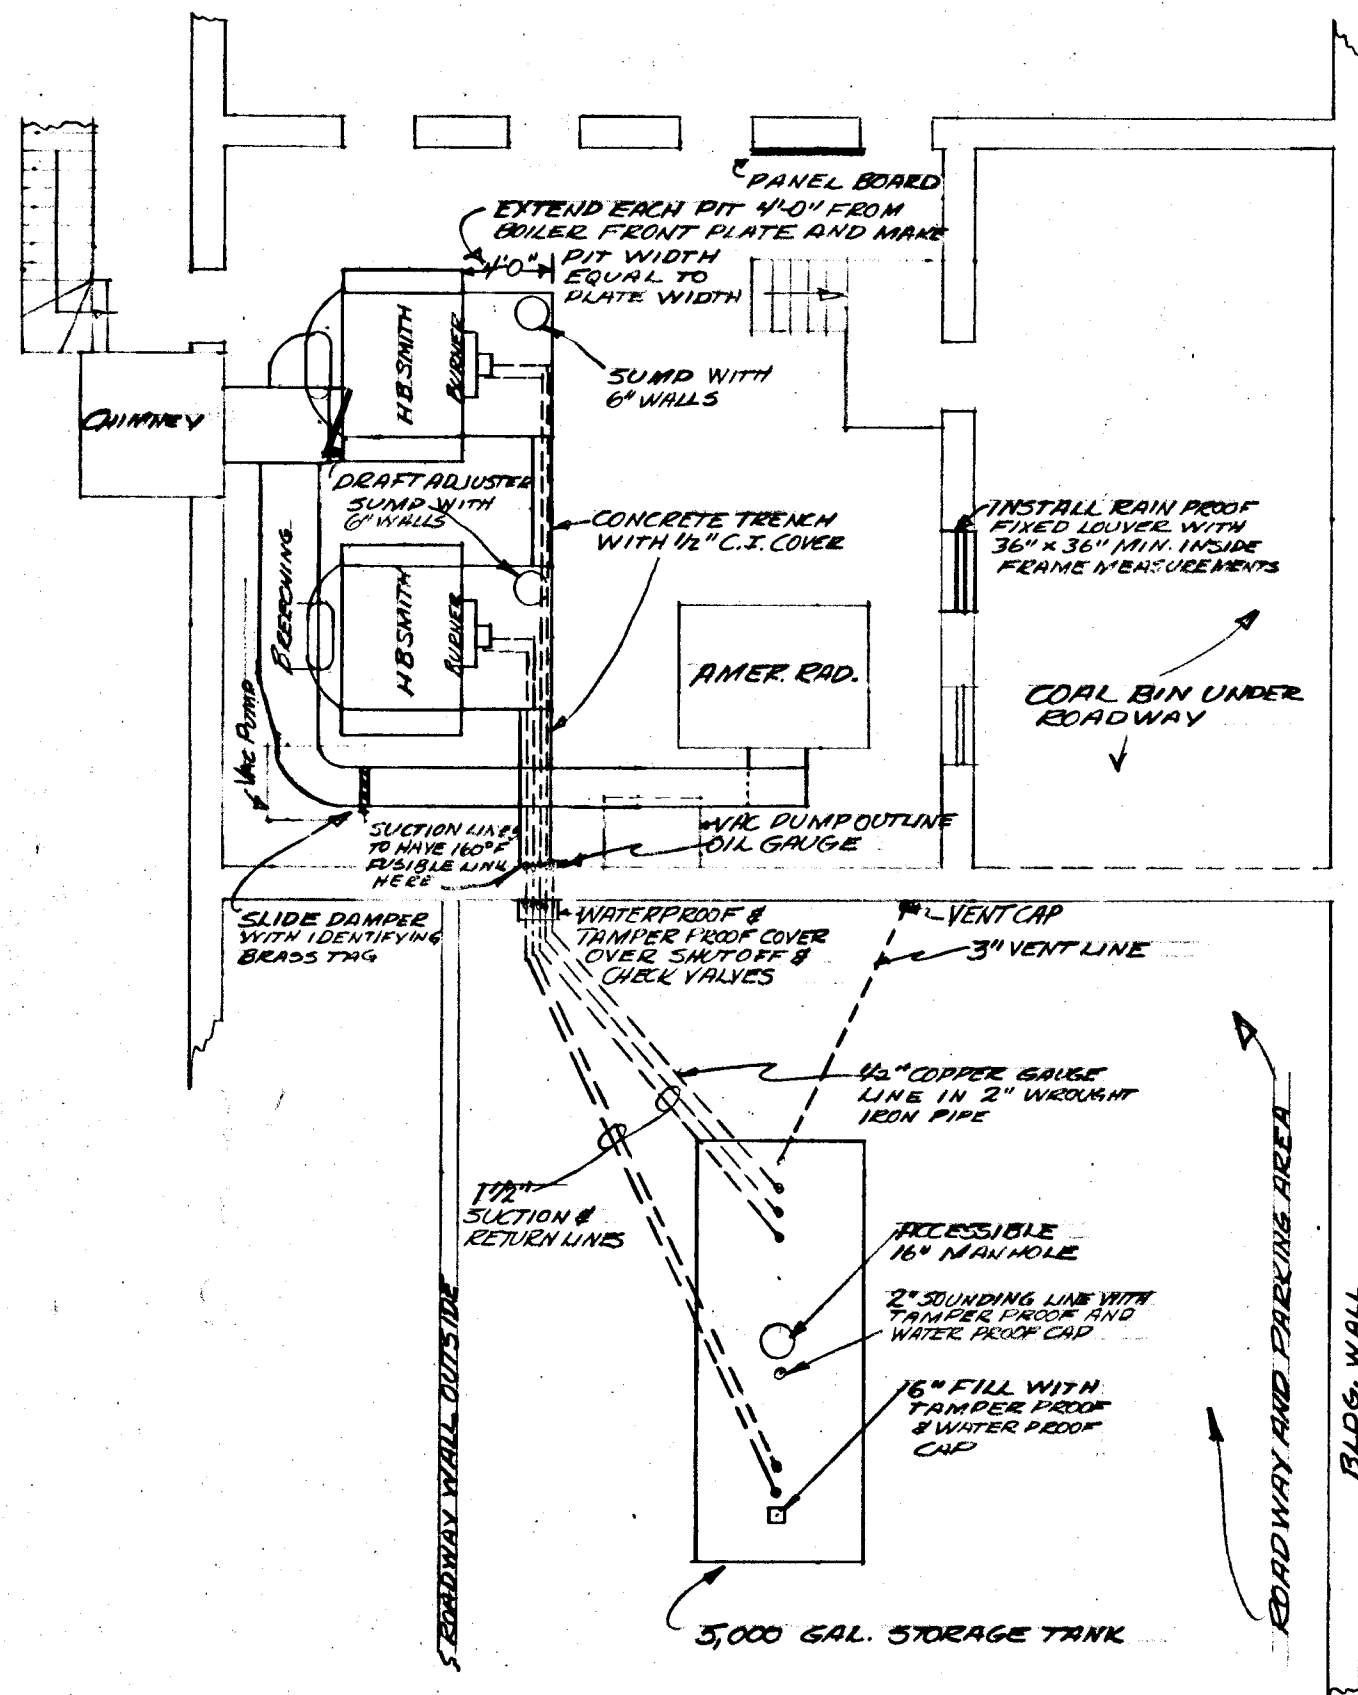
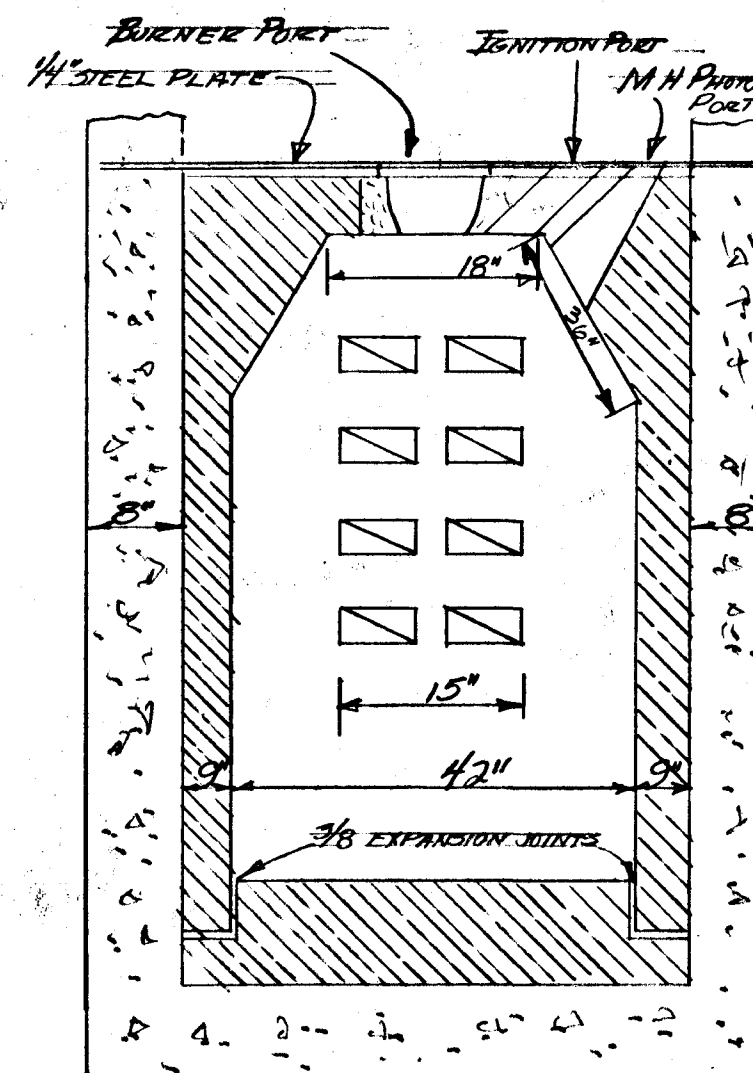


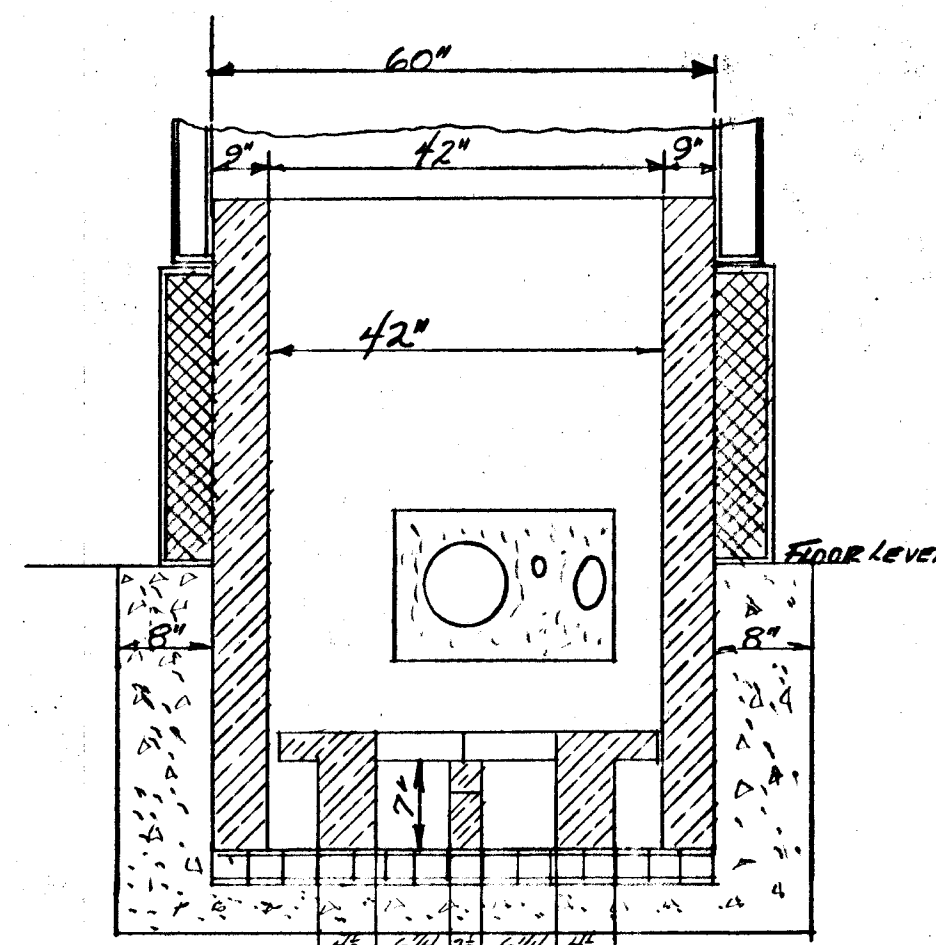



Boiler Room & Surrounding Area Plan
Scale: 1/8" = 1'-0"

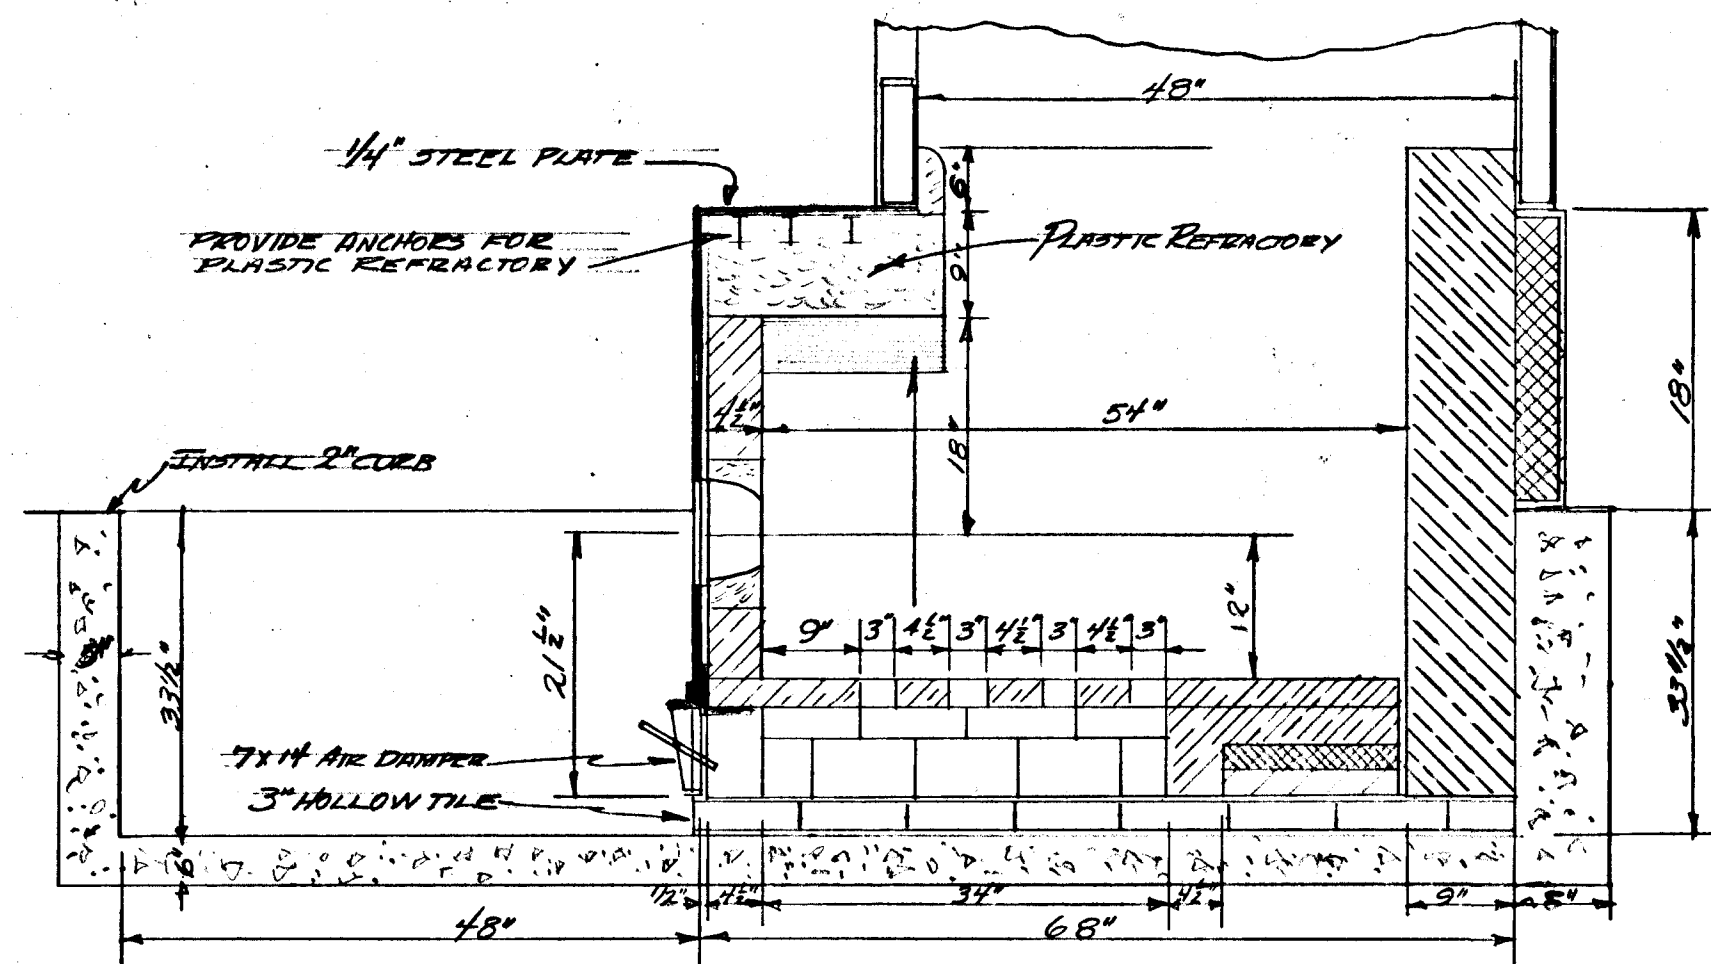

NOTE: VERIFY ALL DIMENSIONS AT THE SITE

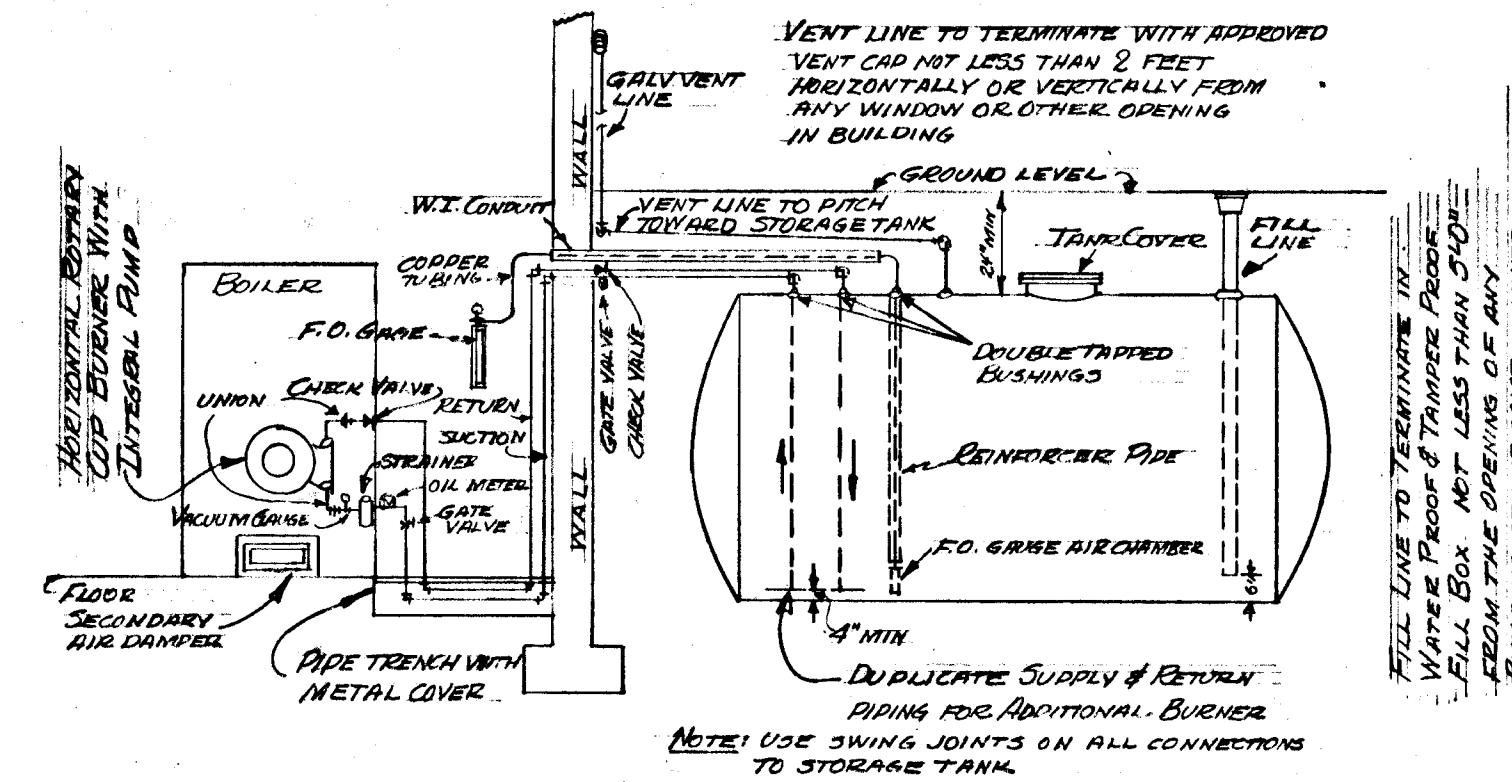

Schematic Piping Layout for Oil Burner
NO SCALE

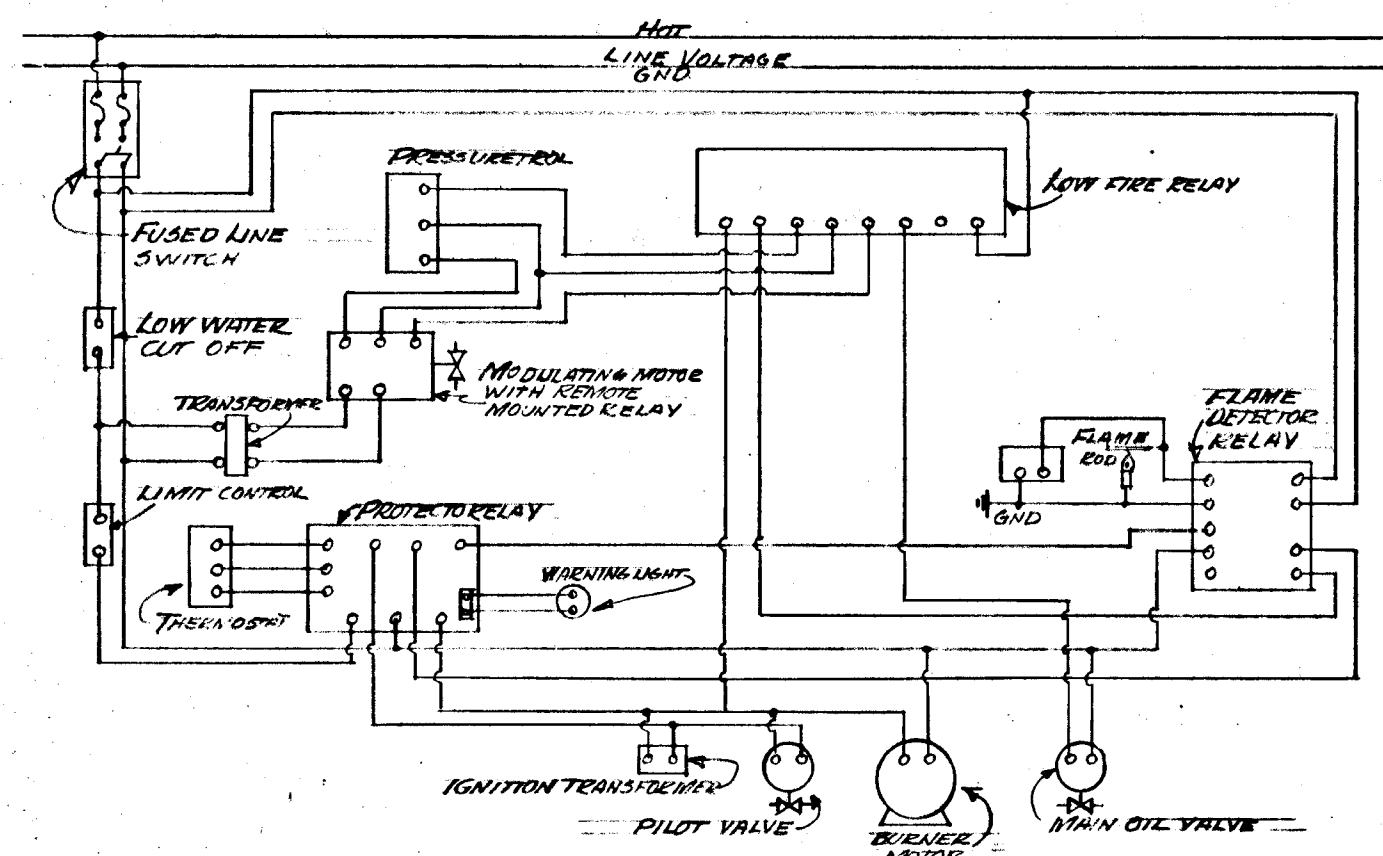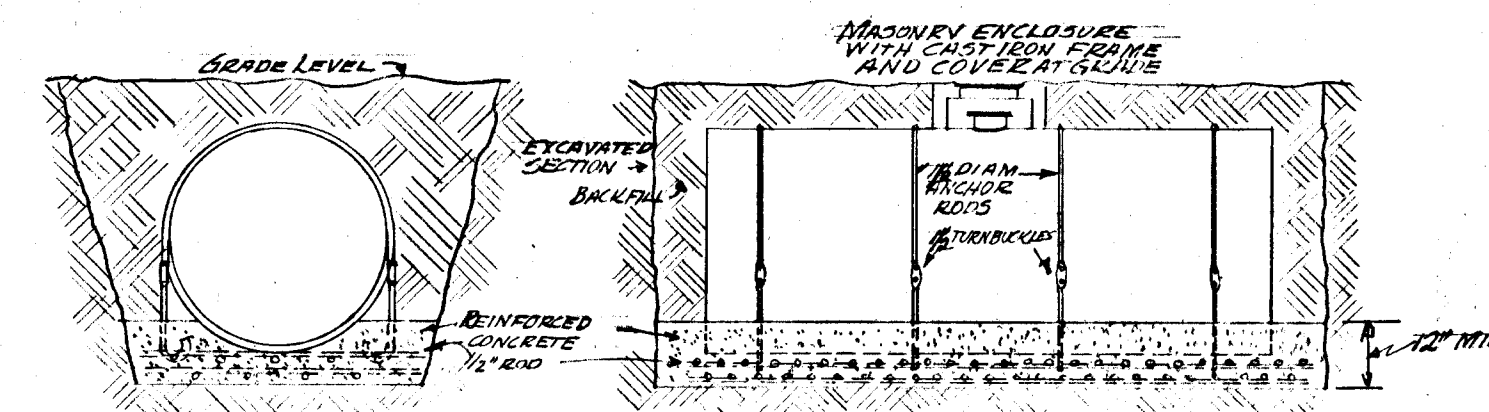

Schematic Control Diagram
FOR EACH BURNER
NO SCALE

CITY OF HARTFORD, CONNECTICUT DEPARTMENT OF ENGINEERING			
SUBMITTED	RECOMMENDED	APPROVED	
Daniel J. Tassell	Wendell D. Bellay	H. J. Skilton	
DIVISION ENGINEER	ASST. CITY ENG.	CITY ENGINEER	
DESIGN	DRAWN	DAYBOOK NO. 09102	
TRACED	CHECK	DATE AUG. 11, 1950	

CONVERSION TO OIL BURNER SOUTHWEST ELEMENTARY SCHOOL 180 WHITE STREET HARTFORD, CONN.			
REVISIONS	JEROME F. MUELLER CONSULTING ENGINEER	PLAN NO.	21
		SCALE	AS NOTED
		SHEET NO.	1 OF 1
15 LEWIS ST.		HARTFORD, CONN.	