




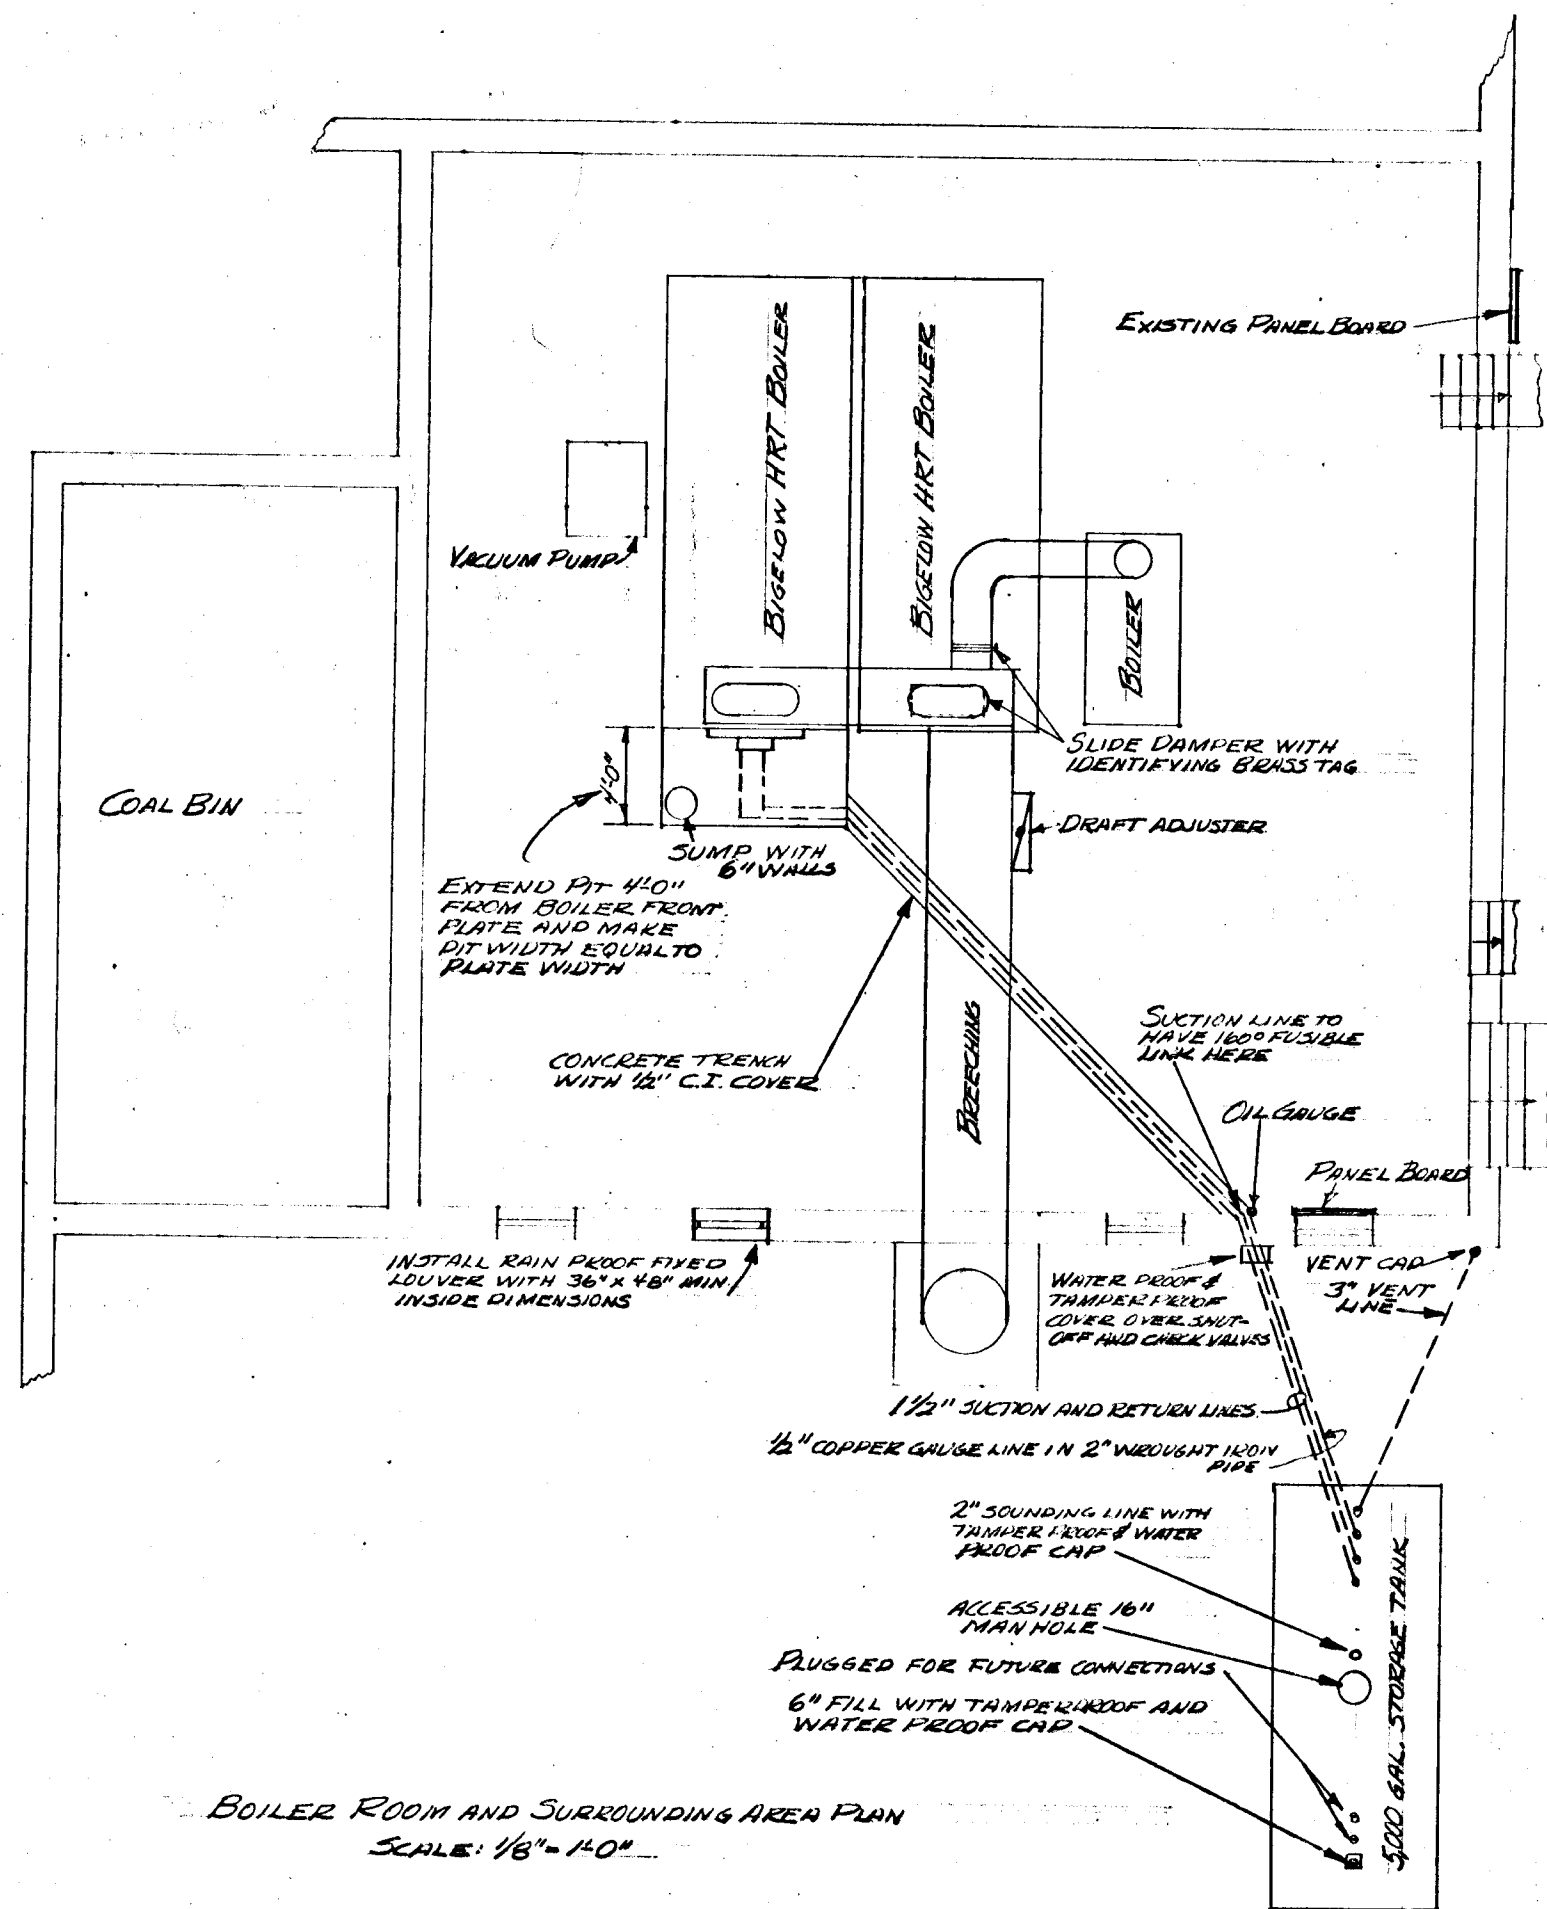


BOILER ROOM AND SURROUNDING AREA PLAN
SCALE: 1/8" = 1'-0"

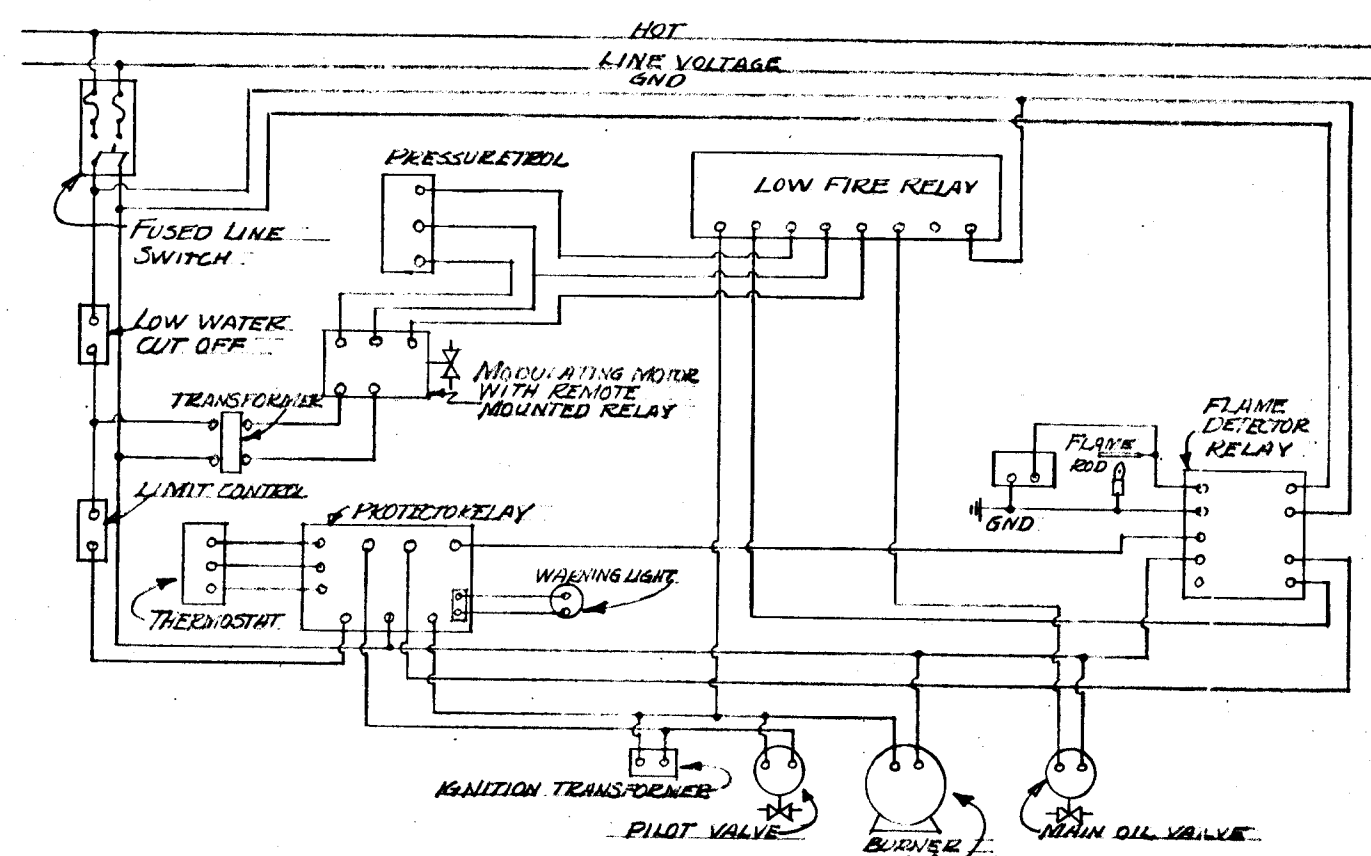


SCHEMATIC CONTROL DIAGRAM
FOR
EACH BURNER
NO SCALE

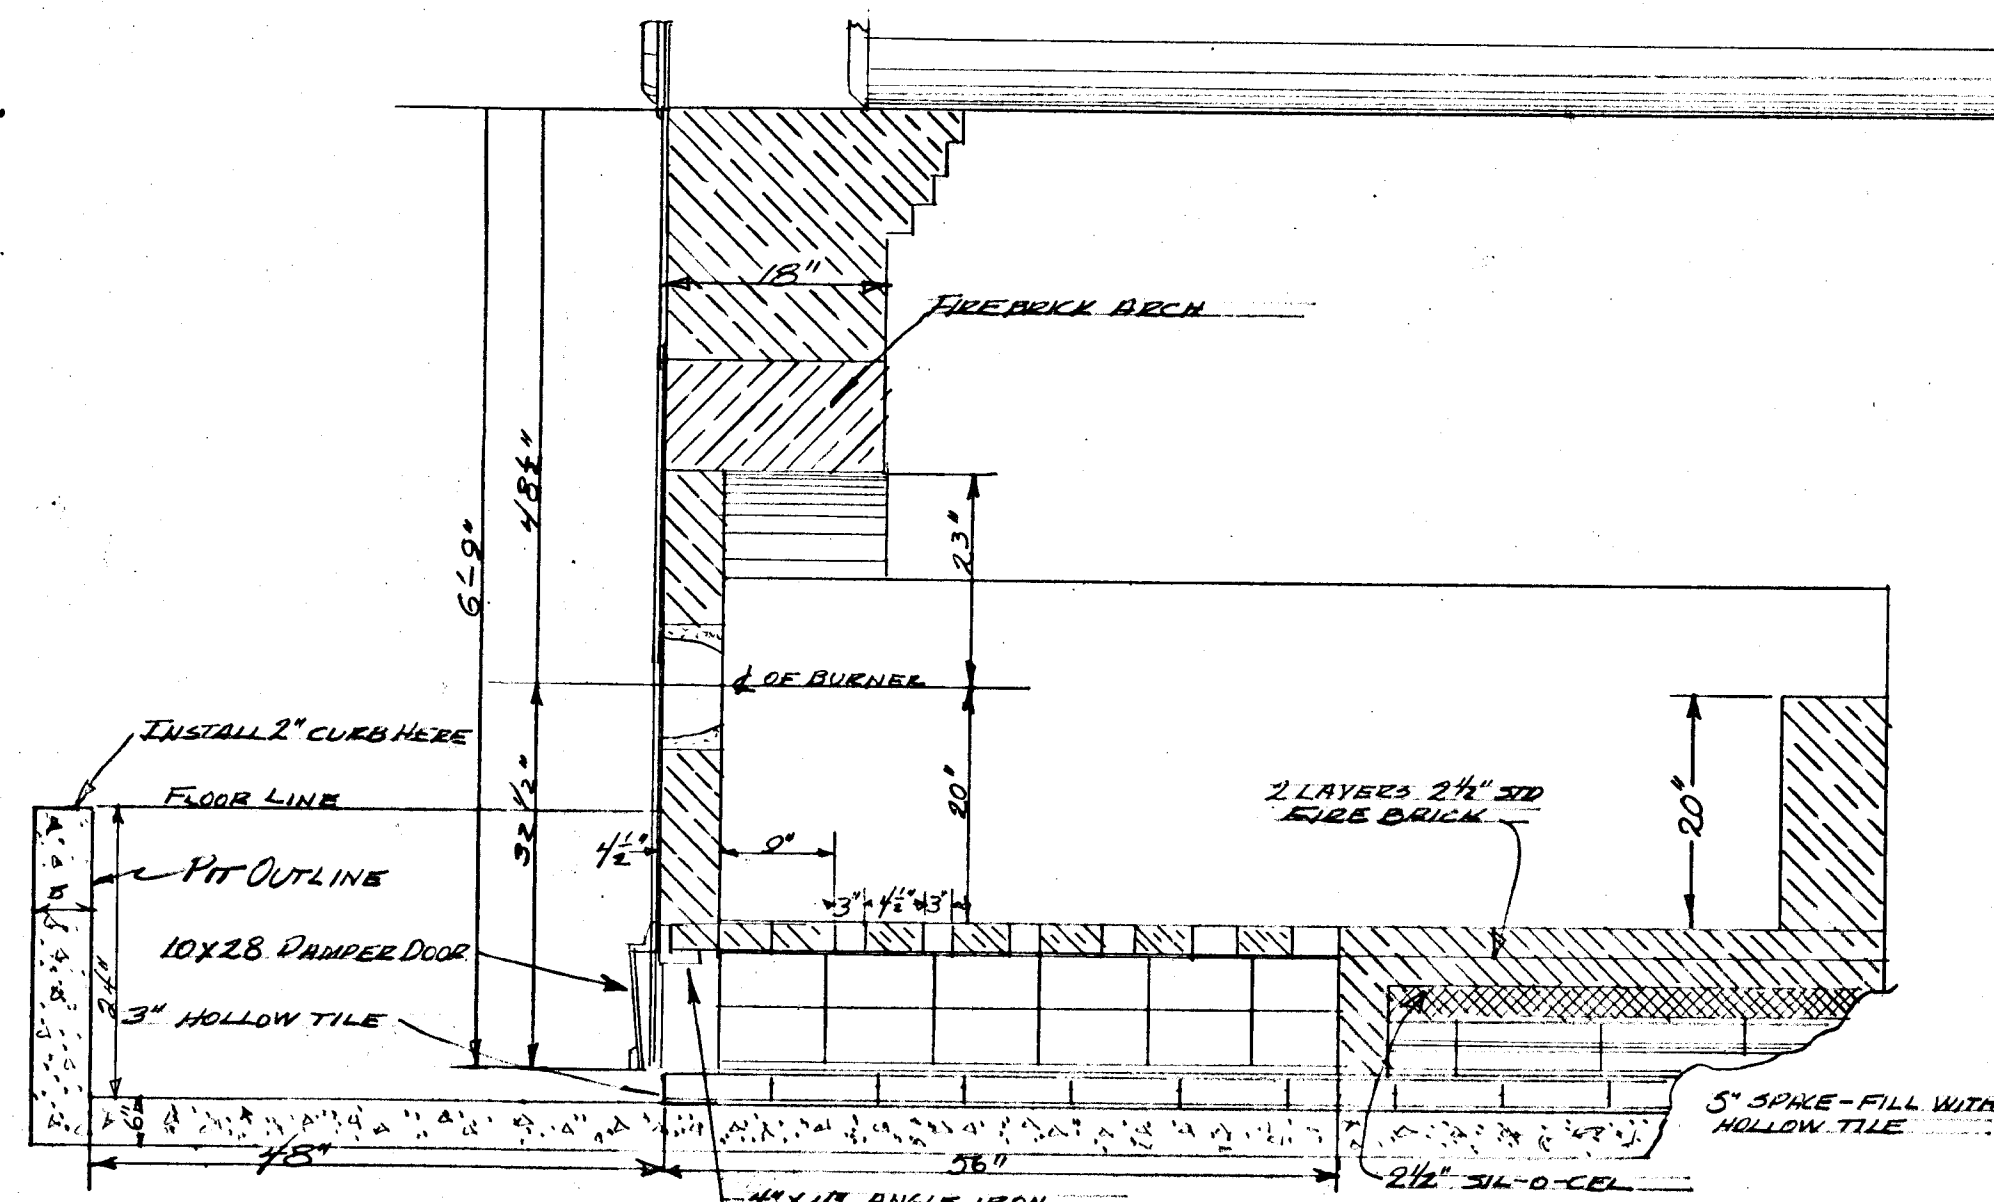


ELEVATION AT BURNER & OF
BOILER COMBUSTION CHAMBER
NO SCALE

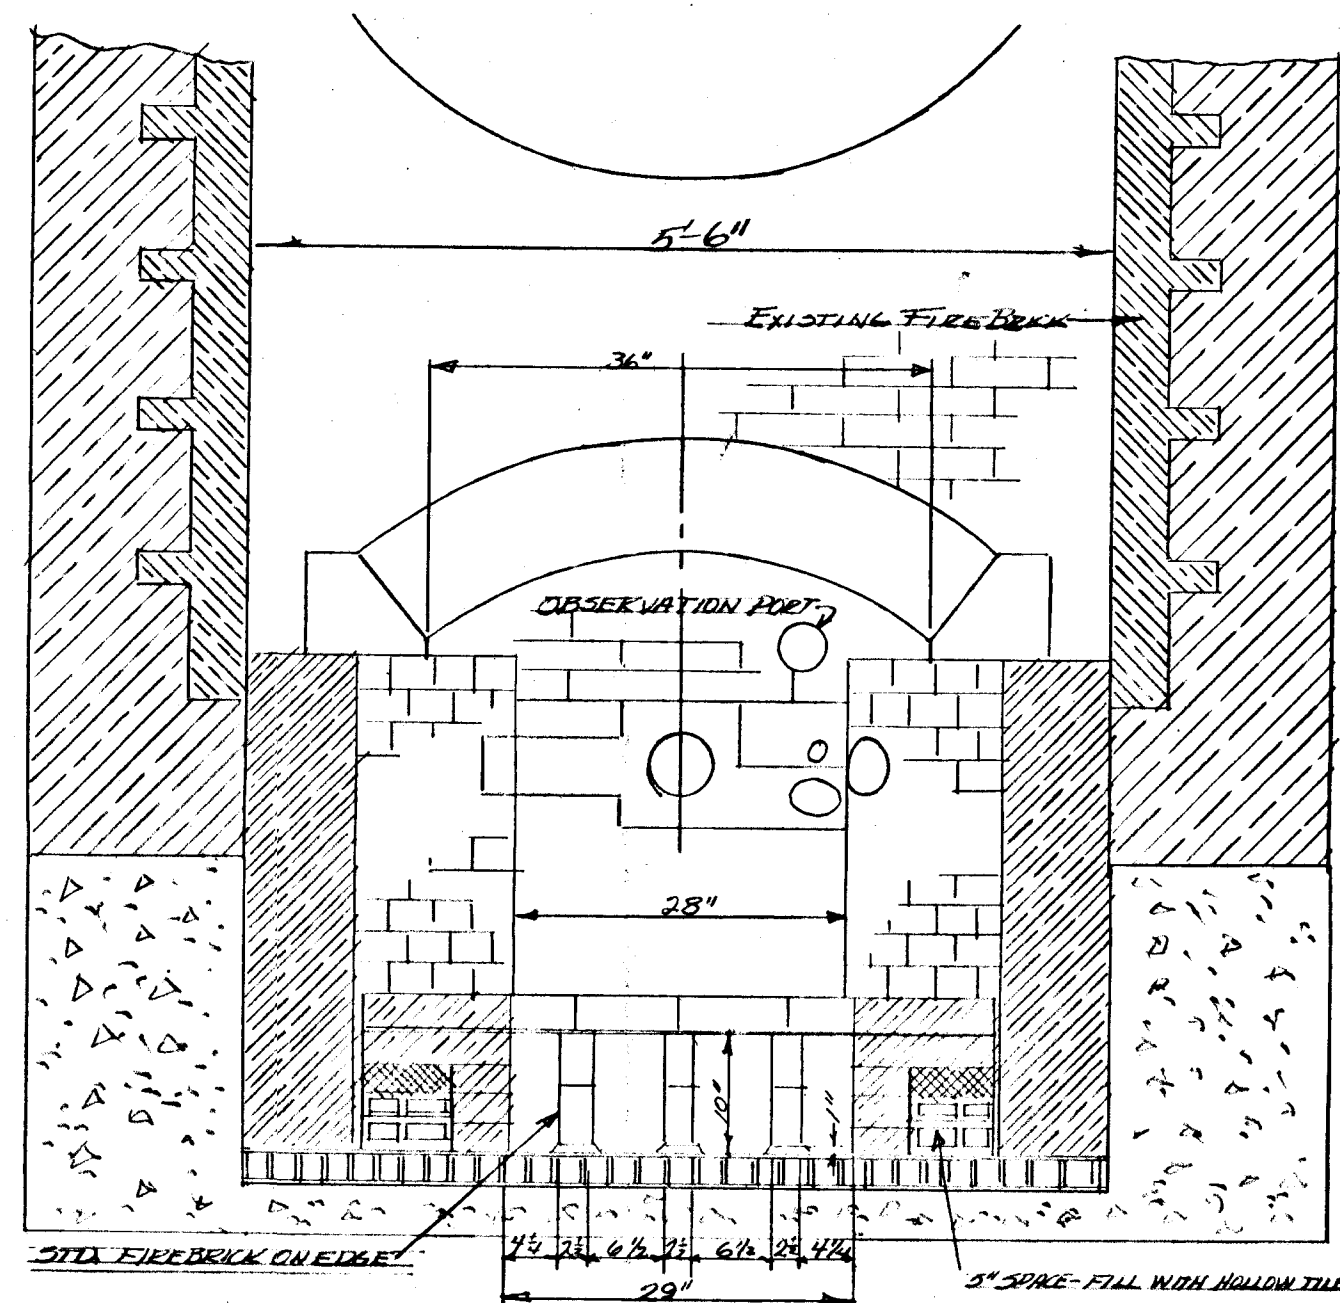


SECTION OF COMBUSTION CHAMBER
NO SCALE

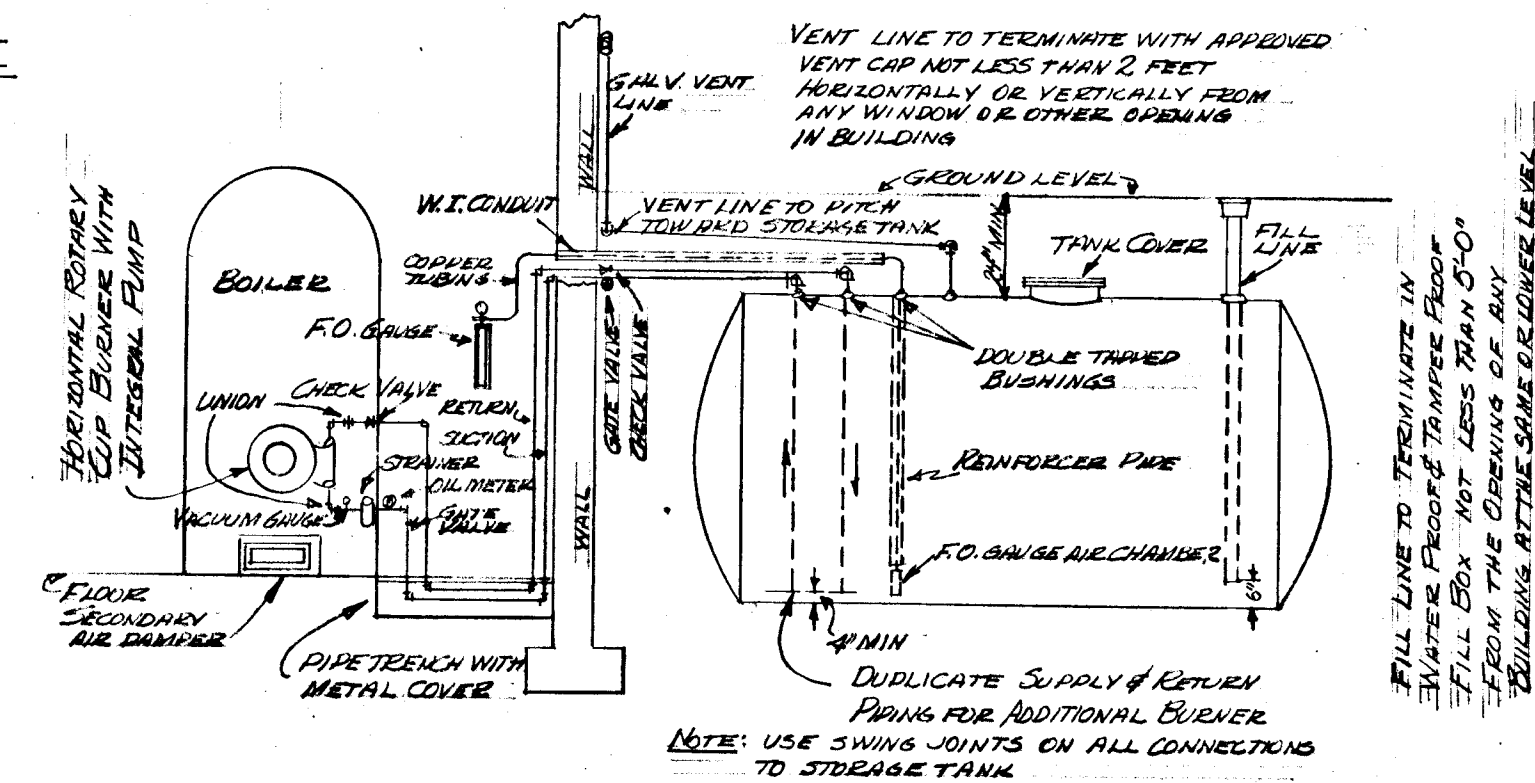

SCHEMATIC PIPING LAYOUT FOR OIL BURNER
NO SCALE

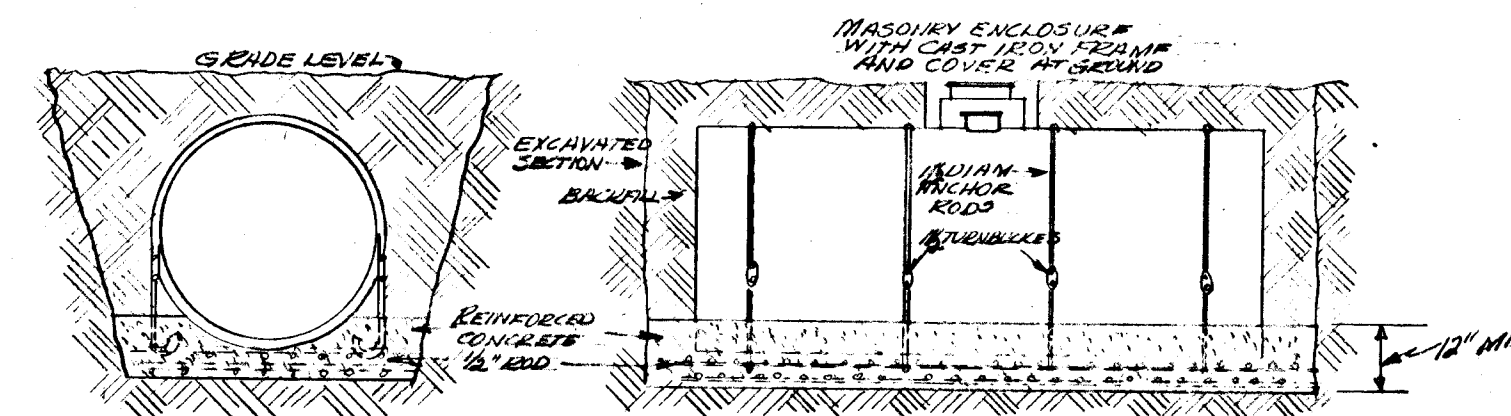

SKETCH OF
CONCRETE CRADLE FOR FUEL OIL TANK
NO SCALE

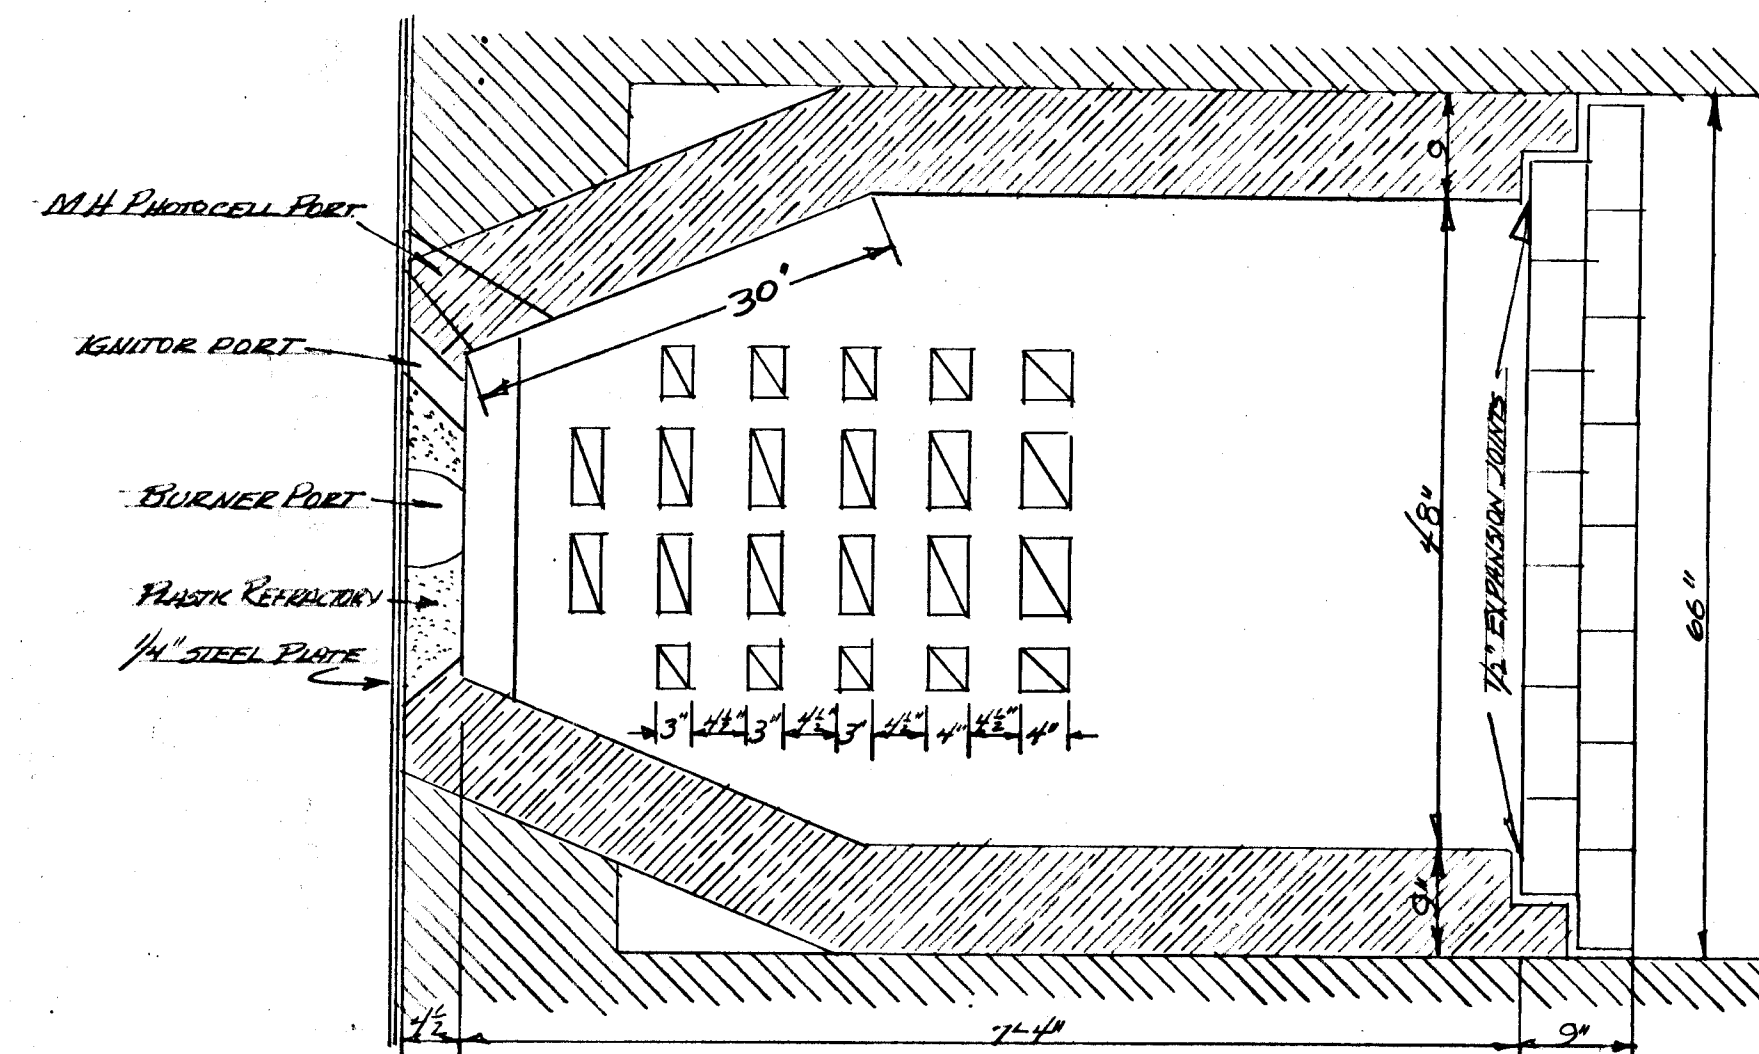

PLAN OF COMBUSTION CHAMBER
NO SCALE

NOTE: VERIFY ALL DIMENSIONS AT THE SITE

CITY OF HARTFORD, CONNECTICUT DEPARTMENT OF ENGINEERING		
SUBMITTED DIVISION ENGINEER Daniel J. Tardio	RECOMMENDED CITY ENGINEER Walter H. May	APPROVED CITY ENGINEER Jerome F. Mueller
DESIGN	DRAWN	DAYBOOK NO. 09104
TRACED	CHECK	DATE AUG. 11, 1950

CONVERSION TO OIL BURNER BUREAU JUNIOR HIGH SCHOOL 400 WETHERSFIELD AVE HARTFORD, CONN.			
REVISIONS	JEROME F. MUELLER CONSULTING ENGINEER	PLAN NO. 24	SCALE AS NOTED
15 LEWIS ST.	HARTFORD, CONN.	SHEET NO.	1 OF 1