




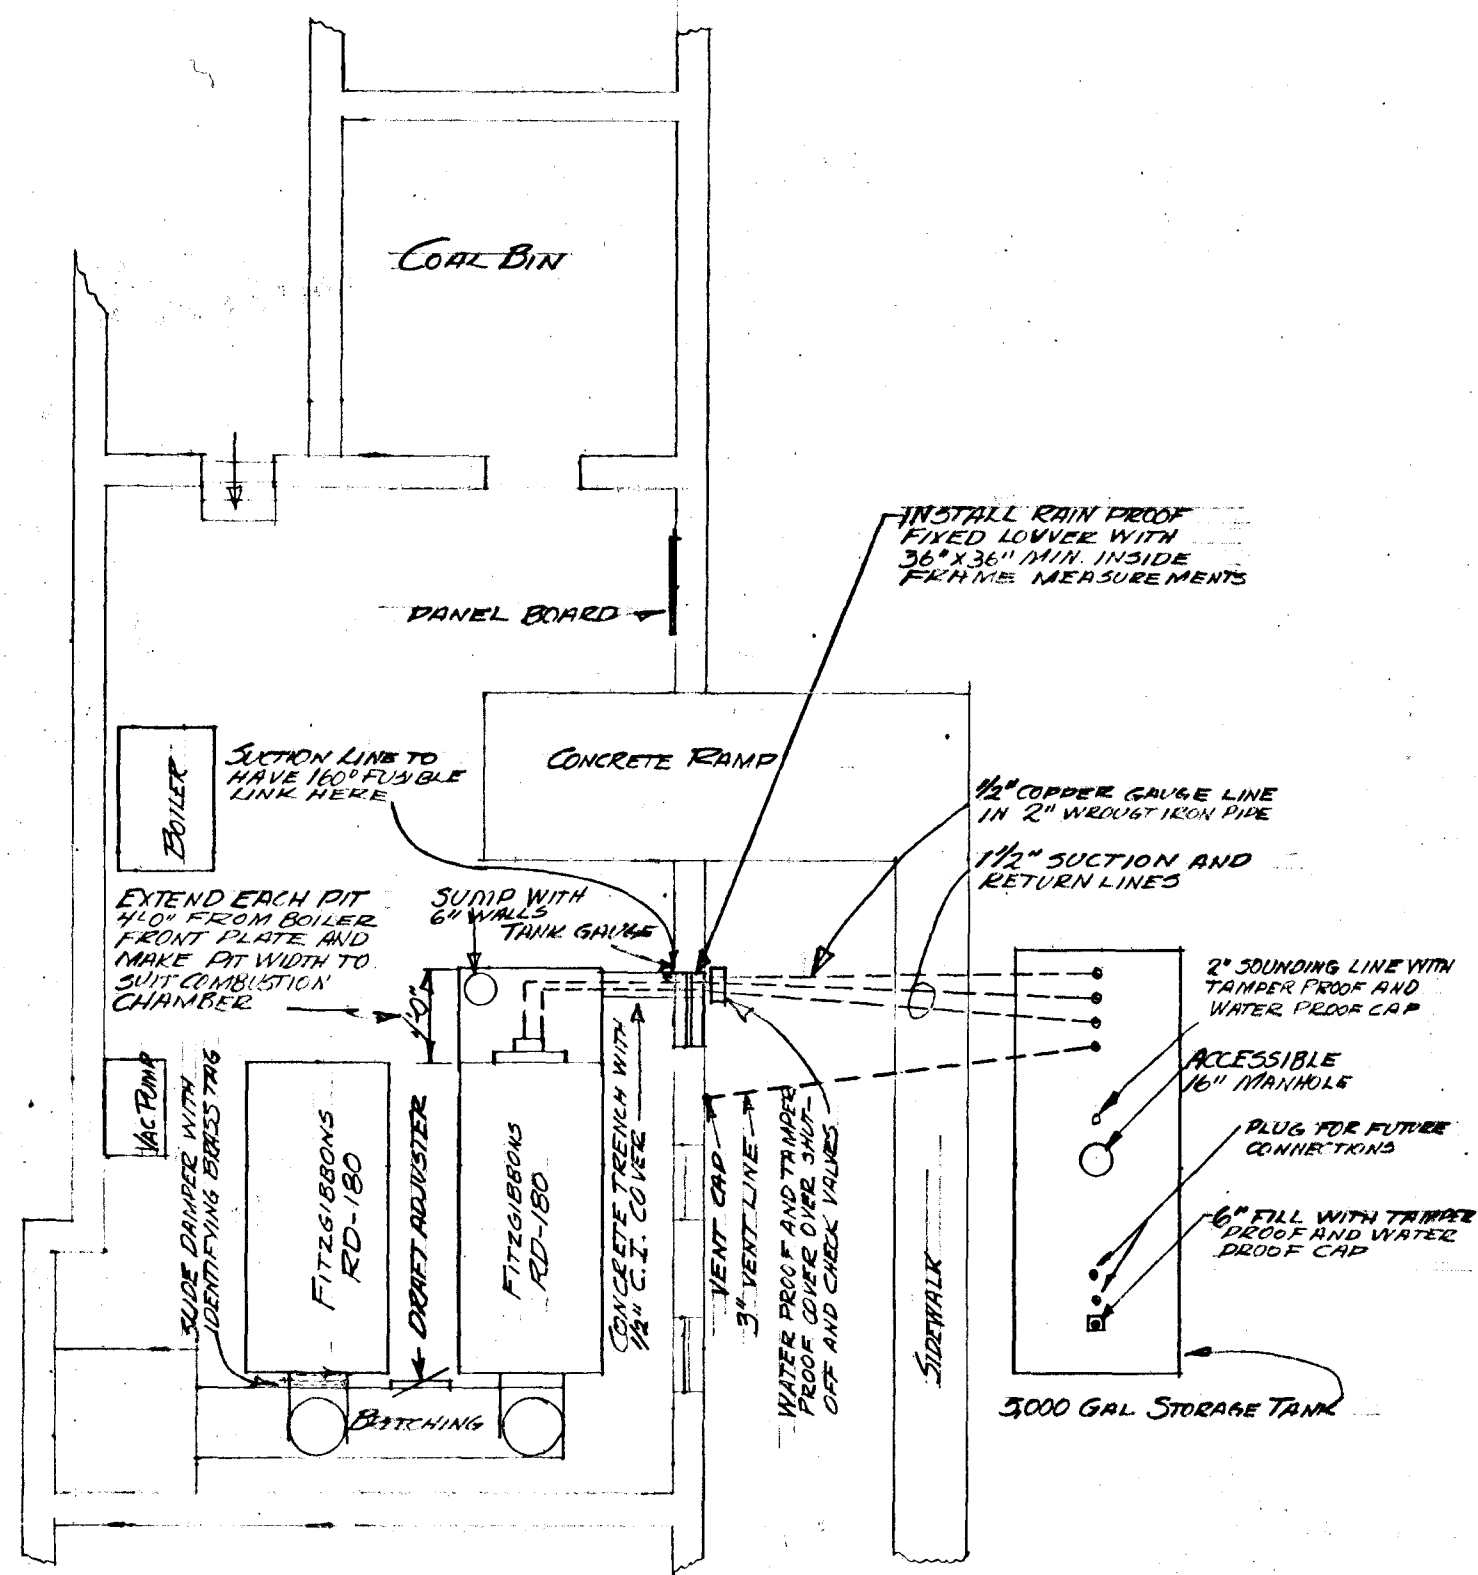


BOILER ROOM AND SURROUNDING AREA PLAN
SCALE: 1/8" = 1'-0"

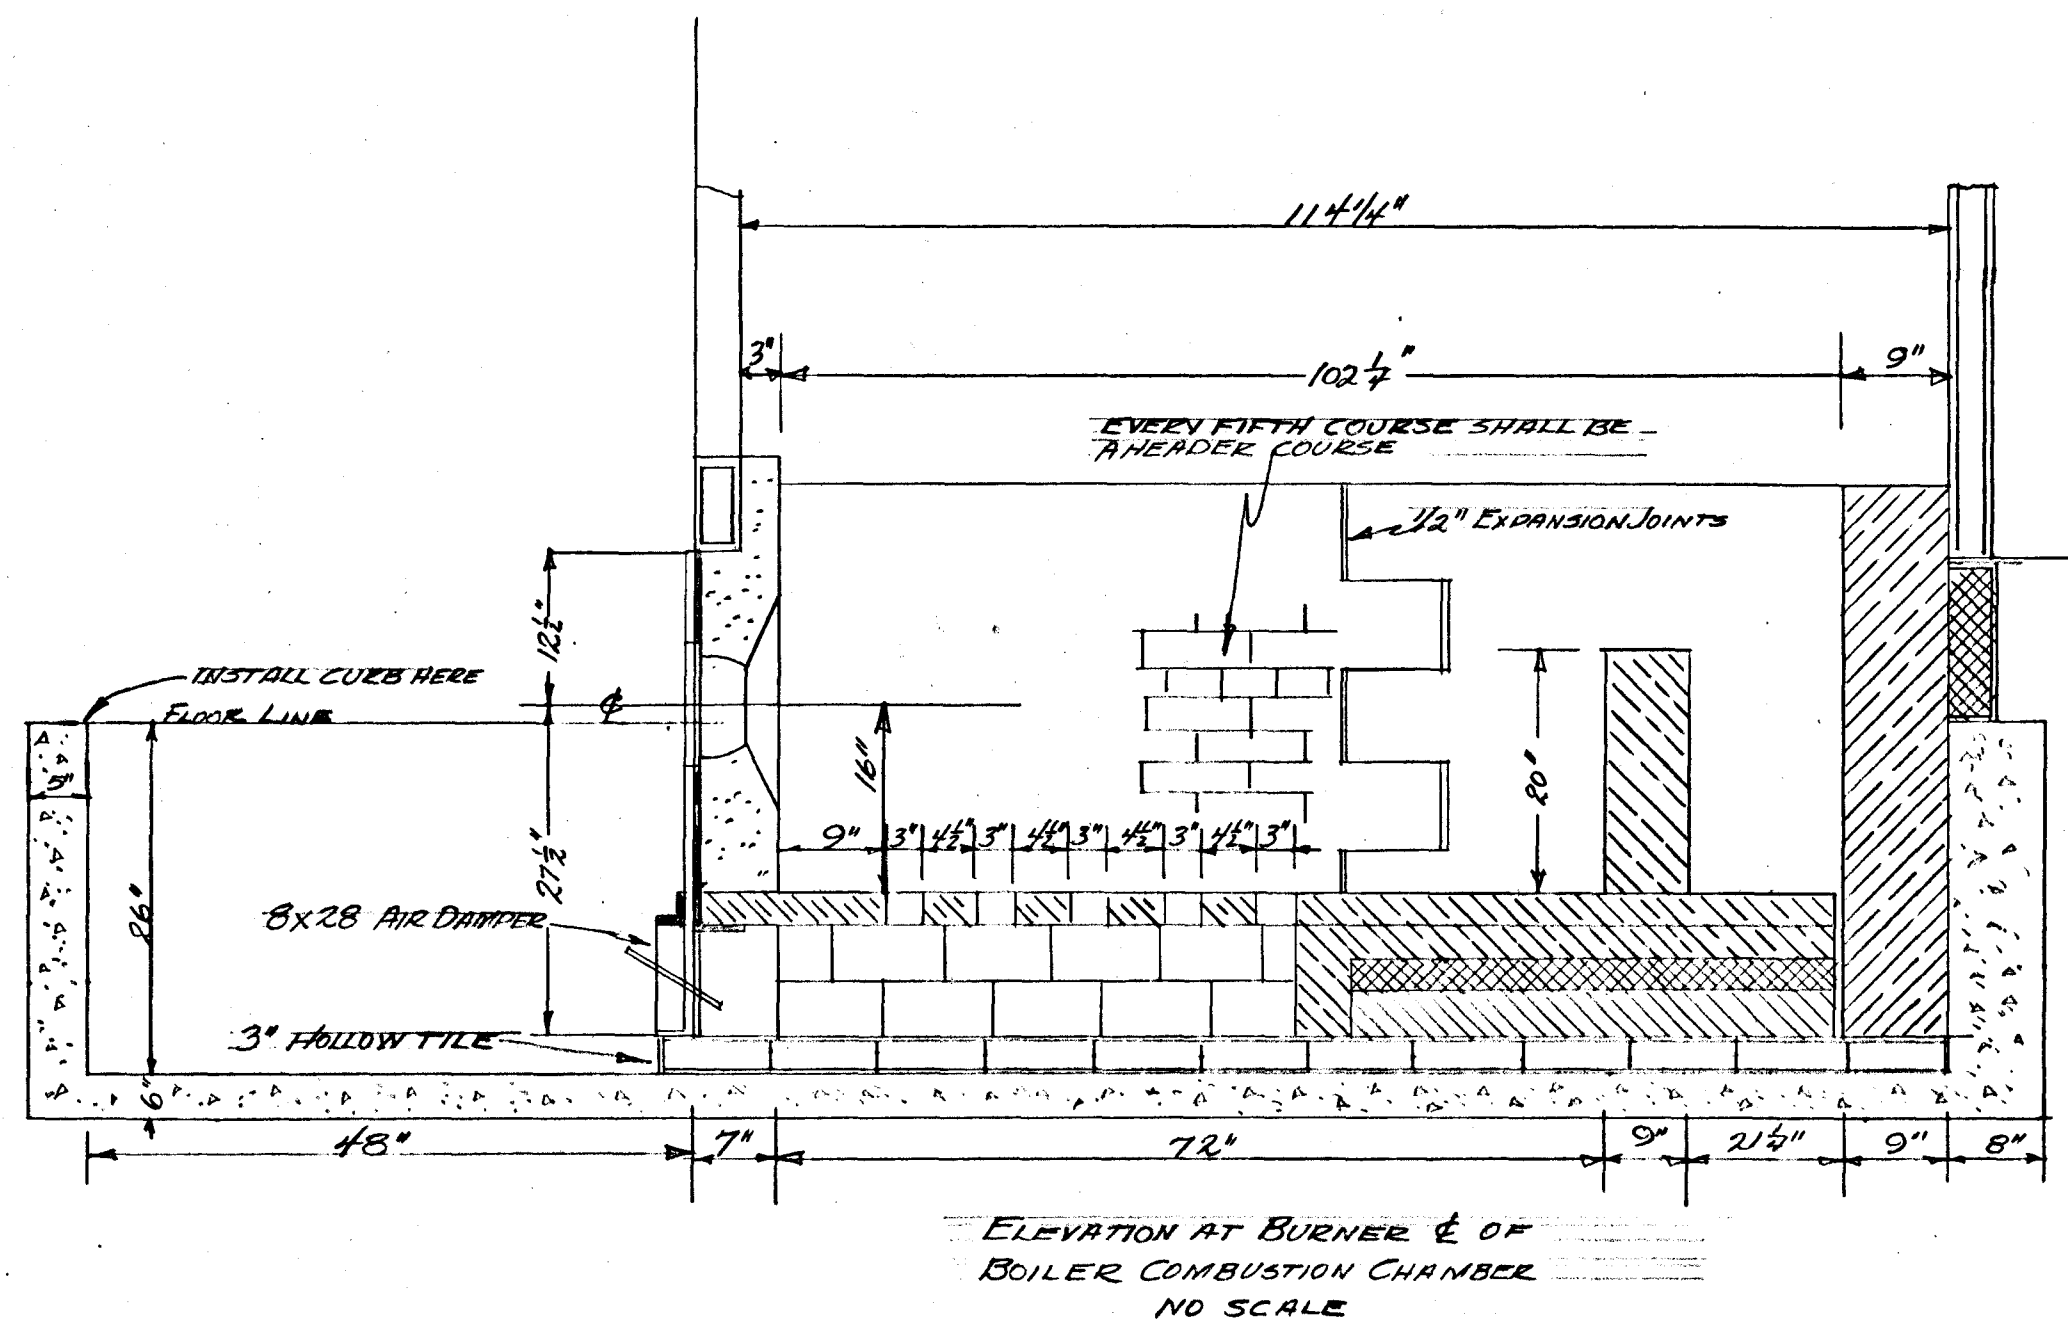


ELEVATION AT BURNER END OF
BOILER COMBUSTION CHAMBER
NO SCALE

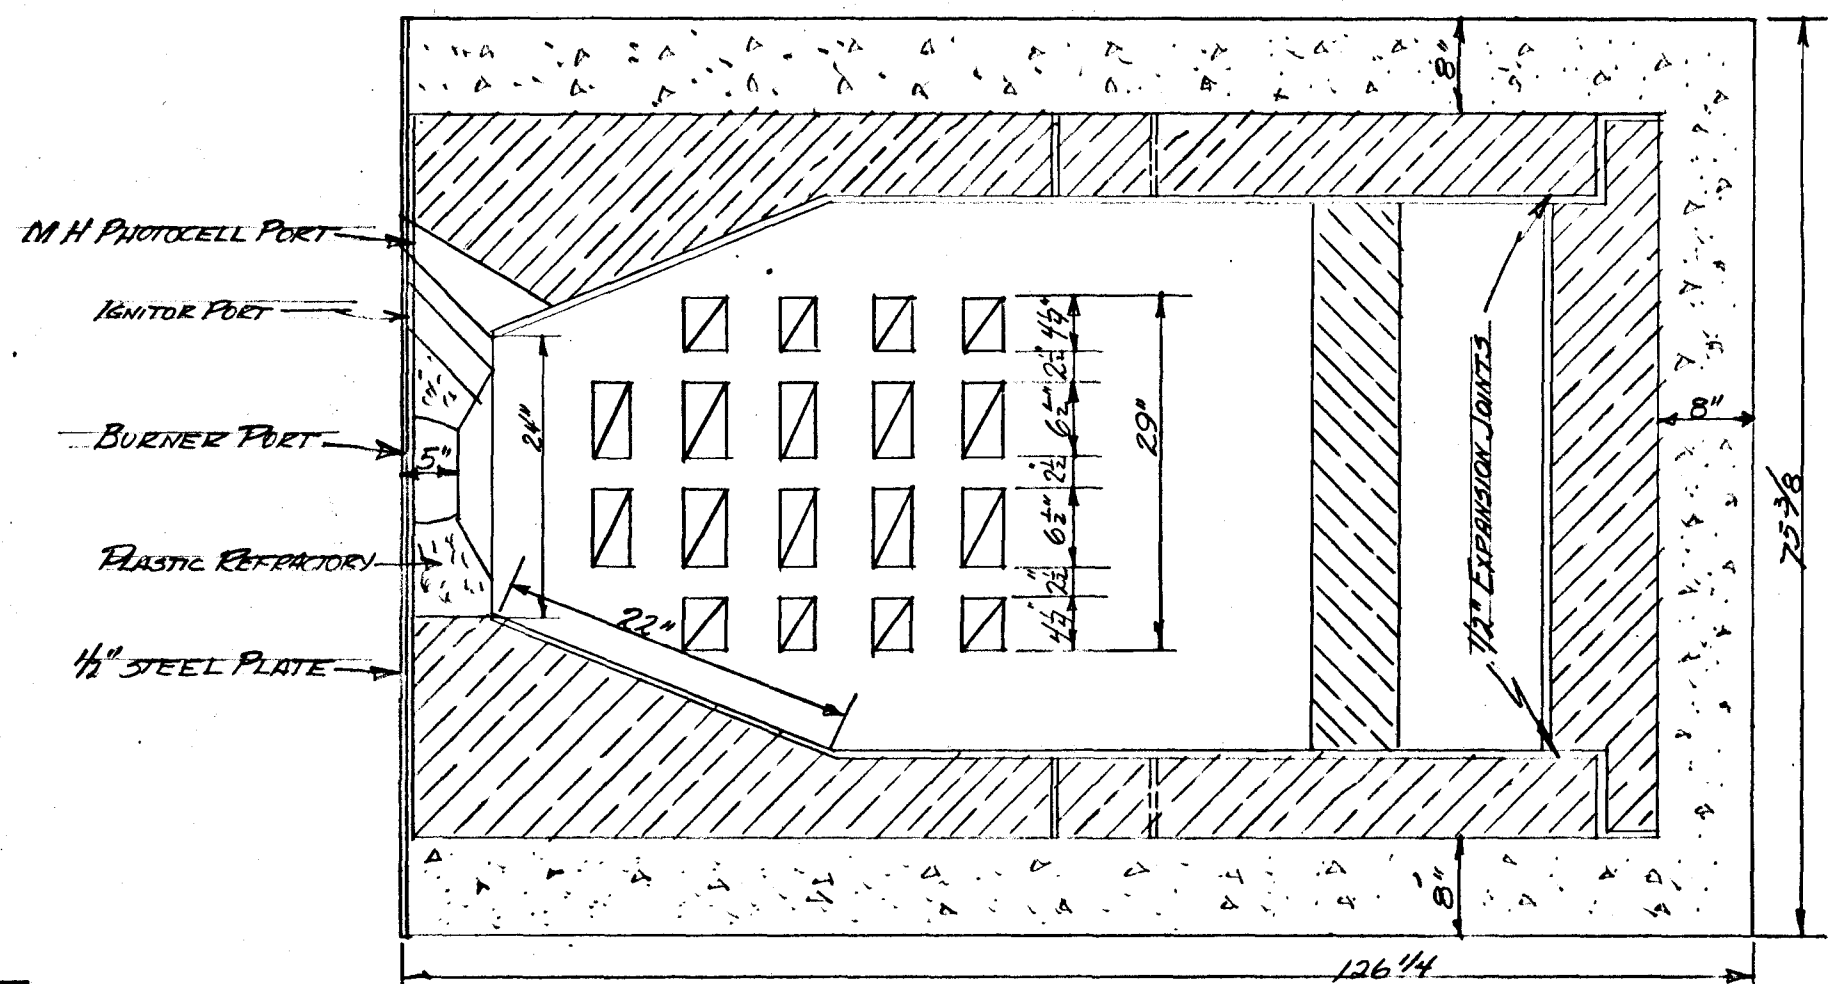


PLAN AT BURNER END OF
BOILER COMBUSTION CHAMBER
NO SCALE

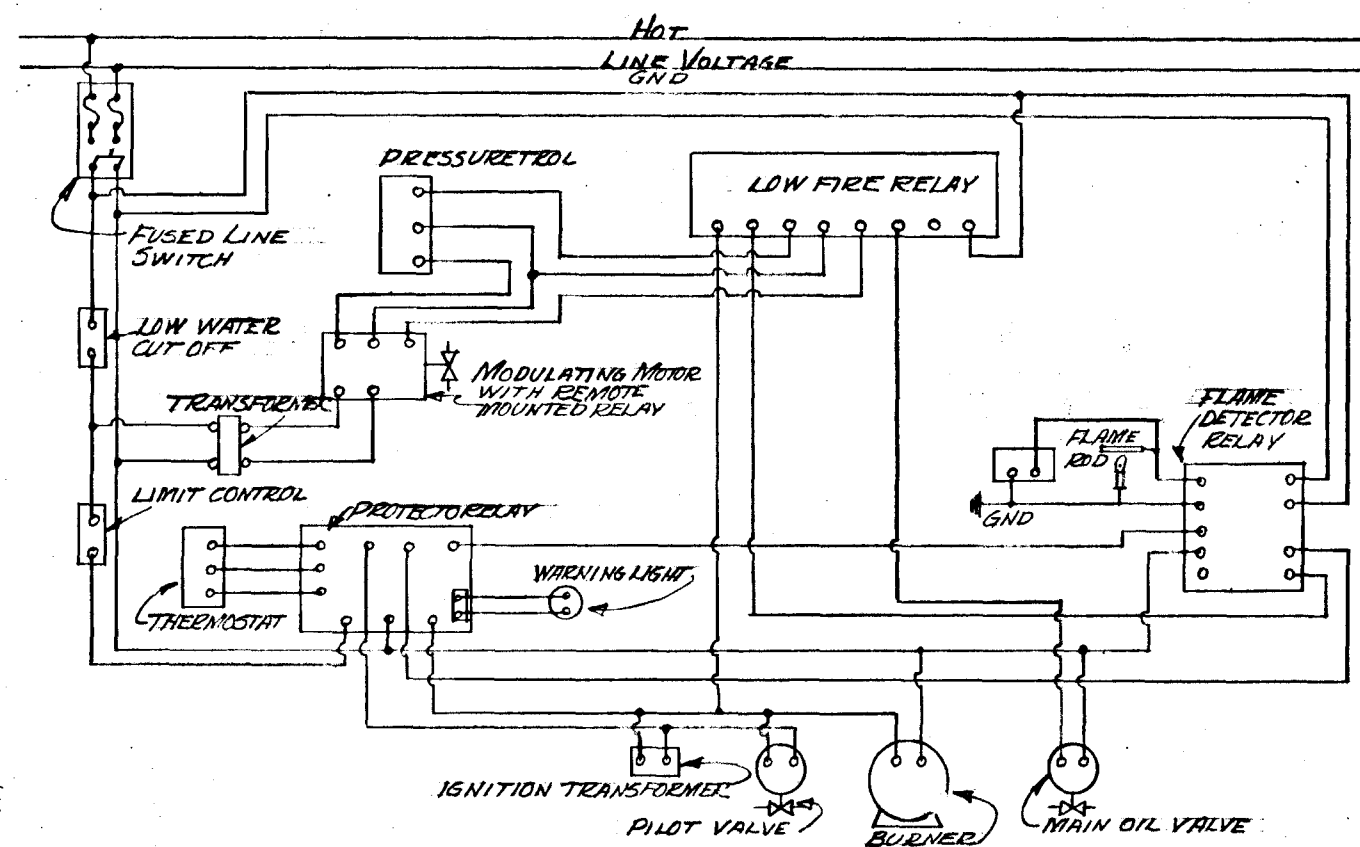


SCHEMATIC CONTROL DIAGRAM
FOR
EACH BURNER
NO SCALE

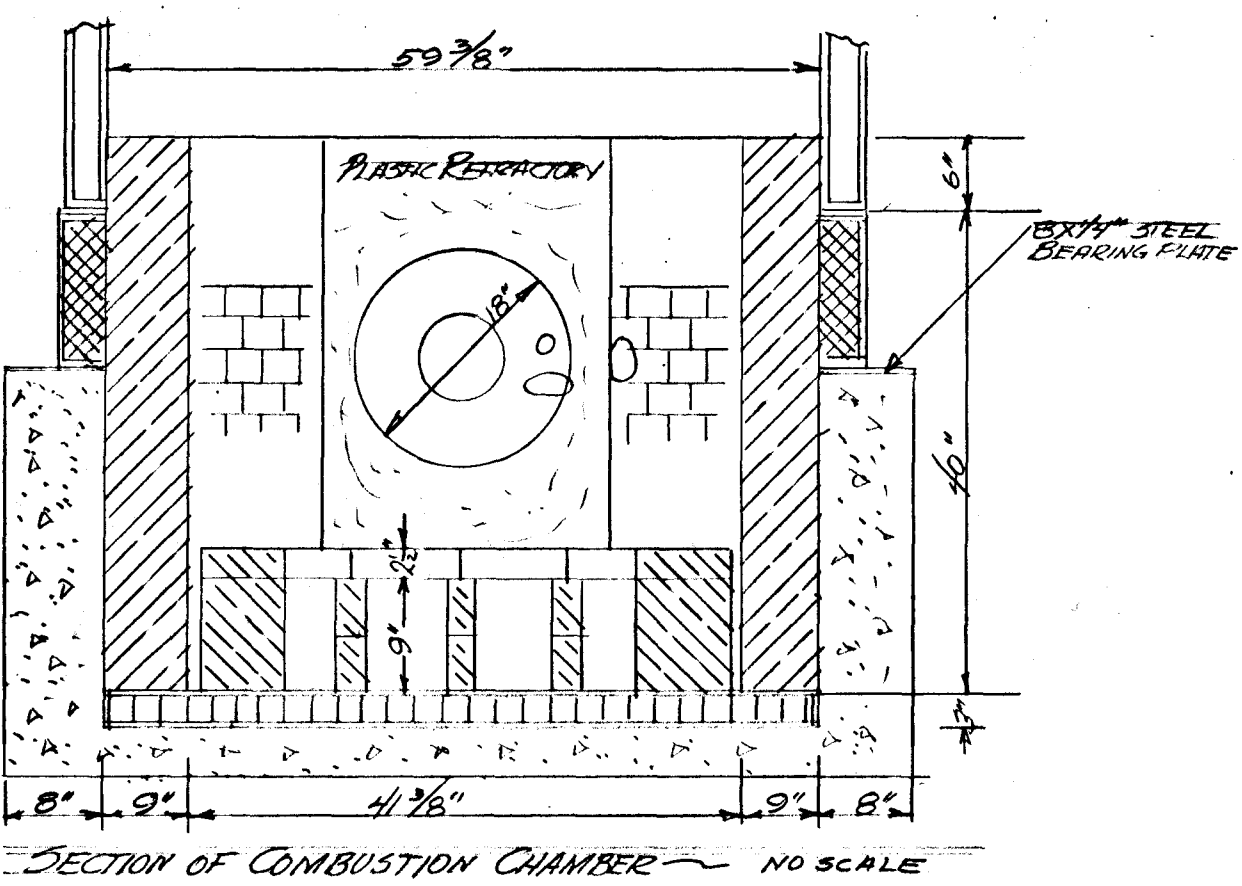

SECTION OF COMBUSTION CHAMBER
NO SCALE

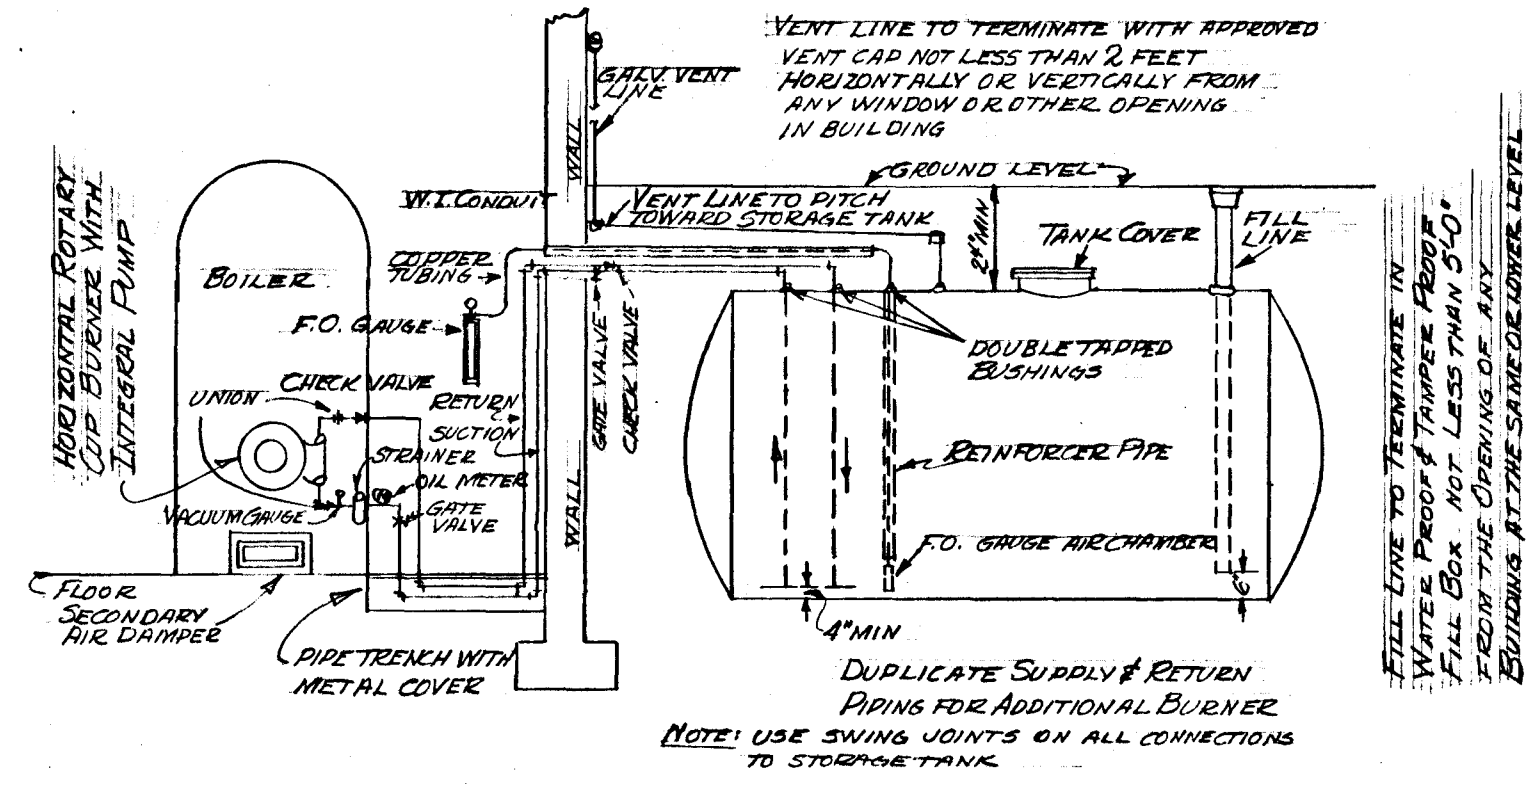

SCHEMATIC PIPING LAYOUT FOR OIL BURNER
NO SCALE

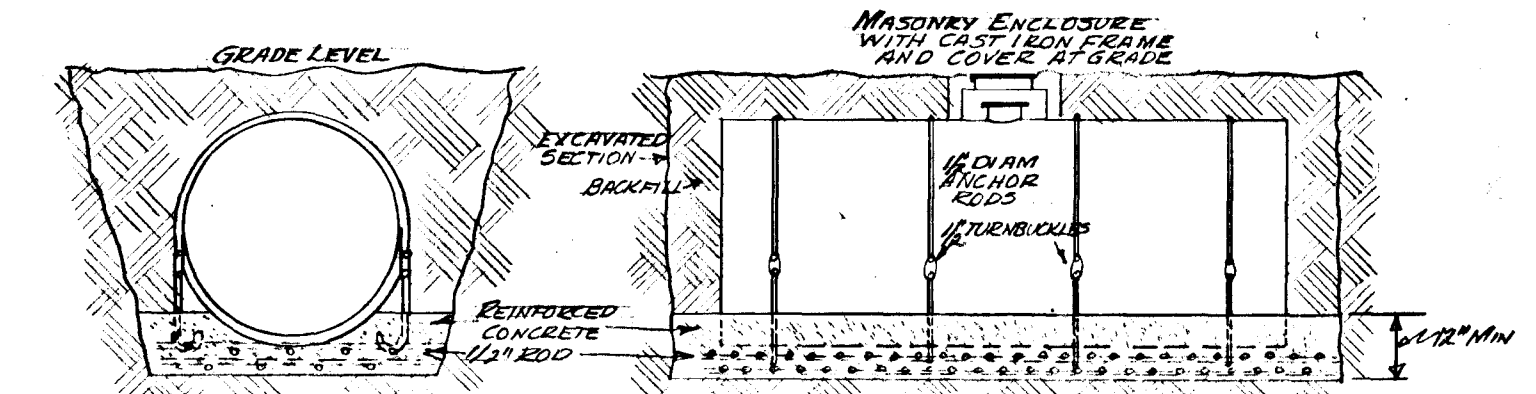

SKETCH OF
CONCRETE CRADLE FOR FUEL OIL TANK
NO SCALE

NOTE: VERIFY ALL DIMENSIONS AT THE SITE

CITY OF HARTFORD, CONNECTICUT DEPARTMENT OF ENGINEERING			
SUBMITTED Daniel A. Tancil DIVISION ENGINEER	RECOMMENDED Wm. J. W. Sullivan ASST. CITY ENGINEER	APPROVED [Signature] CITY ENGINEER	DAYBOOK NO. 89105
DESIGN	DRAWN	DATE	AUG. 11, 1950
TRACED	CHECK		

CONVERSION TO OIL BURNER MOYLAN ELEMENTARY SCHOOL 235 HILLSIDE AVENUE HARTFORD, CONN.			
REVISIONS	JEROME F. MUELLER CONSULTING ENGINEER	PLAN NO.	23
		SCALE	AS NOTED
		SHEET NO.	1 OF 1
15 LEWIS ST.		HARTFORD, CONN.	