


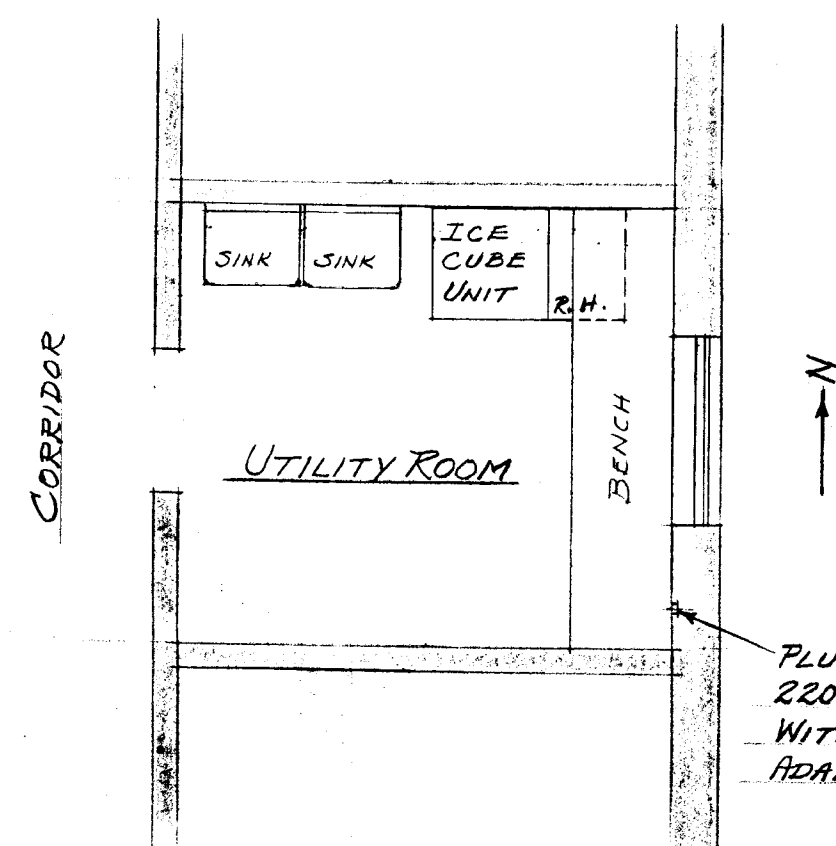
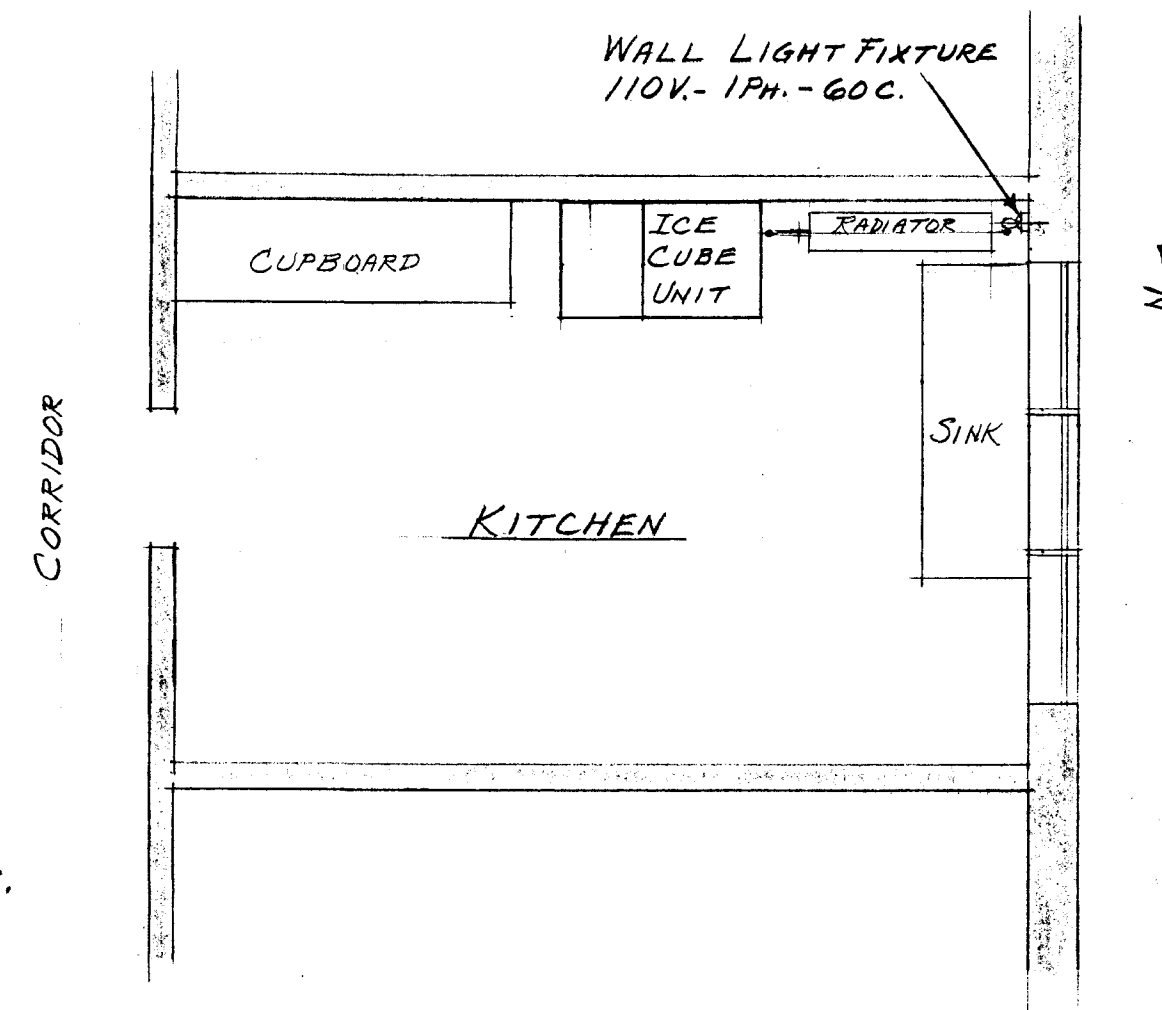


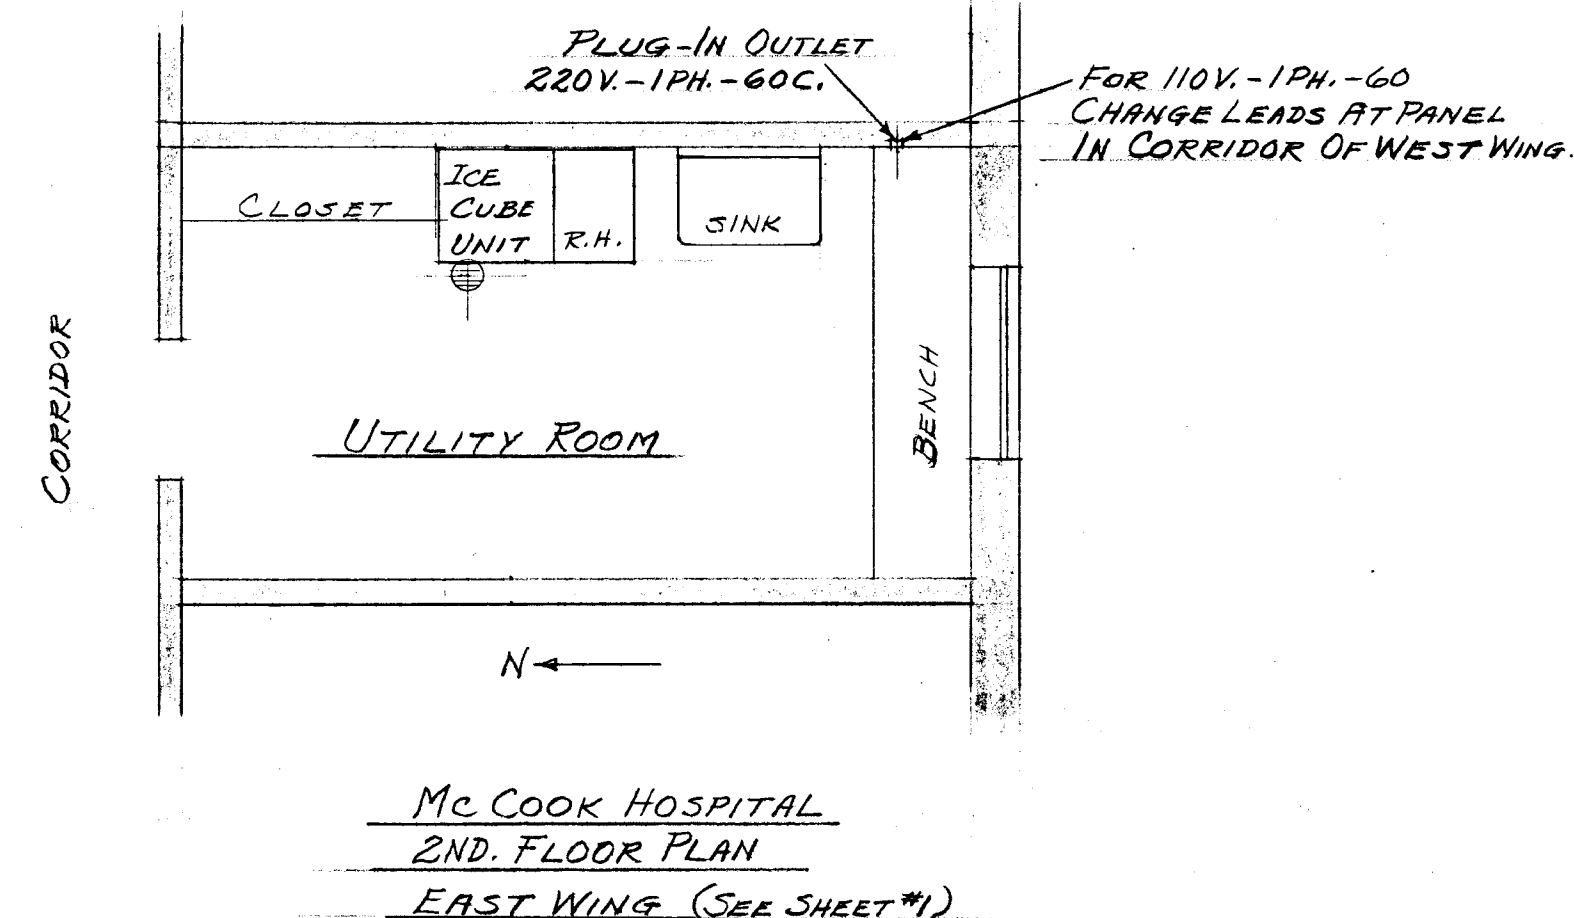

ISOLATION BLDG.
1ST. FLOOR PLAN

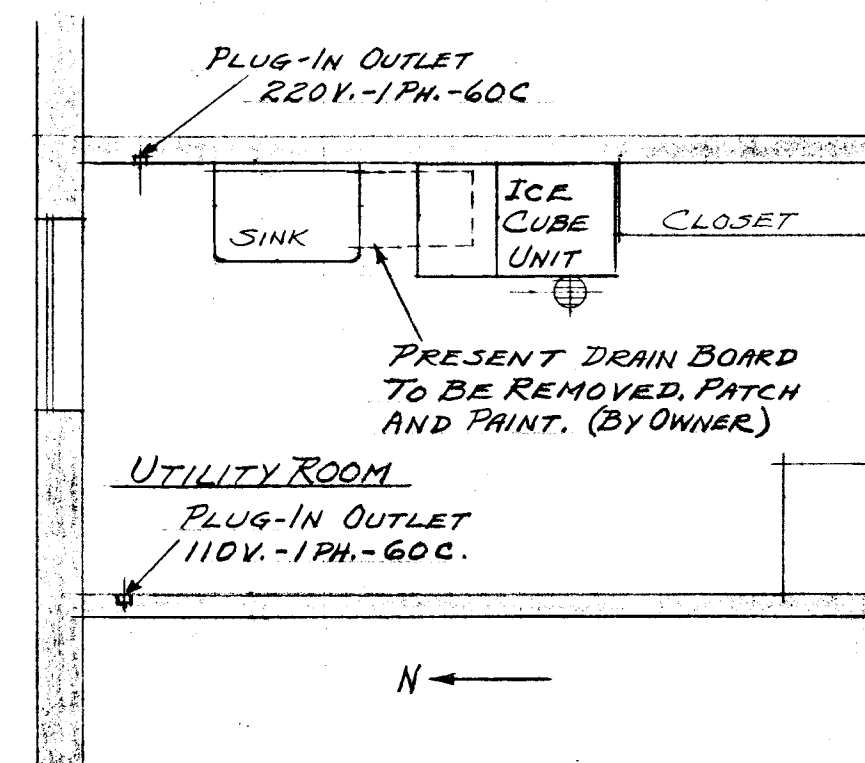

T.B. BLDG.
1ST. FLOOR PLAN

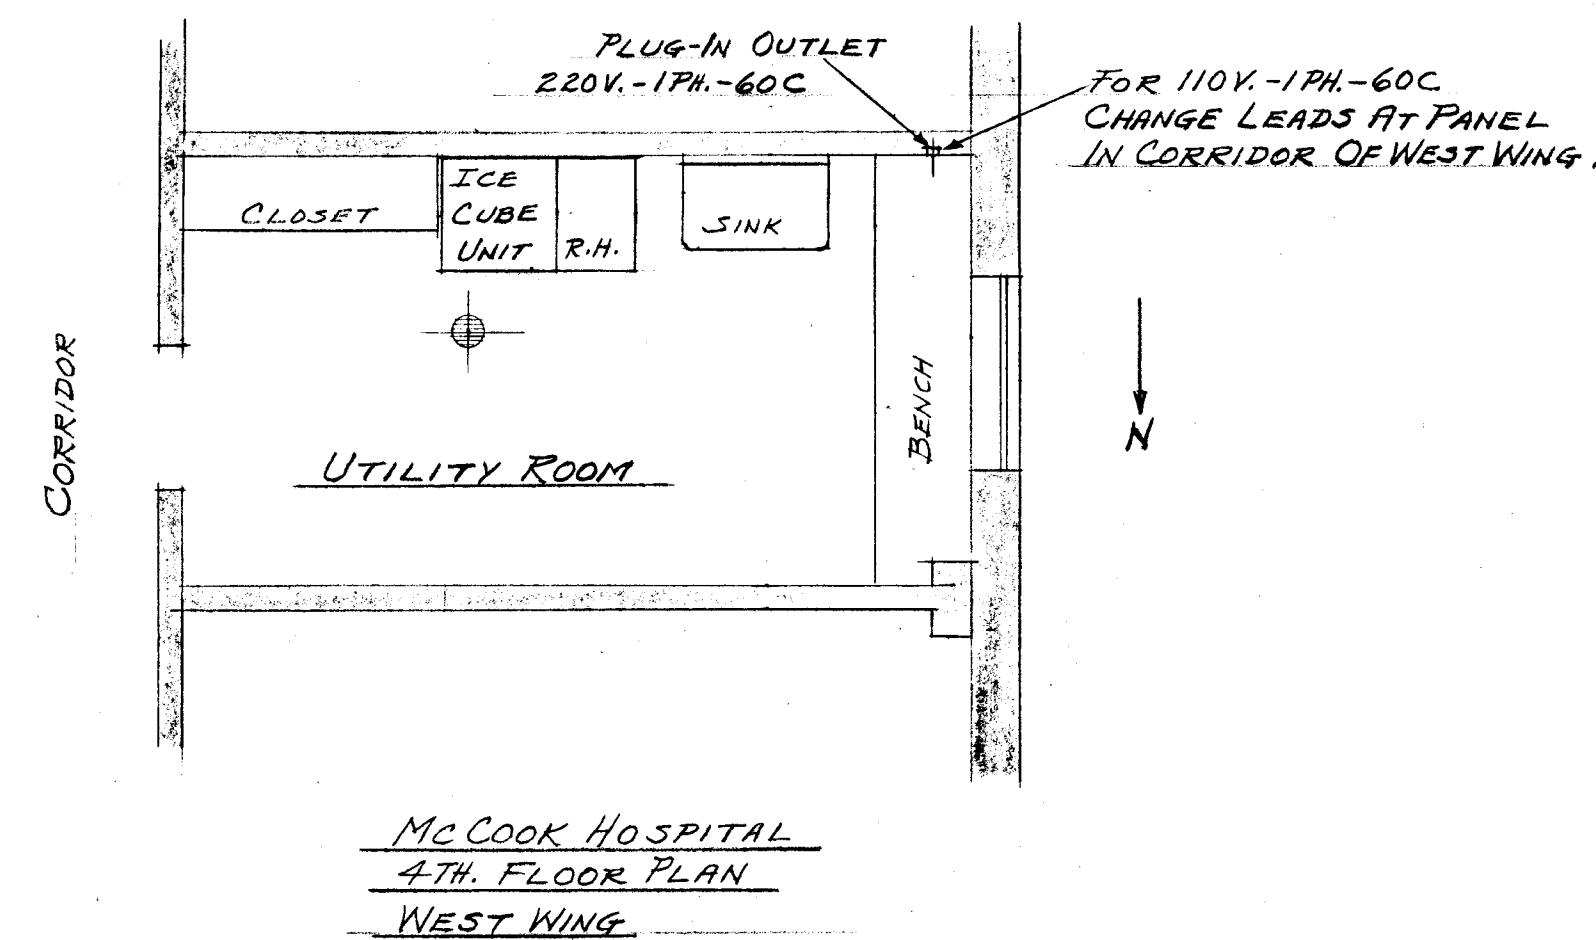


ALL ICE CUBE FREEZING UNITS ARE TO BE INSTALLED
IN THE VARIOUS UTILITY ROOMS AS SHOWN, EXCEPT
THE TWO IN KITCHENS.

UNITS REQUIRE NO WATER CONNECTION OR DRAIN.
ALL UTILITY ROOMS HAVE FLOOR DRAIN.

CURRENT AVAILABLE IS AS INDICATED. ALL EXTENSIONS
TO BE MADE WITH WIREMOLD, TO PROVIDE PLUG-IN CONNECTIONS.

CAPACITY PER UNIT APPROX. 250 LBS. PER DAY

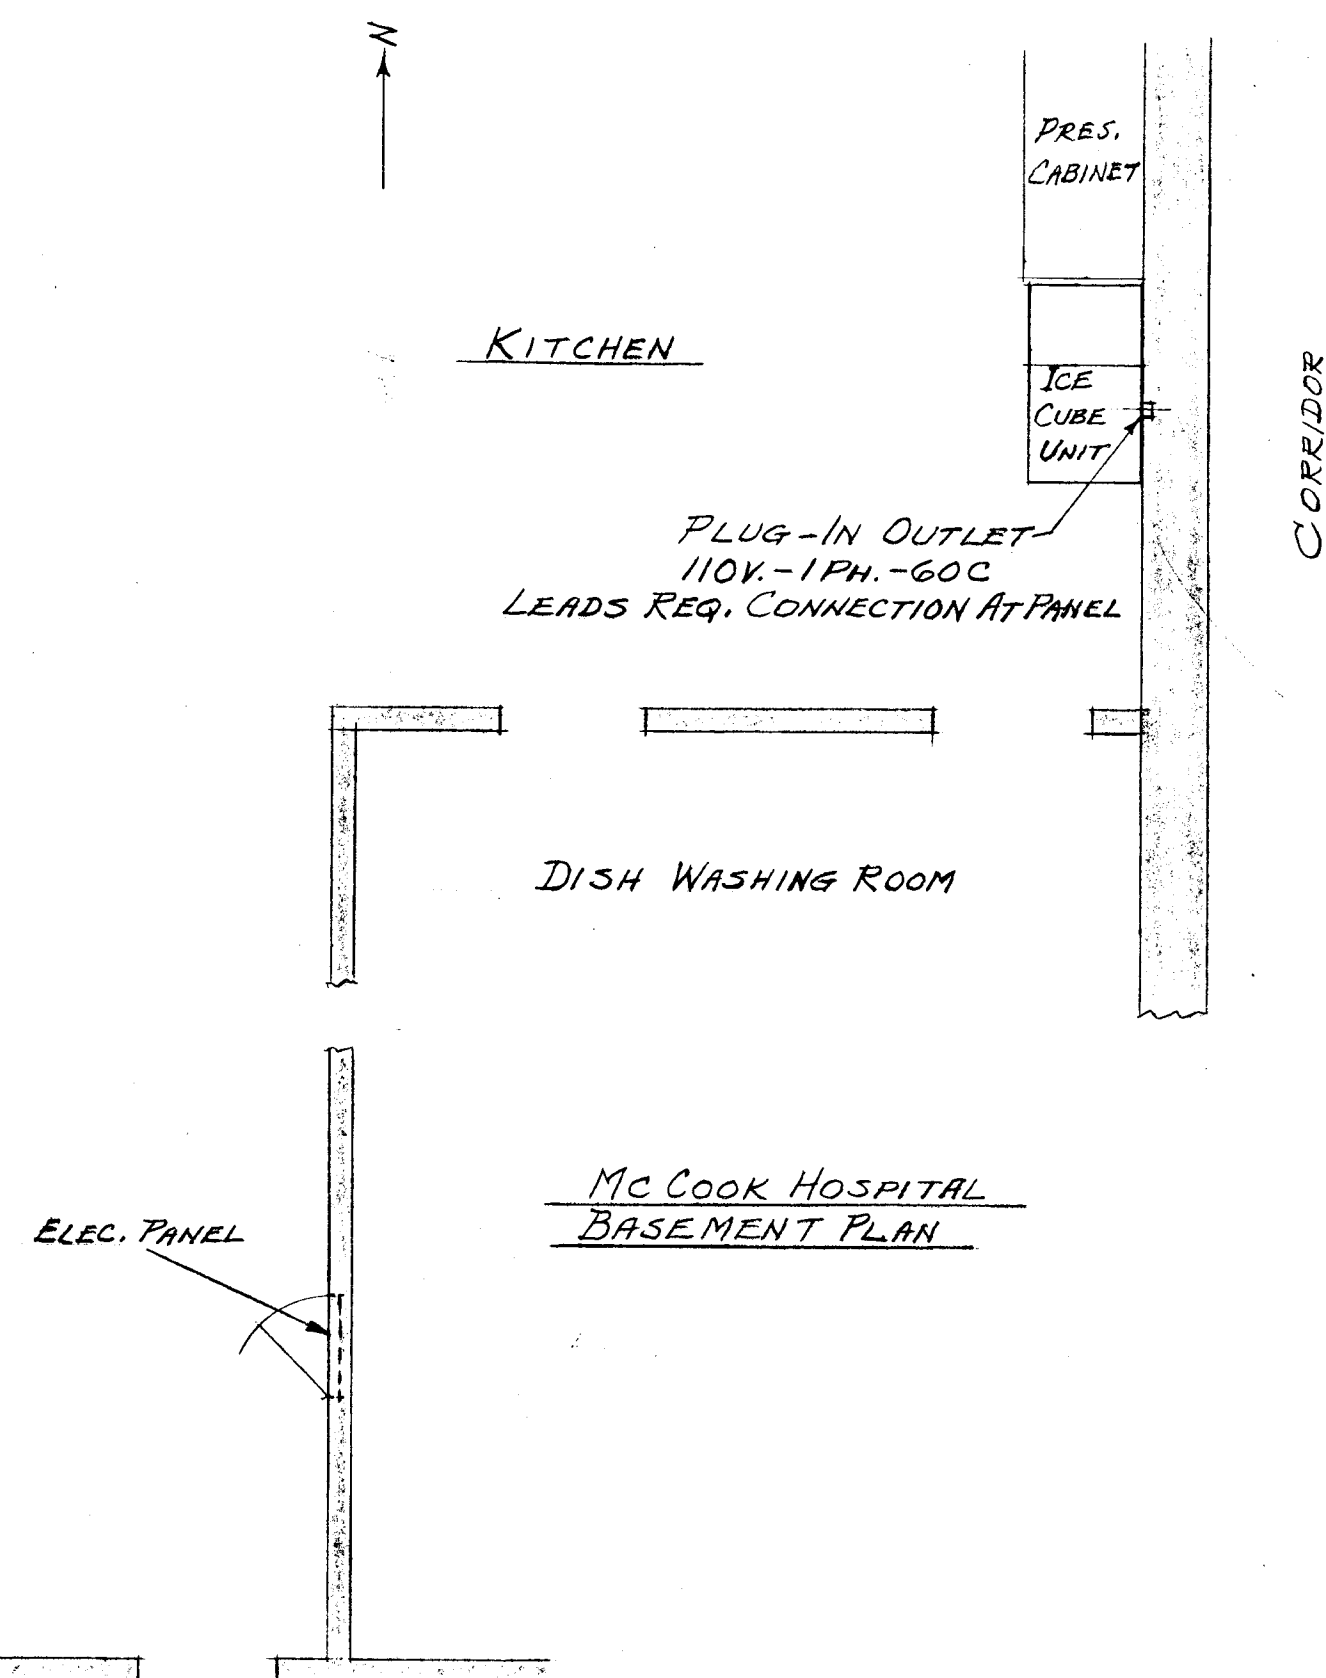

VERIFY EXISTING
CONDITIONS AND
DIMENSIONS AT
BUILDING

CITY OF HARTFORD, CONNECTICUT DEPARTMENT OF ENGINEERING			
REFRIGERATION & ICE CUBE MAKERS FOR JOHN J. MCCOOK MEMORIAL HOSPITAL 2 HOLCOMB ST. HARTFORD, CONN.			
SUBMITTED DIVISION ENGINEER	RECOMMENDED ASST. CITY ENG.	APPROVED CITY ENGINEER	
DESIGN	DRAWN	DAYBOOK NO. 09738-D	
TRACED	CHECK	DATE	

SHEET No.
2