



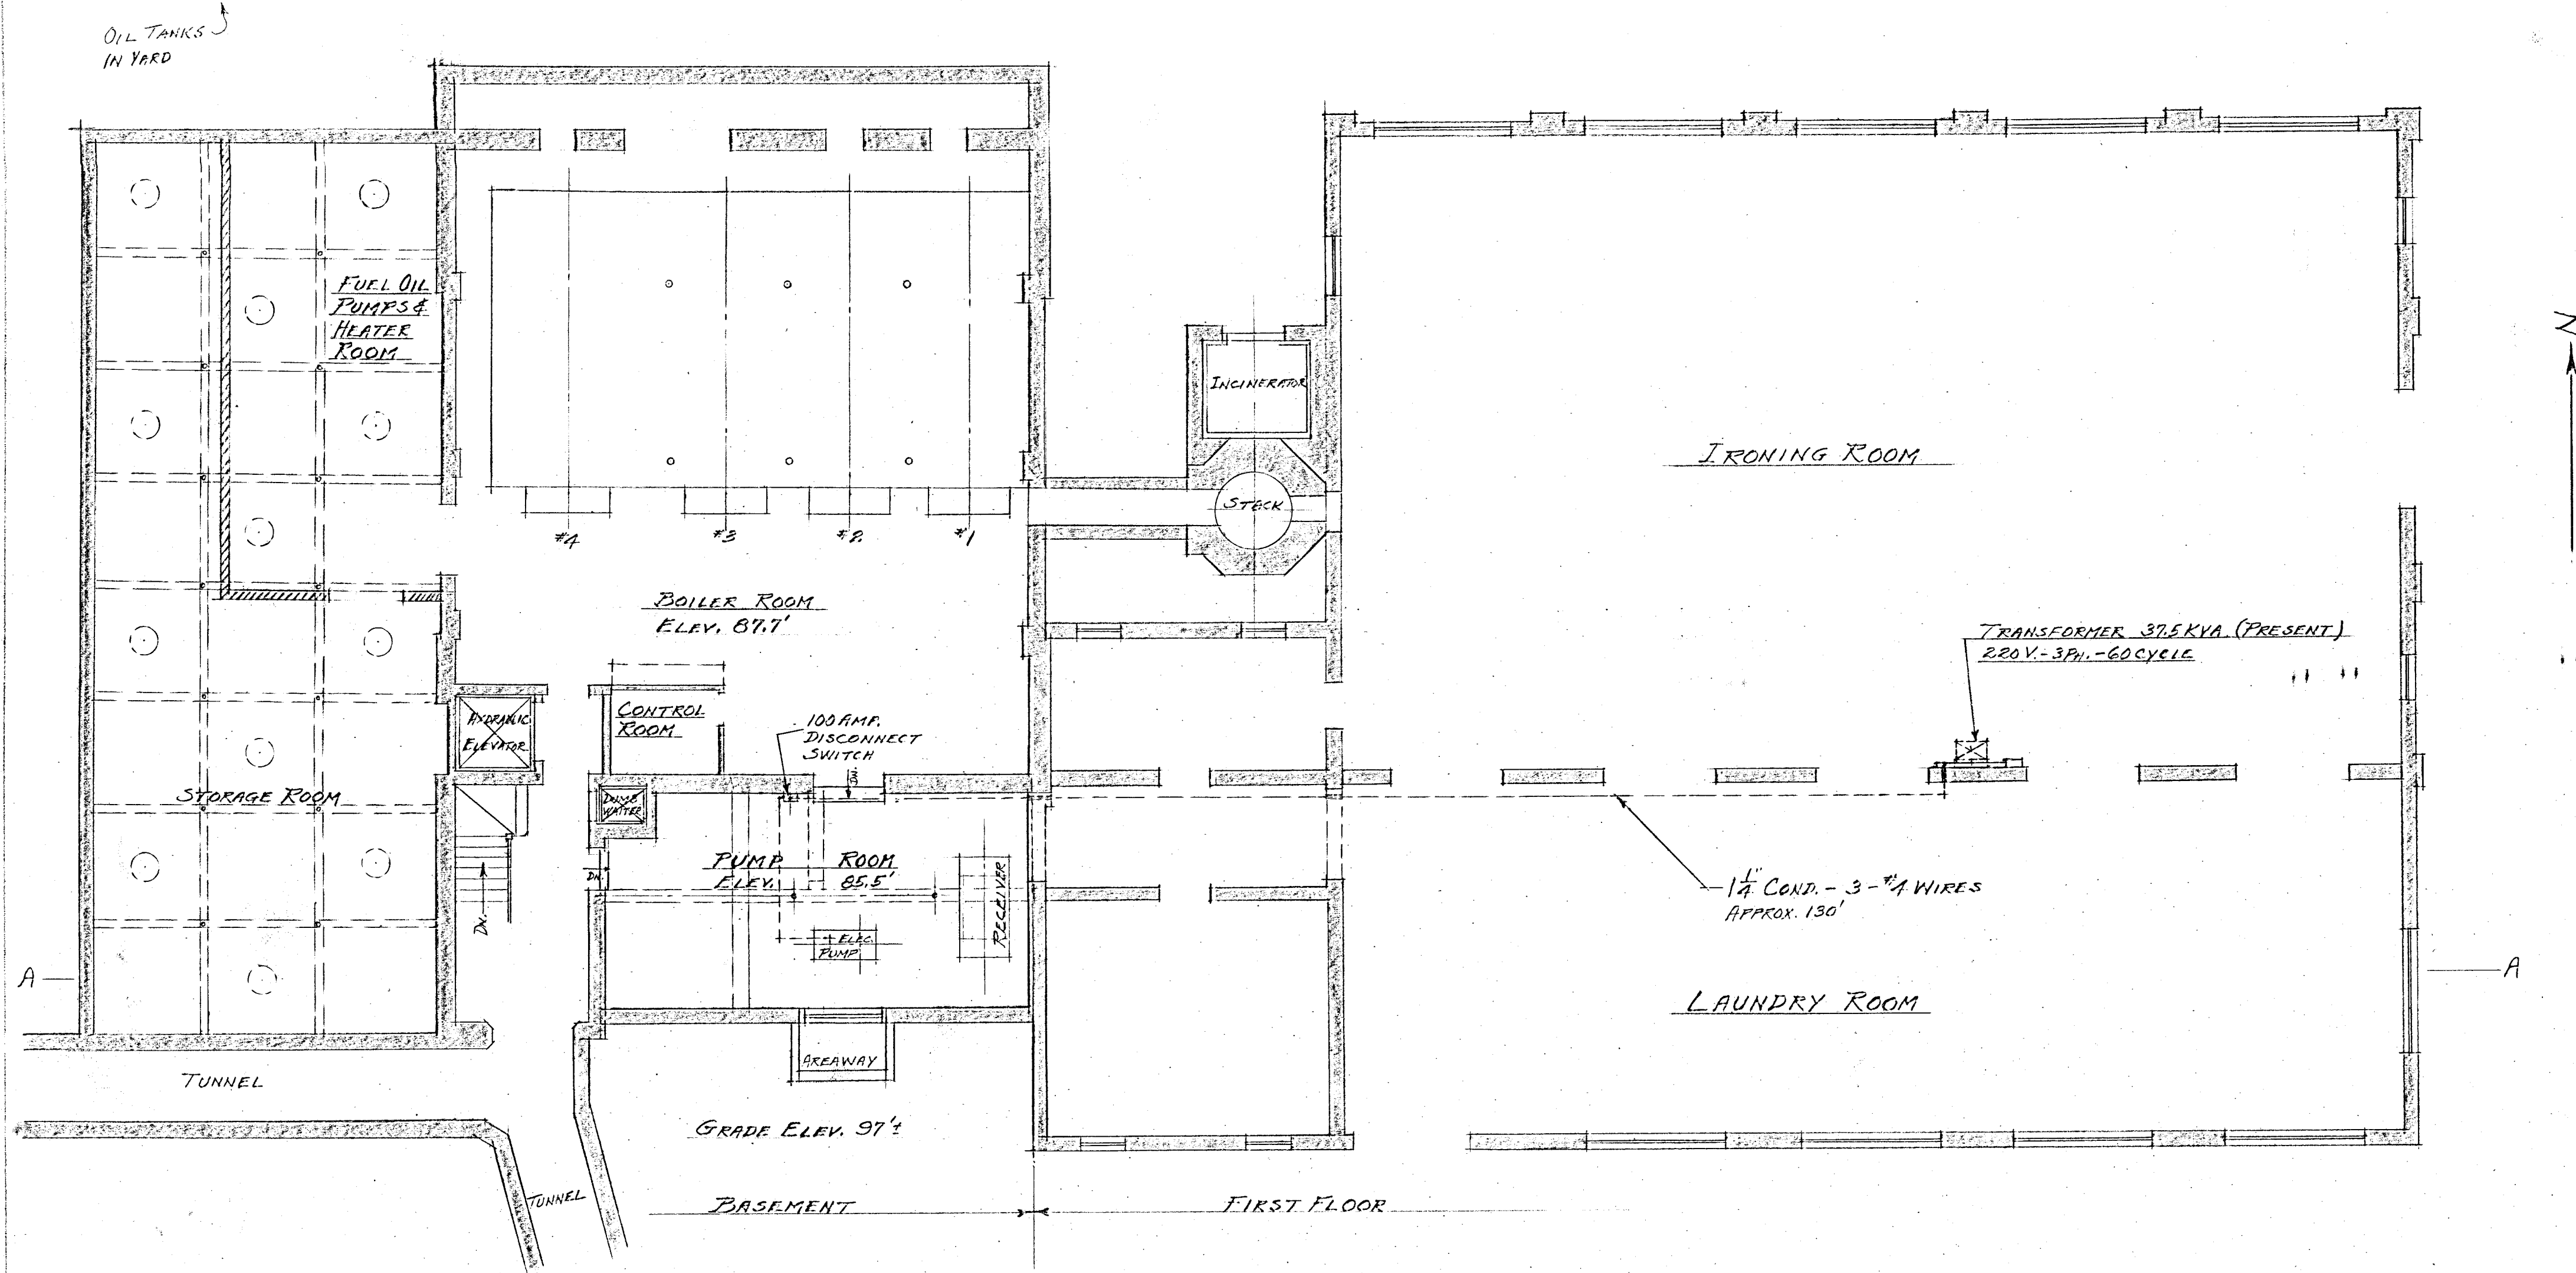

PLAN OF BOILER, PUMP AND LAUNDRY ROOMS  
SCALE - 1/8" = 1'-0"

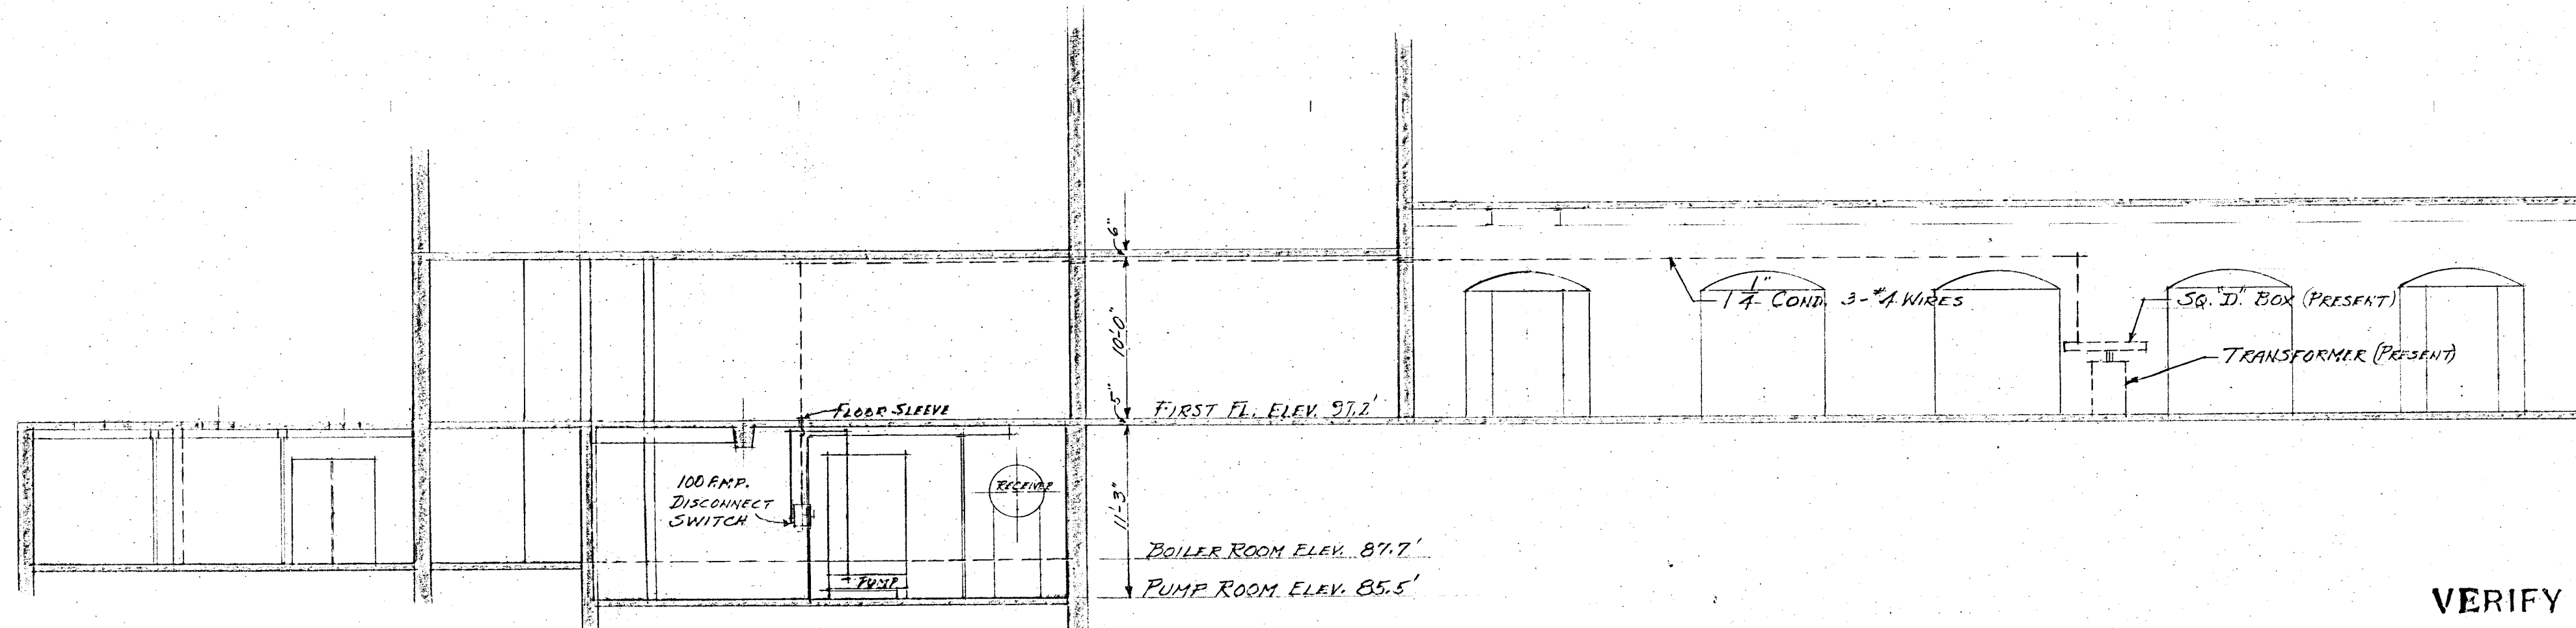

SECTION A-A  
SCALE - 1/8" = 1'-0"

VERIFY EXISTING  
CONDITIONS AND  
DIMENSIONS AT  
BUILDING

|                                                            |                              |                         |  |
|------------------------------------------------------------|------------------------------|-------------------------|--|
| No. 2<br>OF 3 SHEETS                                       |                              |                         |  |
| CITY OF HARTFORD, CONNECTICUT<br>DEPARTMENT OF ENGINEERING |                              |                         |  |
| BOILER FEED PUMP AND CONDENSATE RECEIVER                   |                              |                         |  |
| ELECTRICAL LAYOUT                                          |                              |                         |  |
| JOHN J. MCCOOK MEMORIAL HOSPITAL<br>2 HOLCOMB STREET       |                              |                         |  |
| SUBMITTED<br>Daniel J. Taillor                             | RECOMMENDED<br>Wm. W. Bulley | APPROVED<br>G. J. Davis |  |
| DIVISION ENGINEER                                          | ASST. CITY ENG.              | CITY ENGINEER           |  |
| DESIGN                                                     | DRAWN<br>H.S.L.              | DAYBOOK NO. 09171-B     |  |
| TRACED                                                     | CHECK                        | DATE OCT. 26, 1951      |  |