



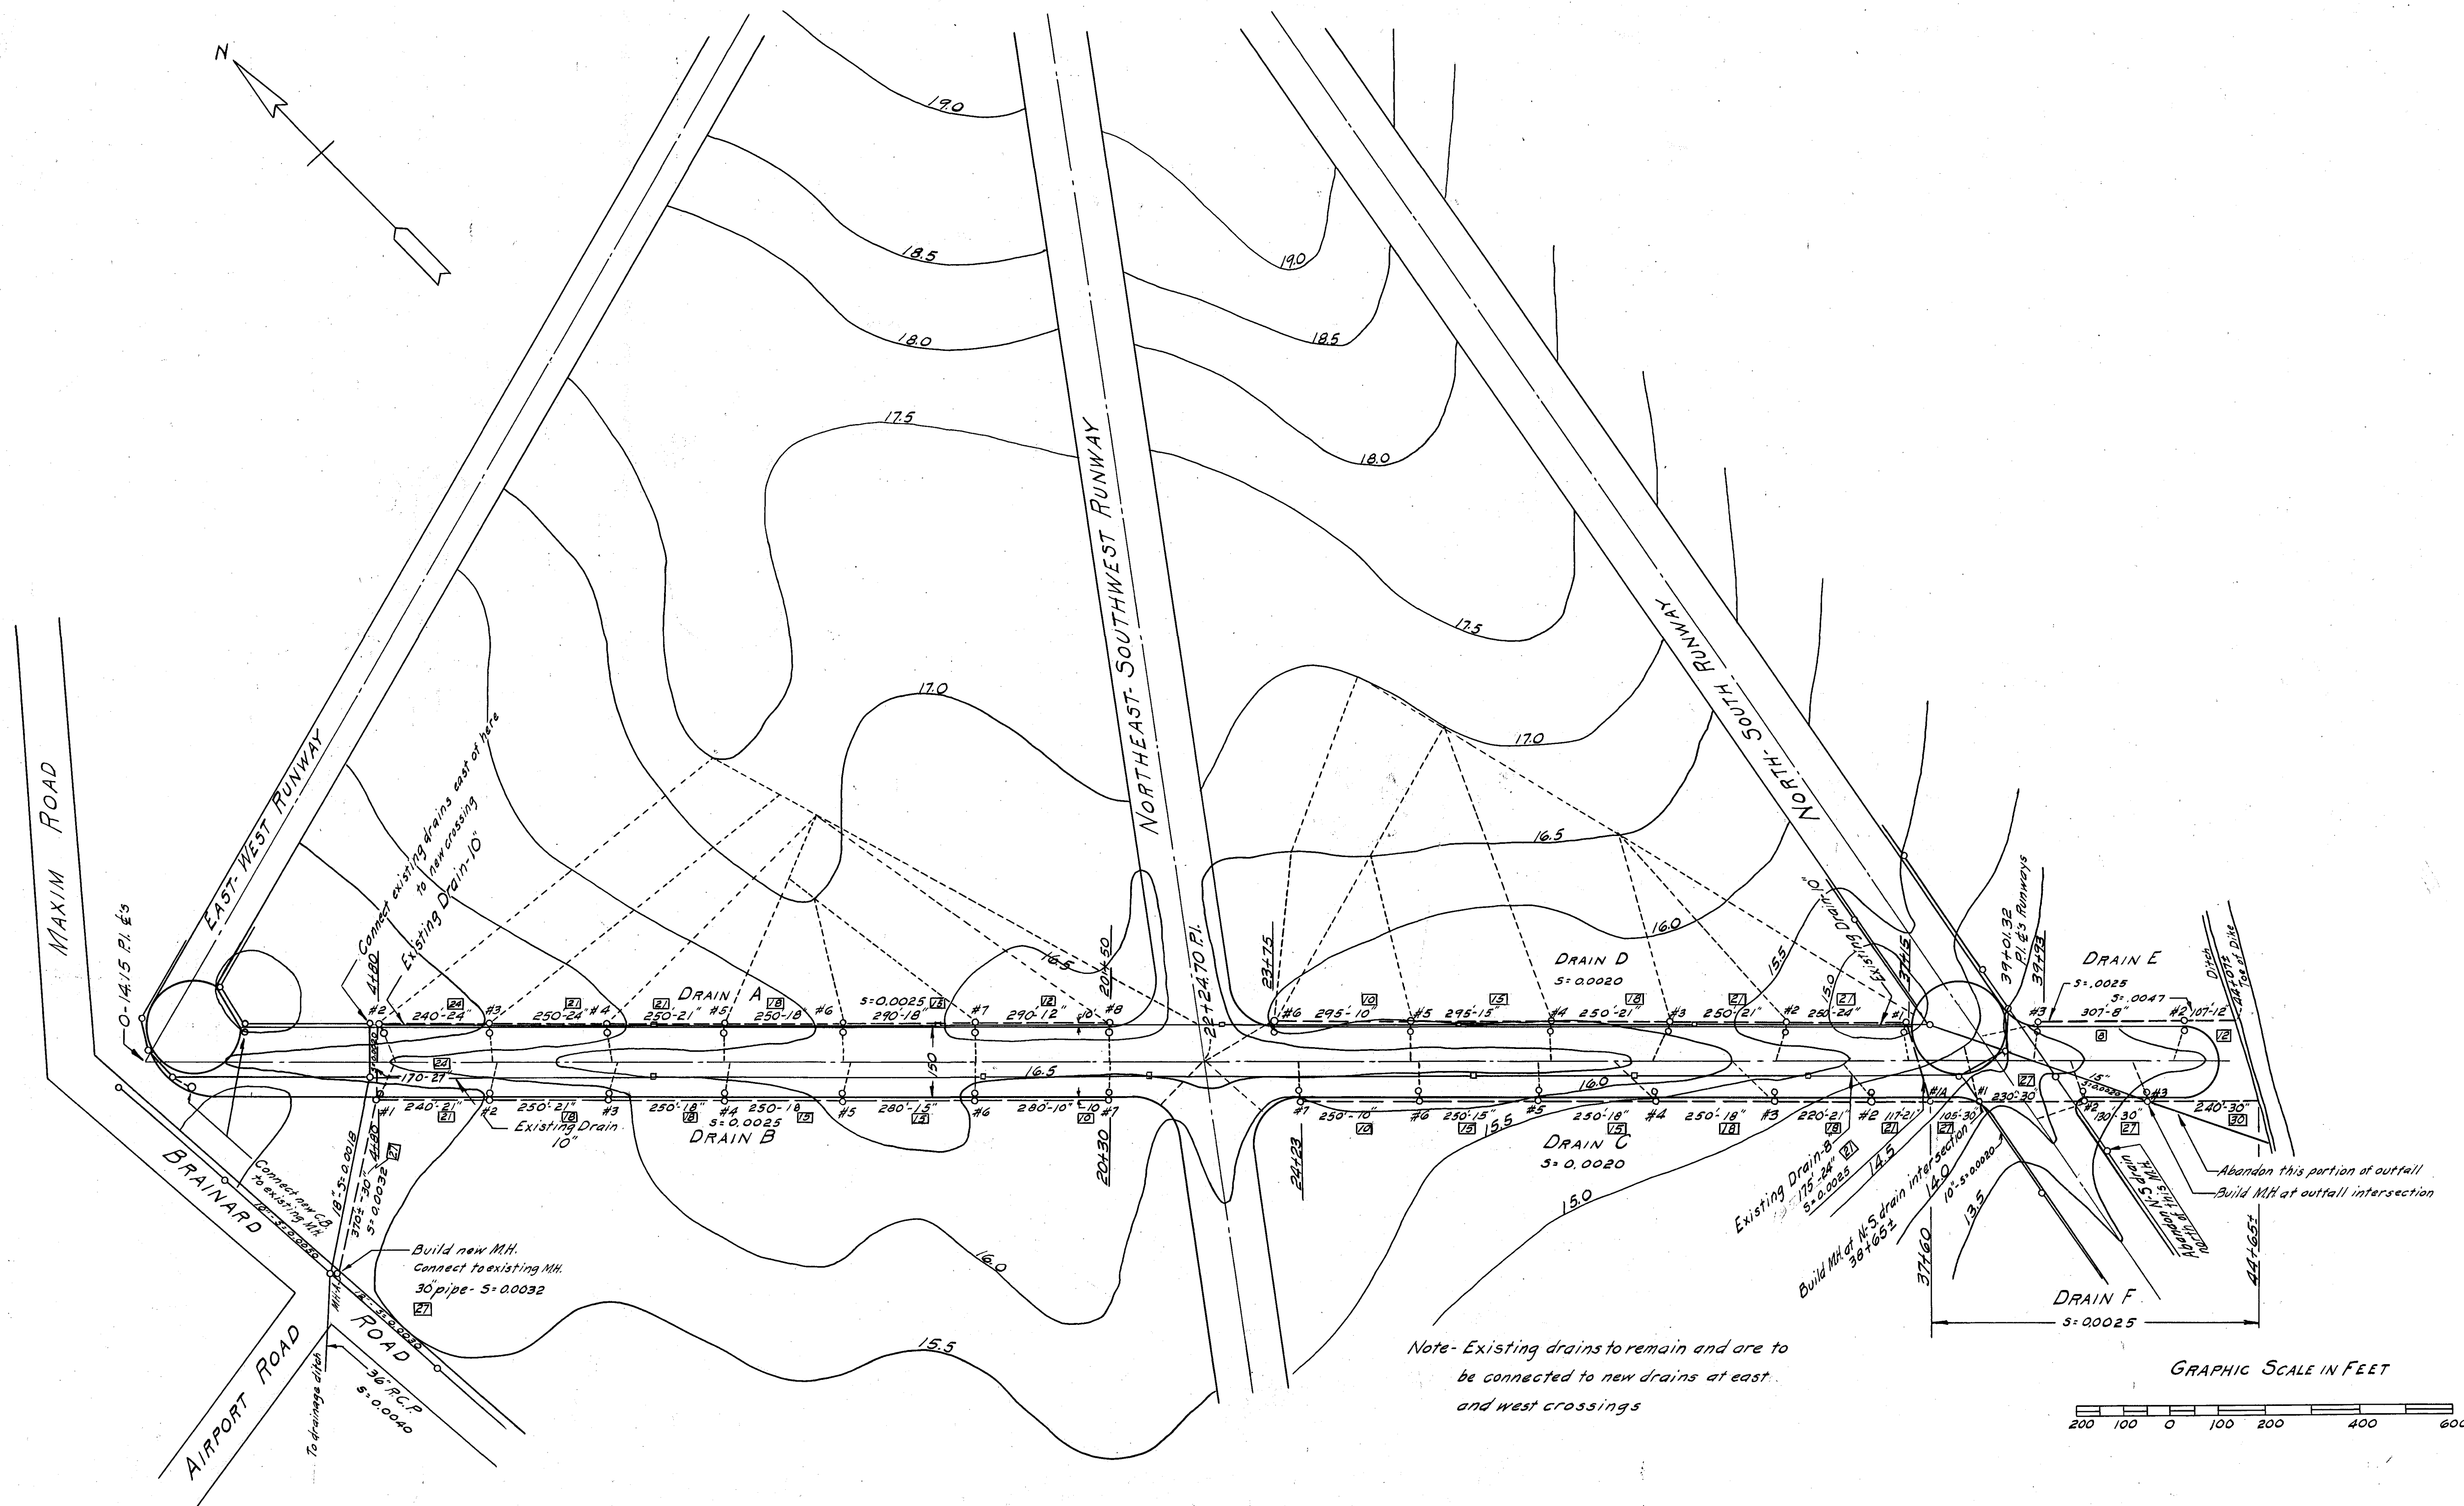

Note- Existing drains to remain and are to be connected to new drains at east and west crossings

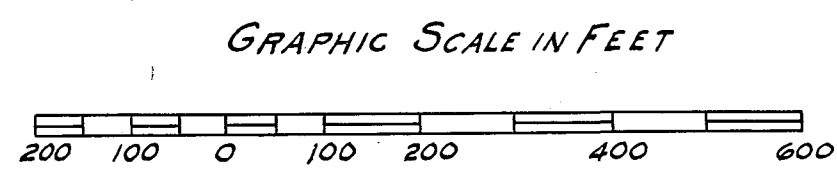

- LEGEND**
- DRAINAGE LIMITS
 - EXISTING DRAINS
 - NEW DRAINS
 - 160— FINISHED CONTOURS
 - EXISTING M.H. & DRAIN
M.H.'S TO BE LOWERED- SOUTH DRAIN ONLY
SEE DETAIL

Note- Pipe sizes shown thus-18" indicate corrugated pipe
Pipe sizes shown thus-18 indicate concrete pipe

CITY OF HARTFORD, CONN.		
HARTFORD MUNICIPAL AIRPORT		
DRAINAGE PLAN		
City of Hartford		Department of Engineering
APPROVED DATE		City Engineer
APPROVED DATE		
DRAWN		CHECKED
DATE	SHEET 7 OF 18	CONN. PROJECT NO.
DAYBOOK NO. 08982		