

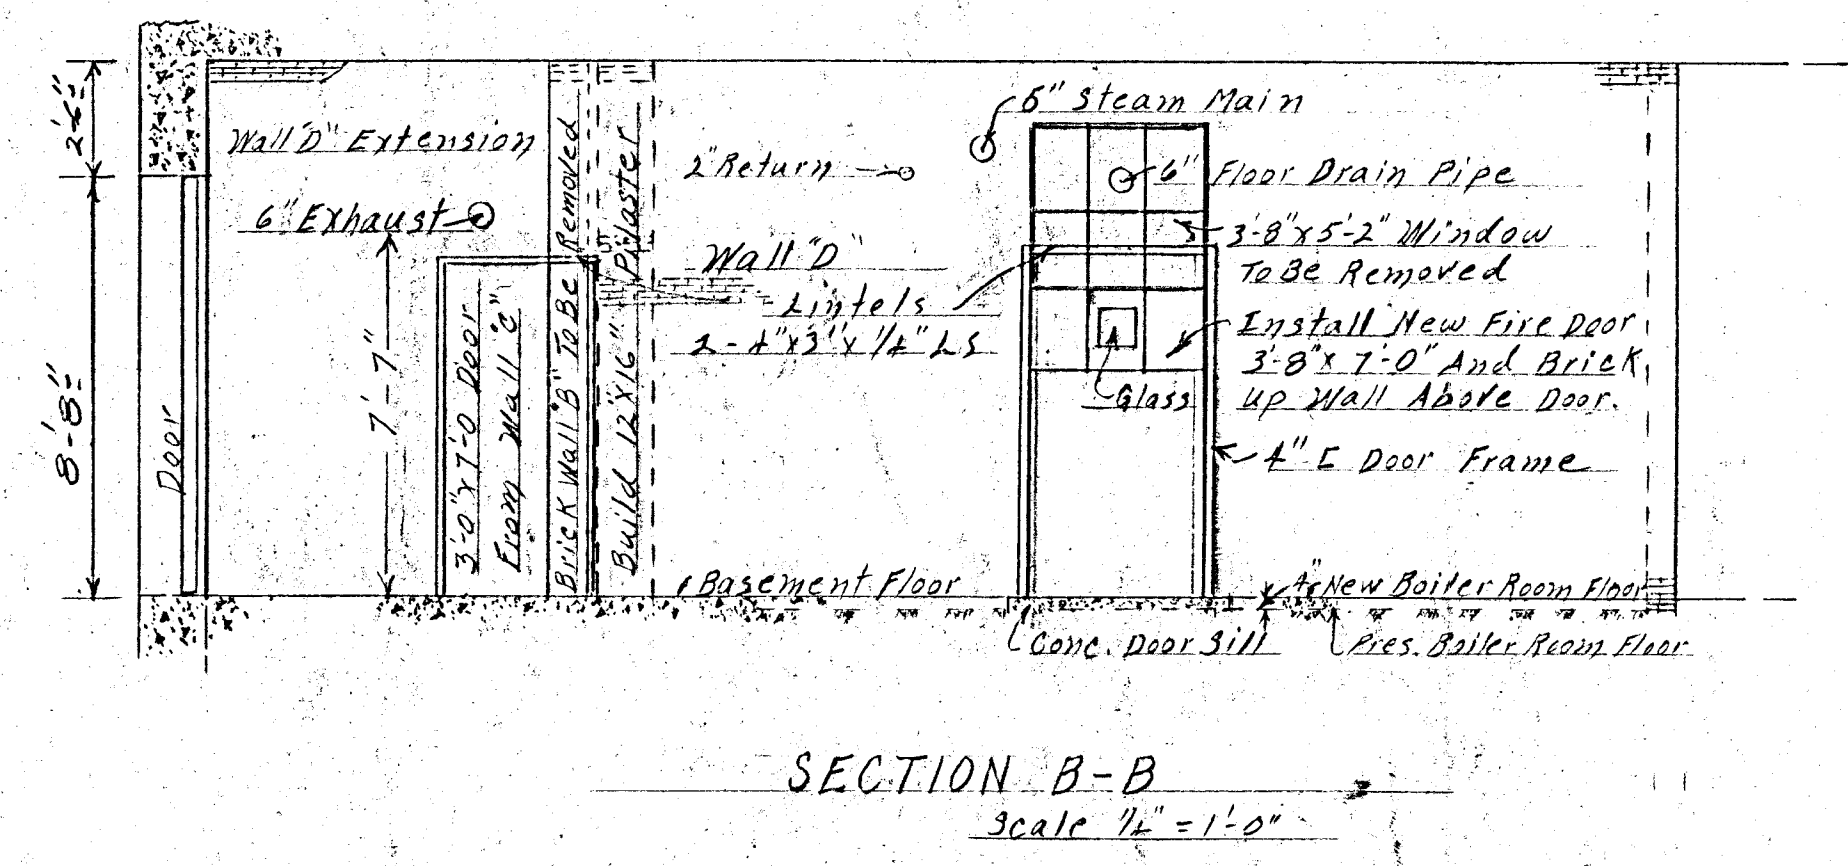
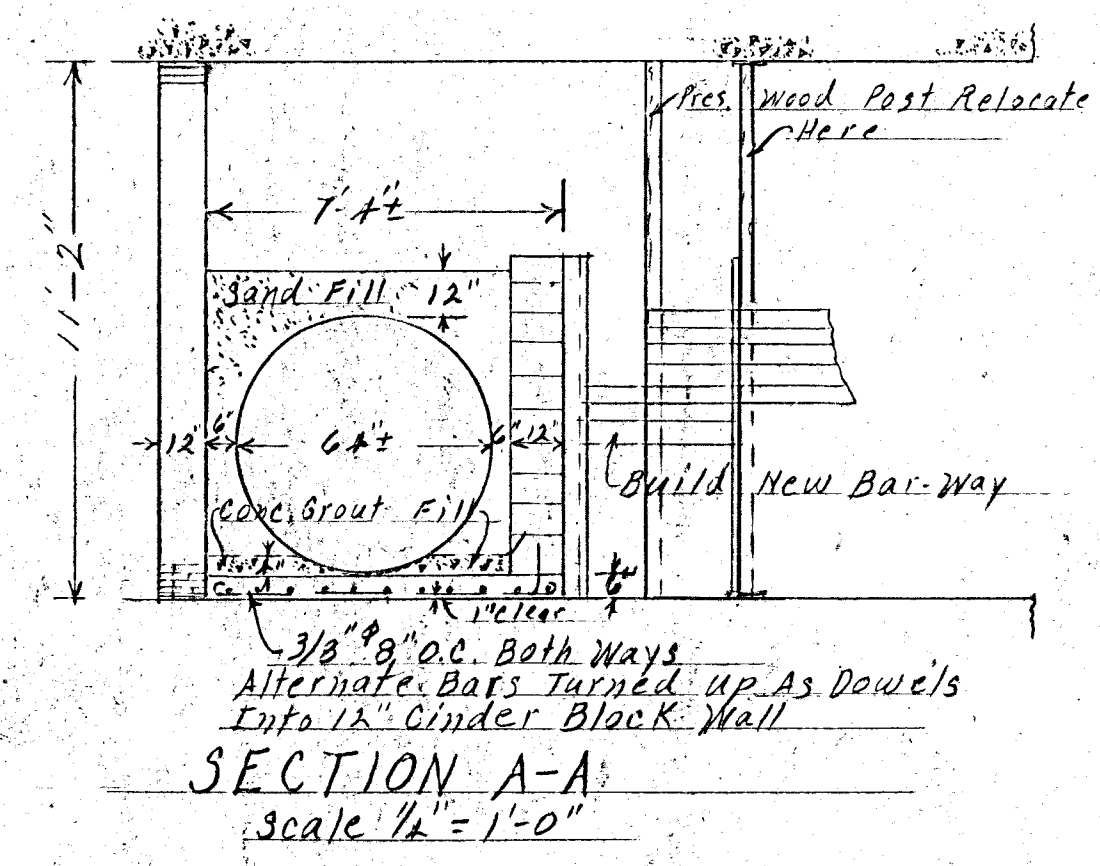
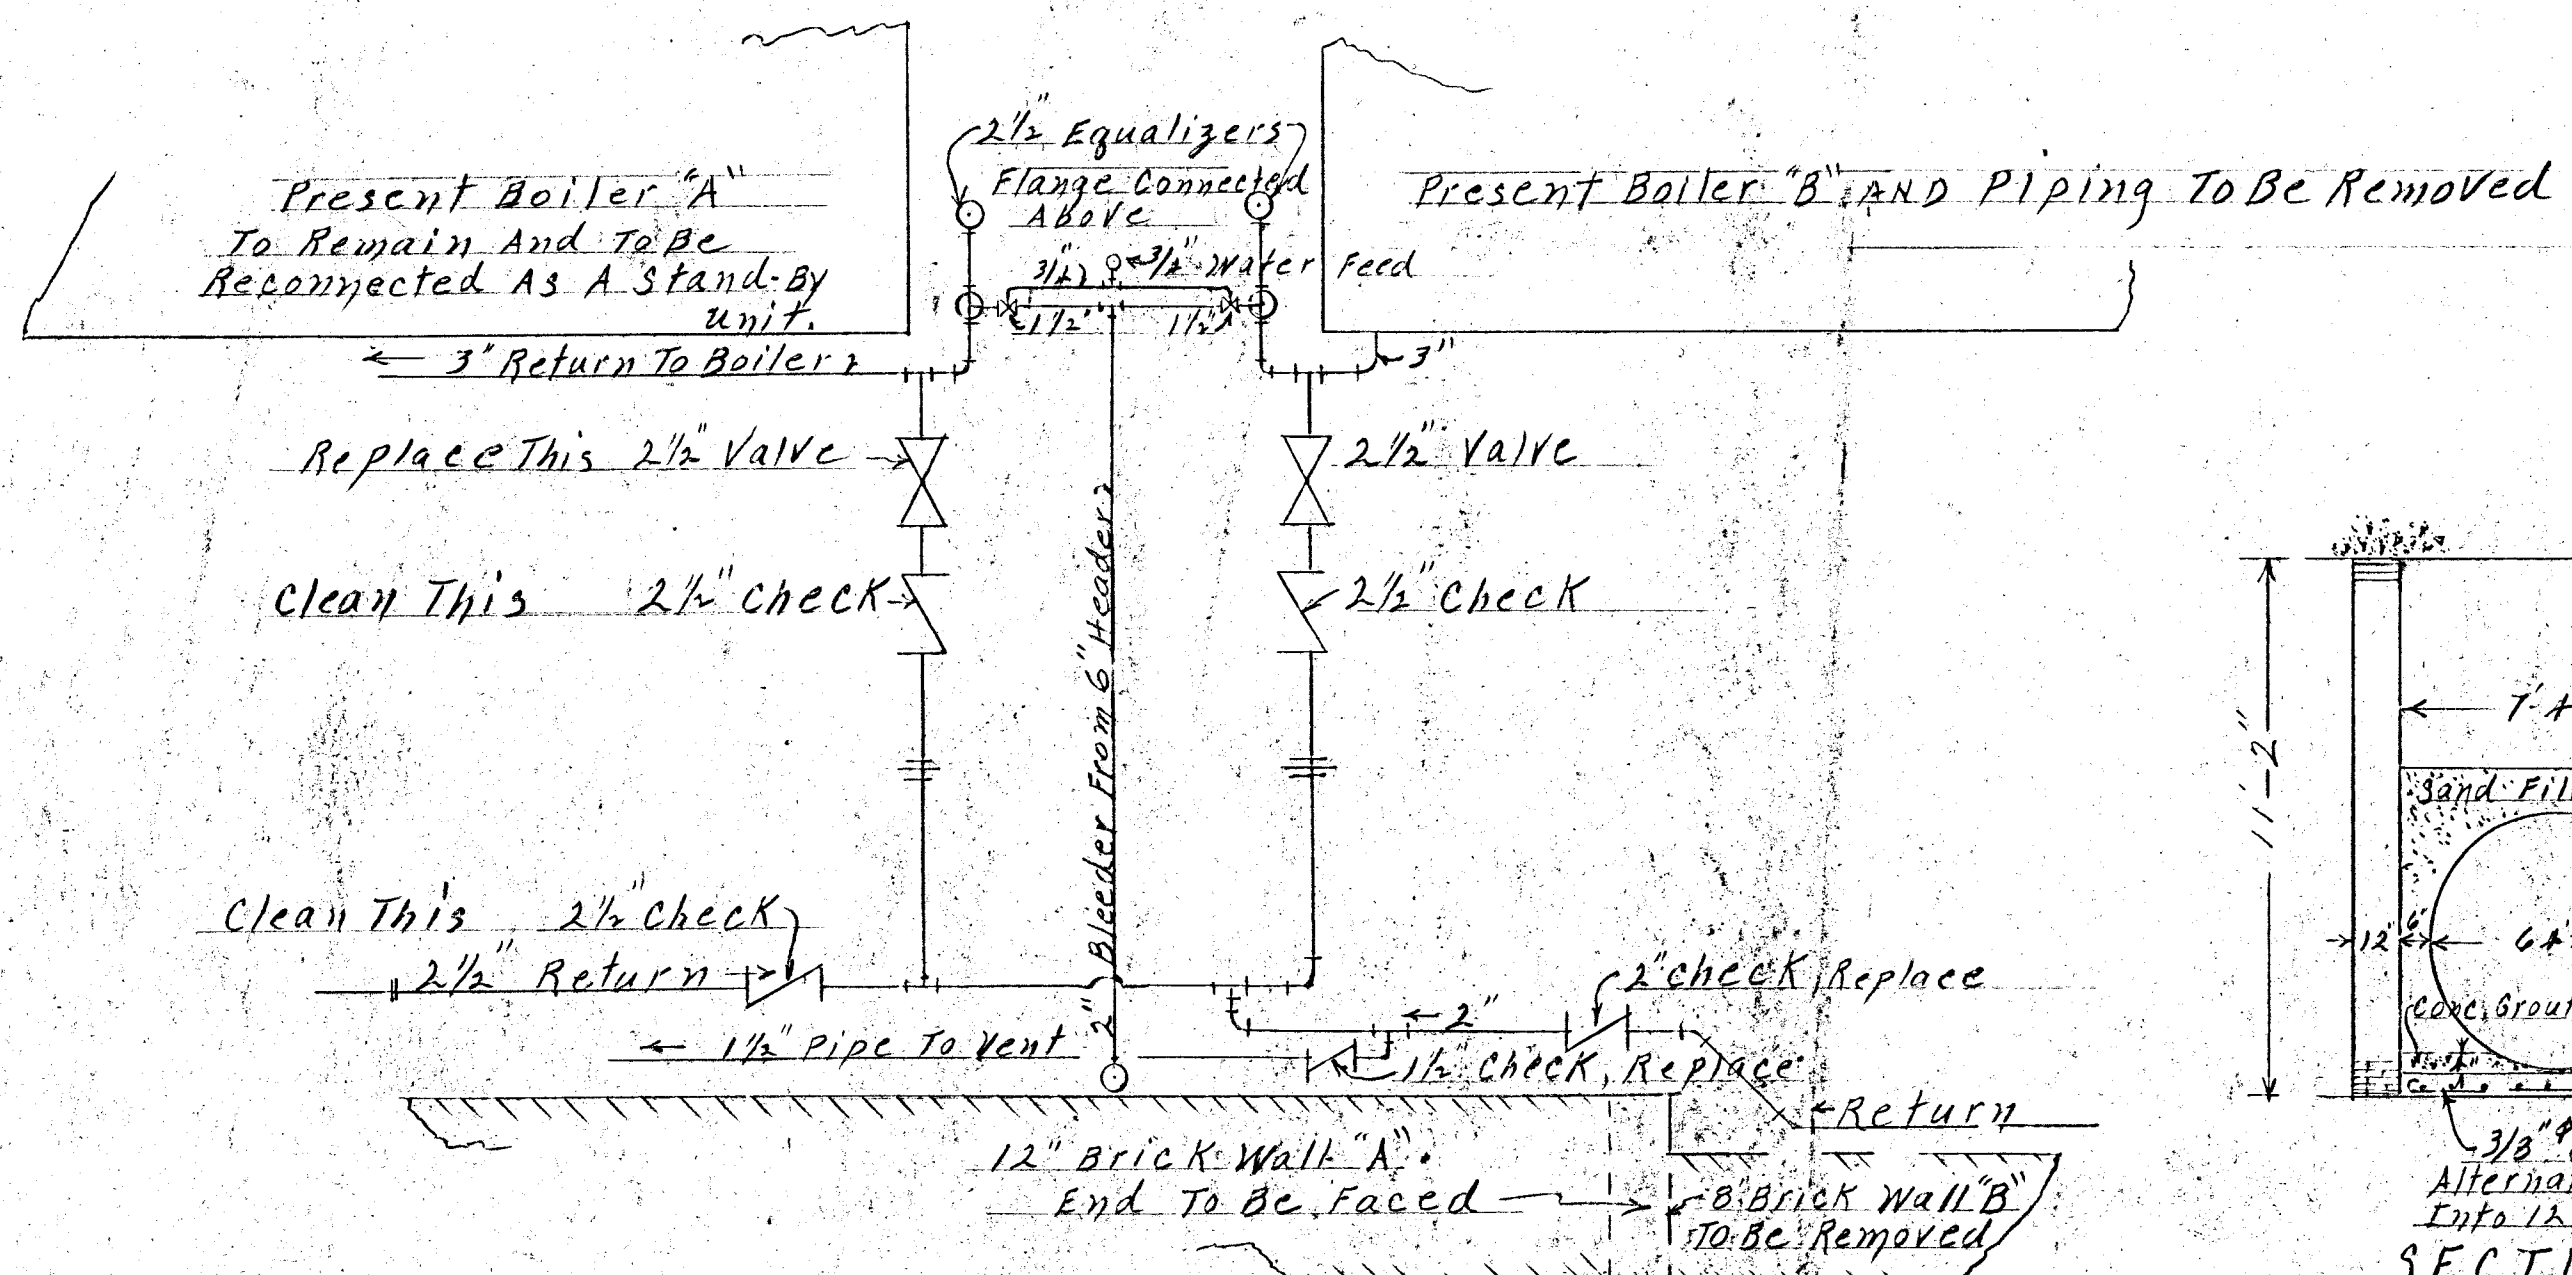
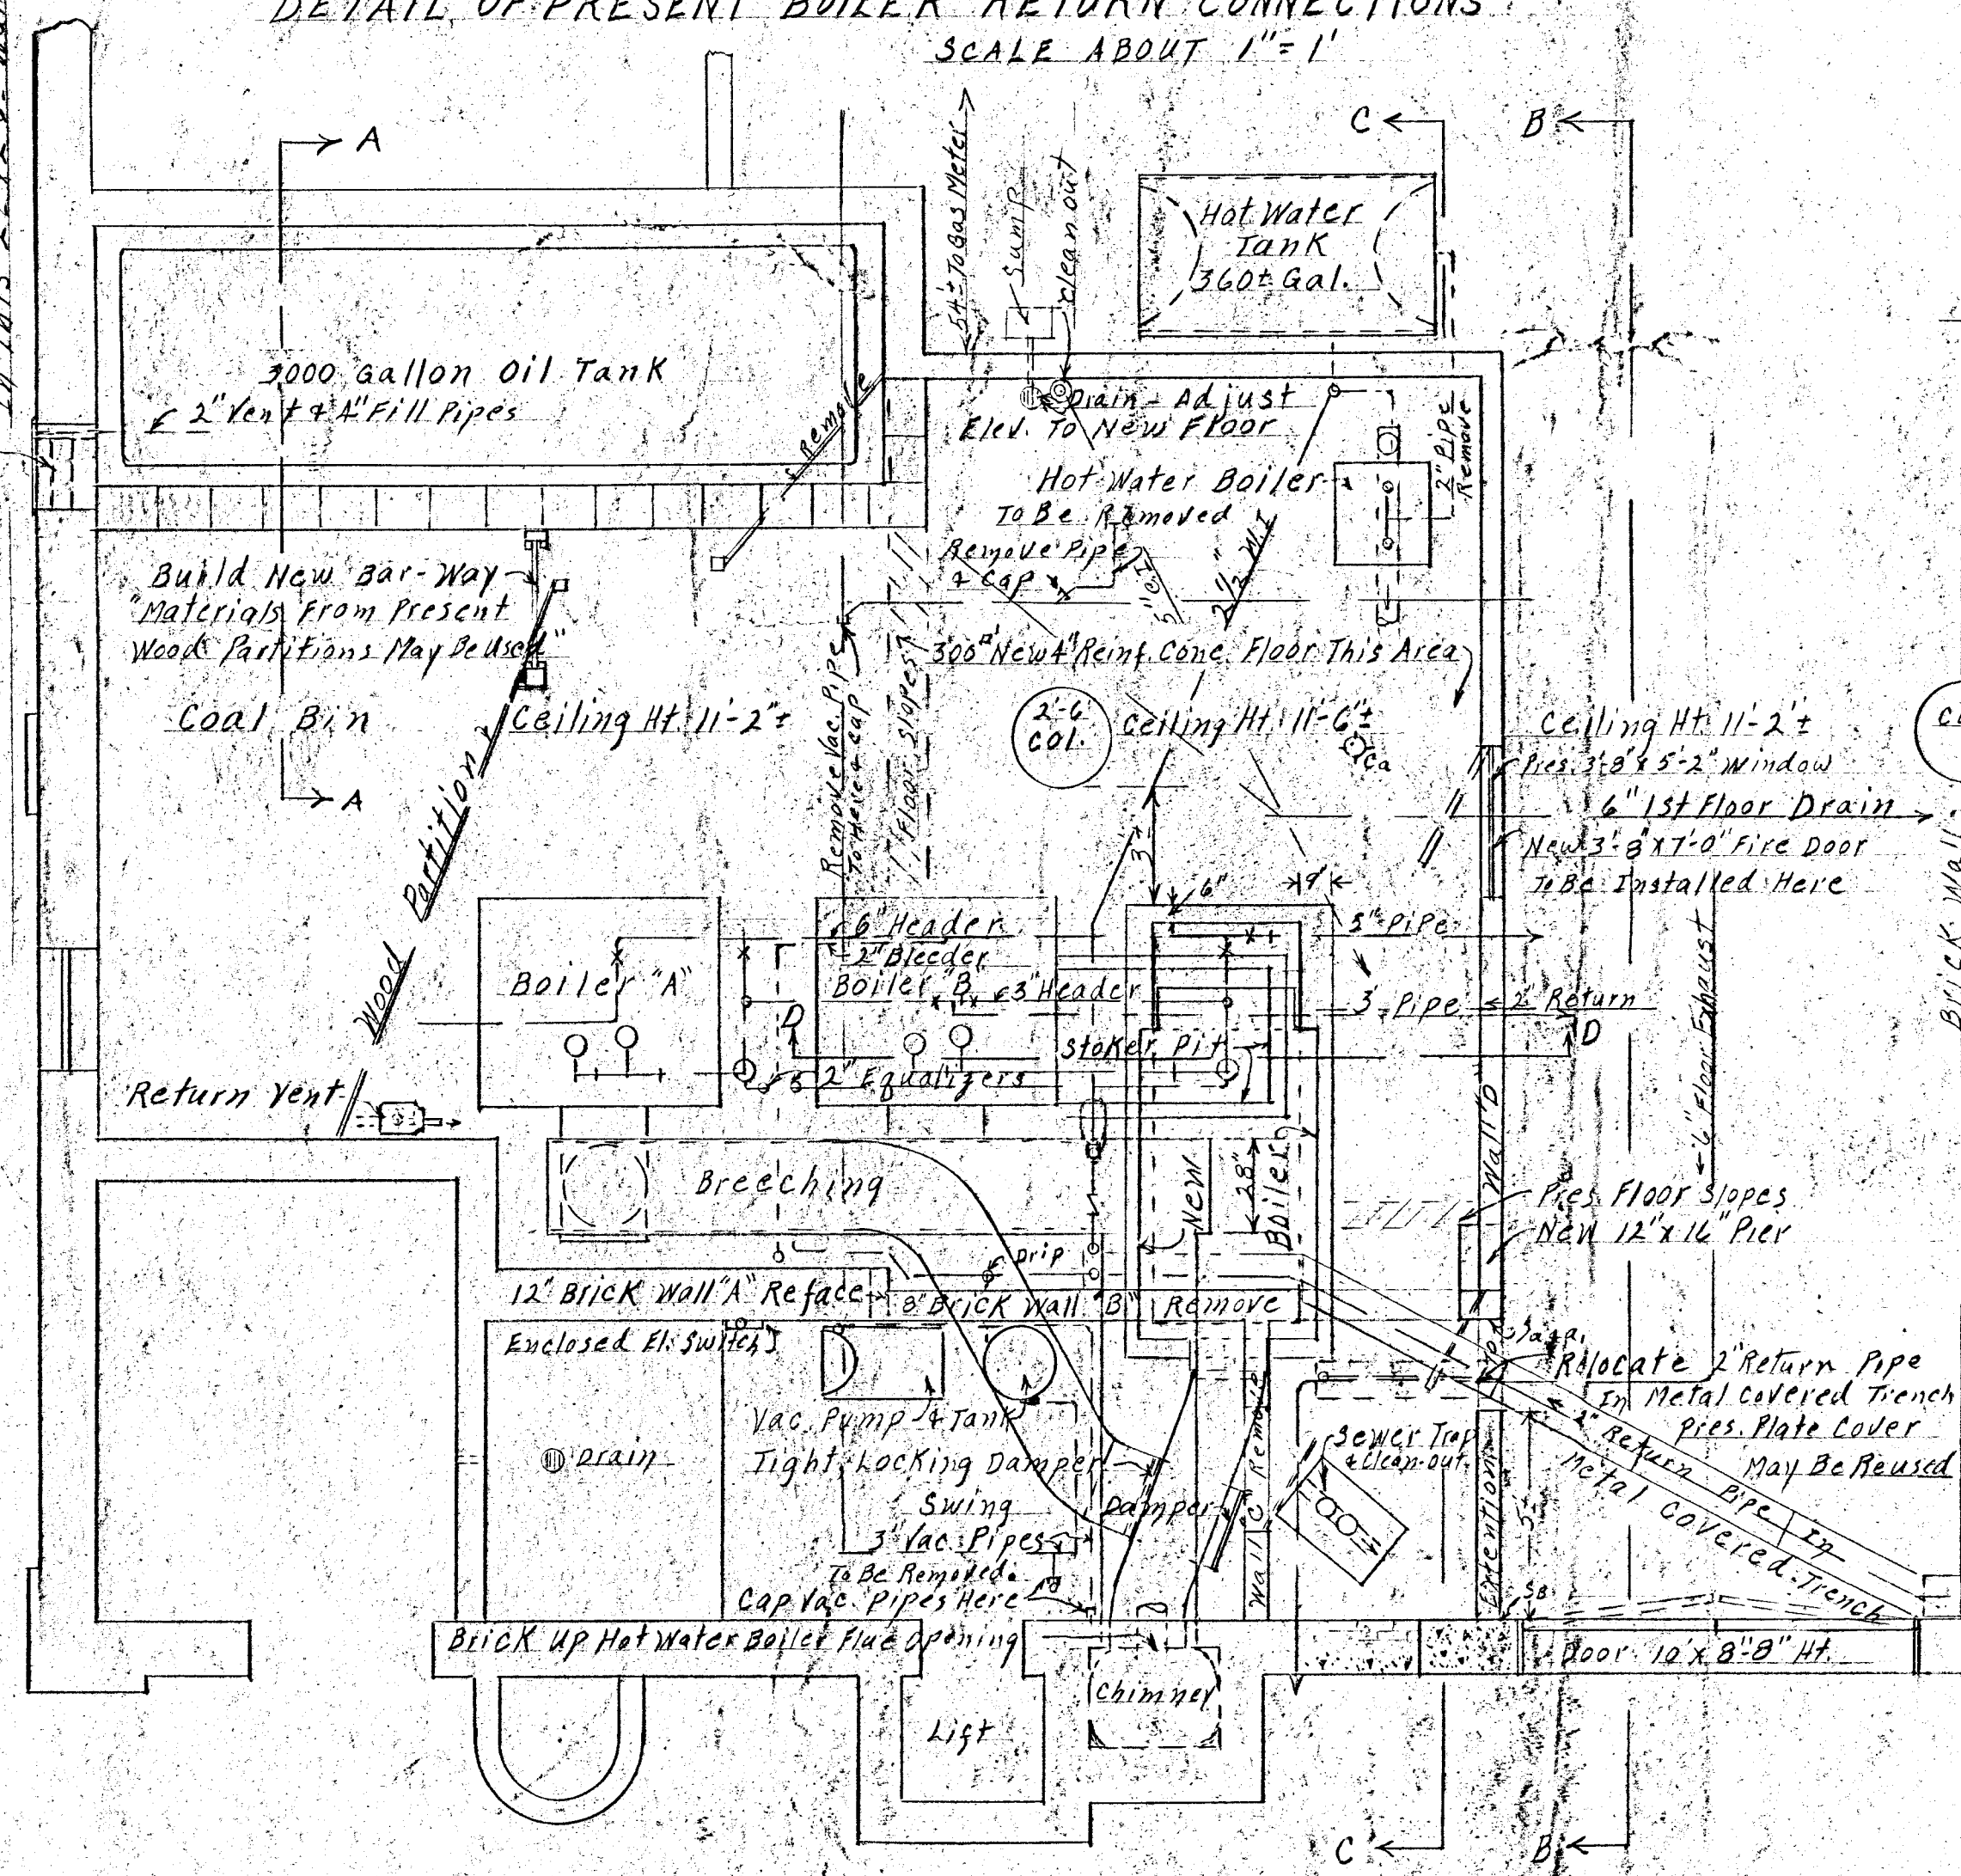
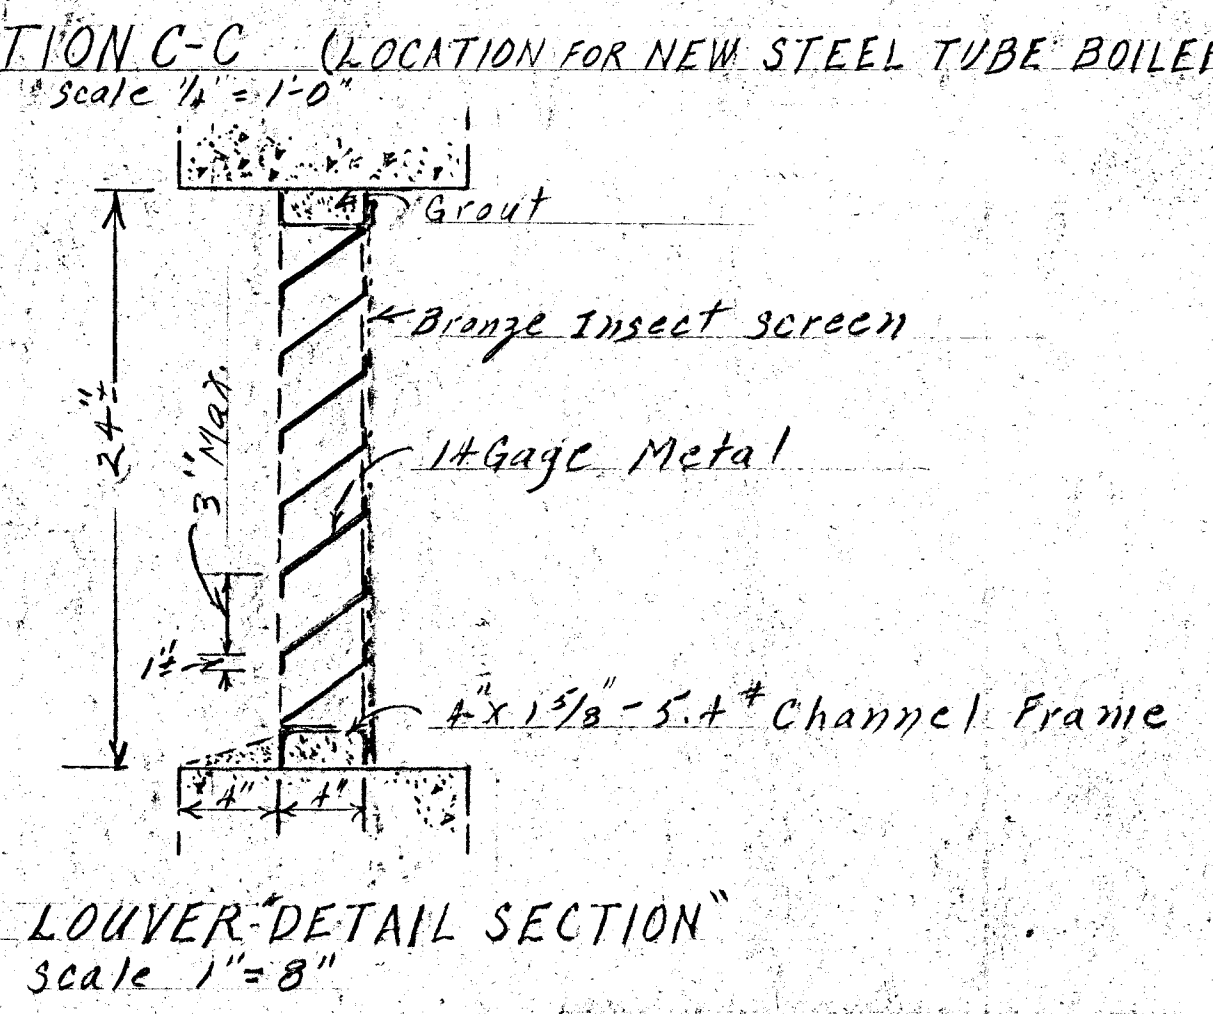
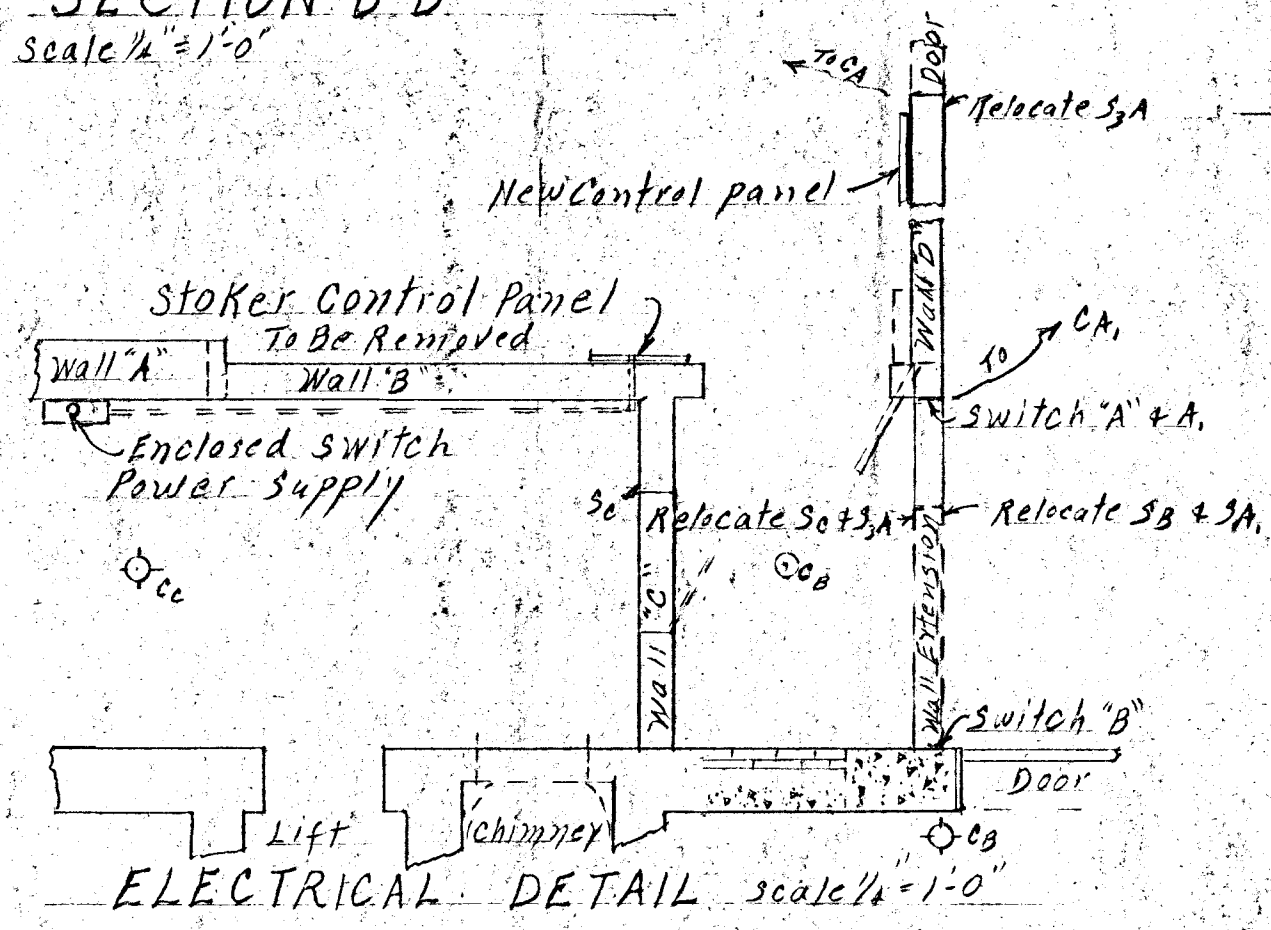


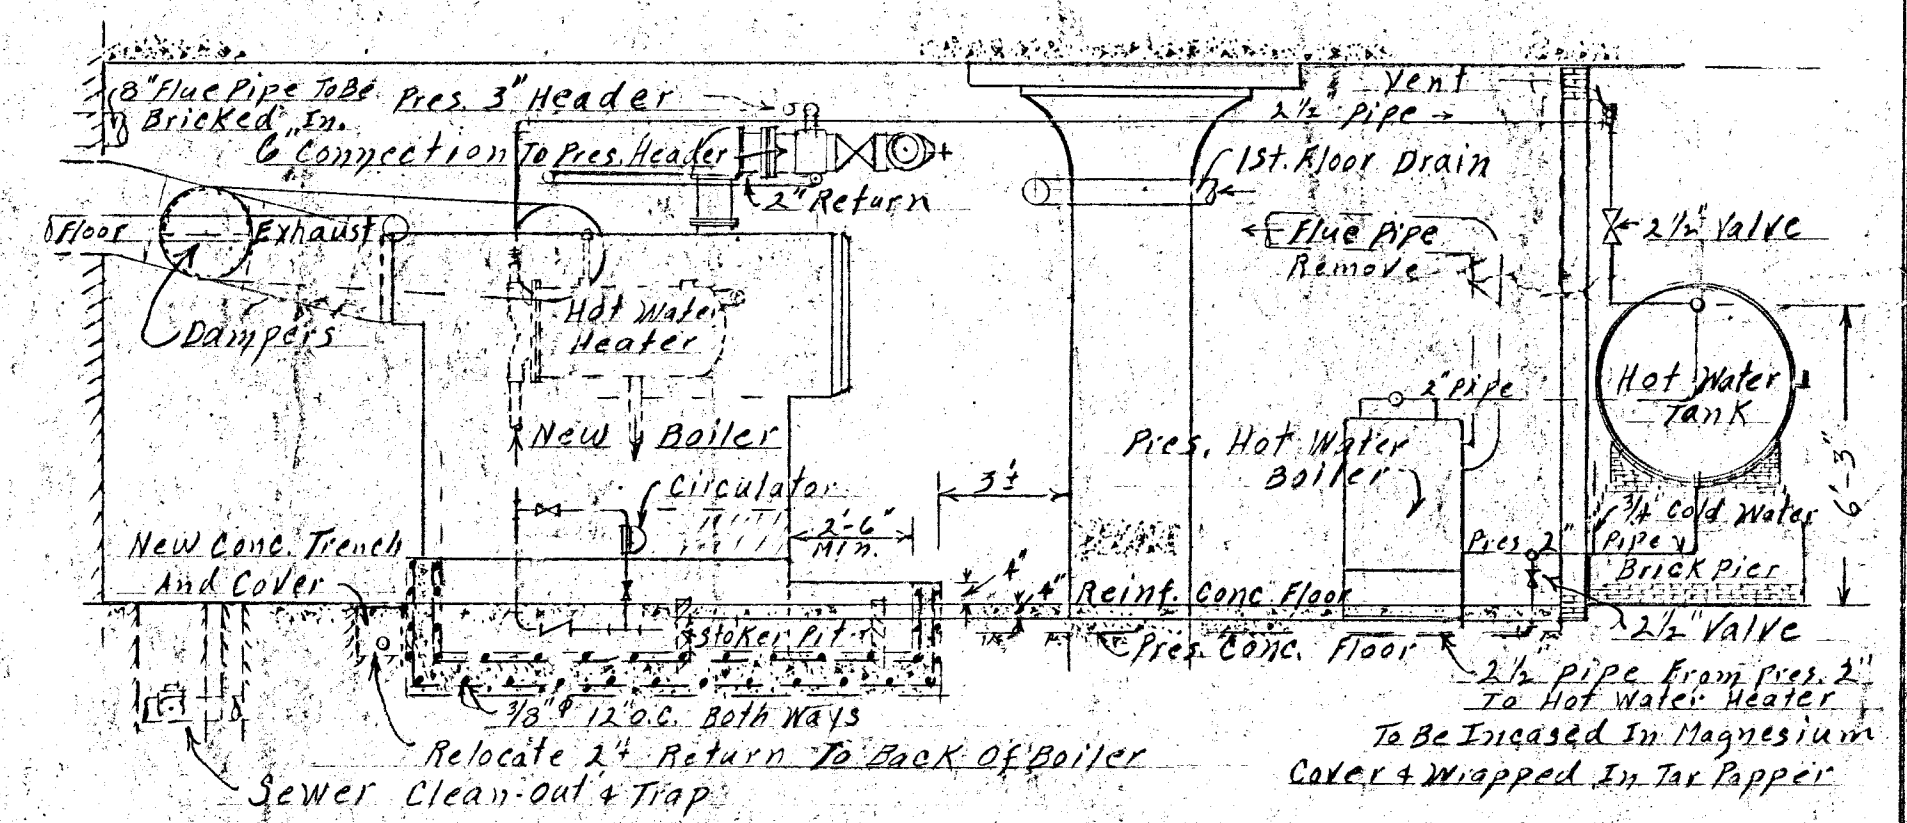

DETAIL OF PRESENT BOILER RETURN CONNECTIONS
SCALE ABOUT 1" = 1'

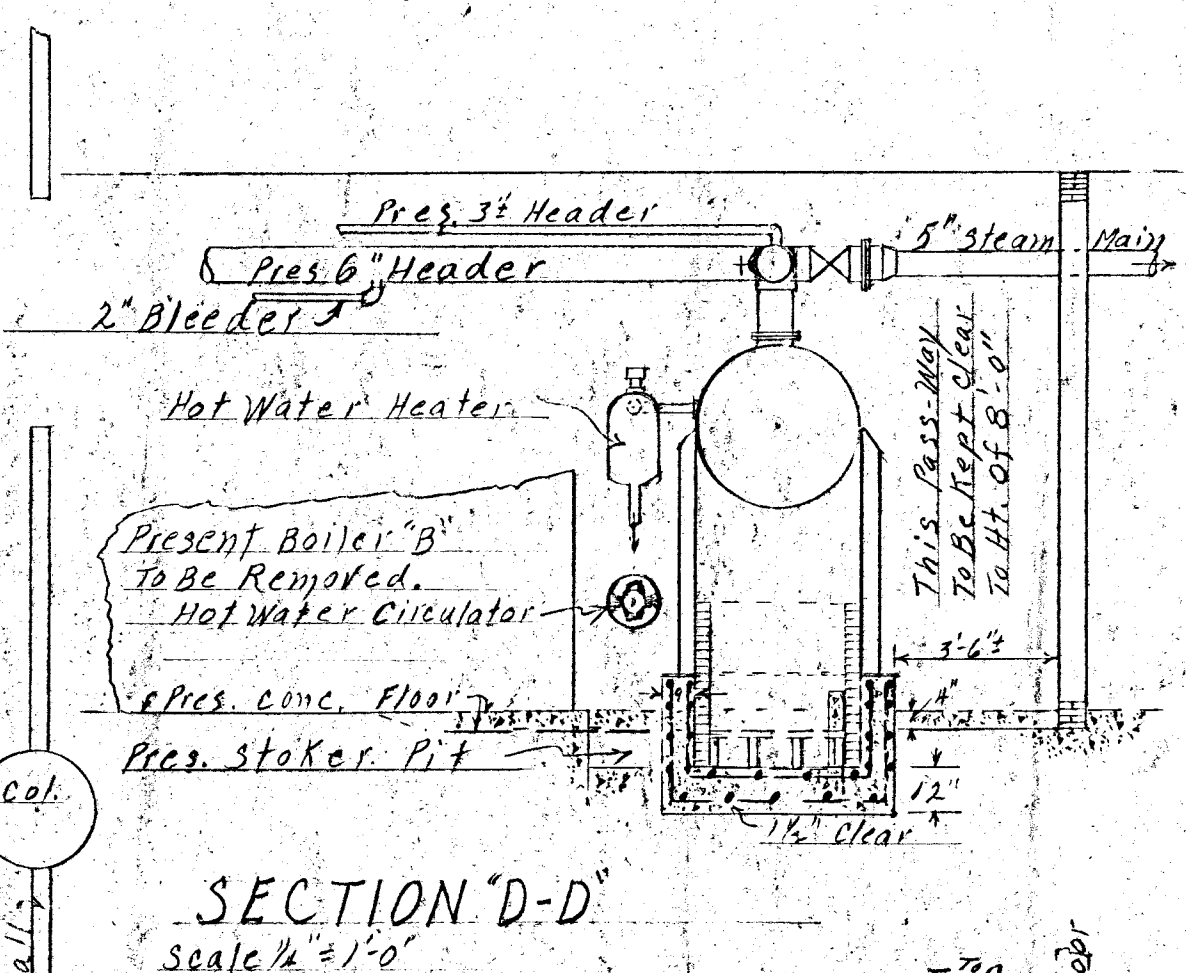

Install Louver And Fuel Oil Tank Piping In This 2'-4" x 2'-6" Wall Opening

DRIVE-WAY TO PEARL STREET

DRIVE-WAY TO ANN STREET



CITY OF HARTFORD, CONN. ENGINEERS

HEATING PLANT FOR
FIRE DEPARTMENT
HEADQUARTERS

275 PEARL STREET HARTFORD, CONN.

Daniel J. Tardella, Engineer, W. Delaney, Architect, W. Hillier, Draftsman

C.D. U.L.B. DAY BOX 07068

D.S.T. Feb., 1950