


SYMBOLS


- ⊗ MOTOR - FURNISHED BY GRILLE CONT'R. INSTALLED & WIRED BY THIS E.C.
- ⊠ MOTOR CONTROLLER - FURNISH BY GRILLE CONT'R. INSTALLED & WIRED BY THIS E.C.
- FUSED DISC. SW. G.E. TYPE "TH" NEMA 3R. FUSE TO BE BUSS FRN 12AMP.
- ⊕PB PUSH BUTTON STATION - FURNISHED BY GRILLE CONT'R. INSTALLED & WIRED BY THIS E.C. UP 4'-6"

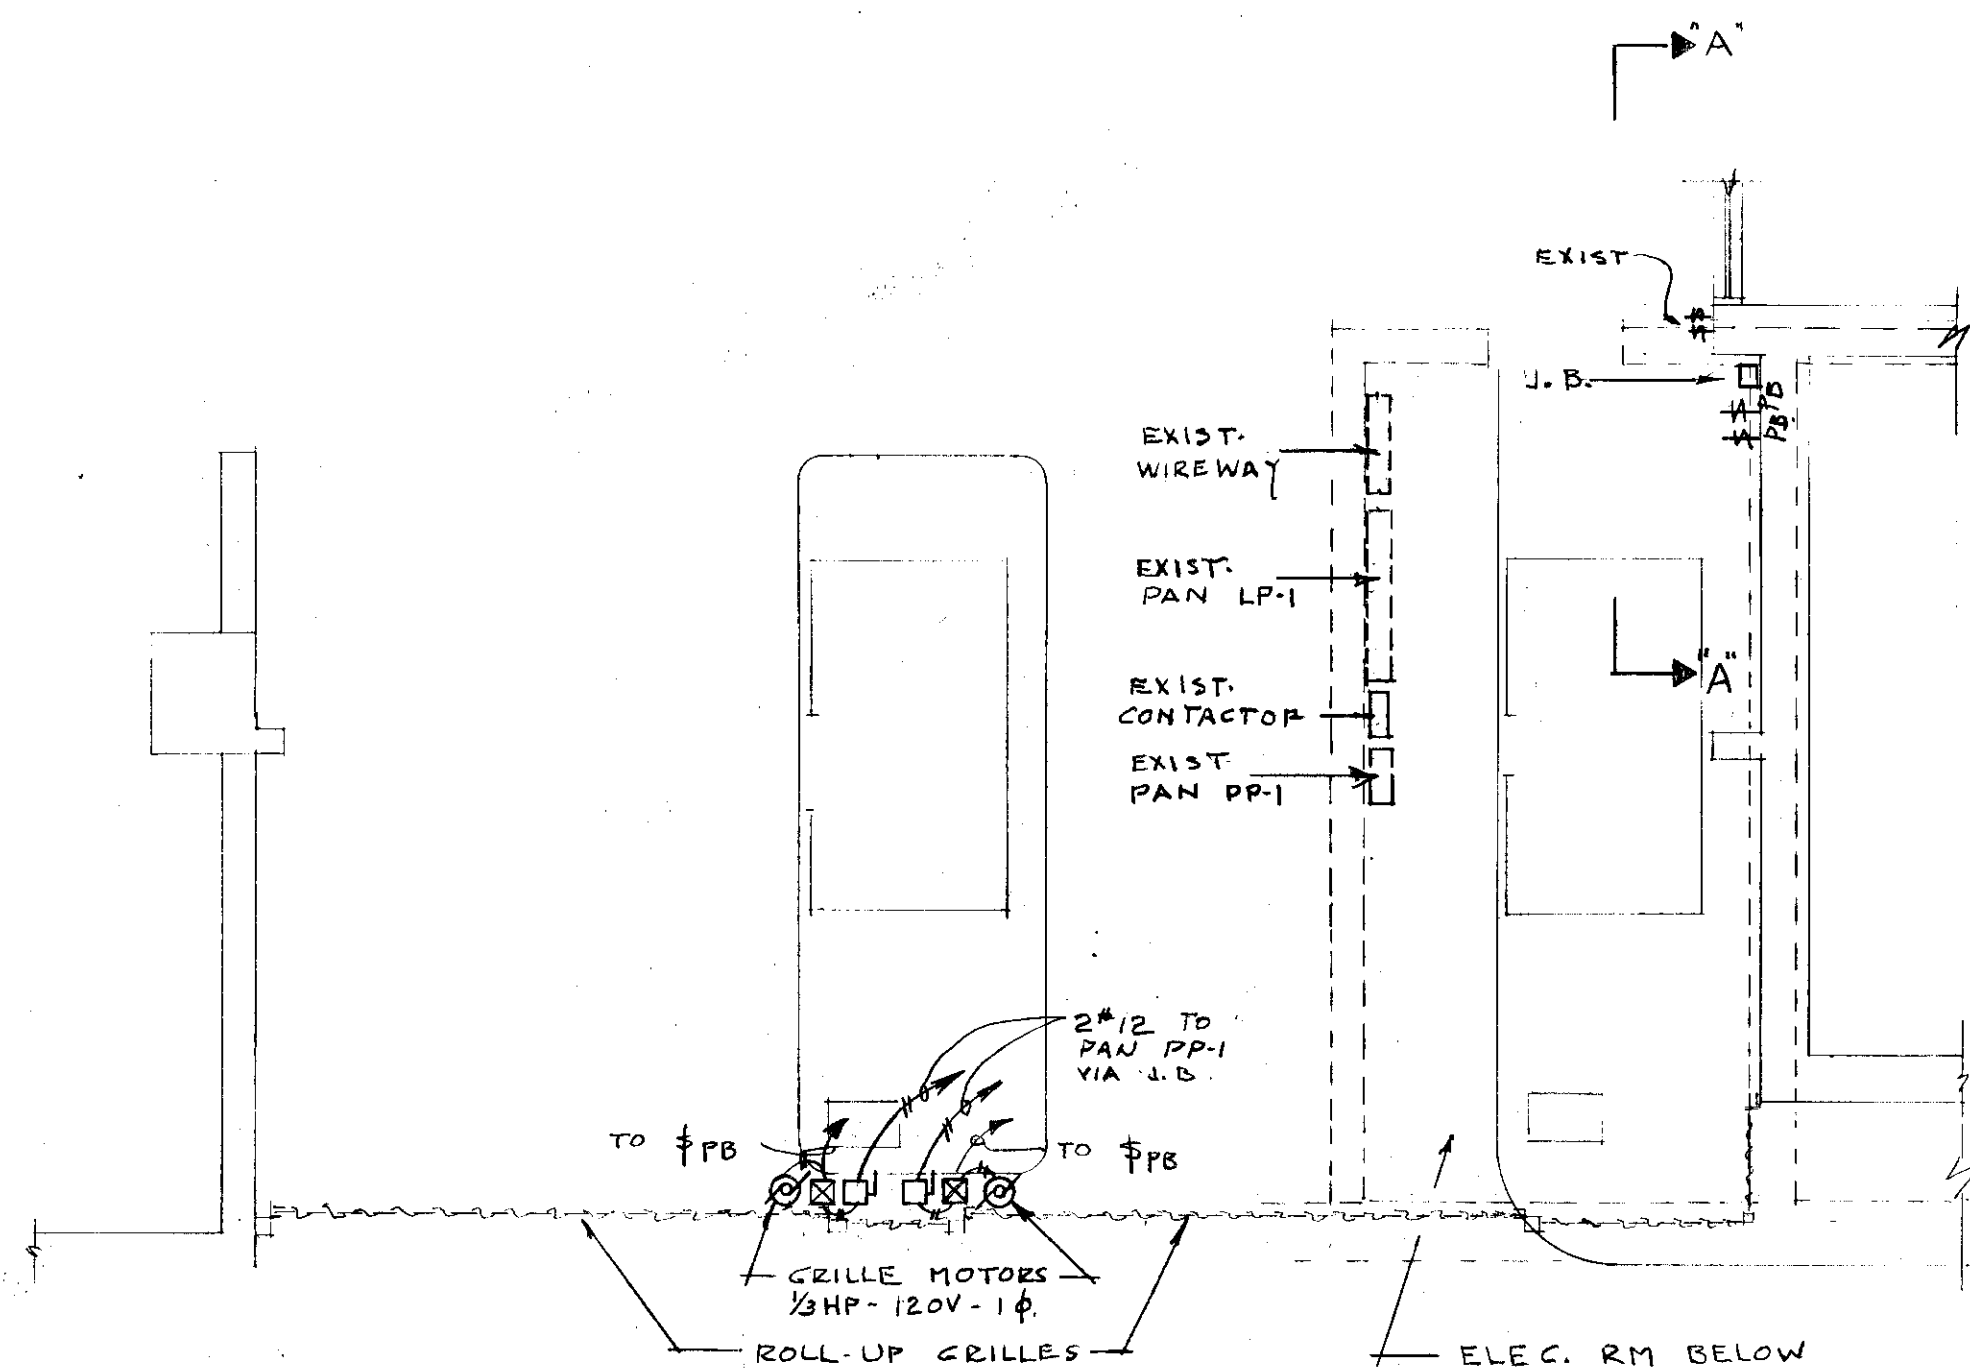

NOTE: DASH LINES INDICATE WALLS, ROOMS & EQUIPMENT LOCATED IN BSM'T.

PARTIAL FIRST FLOOR PLAN

SCALE 1/4" = 1'-0"

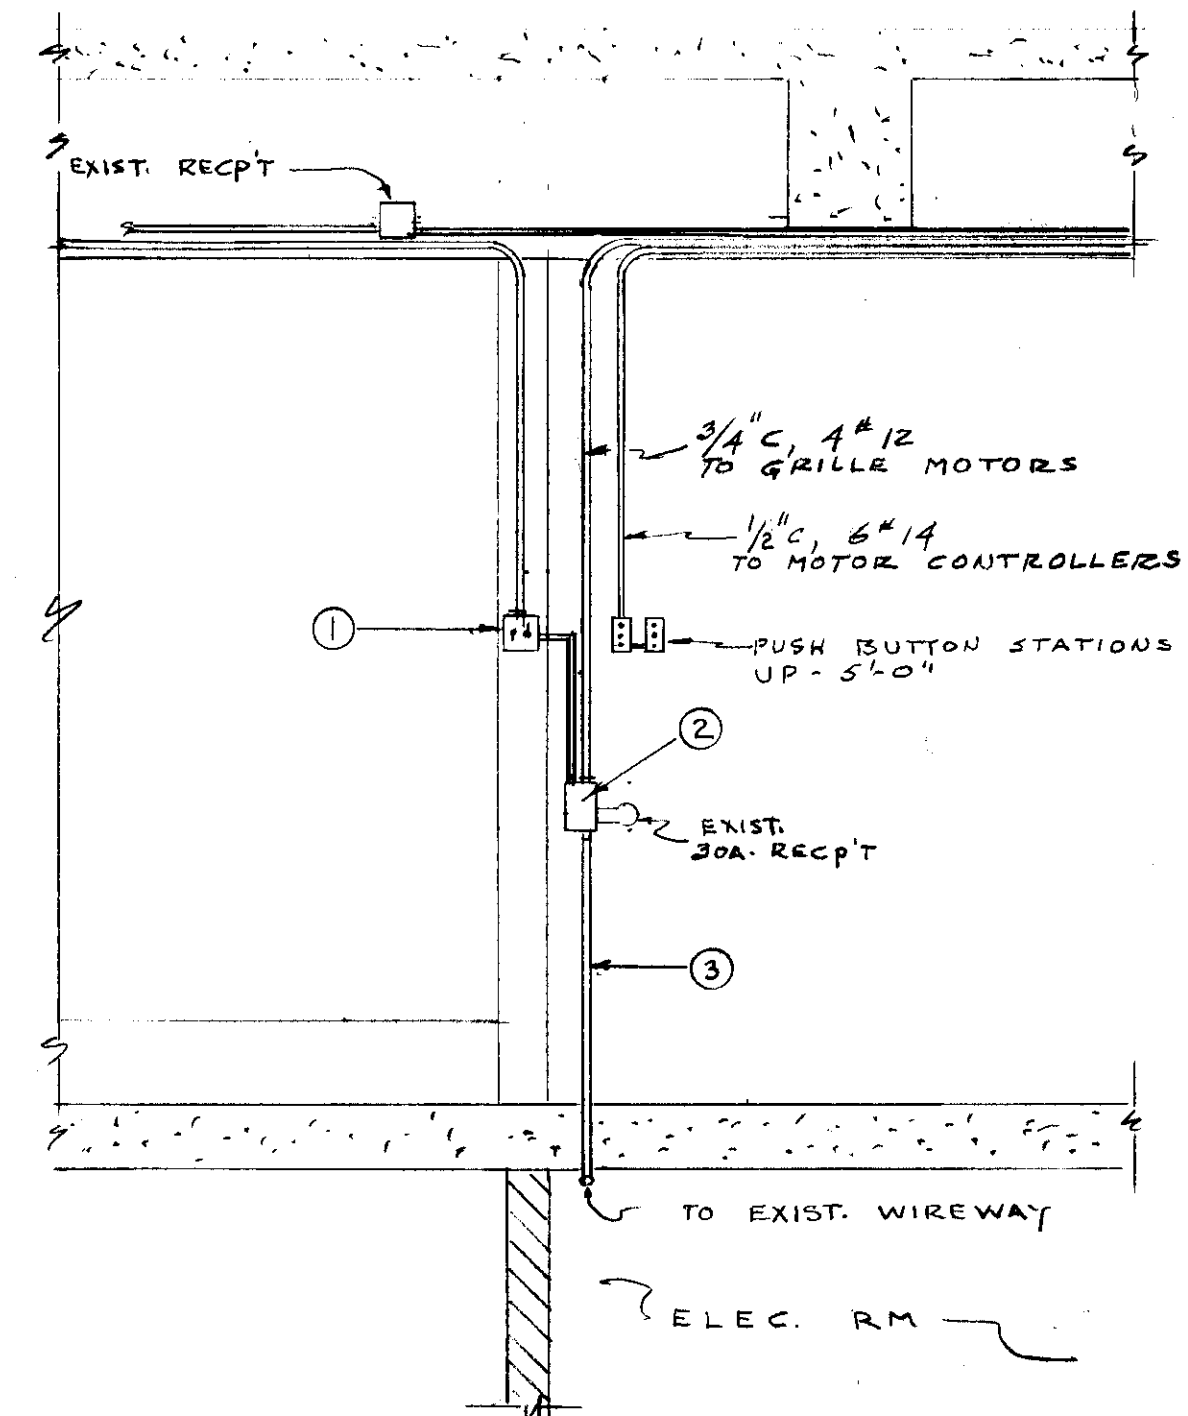

- EXISTING TOGGLE SWITCHES. PROVIDE TEMPORARY POWER FROM RECEPTACLE ABOVE TO INSURE CONTINUOUS SERVICE WHILE REWIRING IS BEING DONE IN ③
- EXISTING CIRCUIT BREAKER BOX. REMOVE CIRCUIT BREAKERS. PROVIDE NEW BLANK COVER. USE AS J.B.
- EXISTING 3/4" CONDUIT WITH 3#10 EXISTING. RUN BRANCH CIRCUIT WIRING 4#12 THWN FOR GRILLE MOTORS IN THIS CONDUIT TO WIREWAY & THEN IN NEW CONDUIT TO PAN PP-1. IF NECESSARY, REMOVE EXISTING CONDUCTORS & REPULL ALONG WITH NEW CONDUCTORS. & THEN RECONNECT.

SECTION A-A

SCALE 1/2" = 1'-0"

ELECTRICAL

CITY OF HARTFORD, CONNECTICUT
DEPARTMENT OF PUBLIC WORKS
BUREAU OF PUBLIC BUILDINGS

NEW ROLLING GRILLES
MUNICIPAL PARKING GARAGE
200 CHURCH STREET
HARTFORD CONNECTICUT.

Robert Cannon *William H. Reed* *George C. Hopper*

VERIFY EXISTING CONDITIONS
AND DIMENSIONS AT BUILDING

R.G.B.

DAYBOOK NO. 010617-B

DATE AUG. 24, 1977

E-1