



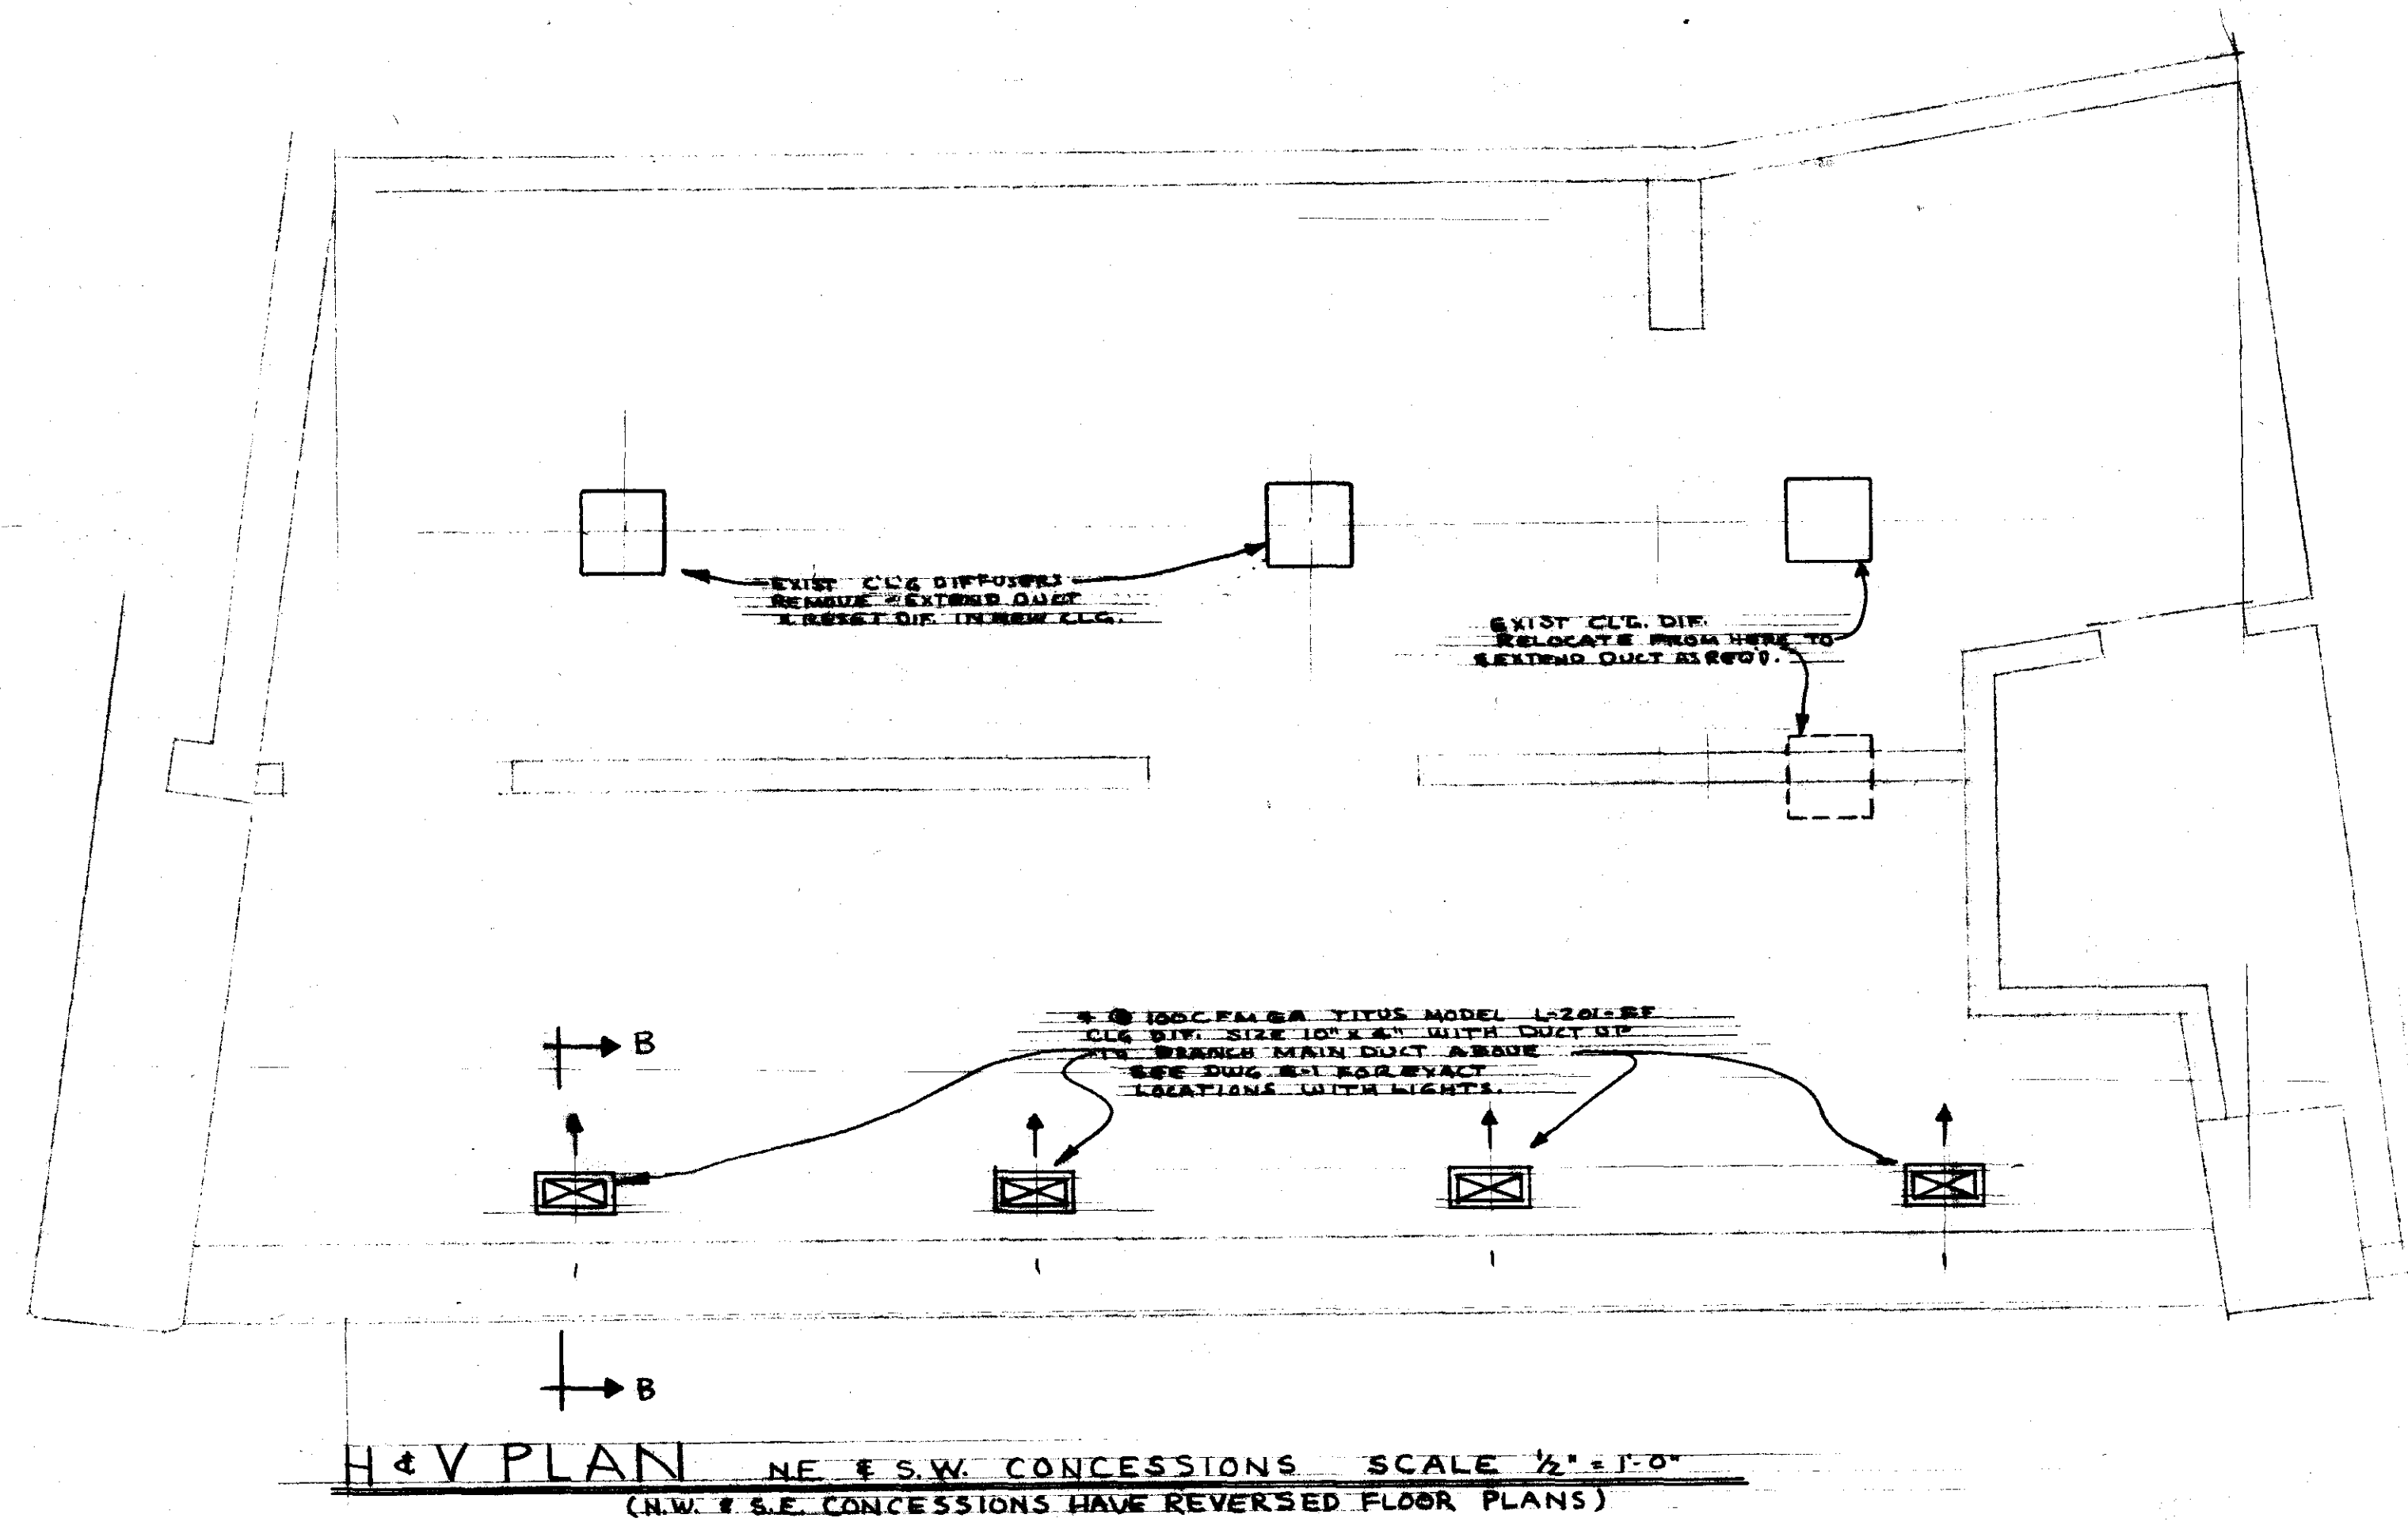

H & V PLAN NE & S.W. CONCESSIONS SCALE 1/2" = 1'-0"
(N.W. & S.E. CONCESSIONS HAVE REVERSED FLOOR PLANS)


PLUMBING NOTES -

- 1 EXISTING FLOOR DRAIN TO REMAIN - RESET COVER TO NEW FLOOR COVERING ELEV.
- 2 NEW FLOOR DRAIN TURN 90° CW 2"Ø 200-28 4" PIPE SIZE - PIPE IN C.I. WITH
TEAT & NEW FLOOR TO NEAREST EXISTING SAN. LINE.
- 3 NEW 1/2"Ø DRAIN FROM NEW LAV. CONNECT TO EXISTING LINK DRAIN PIPING.
- 4 EXIST 1/2"Ø COLD WATER TO REMAIN.
- 5 EXIST 1/2"Ø COLD WATER - REMOVE ALL EXISTING COLD PIPING UNDER EXISTING
COUNTY BACK TO 1"Ø DRAIN NEAR SINK. BRASS & RESET BRIT. 1"Ø VALVE HORIZONTAL
NEW COVER & ABOVE FLOOR - INSTALL NEW PIPING UNDER SINK UNDER COUNTER AS
SHOWN ON PLANS.
- 6 NEW 1/2"Ø HOT WATER - EXISTING 1/2"Ø AT EXISTING SINK TO NEW LAV.
- 7 NEW LAVATORY - AM. STD. "BRUSALYN" #669-RIZ. SIZE 19"x17" WITH
7000-1"Ø VALVE & FLARE & 6618-RIZ. Ø 3/4"Ø 1/2"Ø SUPPLY & DRAIN
220-112 - 2"Ø DRAIN MODEL #220-112 P. 112.
- 8 NEW P-TRAP SINK UNIT - 18" BRASS Ø 2-1/2" - PROBABLY 18" Ø WALL BRACKET
WITH 18" Ø VERTICAL CHASE - 1/2"Ø - CONNECT WITH 1/2" Ø VC TO EXISTING
HIC PIPING AT EXISTING SINK.

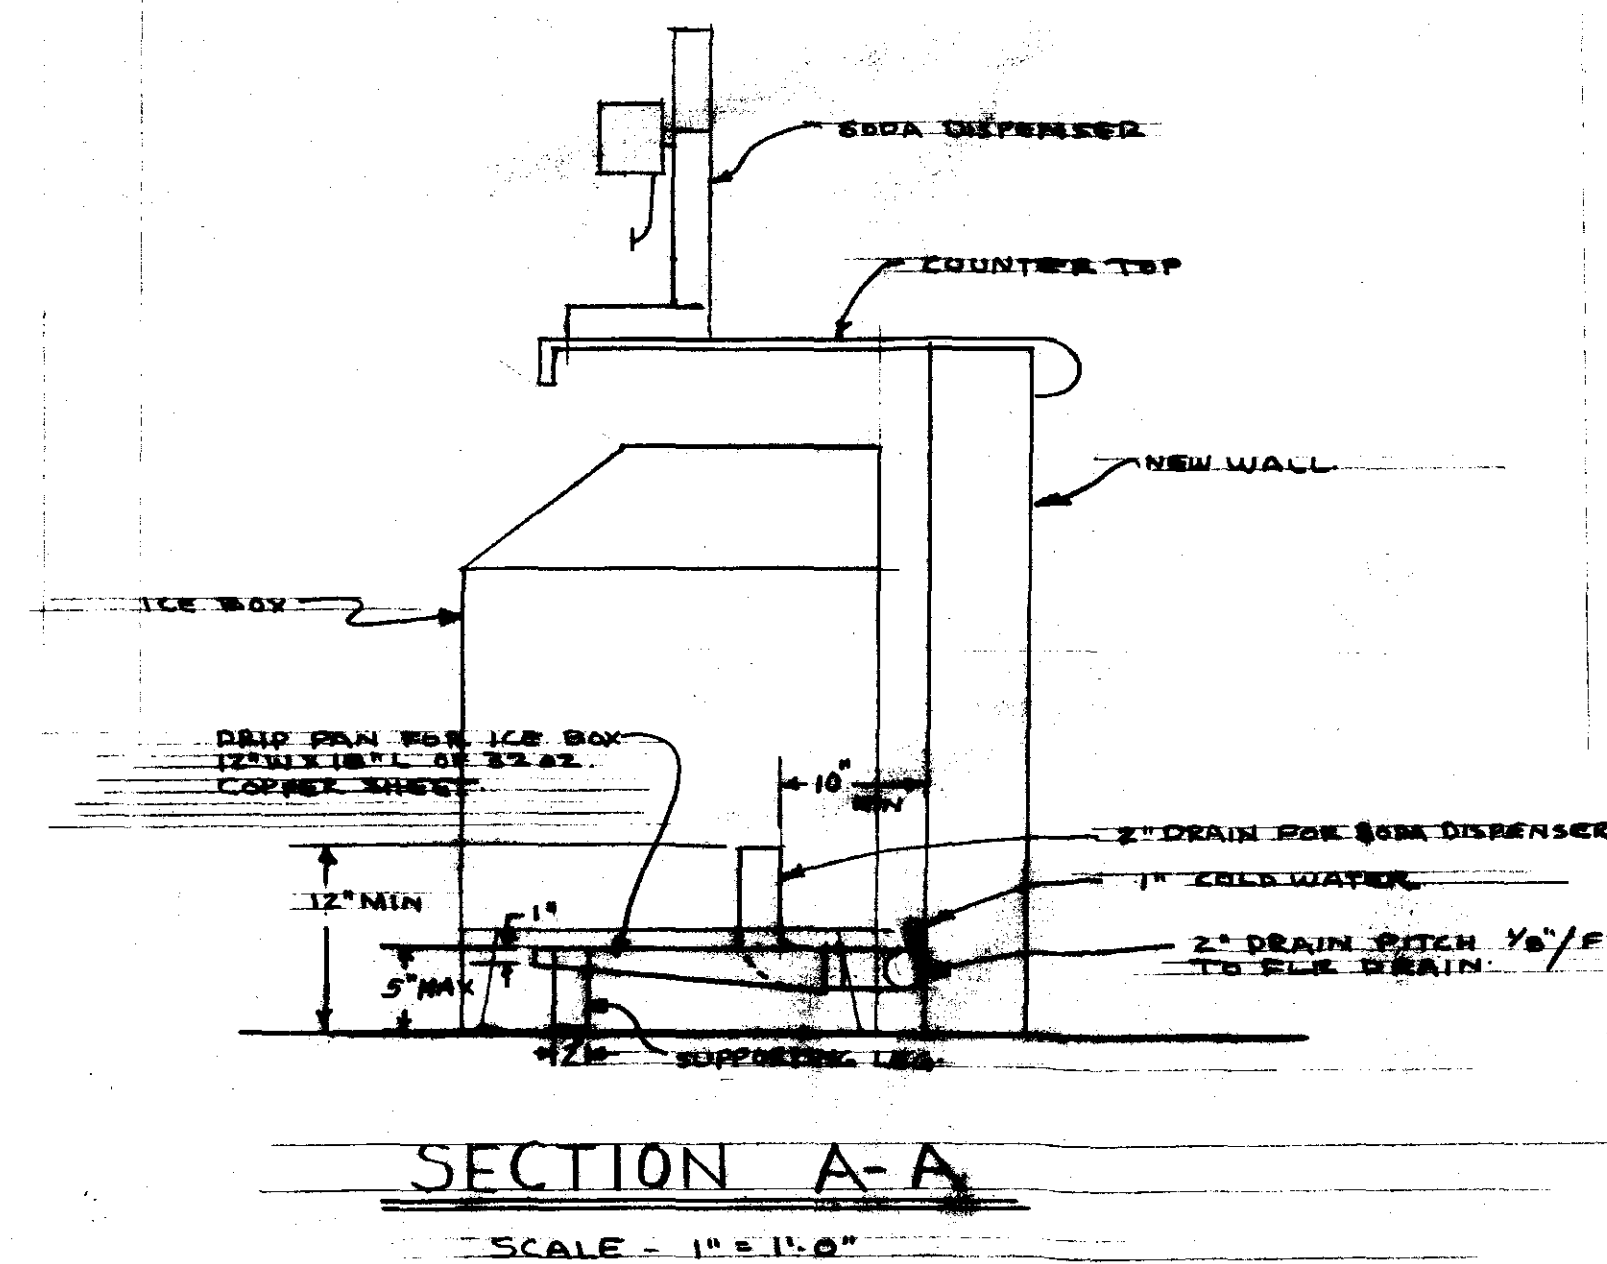

SECTION A-A

SCALE - 1" = 1'-0"

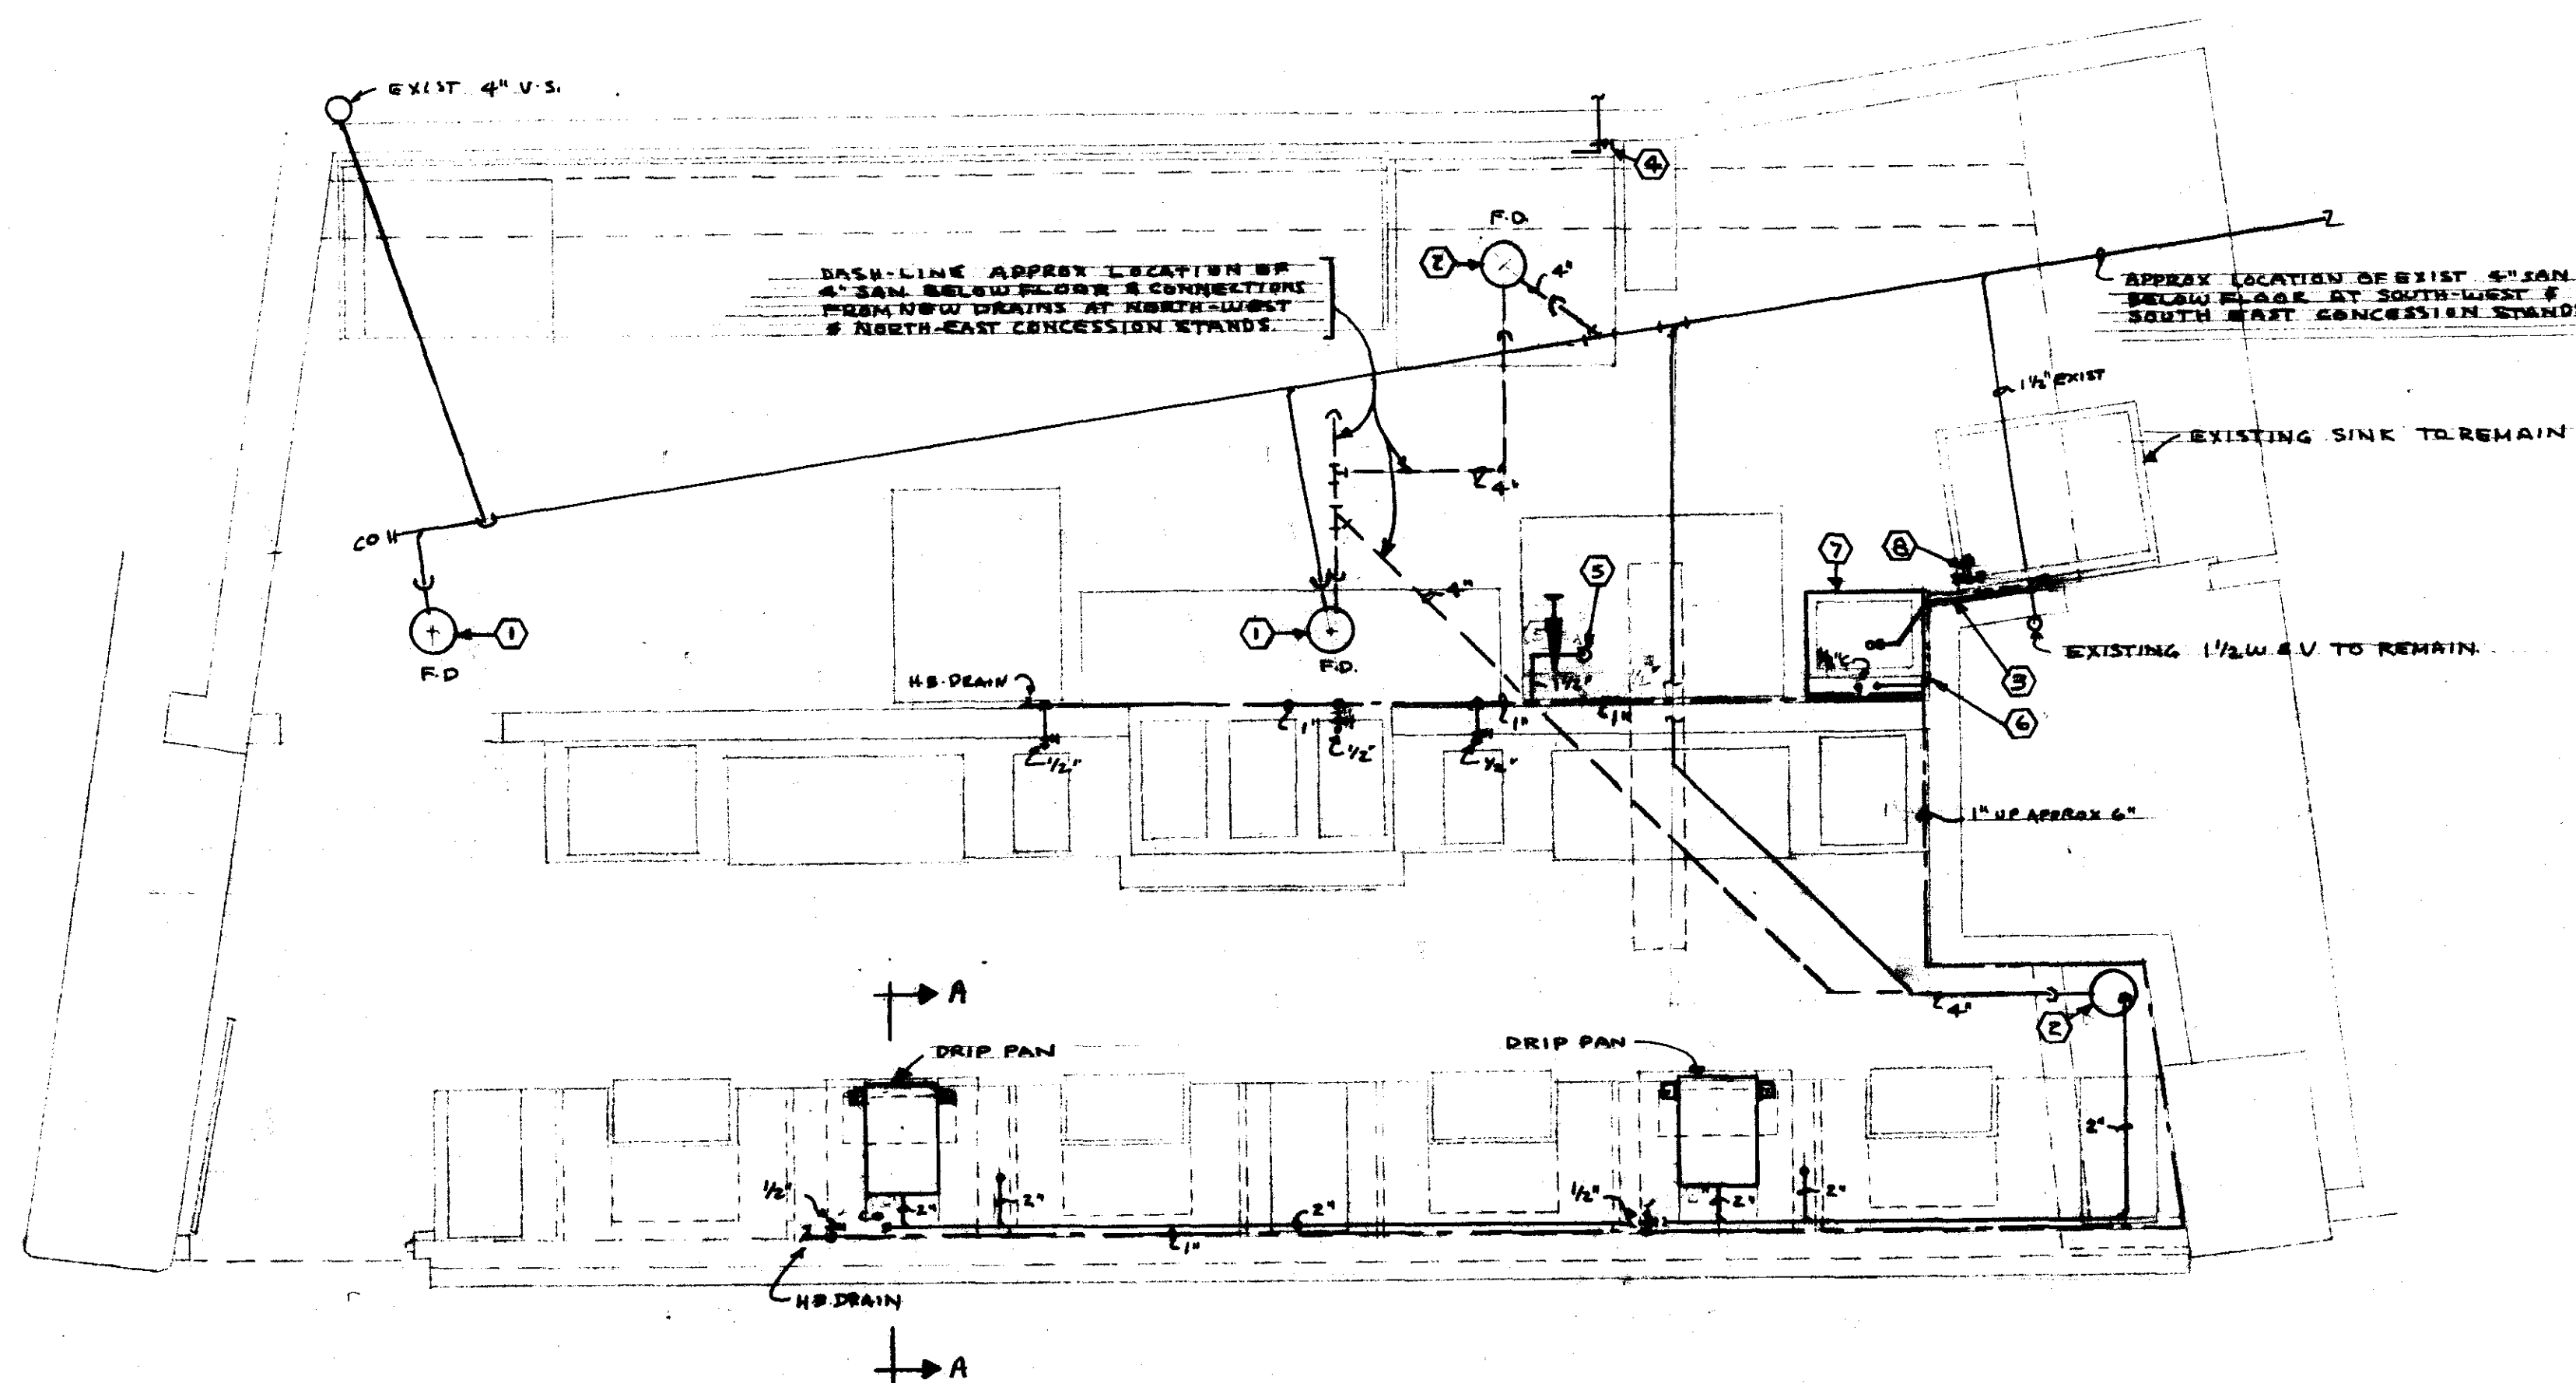

PLUMBING PLAN RE & S.W. CONCESSIONS SCALE 1/2" = 1'-0"
(N.W. & S.E. CONCESSIONS HAVE REVERSED FLOOR PLANS)

**VERIFY EXISTING
CONDITIONS AND
DIMENSIONS**

NUMBER	DESCRIPTION	BY	DATE
REVISIONS			
CITY OF HARTFORD, CONNECTICUT DEPARTMENT OF PUBLIC WORKS BUREAU OF PUBLIC BUILDINGS			
RENOVATION OF FOUR CONCESSION STANDS AT LEVEL 6.10 CIVIC CENTER, HARTFORD, CT.			
SUBMITTER <i>W. J. ...</i>	RECOMMENDED <i>W. J. ...</i> DESIGN ARCHITECT	APPROVED <i>W. J. ...</i> ASSISTANT CITY ENGINEER	
DRAWN F.P.P.	SCALE AS NOTED	DATEBOOK NO. 110618- DATE AUG. 3, 1977	M-1
CHECKED F.P.P.			