


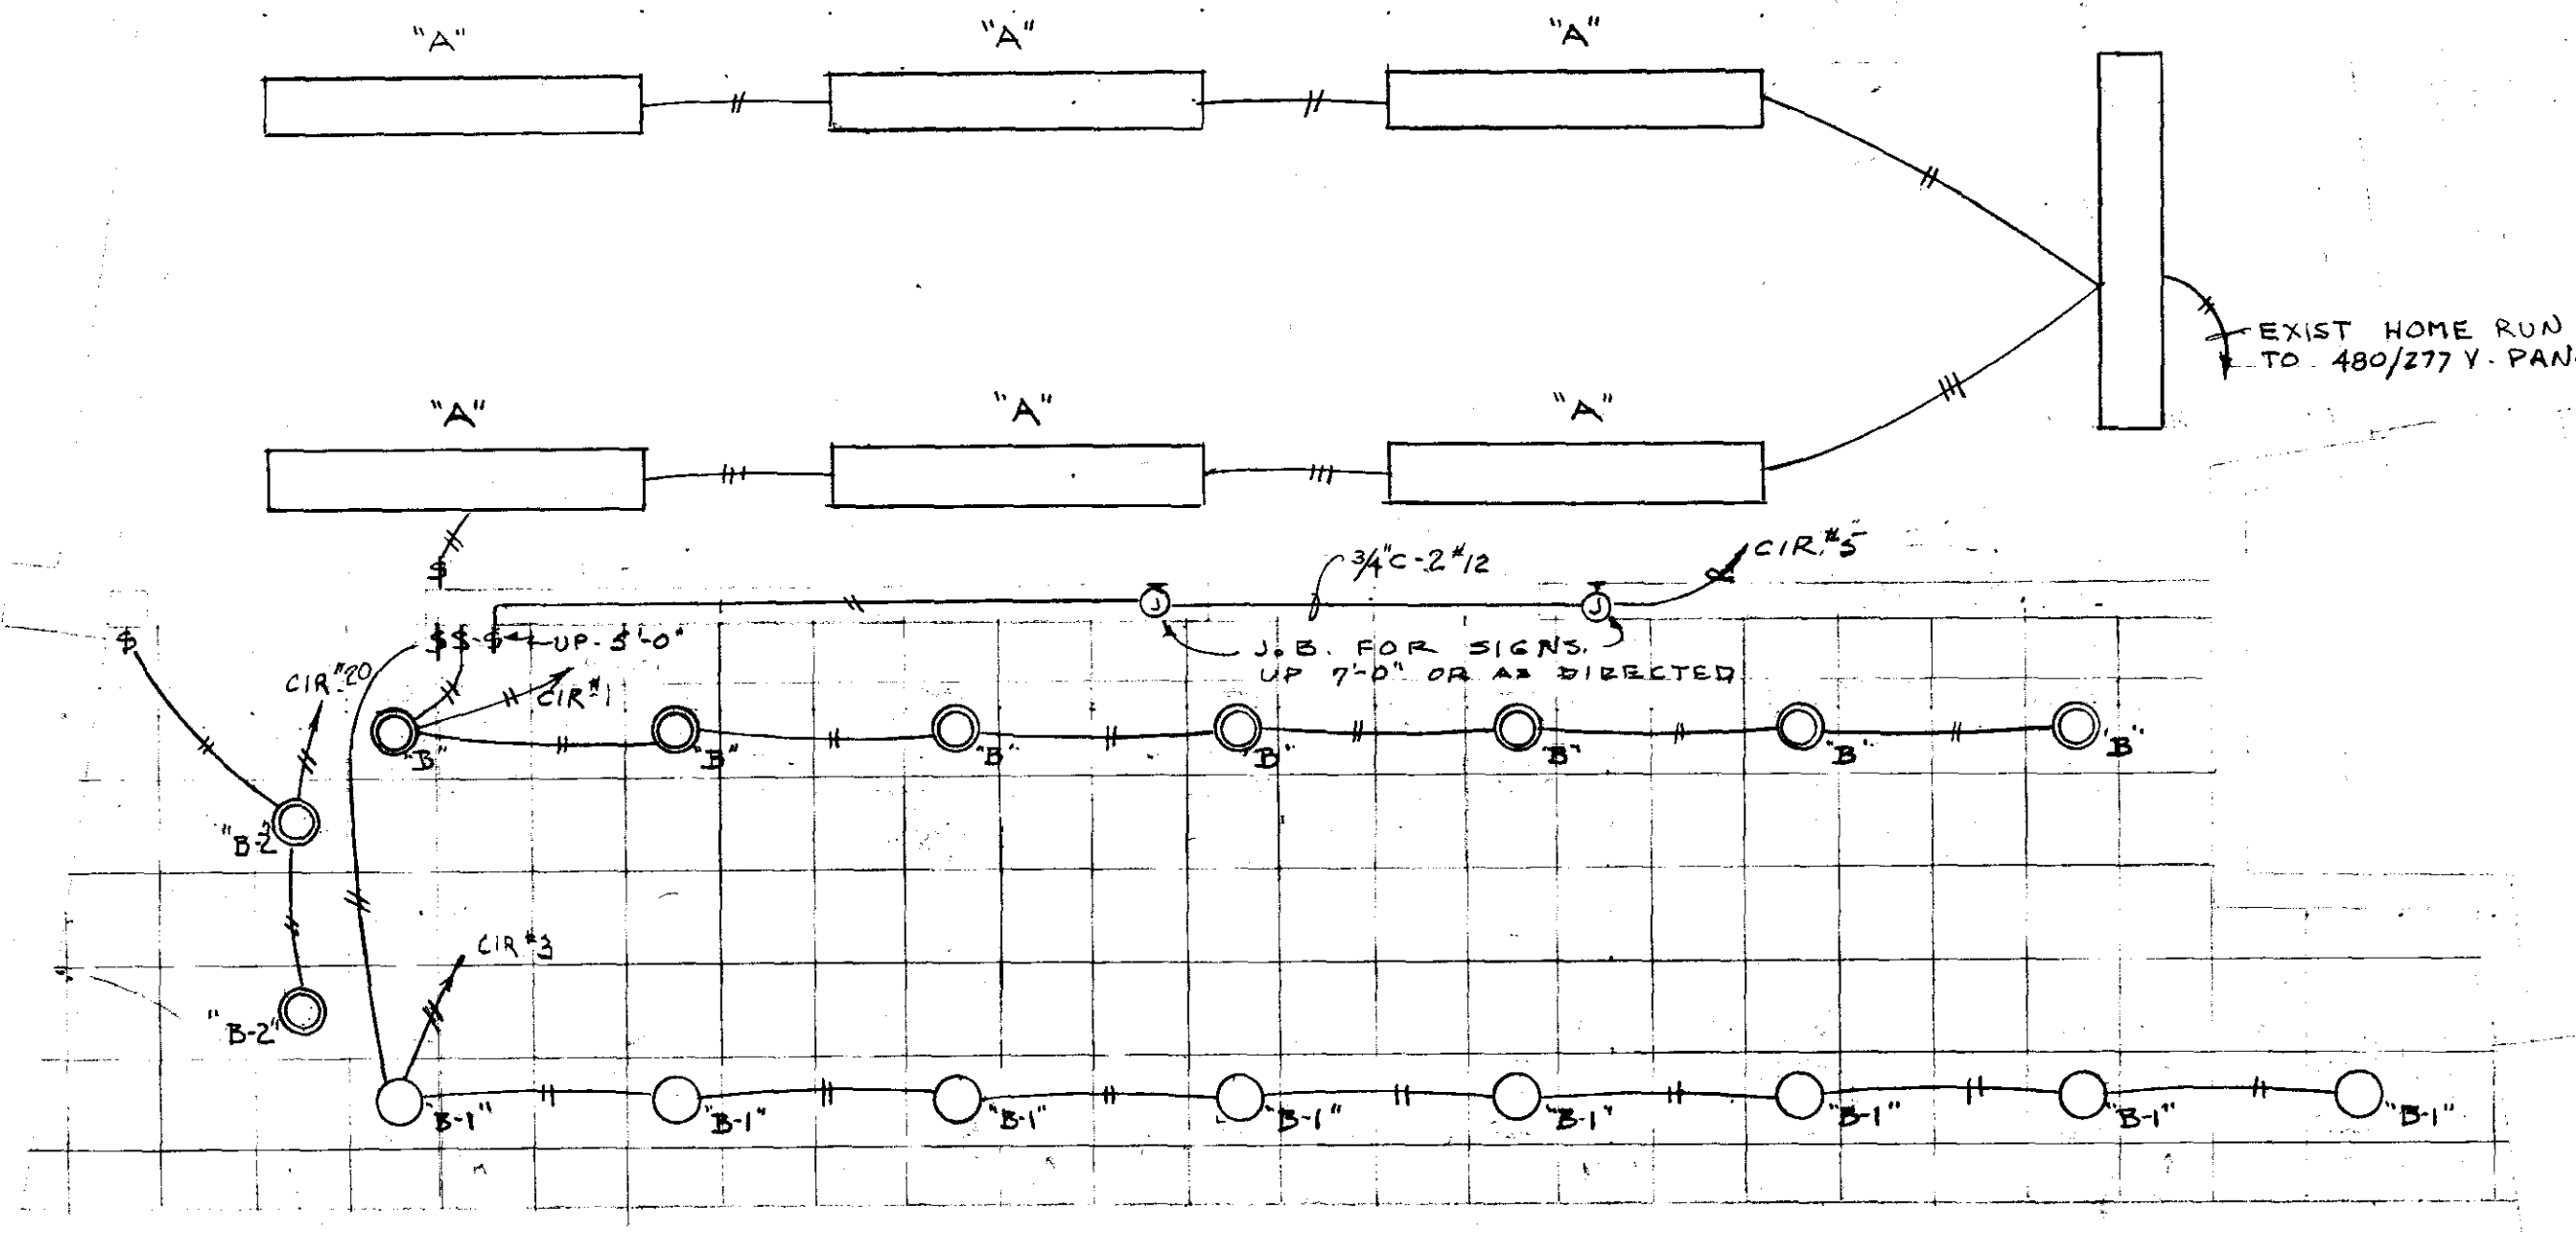


LIGHTING PLAN N.E. & S.W. CONCESSIONS SCALE 1/2" = 1'-0"
(N.W. & S.E. CONCESSIONS HAVE REVERSED FLOOR PLANS.)

EQUIPMENT SCHEDULE			
I.D.	EQUIPMENT	ELECTRICAL	CONNECT.
1	POPCORN	720 VA - 120V - 1φ - 6A.	PLUG
2	HOT DOG WARMER	1360 VA - 120V - 1φ - 11.3A	"
3	CASH REGISTER	120V - 1φ	"
4	SODA	65 VA - 120V - 1φ - 0.54A	"
5	PIZZA DISPLAY	720 VA - 120V - 1φ - 6A.	"
6	ROLL-A-GRILL	1360 VA - 120V - 1φ - 11.3A	"
7	COFFEE MAKER	2200 VA - 120V - 1φ - 18.3A	"
8	STEAM TABLE	3600 VA - 208V - 3φ - 10A	DIRECT
9	REFRIG-FREEZER	1300 VA - 120V - 1φ - 10.8A	PLUG
10	PIZZA OVEN	6700 VA - 208V - 1φ - 32.2A	DIRECT
11	ICE MACHINE	1715 VA - 120V - 1φ - 14.3A	PLUG
12	STEAM COOKER	24 KW - 480V - 3φ - 29A	DIRECT

EQUIPMENT NOT IN CONTRACT ~ FINAL CONNECTION BY CITY.


SYMBOL LIST	
SYMBOL	DESCRIPTION
○	FLUORESCENT FIXTURE
○	CEILING OUTLET OR FIXTURE
○	RECESSED FIXTURE
⊕	DUPLEX RECEPTACLE ~ HxH 5/8" x 5/8" ~ UP 2'-4"
⊕	DUPLEX RECEPTACLE ~ HxH 5/8" x 5/8" ~ IN WIREMOLD 3000
⊕	DUPLEX RECEPTACLE ~ HxH 5/8" x 5/8" ~ UP 3'-6" ~ SEE DETAIL "B"
⊕	JUNCTION BOX ~ UP 2'-0" ~ SEE DETAIL "B"
⊕	JUNCTION BOX ~ IN WIREMOLD 3000 ~ COVER # 4 3036
⊕	WIREMOLD #3000
⊕	20A-2P-3W RECEPT ~ HxH 5/8" x 5/8" ~ UP 3'-6" ~ SEE DETAIL "B"
⊕	SINGLE POLE SW ~ HxH 1 1/2" x 1 1/2" ~ UP 4'-0" OR AS NOTED
⊕	FUSED DISCONNECT SWITCH
⊕	TELEPHONE OUTLET 4" SQ BOX W/ PLASTER COVER
⊕	EXISTING TELEPHONE OUTLET, LOCATION VARIES W/ STAND
⊕	EXISTING FIRE ALARM HORN
⊕	EXISTING FIRE ALARM STATION

FIXTURE SCHEDULE	
A	EXISTING FIXTURE ~ TO BE REMOVED, CLEANED & REHUNG ON NEW CEILING. SURFACE MTD. PROVIDE NEW BRANCH CIRCUIT WIRING.
B	LIGHTOLIER #7760-RECESSED ~ LAMP 150R/FL
B-1	LIGHTOLIER #7075 ~ SURFACE MTD ~ LAMP 150R/FL
B-2	LIGHTOLIER #7042-A2 ~ RECESSED ~ LAMP 300R/FL

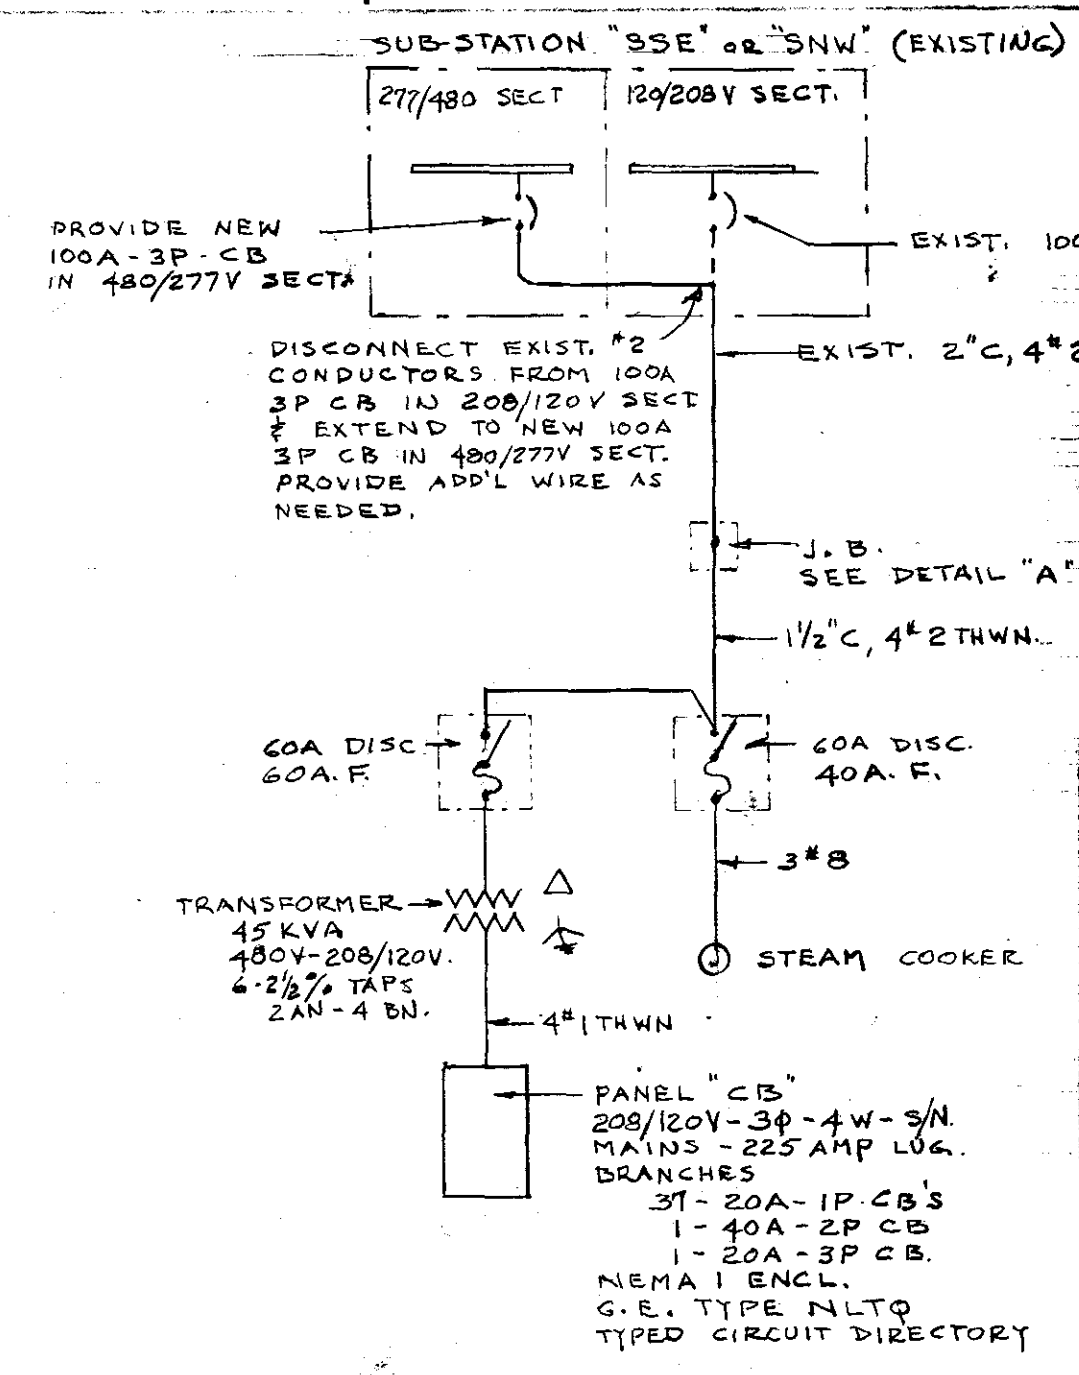


POWER RISER DIAGRAM
NO SCALE


- NOTES:**
- EXISTING PANELS "CB" & FEEDERS ARE LOCATED ON THE WALLS WHICH ARE TO BE REMOVED. EXACT LOCATION VARY WITH EACH CONCESSION STAND. SEE DETAIL "A" OR "A-1" FOR METHOD OF UTILIZING EXISTING FEEDERS AND CONDUIT.
 - EXISTING BRANCH CIRCUIT CONDUITS FROM EXISTING PANELS "CB". REMOVE EXISTING CONDUITS. CUT CONDUITS 1' BELOW EXISTING FLOOR ELEVATION AND PLUG CONDUITS. REFINISH FLOOR.
 - EXISTING 2" CONDUIT & CONDUCTORS. CUT CONDUIT WITHOUT CUTTING OR DAMAGING CONDUCTORS. CUT FLOOR IF NECESSARY TO CUT CONDUIT AND/OR TO MAINTAIN DIMENSIONS SHOWN. IF CONDUCTORS ARE DAMAGED WHEN CUTTING CONDUIT, THE CONTRACTOR SHALL REPLACE THEM WITH NEW CONDUCTORS AT NO COST TO THE CITY.
 - EXISTING RECEPTACLES, OUTLETS, JUNCTION BOXES, AND RACEWAYS ARE NOT SHOWN, BUT THEIR REMOVAL SHALL BE THE RESPONSIBILITY OF THIS ELECTRICAL CONTRACTOR. ALSO SEE SPECIFICATIONS.

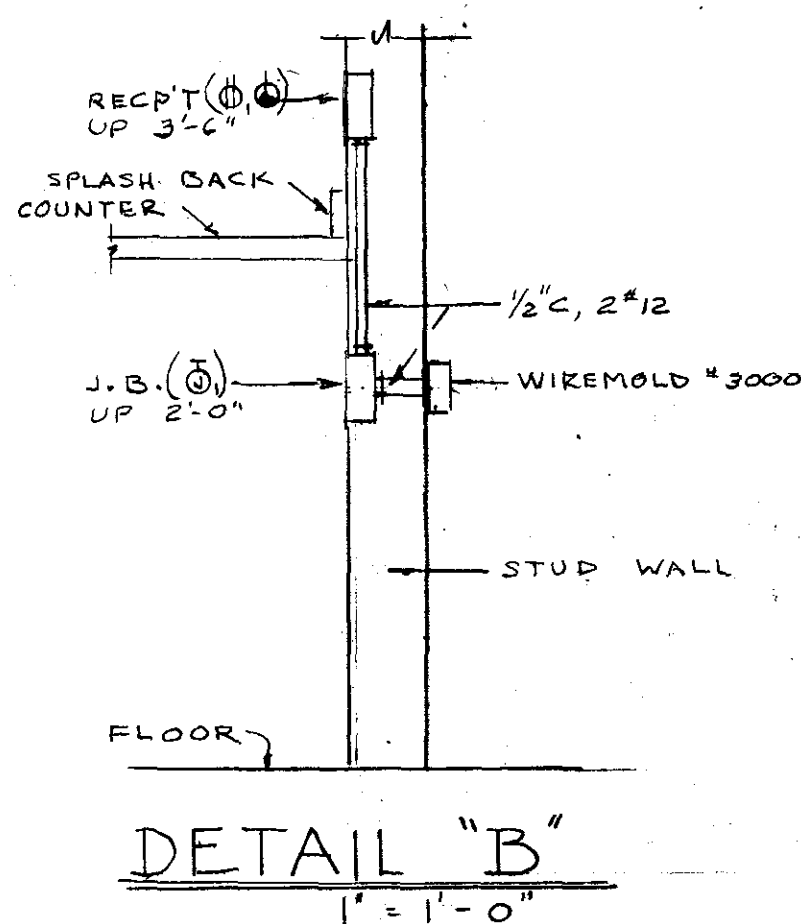


DETAIL "B"
1" = 1'-0"

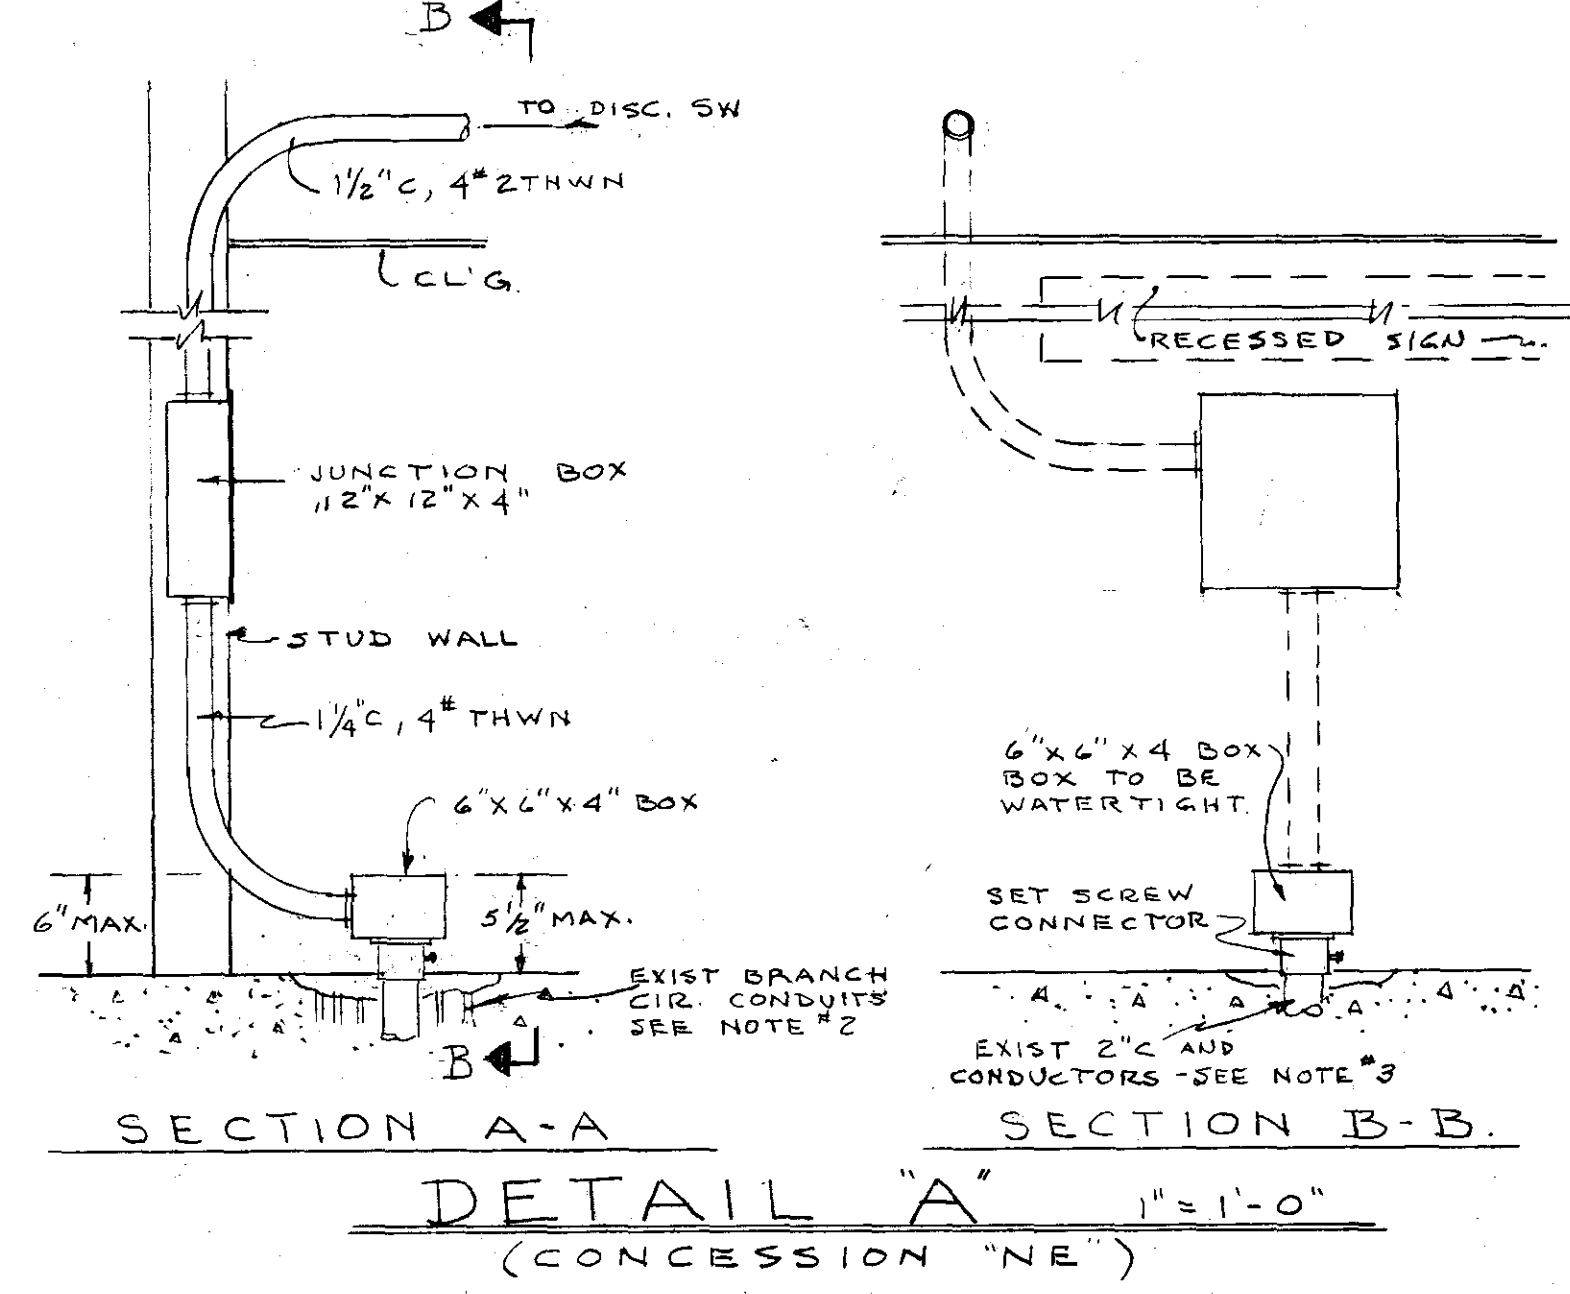

DETAIL "A"
(CONCESSION "NE")
1" = 1'-0"

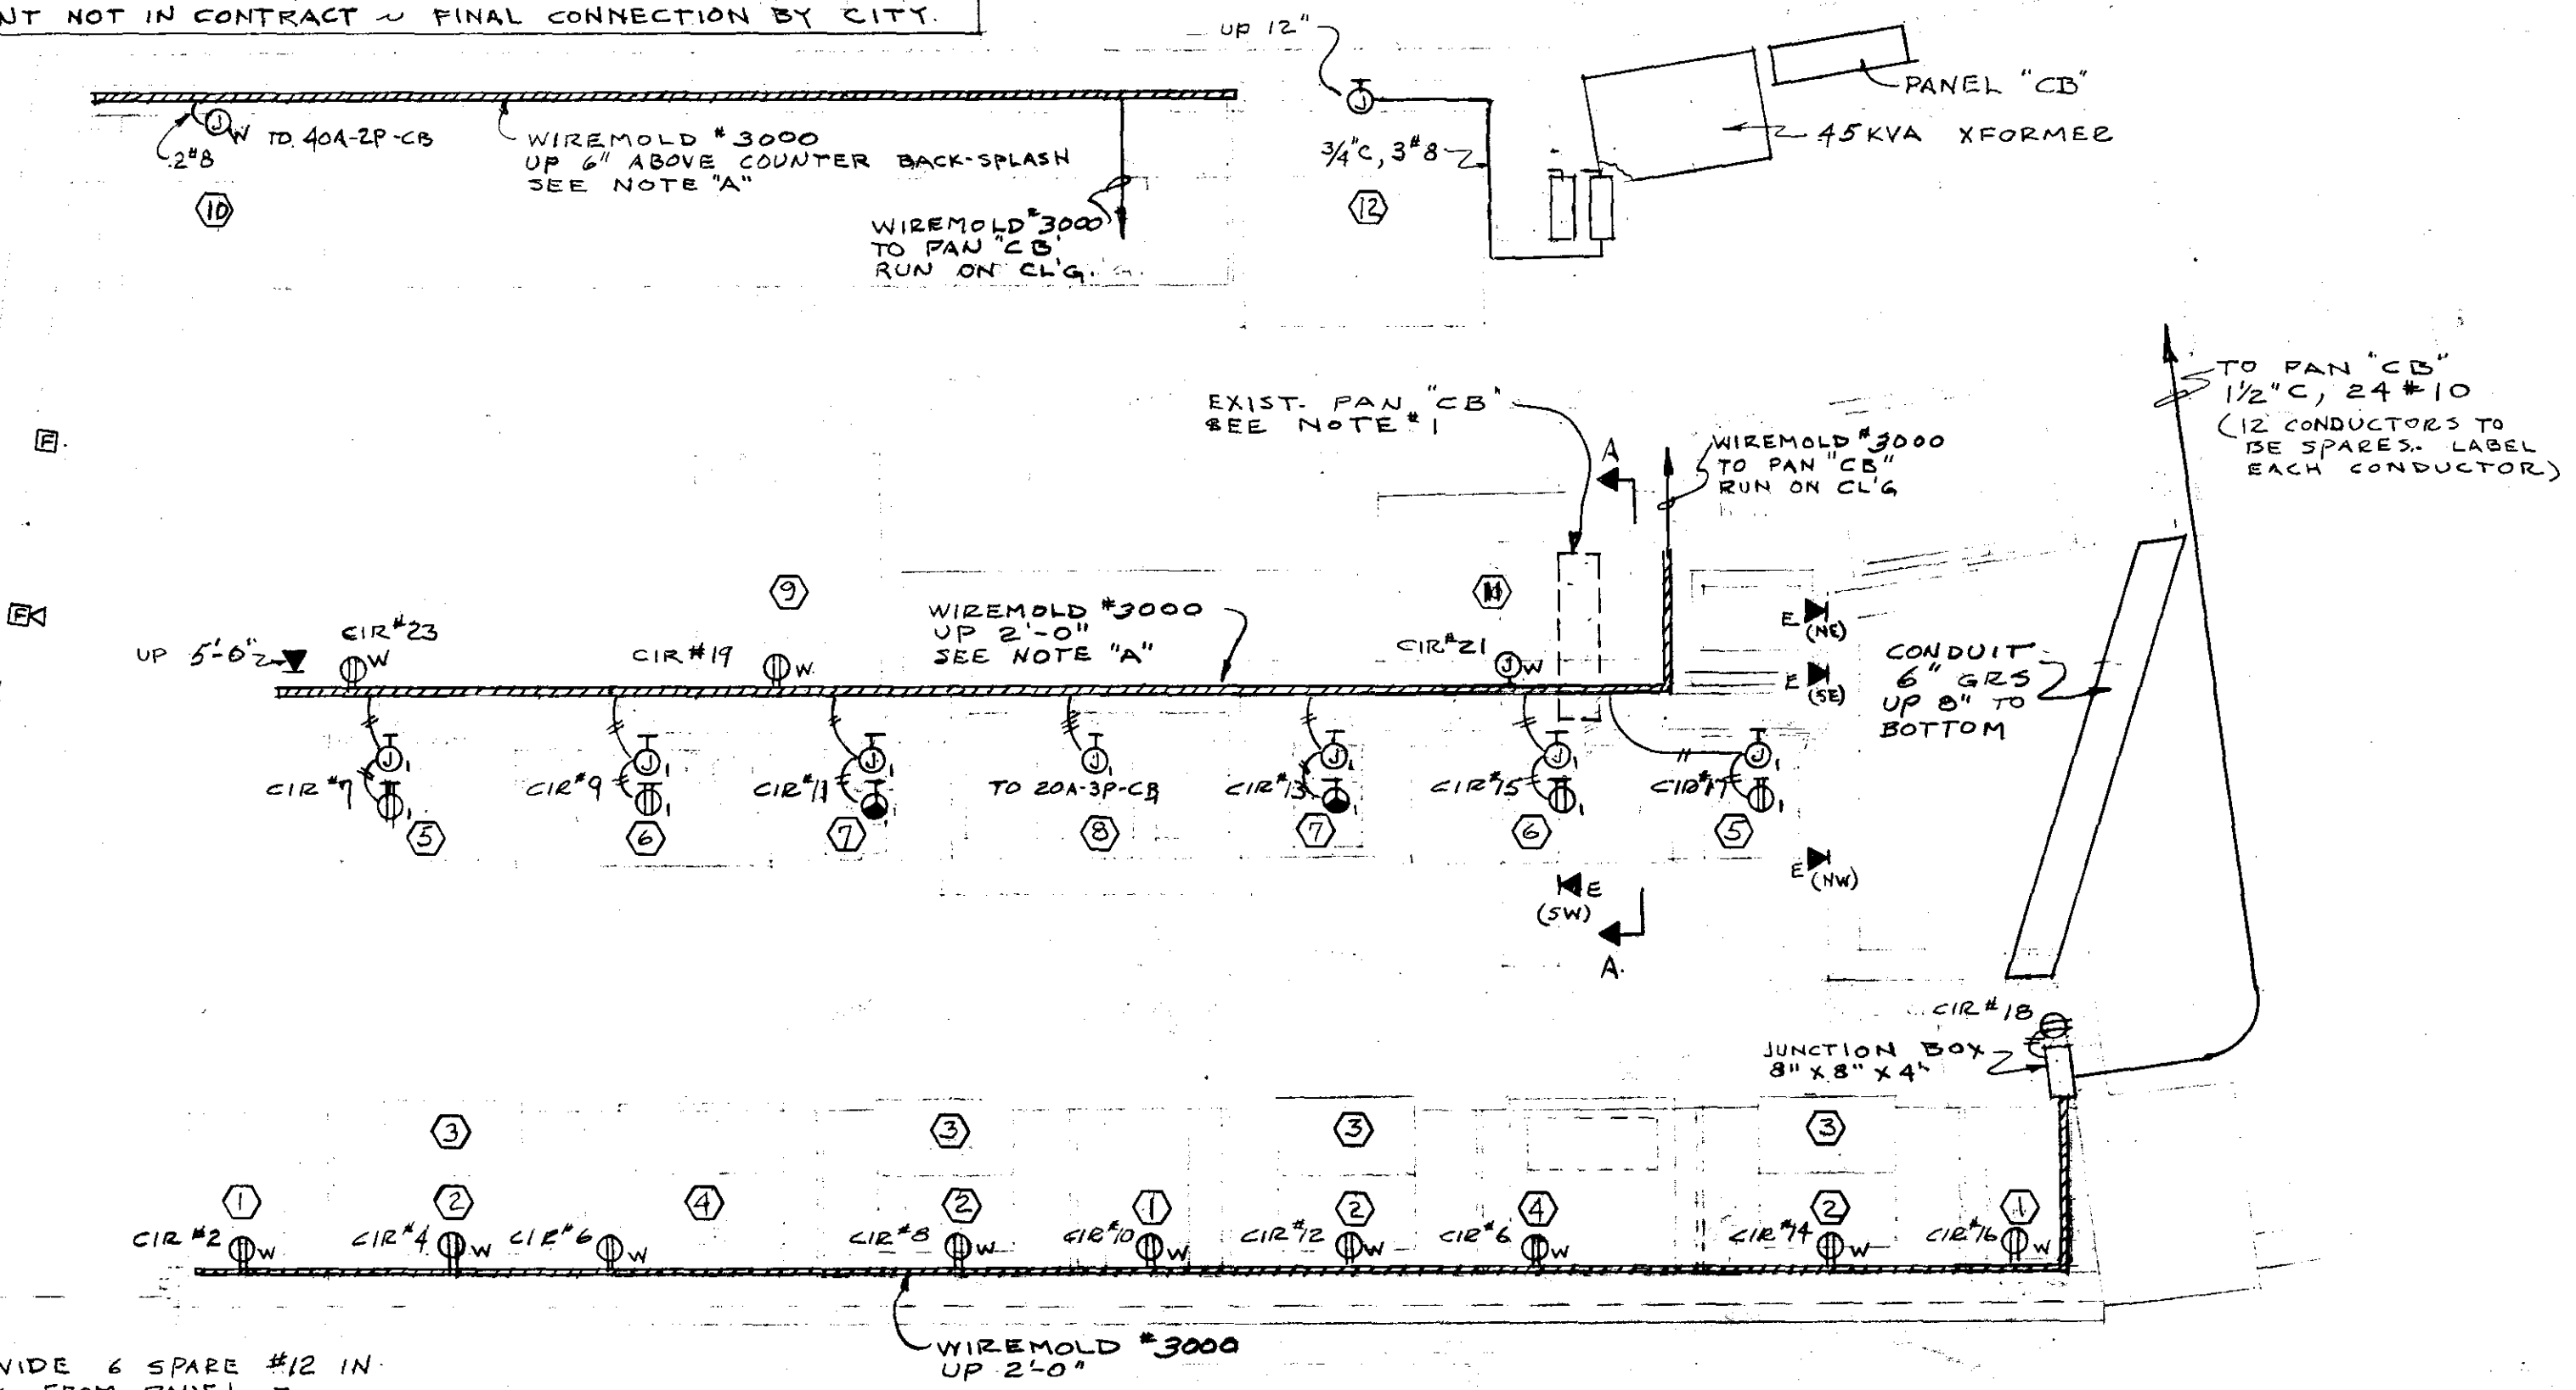

POWER PLAN N.E. & S.W. CONCESSIONS SCALE 1/2" = 1'-0"
(N.W. & S.E. CONCESSIONS HAVE REVERSED FLOOR PLANS.)

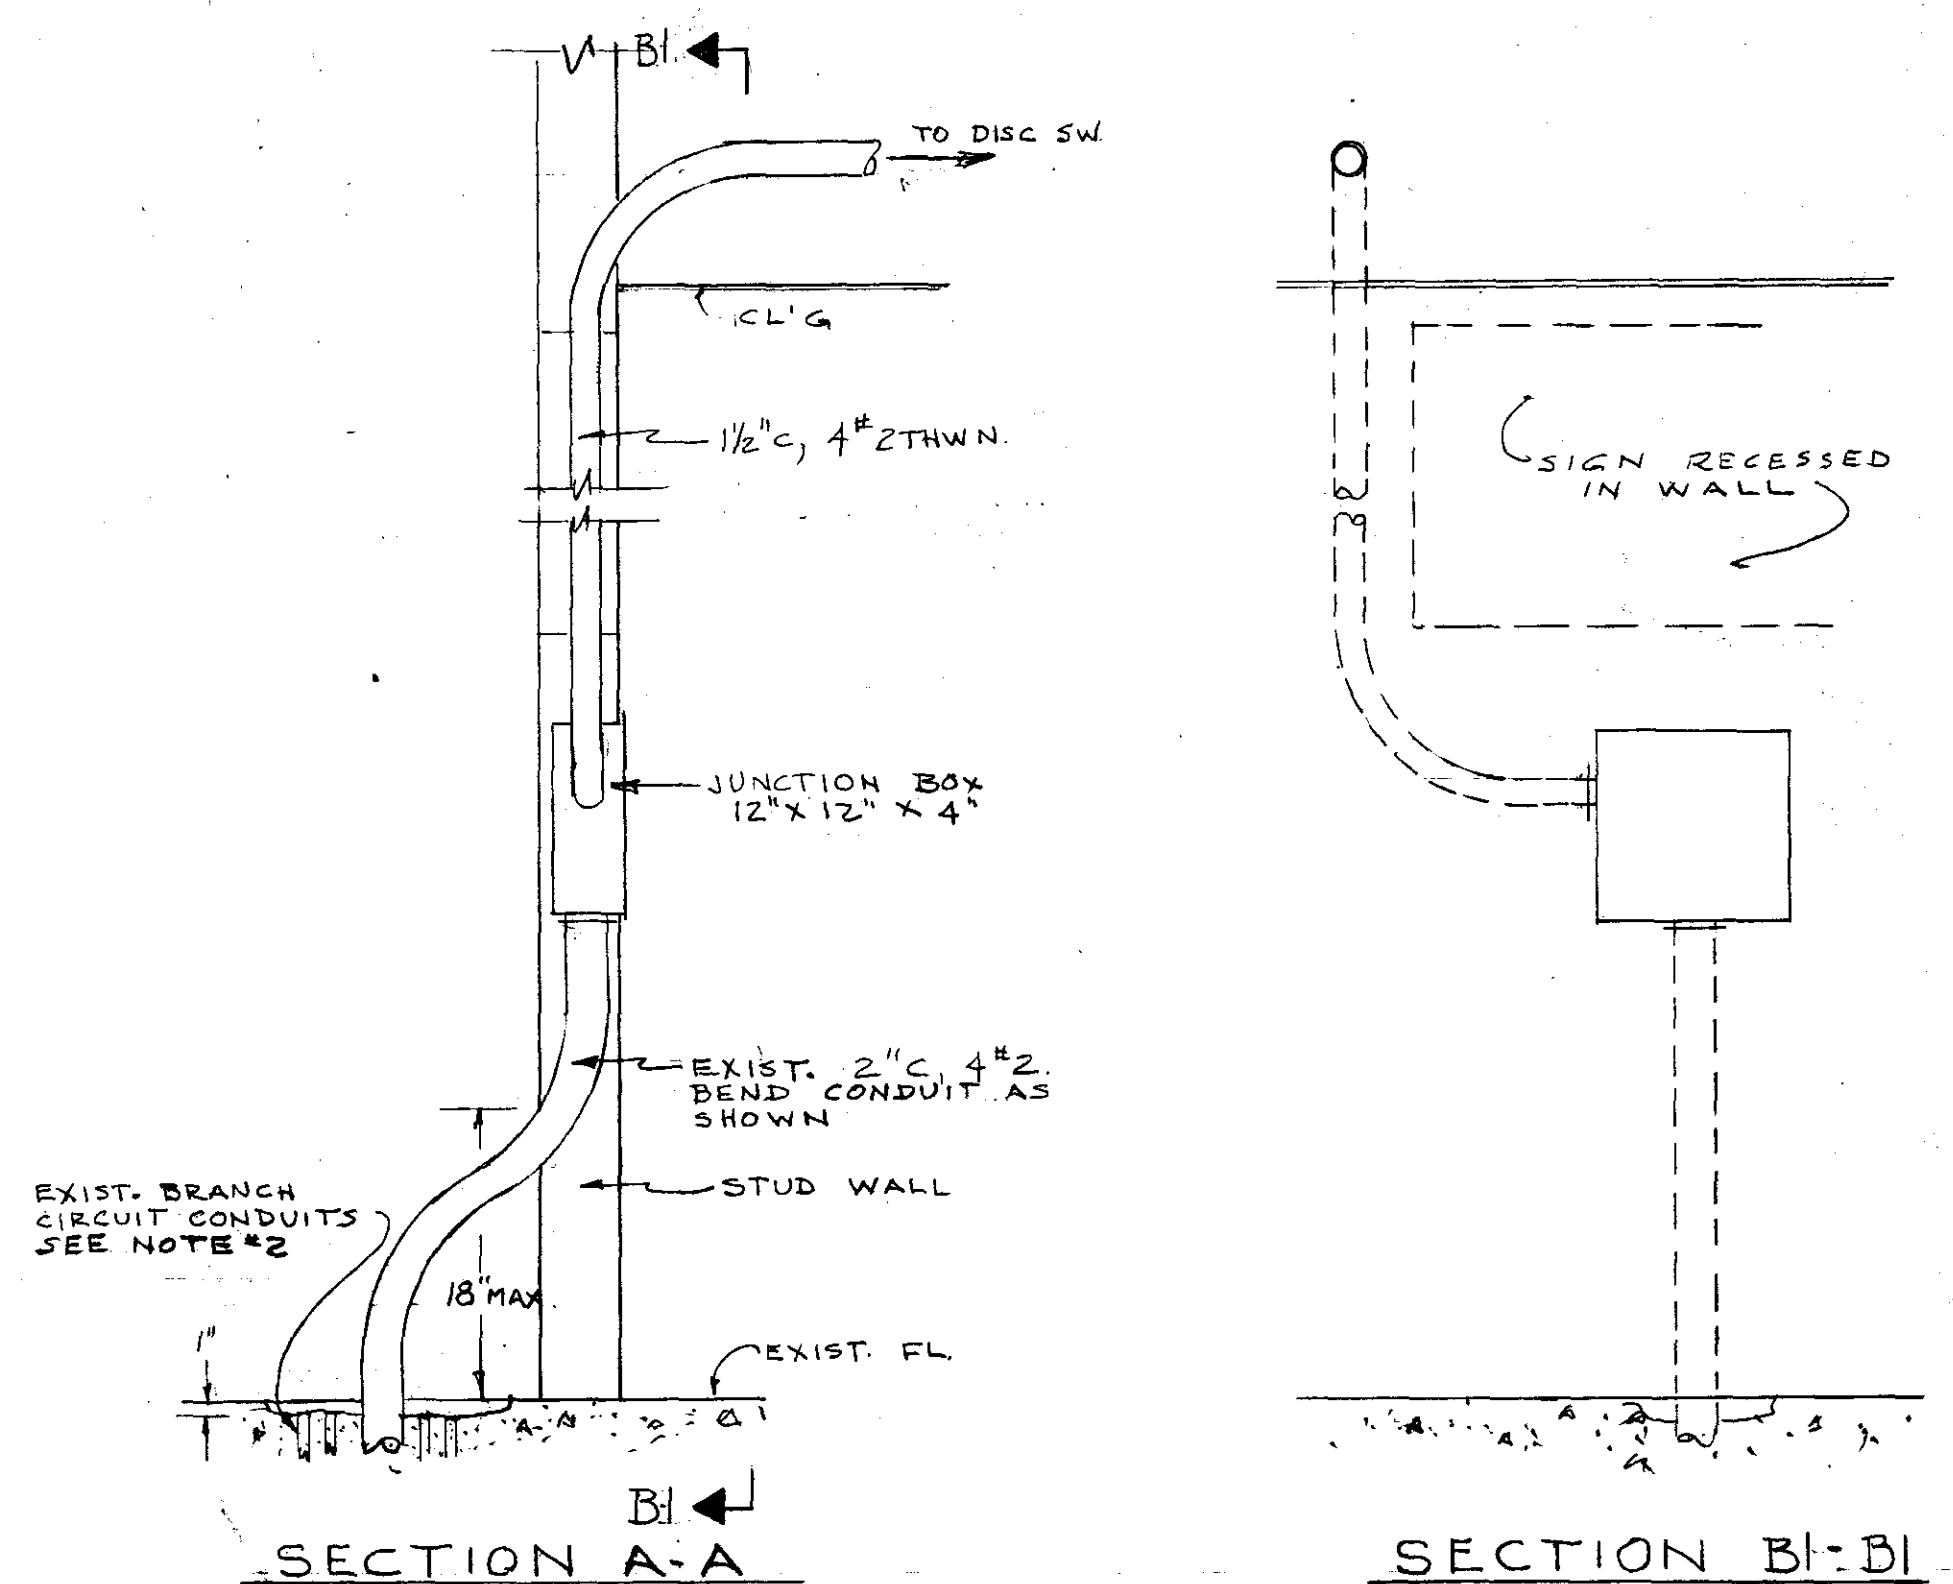

DETAIL "A-1"
(TYPICAL FOR CONCESSION SE, SW & NW)
1" = 1'-0"

VERIFY EXISTING CONDITIONS AND DIMENSIONS

CITY OF HARTFORD, CONNECTICUT
DEPARTMENT OF PUBLIC WORKS
BUREAU OF PUBLIC BUILDINGS

RENOVATION OF FOUR CONCESSION STANDS
AT ELEVATION 61'
CIVIC CENTER HARTFORD CONN.

APPROVED: *R. H. Cannon* *Walter K. Paul* *George L. Meyer*
DRAWN: R.G.B. SCALE: DAYBOOK NO. 010618D
CHECKED: DATE: AUG. 31, 1977

E-1