

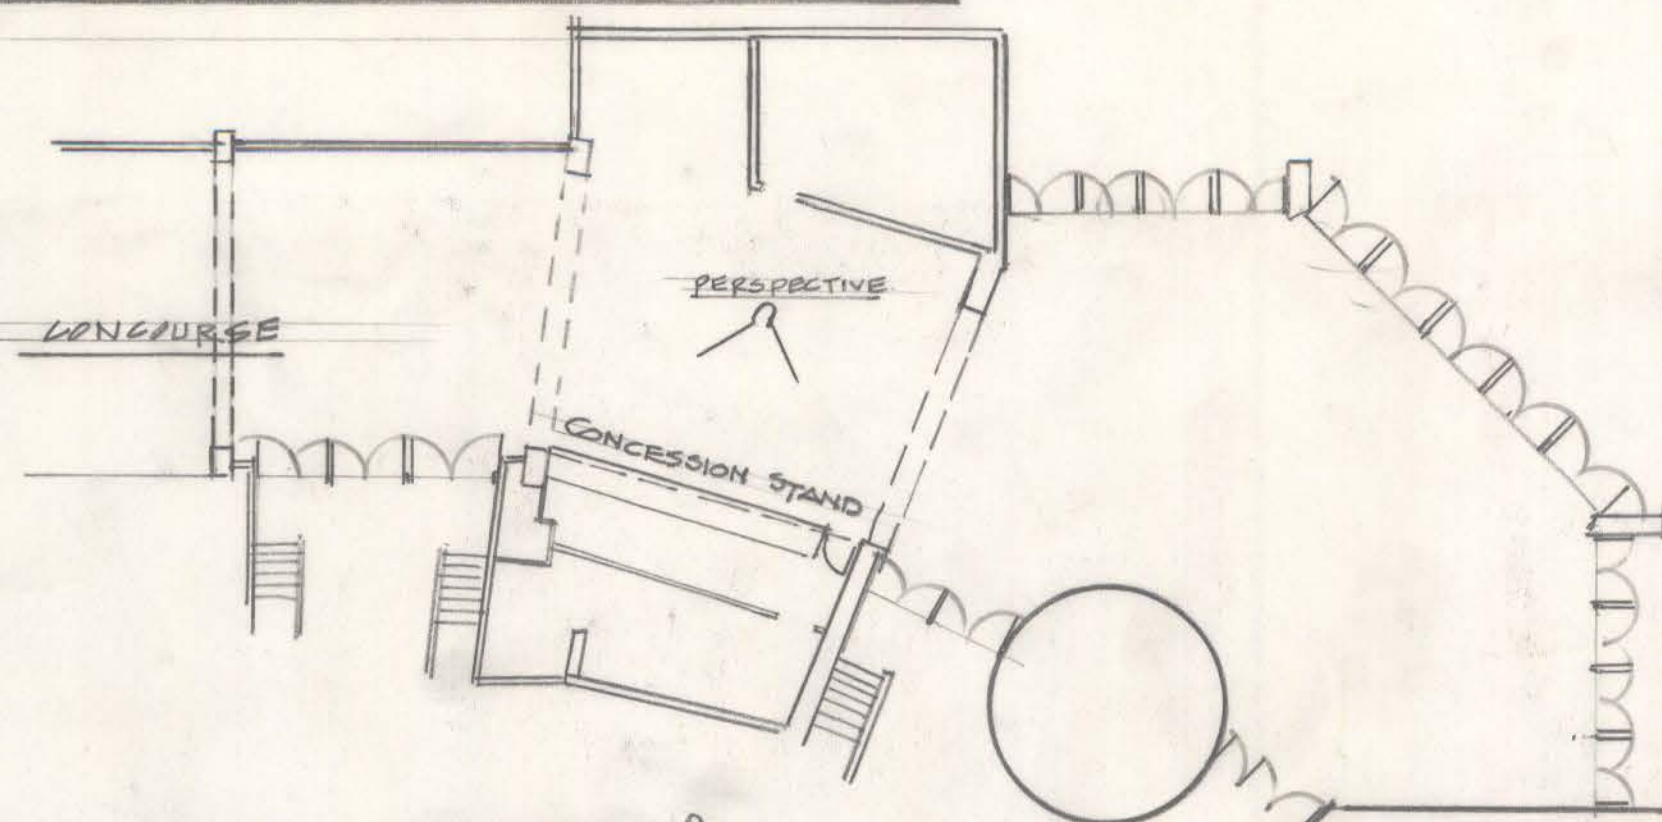



PLOT PLAN OF NORTH EAST CONCESSION

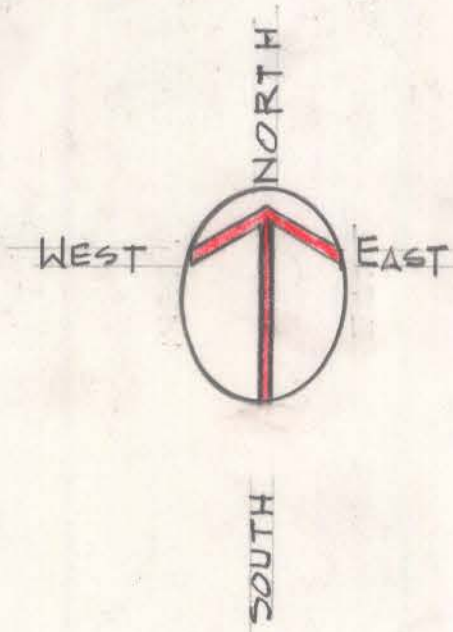

PLOT PLAN OF NORTH WEST CONCESSION

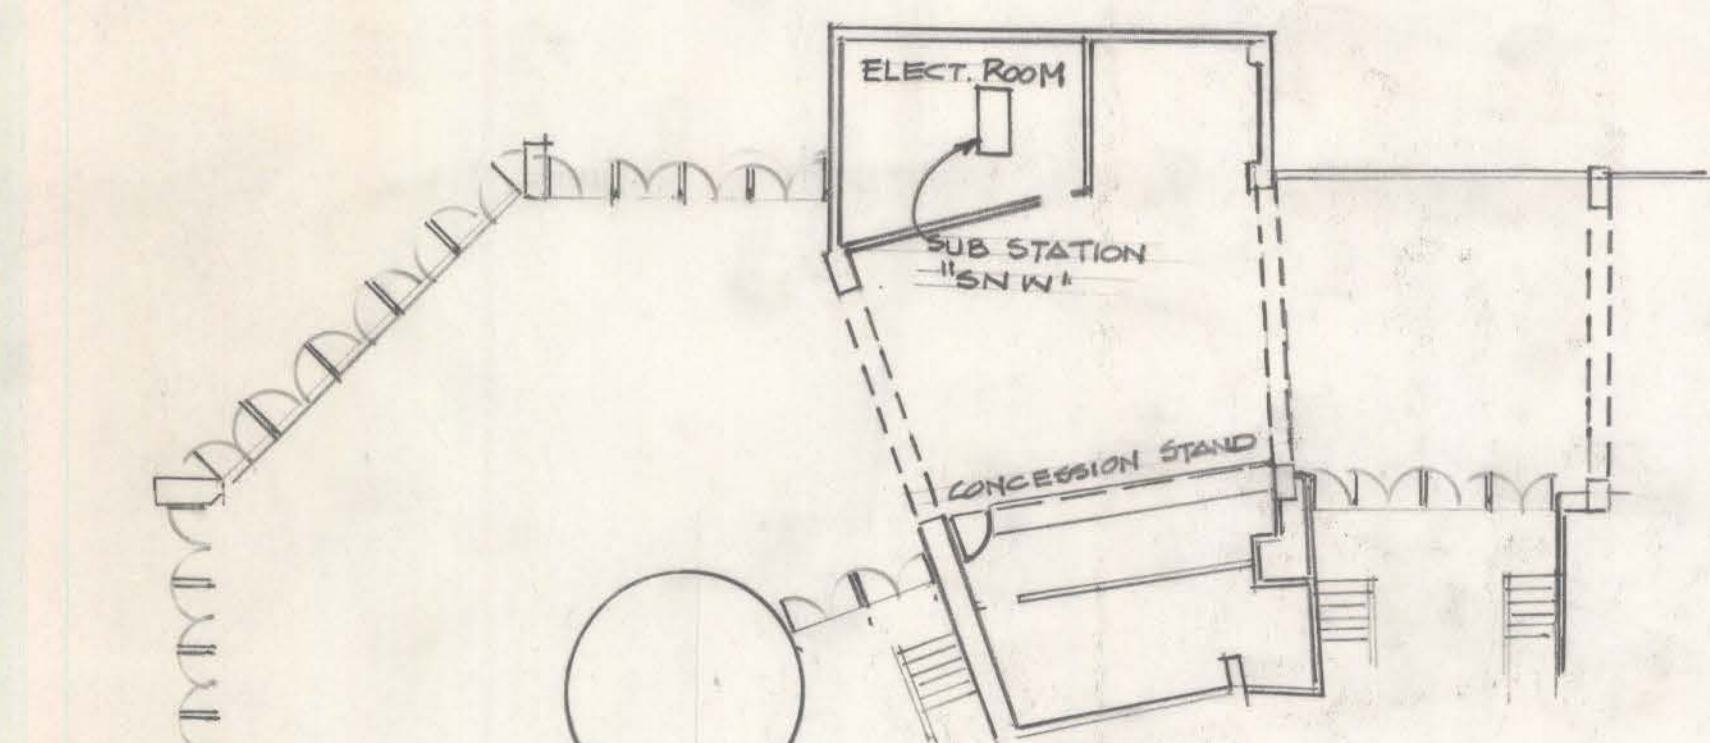


PLOT PLAN OF SOUTH WEST CONCESSION

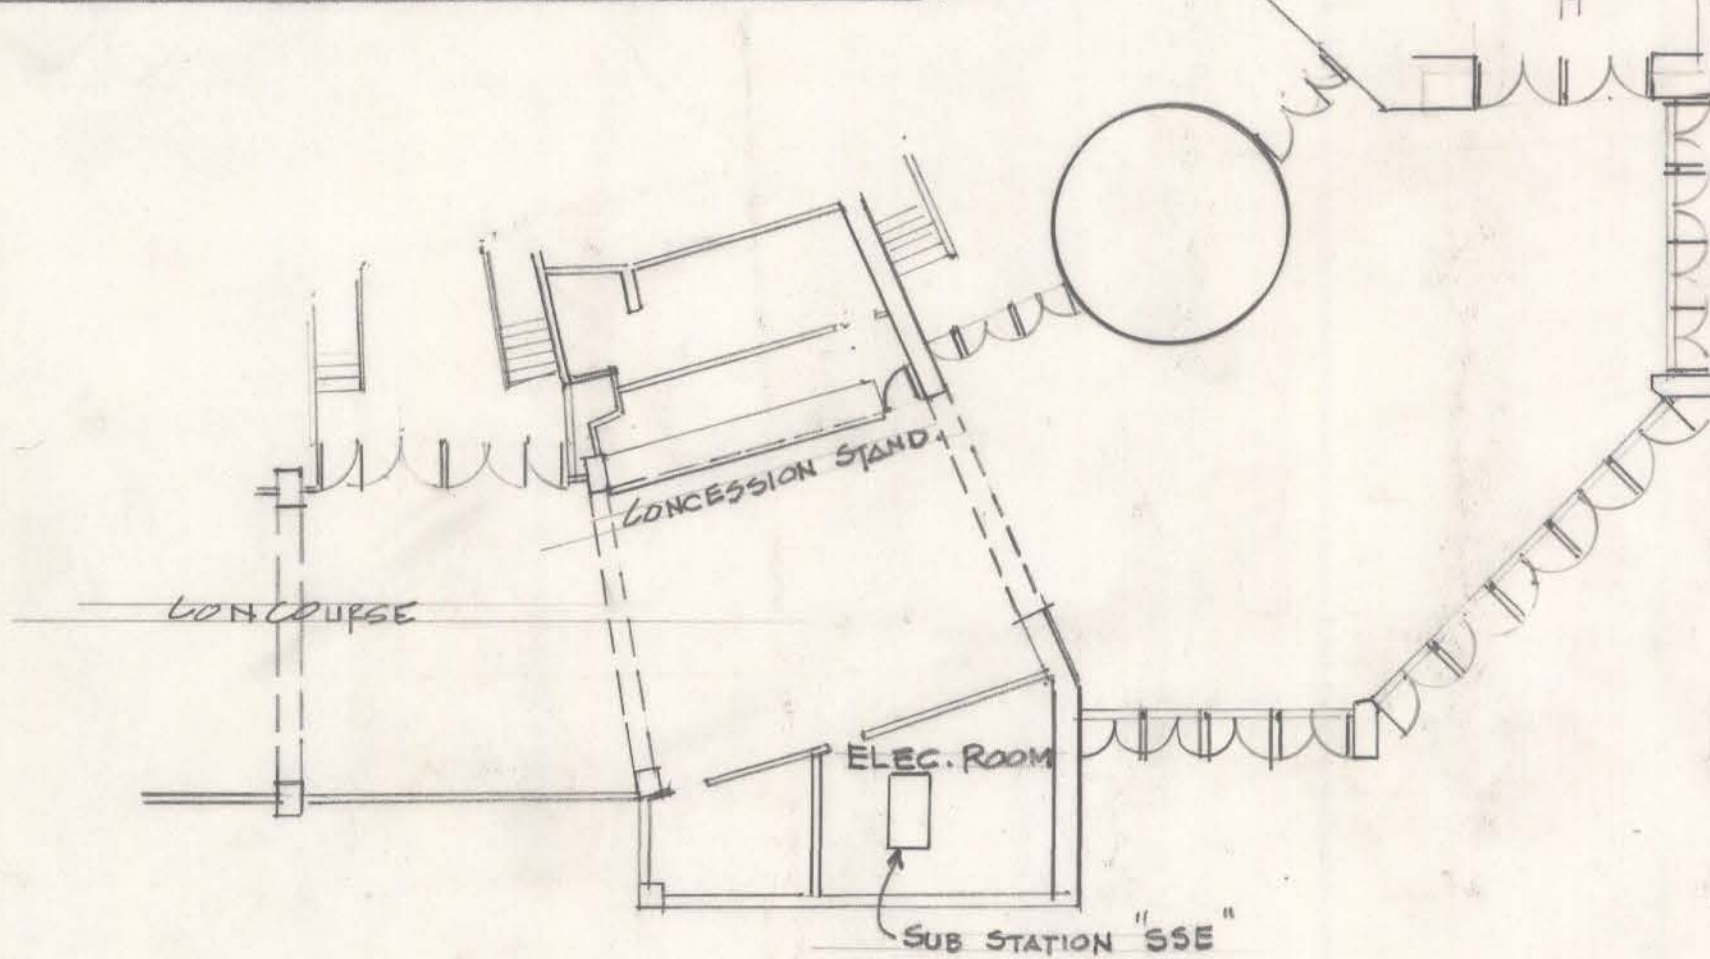


PLOT PLAN OF SOUTH-EAST CONCESSION

SCALE 1/16" = 1'-0"

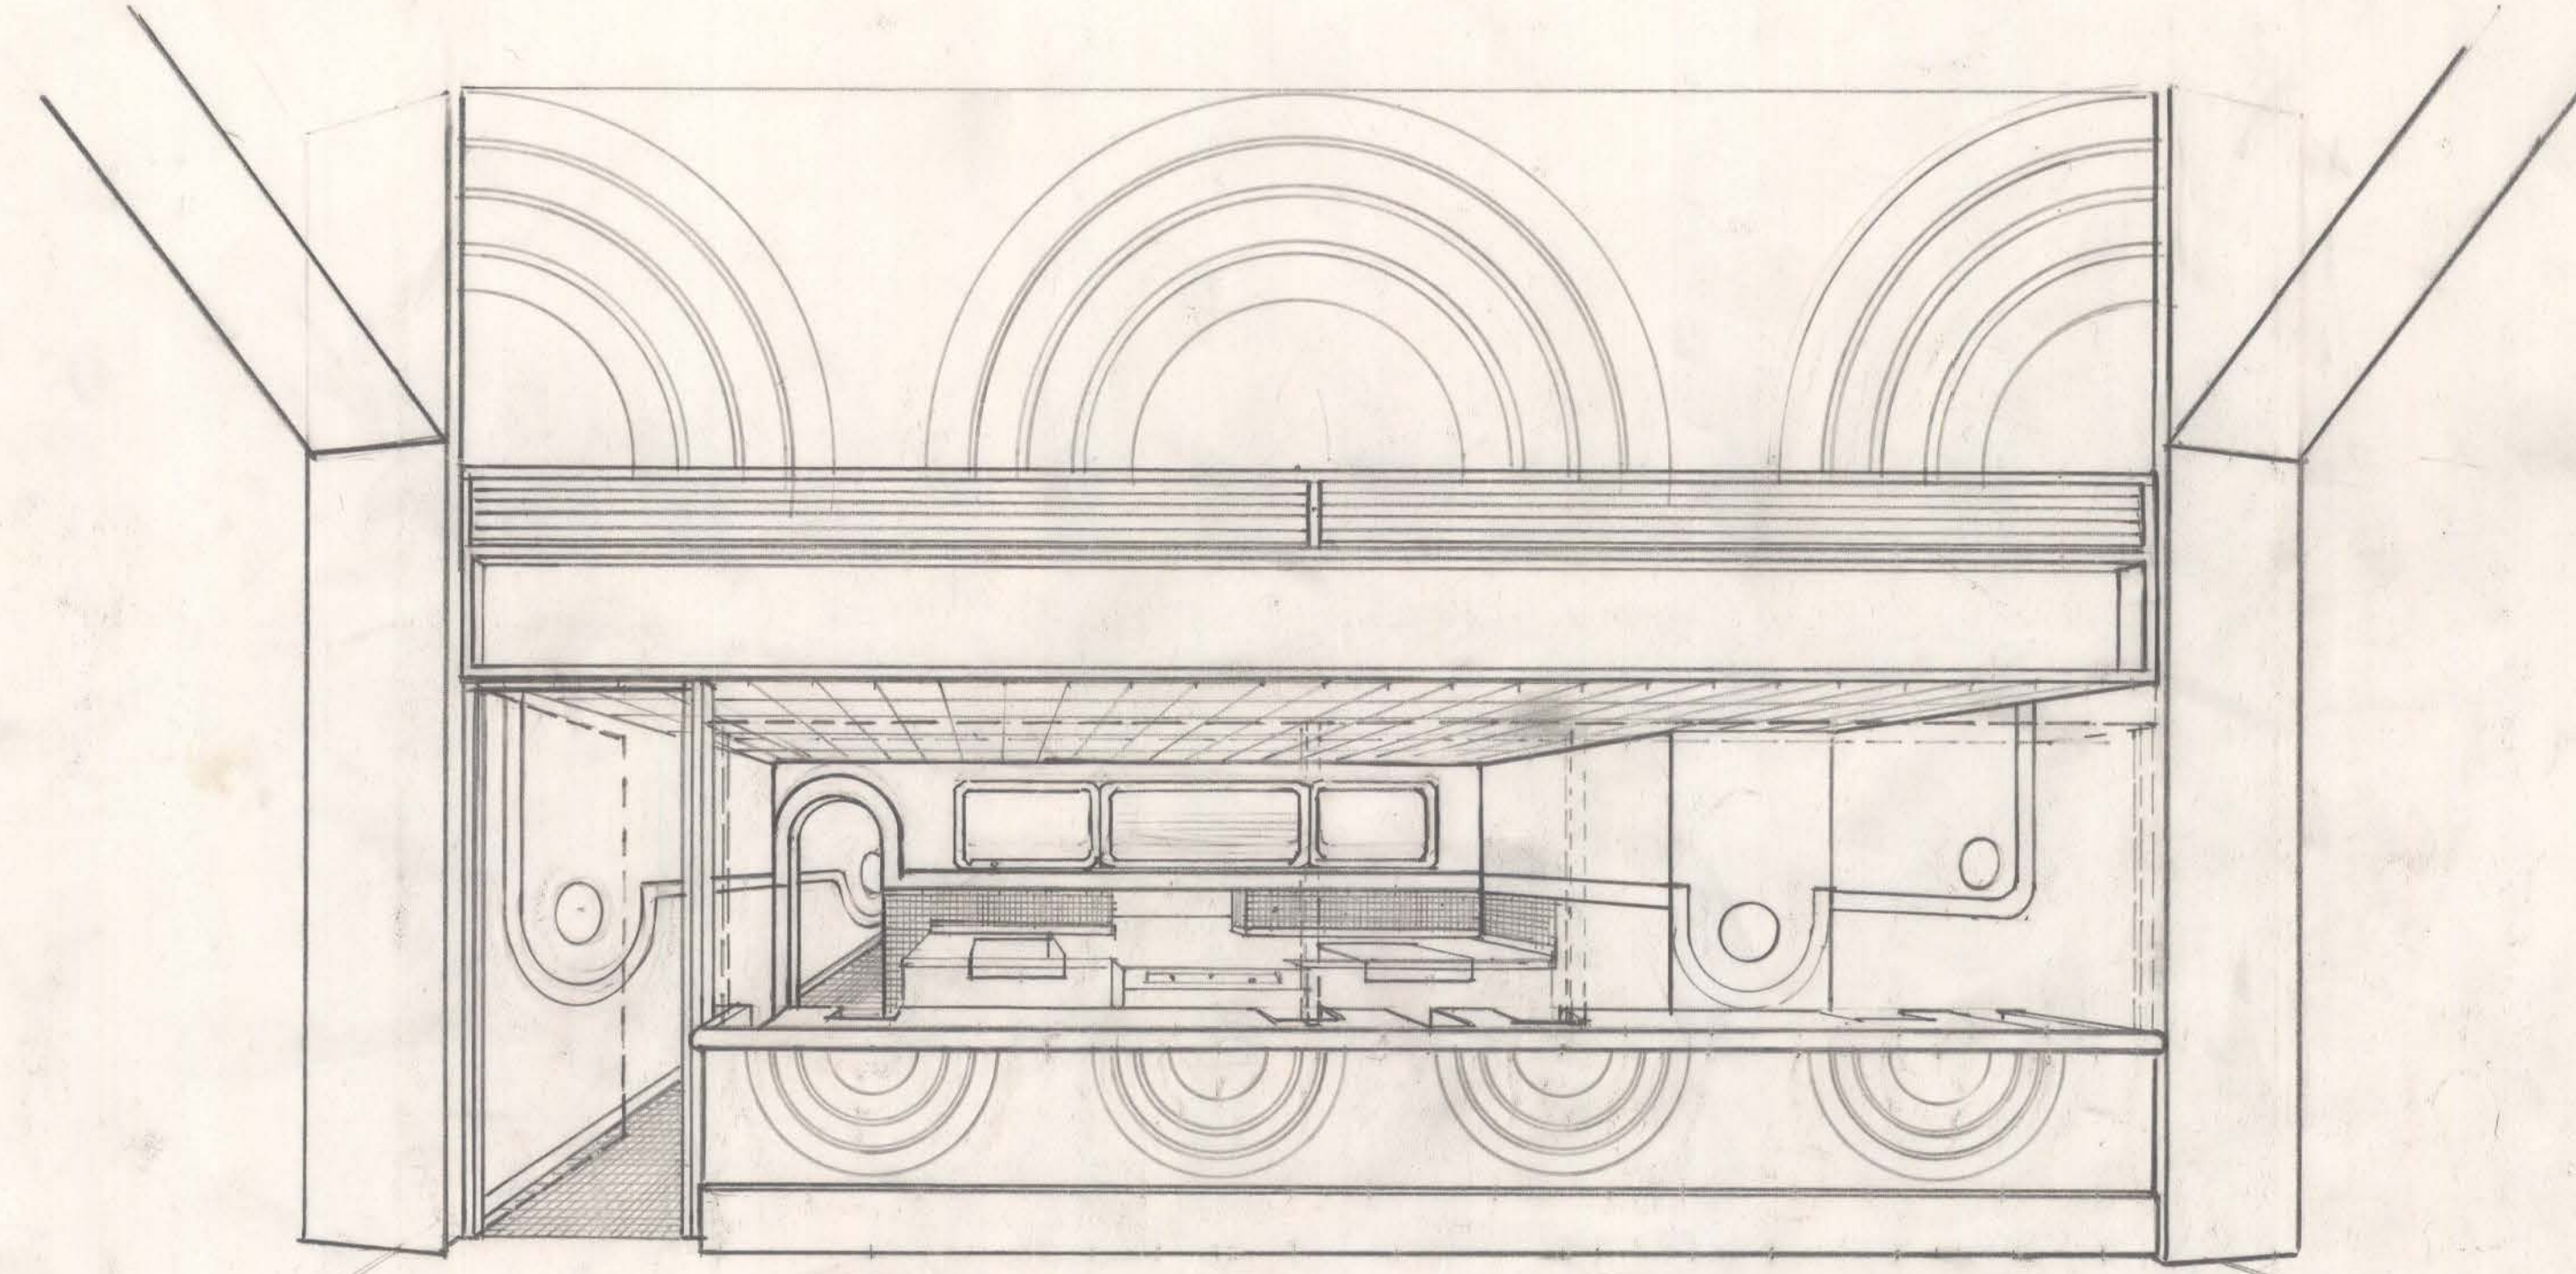

PERSPECTIVE

NO SCALE.

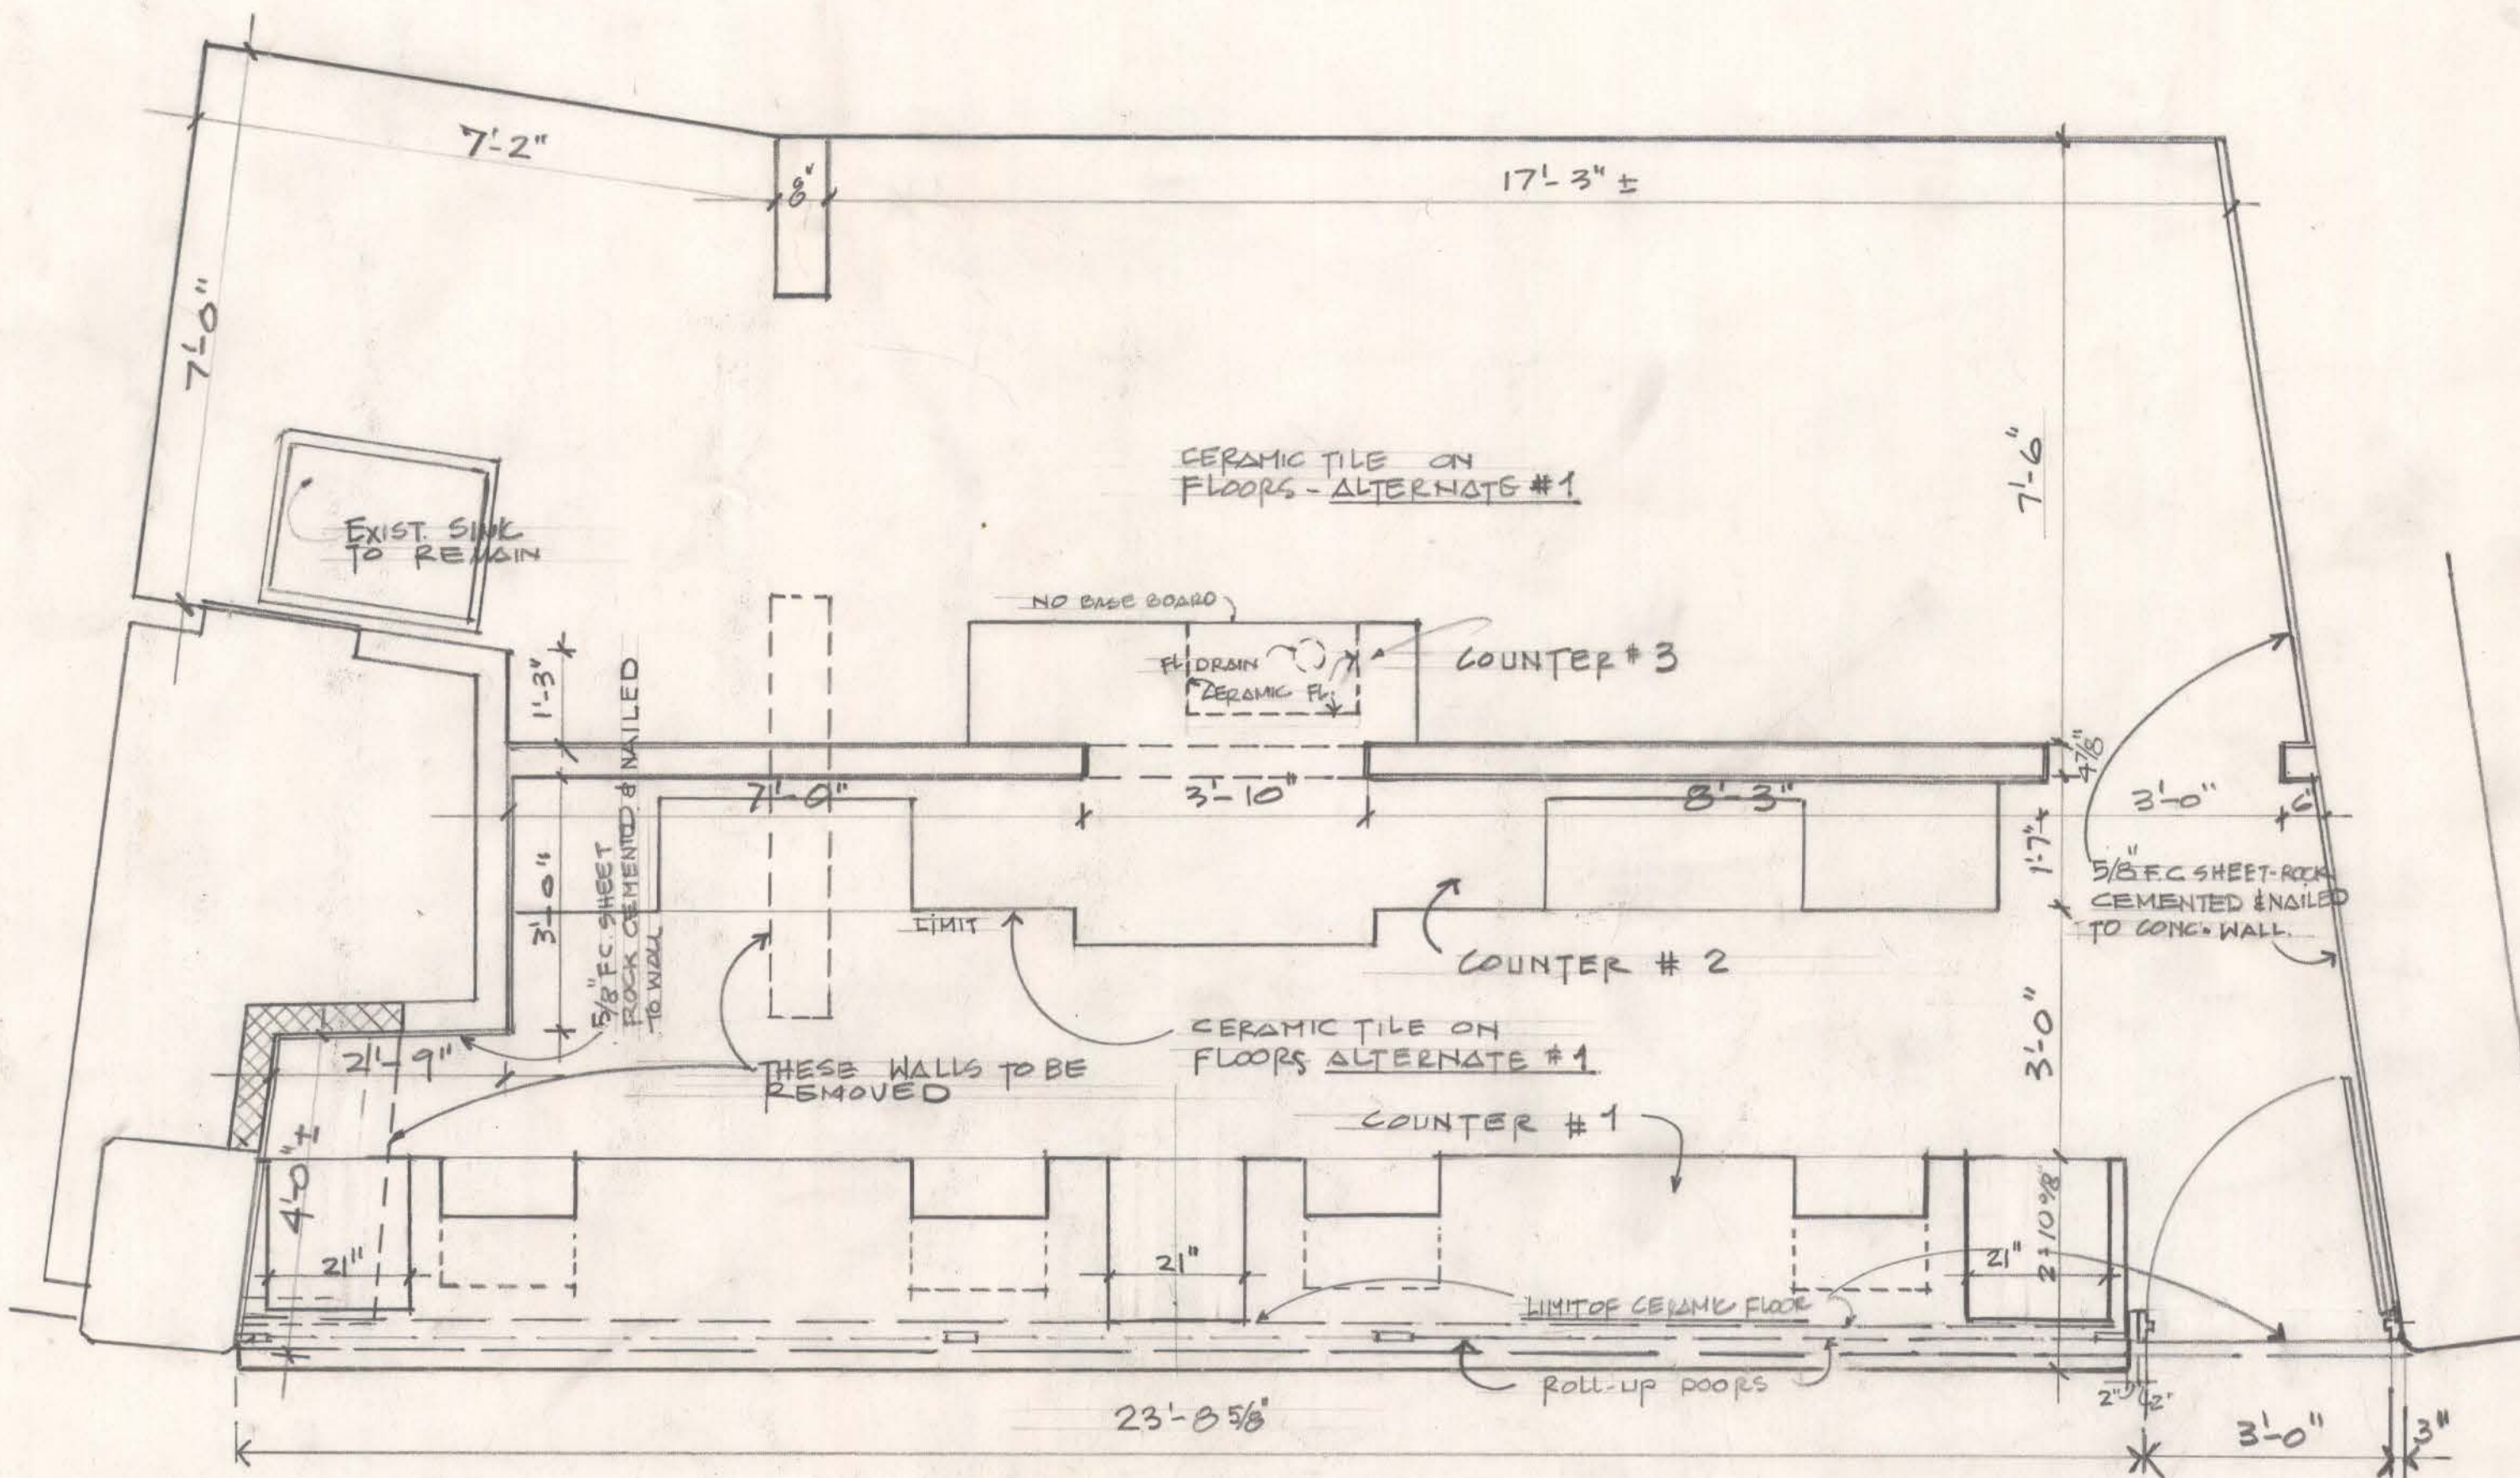

FLOOR PLAN OF IN.W. & S.E. CONCESSION STANDS

FOR DETAILS - SEE DRWG A-1

SCALE 1/2" = 1'-0"



The Hartford Civic Center

LEGEND

- A-0 - PLOT PLANS, FLOOR PLAN, PERSPECTIVE, & LEGEND.
- A-1 - FLOOR PLAN, ELEVATIONS, STRUCTURAL DETAIL, AND SECTIONS
- E-1 - ELECTRICAL PLAN
- M-1 - MECHANICAL PLAN.

VERIFY EXISTING CONDITIONS AND DIMENSIONS

CITY OF HARTFORD, CONNECTICUT
DEPARTMENT OF PUBLIC WORKS
BUREAU OF PUBLIC BUILDINGS

RENOVATION OF FOUR CONCESSION STANDS AT LEVEL G.0
CIVIC CENTER, HARTFORD, CT.

SUBMITTED	RECOMMENDED	APPROVED
H. FLORES-JENKINS	Walter D. Peak	George C. Higgins
ARCHITECT	ARCHITECT	ARCHITECT
DRAWN H.F.J.	AS NOTED	DATE AUG. 31/77
CHECKED		

A-0