




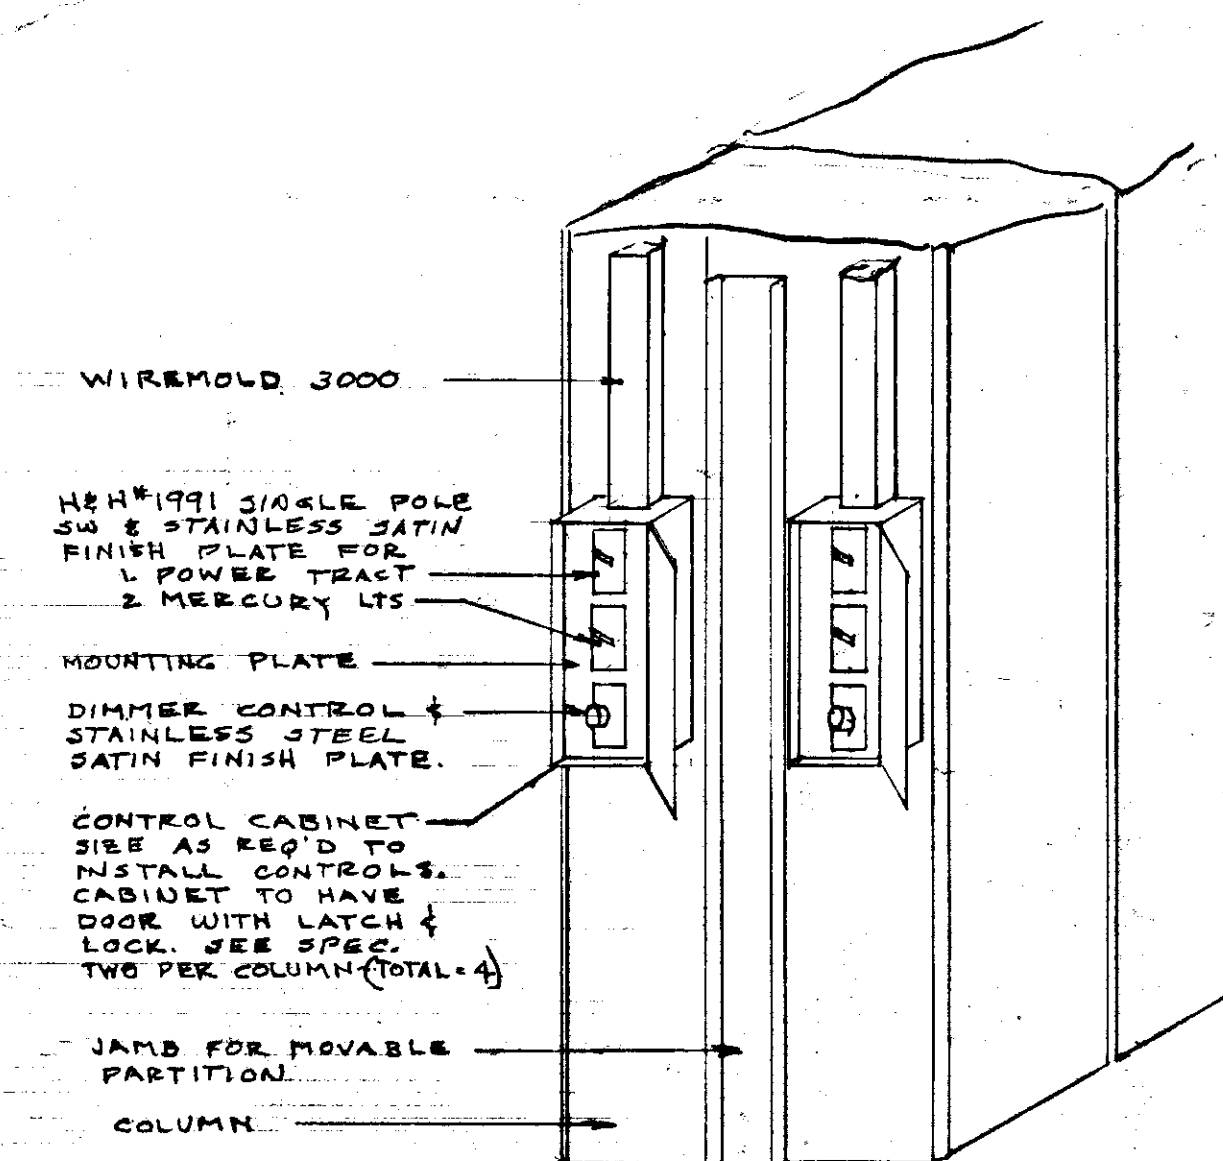

DETAIL "A"

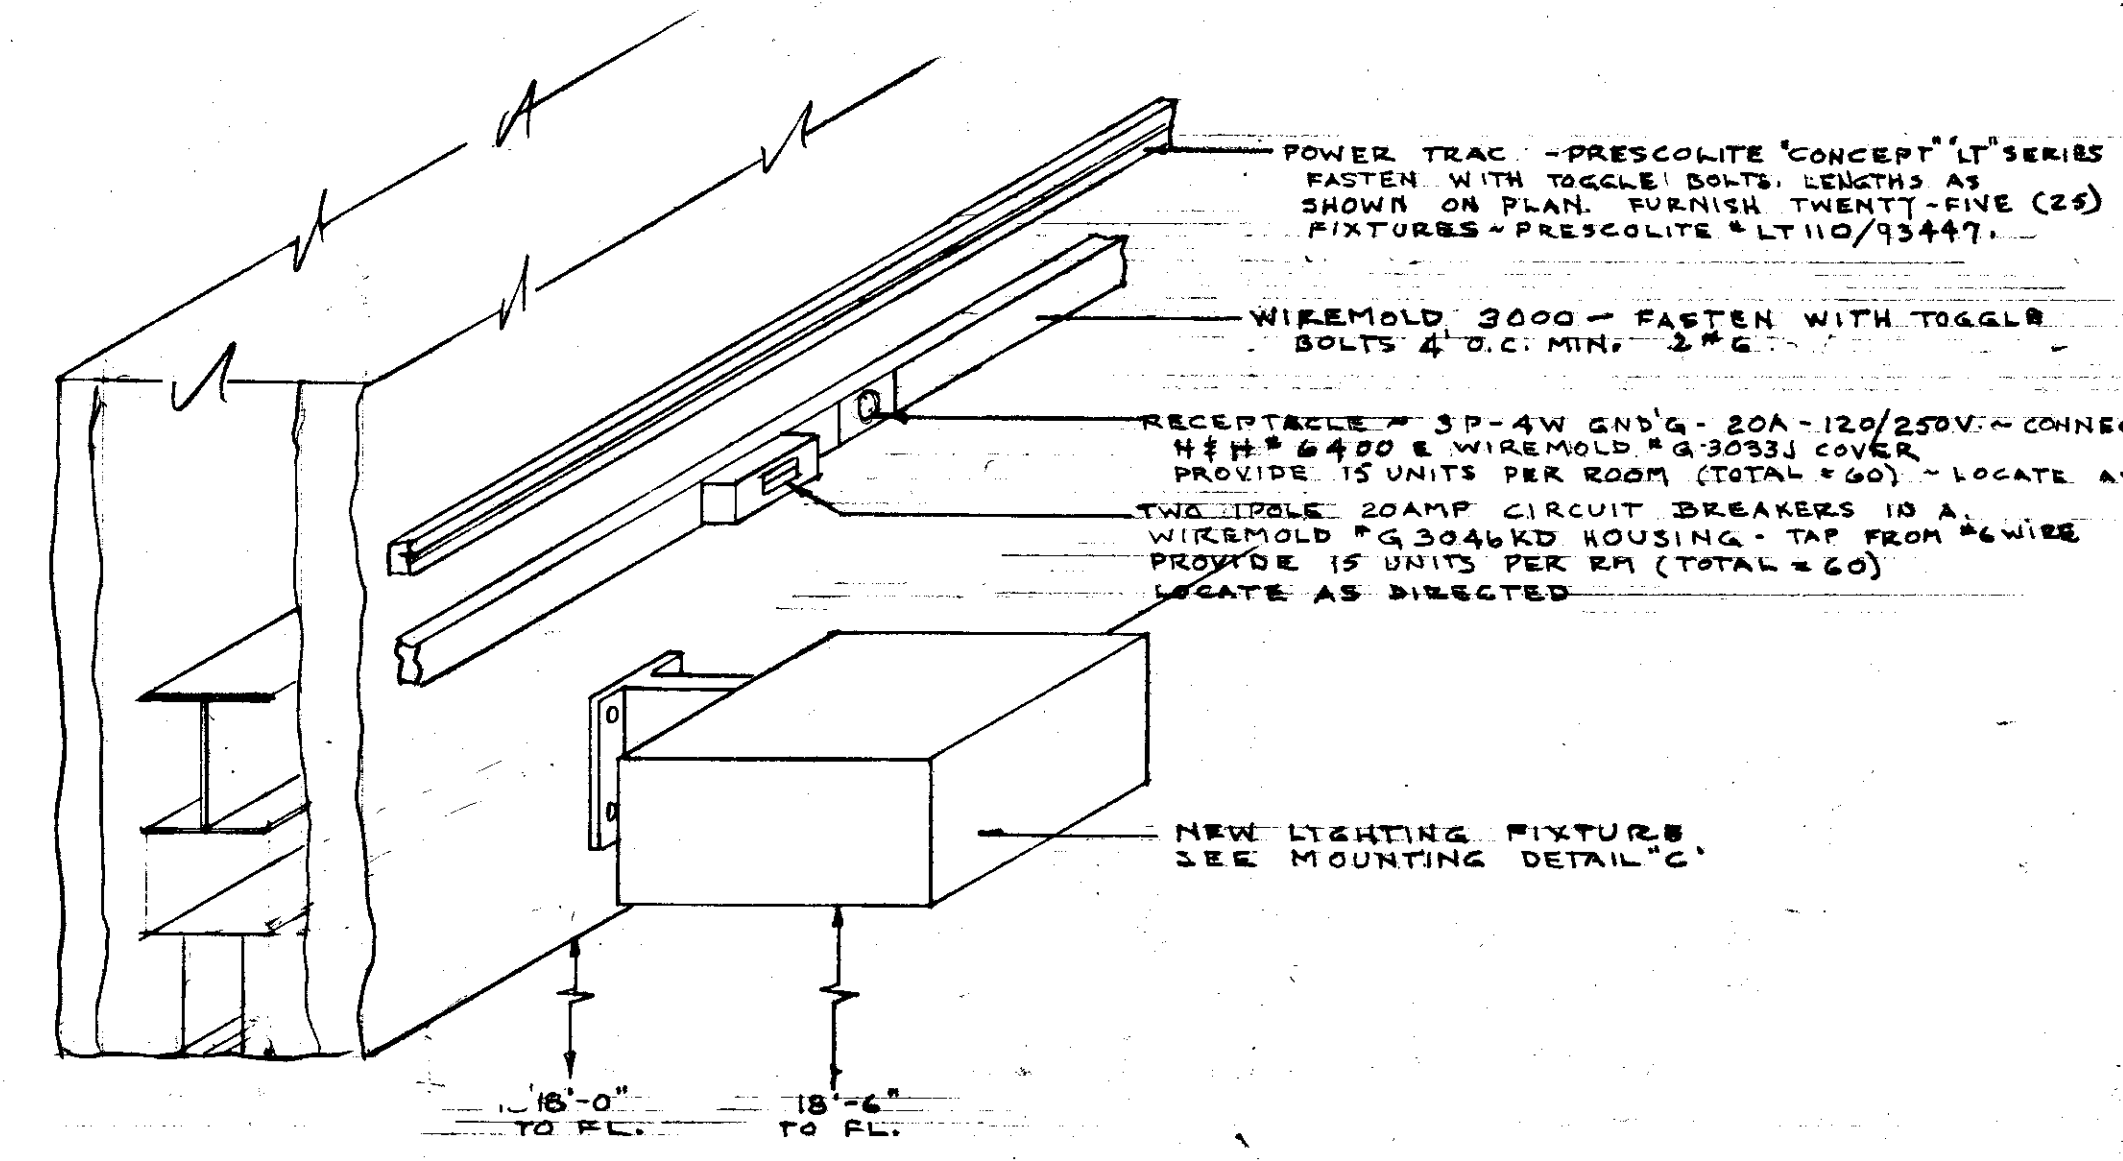


DETAIL "B"

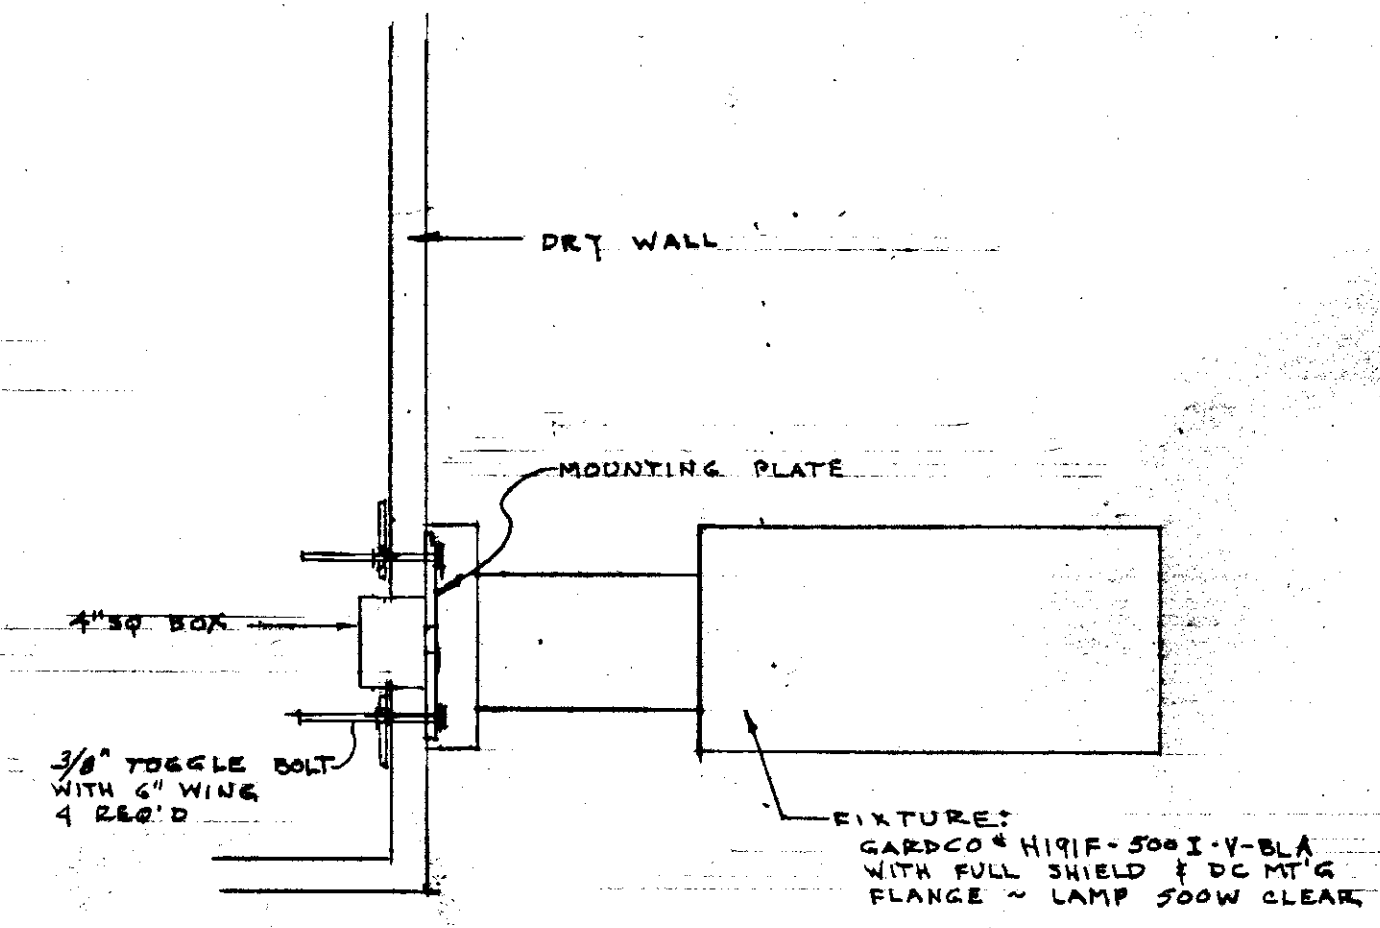

DETAIL "C"

SYMBOL LIST			
SYM.	DESCRIPTION	SYM.	DESCRIPTION
◻	EXISTING MERCURY FIXTURE TO REMAIN	◻	INCANDESCENT FIXTURE - GARDCO #H19IF-500I-V-BLA W/FULL SHIELD & DC MT'G FLANGE - SEE MT'G DETAIL "C"
◻	EXISTING EMERGENCY MERCURY FIXTURE TO REMAIN	◻	EMERGENCY LIGHTING FIXTURE - STONCO #6800B LAMP - 300R/3FL (277V) - MT'G HT. 19"
◻	EXISTING MERCURY FIXTURE TO BE REMOVED & RELOCATED	◻	JUNCTION BOX
◻	RELOCATED MERCURY FIXTURE. SEE SPECIFICATION		
◻	EXISTING AIR DIFFUSER		

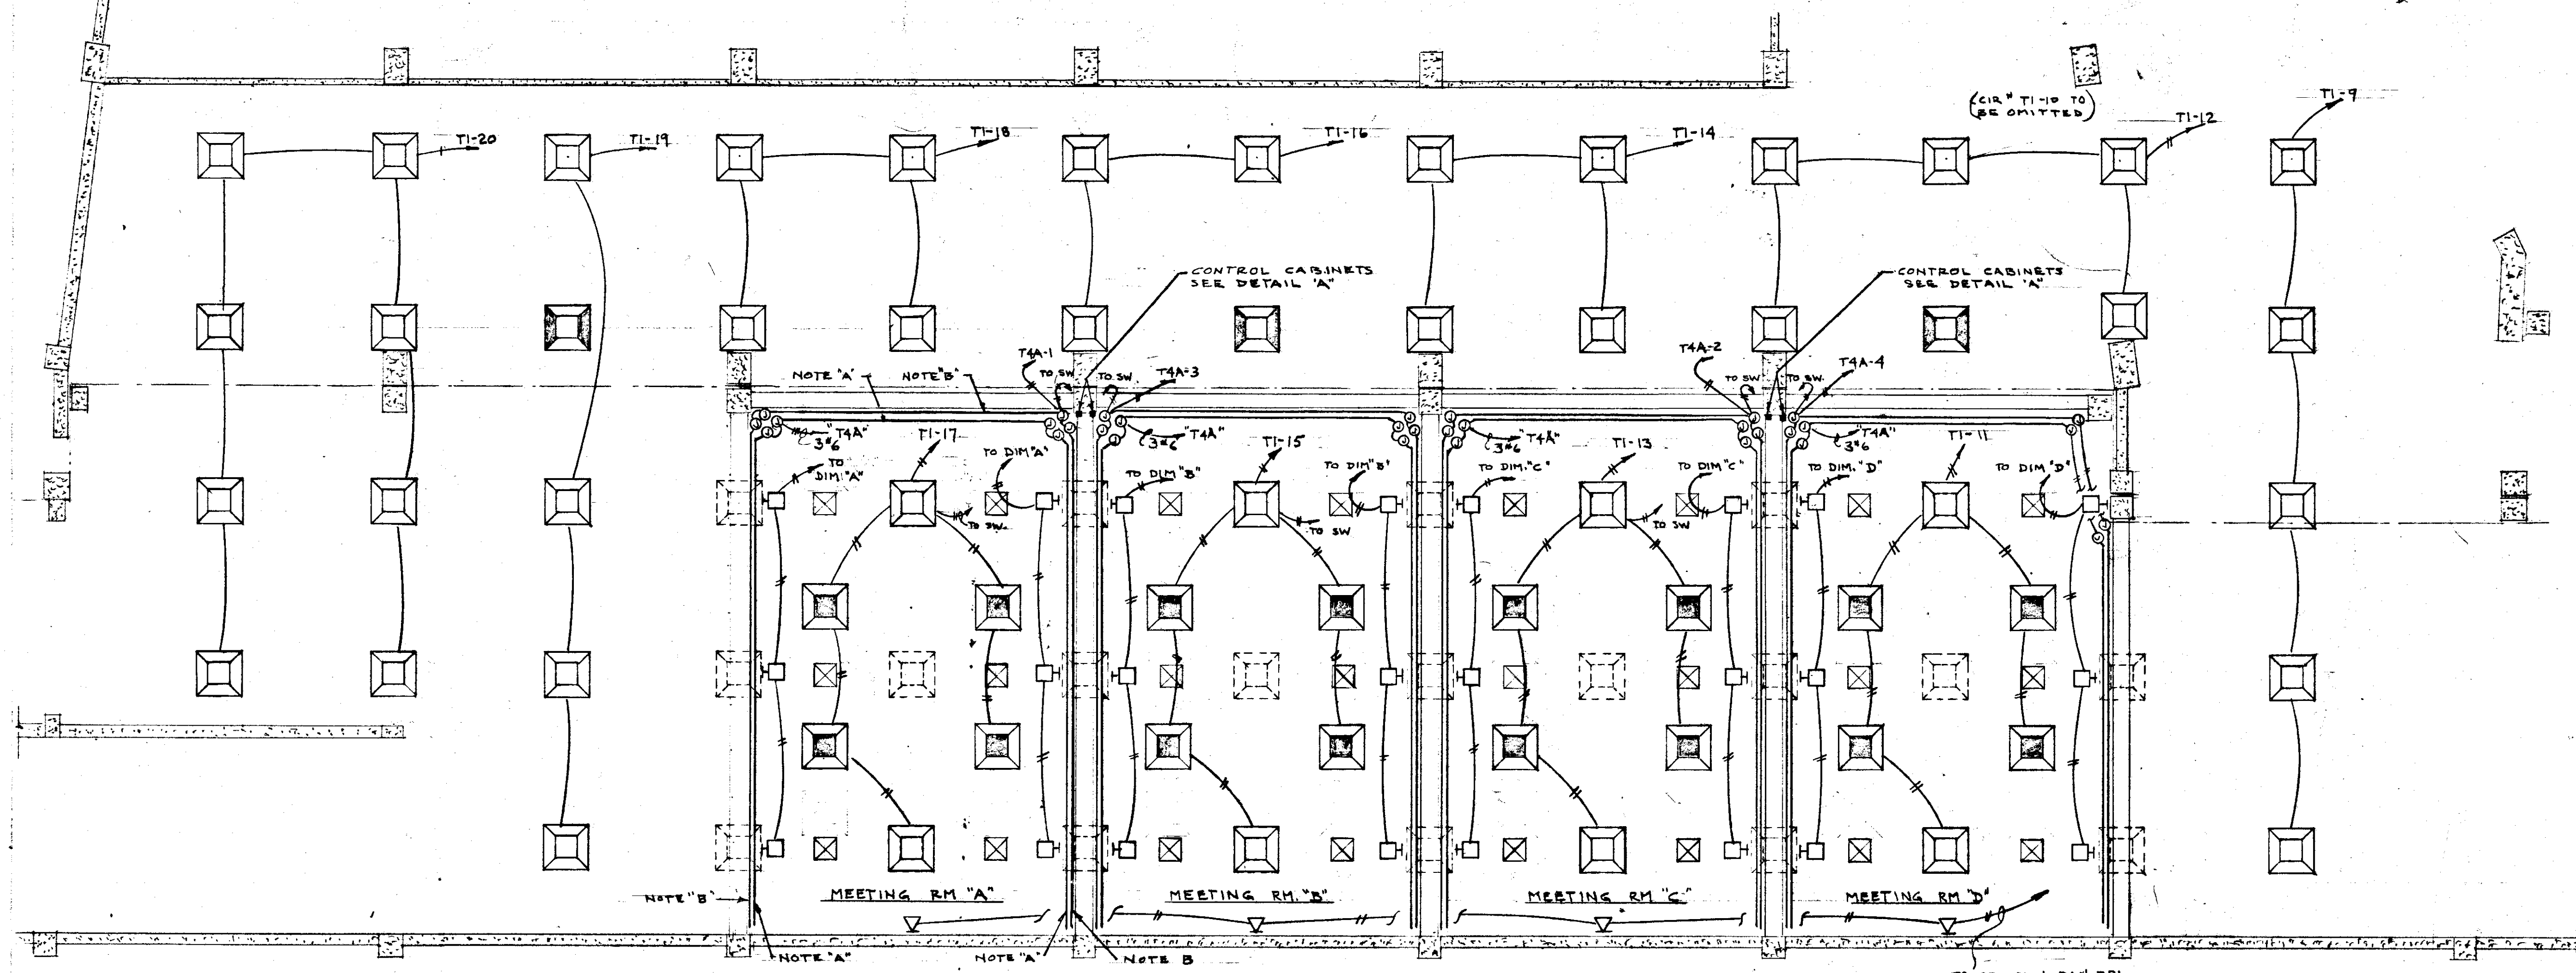

NOTE:
A. WIREMOLD 3000 - SEE DETAIL "B" TYPICAL FOR THE 4 MEETING RMs.
B. POWER TRACT - SEE DETAIL "B" TYPICAL FOR THE 4 MEETING RMs.

PARTIAL FLOOR PLAN ~ EXHIBITION HALL ELEV 31'
SCALE 1/8" = 1'-0"

VERIFY EXISTING CONDITIONS AND DIMENSIONS AT BUILDING		ELECTRICAL	
CITY OF HARTFORD, CONNECTICUT DEPARTMENT OF PUBLIC WORKS BUREAU OF PUBLIC BUILDINGS			
NEW MOVABLE WALLS IN EXHIBITION & ASSEMBLY HALLS CIVIC CENTER HARTFORD, CONN.			
SUBMITTED	RECOMMENDED	APPROVED	
<i>Ed. Bannan</i>	<i>William R. Bannan</i>	<i>George W. Bannan</i>	
DRAWN <i>R.G.B.</i>	SCALE	DAYBOOK NO. 010609F	E-1
CHECKED		DATE MAY 31, 1977	