


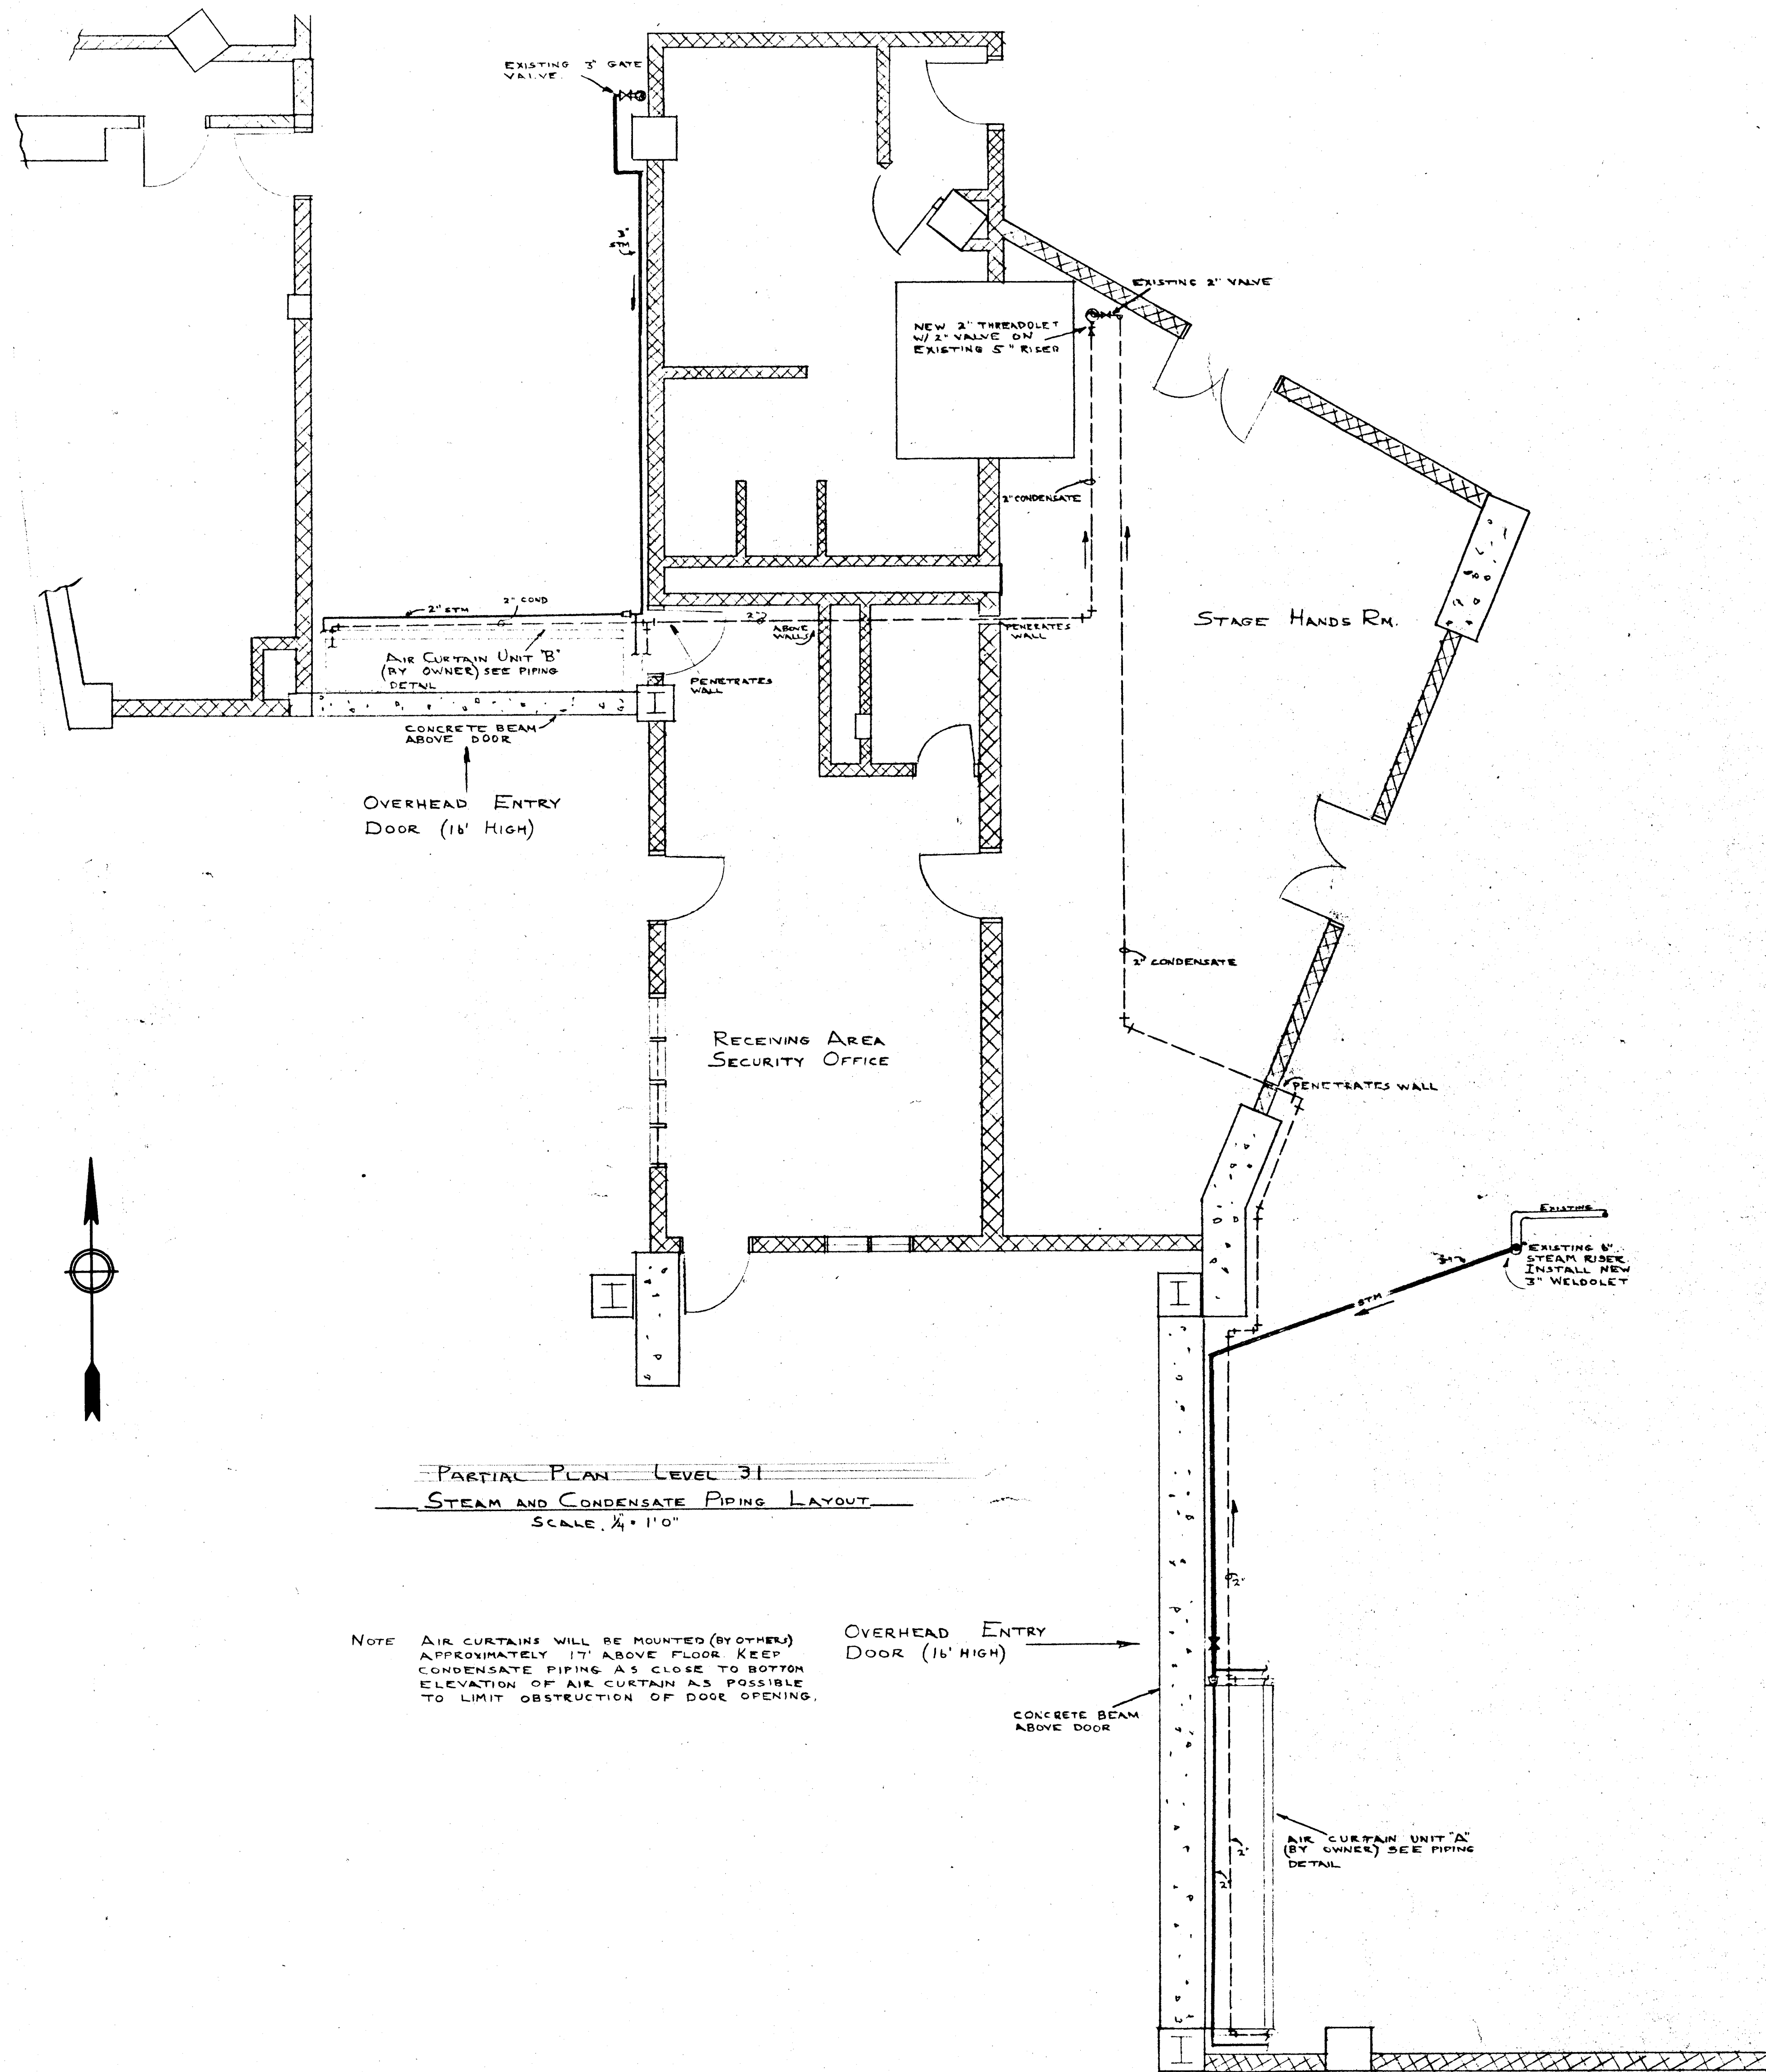


PARTIAL PLAN LEVEL 31
STEAM AND CONDENSATE PIPING LAYOUT
SCALE 1/4" = 1'-0"

NOTE AIR CURTAINS WILL BE MOUNTED (BY OTHERS) APPROXIMATELY 17' ABOVE FLOOR. KEEP CONDENSATE PIPING AS CLOSE TO BOTTOM ELEVATION OF AIR CURTAIN AS POSSIBLE TO LIMIT OBSTRUCTION OF DOOR OPENING.



OVERHEAD ENTRY DOOR (16' HIGH)

CONCRETE BEAM ABOVE DOOR

AIR CURTAIN UNIT "A" (BY OWNER) SEE PIPING DETAIL

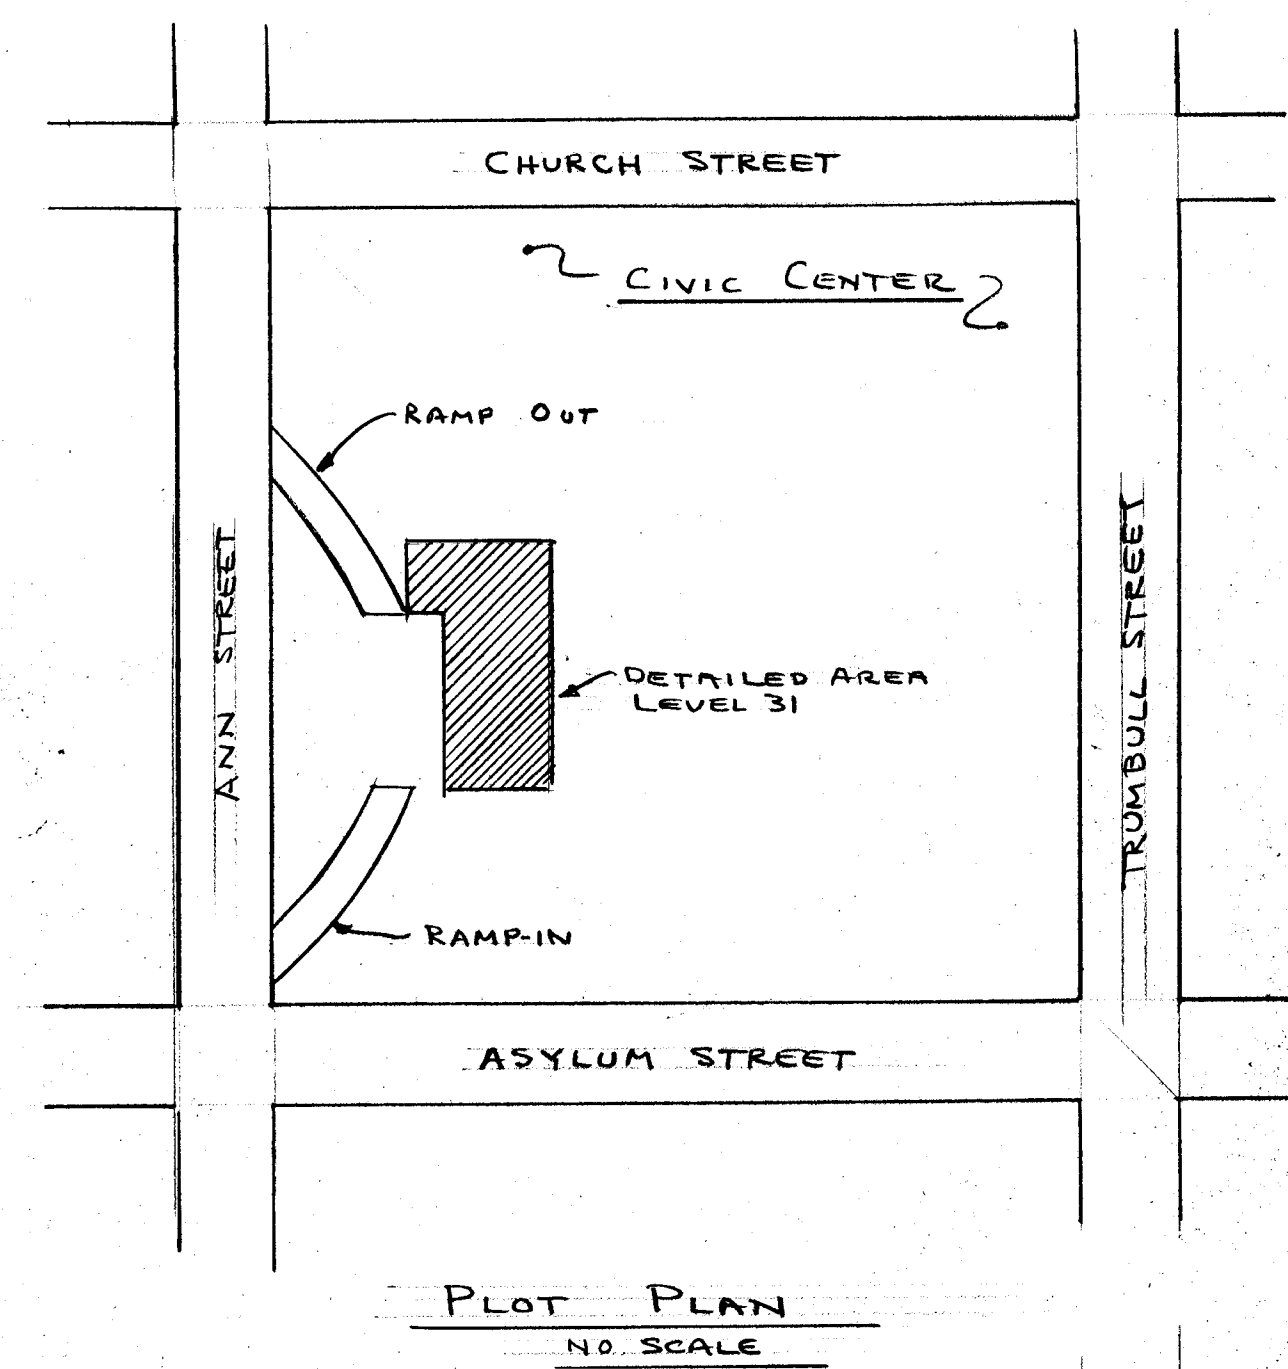

PLOT PLAN
NO. SCALE

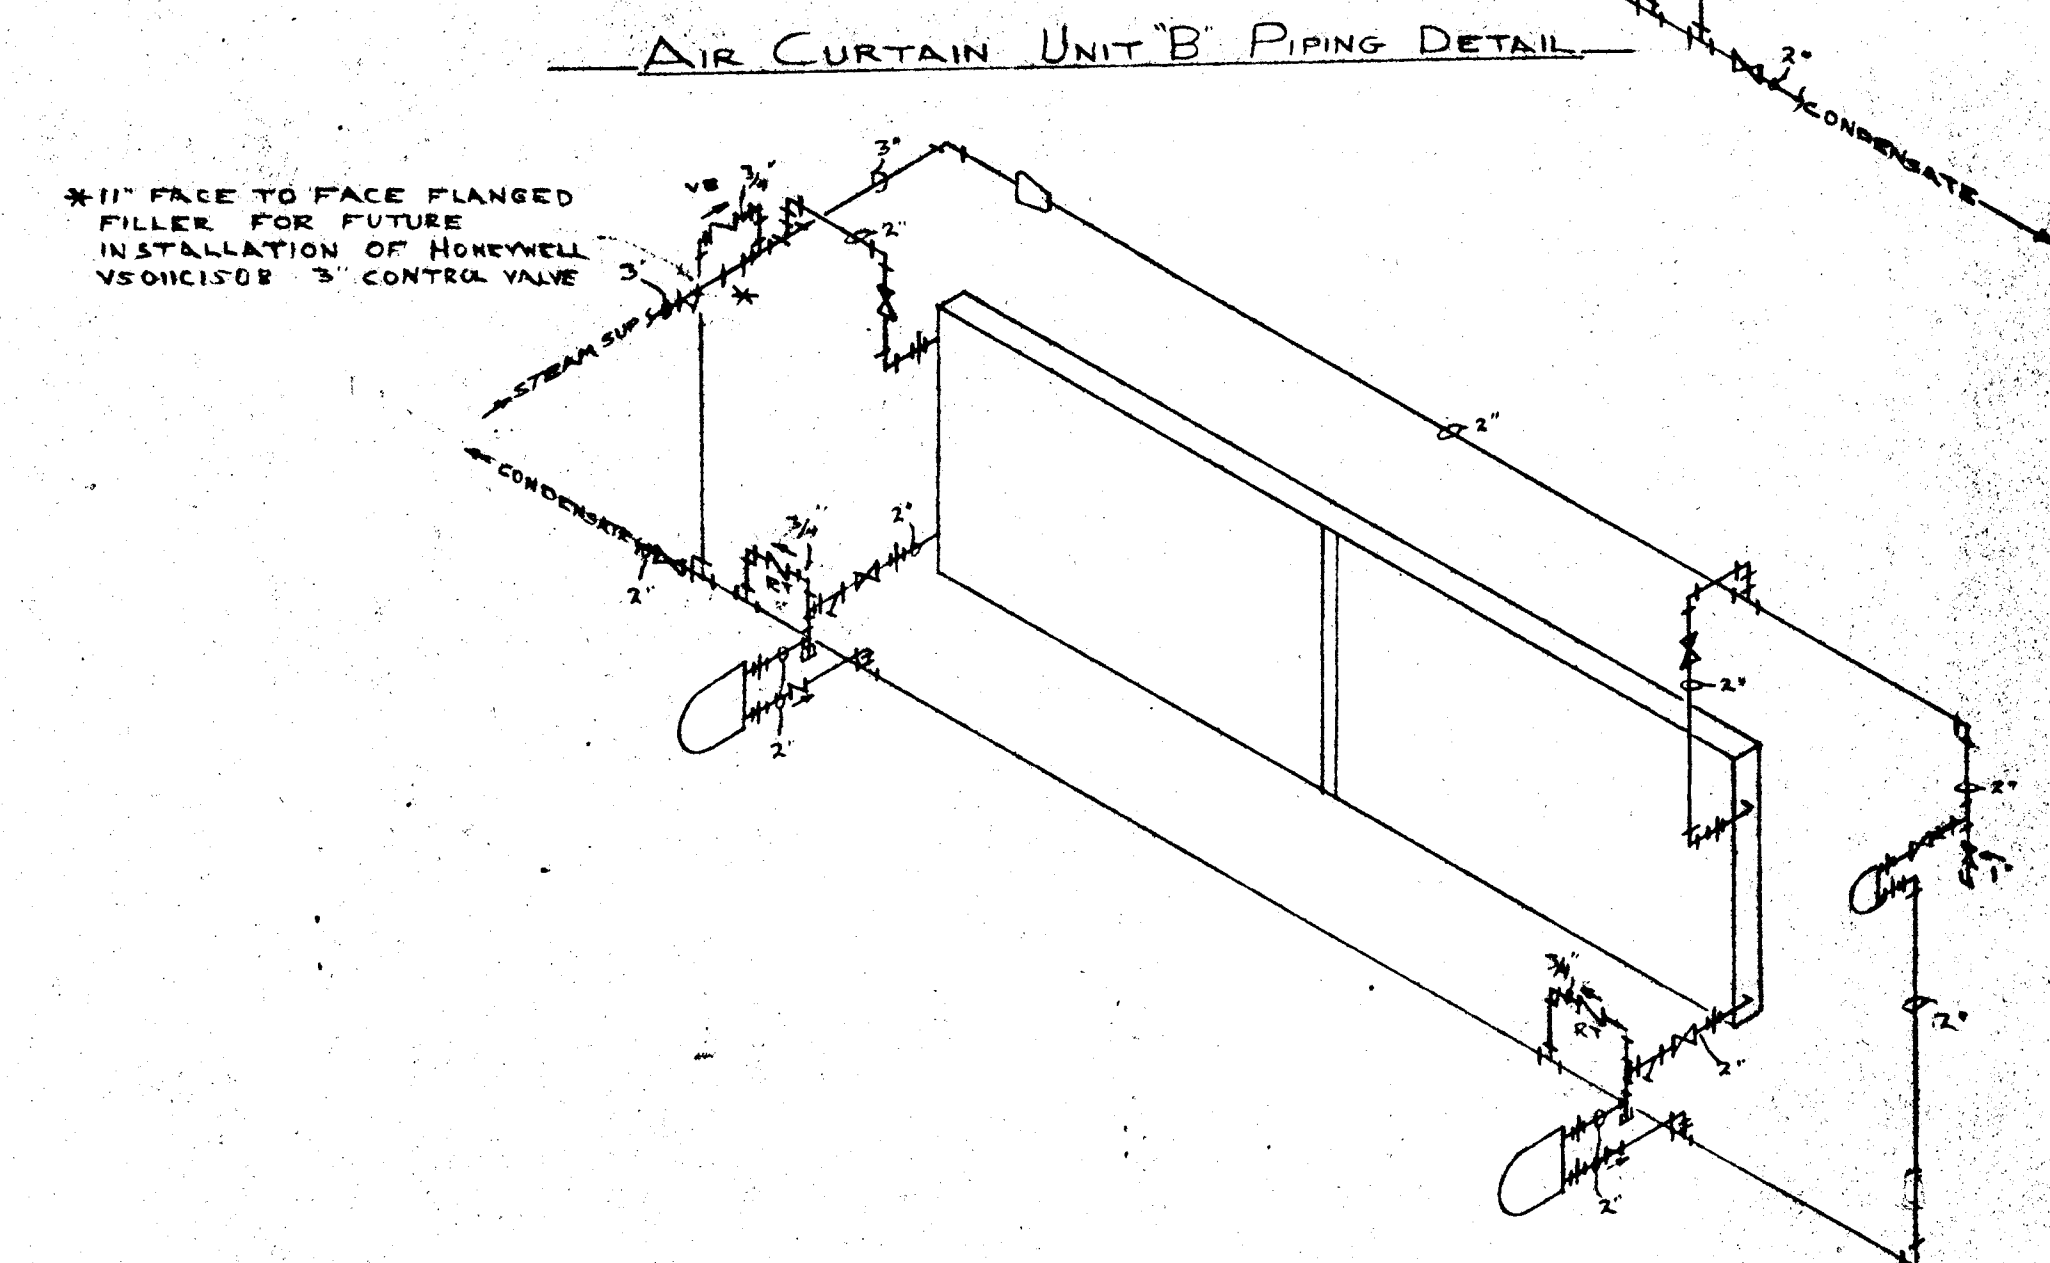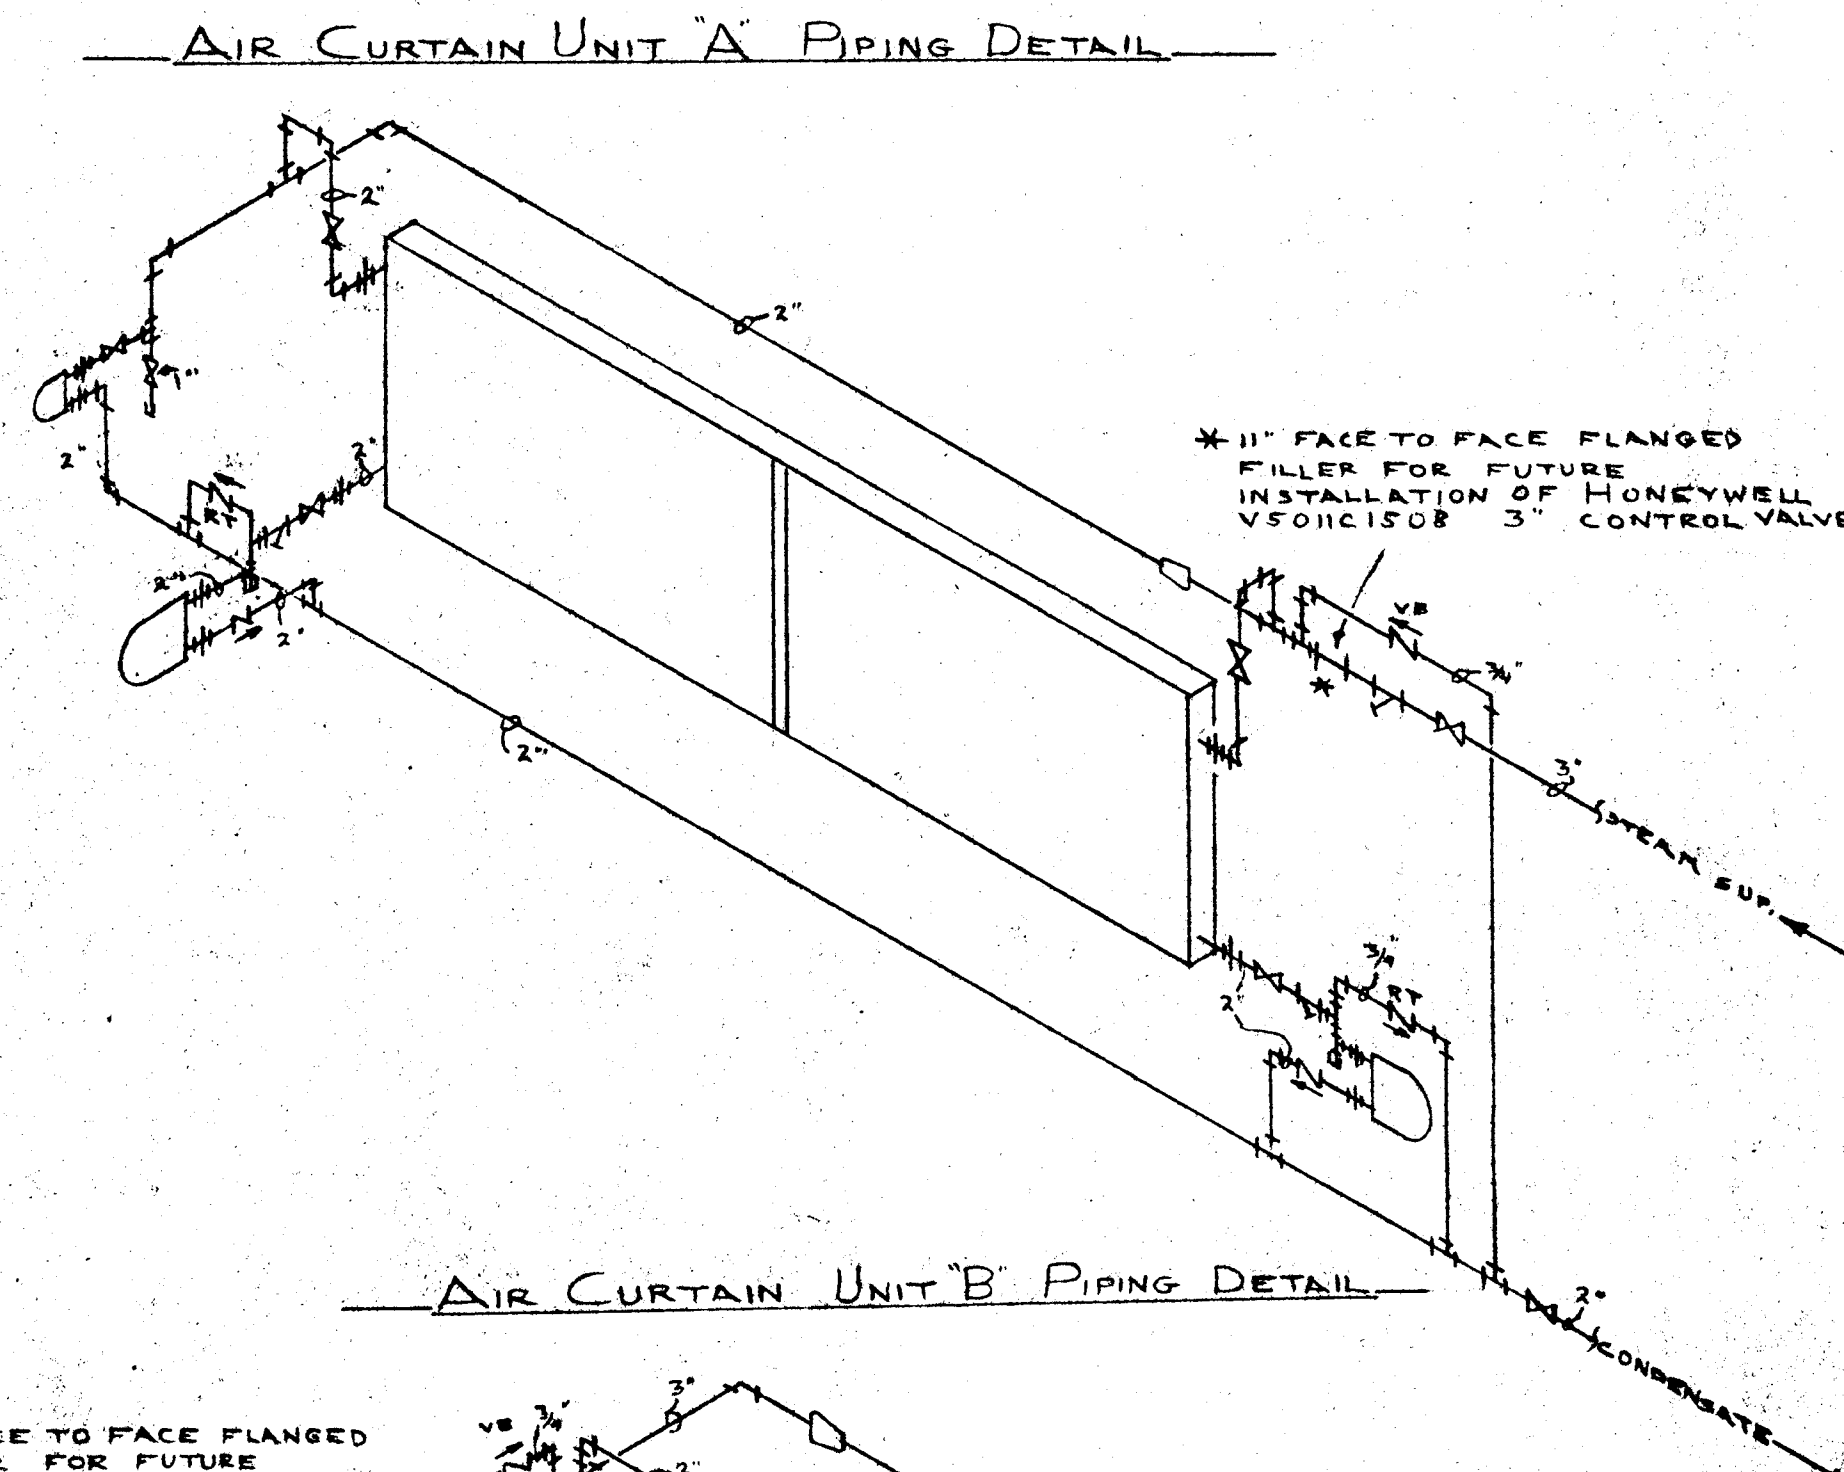

LEGEND

— STH —	STEAM PIPING
— COND —	CONDENSATE PIPING
— TRAP —	RADIATOR TRAP
— VB —	VACUUM BREAKER
— CV —	CHECK VALVE
— U —	UNION
— R —	REDUCER
— GV —	GATE VALVE
— S —	STRAINER

STEAM PIPING FOR AIR CURTAINS AT THE HARTFORD CIVIC CENTER TRUMBULL STREET, HARTFORD CT

Walter R. Reed *George F. Hoffman*

C.T. P.D.P. AS NOTED 010614-A

AUG. 10 1977

M-1