

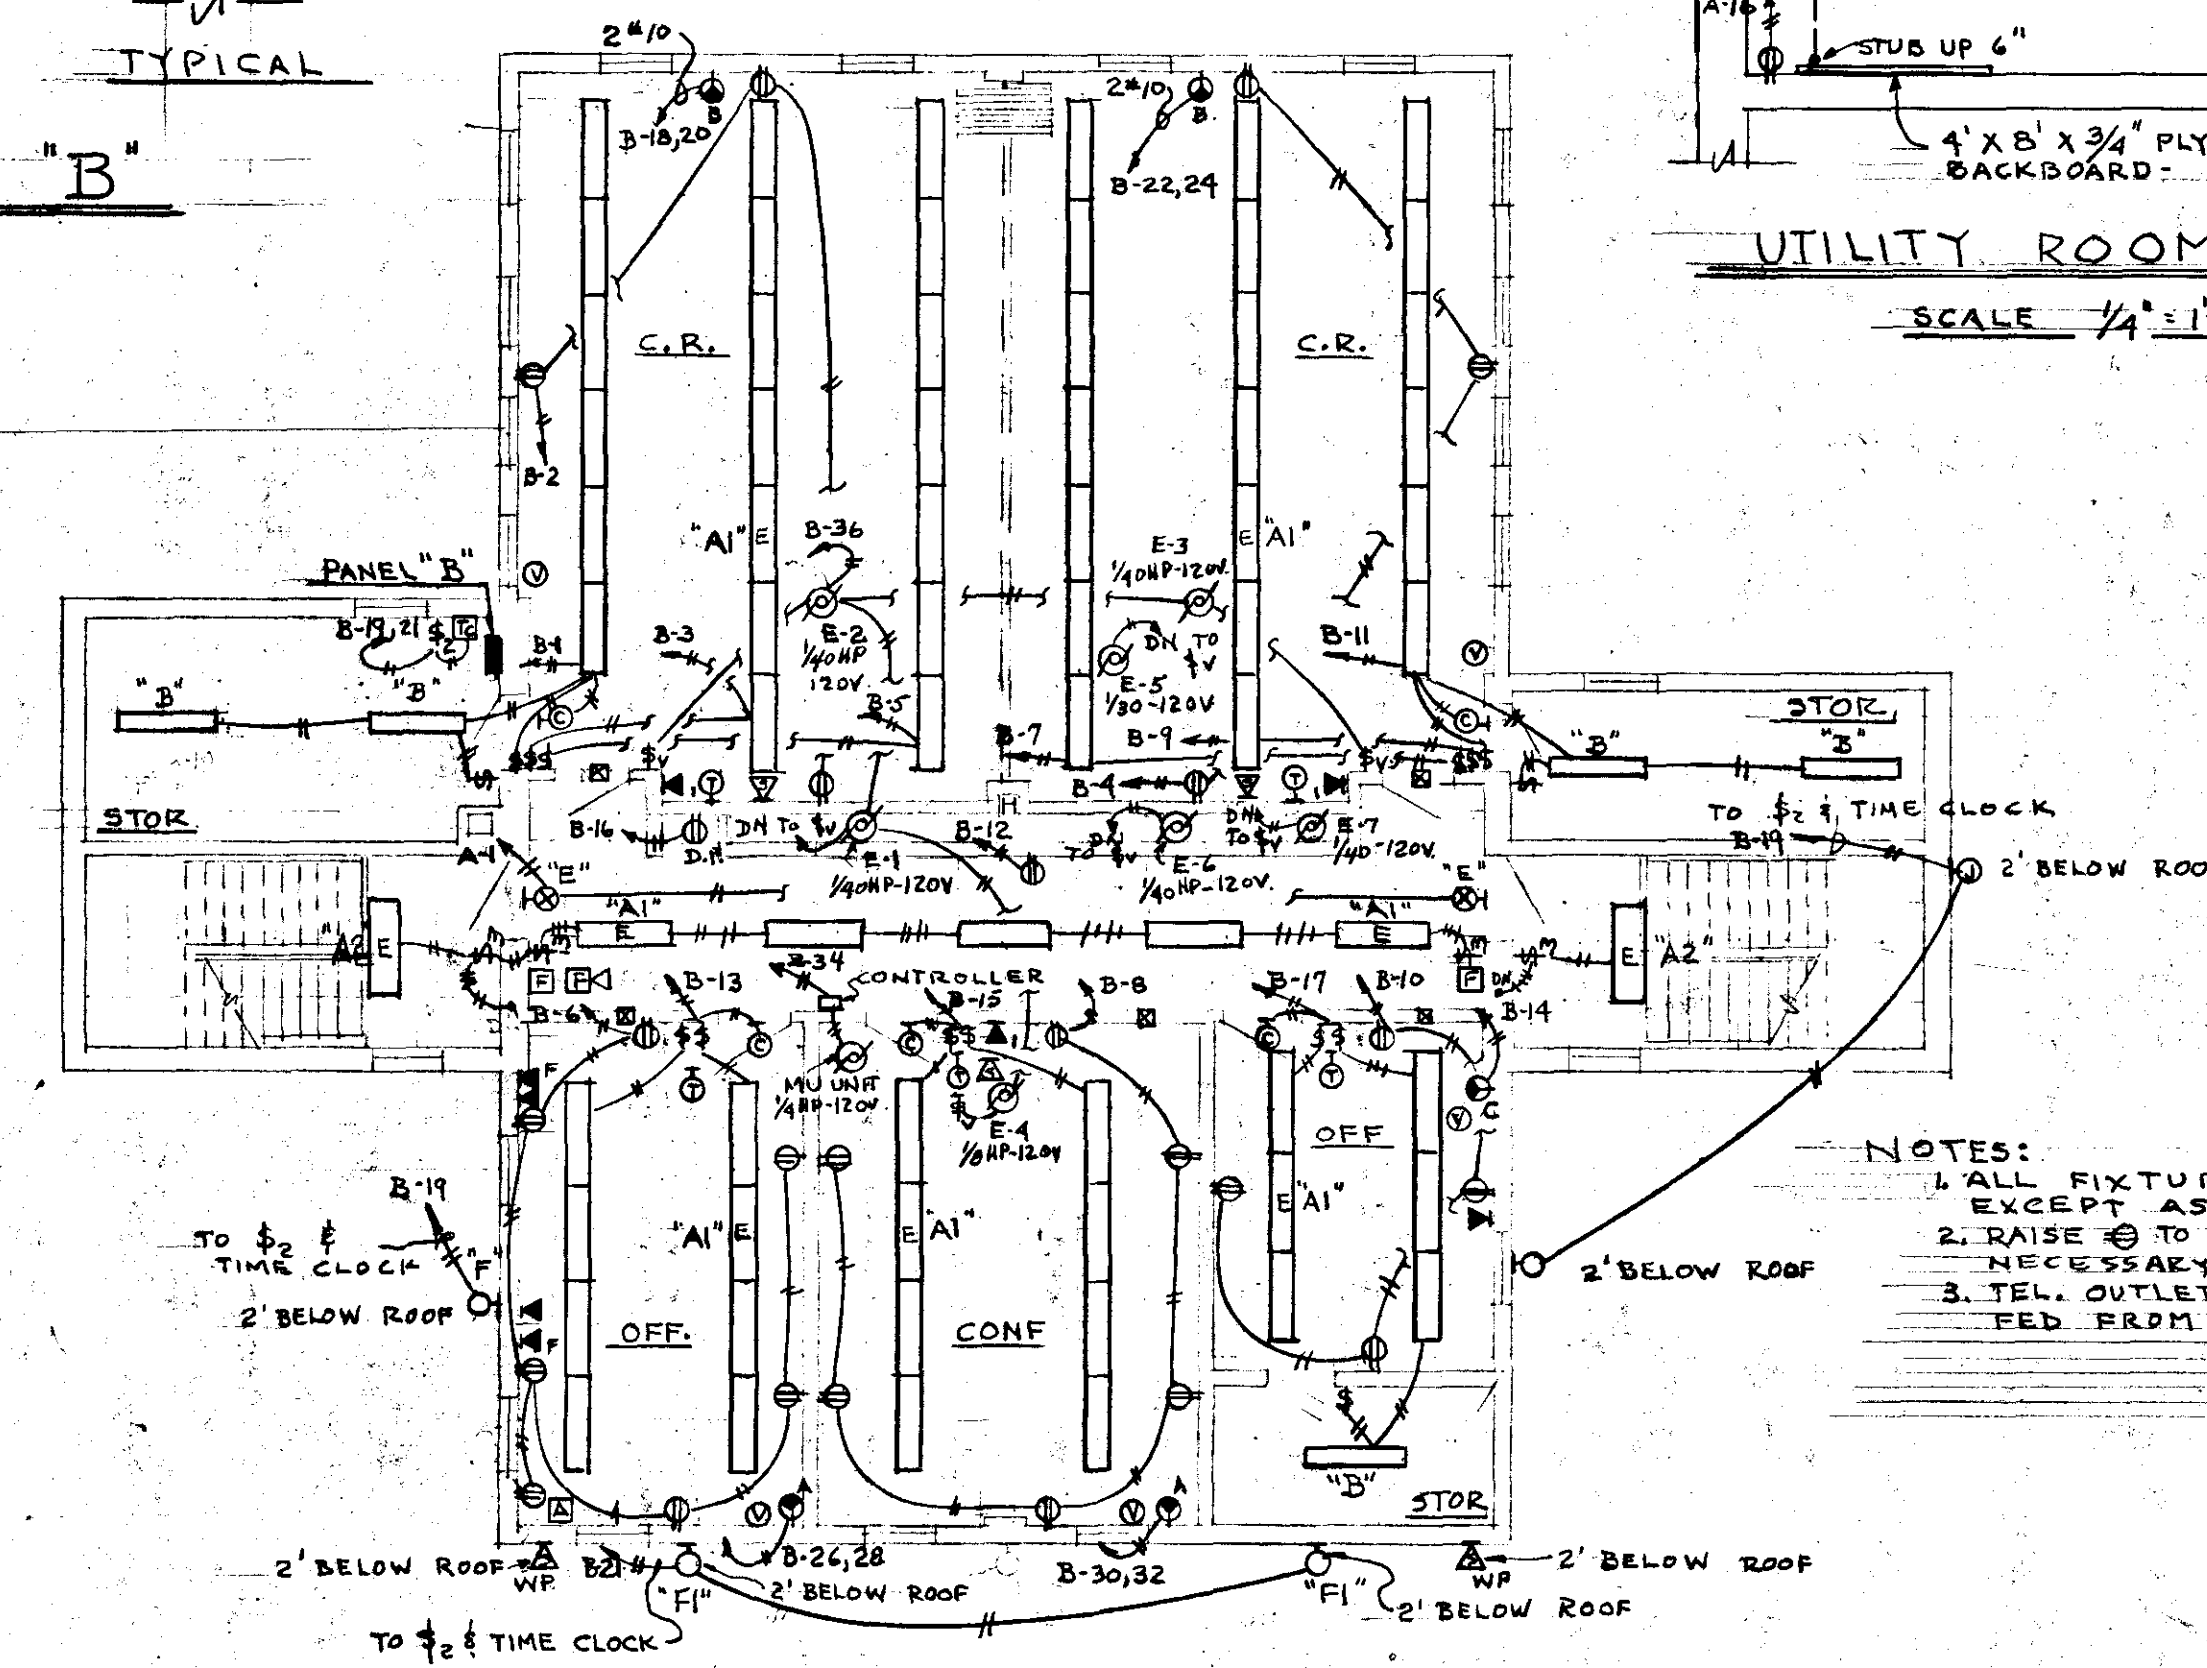


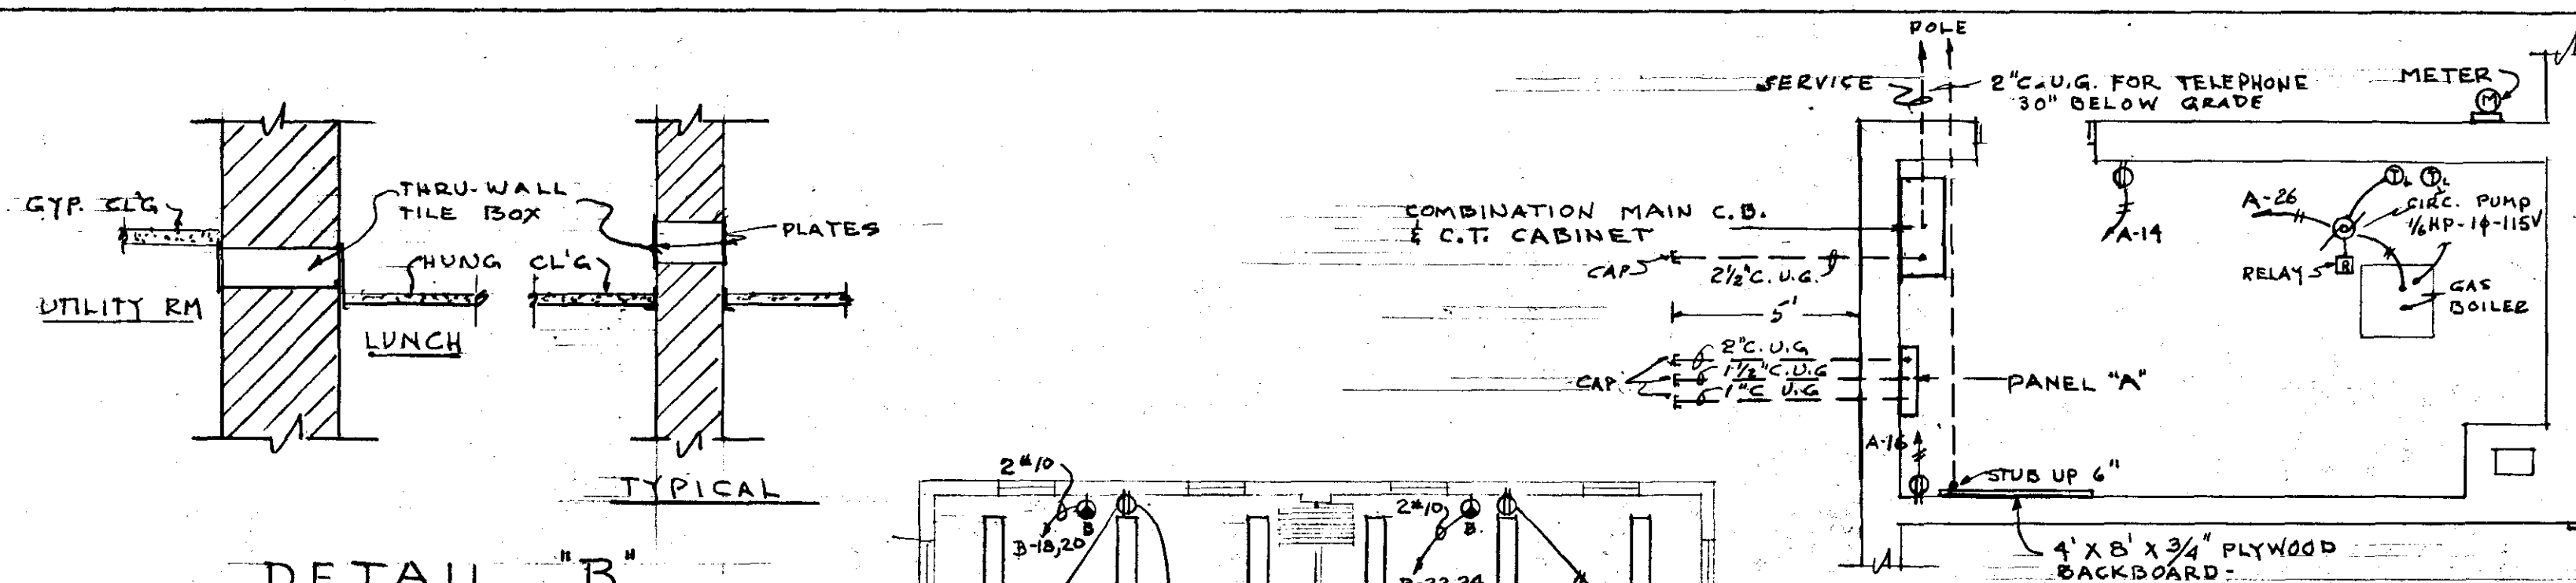





TYPE	MANUFACTURER & CATALOG NO	LAMPS	REMARKS
A	LITHONIA *HL240M	2 - F40 CW.	SURFACE MT'D
A1	LITHONIA *HL240MEL	2 - F40 CW.	" " " " W/ EMERG. LT'G UNIT.
A2	LITHONIA *HL440MEL	4 - F40 CW	" " " " " "
B	LITHONIA *C240	2 - F40 CW	" " " " " "
C	GARDCO *K940B/10-240RS	2 - F40 CW	" " " " " "
D	STONCO *6800R-W/#6741B & 671B	150W R40 FL'D.	WALL MT'D ~ UP 8'-3"
E	LITHONIA *ESIREL	AS REQ'D.	WALL MT'D OVER DOOR ~ W/ EMERG. UNIT.
F	WIDE-LITE *BL-250S-CWRB-LX	250W. HP SODIUM	WALL MT'D ~ W/ *AL-25-B AUX LENS.
F1	WIDE-LITE *BL-400-AWRB-LX-MF4	400 W. HP SODIUM	WALL MT'D ~ W/ W/B-1 WALL BRACKET ~ W/ *AL-4-B AUX LENS.

SYMBOL	DESCRIPTION	SYMBOL	DESCRIPTION
[Symbol]	FLUORESCENT FIXTURE	[Symbol]	TELEPHONE OUTLET ~ UP 18" ~ SEE DETAIL "A"
[Symbol]	FLUORESCENT FIXTURE W/ EMERG. LT'G UNIT.	[Symbol]	" " " " UP 5'-0" " " " "
[Symbol]	CEILING OUTLET	[Symbol]	" " " " FOR FIRE DEPT ~ UP 18" ~
[Symbol]	WALL BRACKET	[Symbol]	" " " " ~ UP 5'-0" ~
[Symbol]	JUNCTION BOX ~ 4" SQ.	[Symbol]	INTERCOM MASTER STATION ~ TELETALK *A2712
[Symbol]	CLOCK OUTLET ~ H/H *570B ~ UP 8'-0"	[Symbol]	WALL SPEAKER ~ TELETALK *4H45 ~ UP 8'-0"
[Symbol]	EXIT LIGHT	[Symbol]	EXTERIOR SPEAKER ~ ATLAS *AP-30PT ~ WALL MT'D
[Symbol]	DUPLEX CONV. OUTLET ~ H/H *5262 ~ UP 18" OR 24"	[Symbol]	AQUASTAT - NOTE #1
[Symbol]	15A/230V OUTLET FOR A/C ~ H/H *5661 ~ UP 7'-0"	[Symbol]	FIRE ALARM STA. ~ SIMPLEX *4251-22 ~ UP 5'-0"
[Symbol]	30A/230V OUTLET FOR A/C ~ H/H *5700 ~ UP 7'-0"	[Symbol]	FIRE ALARM HORN & LT. ~ SIMPLEX *4051-60 ~ UP 7'-0"
[Symbol]	15A/115V OUTLET FOR A/C ~ H/H *5261 ~ UP 7'-0"	[Symbol]	HEAT DETECTOR ~ SIMPLEX *4272-200 ~ CEILING MT'D
[Symbol]	THRU-WALL TILE BOX W/ BLANK PLATES - SEE DETAIL "B"	[Symbol]	MOTORIZED VALVE (LOW VOLTAGE) ~ NOTE #1 ~ SEE H-V PLANS
[Symbol]	SINGLE POLE SW. ~ H/H *1891 ~ UP 4'-0"	[Symbol]	MOTOR SPEED CONTROL SW. ~ NOTE #2 ~ UP 5'-0"
[Symbol]	DOUBLE POLE SW. ~ H/H *1542 ~ UP 5'-0"	[Symbol]	MOTOR ~ NOTE #1
[Symbol]	3-WAY SW. ~ H/H *1893 ~ UP 4'-0"	[Symbol]	THERMOSTAT - LOW VOLTAGE ~ NOTE #2 ~ UP 5'-0"
[Symbol]	TIME CLOCK ~ TORK *7200ZL ~ UP 5'-0"	[Symbol]	THERMOSTAT - LINE VOLTAGE ~ NOTE #2 ~ UP 5'-0"
[Symbol]	PANELBOARD ~ UP 6'-6" TO TOP	[Symbol]	CONTROL TRANSFORMER FOR L.V. T'STAT ~ NOTE #2

NOTES:
1. FURNISHED & INSTALLED BY OTHERS; WIRED BY THIS ELECTRICAL CONTRACTOR.
2. FURNISHED BY OTHERS; INSTALLED & WIRED BY THIS ELECTRICAL CONTRACTOR.

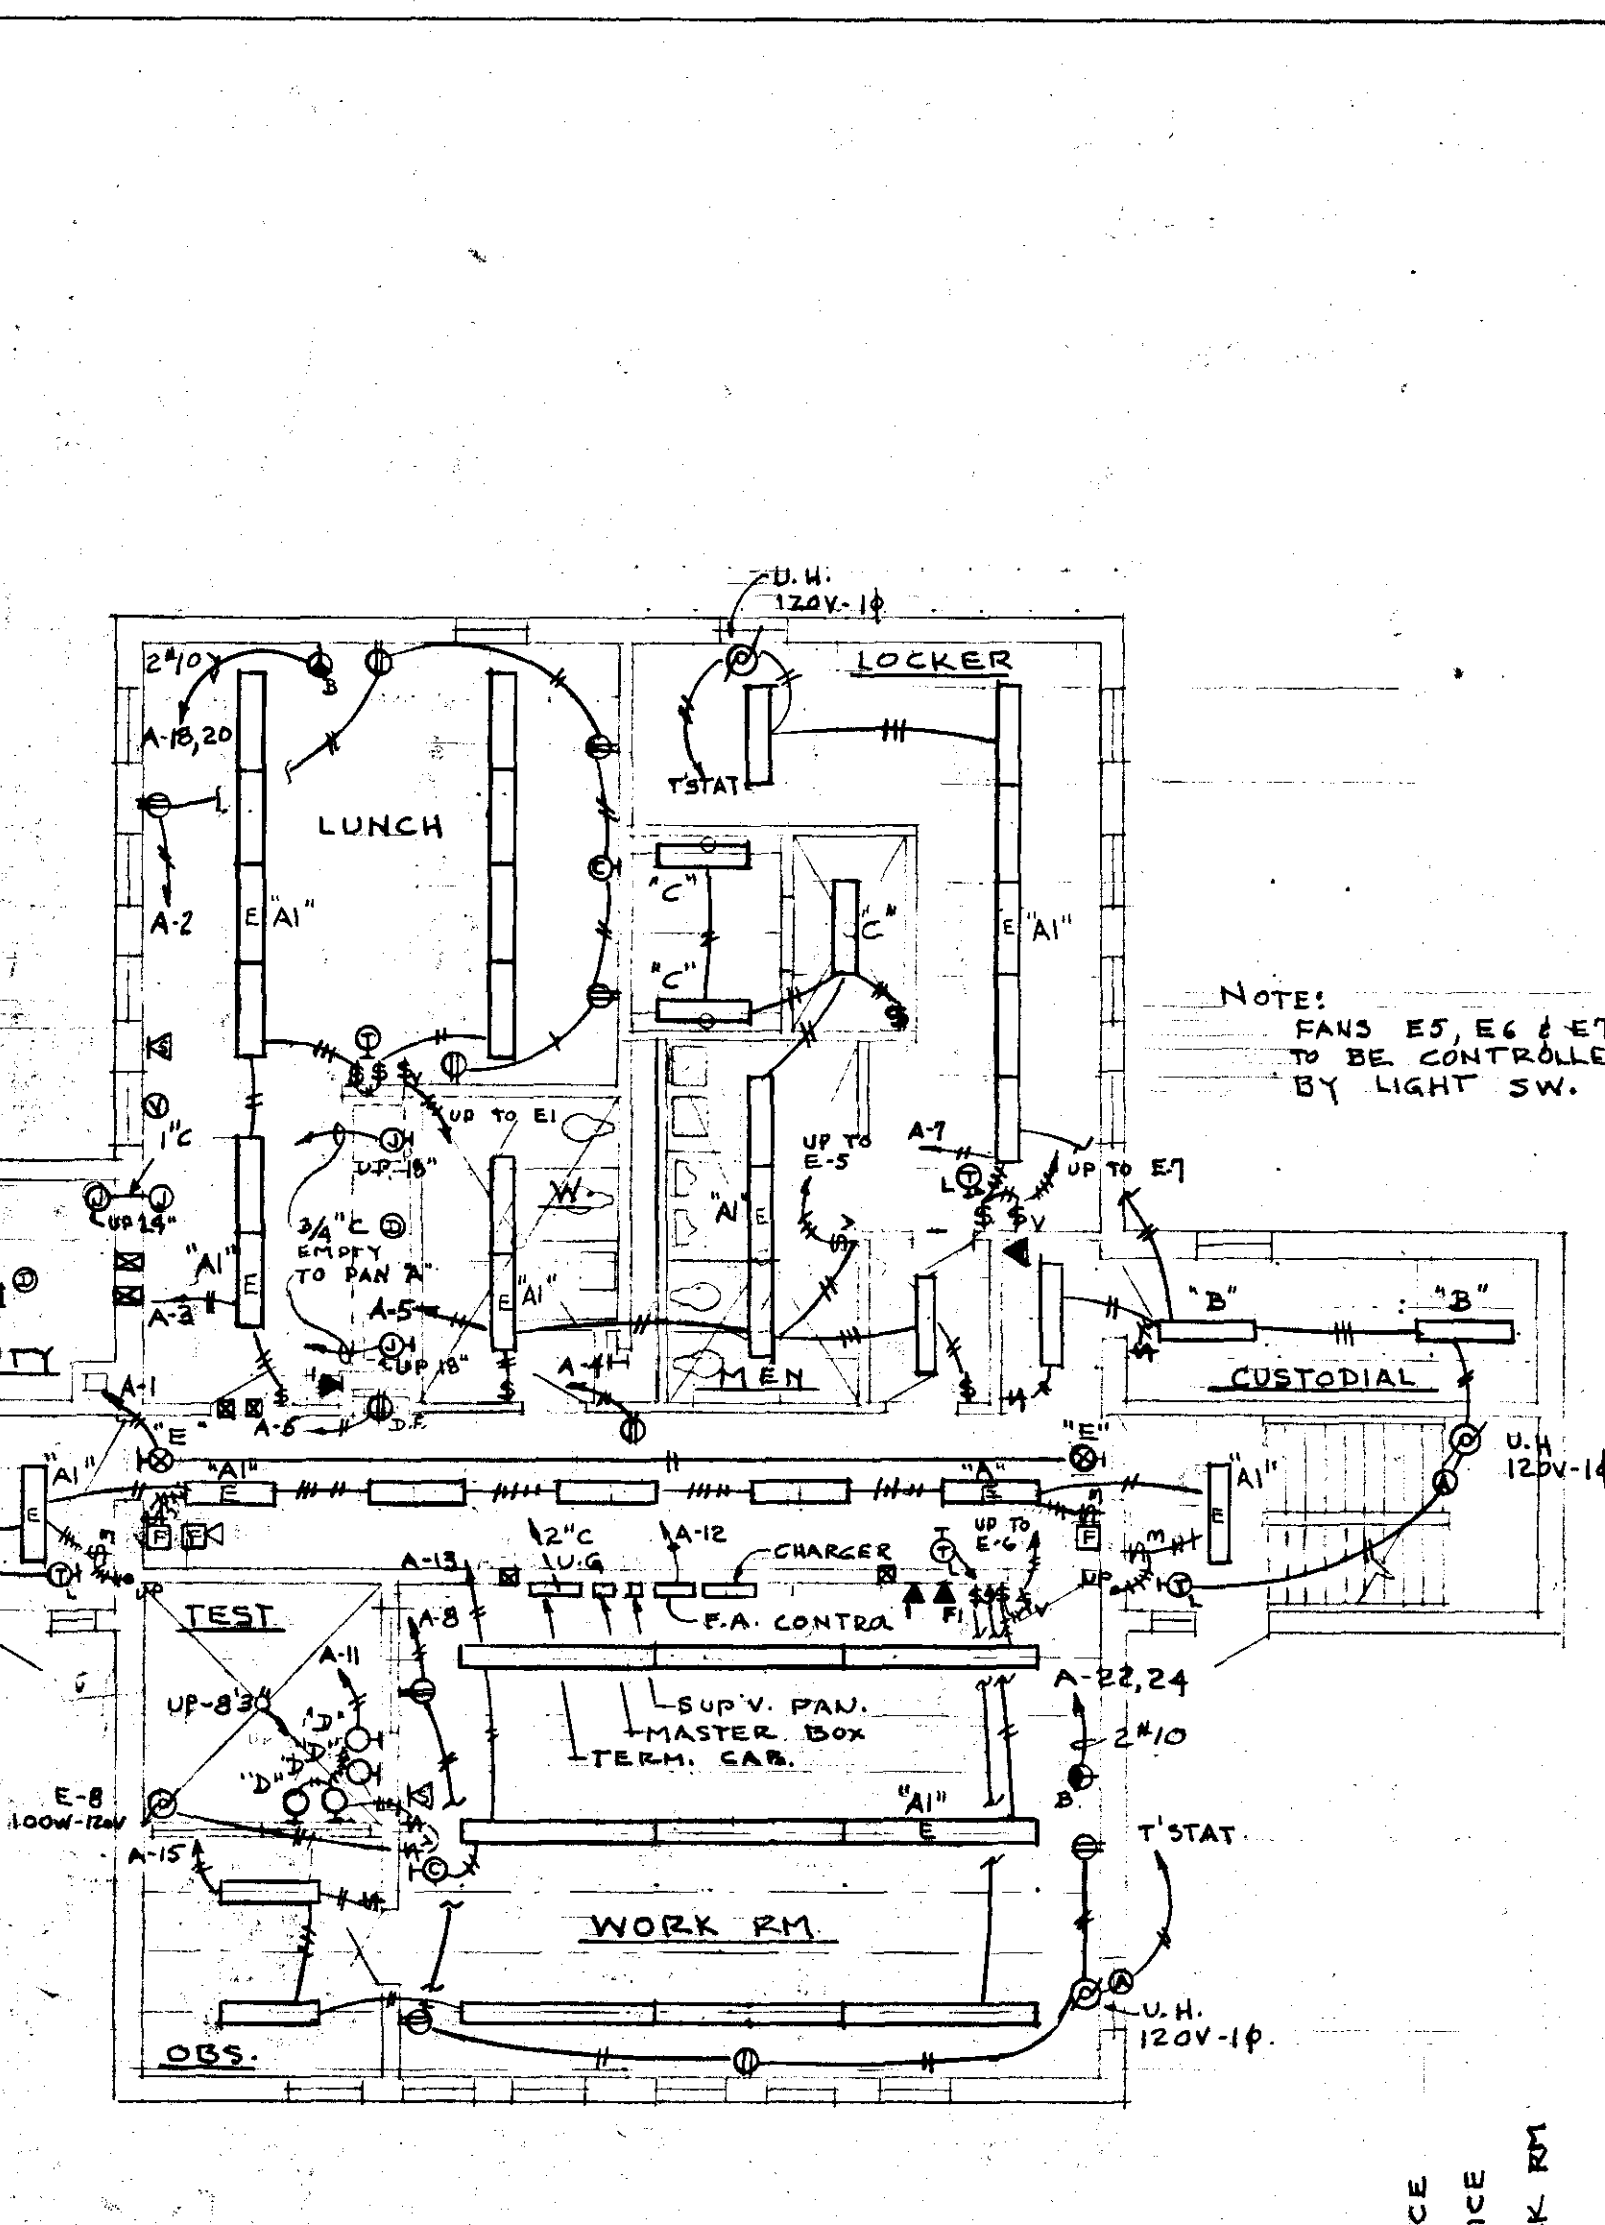

FIRST FLOOR PLAN
SCALE 1/8" = 1'-0"

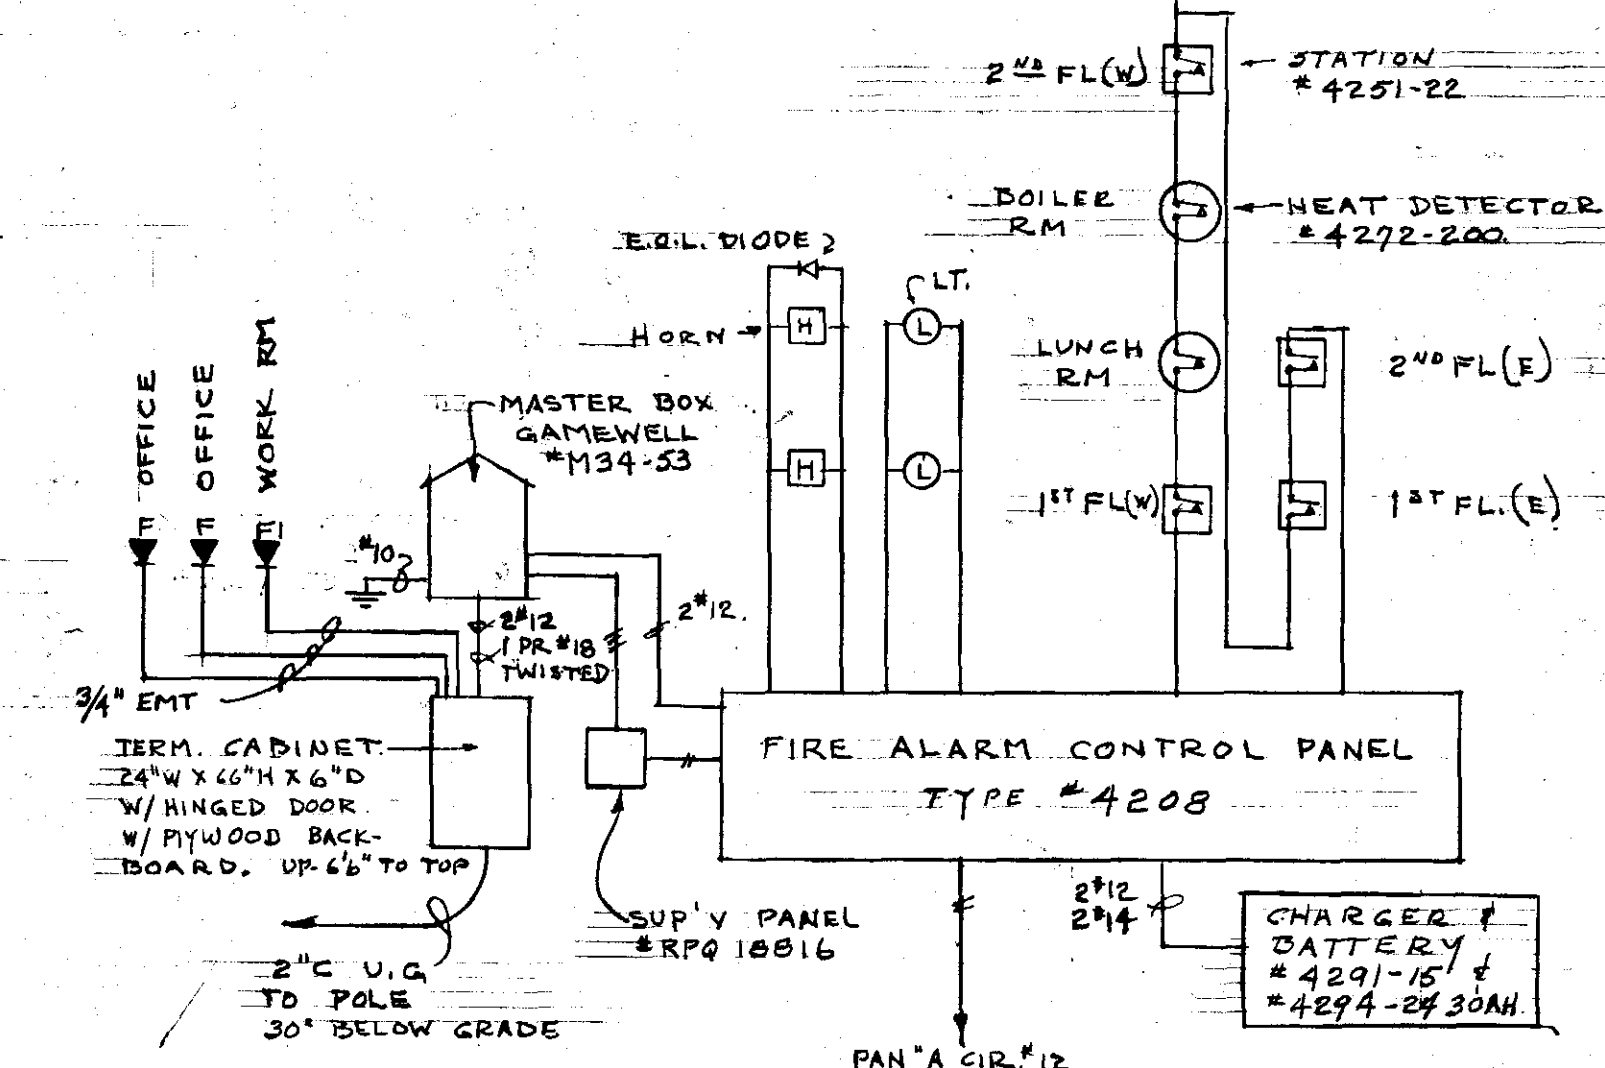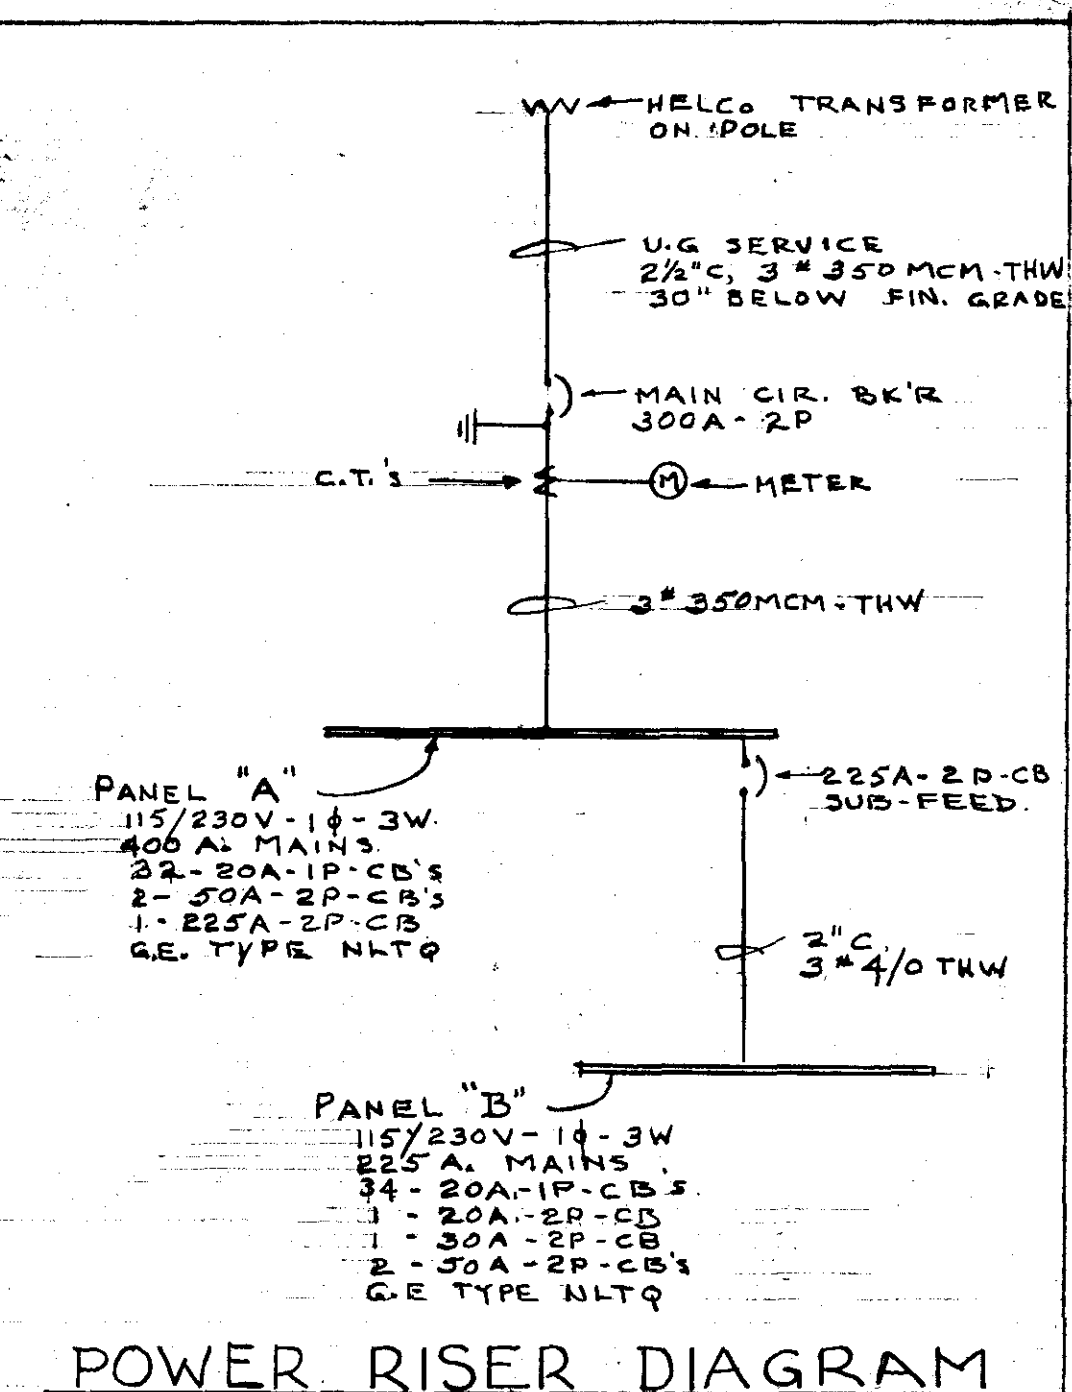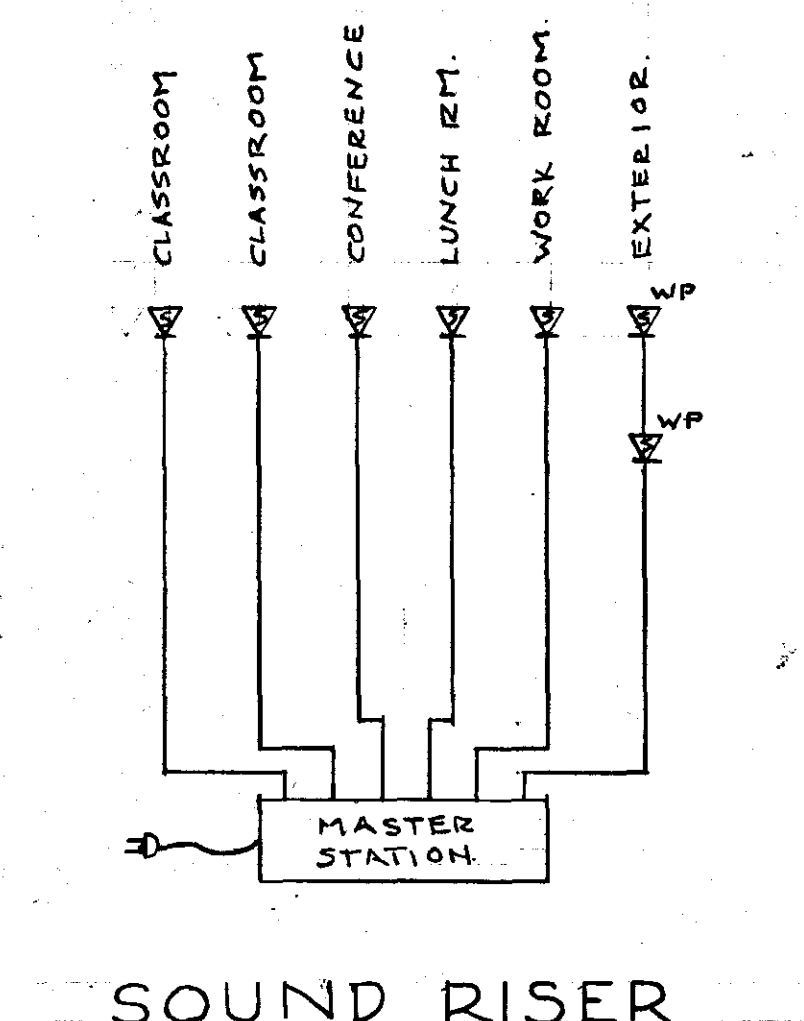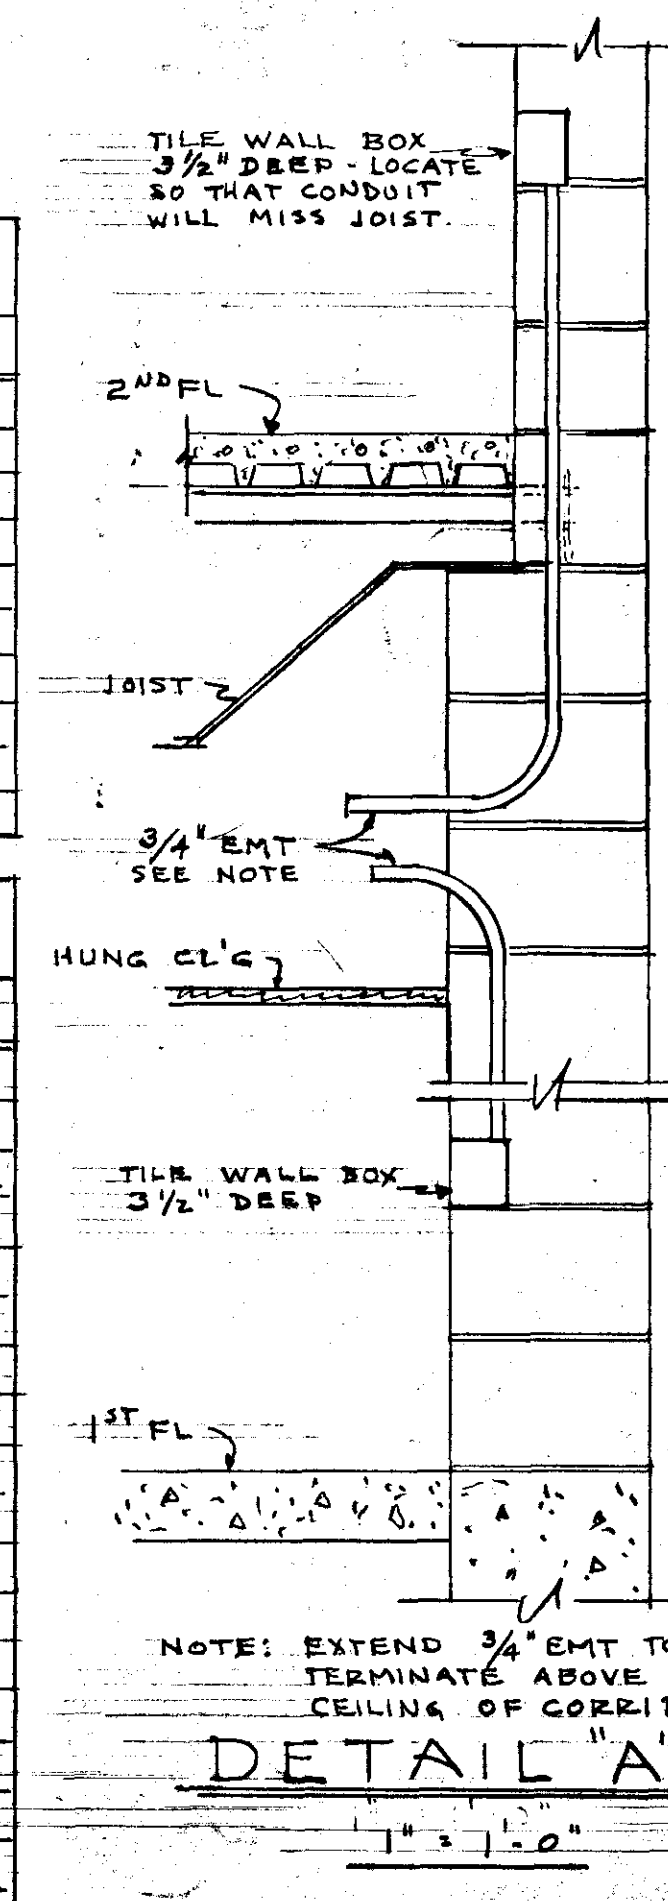

FIRE ALARM RISER DIAGRAM

CITY OF HARTFORD, CONNECTICUT
DEPARTMENT OF PUBLIC WORKS
BUREAU OF PUBLIC BUILDINGS

FIRE SAFETY TRAINING FACILITY
INCINERATOR ROAD
HARTFORD, CONNECTICUT

DRAWING
E
1

SUBMITTED: [Signature]
RECOMMENDED: [Signature]
APPROVED: [Signature]

DRAWN: R.G.B.
SCALE: AS SHOWN
DAYBOOK NO. 010524-K
CHECKED: [Signature]
DATE: SEP. 3, 1975