



NOTES:

- "A" ROOF DRAIN WILL BE SET AND FLASHED BY DIVISION 7. PLUG CONTR WILL IN-STALL RAIN LEADERS AND MAKE FINAL CONNECTION TO ROOF DRAIN
- "B" FLASHING FOR VENT WILL BE INSTALLED BY DIVISION 7
- "C" INSTALL 1 1/2" BALL VALVE UP 4'-0"
- "D" ROUGH IN 2" WASTE, 1/2" CEN FOR FUTURE COUNTE SINK
- "E" RUN WATER SERVICE BELOW FLOOR. THIS WALL SPACE TO BE KEPT CLEAR FOR DIVISION 16 EQUIPMENT

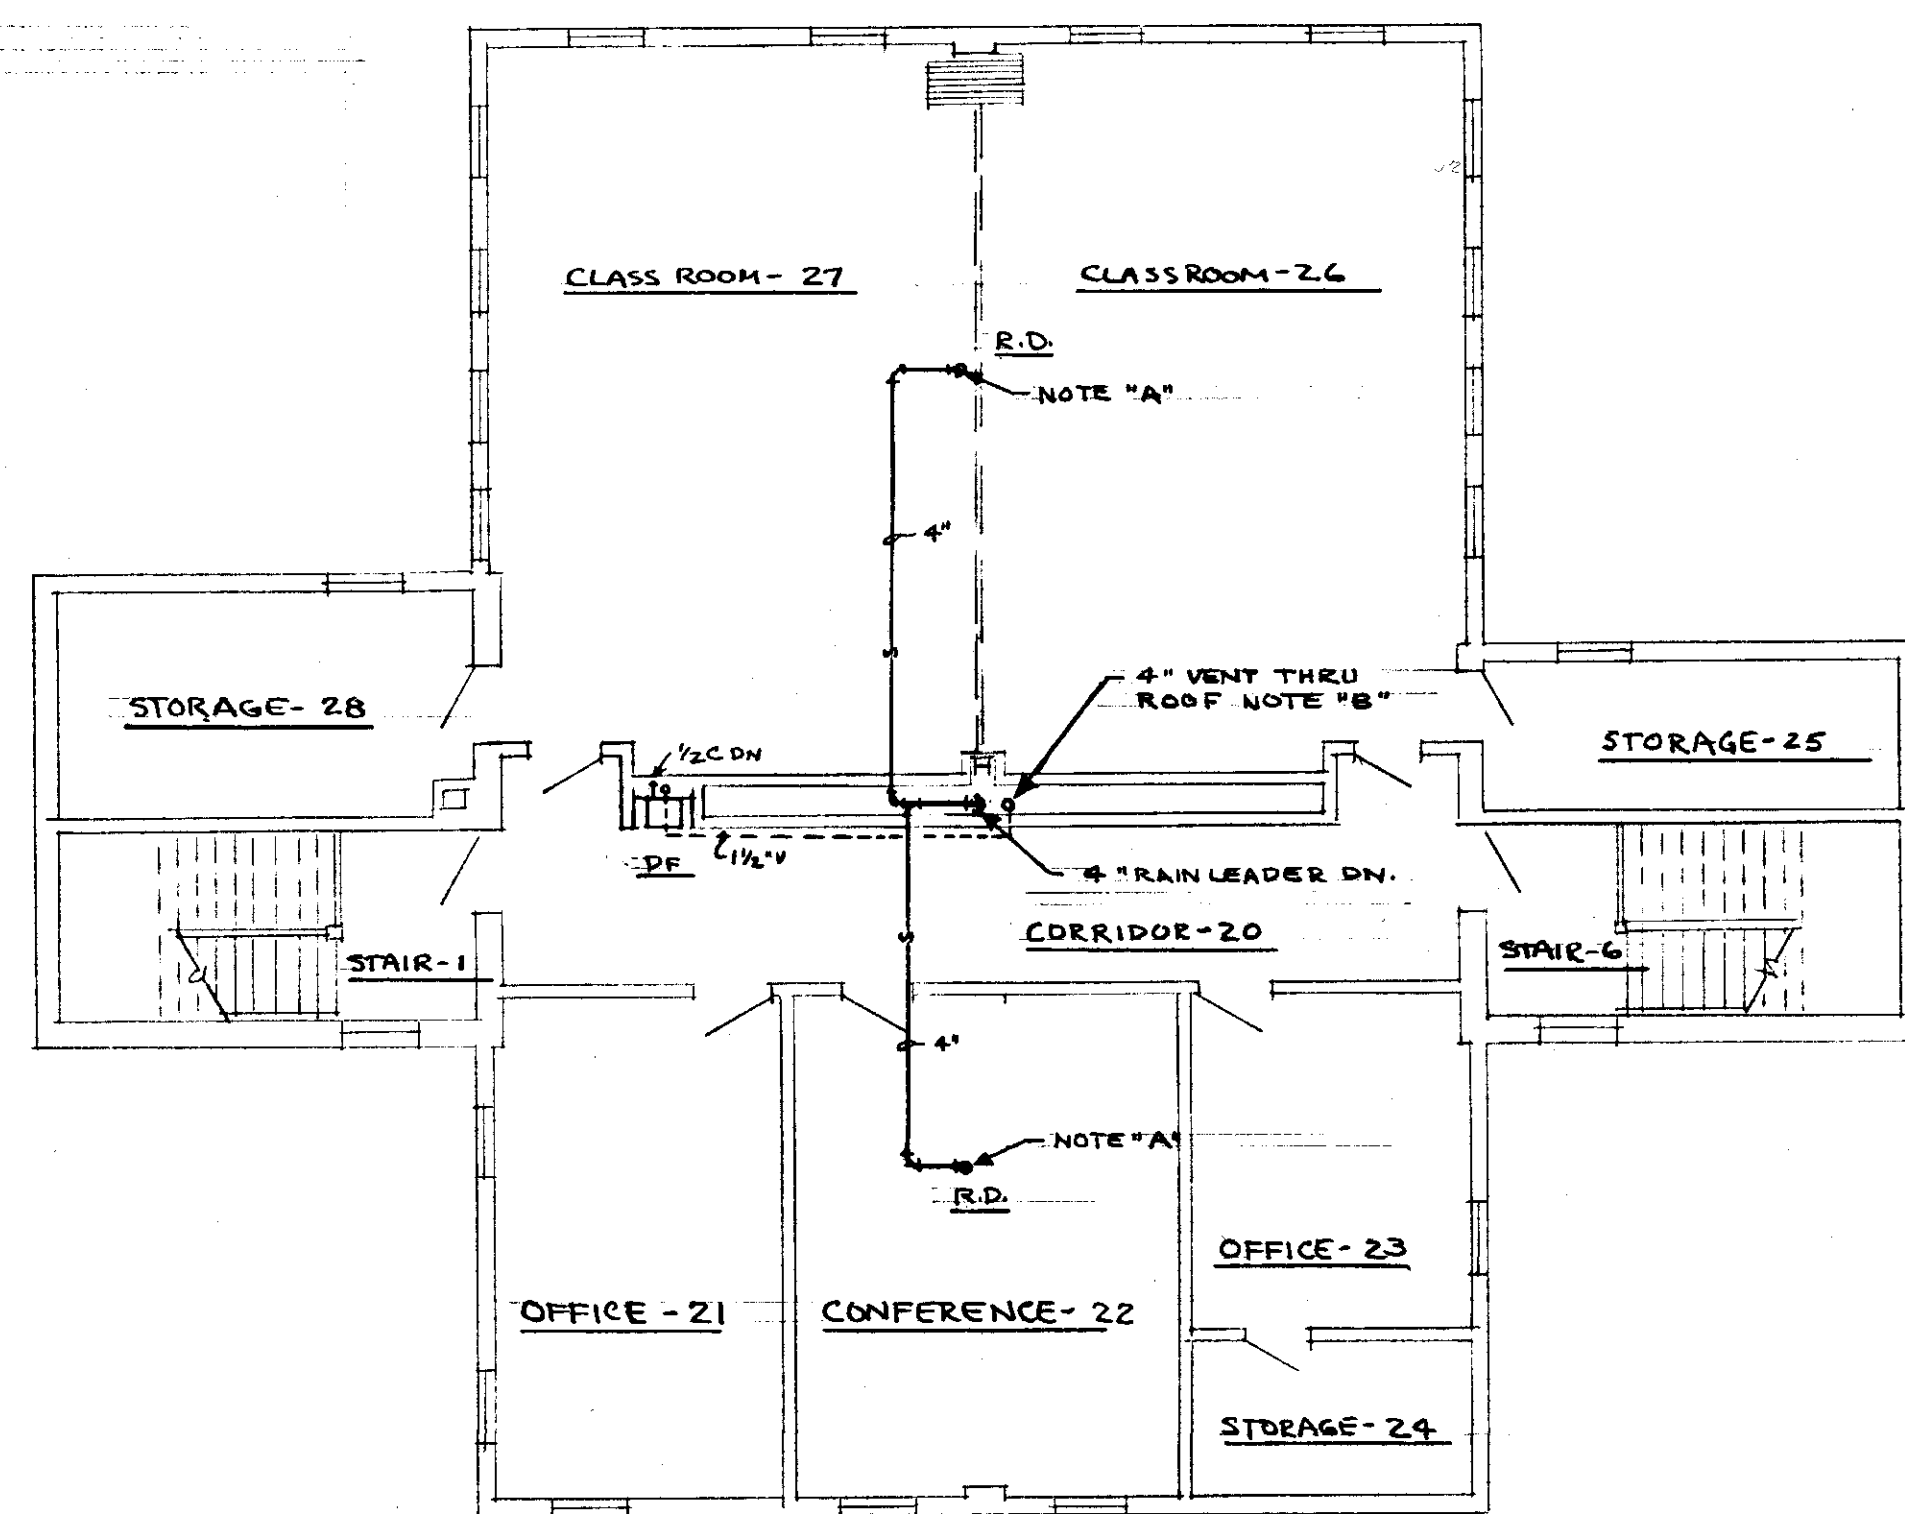


SECOND FLOOR PLAN

SCALE 1/8" = 1'-0"

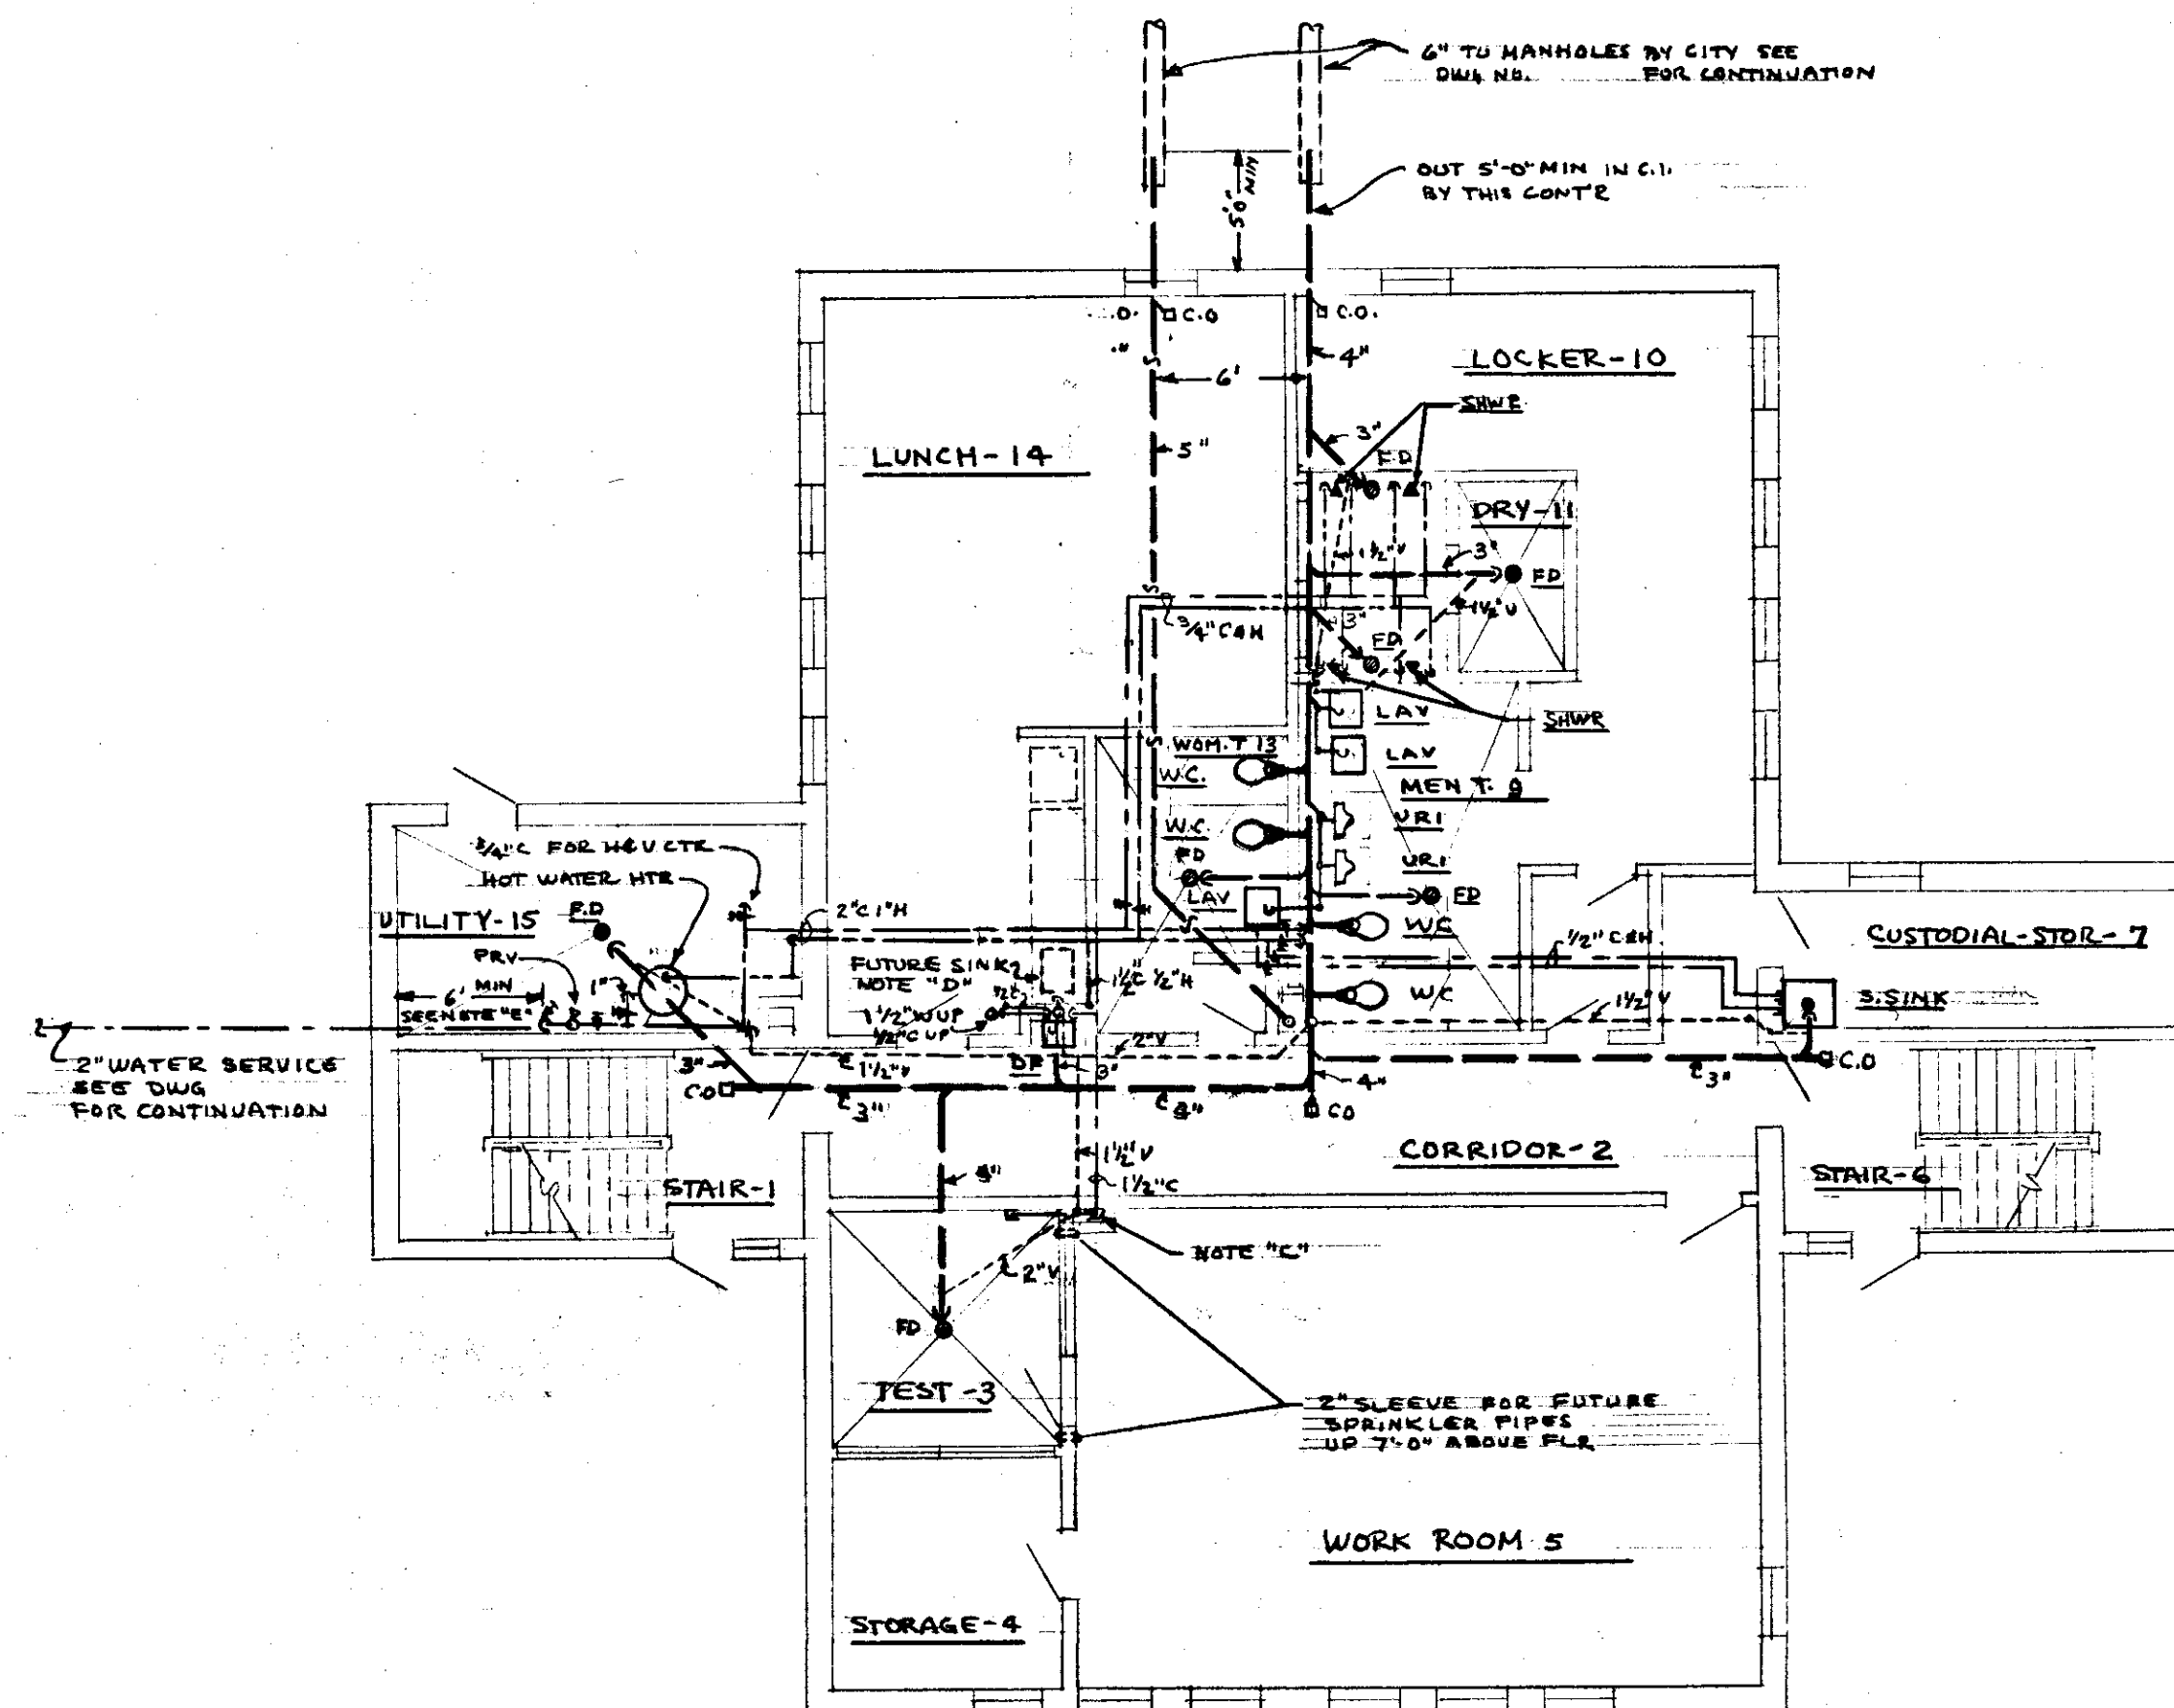


FIRST FLOOR PLAN

SCALE 1/8" = 1'-0"

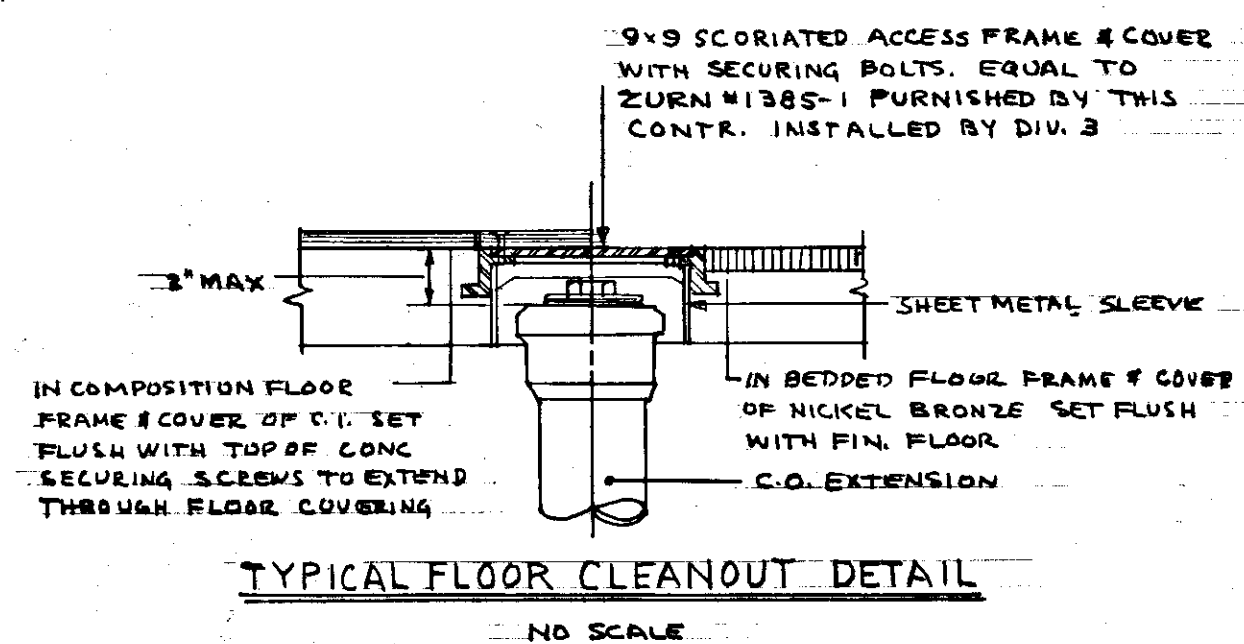


TYPICAL FLOOR CLEANOUT DETAIL

NO SCALE

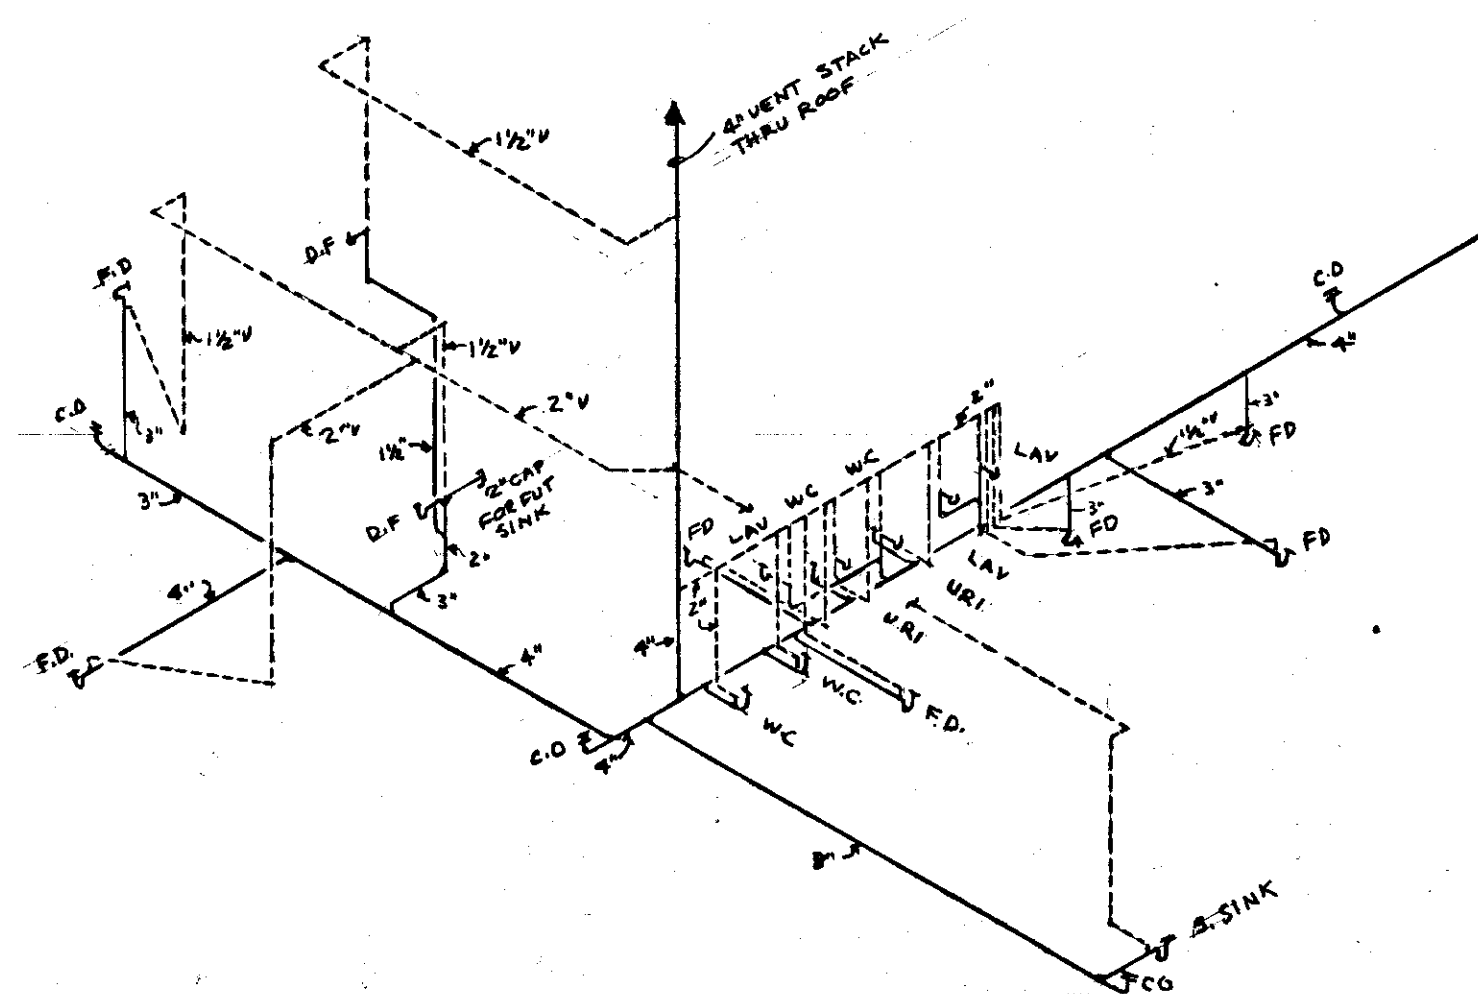


SCHEMATIC WASTE & VENT PIPING

NO SCALE

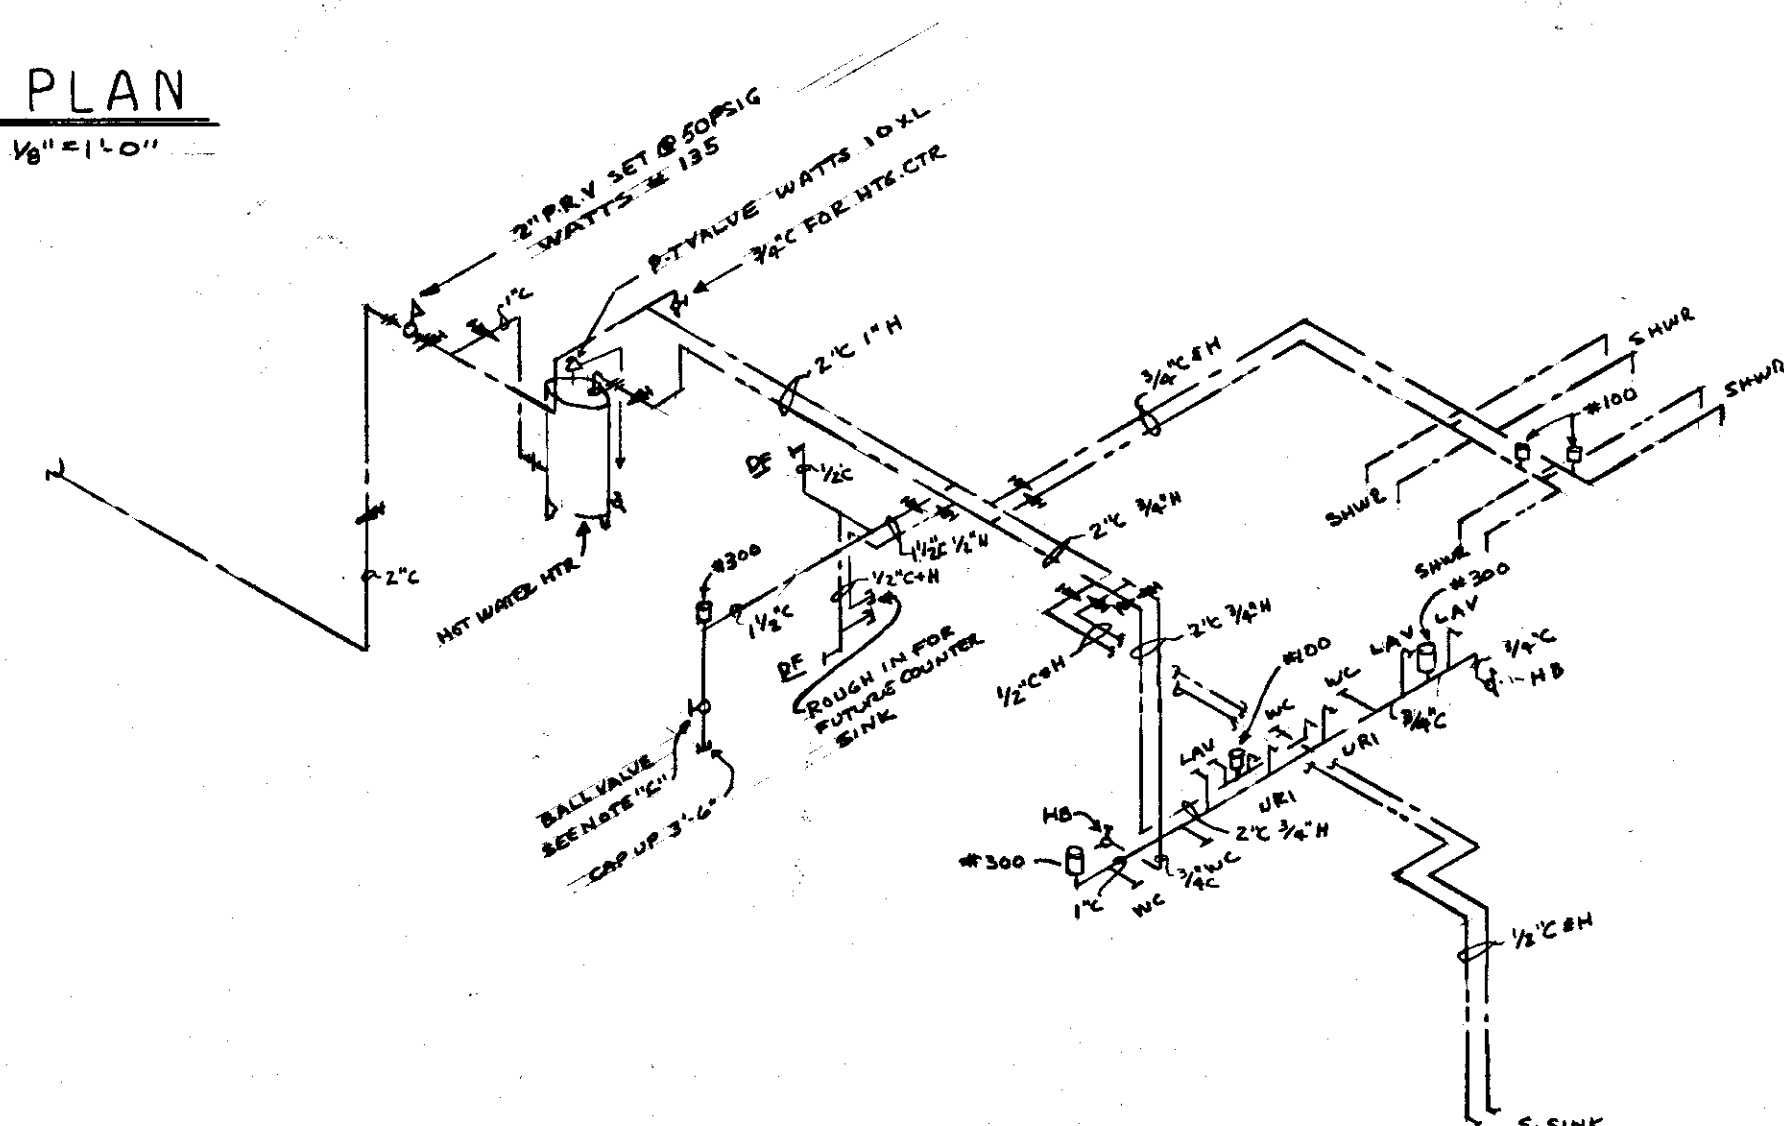

SCHEMATIC WATER PIPING

NO SCALE

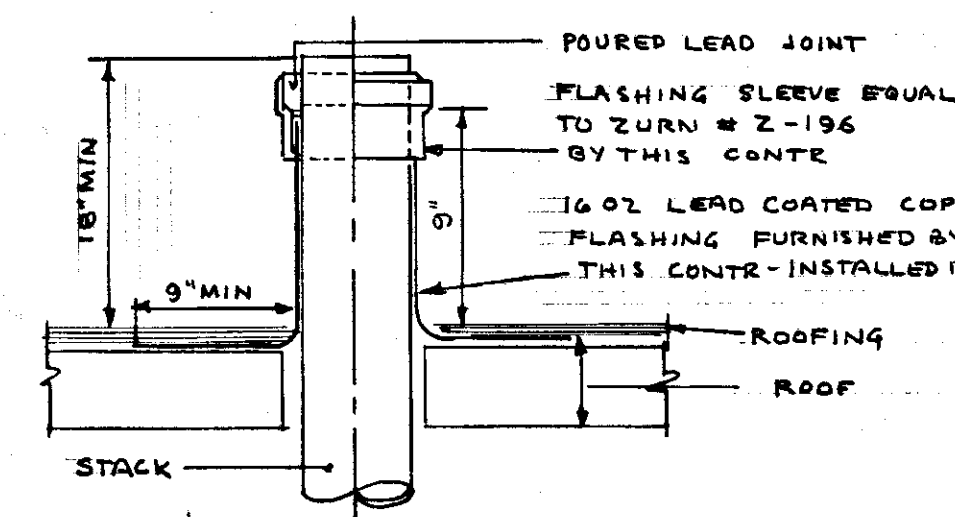

TYPICAL VENT FLASHING DETAIL

NO SCALE

PLUMBING SYMBOLS

---	SOIL OR WASTE
---	SOIL OR WASTE - BURIED
---	VENT
---	STORM
---	STORM - BURIED
---	COLD WATER
---	HOT WATER
---	GATE VALVE - CRANE 1320
---	BALL VALVE - CRANE 2180 OR 2182
---	SHOCK ARRESTOR - ZURN Z-1700
---	TRAP
---	GILLCOCK - HAMMOND FIG 1033
---	CLEANOUT
---	RELIEF VALVE
---	UNION

PLUMBING FIXTURE SCHEDULE

FIXTURE	SOIL OR WASTE	VENT	COLD WATER	HOT WATER	SPECIFICATION
W.C. - WATER CLOSET	4"	2"	1"	-	AMERICAN STD. "MADERA" TOILET # 2222-016 WITH SLOAN ROYAL NO 110 VALVE SOLID PLASTIC WHITE OPEN FRONT SEAT # 5320-144 (9500C) MOLTEX HEAVY DUTY
U.R.I. - URINAL	2"	1 1/2"	3/4"	-	AMERICAN STD. "ALL-BROOK" URINAL # 6840-017 WITH SLOAN ROYAL NO 180 VALVE
L.V. - LAVATORY	1 1/2"	1 1/2"	1/2"	1/2"	AMERICAN STD. "REGALYN" LAVATORY 20" x 18" ENAMELED C.I. # 4869-020 WITH AQUARIAN # 2179-125 HIGH SPOUT CENTER SET WITH VANDALPROOF POP-UP DRAIN, HANDLE & AERATOR, # 2302-081 CURBUP WITH LOOSE SET KEY, # 4420-020 ADJ. P TRAP 1 1/2" x 1 1/2"
D.F. DRINKING FOUNTAIN	1 1/2"	1 1/2"	1/2"	-	HALSEY TAYLOR # WM16A ELEC. COOLER DRINKING FOUNTAIN, 1 1/4" x 1 1/2" P TRAP & 3/8" IPS SERVICE STOP
S.SINK - SERVICE SINK	3"	1 1/2"	1/2"	1/2"	POWERS-FIAT MOP SERVICE BASIN # MSD 2424 WITH # 830-AA SERVICE FAUCET & VACUUM BREAKER, # 832-AA HOSE BRACKET, TWO # 77AA URINAL BUMPER GUARDS AND # 838-CC MOP HANGER
SHWR - SHOWER UNIT	-	-	1/2"	1/2"	SYMMONS # J-500 EXPOSED HEAVY DUTY SAFETY MIX UNIT WITH # 4-521 WAX SAFETY MIX VALVE, 20" HEAD RISER, # 4-295 EZ PRE-FLO HEAD # 221 SUPPLY RISERS
F.D. FLOOR DRAIN	3"	1 1/2"	-	-	ZURN # Z-415 WITH 6" S TRAINER
R.D. ROOF DRAIN	4"	2"	-	-	ZURN # Z-100ERC

CITY OF HARTFORD, CONNECTICUT
DEPARTMENT OF PUBLIC WORKS
BUREAU OF PUBLIC BUILDINGS

FIRE SAFETY TRAINING FACILITY
INCINERATOR ROAD
HARTFORD CONNECTICUT

DRAWING
P
1

SUBMITTED: [Signature]
RECOMMENDED: [Signature]
APPROVED: [Signature]
SCALE: AS SHOWN
DAYBOOK NO. 010524-1
DATE: SEPT. 3, 1975