



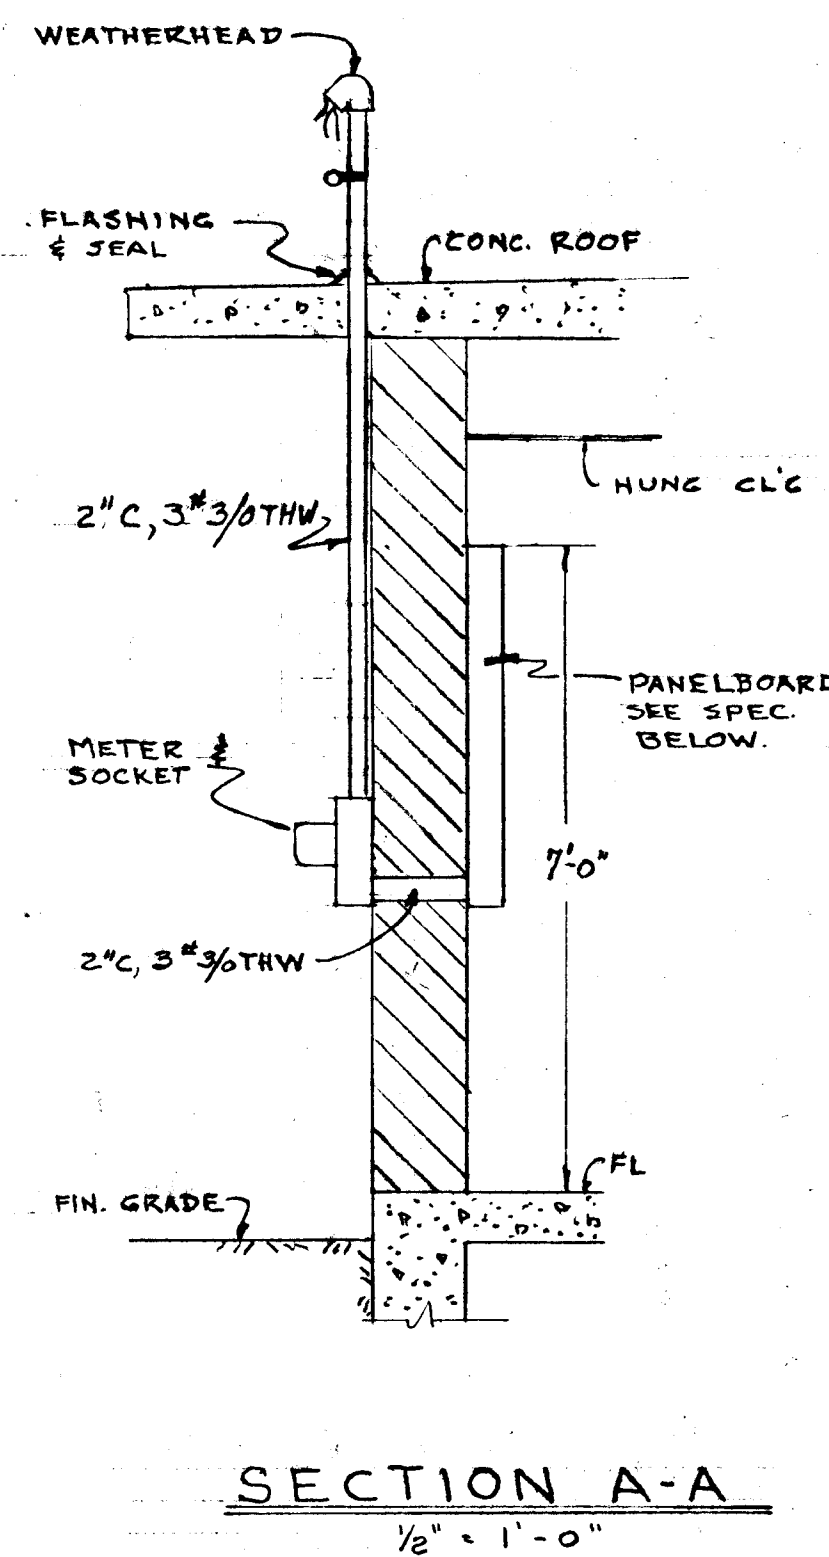

PANELBOARD SPECIFICATION


SERVICE: 120/240V-1Ø-3W
 MAINS: 200AMP CIRCUIT BREAKER
 BRANCHES:
 15-20A-1P-THQL
 1-20A-1P-THQLGF (ELEC. HTR)
 3-20A-2P-THQL (ELEC. HTR)
 1-20A-2P-THQLGF (HAND DRYER)
 2-30A-2P-THQL (FLO. LITS)
 1-50A-2P-THQL (A/C UNIT)
 12-SPACES
 CABINET: SURFACE MOUNTED-DOOR
 WITH TYPED DIRECTORY
 NEMA-1 ENCLOSURE
 MANUFACTURER: G.E. TYPE NLTQ

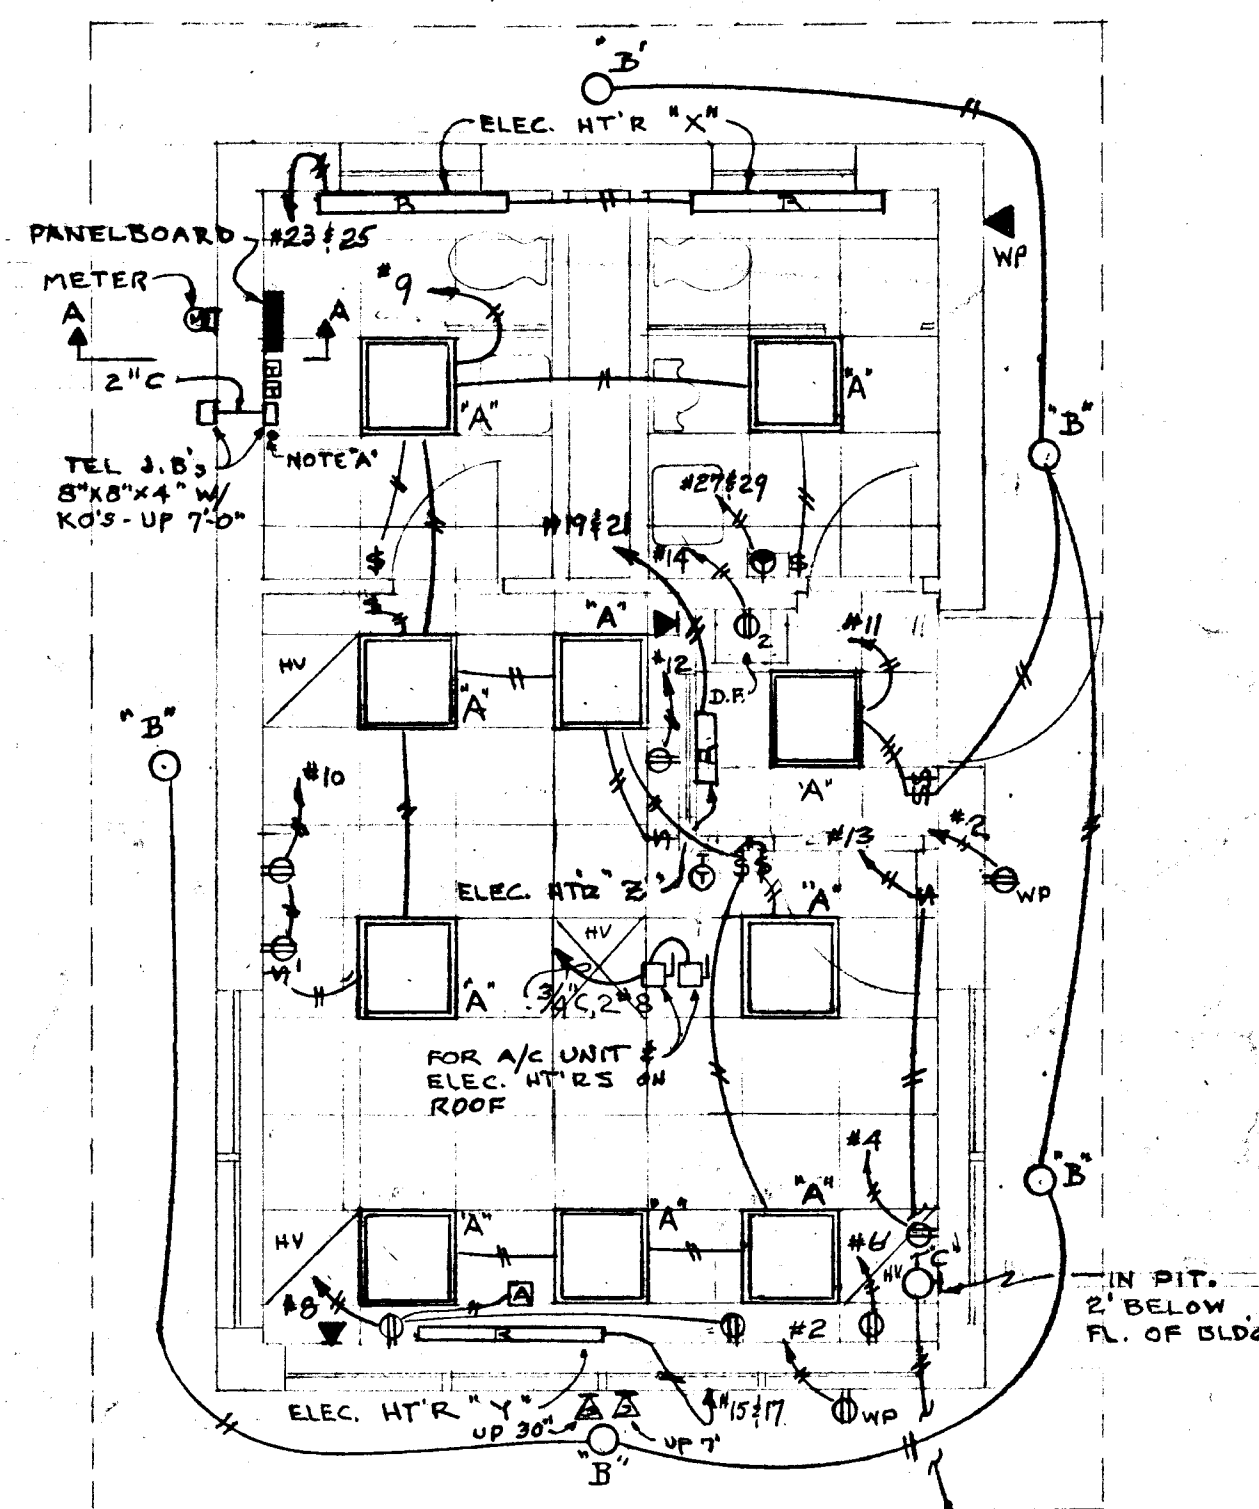

NOTE A - STUDS UP 3/4\"/>


ELECTRIC FLOOR PLAN

SCALE 1/4\"/>


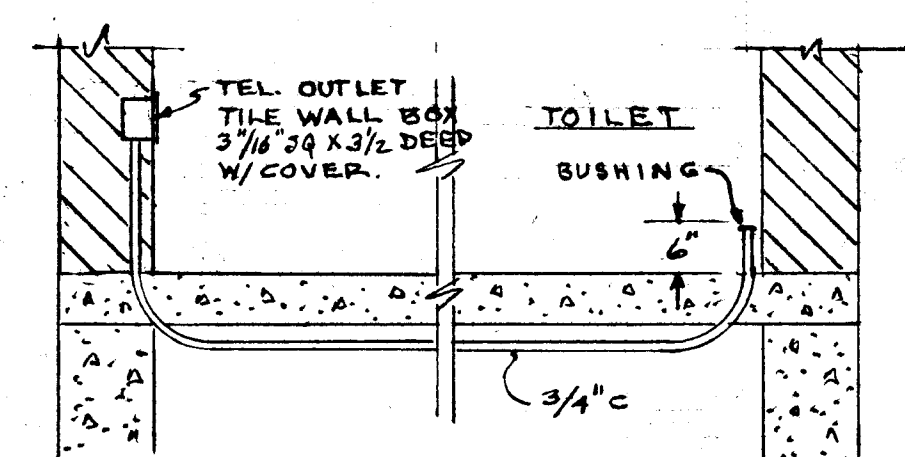


TELEPHONE OUTLET DETAIL

N.T.S.

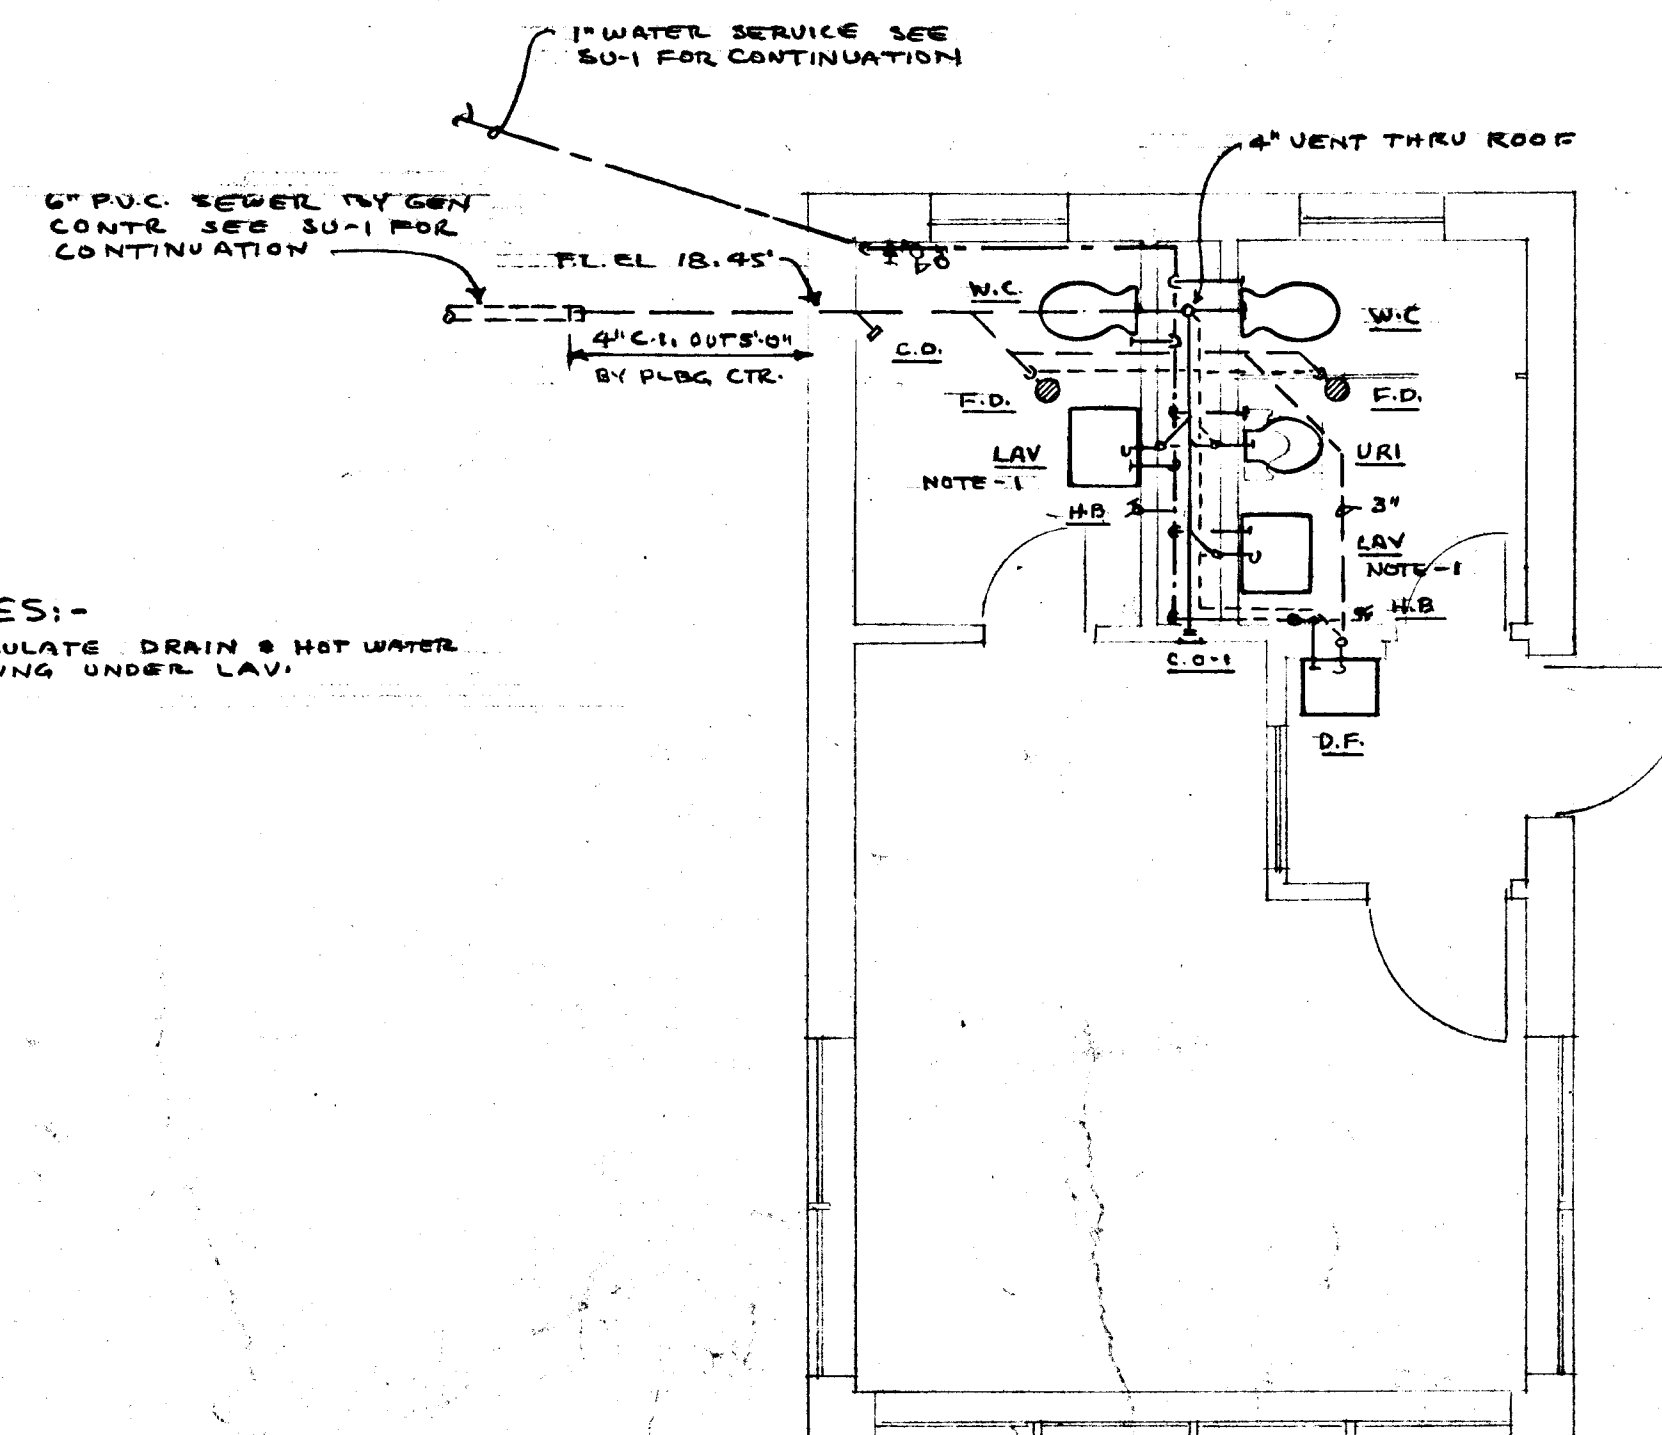


NOTES:-
 1-INSULATE DRAIN & HOT WATER
 PIPING UNDER LAV.

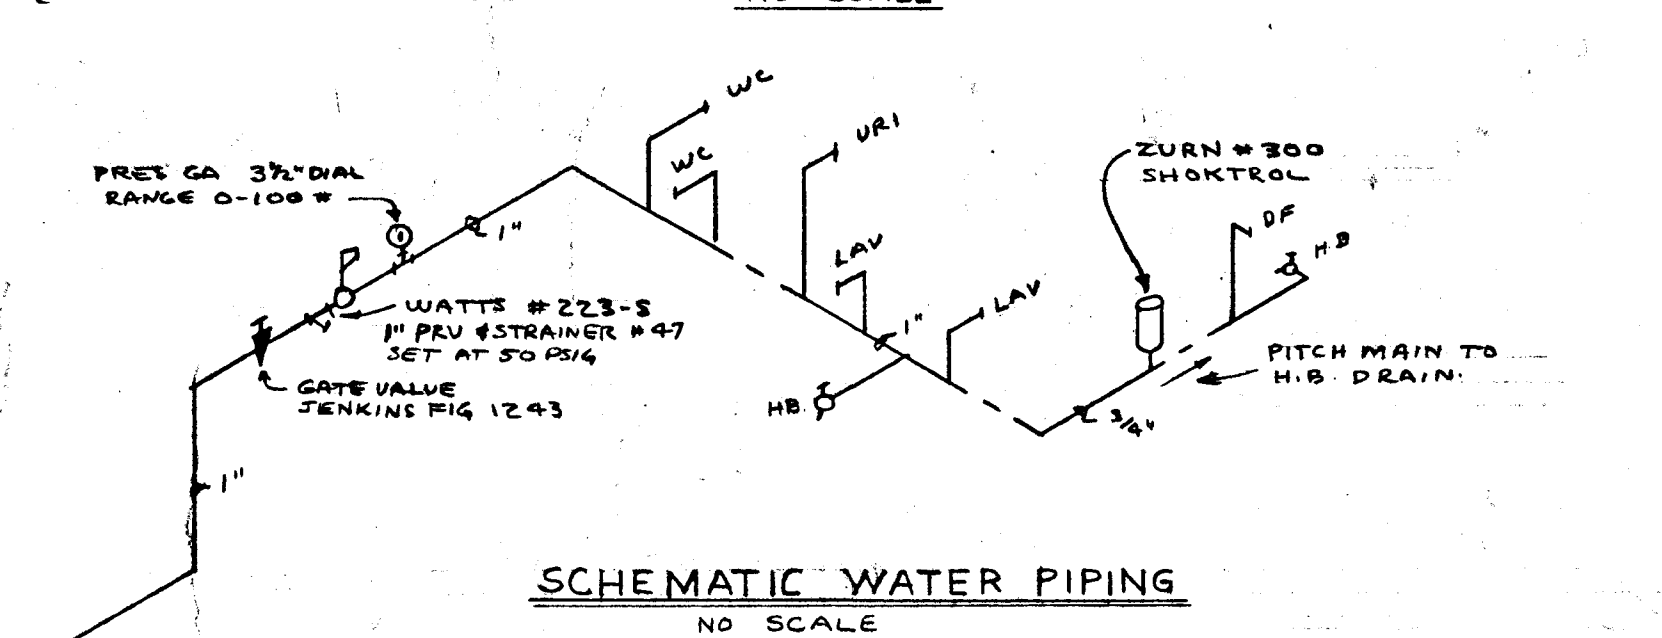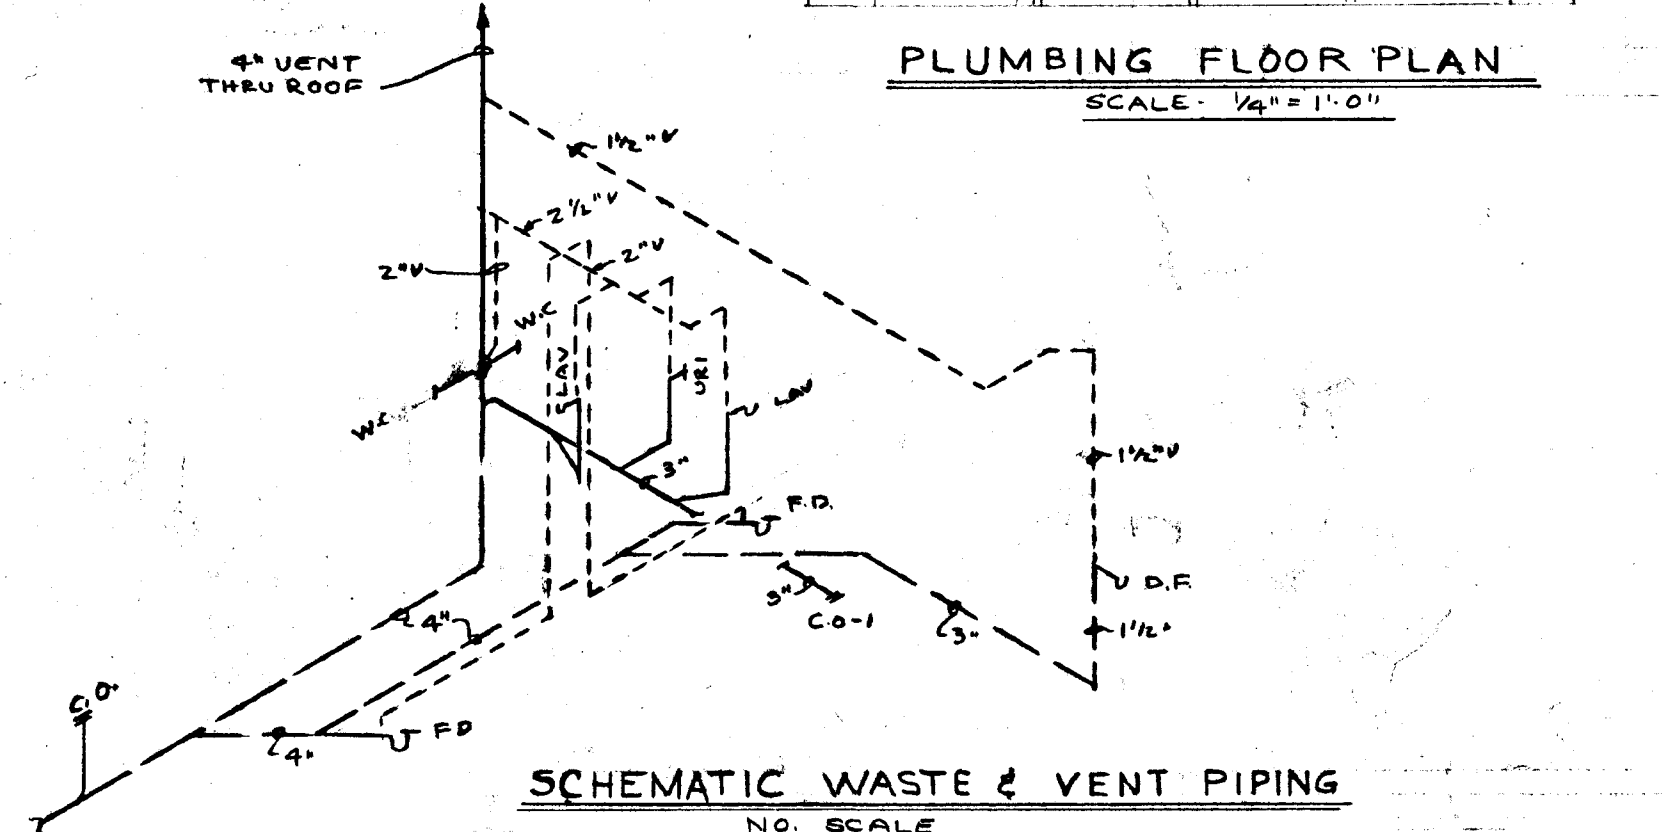

SCHEMATIC WATER PIPING


NO. SCALE

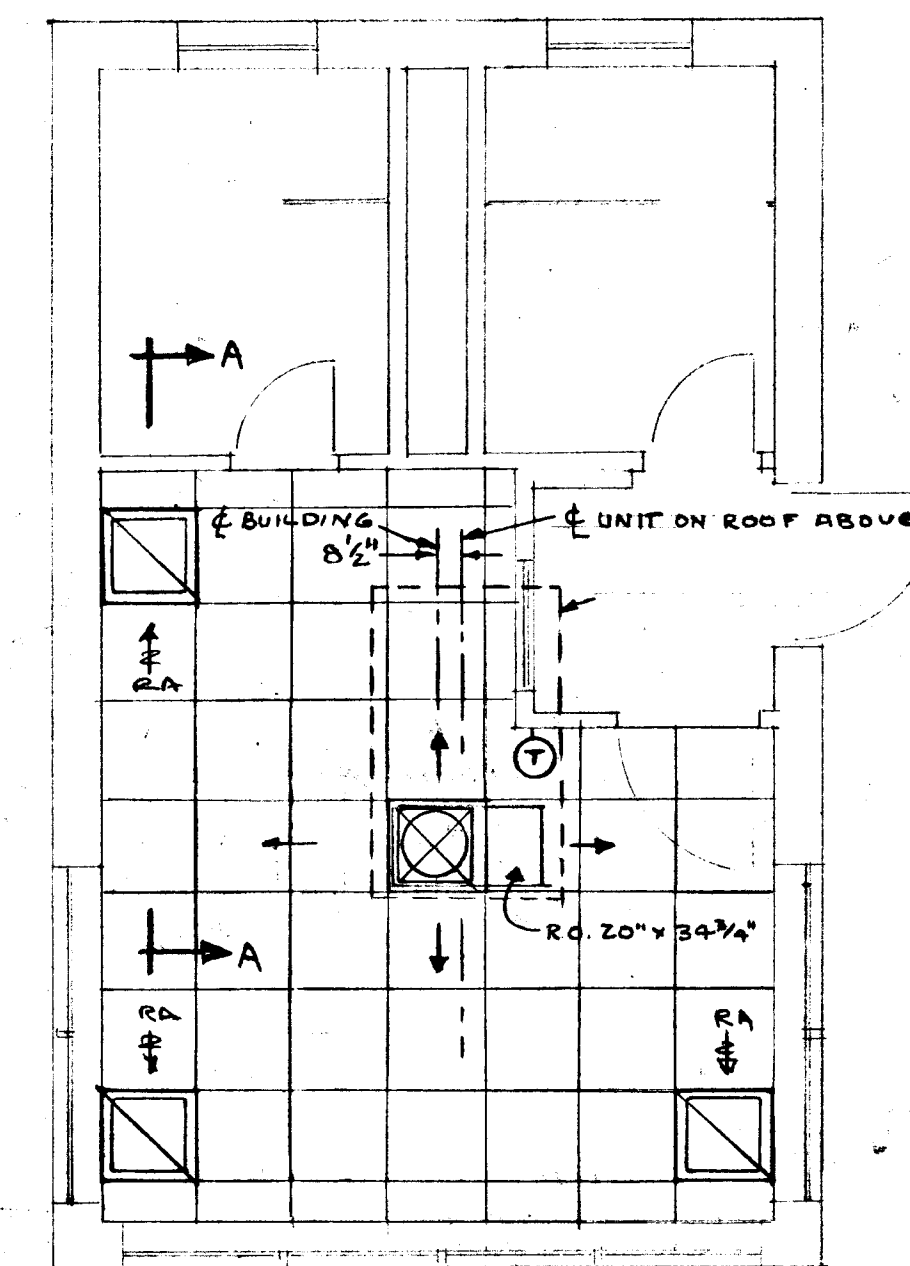

HV-AC FLOOR PLAN

SCALE 1/4\"/>

① T-STAT WITH SUB BASE
 WITH H-C-AUTO SW &
 PROVIDE GUARD

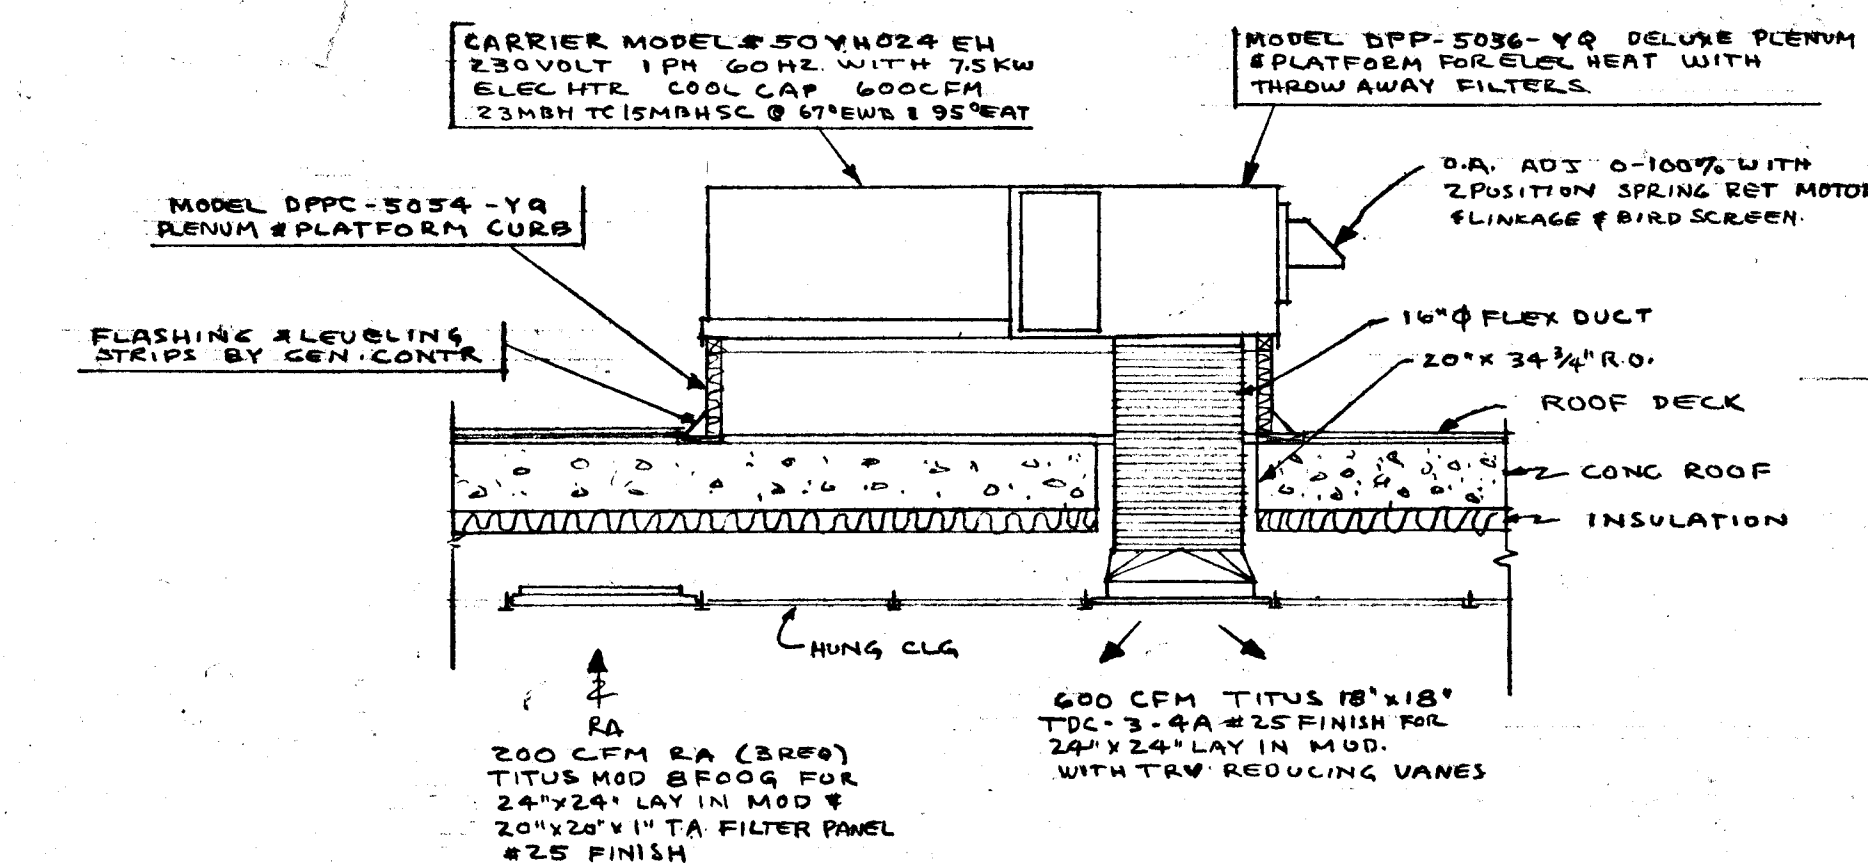

SECTION A-A

SCALE 1/2\"/>

SYMBOL	DESCRIPTION
○	CEILING FIXTURE - SEE FIXTURE SCHEDULE
◊	WALL BRACKET ~ " " " "
◻	RECESSED FIXTURE ~ " " " "
⊕	DUPLEX RECEPTACLE ~ H4H*5262-5 ~ UP 12"
⊕ ₂	DUPLEX RECEPTACLE ~ H4H*5261-5 ~ UP 6" ABOVE COUNTER
⊕ ₂	D.F. RECEPTACLE ~ H4H*5261-5 ~ COORDINATE W/ PLUMB R.
⊕ _{WP}	WEATHERPROOF RECEPTACLE ~ H4H*5272 ~ UP 18"
⊕	HAND DRYER-2500W-240V-1Ø ~ SEE NOTE #1
\$	SINGLE POLE SWITCH ~ H4H*1891 ~ UP 4'-0"
—	HOME RUN TO PANEL
⊠	FUSED DISCONNECT
R	ELECTRIC BASEBOARD HEATER - SEE SCHEDULE
◀	TELEPHONE OUTLET ~ UP 12" ~ SEE DETAIL
◀ _{WP}	TELEPHONE OUTLET ~ UP 3'6" ~ " "
⊕ ₁	THERMOSTAT ~ UP 5'-0" ~ SEE NOTE #1
⊕	TIME CLOCK - TORK*7200ZL - MOTOR TO BE ON SEPARATE CIE.
⊕	MASTER INTERCOM STATION ~ TALK-A-PHONE*K-LC-2
⊕	SUB INTERCOM STATION

NOTES 1. FURNISHED BY OTHERS. INSTALLED AND WIRED
 BY THIS ELECTRICAL CONTRACTOR.

TYPE	DESCRIPTION
A	RECESS FLUORESCENT FIXTURE TWO FOOT SQUARE ~ LAMP E40CW/U LITHONIA #26P2U40A12
B	SURFACE MTD ~ WEATHERPROOF ~ LAMP 100W HPS ~ BALLAST - HRF - 200°F. KENALL #5809HPS W/ SCREWDRIVER*9000
C	VAPORTIGHT ~ LAMP 100W ~ LEXAN GLOBE ~ STONCO #VCXL-10A

TYPE	DESCRIPTION
X	MARKEL #H2004N ~ 1000W @ 240V WITH T2003TT T-STAT
Y	SAME AS "X". MOUNT UNDER COUNTER.
Z	WALL MTD UNIT ~ MARK III MARKEL #H703TN ~ 1500W @ 240V. WITH BUILT-IN T-STAT AND SWITCH AND 2" SEMI-RECESSING EXTENDER

FIXTURE	WASTE	VENT	C.W.	SPECIFICATION
W.C. WATER CLOSET	4"	2"	1"	AM. STD. "GLENCO" TOILET #250Z-011 WITH SLOAN ROYAL #110 VALVE; MOTOR #5300-144 SOLID PLASTIC HEAVY DUTY WHITE SPIN FRONT SEAT CARRIER SMITH FIG #175D 30" MTG. HEIGHT.
U.R.I. URINAL	2"	1 1/2"	3/4"	AM. STD. "JETBROOK" URINAL #6870-014 WITH SLOAN ROYAL #100 VALVE 18" MTG. HEIGHT. CARRIER SMITH FIG #63Z
LAV. LAVATORY	1 1/2"	1 1/2"	1/2"	AM. STD. "REGALYN" LAVATORY 20"x18" #4849-012; 1/4"x1/2" ADT. P. TRAP #4420-014; LAVATORY DRAIN WITH STOPPER #2440-014; CHAIN STAY #5575-017; AVULE STOP W/ LOCK KEY #8225-021; 1/2" ULTRA WARM WATER DISPENSING SYSTEM MODEL #777W (750 WATTS 120V 1Ø) 32" MTG. HEIGHT CARRIER SMITH FIG #720
D.F. DRINKING FOUNTAIN	1 1/2"	1 1/2"	1/2"	HALSEY TAYLOR MODEL #WC 7A-1 36" MTG. HEIGHT HANDLES BOTH SIDES.
F.D. FLOOR DRAIN	4"	2"	-	ZURN #Z-415 TRIUMPH FLOOR DRAIN WITH 6" Ø TYPE B STRAINER-NB.
C.O. CLEAN OUT	4"	-	-	ZURN #Z-415-1460-10 SCORATED ACCESS FRAME #COVER OF NICKEL BRONZE SET FLUSH WITH FINISH FLOOR SIZE 9"x9"
H.B. HOSE BIBB	-	-	1/2"	WALL MTD ANGLE TYPE WITH LOOSE SET KEY & SHIELD CHROME PLATED.
C.O.-1 CLEAN OUT	3"	-	-	ZURN Z-1460-Z 8"x8"

CITY OF HARTFORD, CONNECTICUT
 DEPARTMENT OF PUBLIC WORKS
 BUREAU OF PUBLIC BUILDINGS
LANDFILL WEIGH-STATION
 EAST SERVICE ROAD HARTFORD, CT.
MECHANICAL & ELECTRICAL PLANS

SUBMITTED: *Robert J. Murphy*
 CITY ARCHITECT
 RECOMMENDED: *W.R. Reed*
 CITY ARCHITECT
 APPROVED: *George E. Hoffman*
 ASSOCIATE CITY ARCHITECT

DRAWN: *R.B.P.*
 CHECKED: *R.B.P.*
 SCALE: AS NOTED
 DAYBOOK NO. 010633-G
 DATE JUNE 5, 1978