


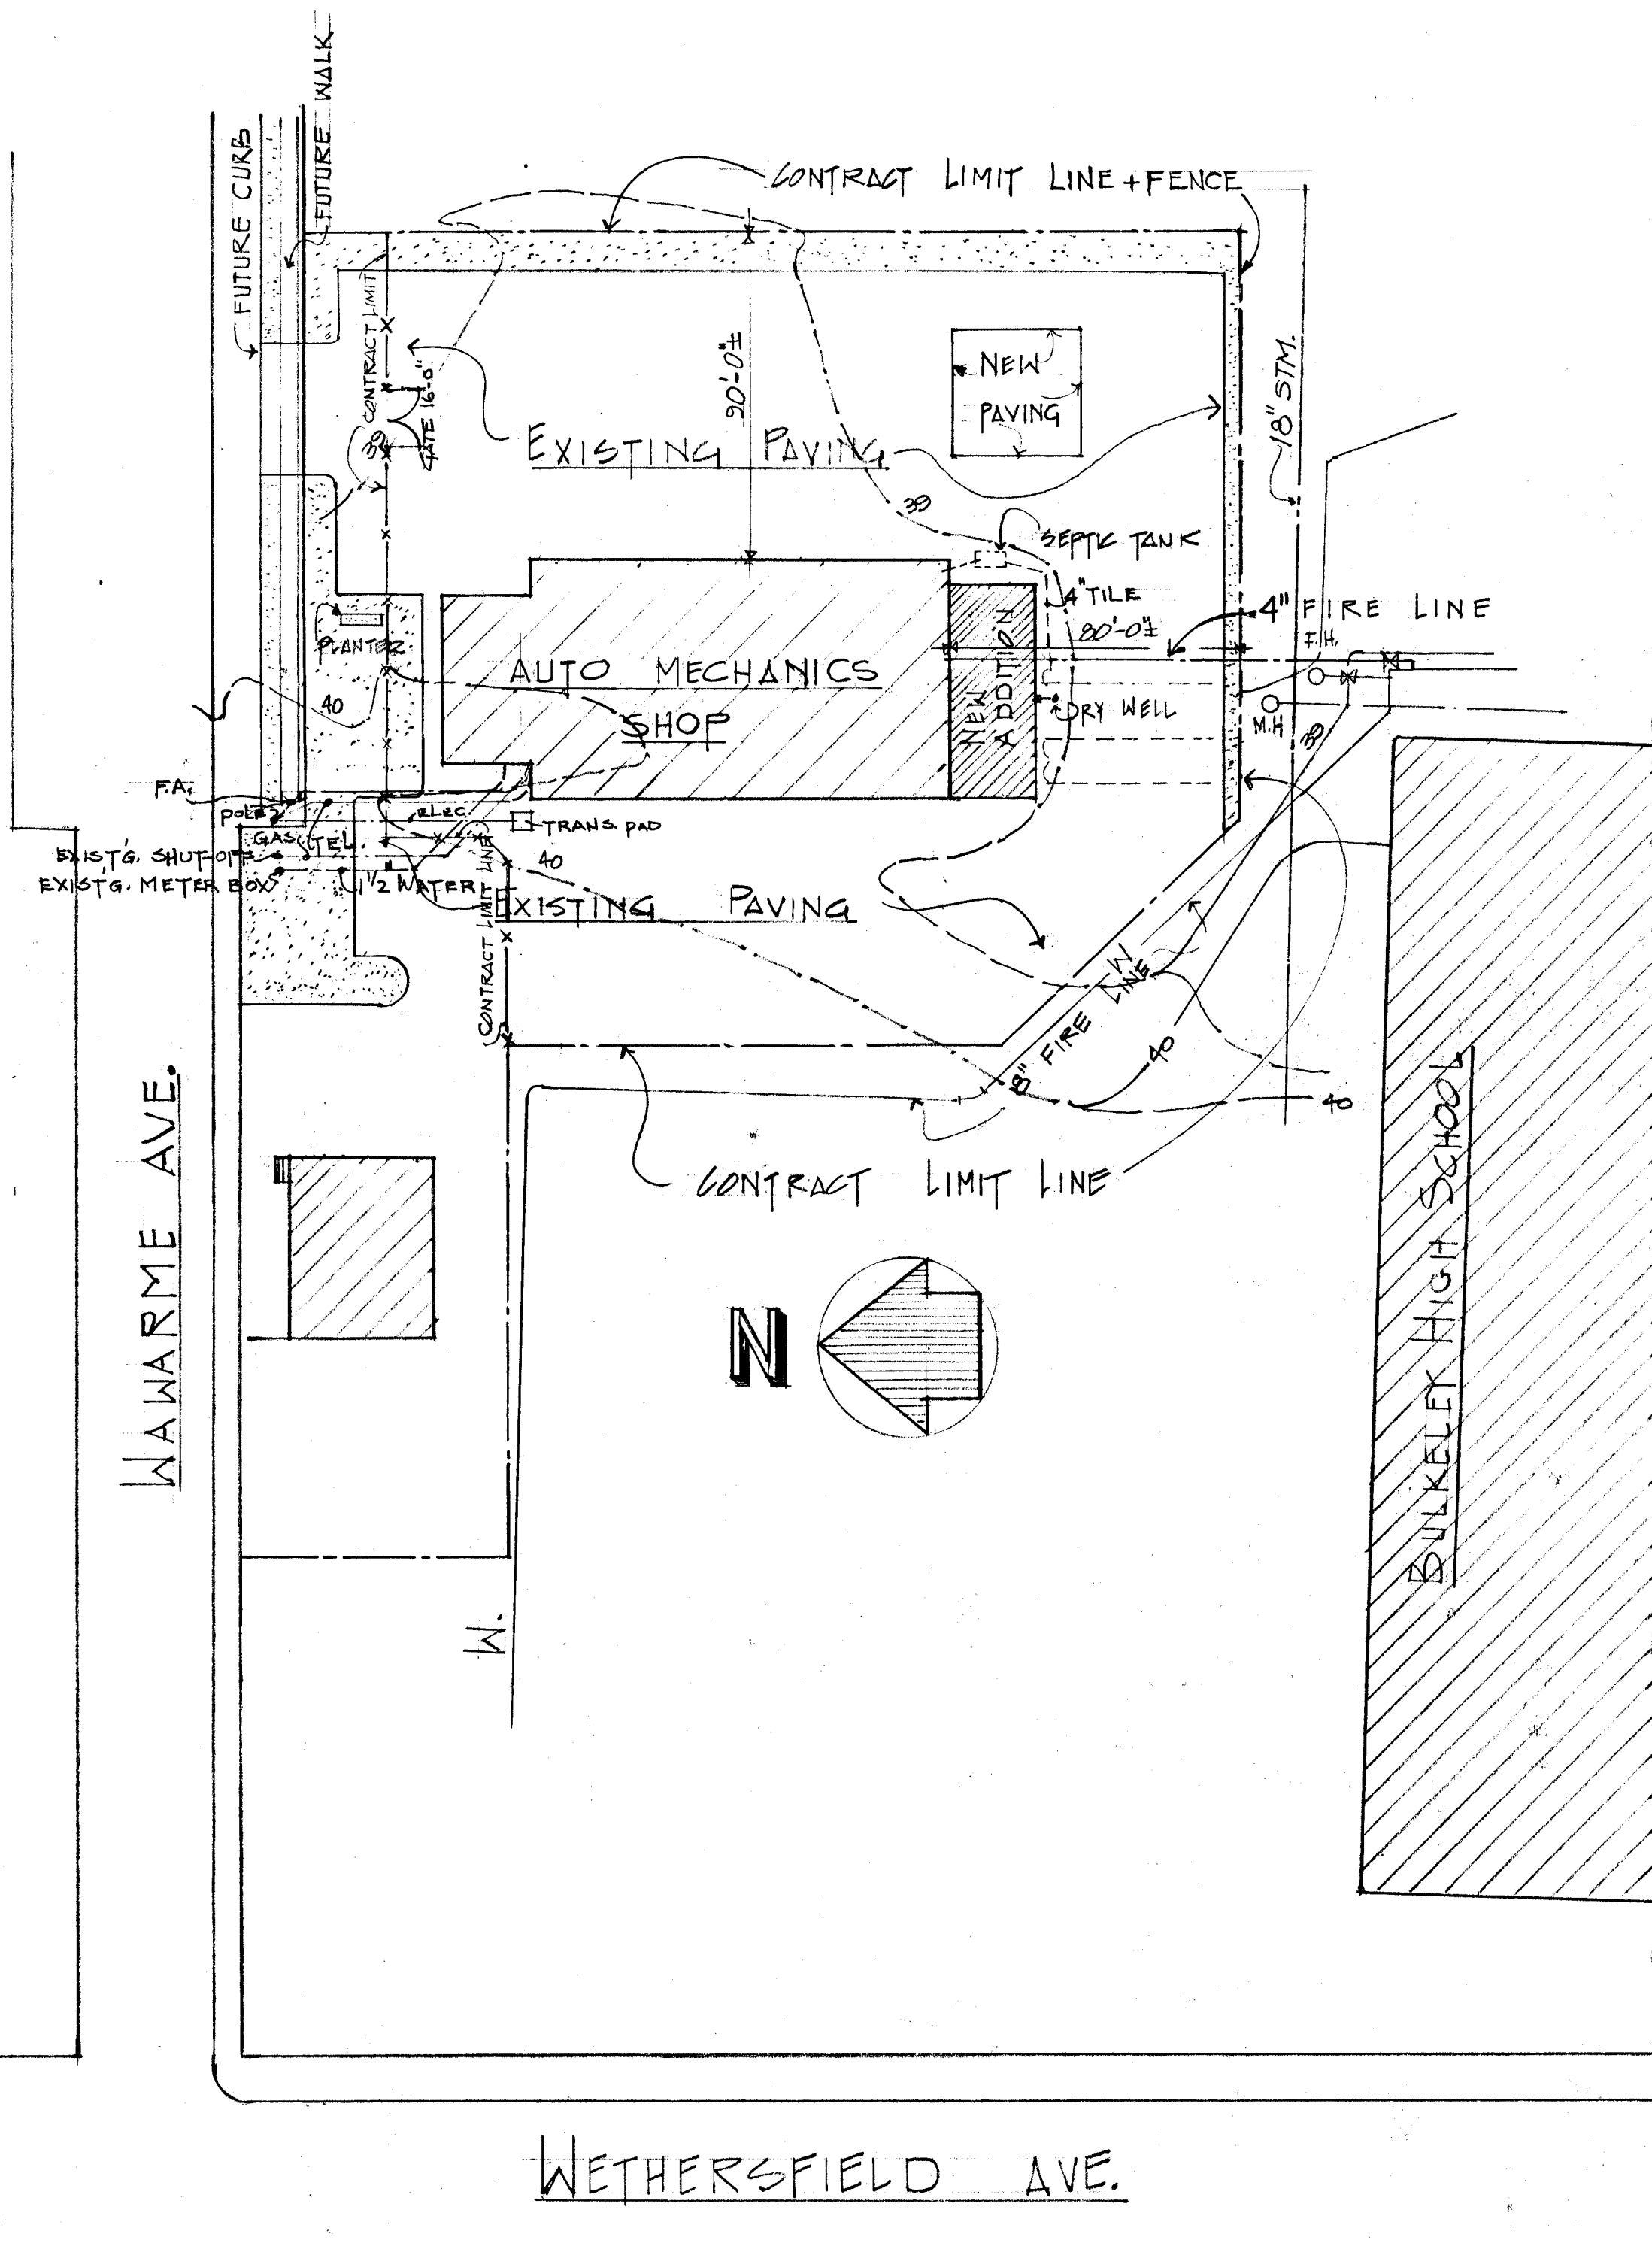

PLOT PLAN

SCALE: 1"=40'-0"

I HEREBY CERTIFY THIS MAP
TO BE SUBSTANTIALLY CORRECT.
Joseph D. Griffin
JOSEPH GRIFFIN, L.S.
CONN. REG. NO. 2160

AUTO MECHANICS SHOP
31 WAWARME AVENUE
HARTFORD, CONN.

INDEX TO DRAWINGS

- A1- PLOT PLAN**
- A2- FLOOR PLAN & ELEVATIONS**
- A3- PARTIAL FLOOR PLAN-DETAILS & SCHEDULES**
- A4- SECTIONS & DETAILS.**

- P1- PLUMBING PLAN & DETAILS**
- HV1- HEATING & VENTILATING PLAN & DETAILS.**

- E1- LIGHTING PLAN & DETAILS**
- E2- POWER PLAN & SCHEDULES**

NOTES

- THE CONTRACTOR SHALL GIVE ALL NOTICES AND COMPLY WITH ALL LAWS, ORDINANCES, RULES, REGULATIONS AND ORDERS OF ANY PUBLIC AUTHORITY BEARING ON THE PERFORMANCE OF THE WORK.
- THE CONTRACTOR SHALL INSTALL UTILITY LINES AS SHOWN ON PLOT PLAN.
- EXISTING CONSTRUCTION FENCE WILL REMAIN IN PLACE FOR THE DURATION OF THE JOB AND WILL THEN BE REMOVED BY THE CITY.
- THE CONTRACTOR SHALL REMOVE DIRT & DEBRIS FROM SITE.
- THE CONTRACTOR SHALL PATCH PAVING WHERE DISTURBED BY EXCAVATIONS FOR UTILITY LINES OR NEW ADDITIONS.
- THE CONTRACTOR SHALL PAVE THE UNPAVED AREA EAST OF THE BUILDING, EXCAVATING TO A DEPTH OF 10" THEN FILLING WITH PROCESSED GRAVEL & PAVING THE AREA TO MATCH ADJOINING PAVING.
- THE CONTRACTOR SHALL CAREFULLY STUDY & COMPARE THE AGREEMENT, CONDITIONS OF THE CONTRACT, DRAWINGS, SPECIFICATIONS, ADDENDA & MODIFICATIONS AND SHALL AT ONCE REPORT TO THE ARCHITECT ANY ERROR, INCONSISTENCY OR OMISSION HE MAY DISCOVER.

VERIFY EXISTING
CONDITIONS AND
DIMENSIONS AT
BUILDING

CITY OF HARTFORD, CONNECTICUT DEPARTMENT OF PUBLIC WORKS.		
DWG. No.		A1
SUBMITTED <i>G.H. Stone</i>	RECOMMENDED <i>W.D. Reed</i>	APPROVED <i>George E. Neffner</i>
CITY ARCHITECT		CITY ENGINEER
DESIGN	DRAWN <i>H.F.J.</i>	DAYBOOK NO. 010344-A
TRACED	CHECK <i>AHS</i>	DATE MAY 24, 1972