



FIXTURE SCHEDULE

TYPE	MANUFACTURER & CATALOG NO.	LAMPS	REMARKS
A	WIDE-LITE #1D-1000-FLB W/H6 HOOK	ONE #H36-15GW/C	PROVIDE #10-RIB-C REMOTE BALLAST PER FIXTURE. DETAIL "A"
B	LITHONIA #L240EL	TWO F40CW	EMERGENCY & WALK LT. SEE DETAIL "A" FOR MT'G
C	LITHONIA #8TLB240A	FOUR F40CW	CEILING MT'D
D	LITHONIA #DV240A	TWO F40/CSS	SEE MT'G DETAIL
DI	LITHONIA #DV240AEL	TWO F40CW	EMERGENCY & WALK LT. CEILING MT'D
E	LITHONIA #EPIREL	FURNISHED WITH UNIT	EXIT LT. W/ EMERGENCY - WALL MT'D UP 10'-0"
EI	LITHONIA #EPIREL	FURNISHED WITH UNIT	EXIT LT. W/ EMERGENCY - CEILING MT'D
F	FURNISHED WITH SPRAY BOOTH	FOUR F40/CSS	FIXTURE INSTALLED & WIRED BY THIS E.C.
G	DAYBRITE #45242-8	FOUR F40CW	WALL MT'D - UP 6'-0"
H	WIDE-LITE #SF400AWRB-CSPCM-1-SWB14-8	ONE #H33-1GL/DX	WALL MT'D UP 16'-0" E.C. TO PROVIDE FISCHER #66906 PHOTO CELL
HI	WIDE-LITE #SF250FWRB-B-SPCM-1-SWB14-8	ONE #H37-KC/DX	WALL MT'D UP 13'-0" E.C. TO PROVIDE FISCHER #66906 PHOTO CELL
J	LITHONIA #2G440A	FOUR F40CW	RECESSED
JI	LITHONIA #2G440AEL	FOUR F40CW	RECESSED - GENERAL & EMERGENCY LT'G
K	LITHONIA #LB240A	TWO F40CW	SURFACE MT'D
KI	LITHONIA #LB240AEL	TWO F40CW	SURFACE MT'D - GENERAL & EMERGENCY LT'G
L	LITHONIA #8TCB140A	TWO F40CW	SURFACE MT'D
LI	LITHONIA #CB140A	ONE F40CW	SURFACE MT'D
L2	LITHONIA #CB140AEL	ONE F40CW	SURFACE MT'D - GENERAL & EMERGENCY LT'G
M	DAYBRITE #45242-4	TWO F40CW	WALL MT'D ABOVE MIRROR OR AS NOTED
N	DAYBRITE #W-150-G1-SI	ONE 150W. I.F.	RECESSED
O	STONCO 2 #CLD 1500	TWO 150PAR/PL	EXIST. BOX; PROVIDE NEW COVER
P	KENALL #5900 PC	ONE #H39-22KC/DX	WALL MT'D UP 9'-0" - 120V BALLASTS (-20°F)


NOTES
 1. ALL FLUORESCENT BALLASTS SHALL BE 118V-ETL-CBM-HPF-UL-CLASS P
 2. ALL MERCURY BALLASTS SHALL BE 208V-REGULATING TYPE - CAPABLE OF OPERATING METAL HALIDE LAMPS.
 3. ALL LAMPS DESIGNATED ARE G.E.

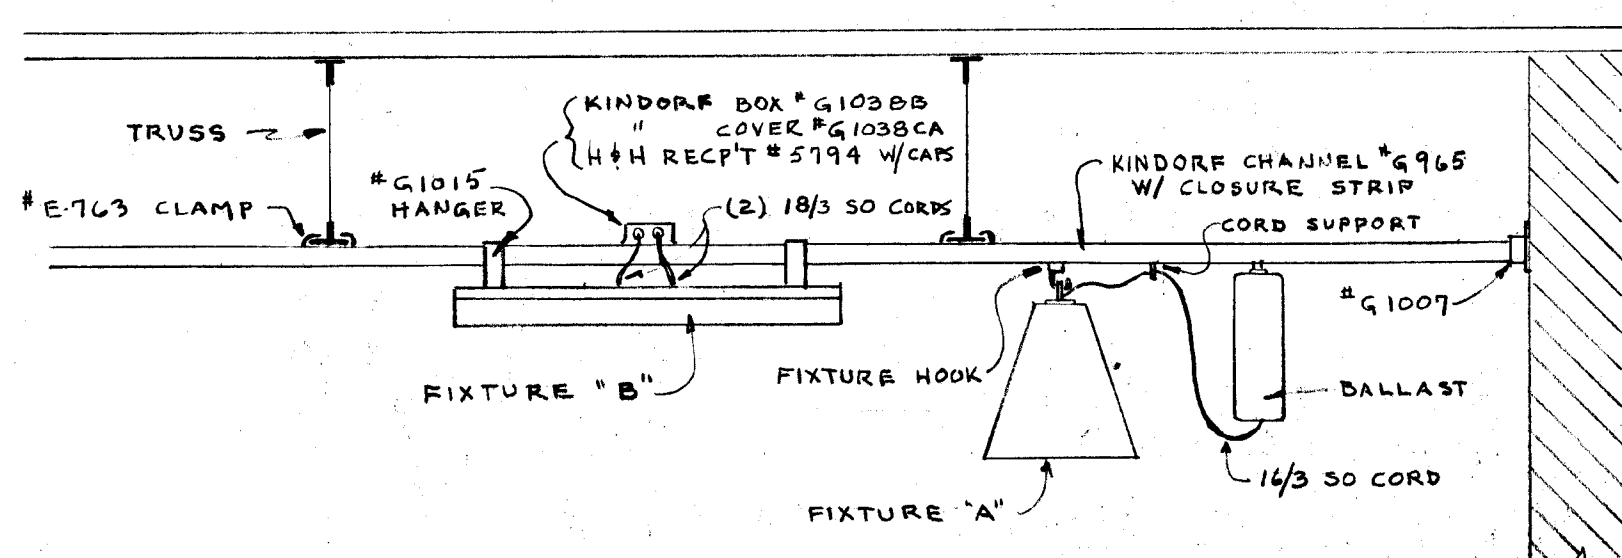


DETAIL "A"
NO SCALE

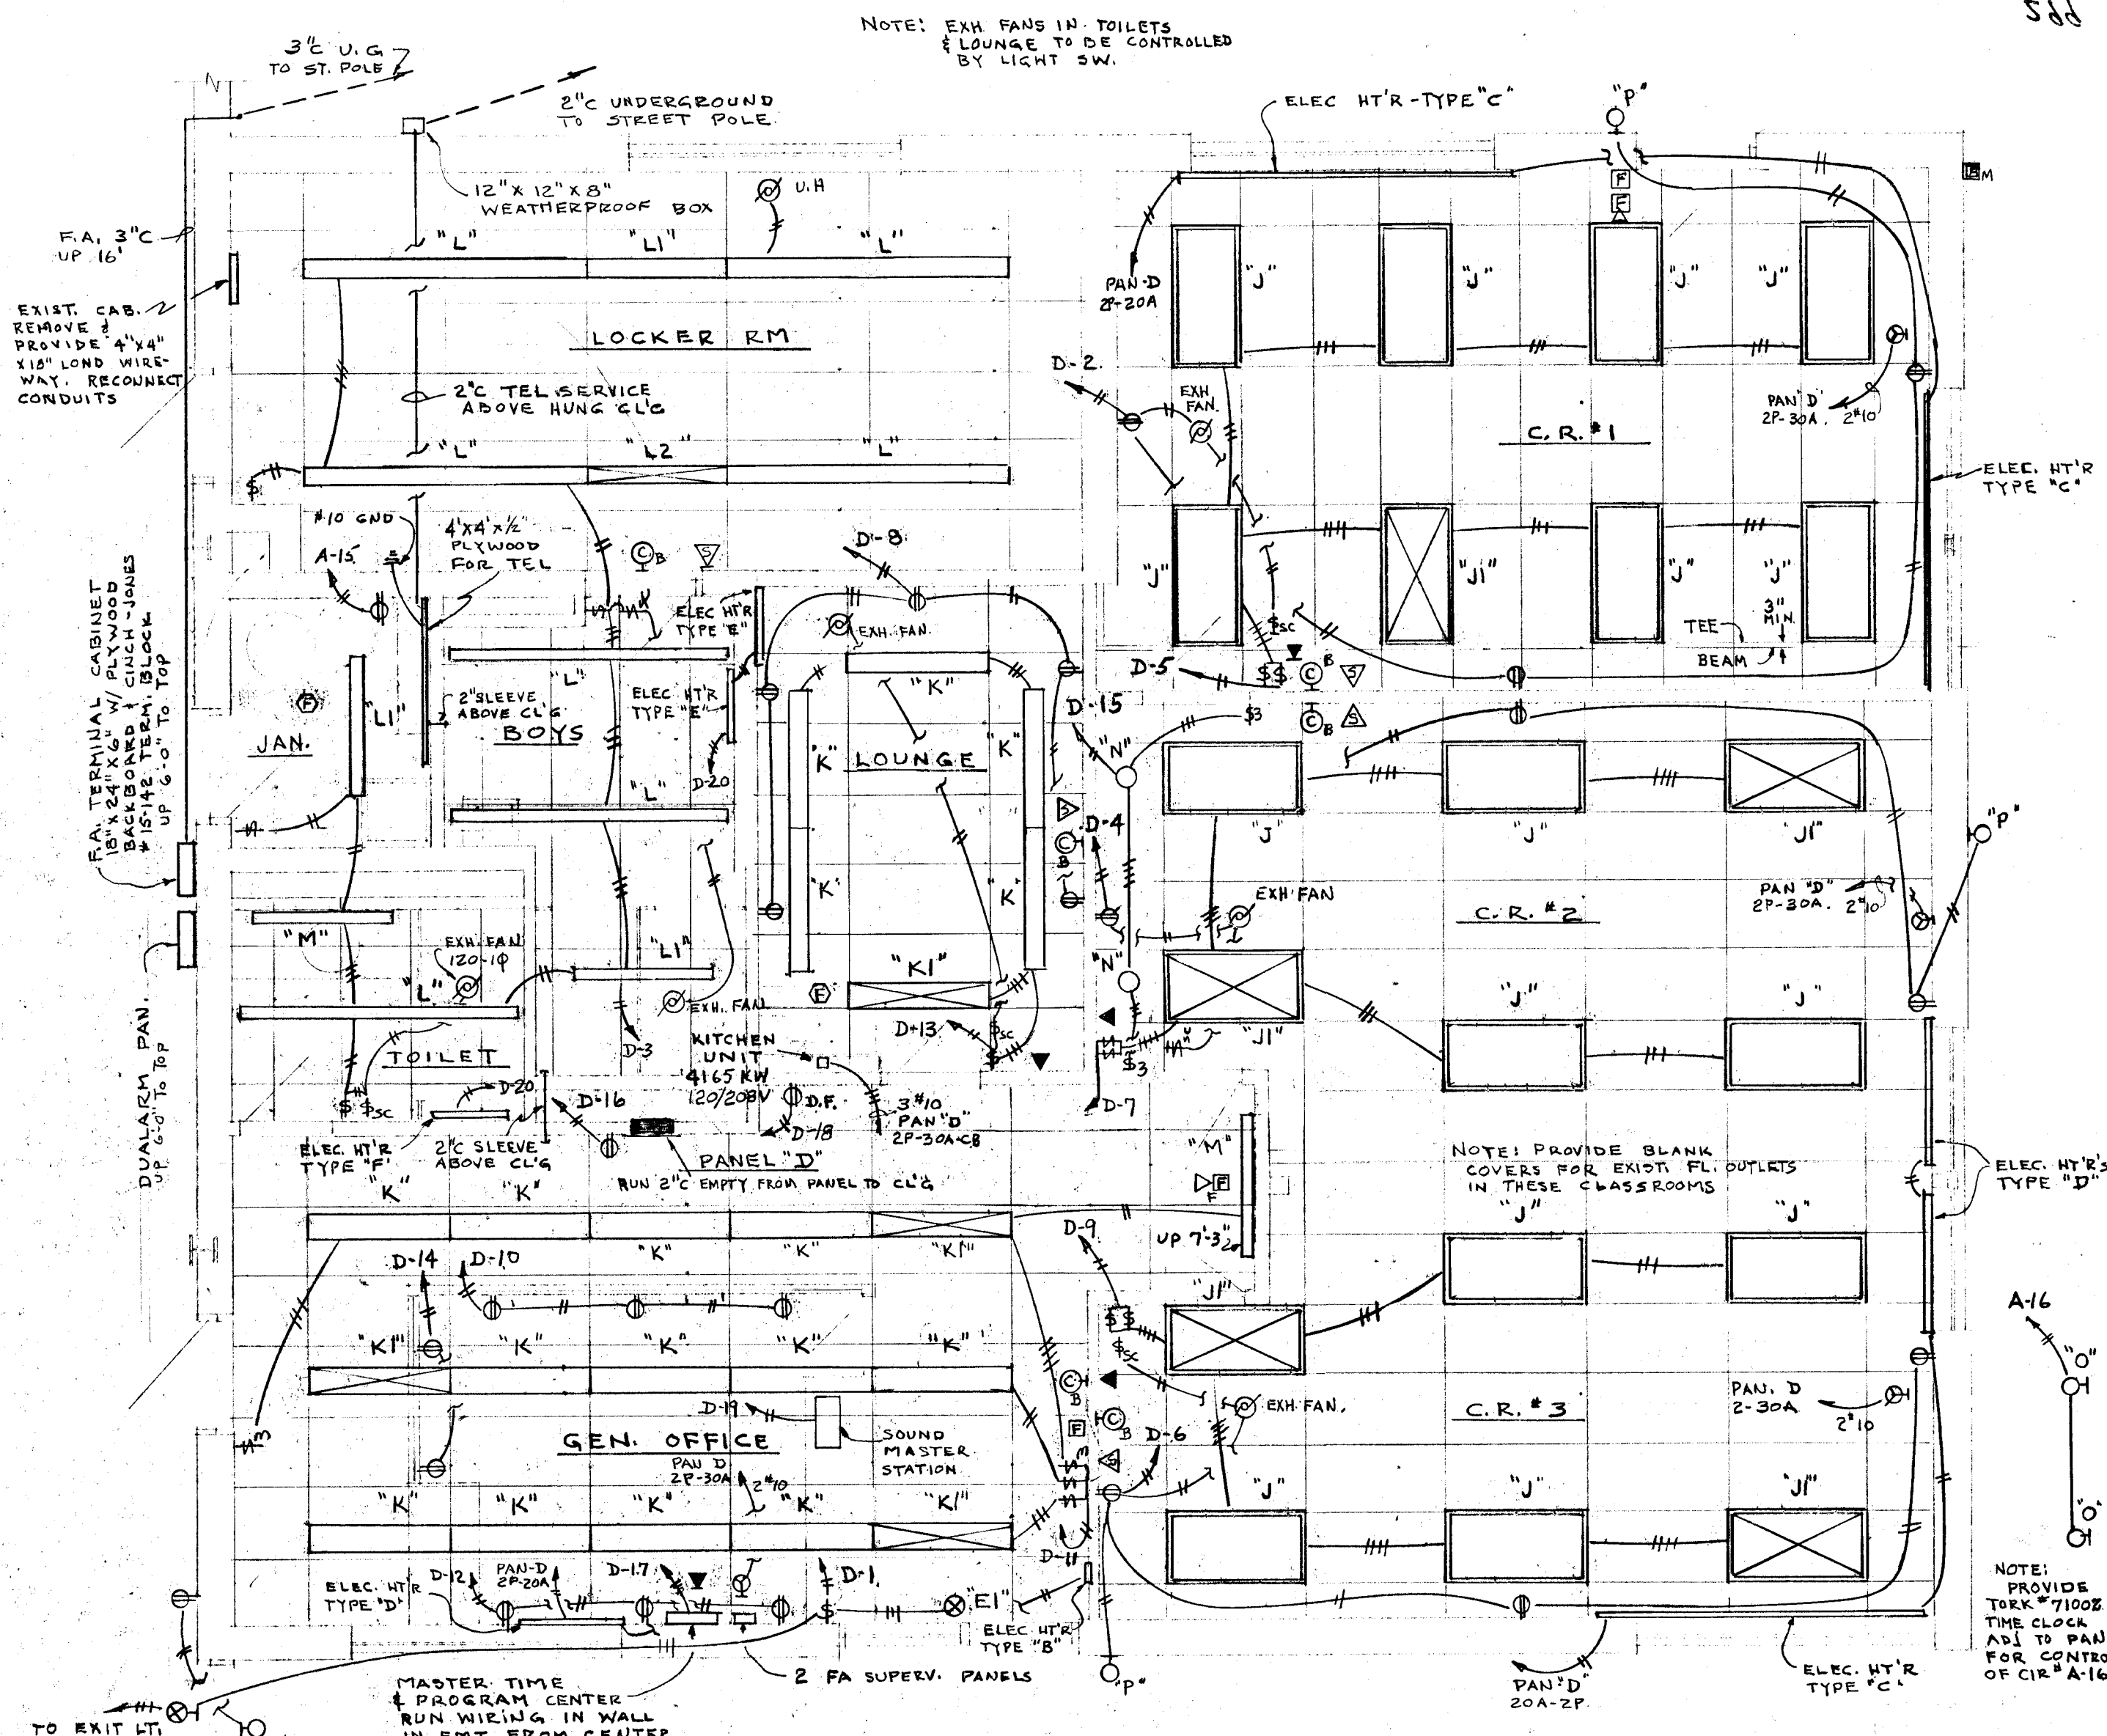

LIGHTING-POWER-SIGNAL PLAN
SCALE 1/4" = 1'-0"

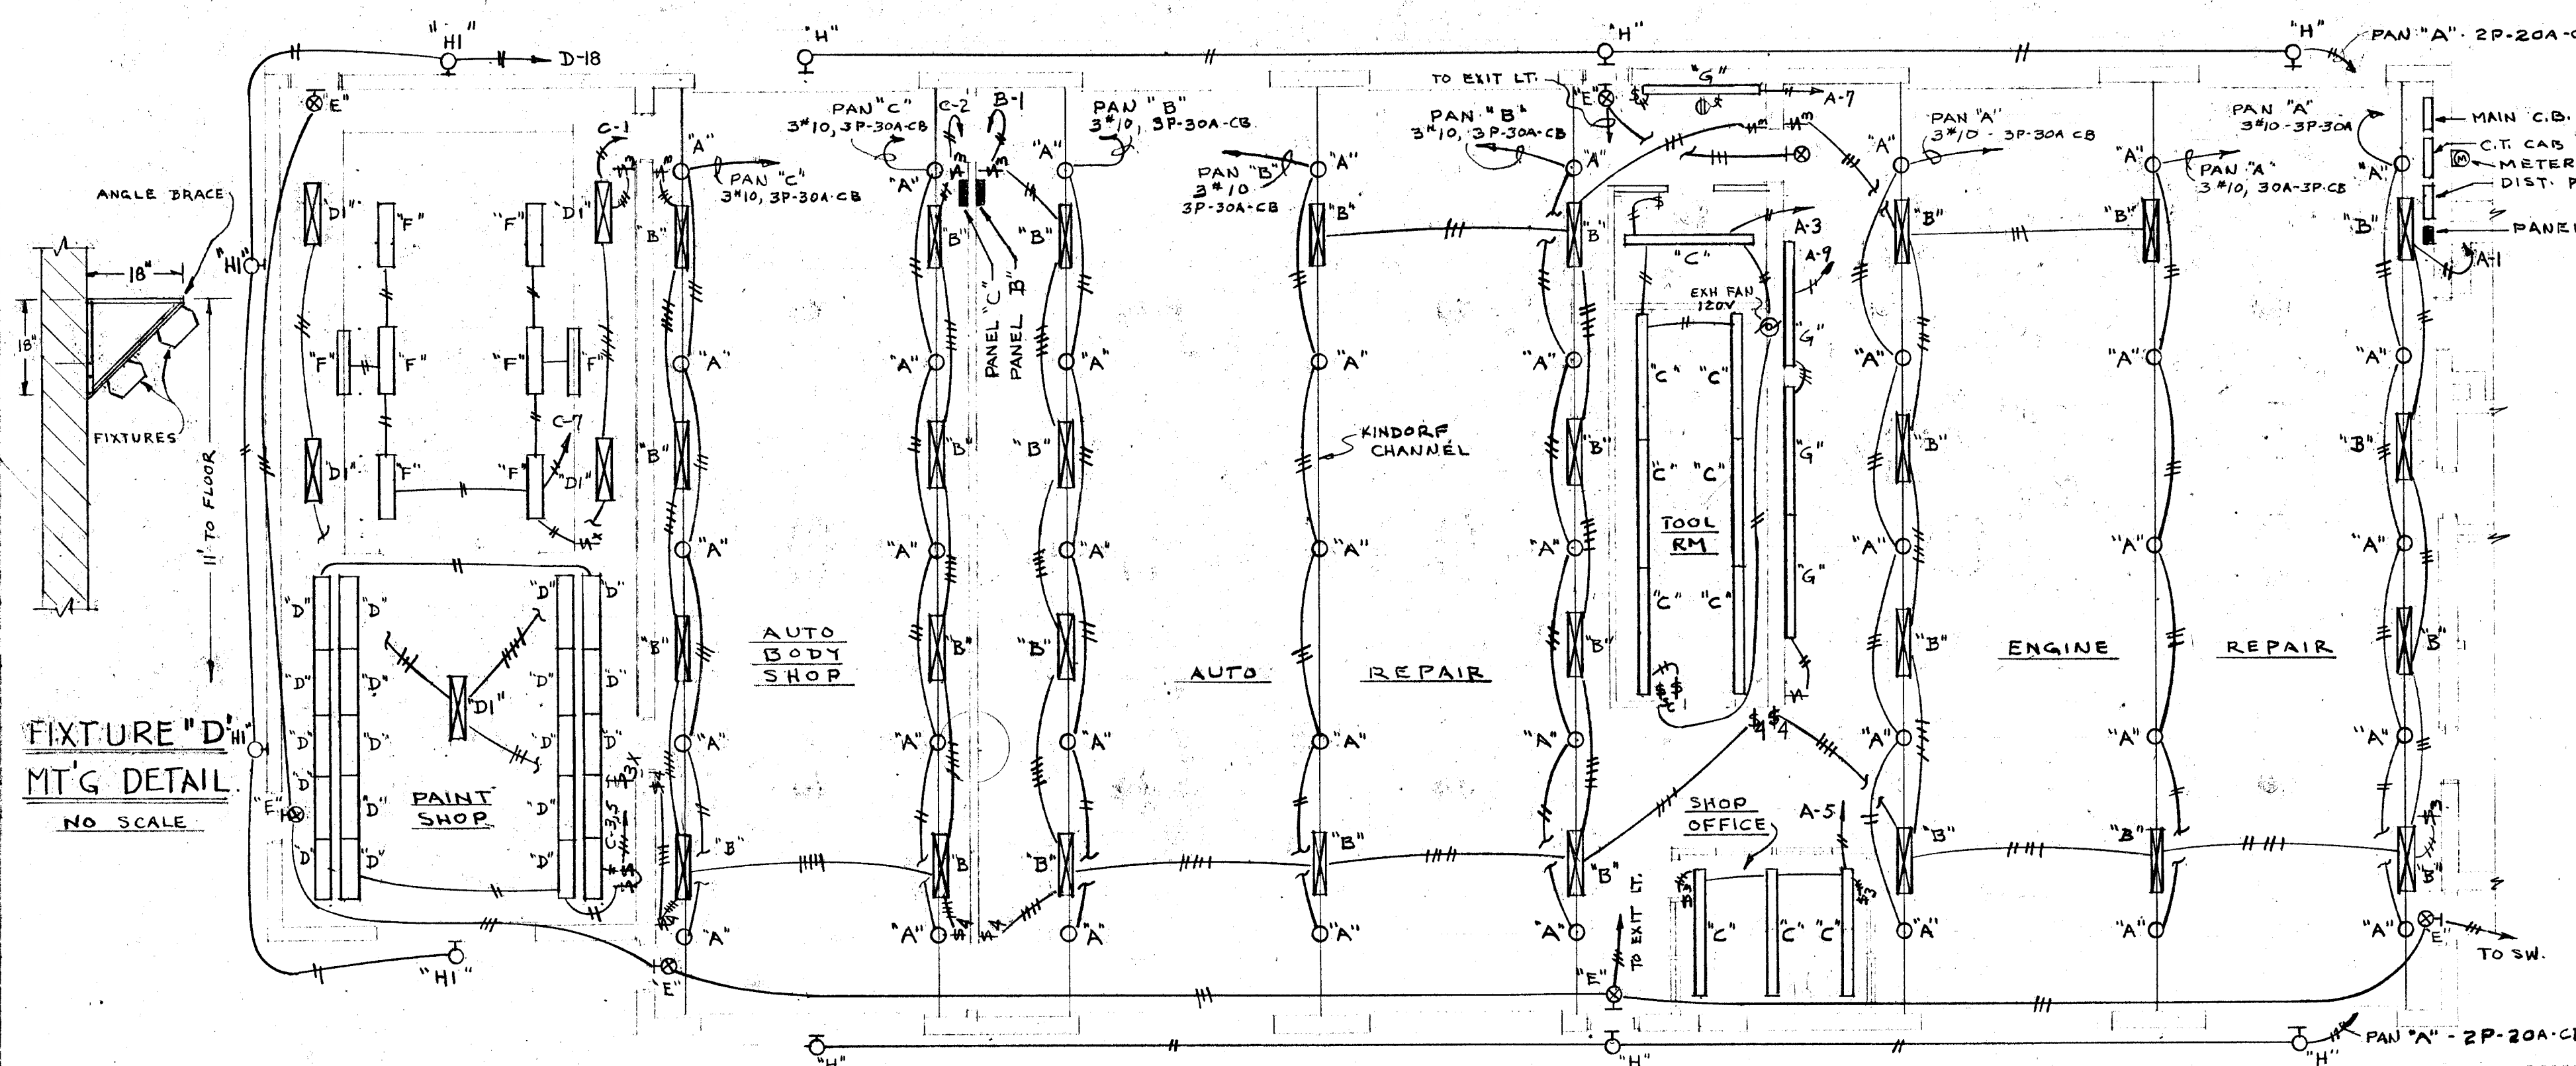

LIGHTING PLAN
SCALE 1/8" = 1'-0"

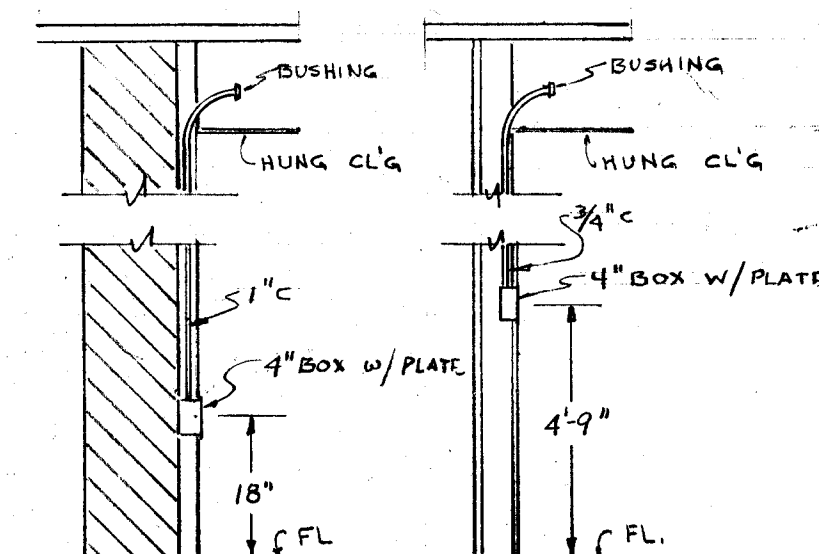

TELEPHONE OUTLET DETAIL
NO SCALE

CITY OF HARTFORD, CONNECTICUT DEPARTMENT OF PUBLIC WORKS		
ELECTRICAL FOR AUTO MECHANICS SHOP 31 WAWARME AVE. HARTFORD CONN.		DWG. NO. E1
SUBMITTED R. S. Cannon	RECOMMENDED W. S. Reed CITY ARCHITECT	APPROVED George J. Heppner CITY ENGINEER
DESIGN R.G.B.	DRAWN R.G.B.	DAYBOOK NO. 010344-G
TRACED	CHECK	DATE MAY 24, 1972

VERIFY EXISTING
CONDITIONS AND
DIMENSIONS AT
BUILDING