


- LEGEND**
- H :: HELCO M.H.
 - S :: HELCO BOX
 - S :: SEWER M.H.
 - T :: SNET M.H.
 - ST :: STEAM M.H.
 - GG :: GAS GATE
 - WB :: WATER BUREAU
 - FH :: FIRE HYDRANT
 - FB :: FIRE BOX
 - LP :: LIGHT POLE
 - CB :: CATCH BASIN

NOTE:
Where size of radius is indicated
new radius curb is to be installed.

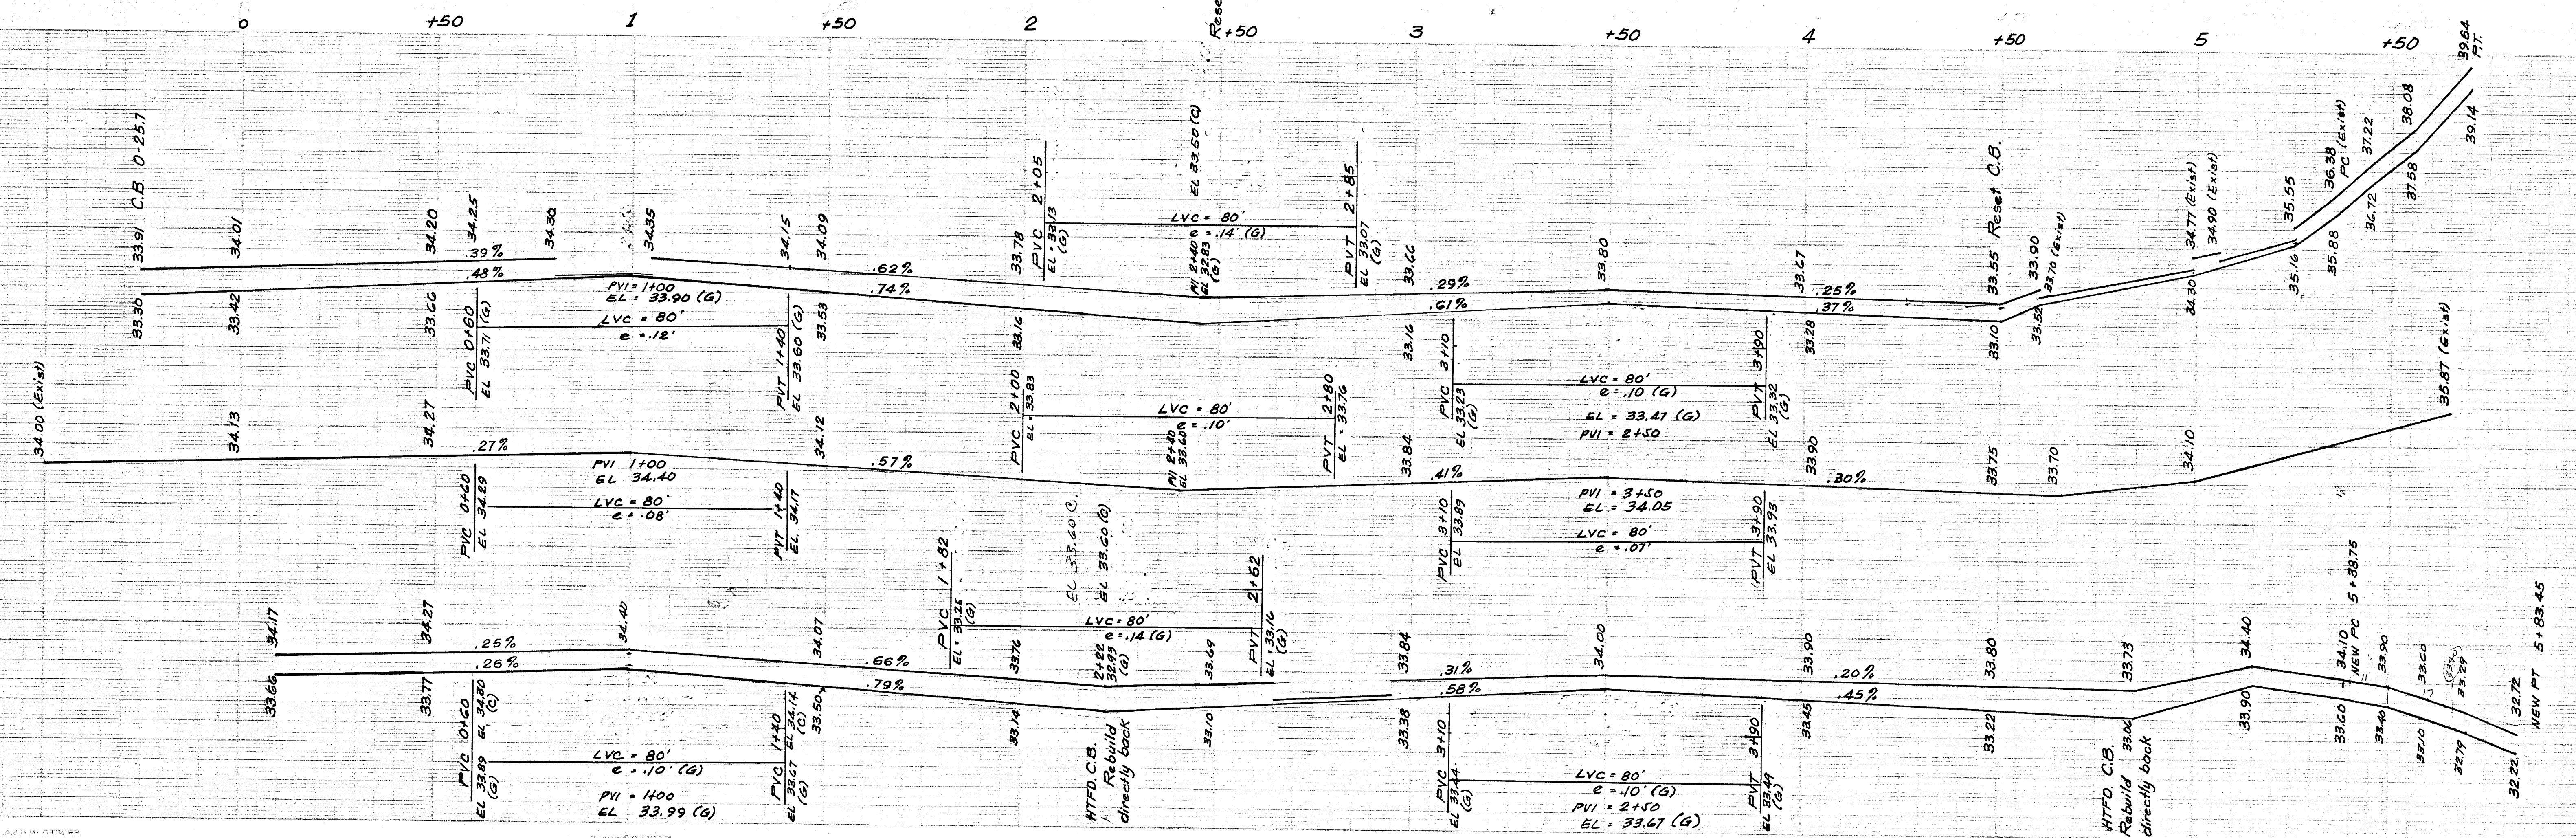

CITY OF HARTFORD, CONNECTICUT DEPARTMENT OF ENGINEERING		
SHELDON STREET PLAN AND PROFILE		
SCALE: H 1"=20' V 1"=2'		
SUBMITTED: <i>[Signature]</i> DIVISION ENGINEER	RECOMMENDED: <i>[Signature]</i> ASSIST. CITY ENG.	APPROVED: <i>[Signature]</i> CITY ENGINEER
DESIGN: G.E.C.	DAYBOOK NO. 010352	
CHECKED: M.M.C.	DATE: JUNE, 1972	

Notes: