


NOTES

1. PROVIDE TWO NEW 2-POLE CIRCUIT BREAKERS IN EXISTING PANEL IN FIELD HOUSE FOR FLOODLIGHT AND WALKWAY LIGHTING CIRCUITS.
2. PROVIDE A 2-POLE TIME CLOCK WITH ASTRONOMICAL DIAL AND RESERVE POWER EQUAL TO TORQUE 7202ZL. INSTALL TIME CLOCK IN WALKWAY LIGHTING CIRCUIT. LOCATE IN FIELD HOUSE.
3. CONNECT RECEPTACLE CIRCUIT TO EXISTING 1-POLE CIRCUIT BREAKER IN PANEL.
4. AIM ALL FLOODLIGHTS AS DIRECTED BY THE ENGINEER.
5. ALL U.G. CONDUITS TO BE 2'-6" MINIMUM BELOW GRADE.

SYMBOLS


- △ — FLOODLIGHT - SEE DETAIL.
 □ — WALKWAY LIGHT - SEE DETAIL.

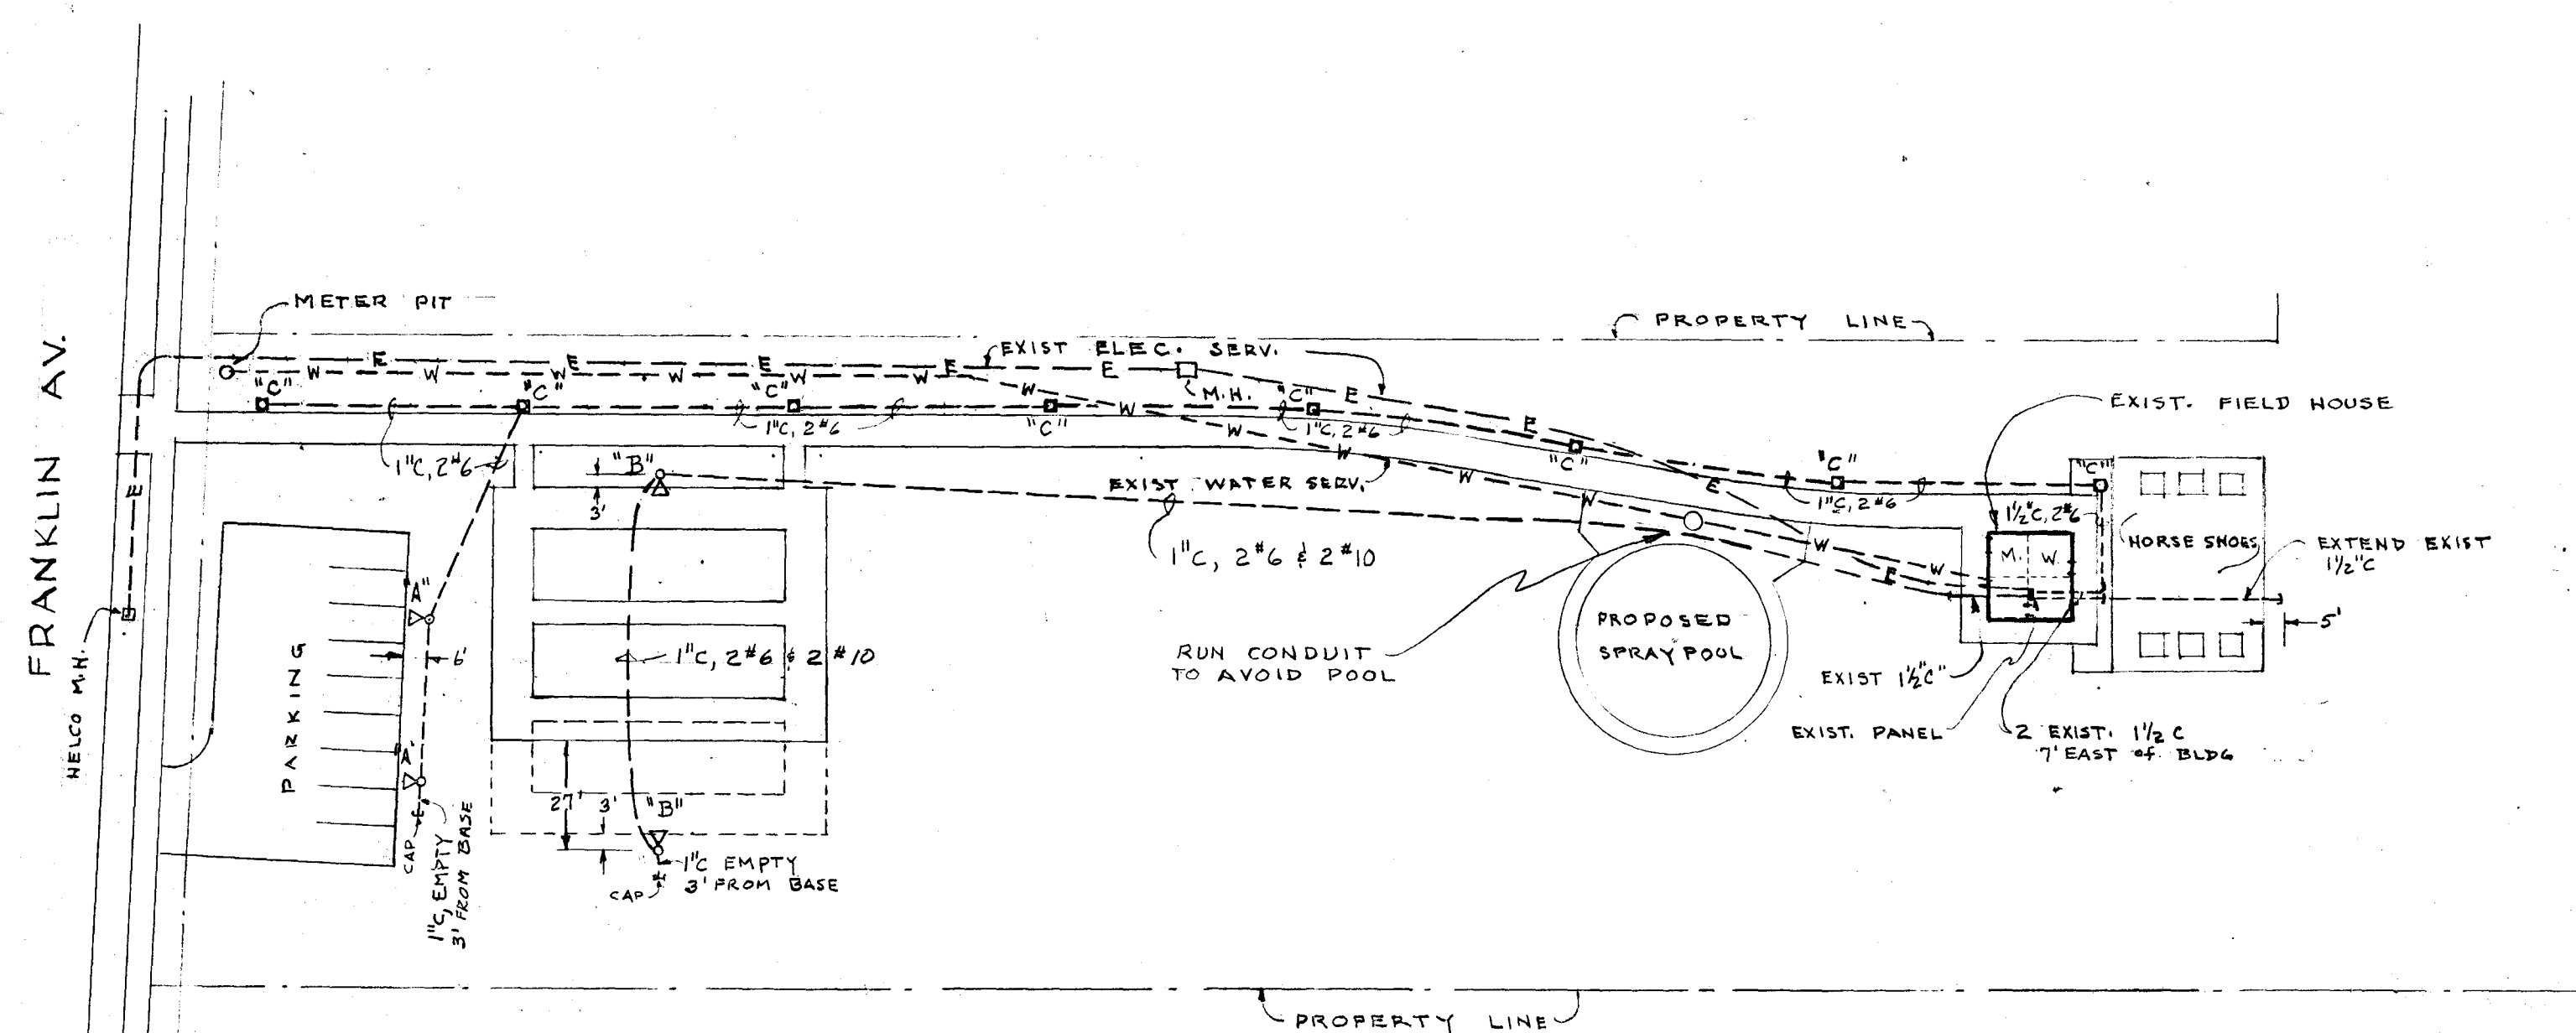


BOCCIE COURTS & WALKWAY LIGHTING & ELECTRICAL PLAN

SCALE 1" = 40'


DETAIL OF POLE "A"

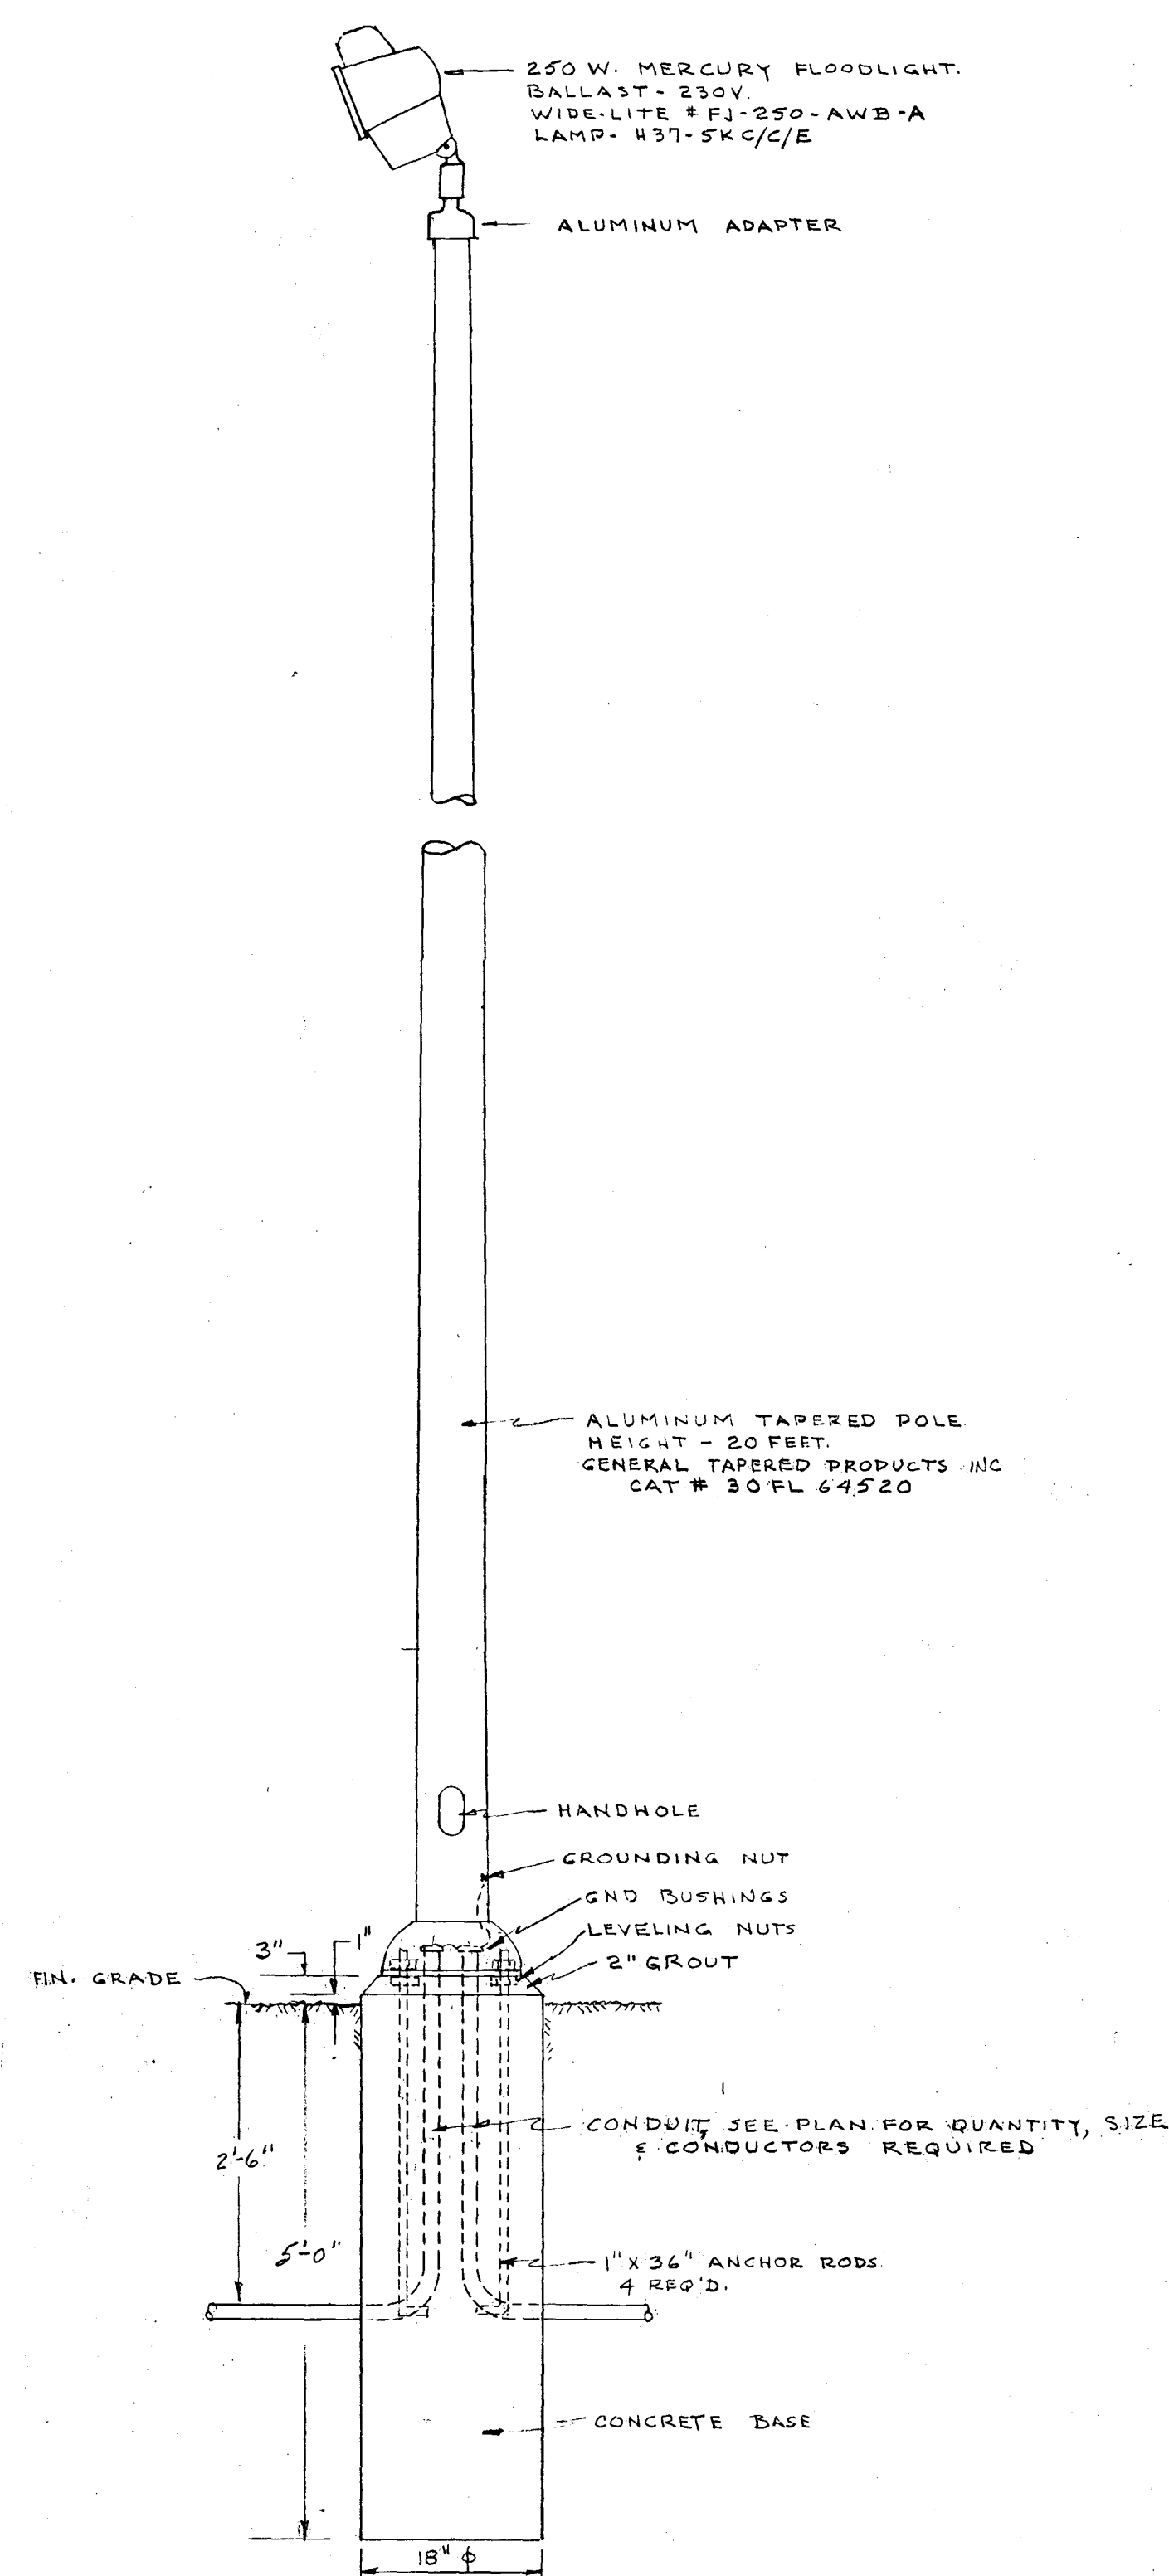

DETAIL OF POLE "B"

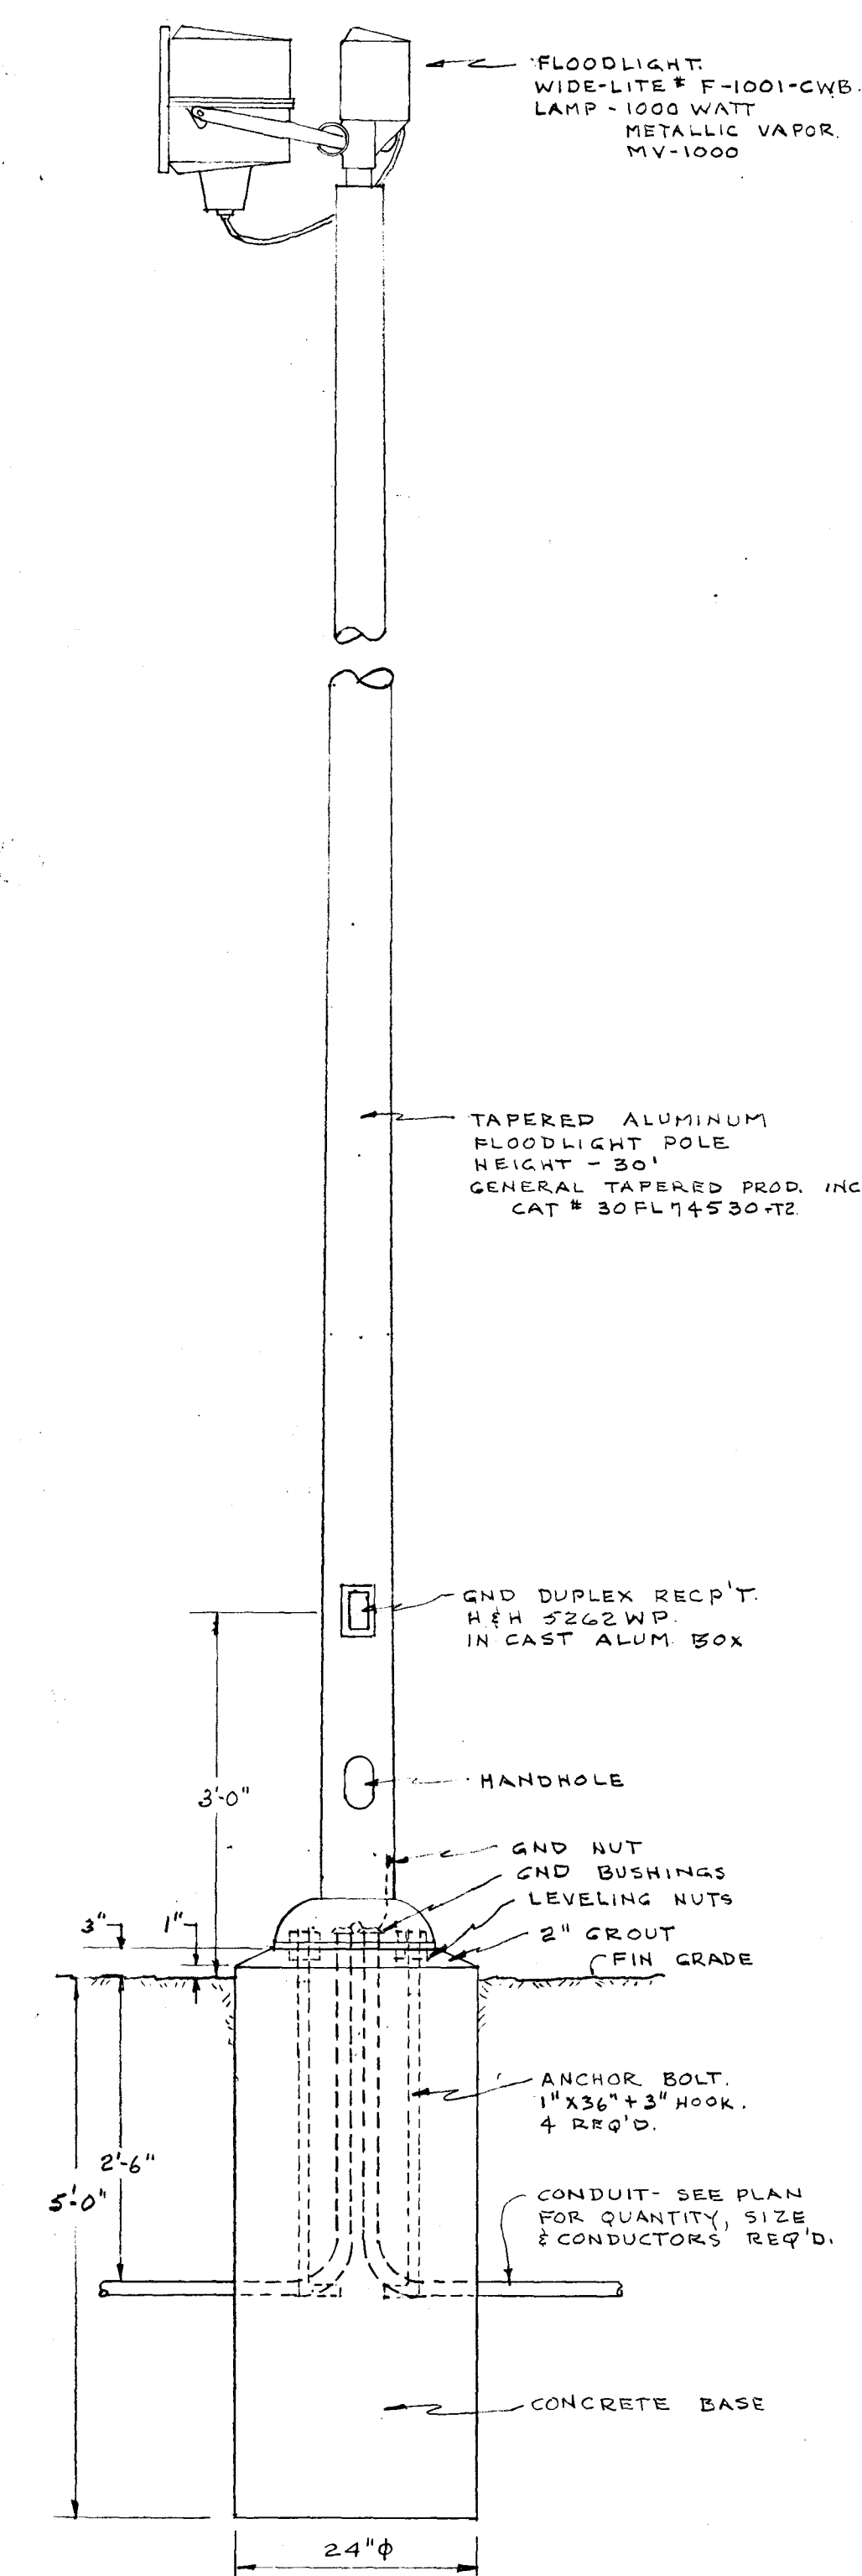

DETAIL OF POLE "C"

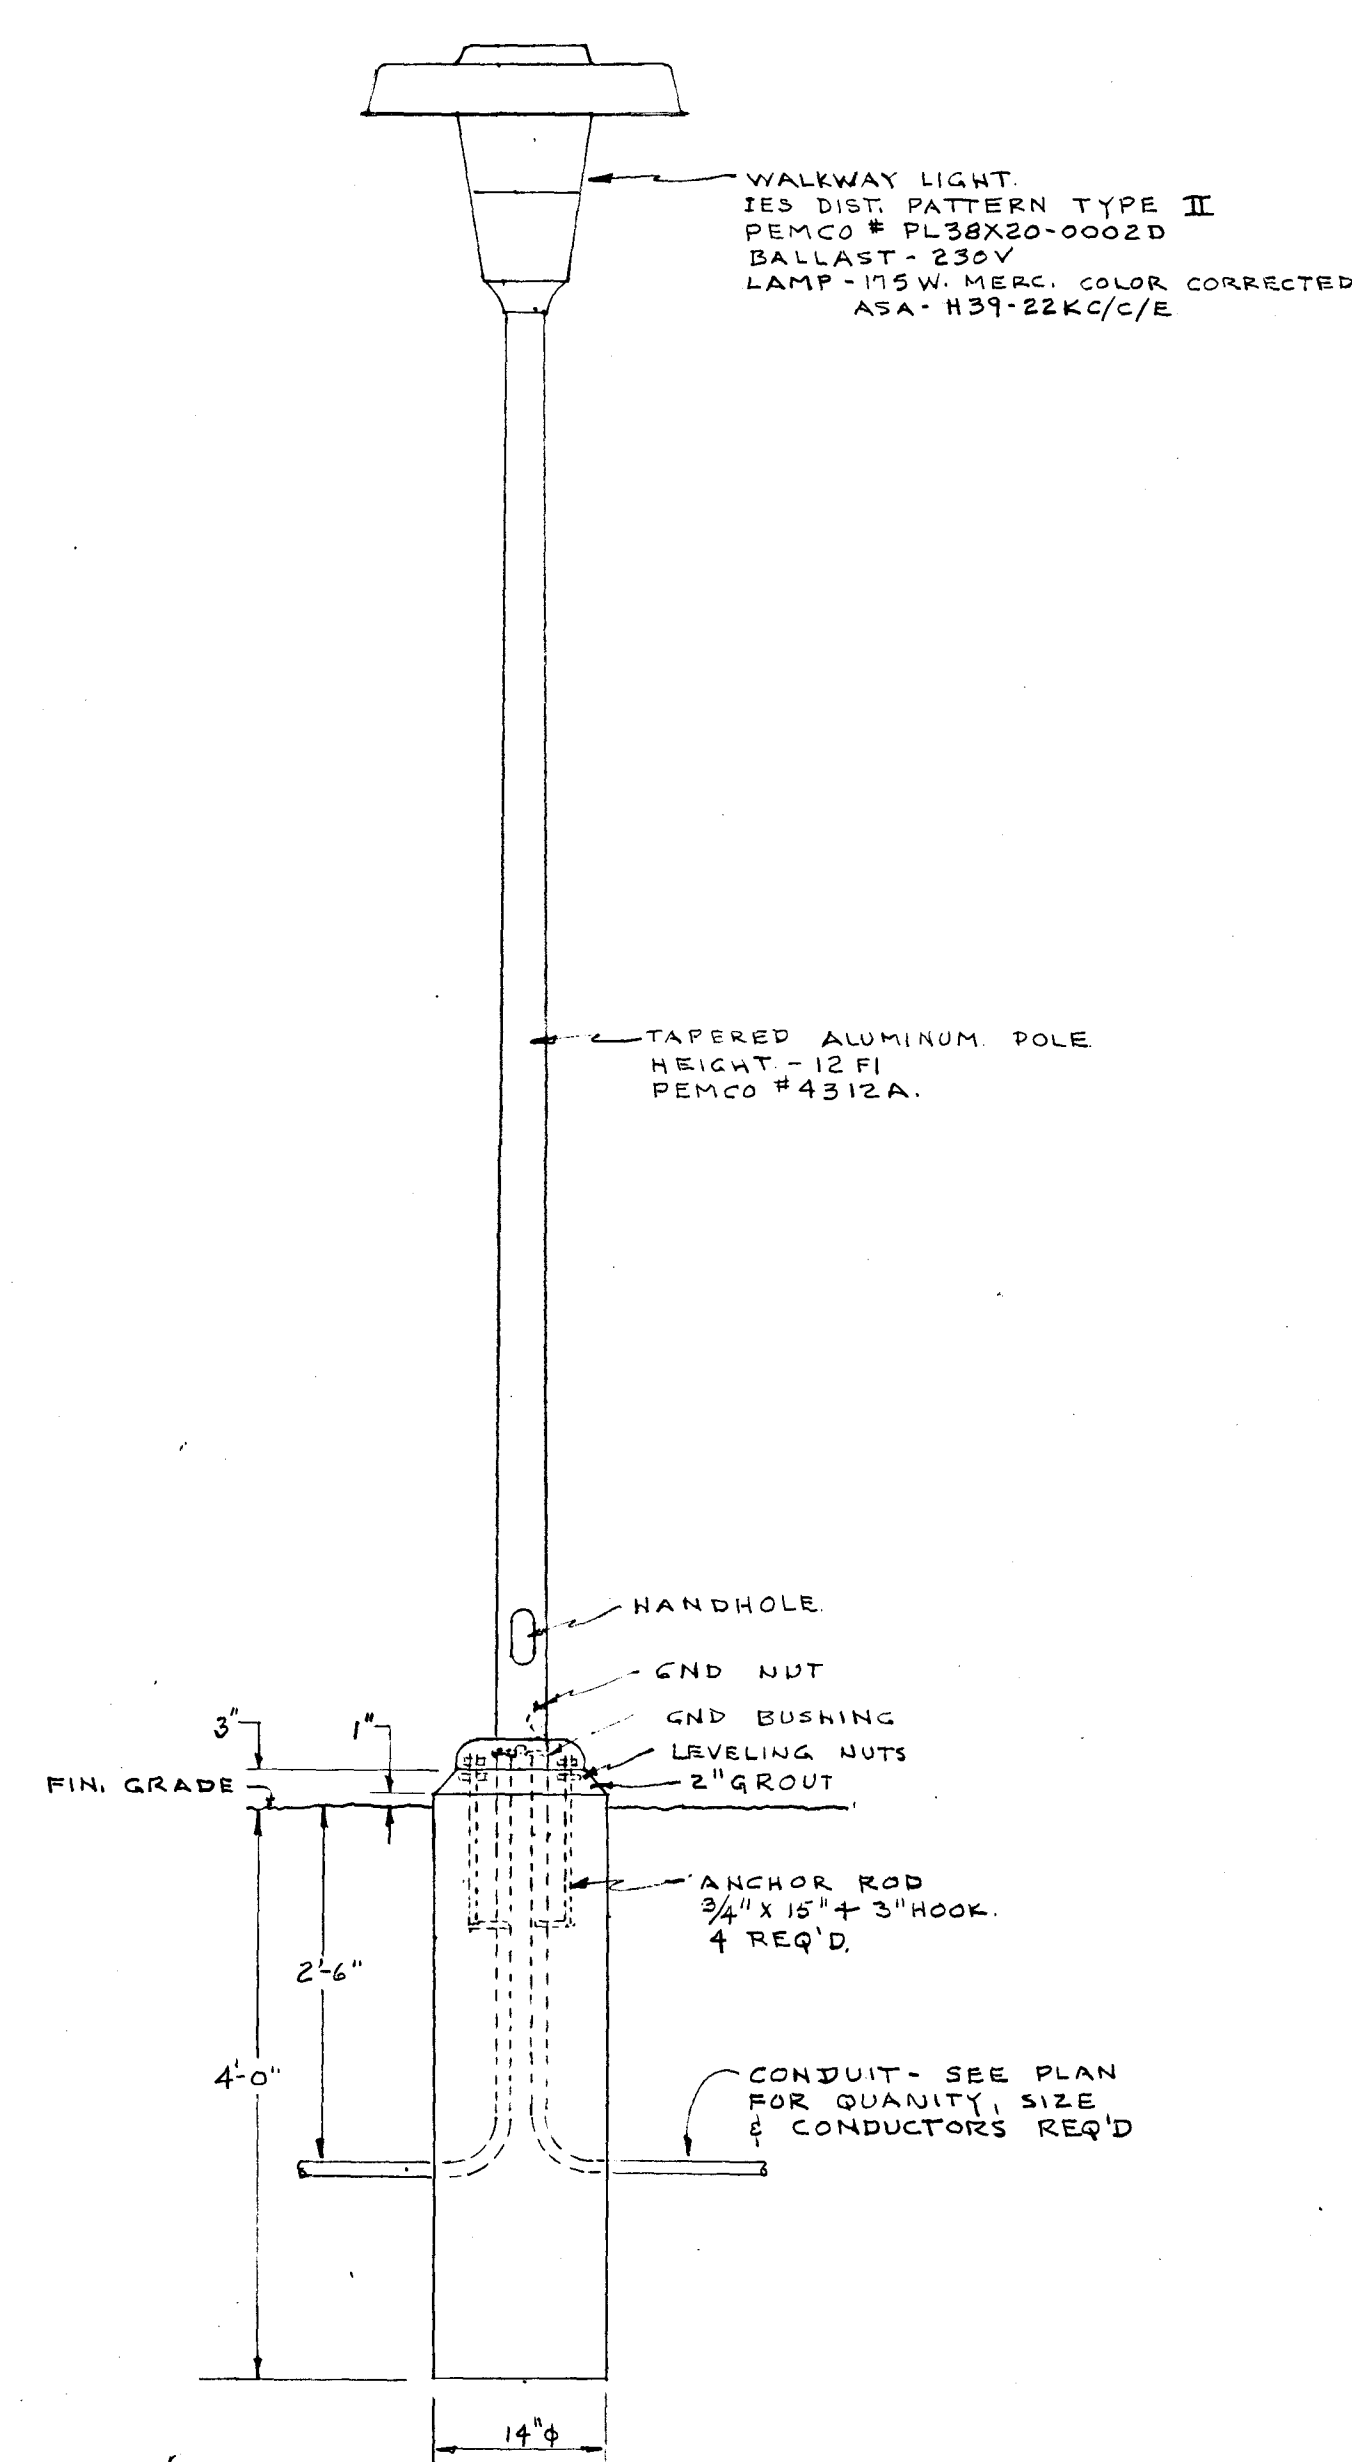

ELECTRICAL		SHEET F OF 6	
CITY OF HARTFORD, CONNECTICUT DEPARTMENT OF ENGINEERING			
SITE IMPROVEMENTS PHASE II SOUTH END PLAYGROUND HARTFORD, CONNECTICUT			
SUBMITTED	RECOMMENDED	APPROVED	
DIVISION ENGINEER	ASST. CITY ENG.	CITY ENGINEER	
DESIGN R.G.B. DRAWN R.G.B.	DAYBOOK NO. 09932 F		
TRACED	CHECK	DATE	