


CURB:
R = 1017.167
I = 3°29'25"
T = 30.99
ARC = 61.96

CURB:
R = 1065.167
I = 3°29'25"
T = 32.45
ARC = 64.89

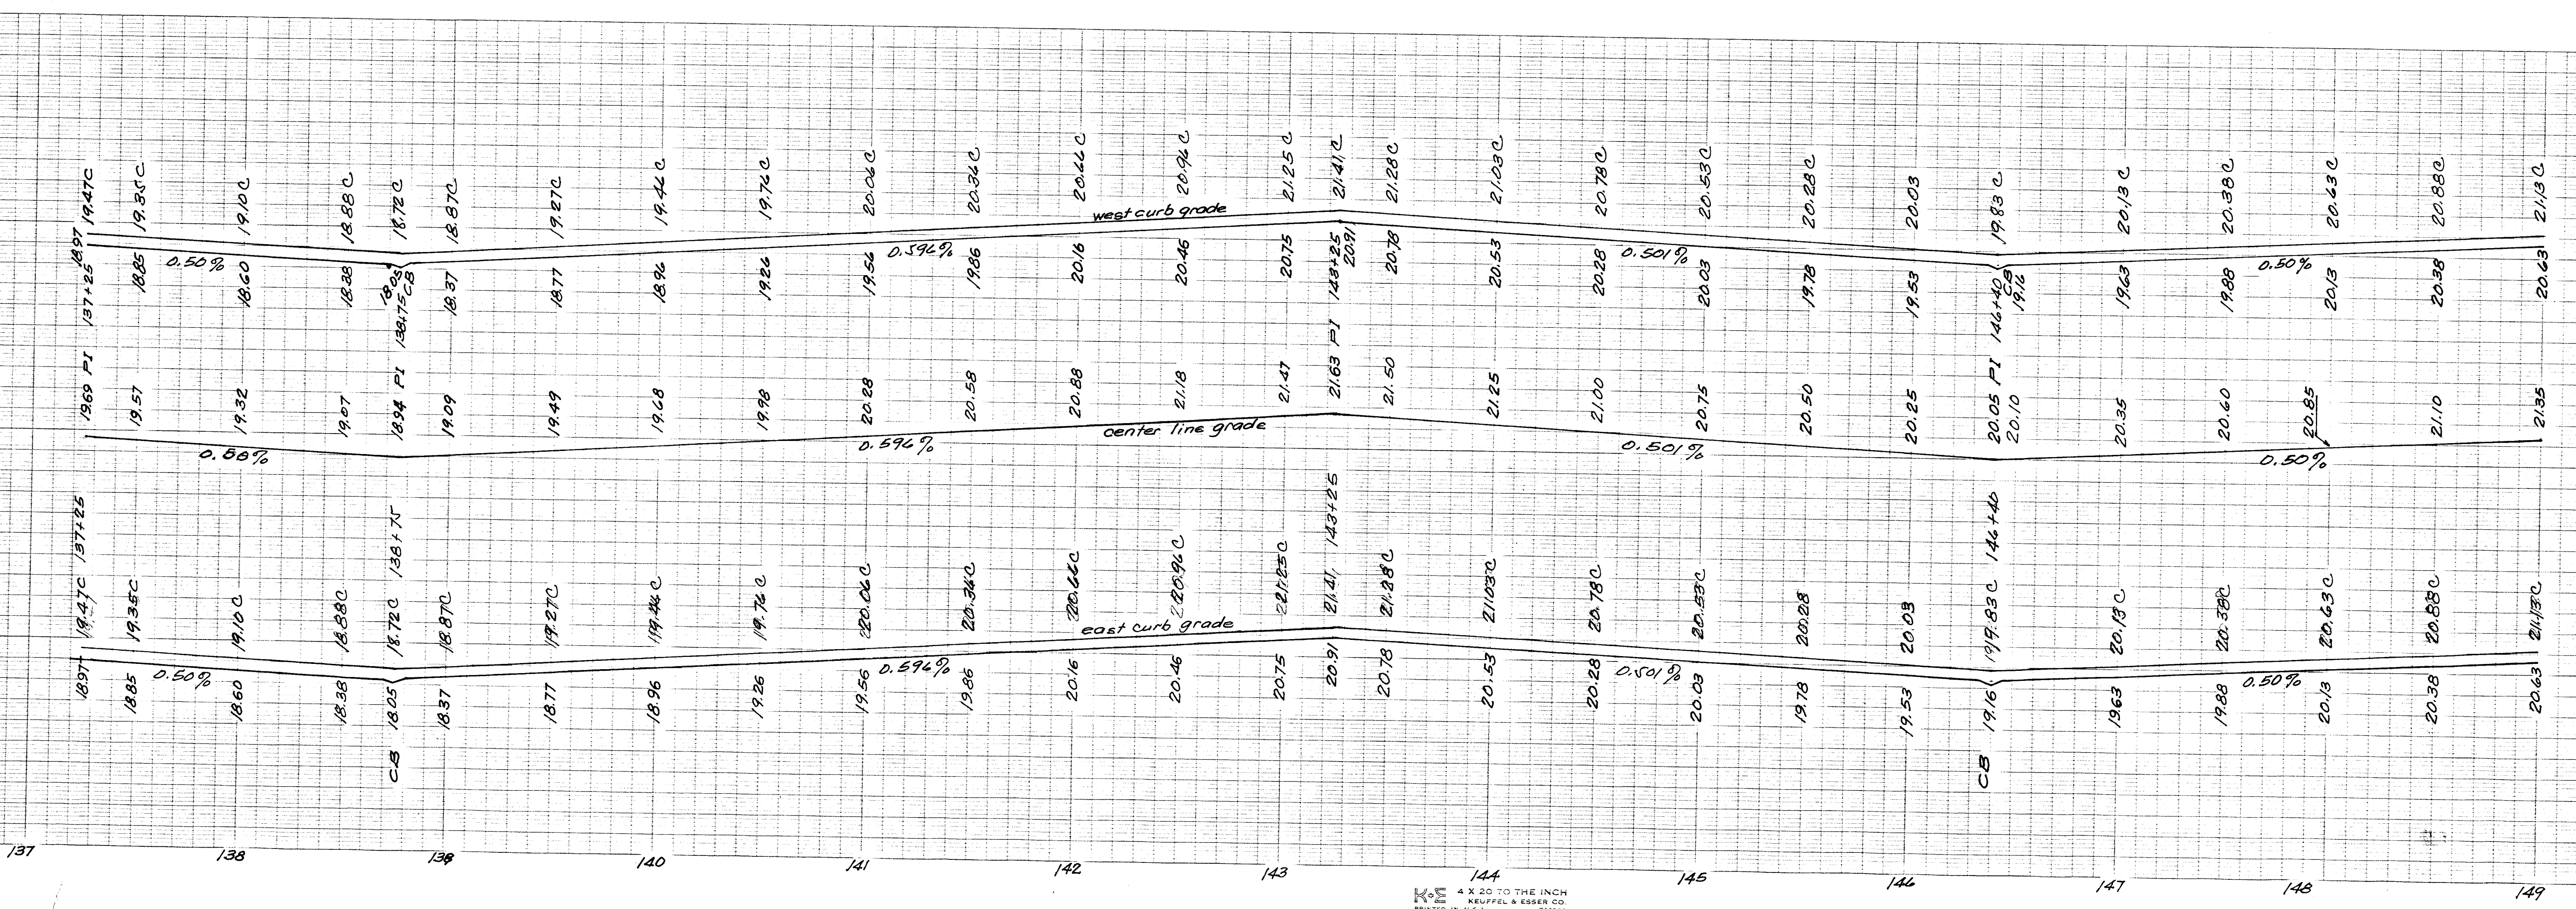

NOTE:
LOCATION OF UTILITIES AND DRIVEWAYS MAY BE CHANGED; FINAL LOCATION WILL BE FURNISHED OR MADE AVAILABLE PRIOR TO CONSTRUCTION; CONTRACTOR SHALL VERIFY ALL UNDERGROUND UTILITIES BY CALLING 1-800-922-4455

- LEGEND:
- CB - Catch Basin
 - SMH - Sanitary Manhole
 - SDMH - Special Precast Drain Manhole
 - TCB - Traffic Controller Base
 - FB - Fire Alarm Box
 - FH - Fire Hydrant
 - Tel - Telephone line
 - Helco - Helco line
 - Gas - Gas line
 - Water - Water pipeline
 - Storm - Storm pipeline
 - Sanitary - Sanitary pipeline
 - LP - Light Pole
 - HDP - Heavy Duty Pole

SHEET 3 OF 4

CITY OF HARTFORD CONNECTICUT
DEPARTMENT OF PUBLIC WORKS
BUREAU OF ENGINEERING SERVICES

PLAN AND PROFILE OF
WESTON STREET
NORTH MEADOWS PROJECT

SUBMITTED: H.M. Clark
RECOMMENDED: [Signature]
APPROVED: [Signature]

DIVISION ENGINEER: [Signature]
CHIEF OF ENG. SERV.: [Signature]
ASS. CHIEF OF ENG. SERV.: [Signature]

DRAWN: GSC
SCALE: 1" = 40'
CHECKED: MTC
VER: 1" = 4'

DAYBOOK No. 010539-C
DATE: SEPT. 1975