


181
4 1/2

181
4 1/2

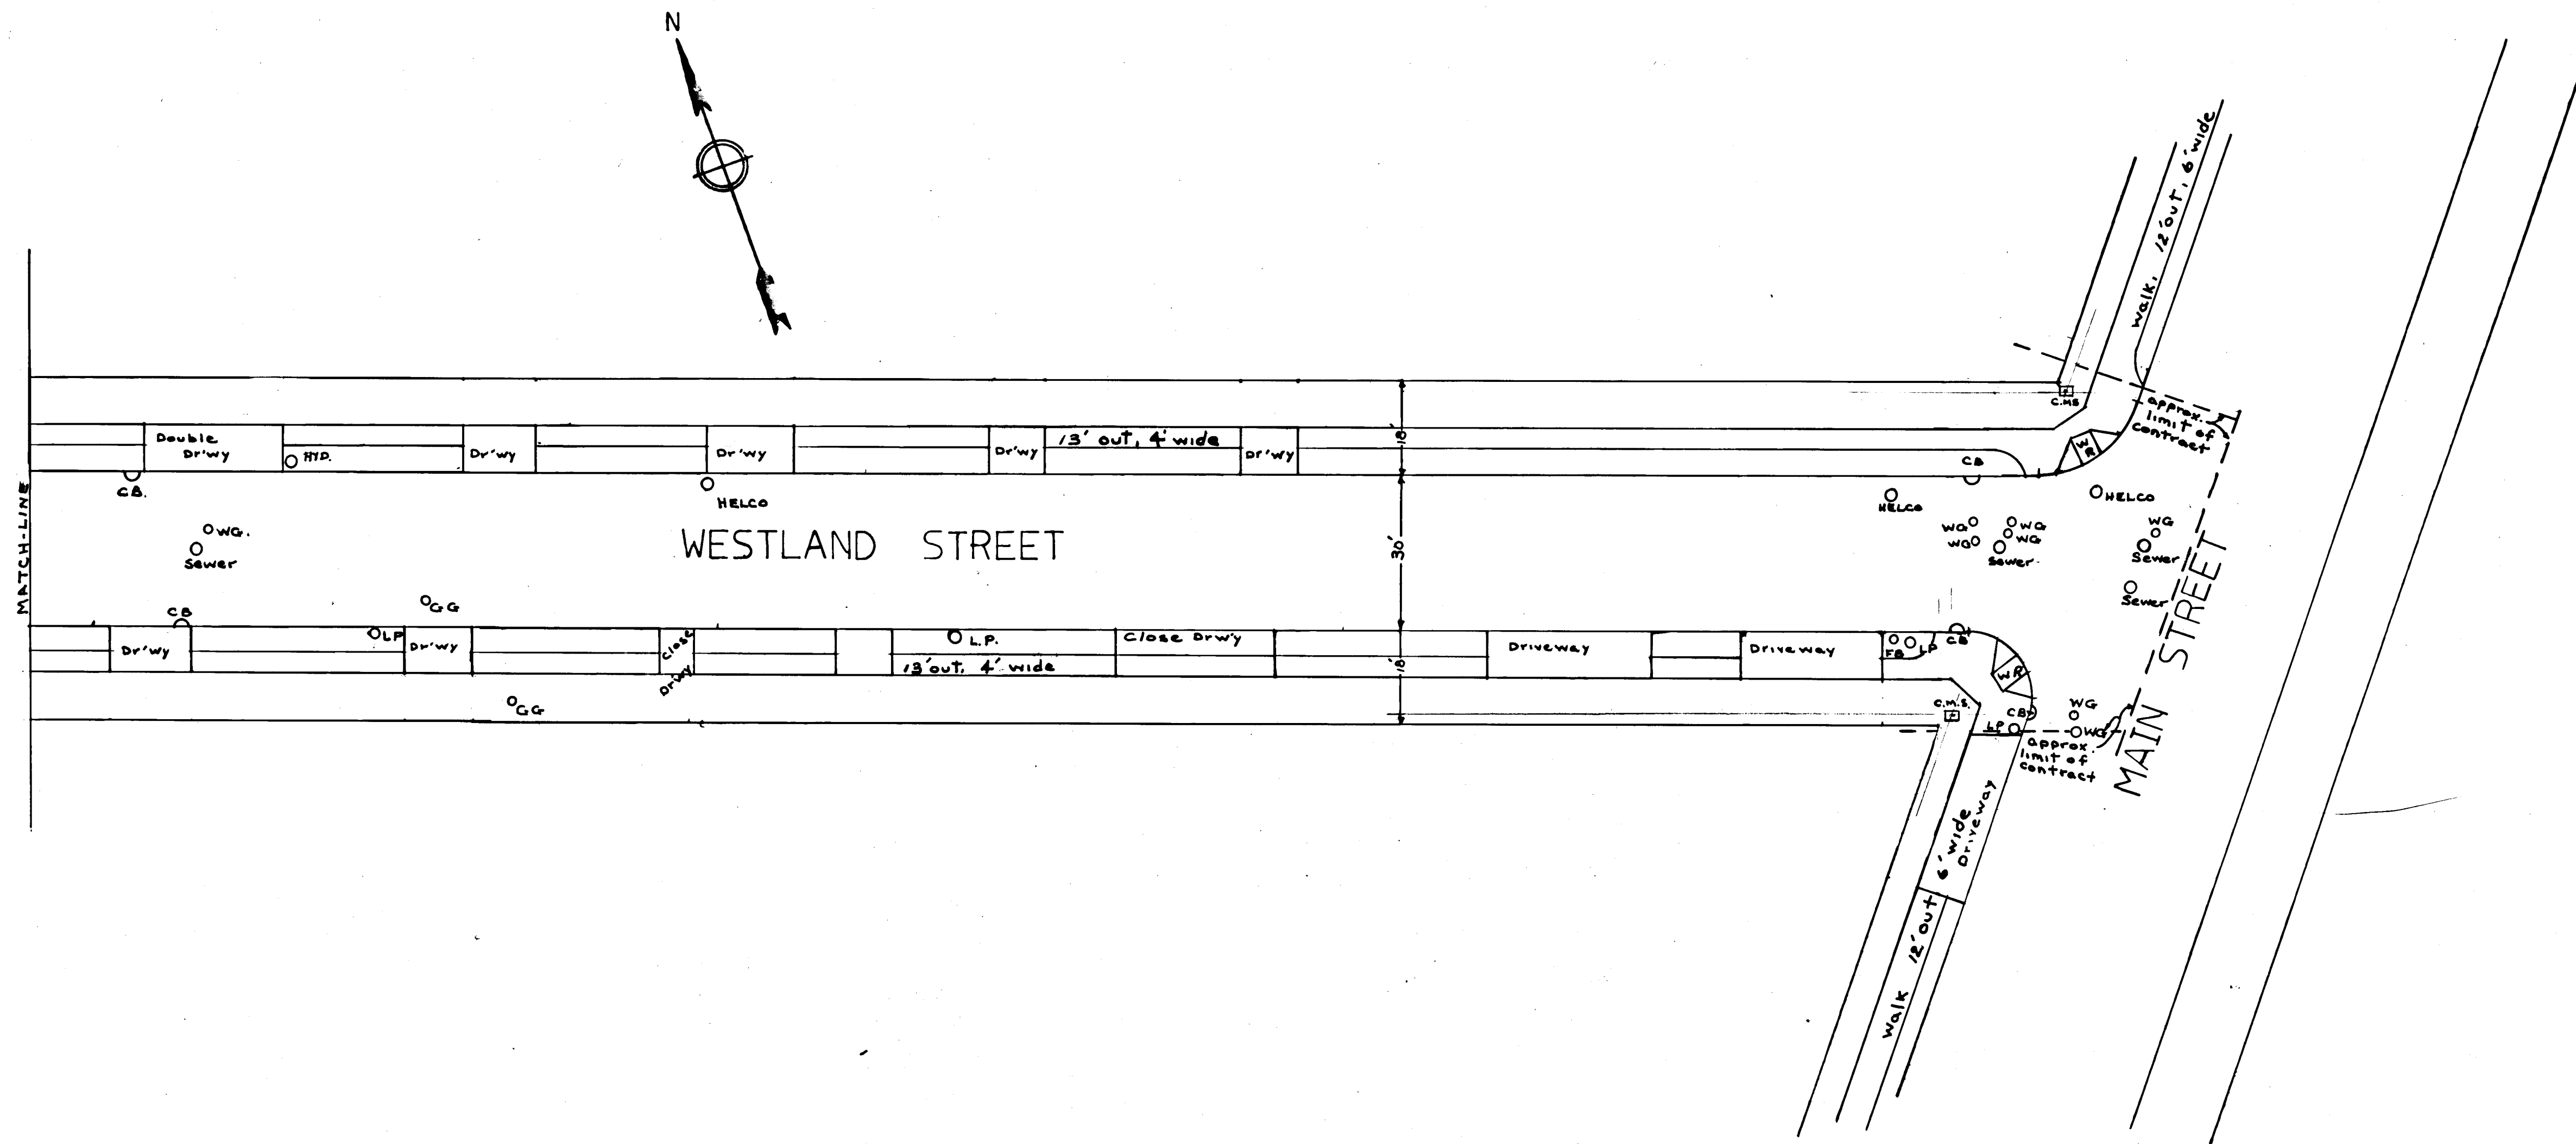

LEGEND:

- LP=Light Pole
- TP=Traffic Pole
- HYD= Fire Hydrant
- CB=Existing Catch Basin
- WR=Wheelchair Ramp
- WG=Water Gate
- GG=Gas Gate
- FB= Fire Box

Page 1 of 2

CITY OF HARTFORD, CONNECTICUT DEPARTMENT OF PUBLIC WORKS BUREAU OF ENGINEERING SERVICES		
PLAN AND PROFILE WESTLAND STREET (MAIN ST. TO ACTON ST.)		
SUBMITTED [Signature] DIVISION ENGINEER	RECOMMENDED [Signature] CHIEF OF ENG. SERV.	APPROVED [Signature] ASS. CHIEF OF ENG.
DRAWN BY R.S.R.	SCALE H=1"=20' V=1"=2'	DAYBOOK NO. 010583-A DATE APRIL 7, 1977

181
4 1/2

181
4 1/2

PRINTED IN U.S.A. BY K&B
K&B ENGINEERING & DESIGN CO.
100 REAR & JEFFERSON
06105

PRINTED IN U.S.A. BY K&B
K&B ENGINEERING & DESIGN CO.
100 REAR & JEFFERSON
06105