


TOWN OF WETHERSFIELD

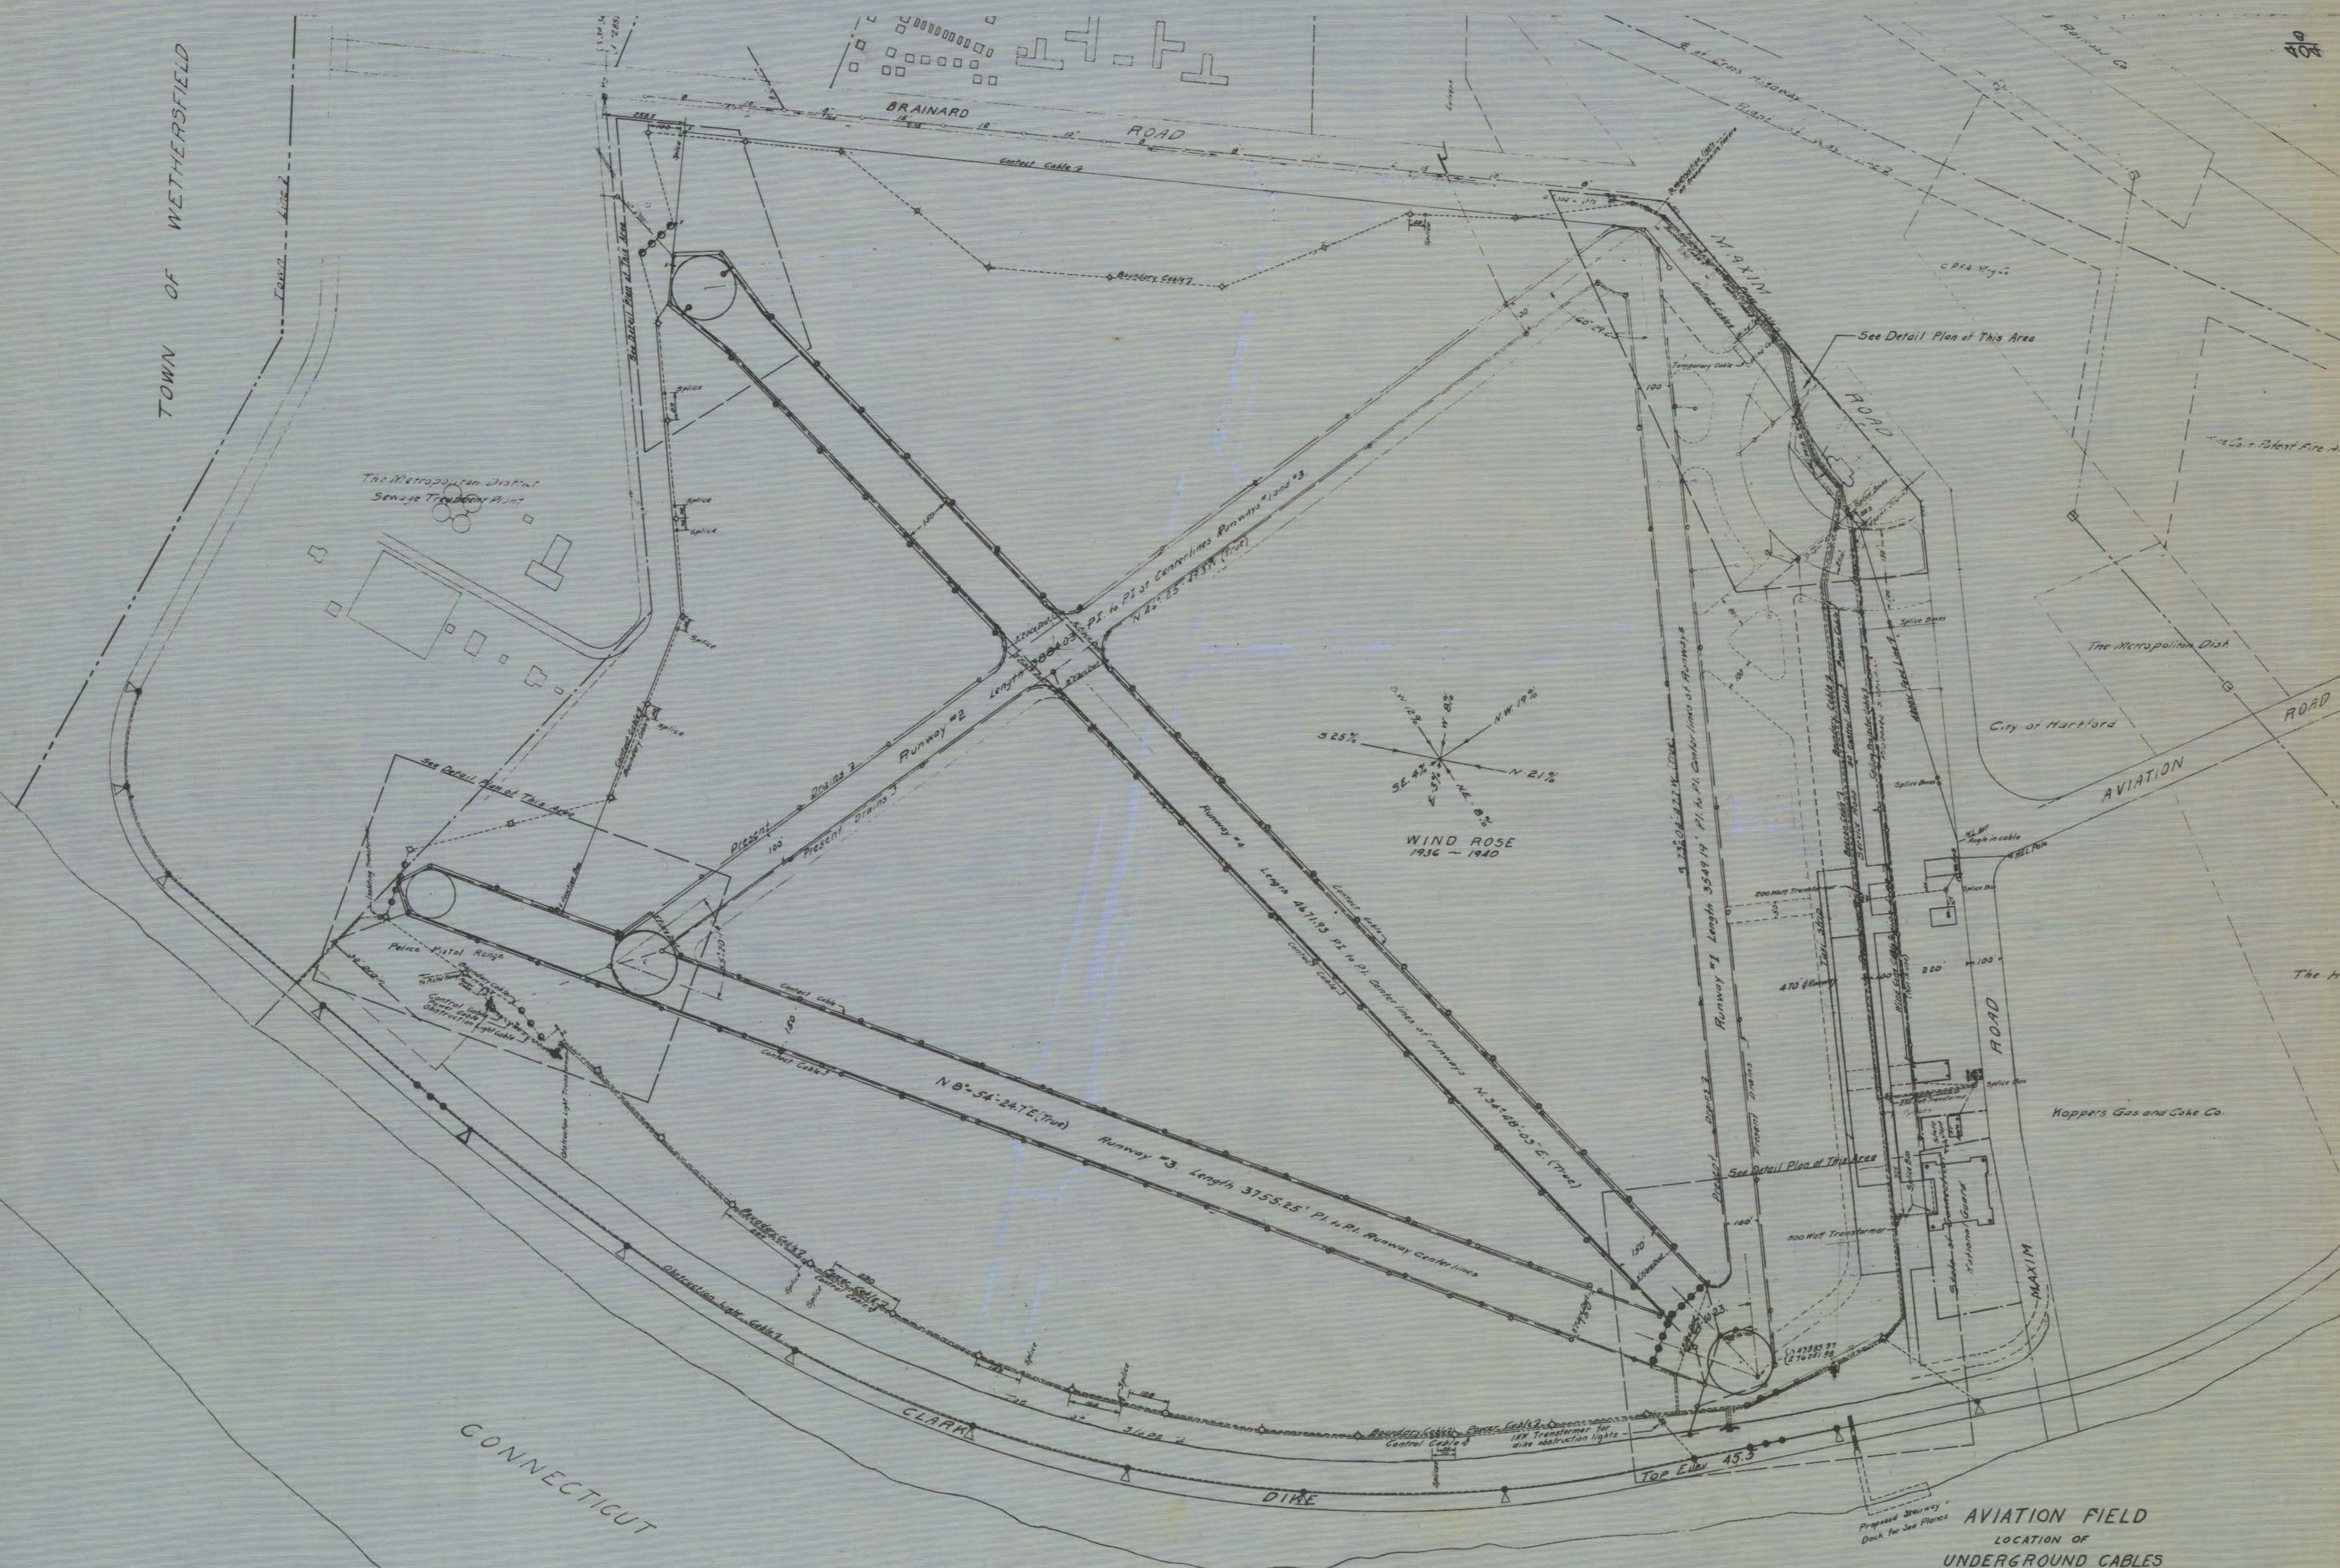

NOTE - This plan compiled from electrical plans of original installations drawn by W.J. Oates, and dated Sept. 28, 1939, from information furnished by Airport Manager, and from surveys. The location of underground cables, etc., is only approximately correct and therefore is not guaranteed. (See Plans 547/9, 347/10, 539/4, 539/5.)

AVIATION FIELD
LOCATION OF
UNDERGROUND CABLES
SCALE - 1" = 200'
NOTES - 740 DAYBOOK NO. 08441
MAY 1943

RIVER

CITY OF HARTFORD
DEPARTMENT OF ENGINEERING