

THE HARTFORD PUBLIC LIBRARY

BUILDING FOR

CITY OF HARTFORD


CARLETON F. SHARPE - CITY MANAGER
H. IRVING SKILTON - CITY ENGINEER
HENRY A. PERKINS - LIBRARY PRESIDENT
MAGNUS K. KRISTOFFERSEN - LIBRARIAN

JOHN C. PARSONS - CHAIRMAN
LIBRARY BUILDING COMMITTEE

SCHUTZ & GOODWIN - ARCHITECTS
KEYES D. METCALF - LIBRARIAN CONSULTANT
ROBERT W. LOOMIS - STRUCTURAL ENGINEER
HENRI B. VAN ZELM & ASSOC. - MECH. ENGRS.

DANIEL J. TASILLO
SUPERVISING ARCHITECT

CITY CONTRACT - NO.
E 54 - 212

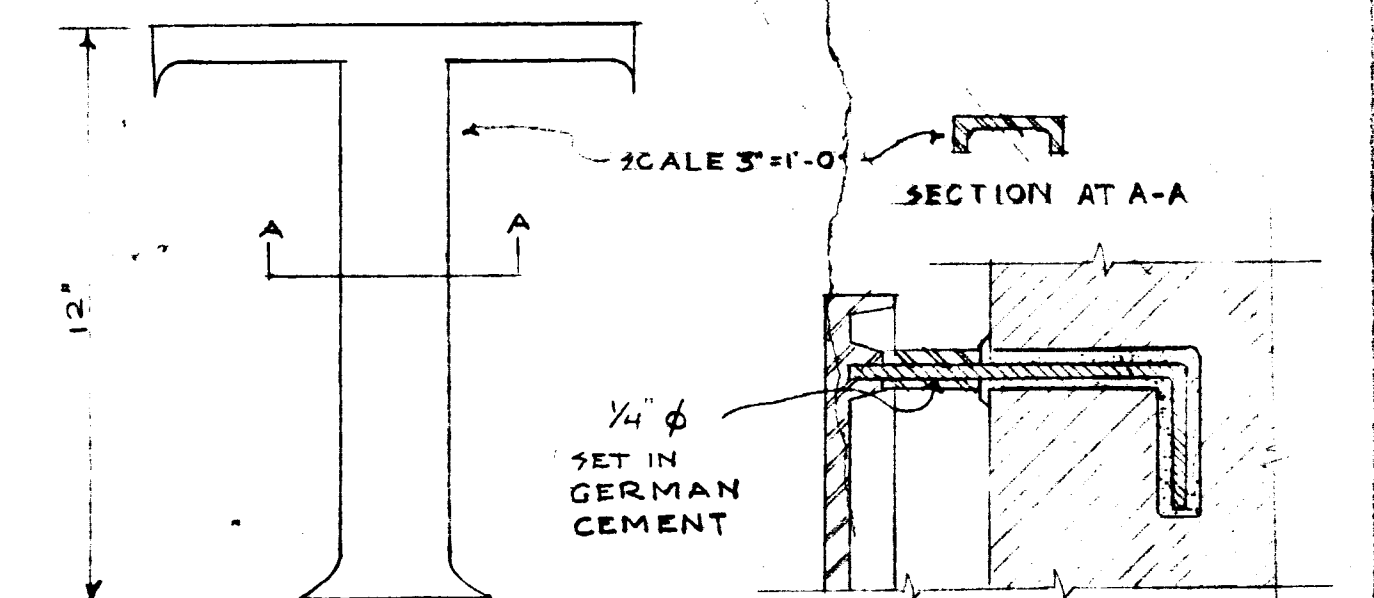

DETAIL OF FASTENING
METAL LETTERS
SCALE 1/2" = 1'-0"

METAL LETTERS FOR NORTH ELEVATION - SEE F.S.D. LATER
SCALE 3/4" = 1'-0"


- ARCHITECTURAL**
1. TITLE SHEET
INDEX OF MATERIALS
 2. PLOT PLAN
DETAIL GRANITE CURB & STEPS
 3. SUB-BASEMENT PLAN
 4. BASEMENT PLAN
 5. MAIN FLOOR PLAN
 6. MEZZANINE FLOOR PLAN
DET. MARBLE BLOCK FOR SCULPTURE
 7. SECOND FLOOR PLAN
 8. ROOF & PENTHOUSE PLAN
ROOF DETAILS
DOOR SCHEDULE
 9. WEST & NORTH ELEVATIONS
 10. EAST & SOUTH ELEVATIONS
 11. CROSS SECTION
LONGITUDINAL SECTION
 12. DETAILS
MAIN ENTRANCE
EXTERIOR SHOW CASE
 13. DETAILS
LECTURE ROOM
ENTRANCE AT CHILDREN'S WING
 14. DETAILS
AREAWAYS
TERRACE
FRONT EXTERIOR ACCESSORIES
 15. 1/4" WALL SECTIONS & BRICK COURSES
REFLECTED CEILING PLANS
 16. 3/4" WALL SECTIONS
DETAILS
MEZZANINE GUARD RAIL &
EYEBROW & PARAPET DETS.
 17. WINDOW SCHEDULE & DETAILS
 18. STAIR TOWER #1
STAIR TOWER #2
 19. DETAILS
RECESS FOR HEATING UNITS AT WINDOWS
STAIR TOWER #3
STAIRS #8
STORY HOUR ROOM FIREPLACE
 20. DETAILS
STAIRWAY #4, #5, #6 & #7

21. DETAILS
SHIPPING AREA & LOADING PLATFORM
BOOK RETURN
GLASS PARTITIONS
KITCHEN
CORNERSTONE
INTERIOR OFFICE WALL ELEVATIONS
22. WALL ELEVATIONS
LOBBY & ENTRANCE
REFERENCE ROOM
OPEN SHELF ROOM
ART ROOM
23. DETAILS
WORK ROOMS
PHOTOGRAPHIC LABORATORY
AUDIO-VISUAL BOOTHS
TELEPHONE SHELF
24. ROOM FINISH SCHEDULE
25. ROOM FINISH SCHEDULE (CONT'D)
DETAIL INTERIOR BASES
26. ROOM FINISH SCHEDULE (CONT'D)
METAL FURRING & FIREPROOFING
INTERIOR DOOR BUCKS
TYPICAL PICTURE MOULD
27. DIAGRAM FOR FIRE BARRIERS
METAL TOILET PARTITIONS
- STRUCTURAL**
28. S1 FOUNDATION PLAN
29. S2 BASEMENT FL. FRAMING PLAN
30. S3 FIRST FL. FRAMING PLAN
31. S4 MEZZ. FL. FRAMING PLAN
32. S5 SECOND FL. FRAMING PLAN
33. S6 STAFF PENTHOUSE FL. & LOW ROOF FR. PLAN
34. S7 STAFF PENTHOUSE & ELEV. ROOF FR. PLAN
35. S8 FOOTING DET. & CONC. GRADE BEAM SCHEDULE
36. S9 COLUMN SCHEDULE
37. S10 COLUMN, LINTEL & SLAB SCHEDULES & MISC. DET.
38. S11 ROOF TRUSS DETAIL
39. S12 VIERENDEEL TRUSS DETAILS
40. S13 VIERENDEEL TRUSS DETAILS

- HEATING & VENTILATING**
41. HV-1 SUB-BASEMENT PLAN
 42. HV-2 BASEMENT PLAN
 43. HV-3 MAIN FLOOR PLAN
 44. HV-4 MEZZANINE
 45. HV-5 SECOND FLOOR PLAN
 46. HV-6 ROOF PLAN & PENTHOUSE
 47. HV-7 TEMPERATURE CONTROL DIAGRAMS
- PLUMBING**
48. P-1 SUB-BASEMENT PLAN
 49. P-2 BASEMENT PLAN
 50. P-3 MAIN FLOOR PLAN
 51. P-4 MEZZANINE
 52. P-5 SECOND FLOOR PLAN
 53. P-6 ROOF PLAN & PENTHOUSE
- ELECTRIC**
54. E-1 SUB-BASEMENT PLAN
 55. E-2 BASEMENT PLAN
 56. E-3 MAIN FLOOR PLAN
 57. E-4 MEZZANINE
 58. E-5 SECOND FLOOR PLAN
 59. E-6 ROOF PLAN & PENTHOUSE

INDEX OF MATERIAL

	CONCRETE
	CINDER BLOCK
	BRICK
	METAL OR FLAGSTONE
	GRANITE
	MARBLE
	SLATE
	WOOD
	PLYWOOD
	PLASTER
	INSULATION
	TERRAZO
	CORK
	CERAMIC TILE
	HOLLOW STUD PART.

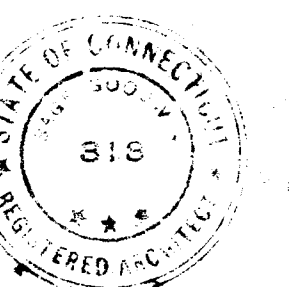

SCHUTZ & GOODWIN
ARCHITECTS
12 HAYNES STREET HARTFORD CONN.

JOB NO. DATE 5/15/52
531A DRAWN BY R.C.G.
SHEET NO. TRACED BY R.C.G.
CHECKED BY A.S.C.

BUILDING FOR
THE HARTFORD PUBLIC LIBRARY
CITY OF HARTFORD - OWNER