



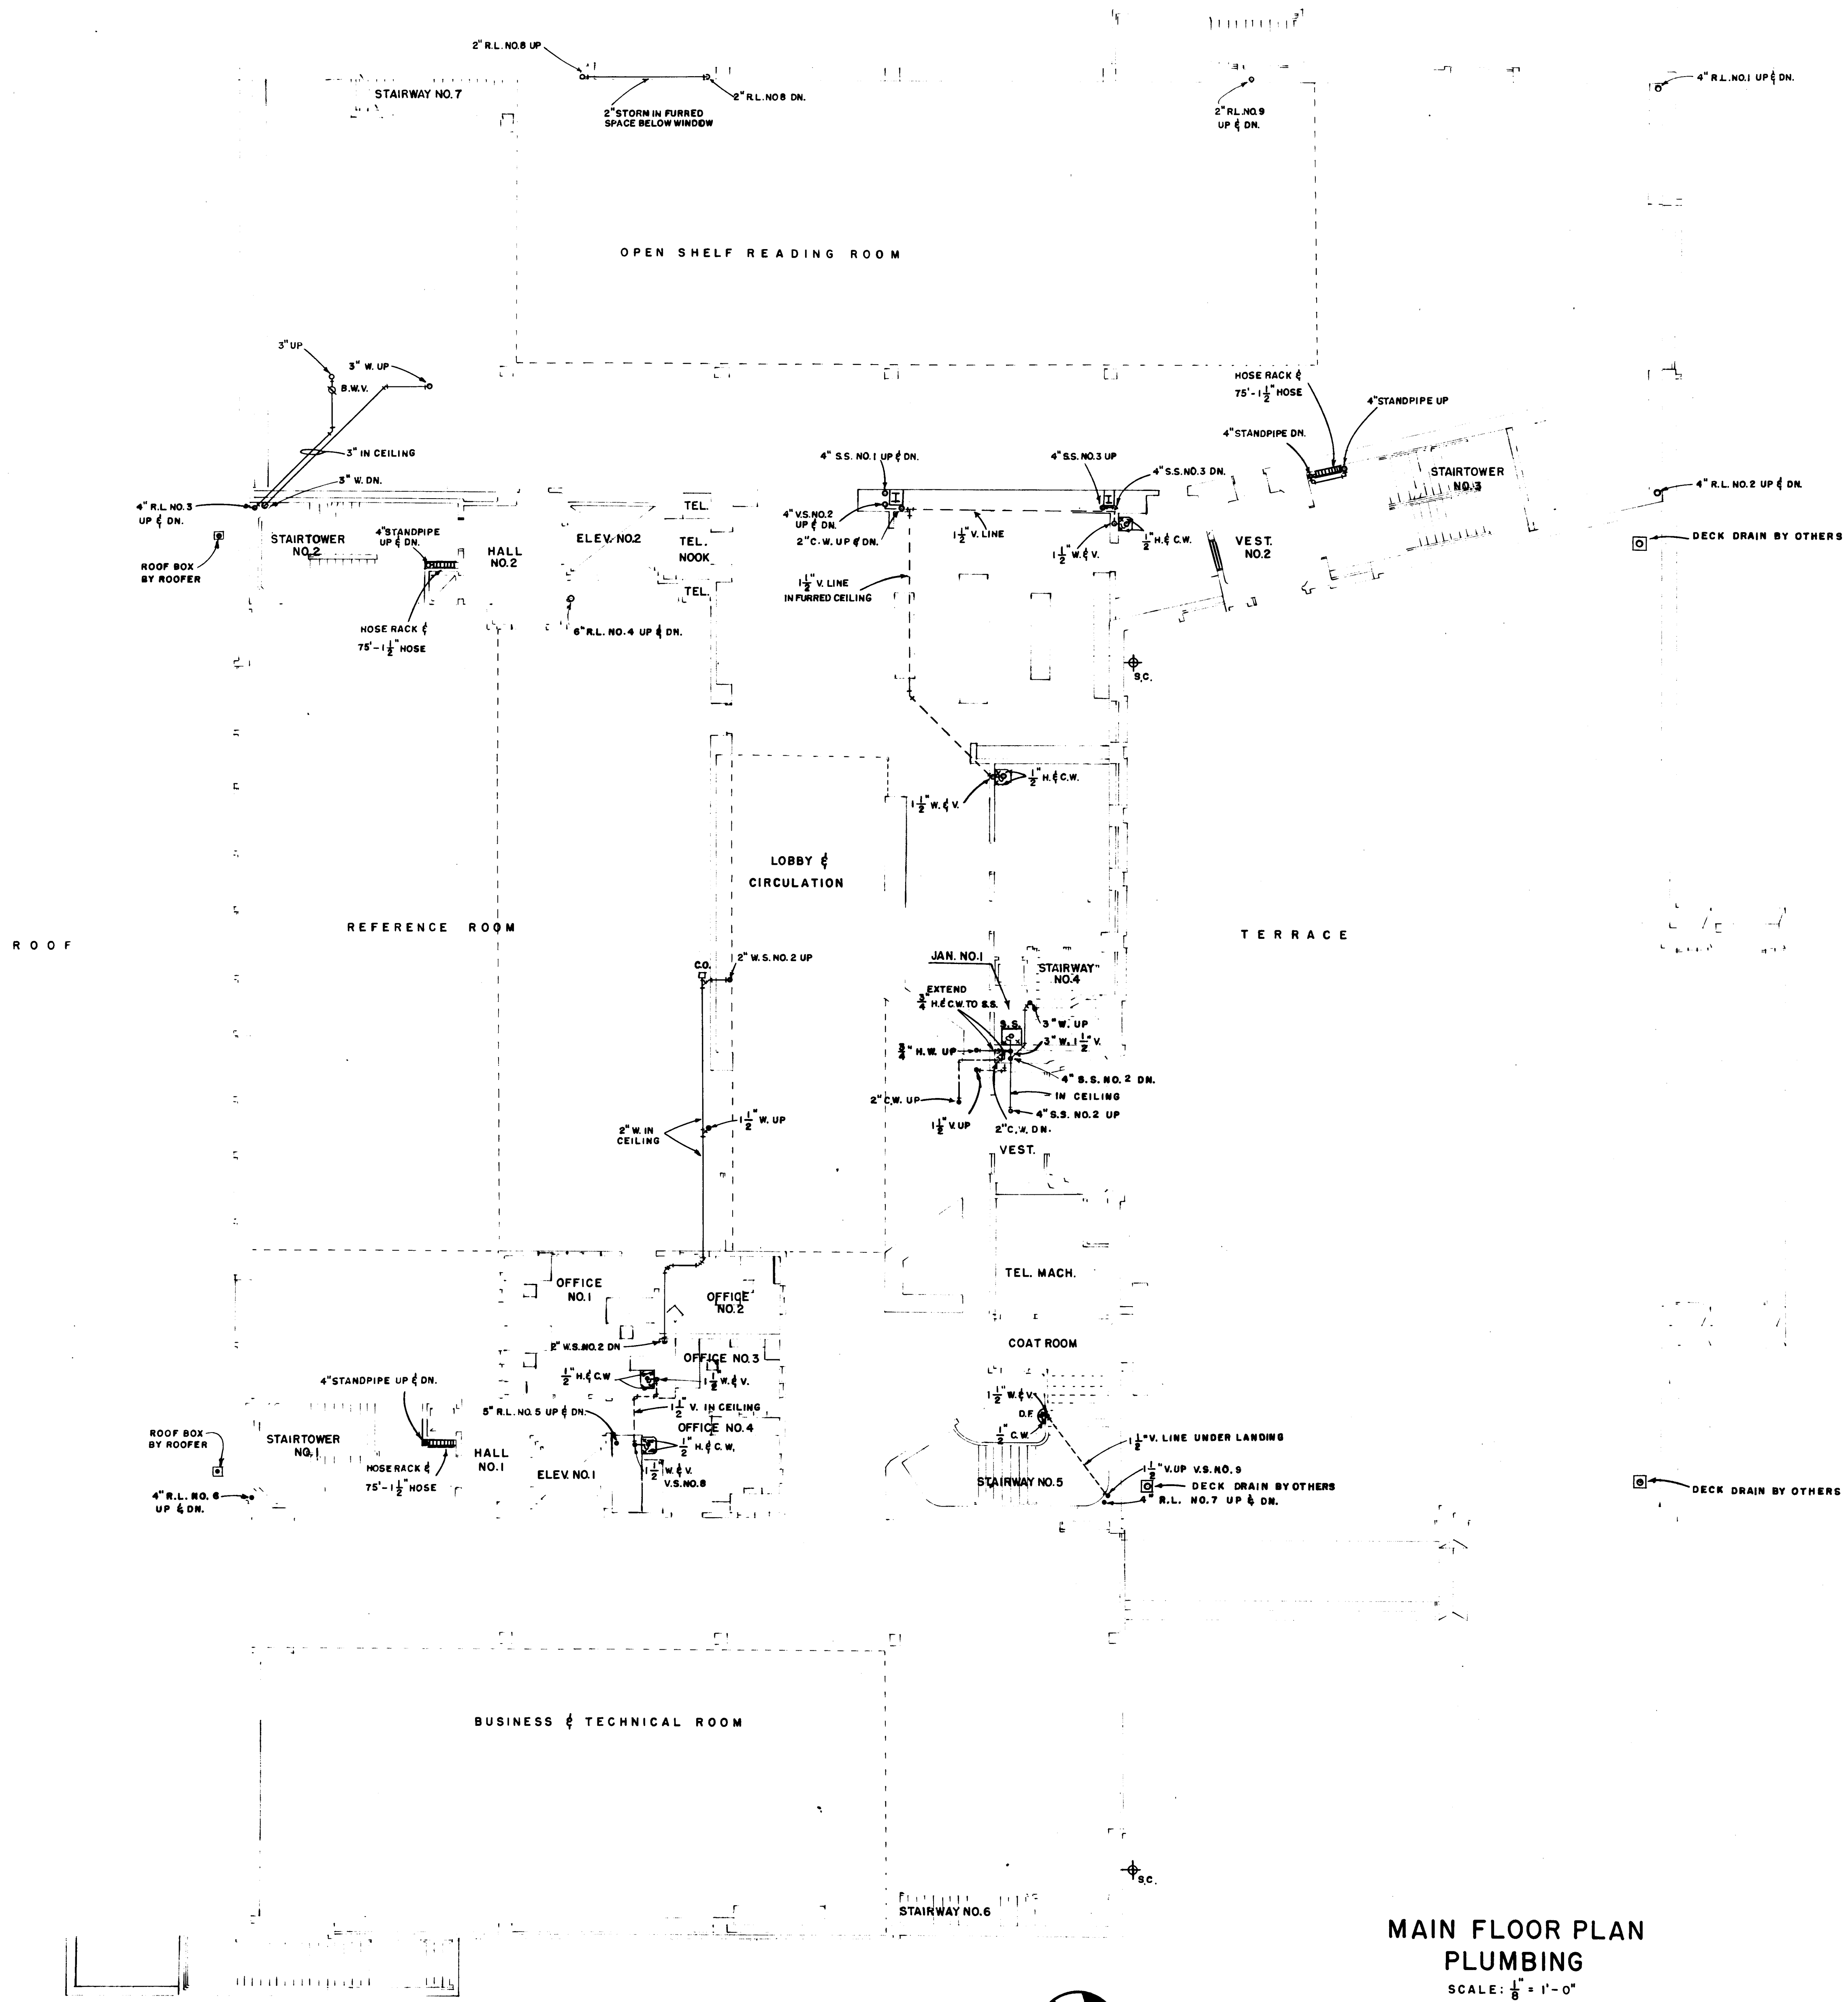

MAIN FLOOR PLAN
PLUMBING

SCALE: 1/8" = 1'-0"

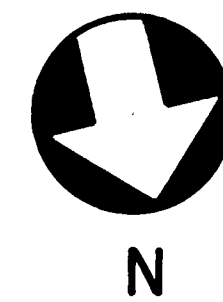

P-3

HENRI B. VAN ZELM AND ASSOCIATES
CONSULTING ENGINEERS
197 ASYLUM STREET
HARTFORD, CONNECTICUT

SCHUTZ & GOODWIN ARCHITECTS 12 HAYNES STREET HARTFORD, CONN.	
JOB NO. 53-1A	DATE 6/15/54
SHEET NO. 50	DRAWN BY JKZ
	TRACED BY JKZ
	CHECKED BY AHG
BUILDING FOR THE HARTFORD PUBLIC LIBRARY CITY OF HARTFORD - OWNER	