


PLUMBING LEGEND

— C.W. —	COLD WATER LINE
— H.W. —	HOT WATER LINE
— F —	FIRE LINE
— G —	GAS LINE
⊗	BALANCE VALVE
⊕	SILL COCK
⊖	CHECK VALVE
⊕	GATE VALVE
⊖	GLOBE VALVE
⊕	CONTROL VALVE
⊖	B.W.V. BACK WATER VALVE
A.W.	ACID WASTE
LAV.	LAVATORY
S.S.	JANITOR'S SERVICE SINK
⊕	WATER CLOSET - FLUSH VALVE
⊖	URINAL
⊕	DRINKING FOUNTAIN
⊖	WATER COOLER
⊕	FLOOR DRAIN OR ROOF BOX
⊖	R.L. ROOF LEADER
⊖	S.S. SOIL STACK
⊖	W.S. WASTE STACK
⊖	V.S. VENT STACK
⊖	W & V WASTE & VENT STACK
ST.	STORM LINE
SAN.	SANITARY LINE
—	STORM OR SANITARY LINE IN GROUND
—	STORM OR SANITARY LINE EXPOSED
CO.	CLEANOUT
CO.	CLEANOUT BELOW FLOOR
—	RUNNING TRAP
⊕	SUMP PUMP WITH RUNNING TRAP & CHECK VALVE

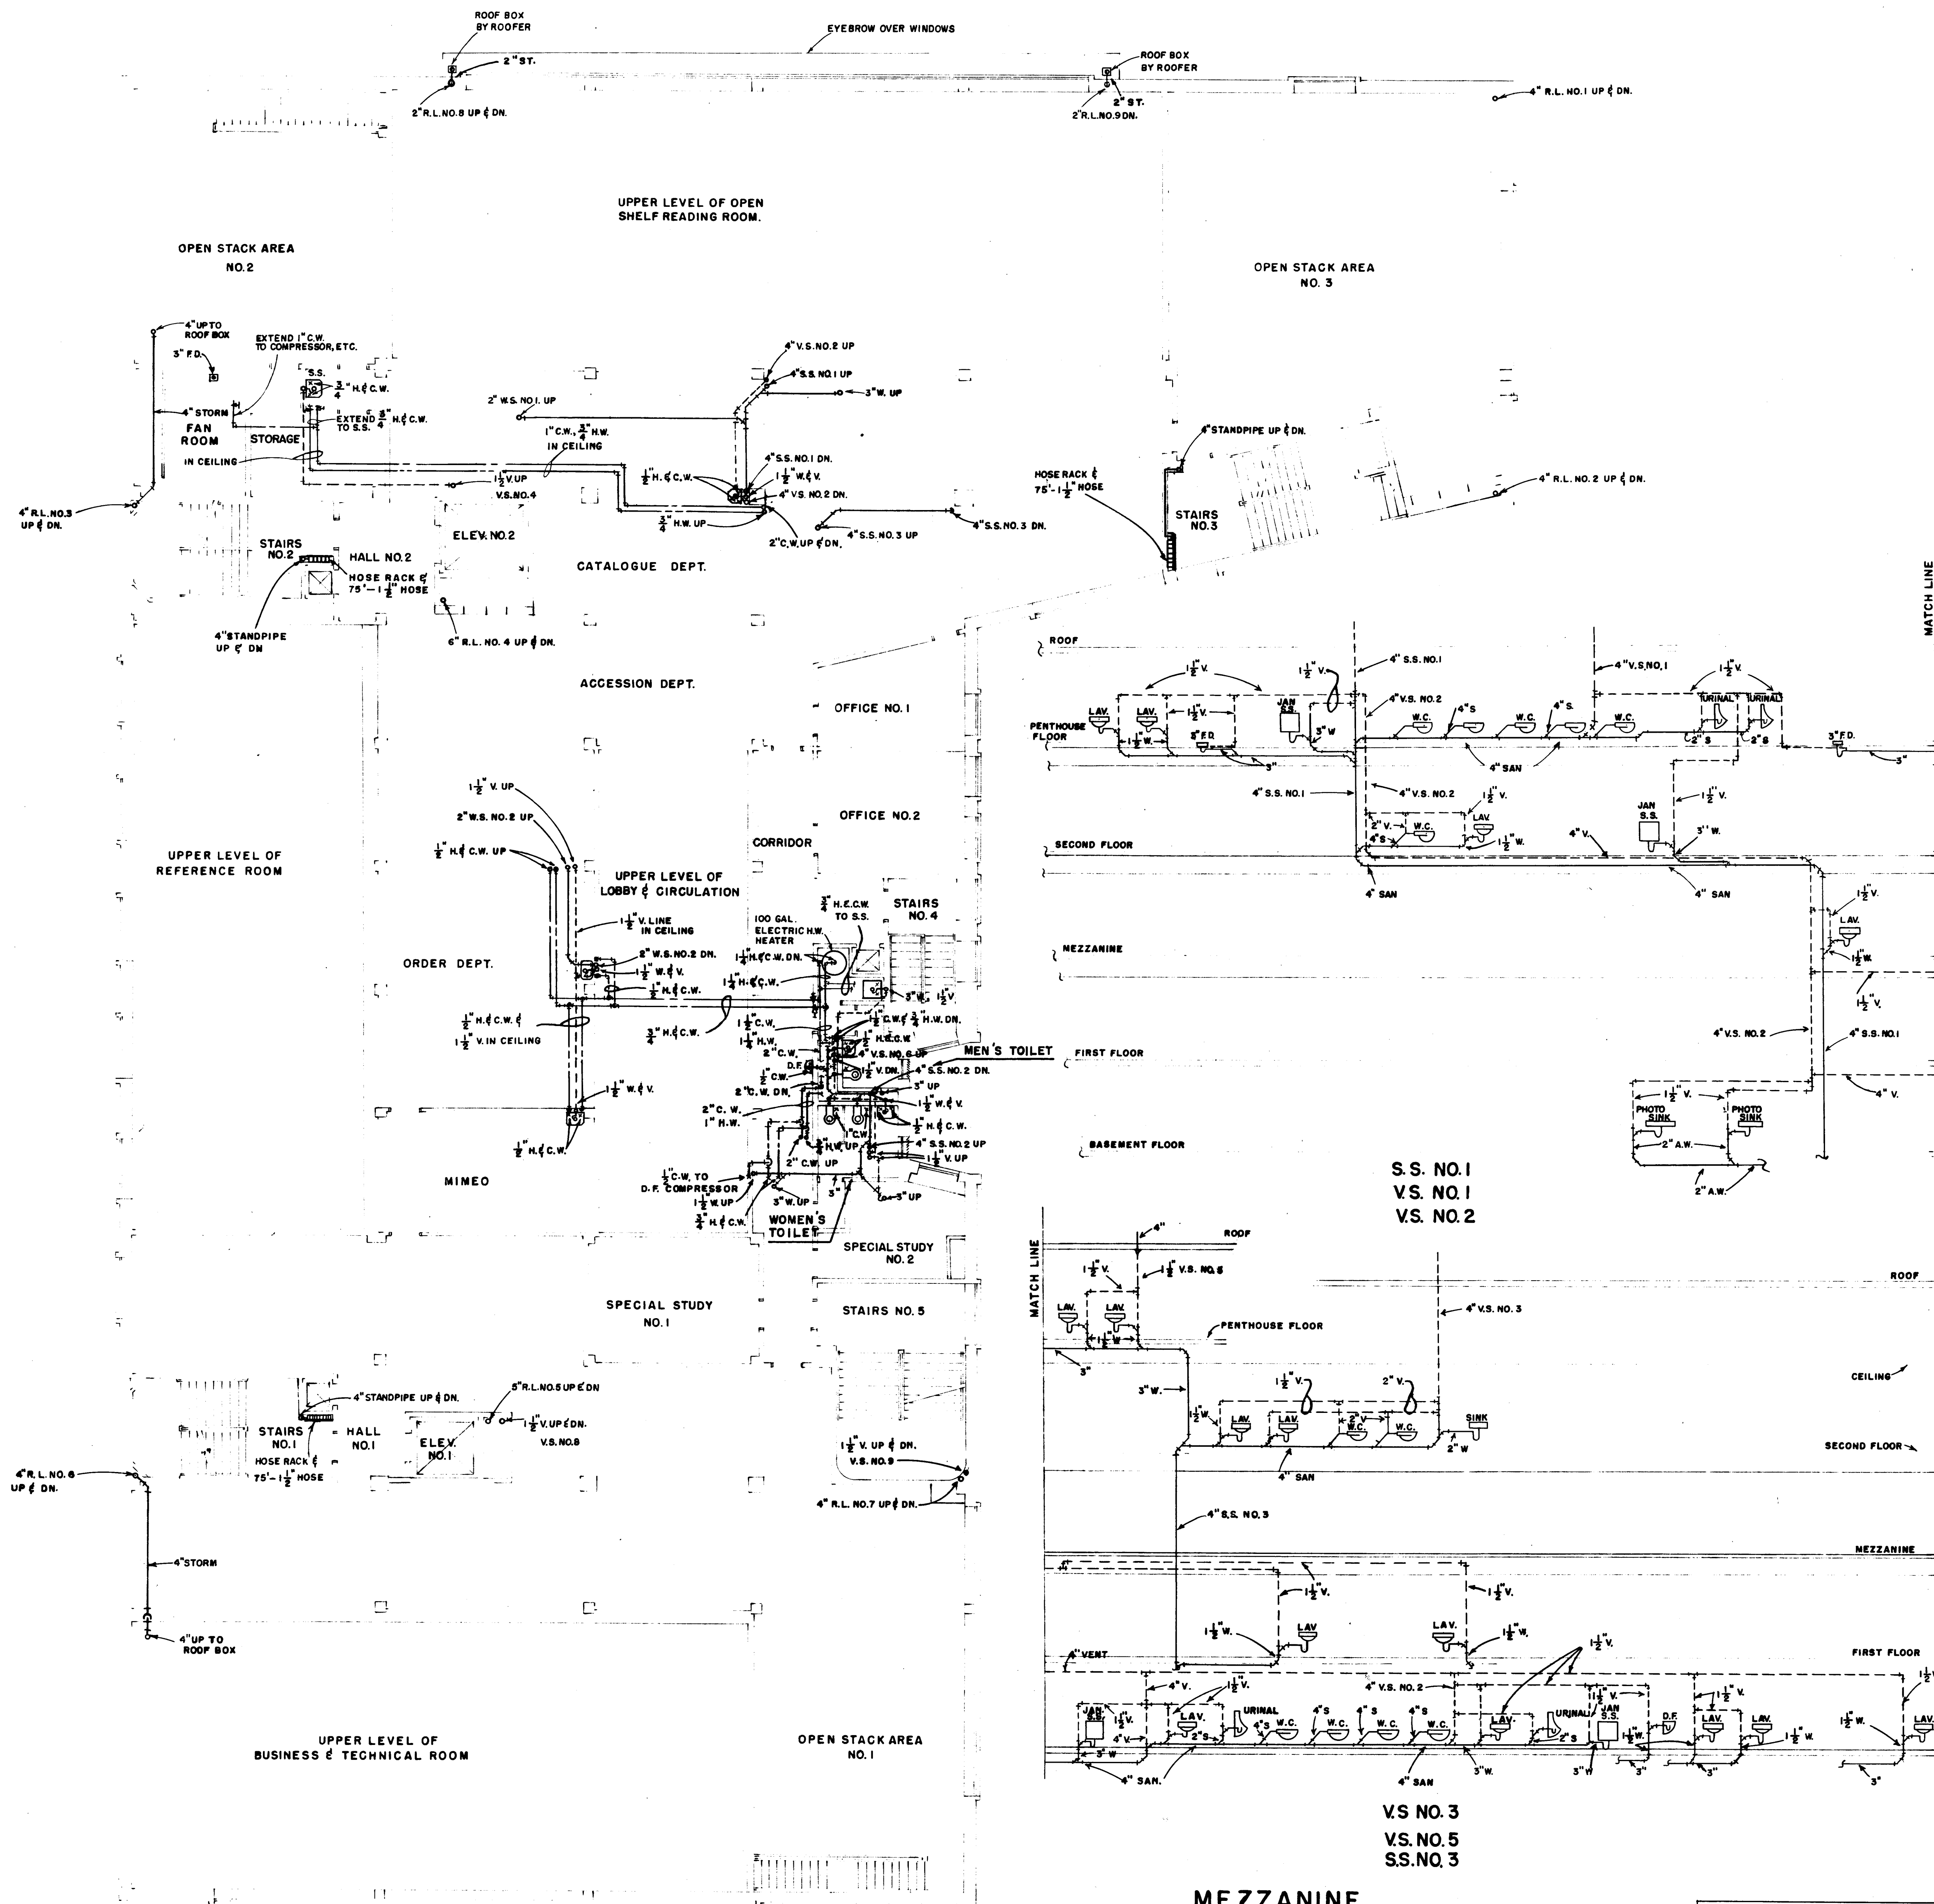

SCHUTZ & GOODWIN
ARCHITECTS
12 HAYNES STREET HARTFORD, CONN.
JOB NO. 53-1A
DATE 6/15/52
DRAWN BY JKZ
TRACED BY JKZ
CHECKED BY AHG

HENRI B. VANZELM AND ASSOCIATES
CONSULTING ENGINEERS
197 ASYLUM STREET
HARTFORD, CONNECTICUT

BUILDING FOR
THE HARTFORD PUBLIC LIBRARY
CITY OF HARTFORD - OWNER