




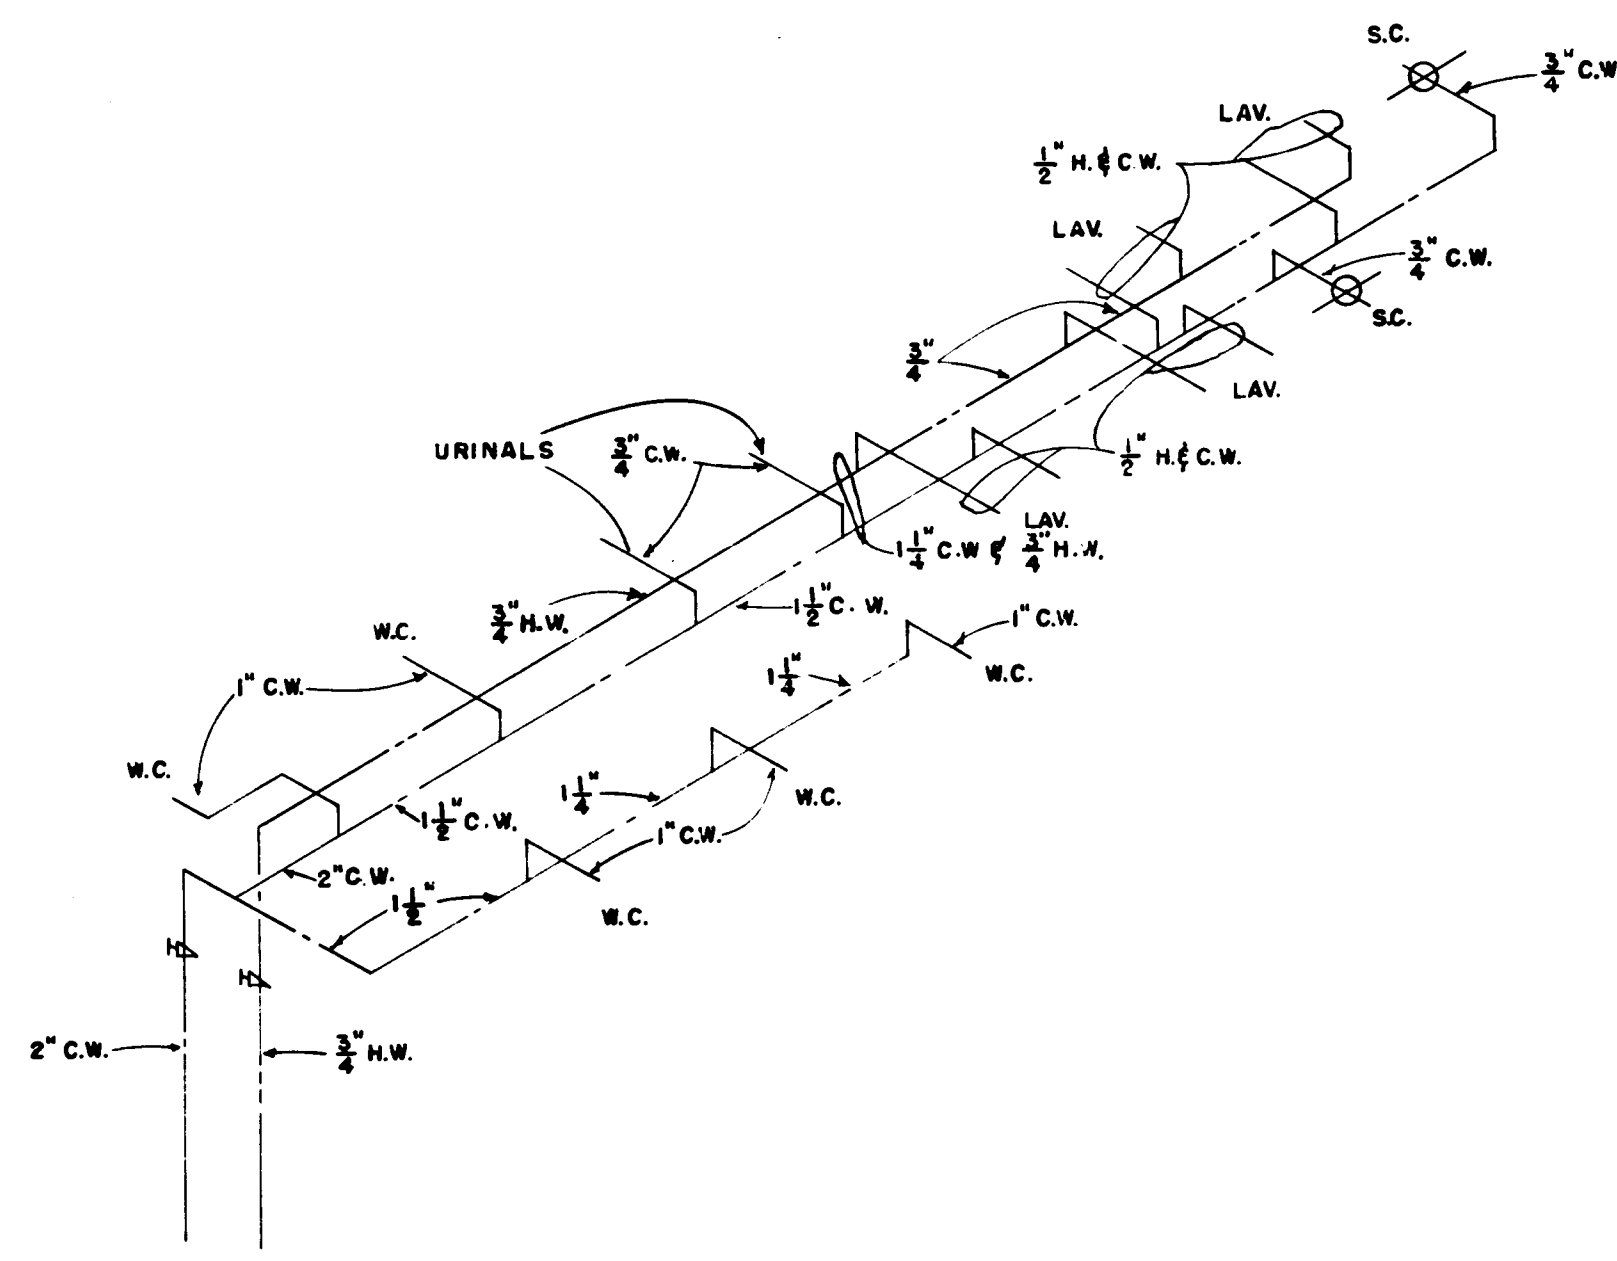


MEN'S & WOMEN'S TOILETS 2ND FLOOR
WATER RISER DIAGRAM

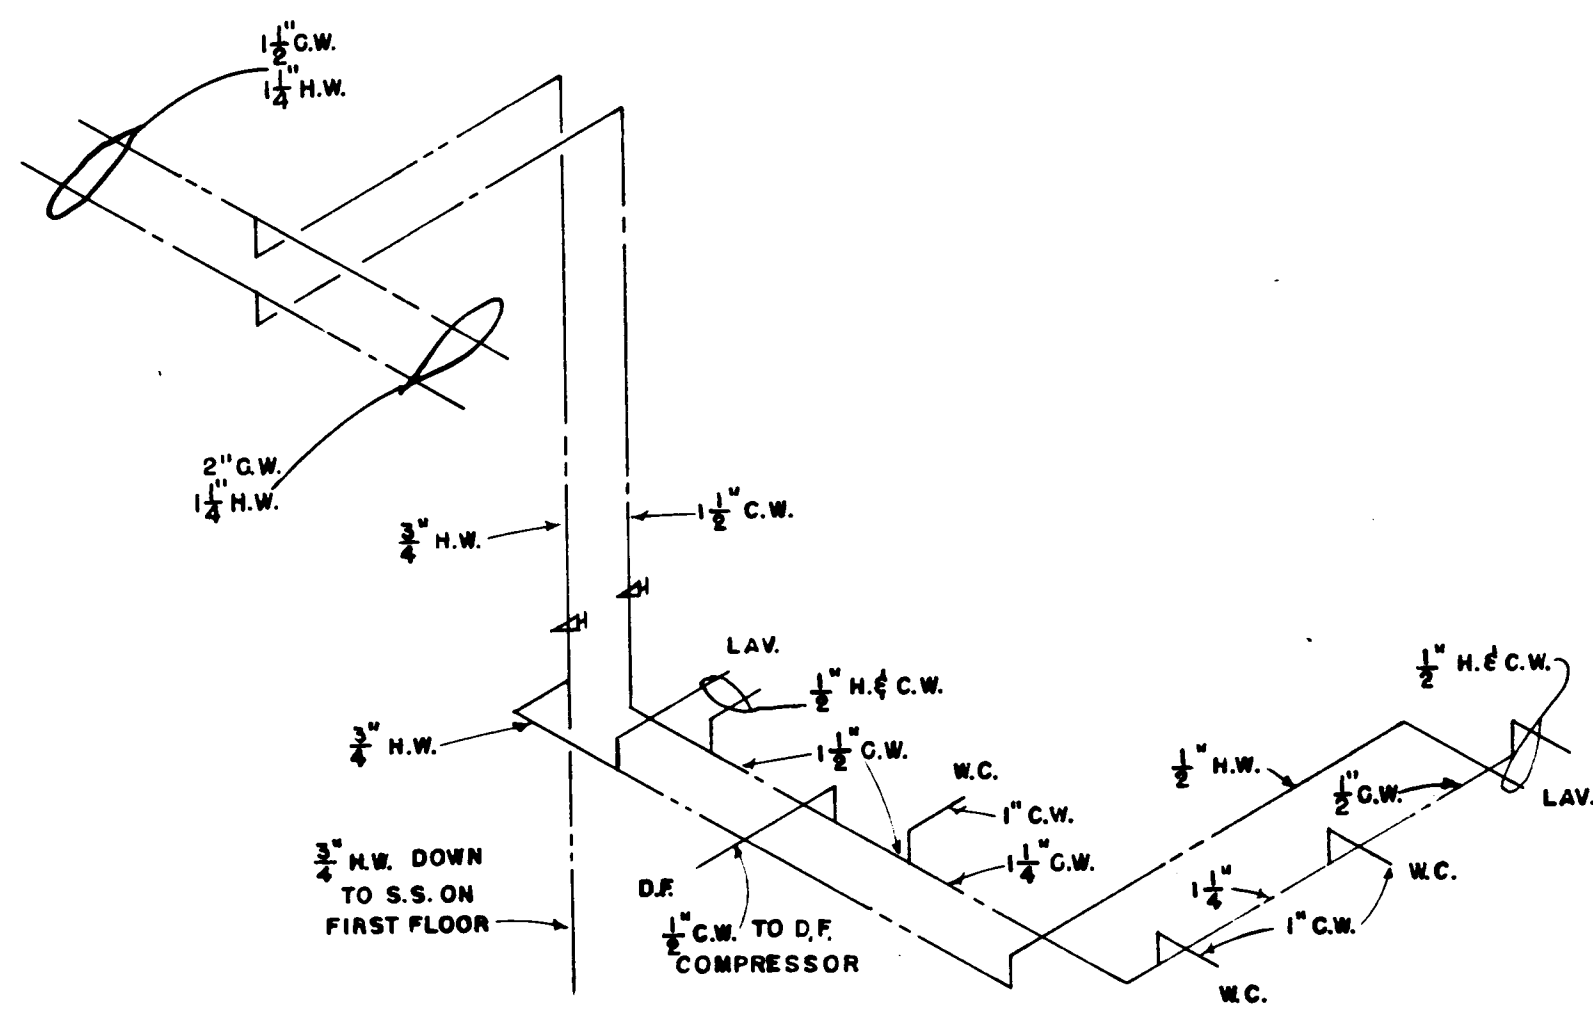


MEZZANINE TOILET ROOM
WATER RISER DIAGRAM

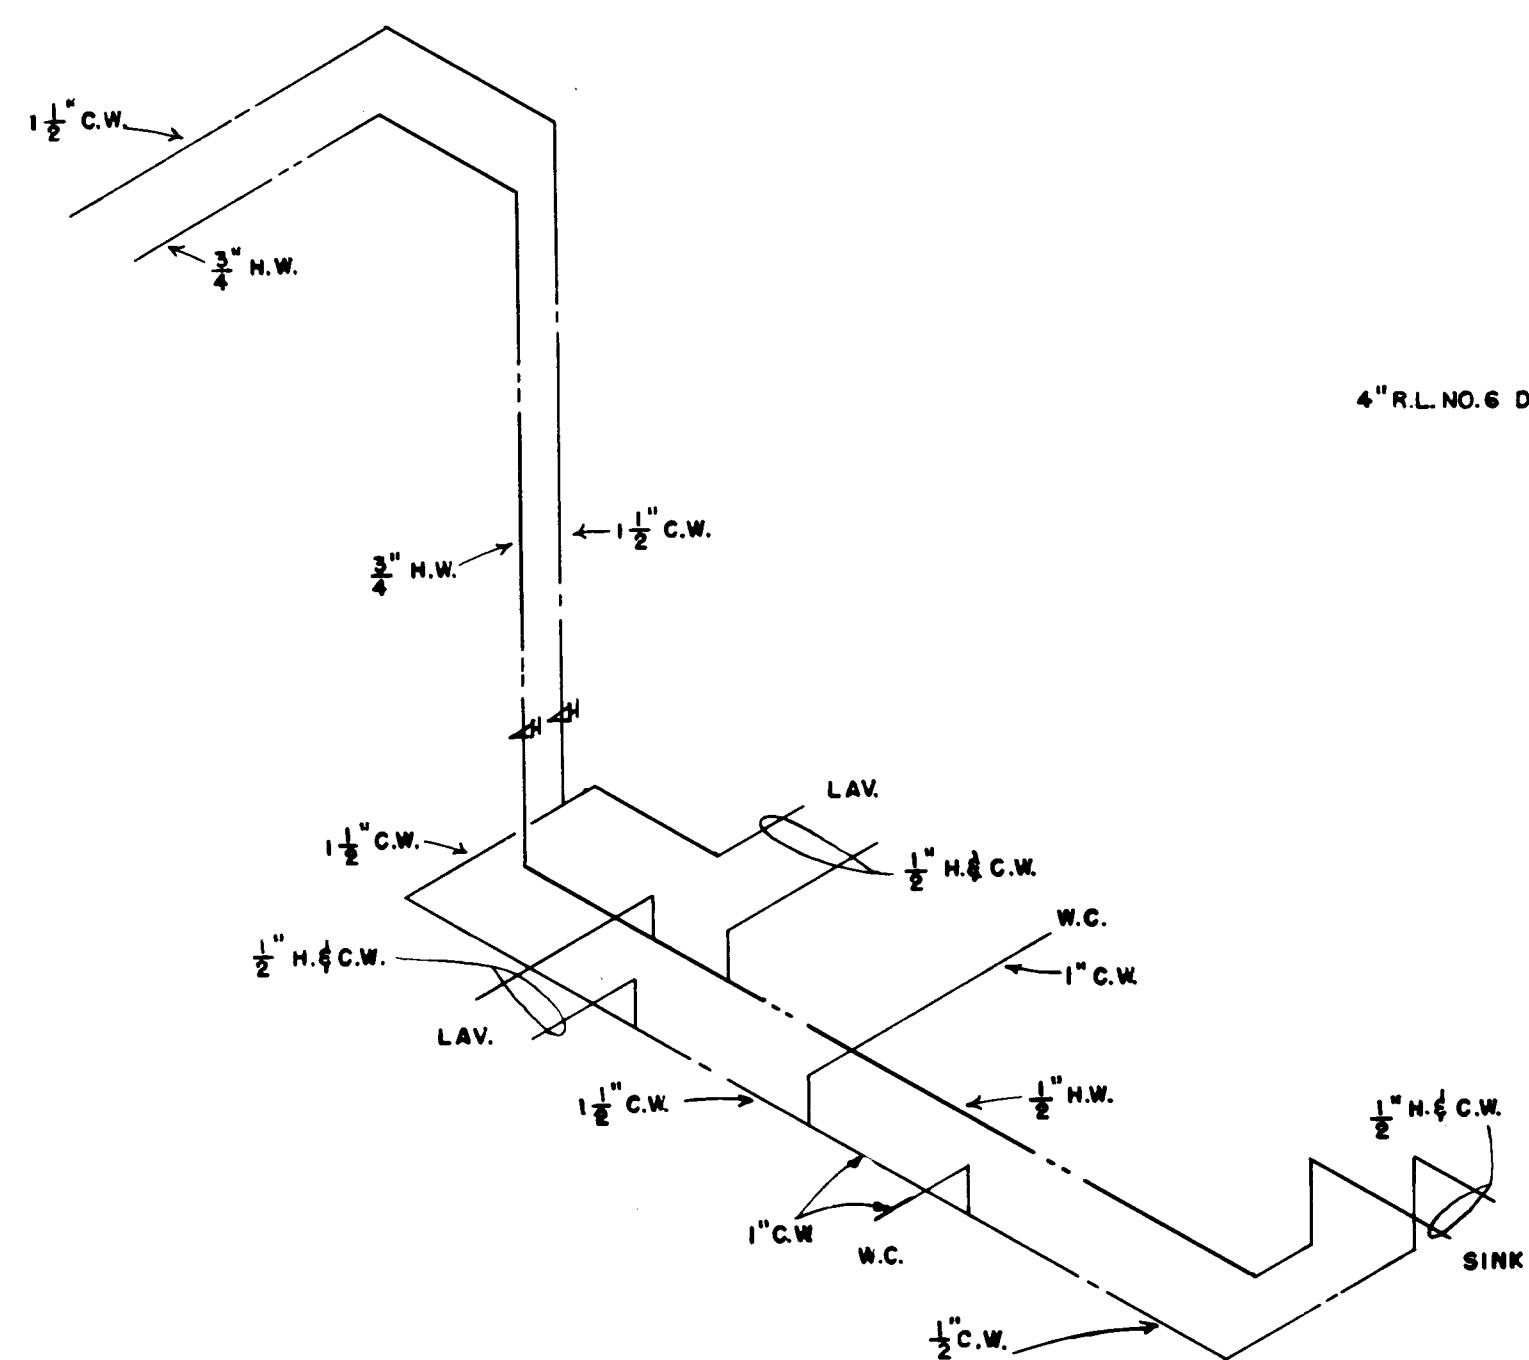

BOY'S & GIRL'S TOILETS - SECOND FLOOR
WATER RISER DIAGRAM

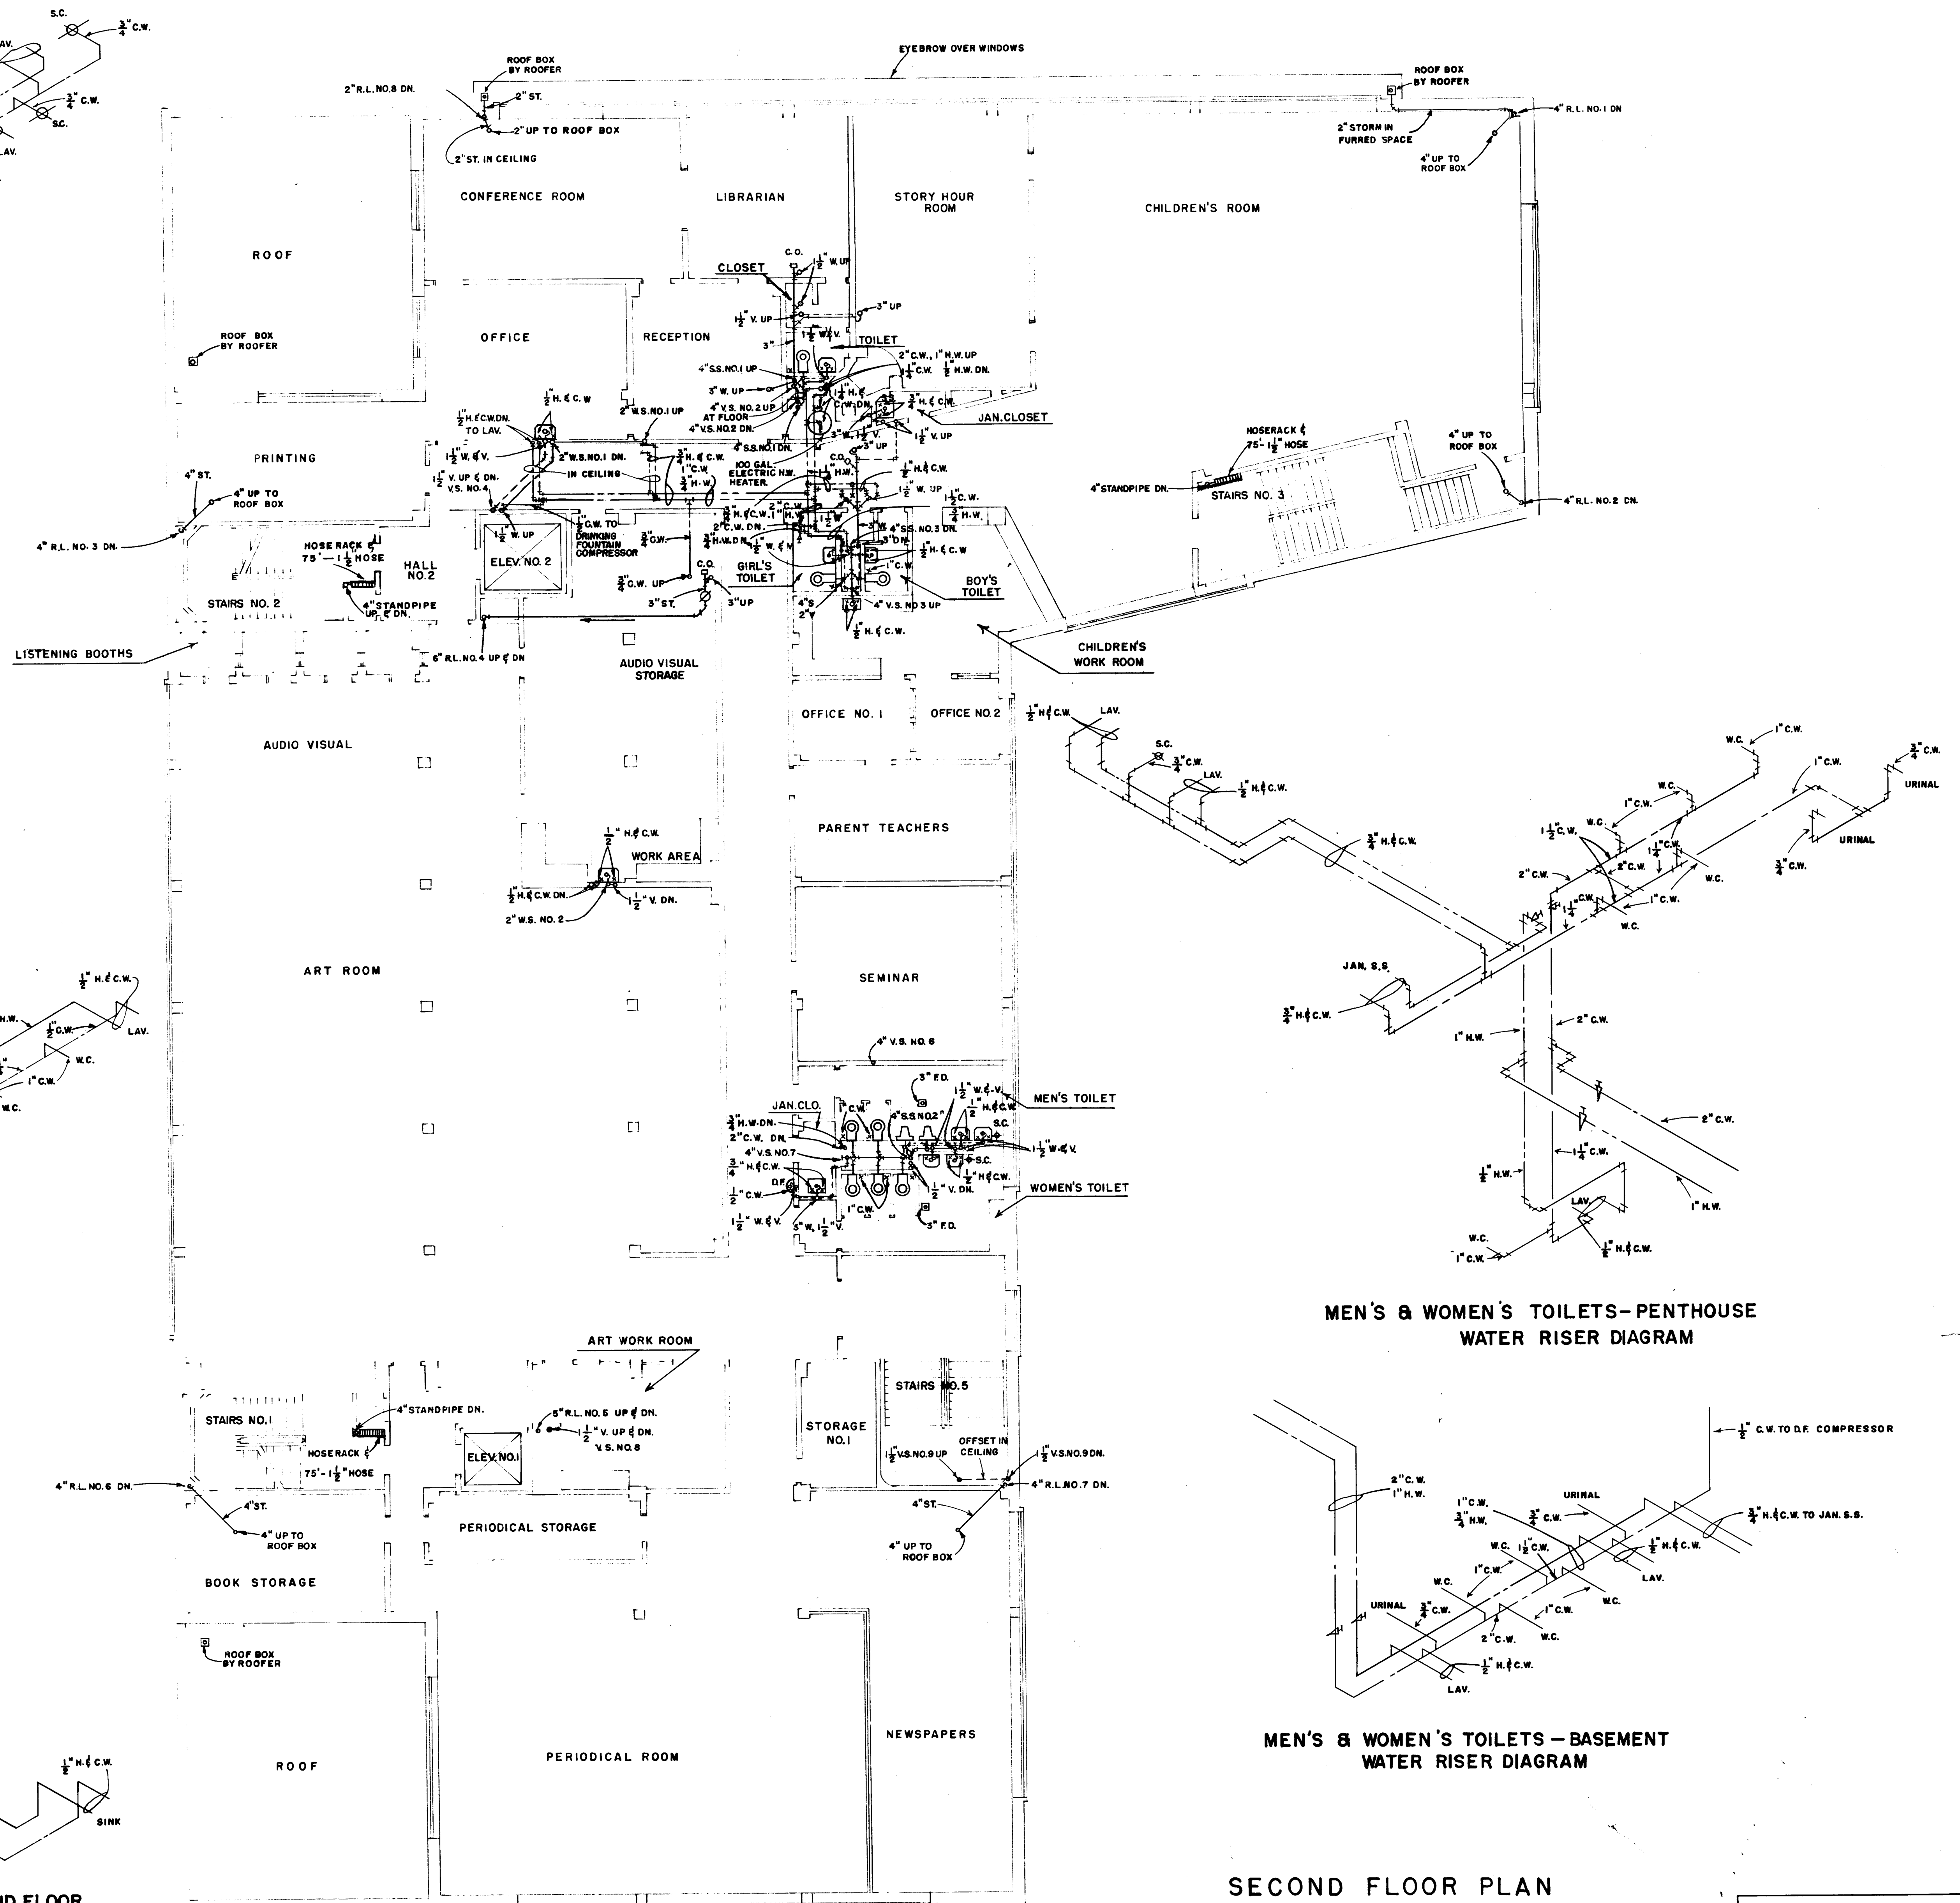


MEN'S & WOMEN'S TOILETS - PENTHOUSE
WATER RISER DIAGRAM

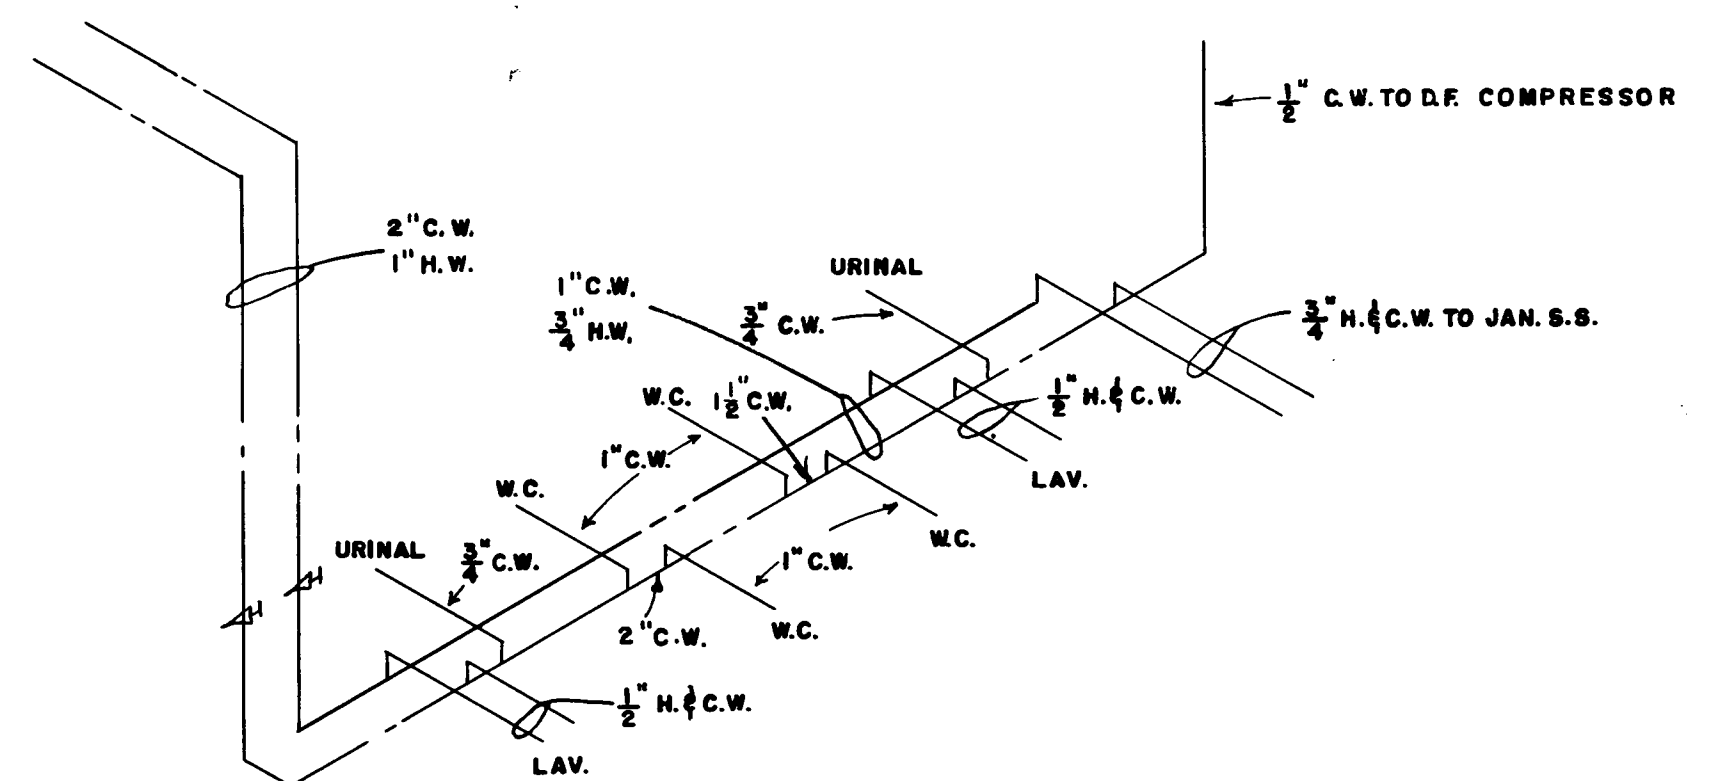

MEN'S & WOMEN'S TOILETS - BASEMENT
WATER RISER DIAGRAM

SECOND FLOOR PLAN PLUMBING

SCALE: 1/8" = 1'-0"

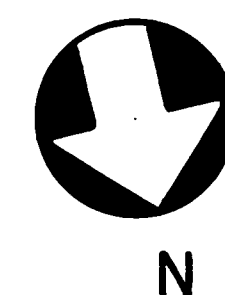

HENRI B. VAN ZELM AND ASSOCIATES
CONSULTING ENGINEERS
197 ASYLUM STREET
HARTFORD, CONNECTICUT

SCHUTZ & GOODWIN
ARCHITECTS
12 HAYNES STREET HARTFORD, CONN.
JOB NO. 53-1A
SHEET NO. 52
DATE 6/15/54
DRAWN BY JKZ
TRACED BY JKZ
CHECKED BY AHG
BUILDING FOR
THE HARTFORD PUBLIC LIBRARY
CITY OF HARTFORD - OWNER