

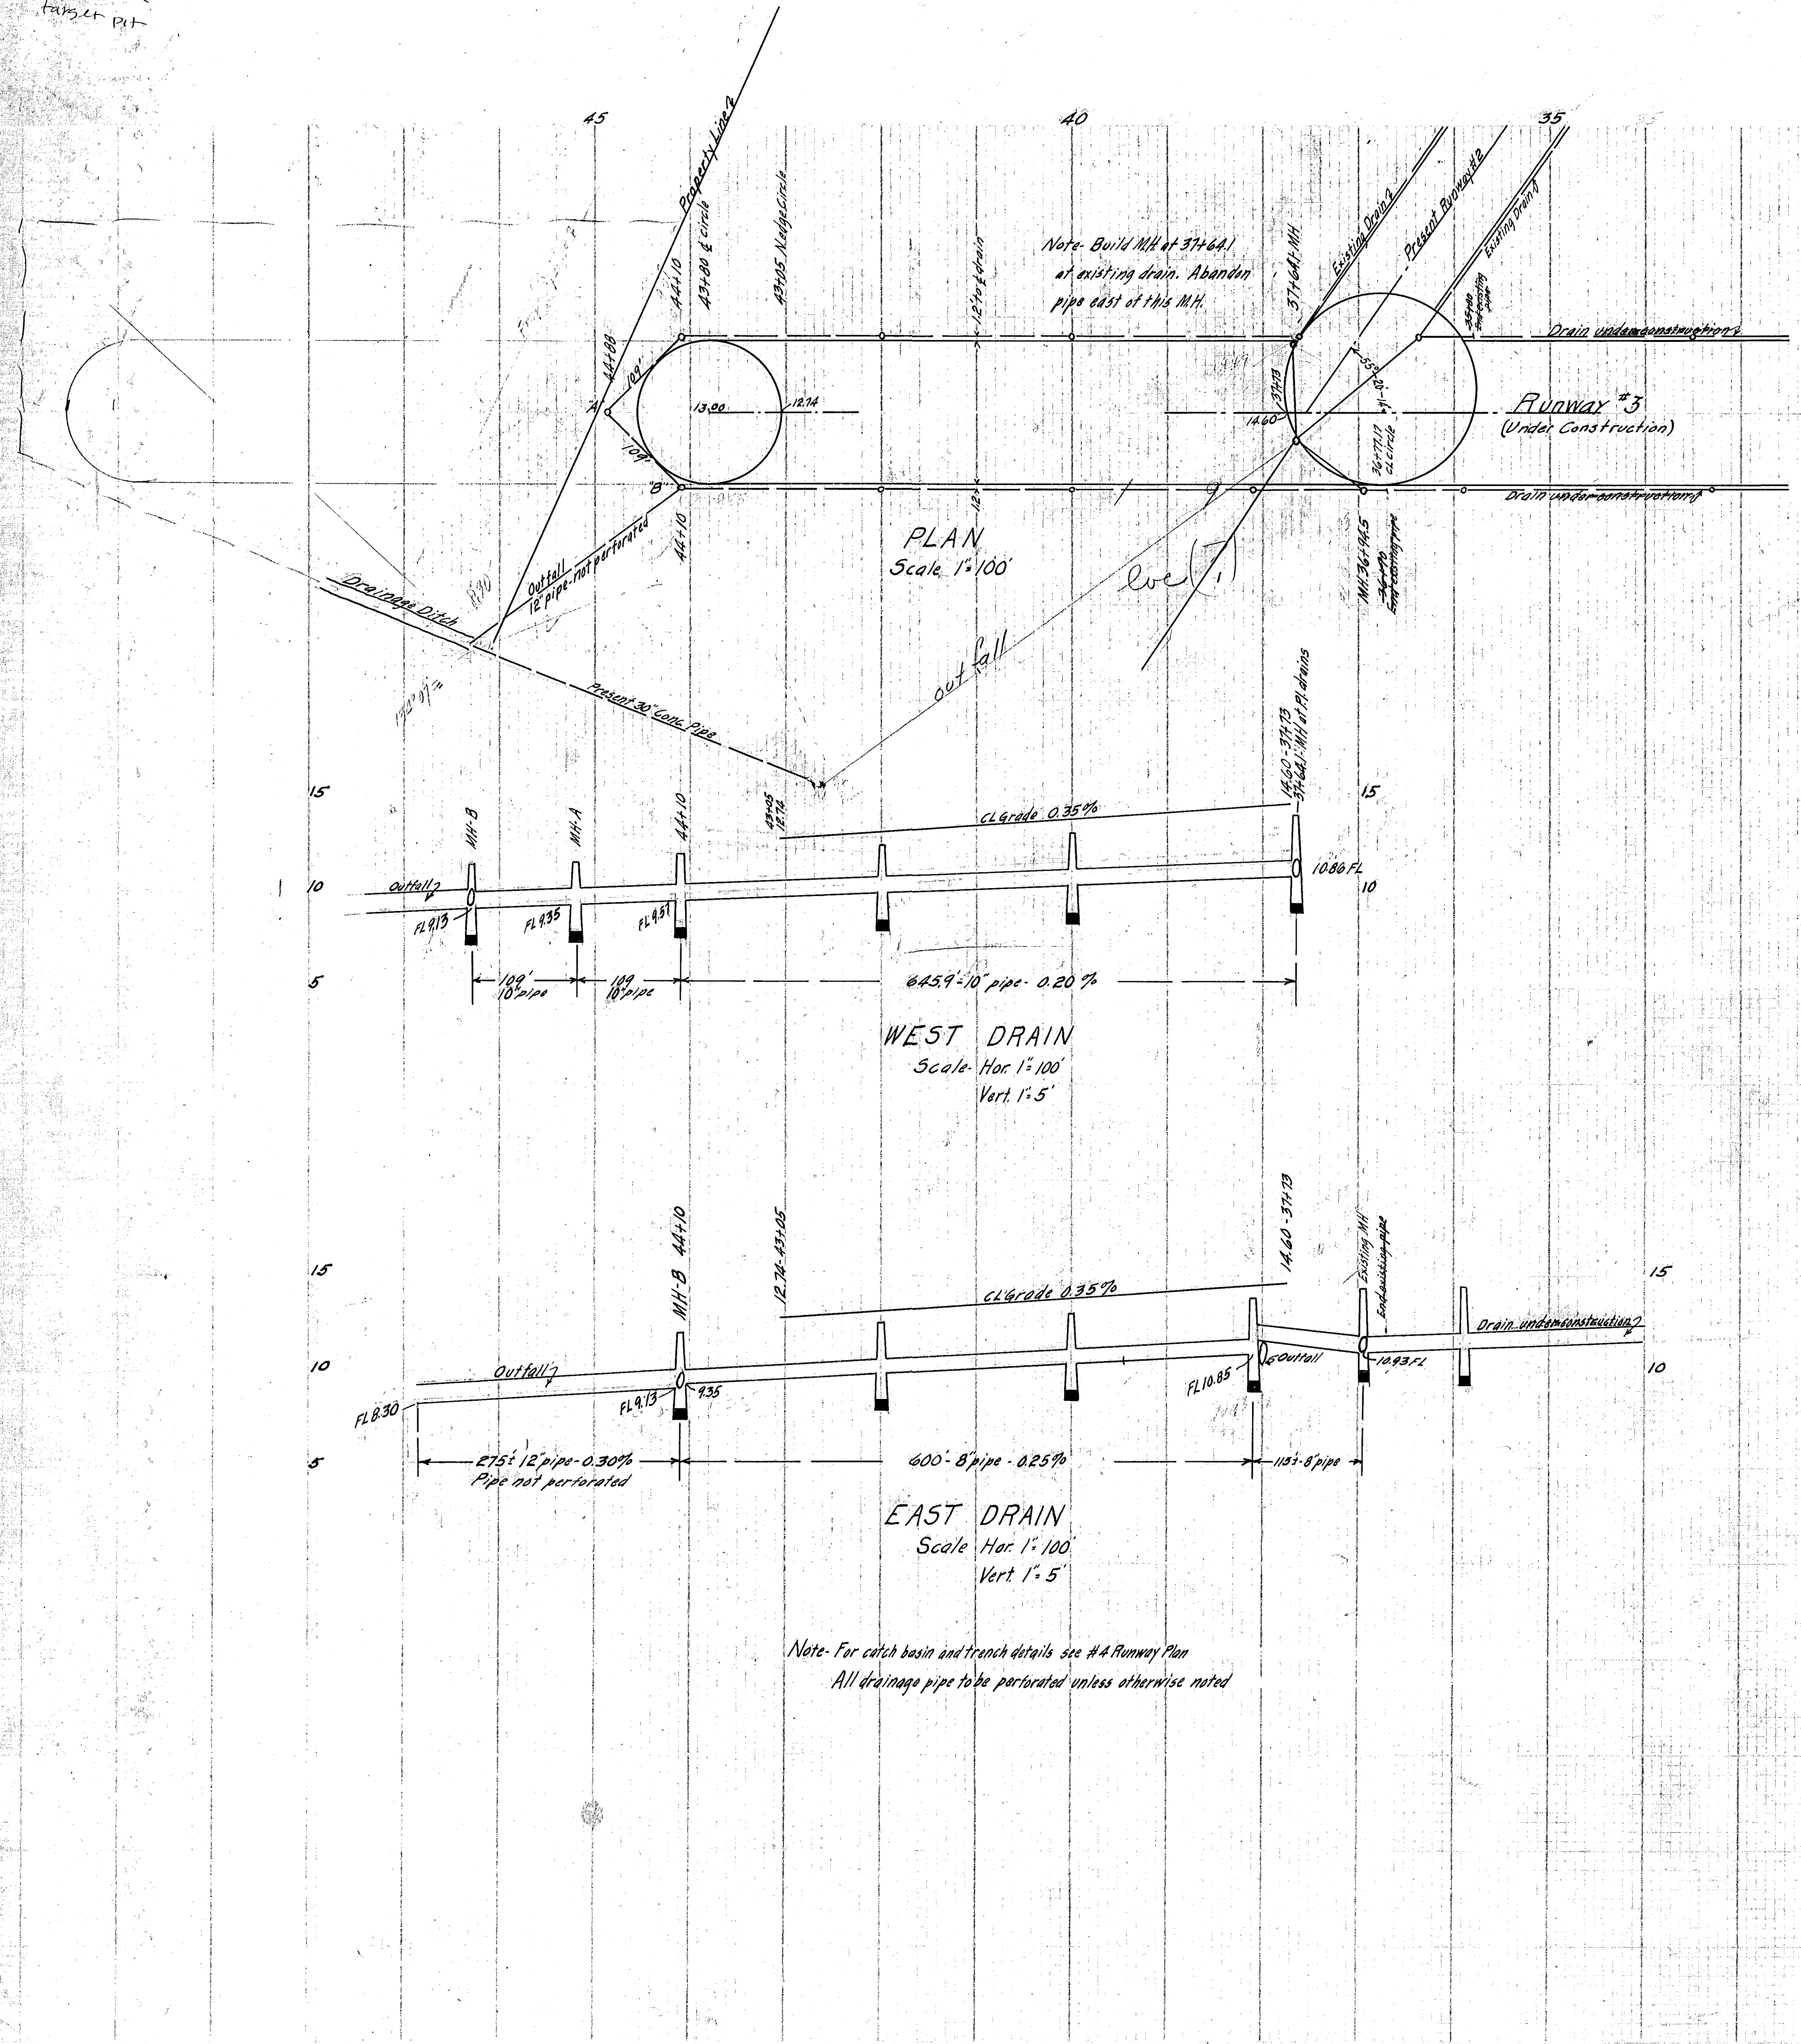


17.0' N.E.M. cone  
Tapered pit

VISION AND DRAINAGE  
EXTENSION OF NO. 3 RUNWAY

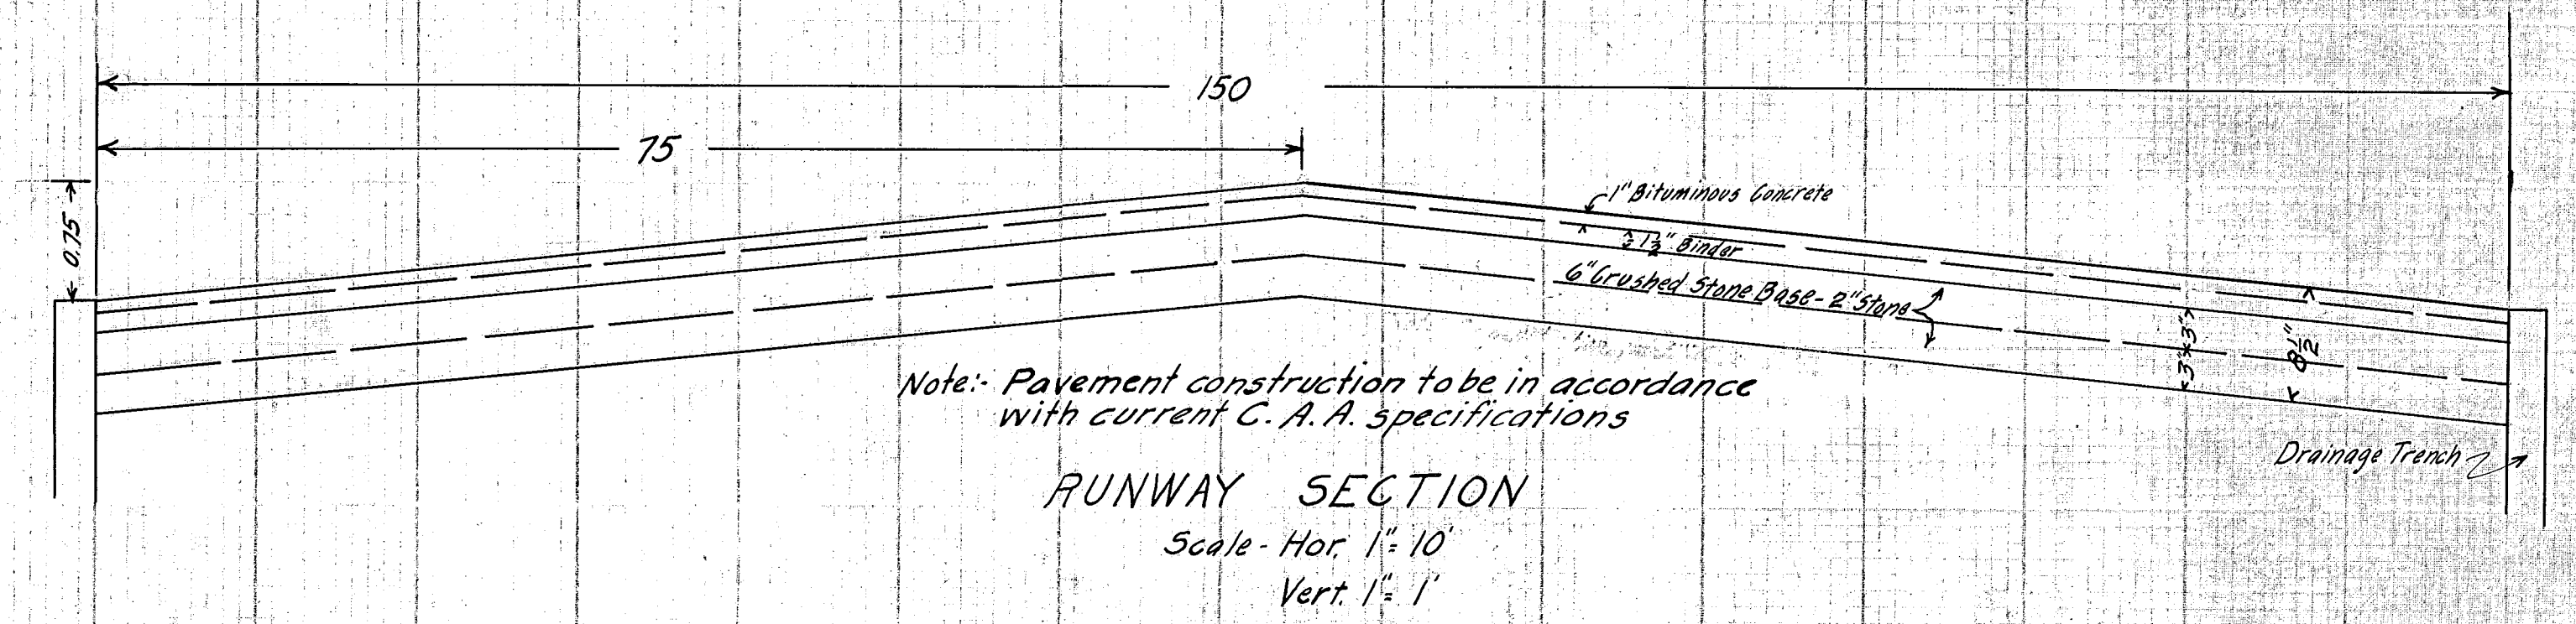

GRADING PLAN  
TURNING CIRCLE  
Radius 75'

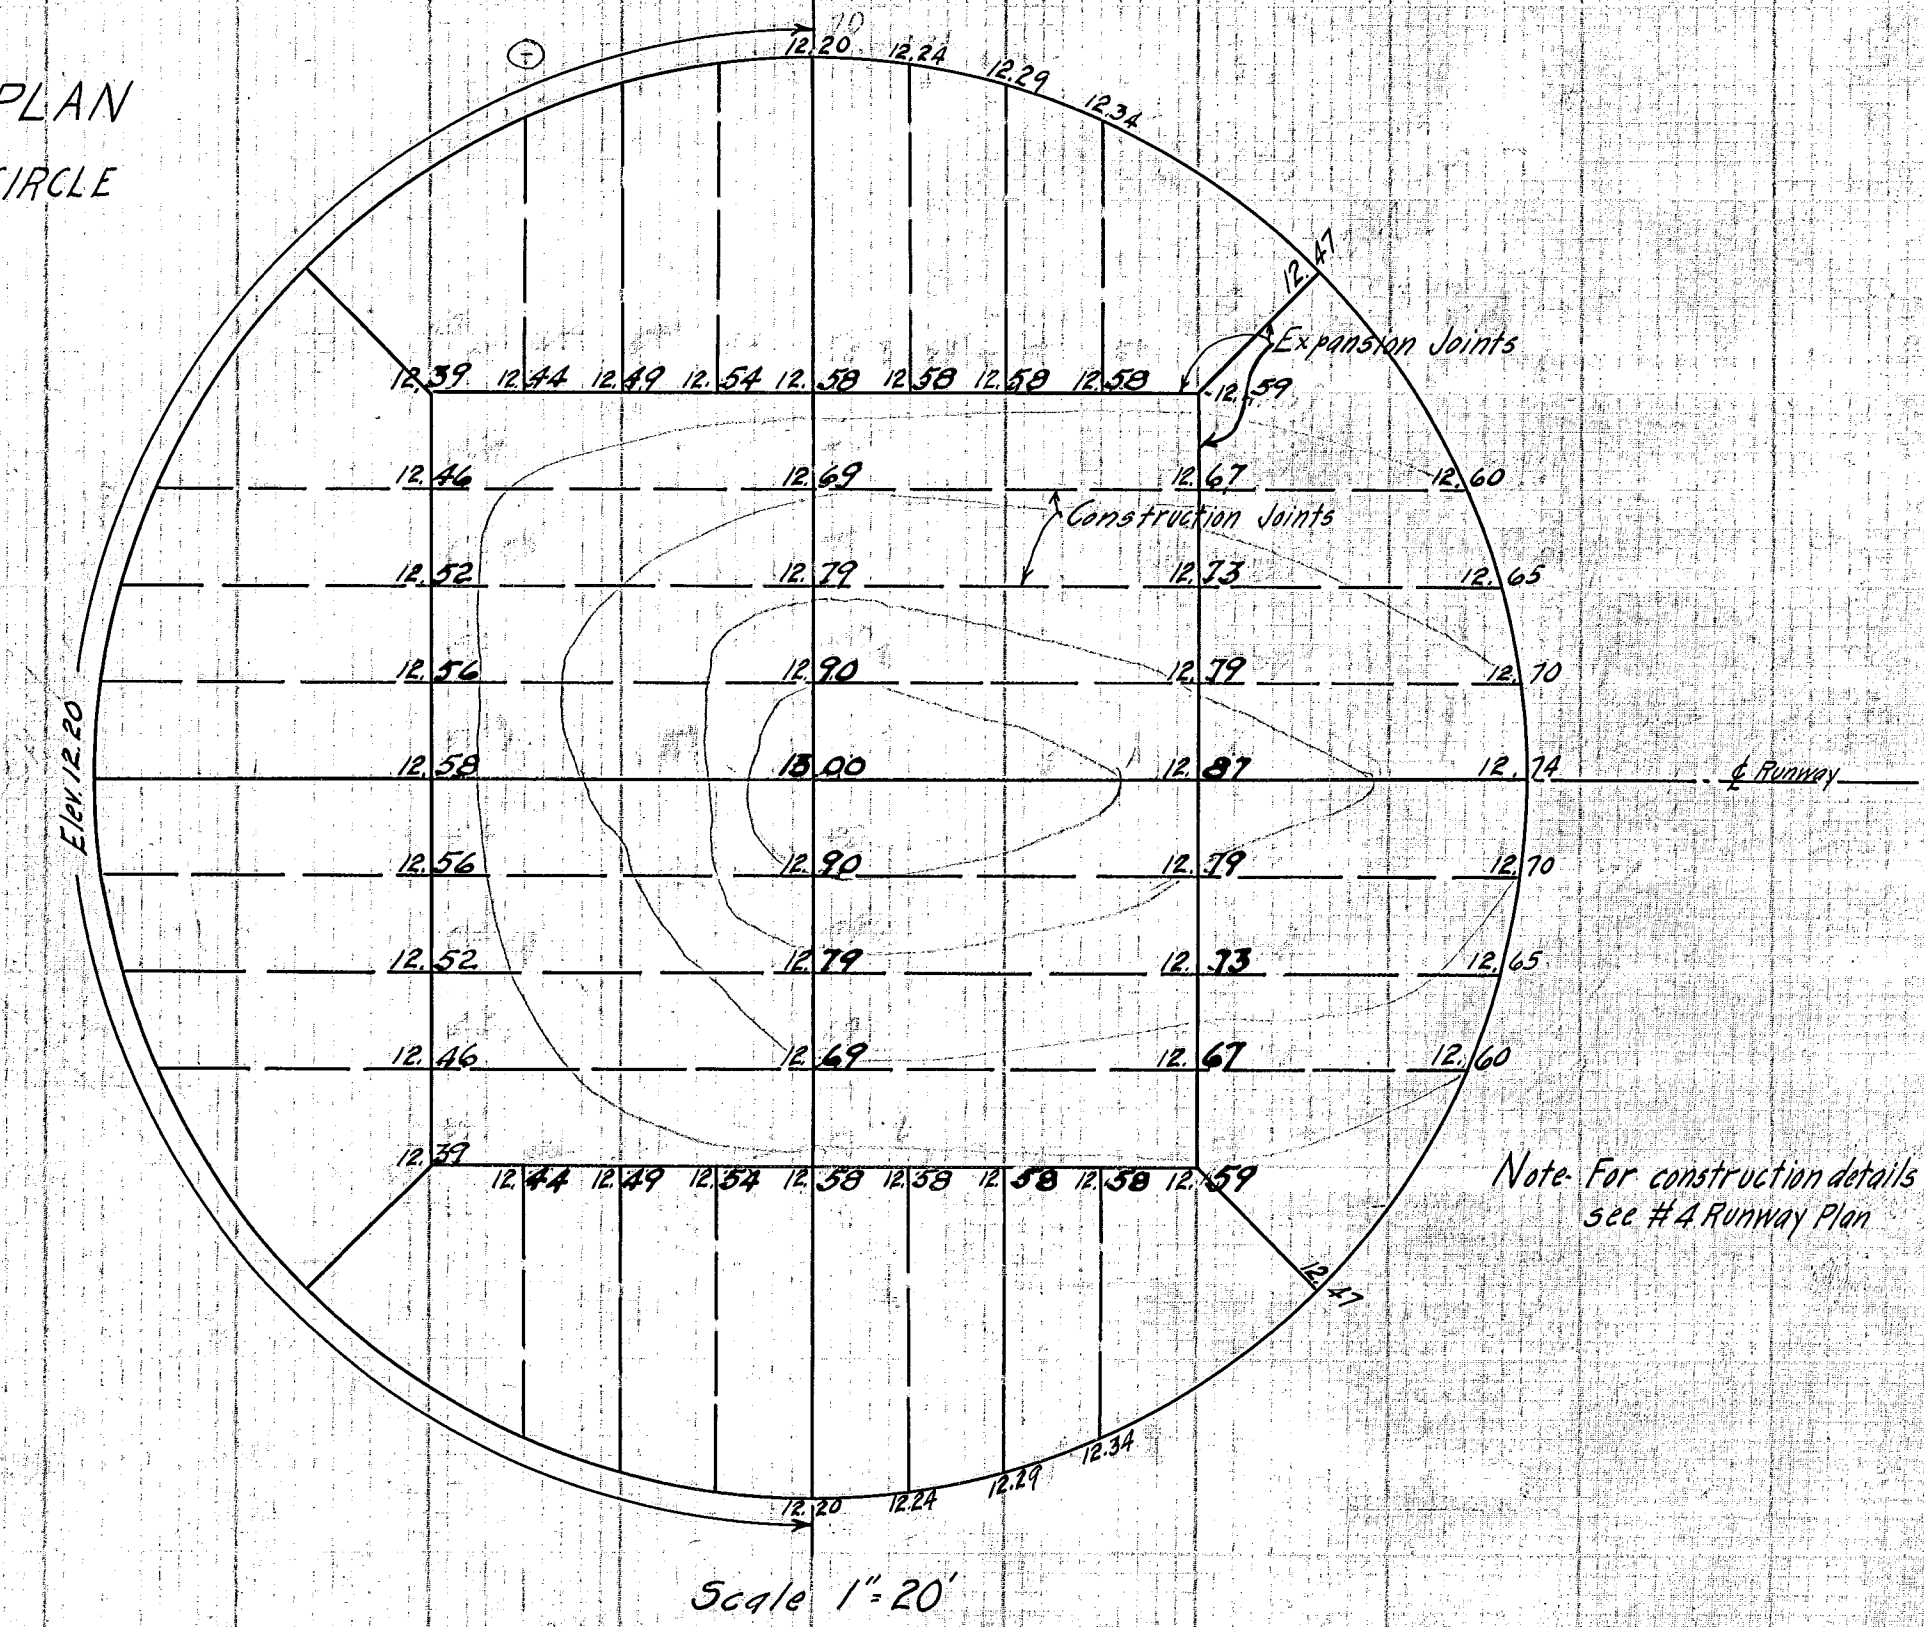

VISION AND DRAINAGE  
EXTENSION OF NO. 3 RUNWAY

|                                                                                                                                     |                                              |                                             |
|-------------------------------------------------------------------------------------------------------------------------------------|----------------------------------------------|---------------------------------------------|
| SHEET<br>1<br>OF 2 SHEETS                                                                                                           |                                              |                                             |
| DEPT. OF ENGINEERING, HARTFORD CONN.<br>ROBERT H. ROSS, CITY ENGINEER<br>FOR THE AVIATION COMMISSION<br>CITY OF HARTFORD<br>PLAN OF |                                              |                                             |
| EXTENSION OF NO. 3 RUNWAY<br>INCLUDING DRAINAGE<br>SCALES AS NOTED                                                                  |                                              |                                             |
| CERTIFIED<br>W. W. DeWitt<br>DIVISION ENGINEER                                                                                      | SUBMITTED<br>Robert H. Ross<br>CITY ENGINEER | APPROVED<br>Robert H. Ross<br>CITY ENGINEER |
| DESIGN BY: W.W.D.<br>TRACED BY: J.L.                                                                                                | DRAWN BY: J.L.<br>CHECK BY: W.W.D.           | DAYBOOK NO. 082.55<br>AUGUST 30, 1941       |

08255