


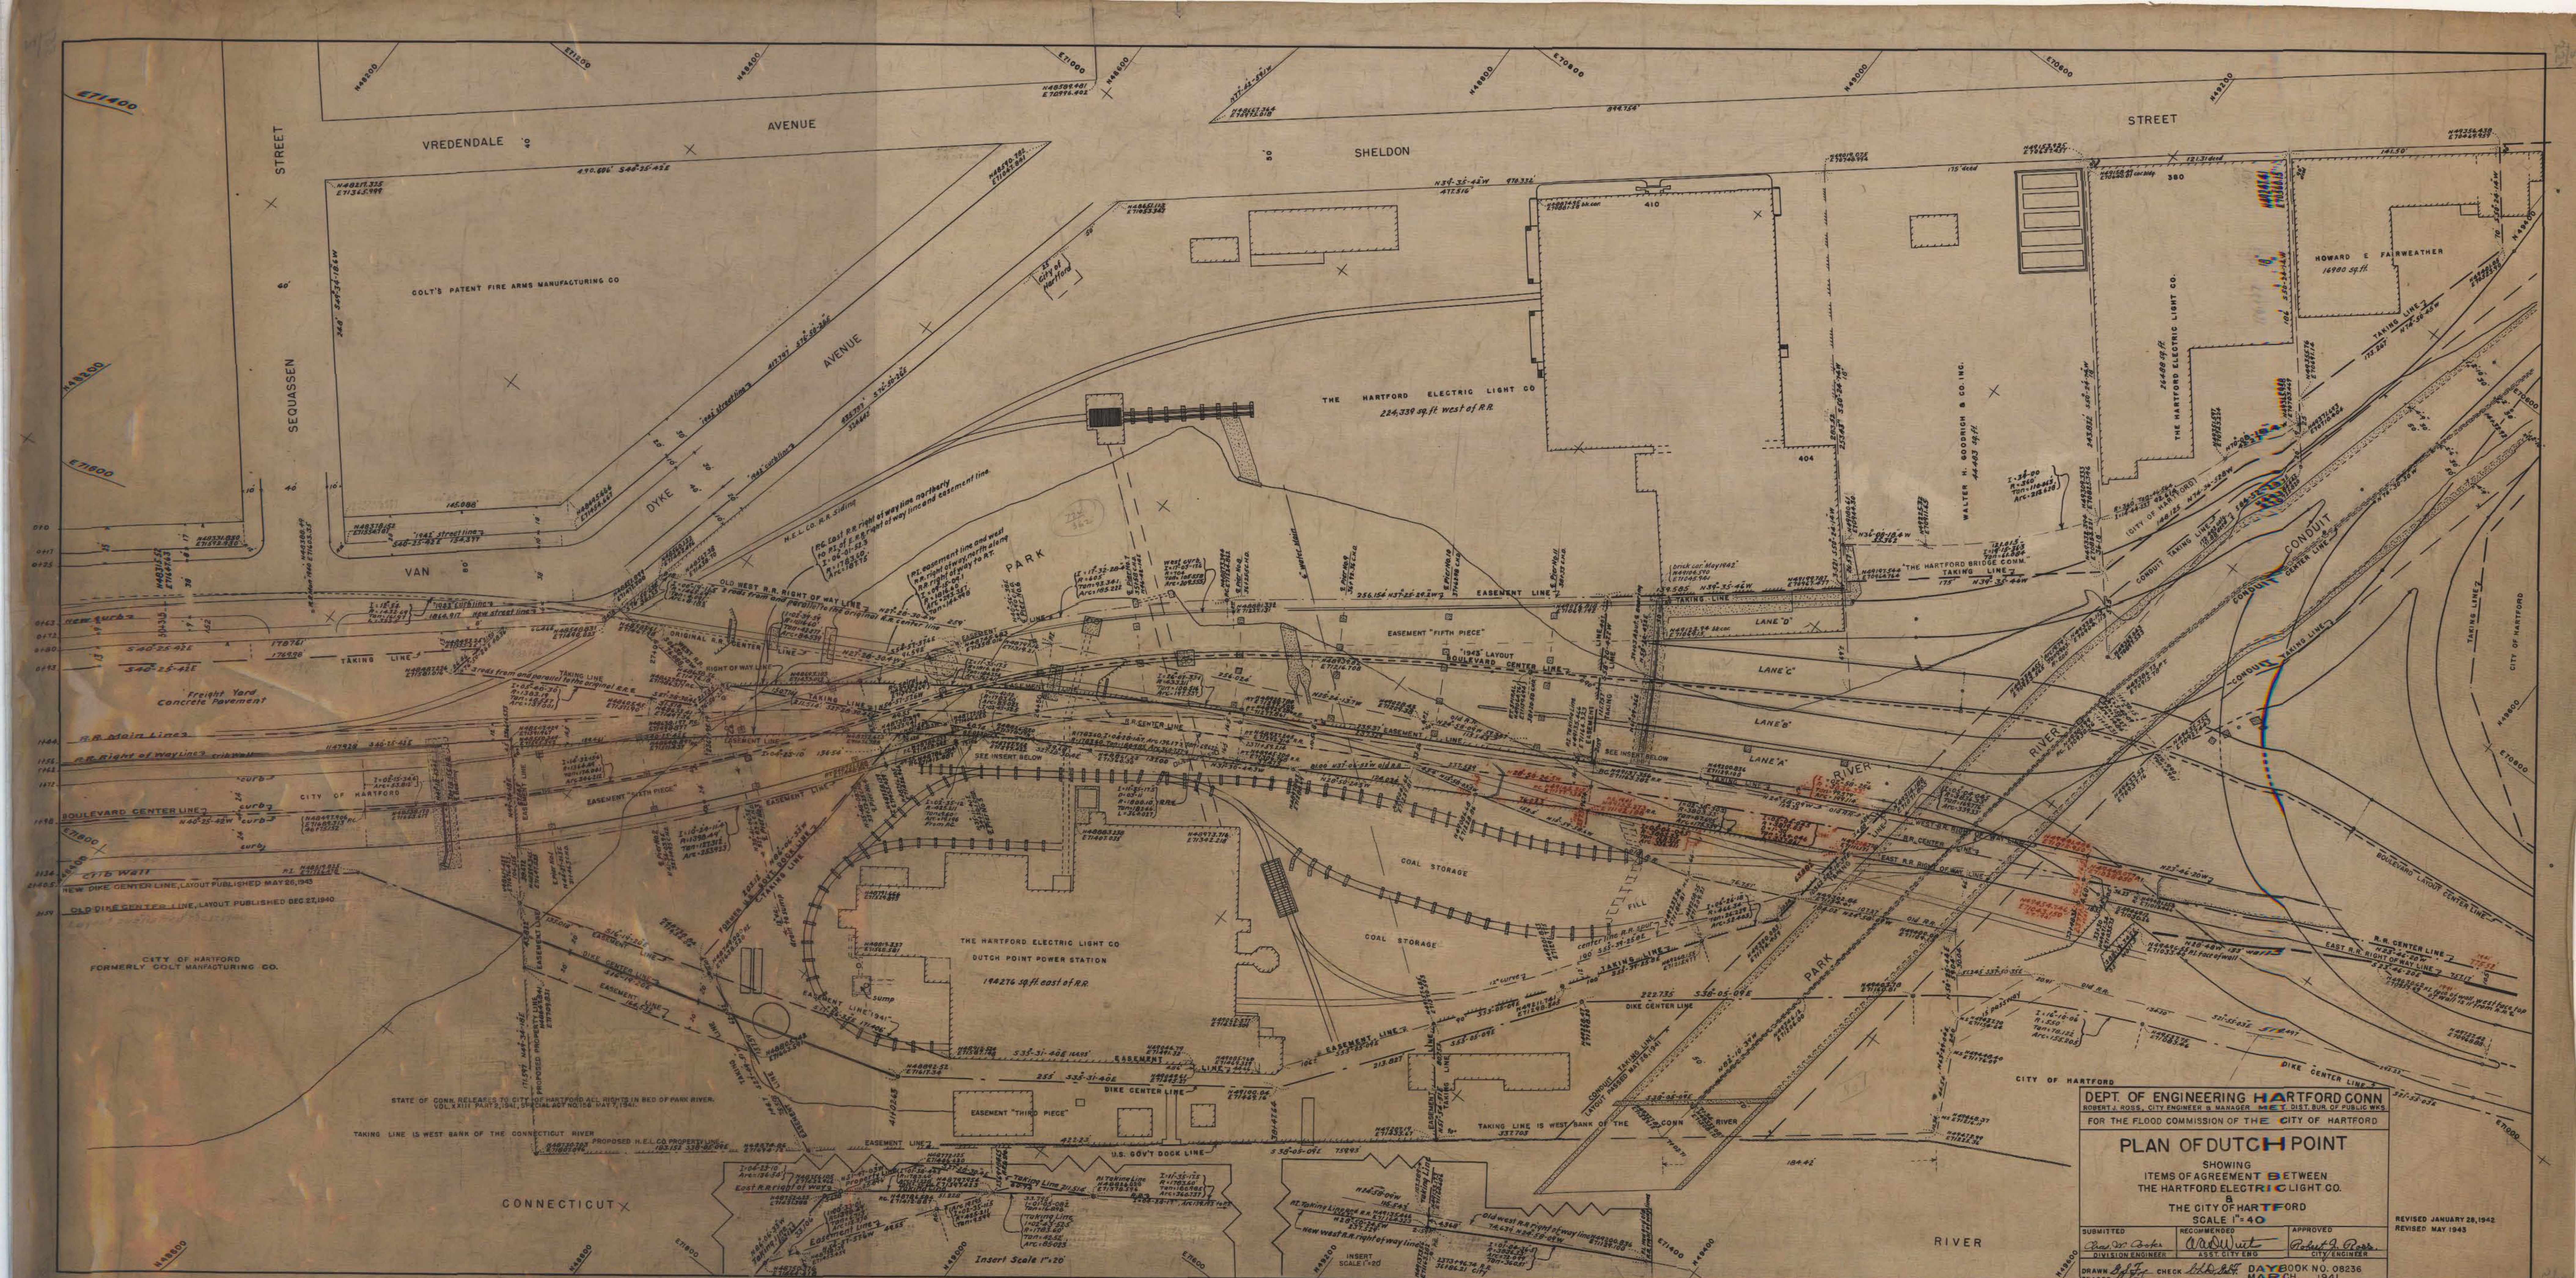

DEPT. OF ENGINEERING HARTFORD CONN.
ROBERT J. ROSS, CITY ENGINEER & MANAGER
FOR THE FLOOD COMMISSION OF THE CITY OF HARTFORD

PLAN OF DUTCH POINT
SHOWING
ITEMS OF AGREEMENT BETWEEN
THE HARTFORD ELECTRIC LIGHT CO.
AND
THE CITY OF HARTFORD
SCALE 1"=40'

SUBMITTED: *Robert J. Ross*
RECOMMENDED: *Robert J. Ross*
APPROVED: *Robert J. Ross*

DRAWN: *Robert J. Ross*
CHECKED: *Robert J. Ross*
BOOK NO. 08236
MARCH 1941

REVISED JANUARY 28, 1942
REVISED MAY 1943

FOR PLAN AND PROFILE VALLEY BRANCH R.R. AND HIGHWAY LAYOUT POTTER STREET TO WAWARNE AVENUE SEE MAP NO. 08236, DATED JANUARY 28, 1942, FILE NO. 555-4
FOR "OZALIDE" TRACING SHOWING CROSS HATCHED PARCELS SEE 551-2A