

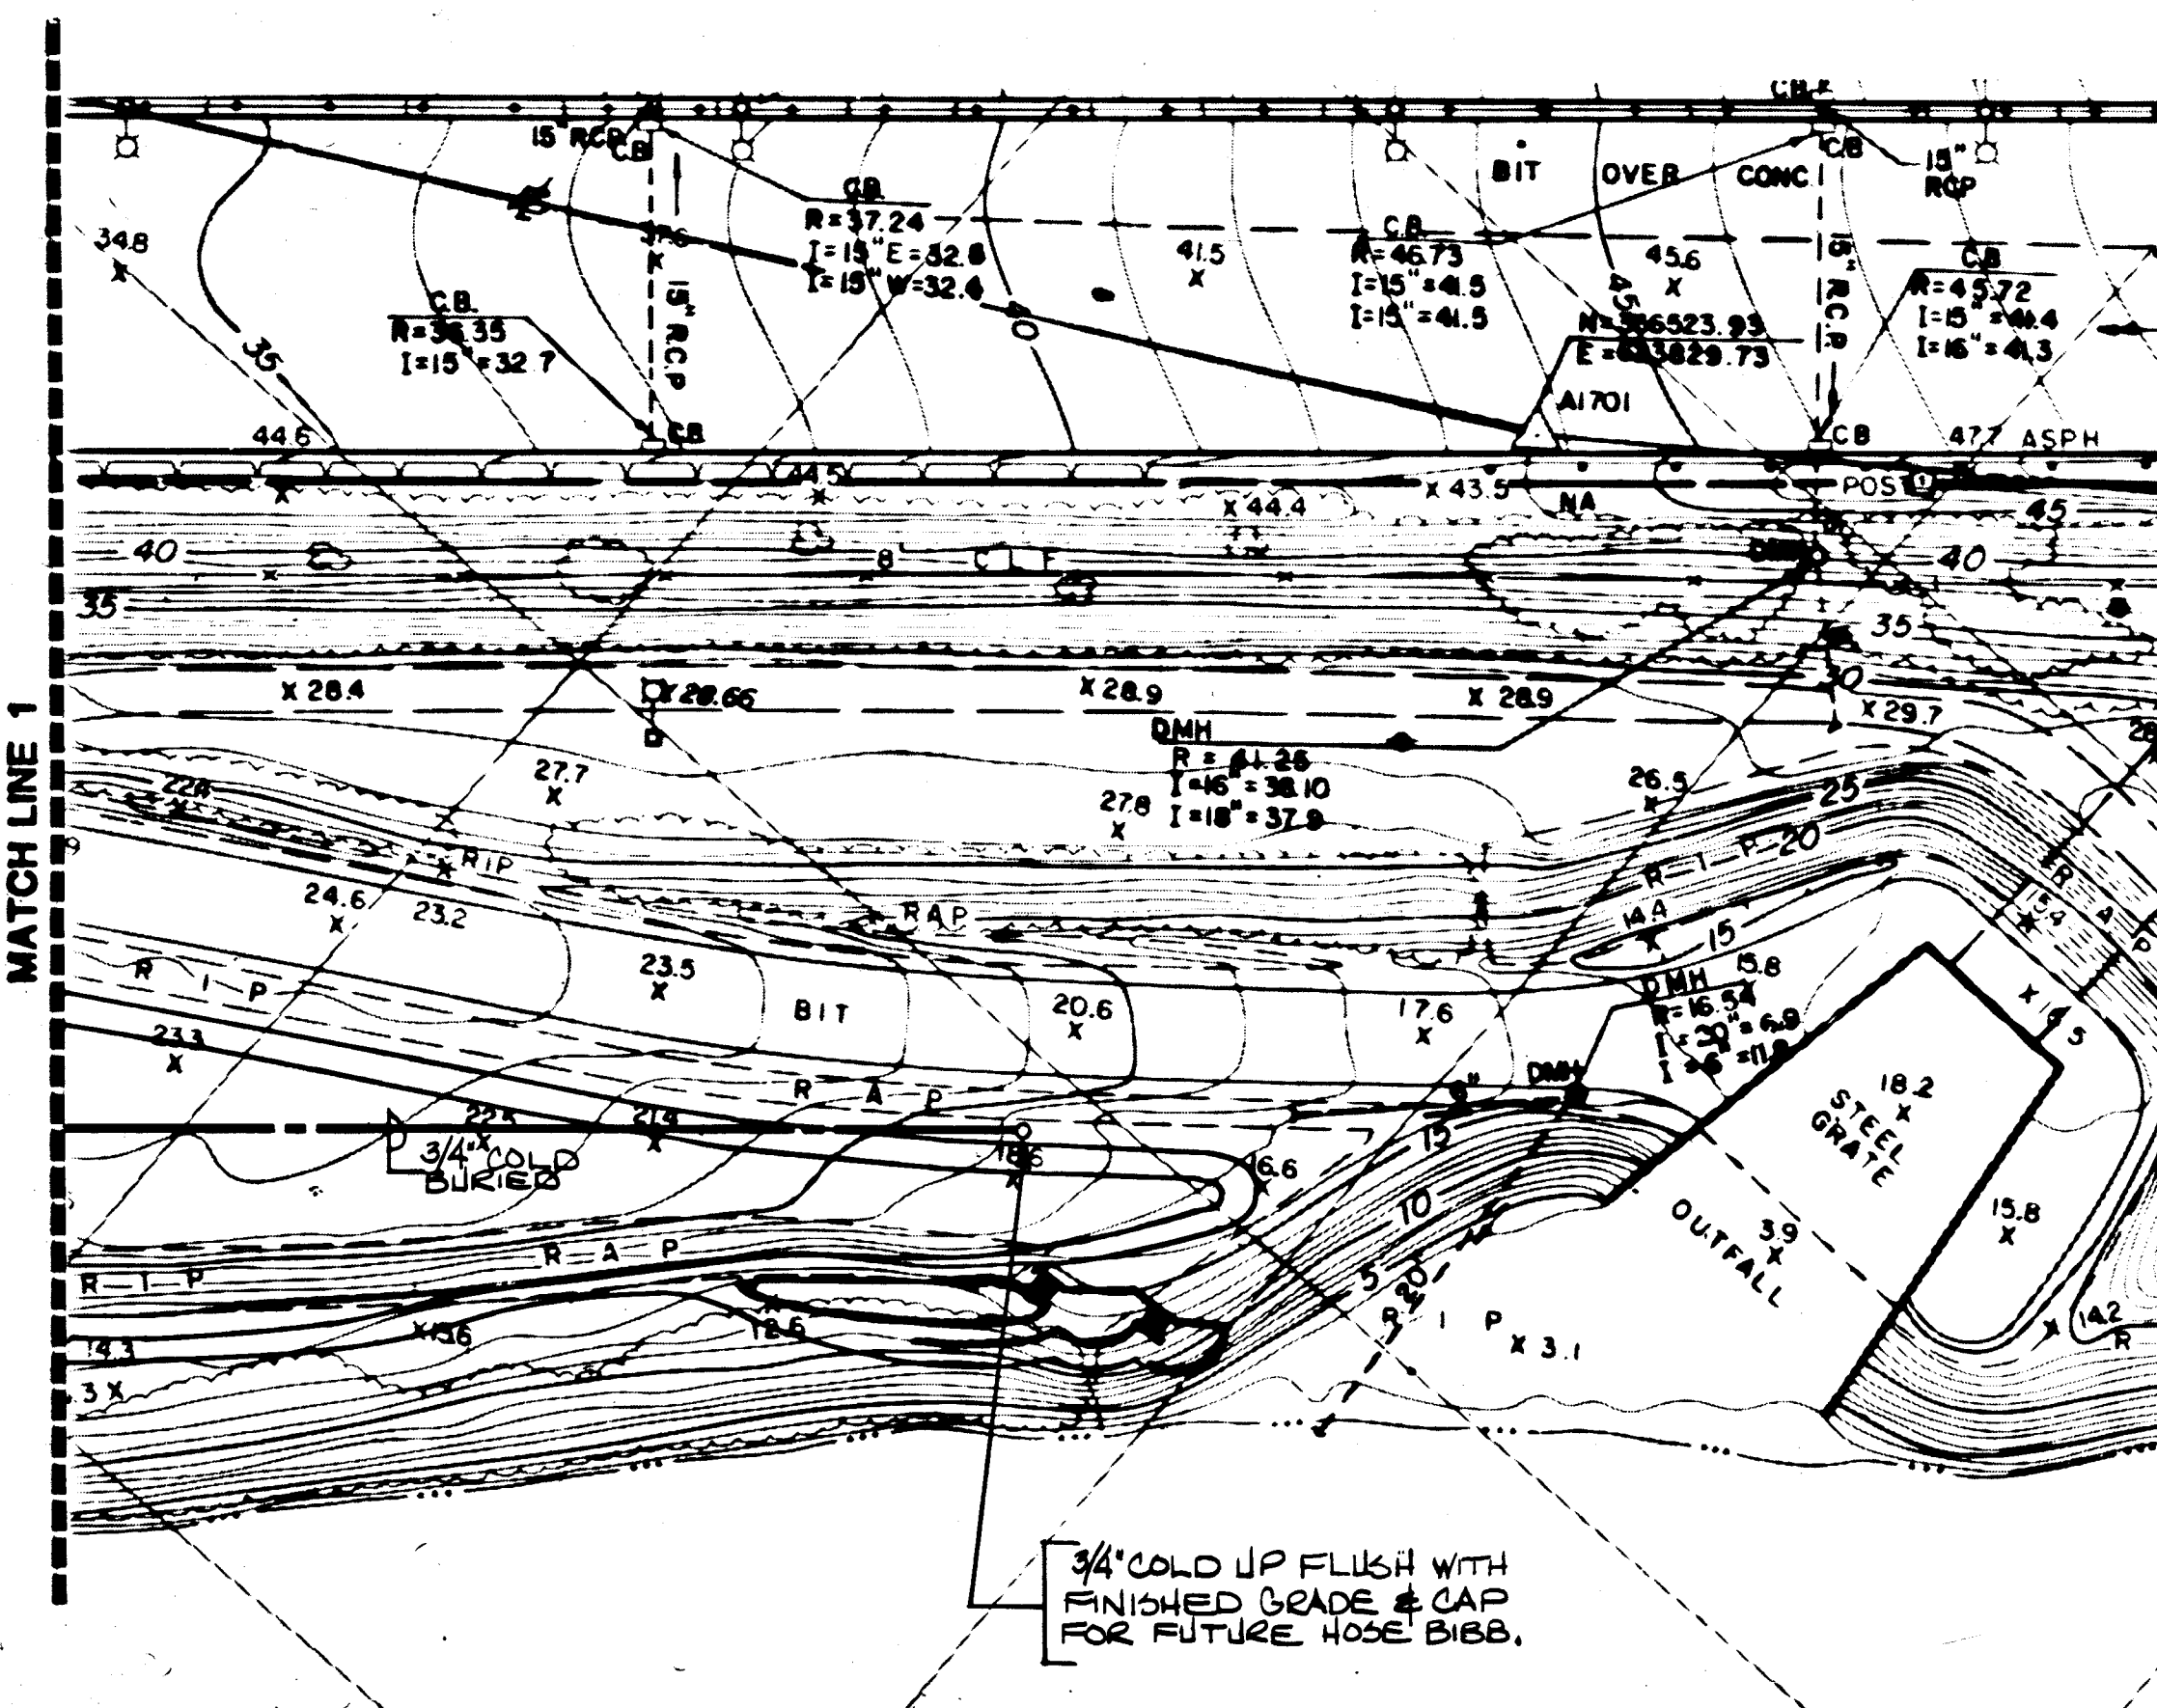


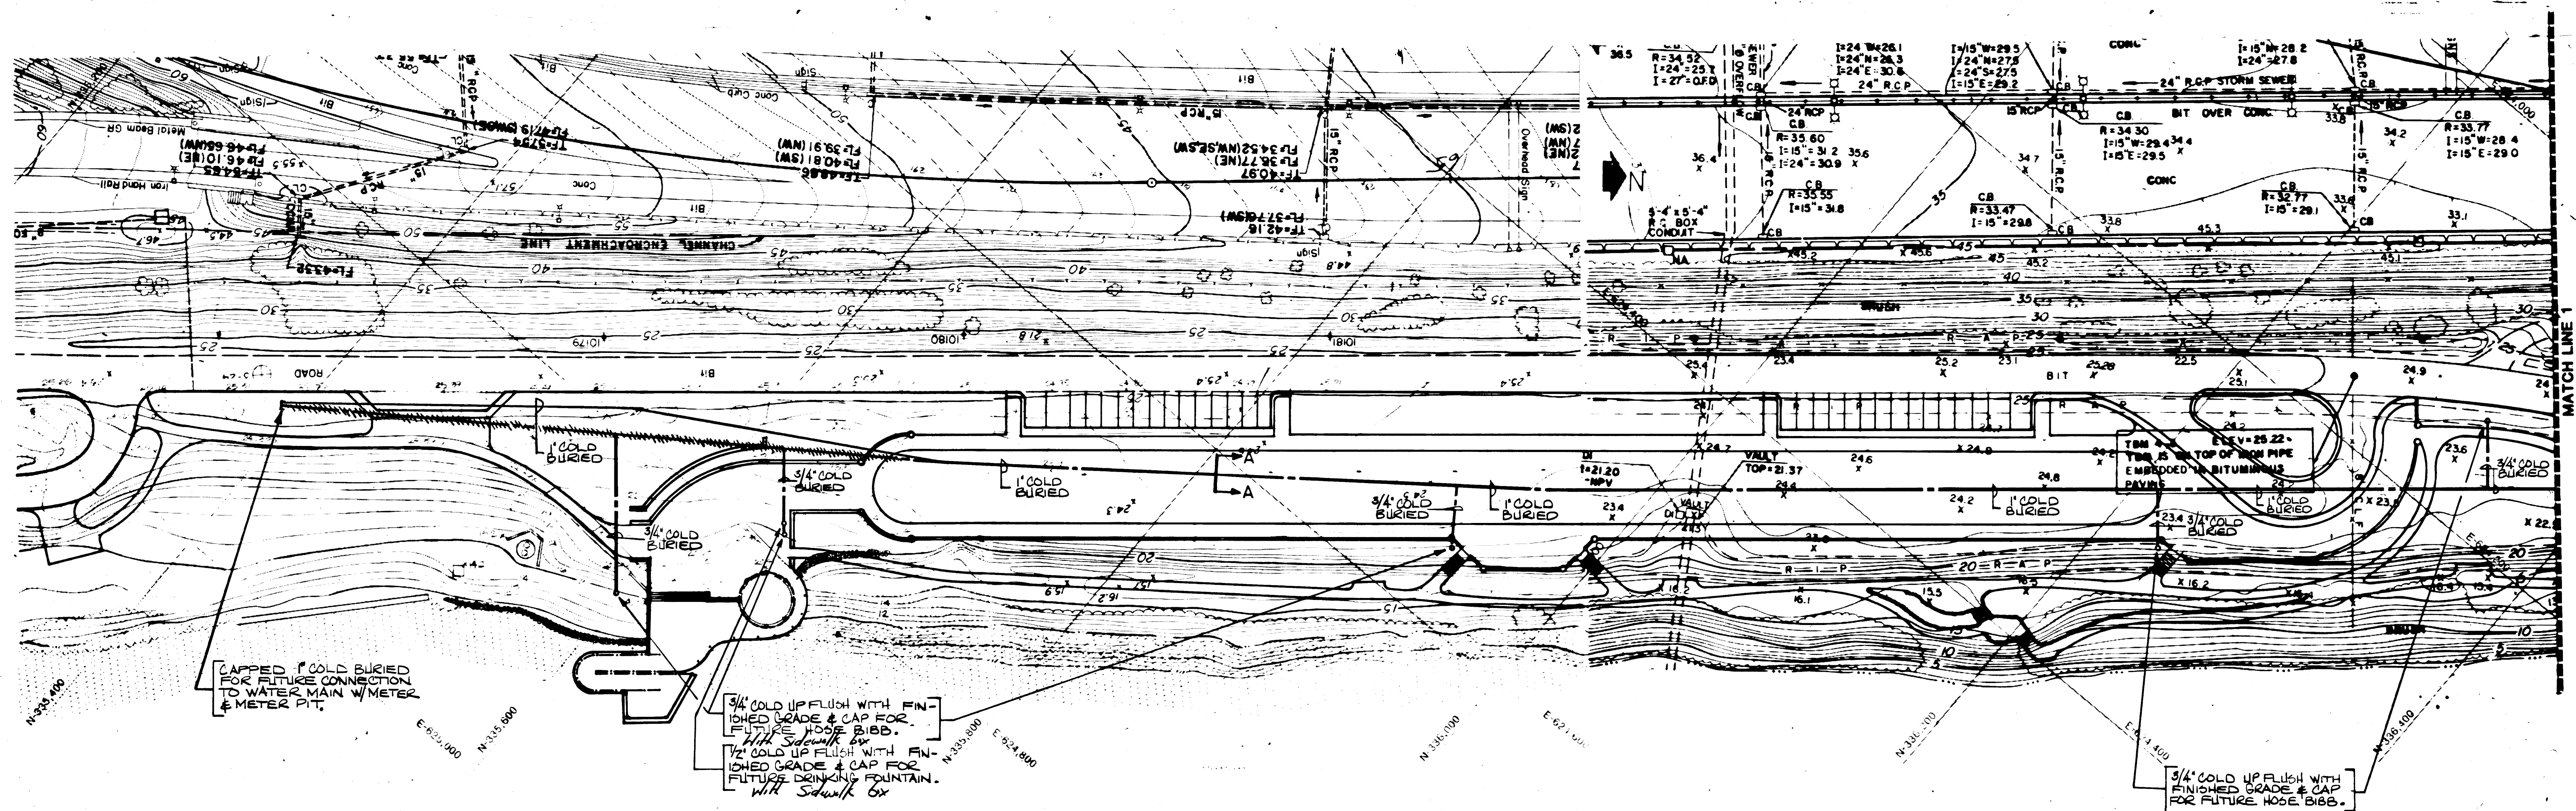

PLUMBING SITE PLAN 1"=40'-0"

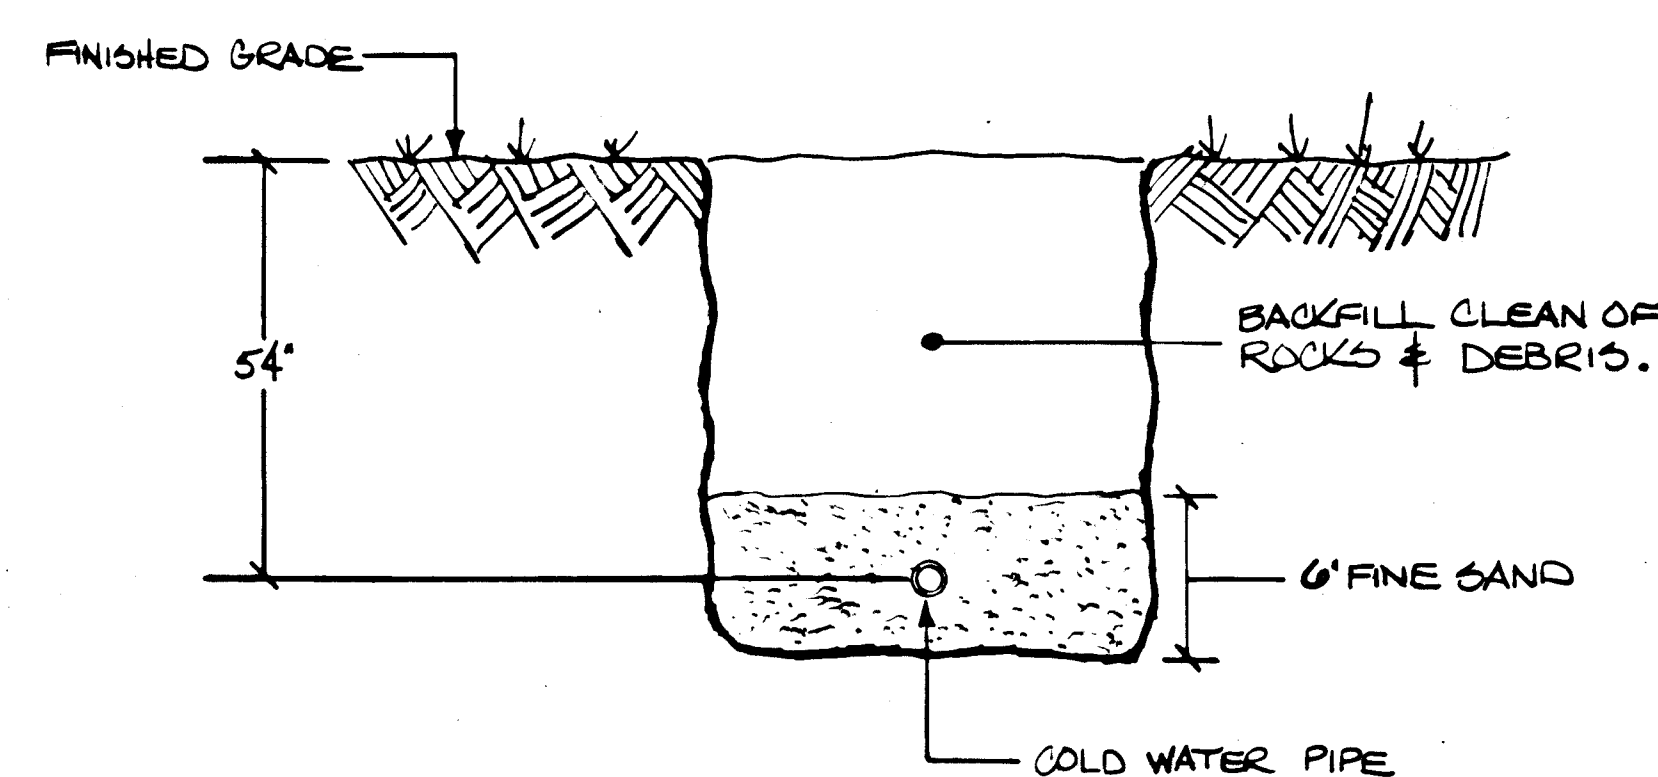


SECTION A-A
NOT TO SCALE

NOTES

- 1) ALL WATER PIPING SHALL BE TYPE "K" SOFT COPPER WITH FLARED COMPRESSION FITTINGS. LAY ON 3" OF FINE SAND.
- 2) MINIMUM BURY DEPTH FOR ALL WATER PIPING SHALL BE 54" BELOW FINISHED GRADE.
- 3) ALL EXCAVATION, BACKFILL, PAVING, SEEDING & CONCRETE BY GENERAL CONTRACTOR.

SYMBOLS

COLD WATER	---
GATE VALVE	⊞
HOSE BIBB	⊕
DRINKING FOUNTAIN	⊙

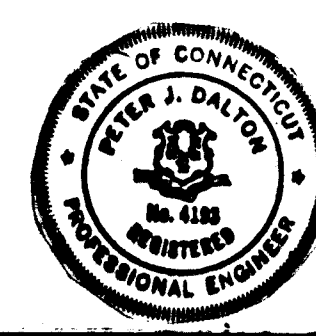

PETER J. DALTON
ASSOCIATES
CONSULTING ENGINEERS
WEST HARTFORD, CONN.



CHARTER OAK PARK
HARTFORD, CONNECTICUT



Riverfront Recapture Inc.
103 Constitution Plaza
Hartford Connecticut 06103
(203) 277-6691

Carol R. Johnson and Associates Inc.
LANDSCAPE ARCHITECTS SITE PLANNERS
1100 Massachusetts Avenue
Cambridge Massachusetts 02138 (617) 888-6115

Date: 28 DEC. 87
Drawn By: PL
Checked By: PD
Revisions:
1) TO CITY HARTFORD REV. 10-19-87
2) TO CITY HARTFORD REV. 12-11-87
3) TO CITY HARTFORD REV. 12-25-87
SCALE: 1"=40'-0"
DAYBOOK NO. 011055

PLUMBING PLAN

PI