



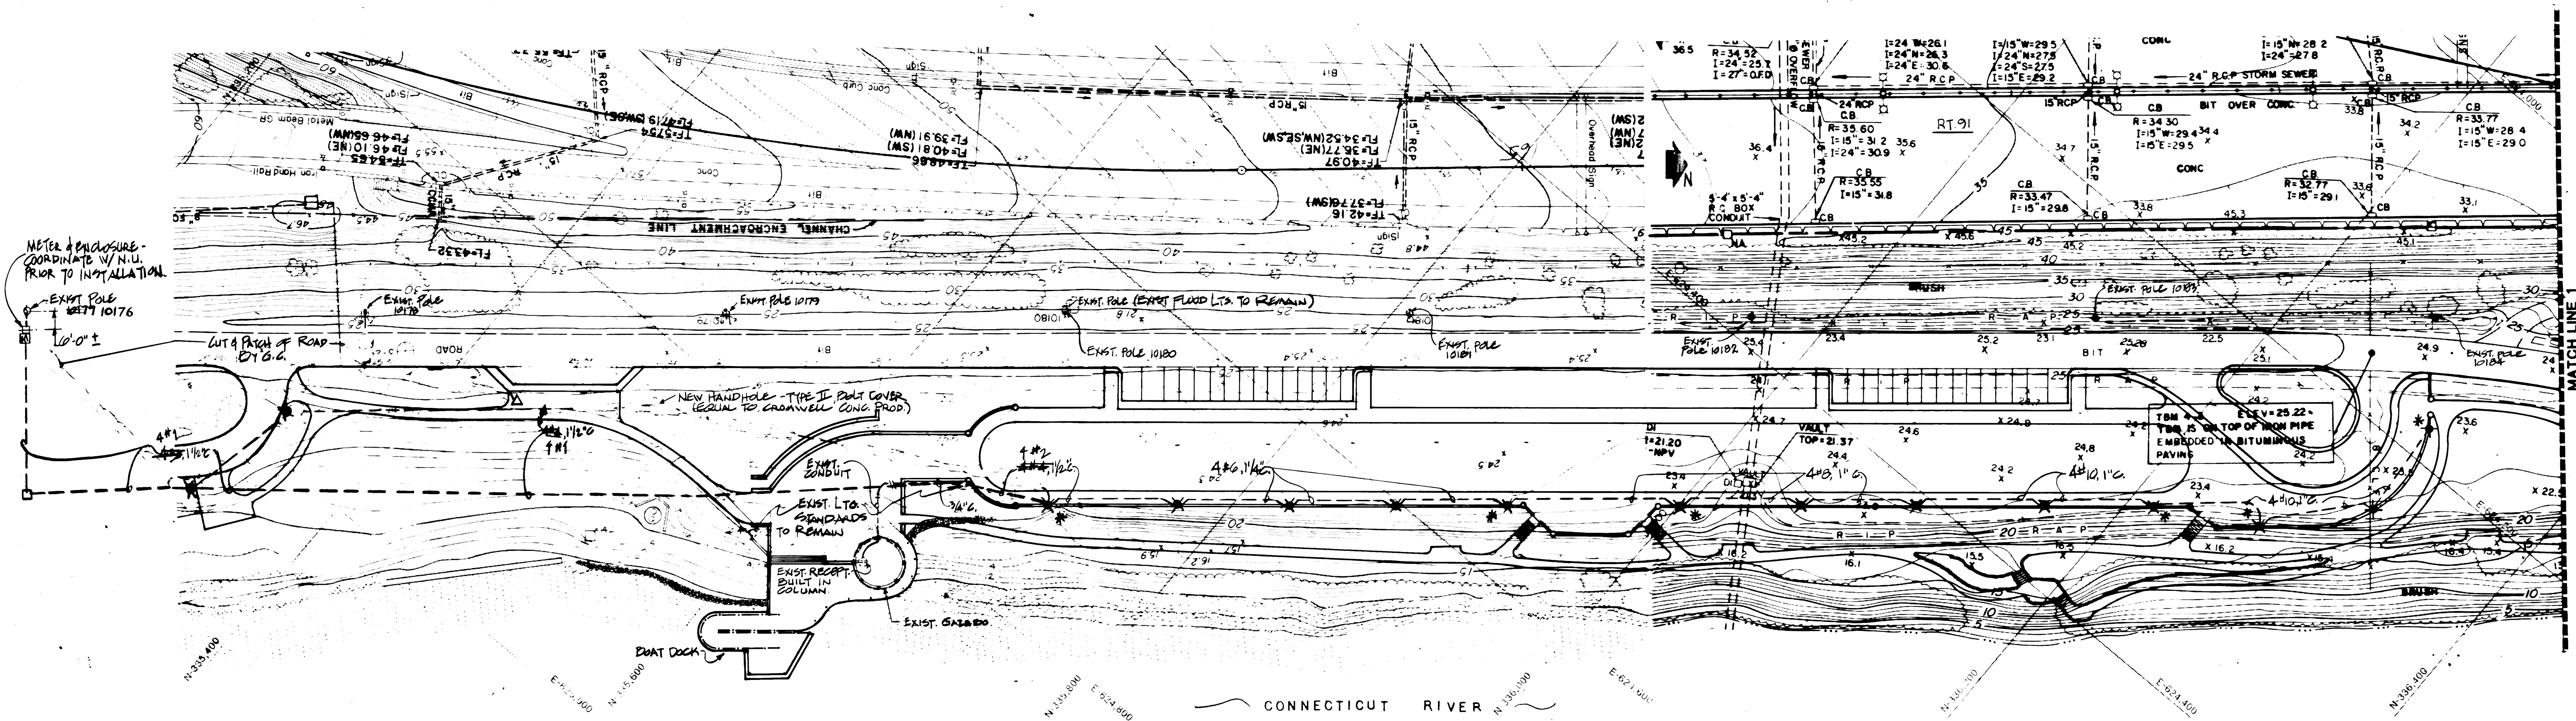


ELECTRICAL SITE PLAN

SCALE : 1" = 40

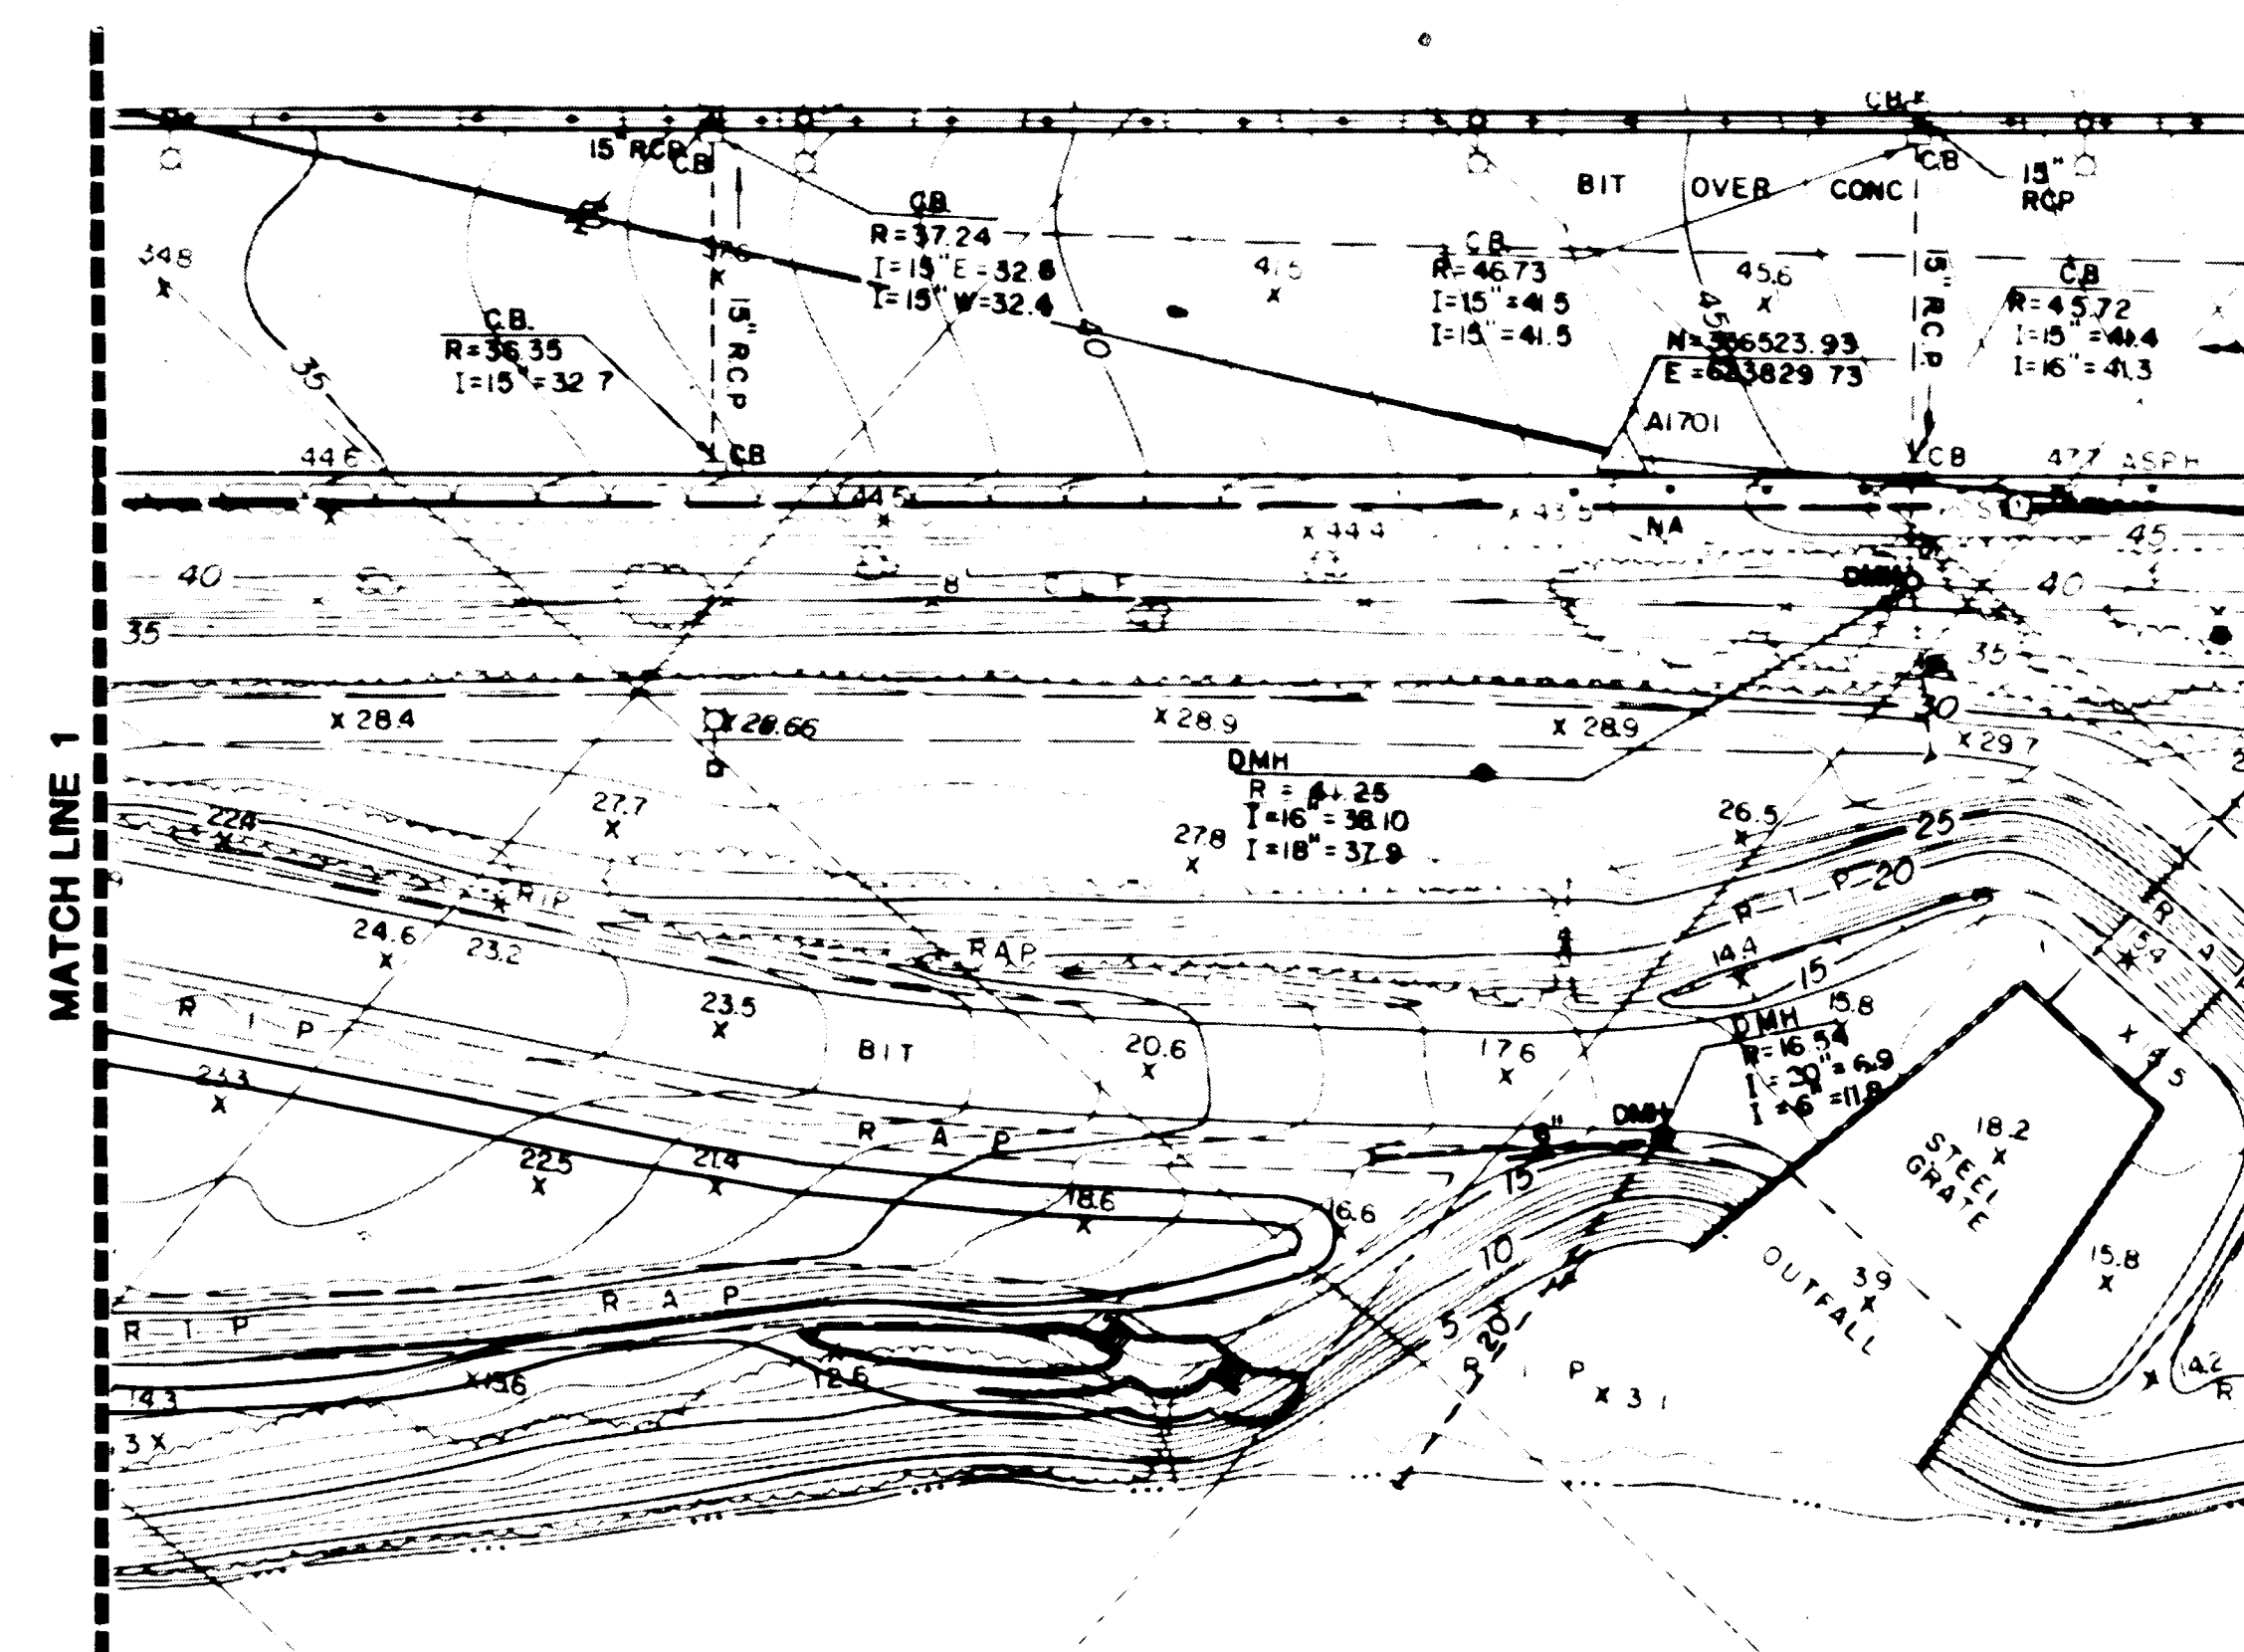

L E G E N D

- ◆ LIGHTING STANDARD - SEE DETAIL
▽ TELEPHONE - PAY STATION
---- UNDERGROUND WIRING - TYPE AS NOTED

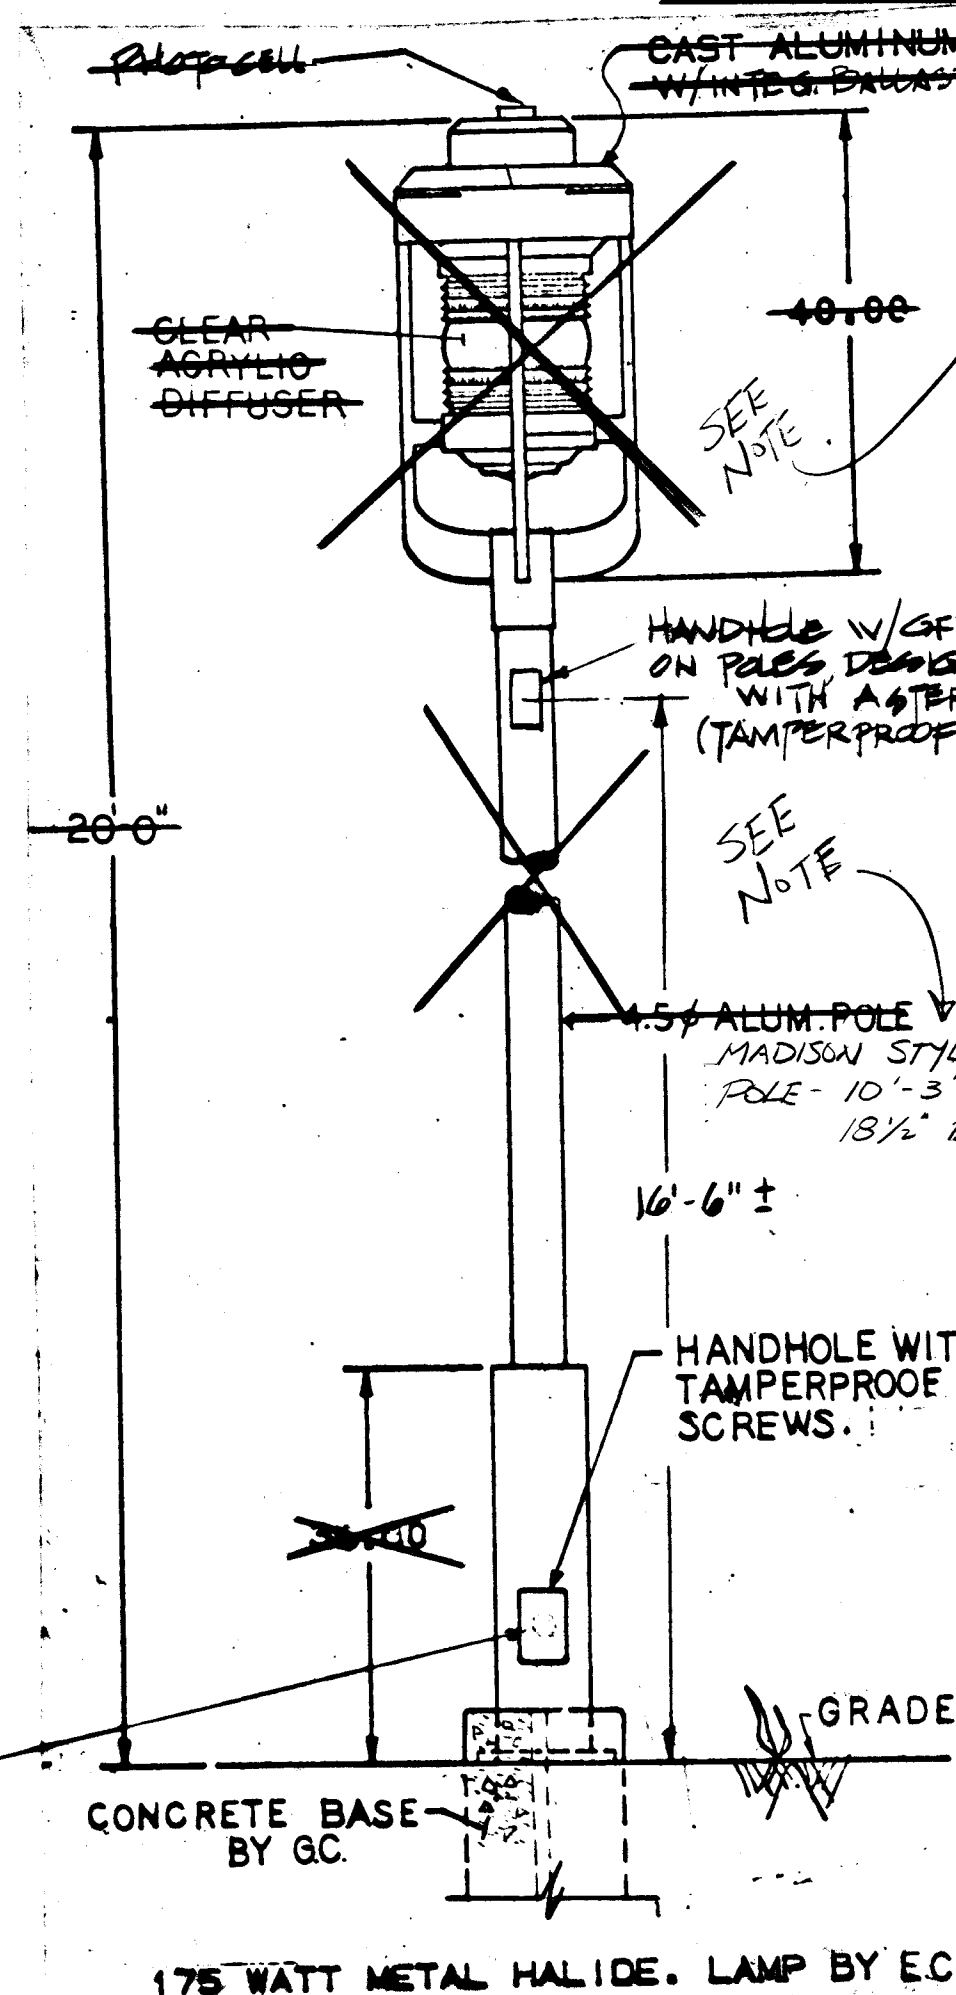

DETAIL - LIGHTING STANDARD



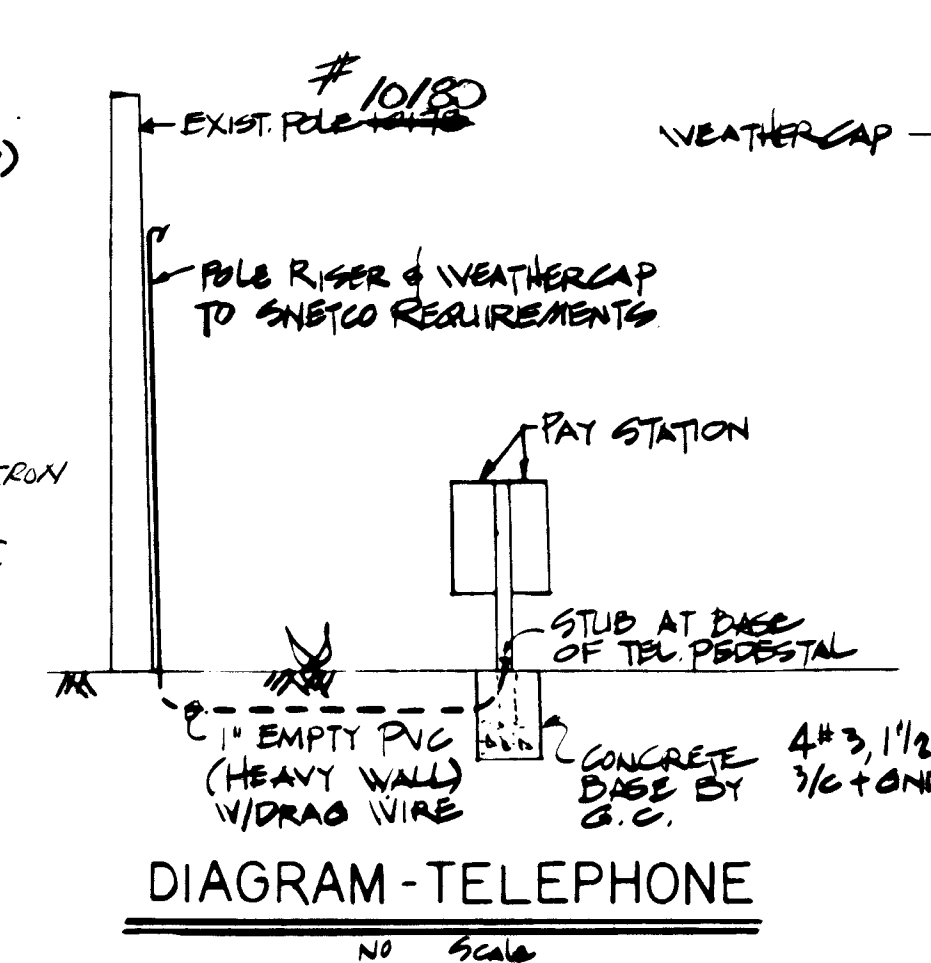


DIAGRAM - TELEPHONE

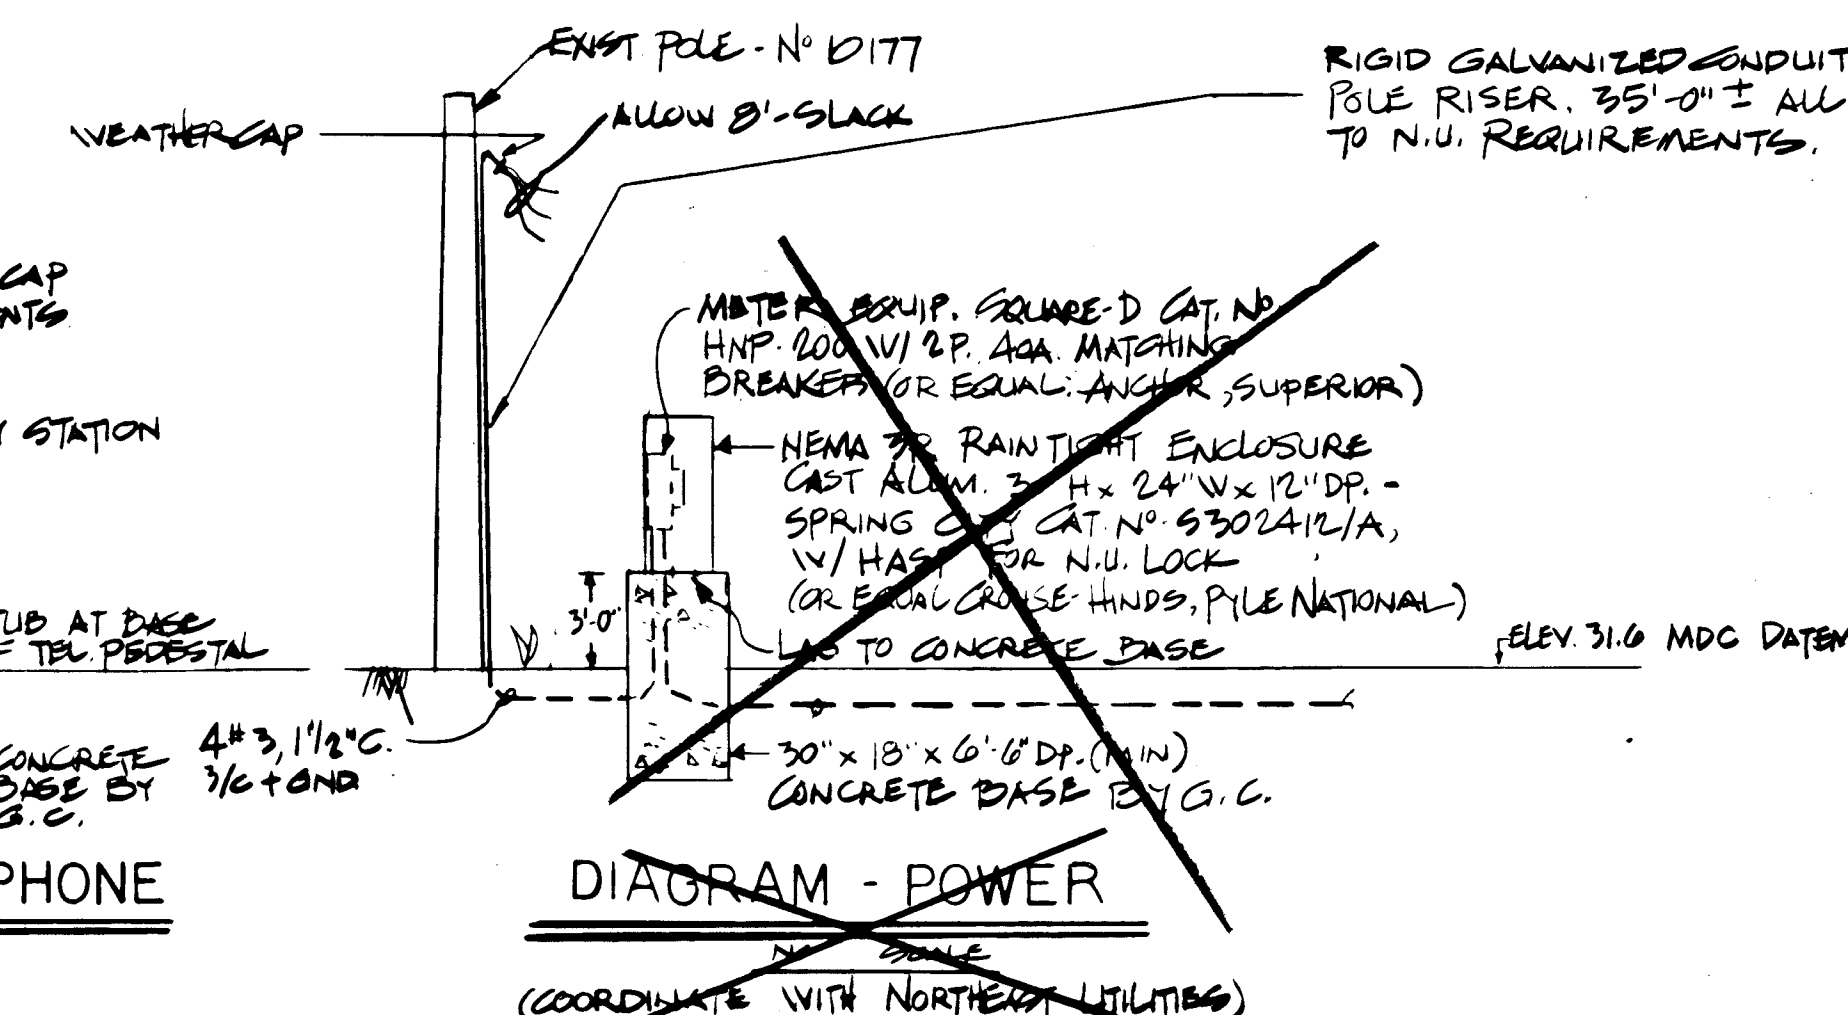


~~DIAGRAM - POWER~~

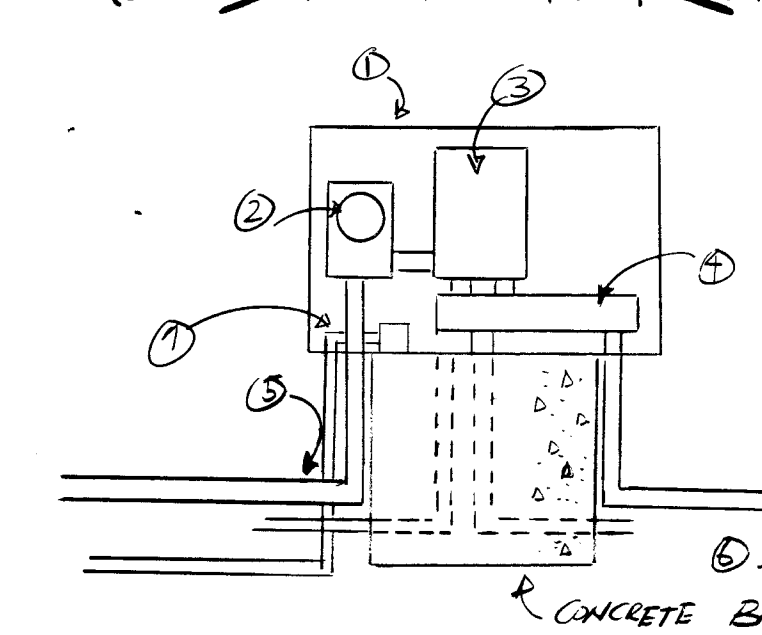

REVISED POWER

NOTES

1. ALL SERVICE WORK TO BE IN STRICT ACCORDANCE WITH N.E.C. & SNETCO REQUIREMENTS.
2. CONDUITS TO BE HEAVY WALL PVC, EXCEPT FLE RISER
3. ALL SPICES SHALL BE WATERPROOF CABLE SPICE TYPE

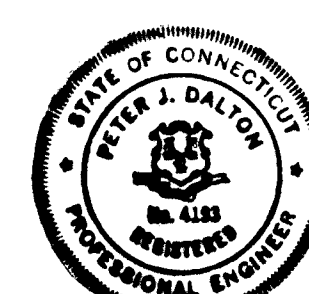

PETER J. DALTON
ASSOCIATES
CONSULTING ENGINEERS
WEST HARTFORD, CONN.



CHARTER OAK PARK



Carol R. Johnson and Associates Inc.
LANDSCAPE ARCHITECTS SITE PLANNERS
 1100 Massachusetts Avenue
 Cambridge Massachusetts 02138 (617) 868-6111

Date: 28 DEC 87
Drawn By: WK
Checked By: PD
Revisions:
1) TO CITY HARTFORD REV 10/79
2) " " " " 11-80
3) " " " " 12-80

DNYBOOK NO. 011053

ELECTRICAL PLAN

E