


LOCATION PLAN  
Scale: 1"=3200'

# CITY OF HARTFORD

## DEPARTMENT OF PUBLIC WORKS

### BUREAU OF ENGINEERING SERVICES

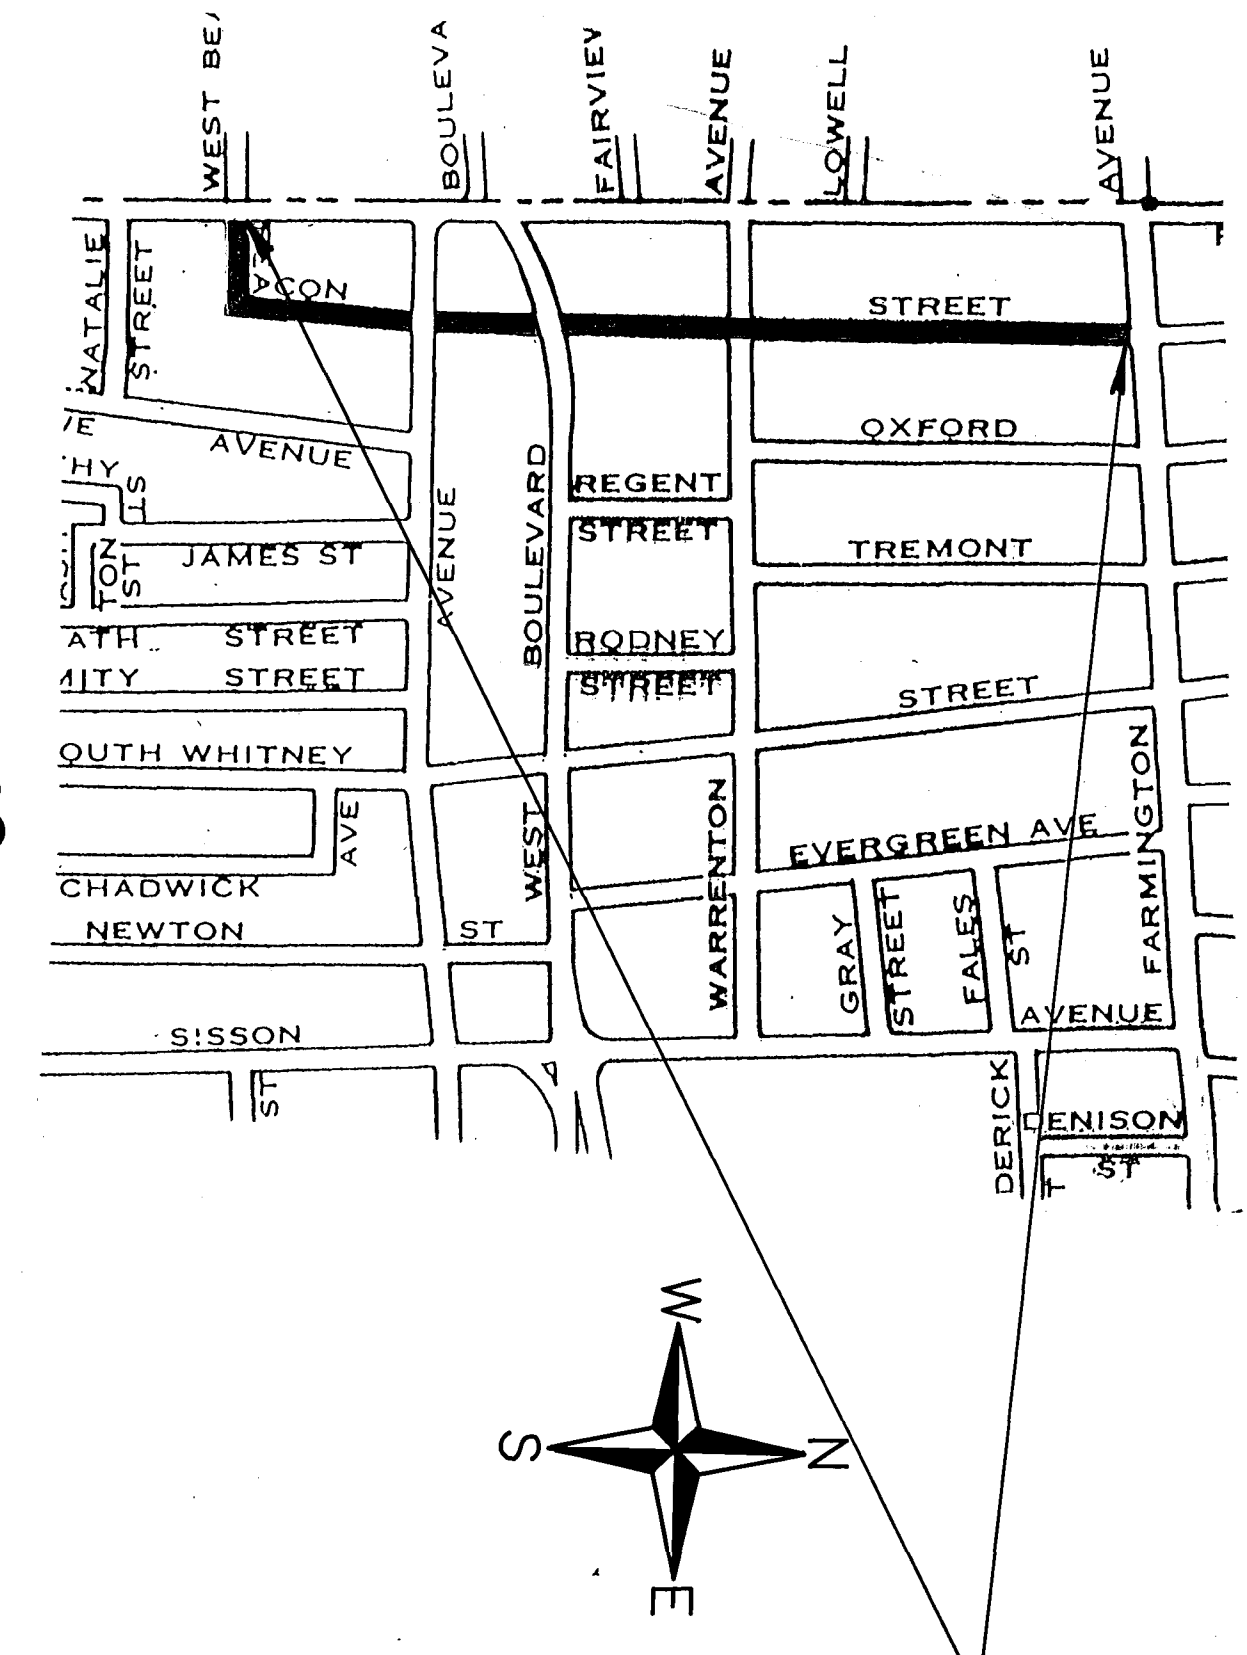

SITE PLAN  
Scale: 1"=500'

## PLANS FOR

# THE RECONSTRUCTION OF BEACON STREET FROM PROSPECT TO FARMINGTON AVENUES HARTFORD, CONNECTICUT CONTRACT NO. E91-07

JOHN L. BERTOLI  
Project Engineer

JEROME F. SHEA  
Division Manager  
Engineering Planning and Design

### CONTENTS

- |                                  |                                  |
|----------------------------------|----------------------------------|
| 1. Title Sheet                   | 7. Beacon Street Plan & Profile  |
| 2. Standard Traffic Details      | 8. Beacon Street Plan & Profile  |
| 3. Standard Traffic Details      | 9. Beacon Street Plan & Profile  |
| 4. Standard Construction Details | 10. Beacon Street Plan & Profile |
| 5. Standard Drainage Details     | 11. Beacon Street Plan & Profile |
| 6. Standard Drainage Details     | 12. Beacon Street Plan & Profile |

ANTHONY FERRARO  
Assistant Director of  
Public Works/ City Engineer

DELBERT F. KARMEIER  
Director of Public Works