
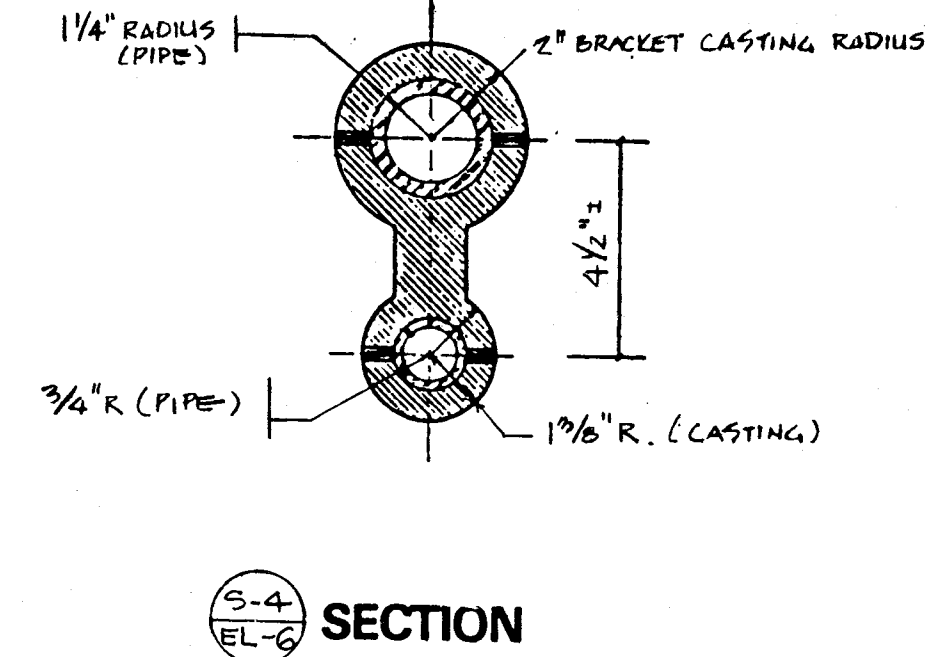
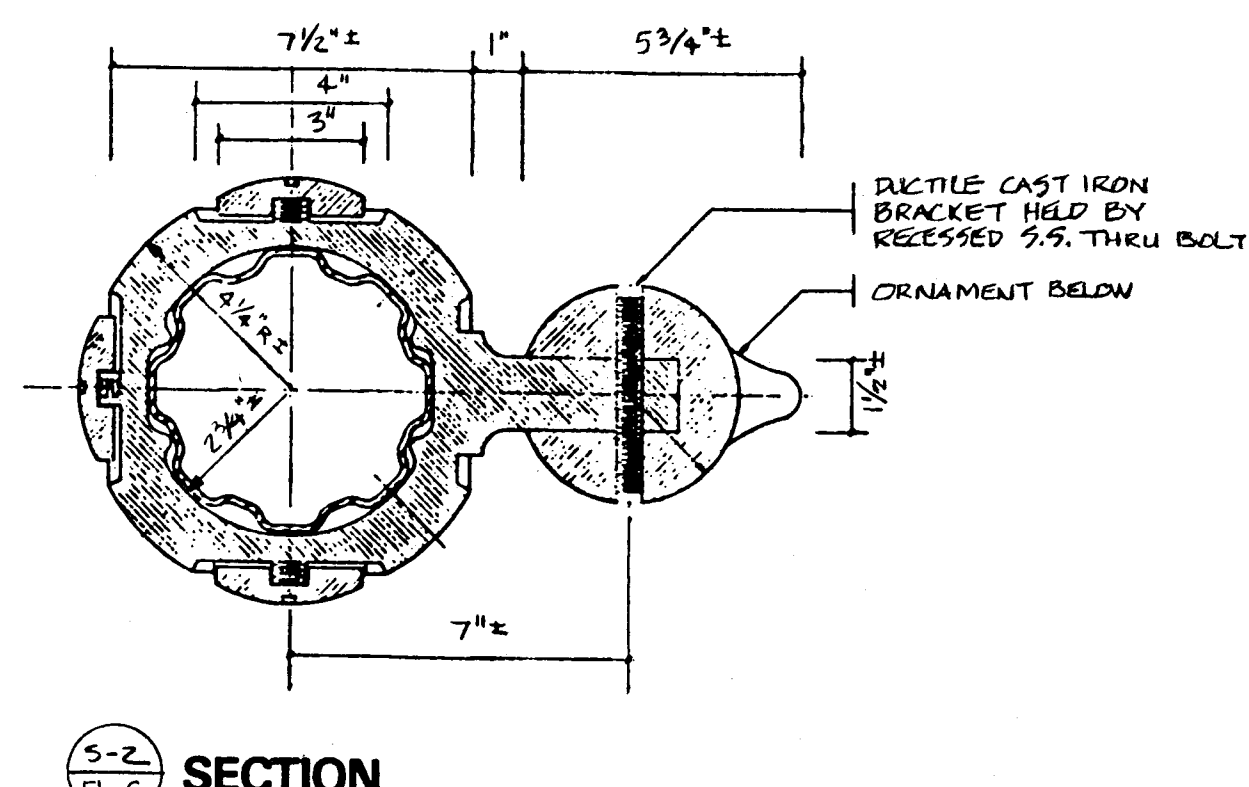
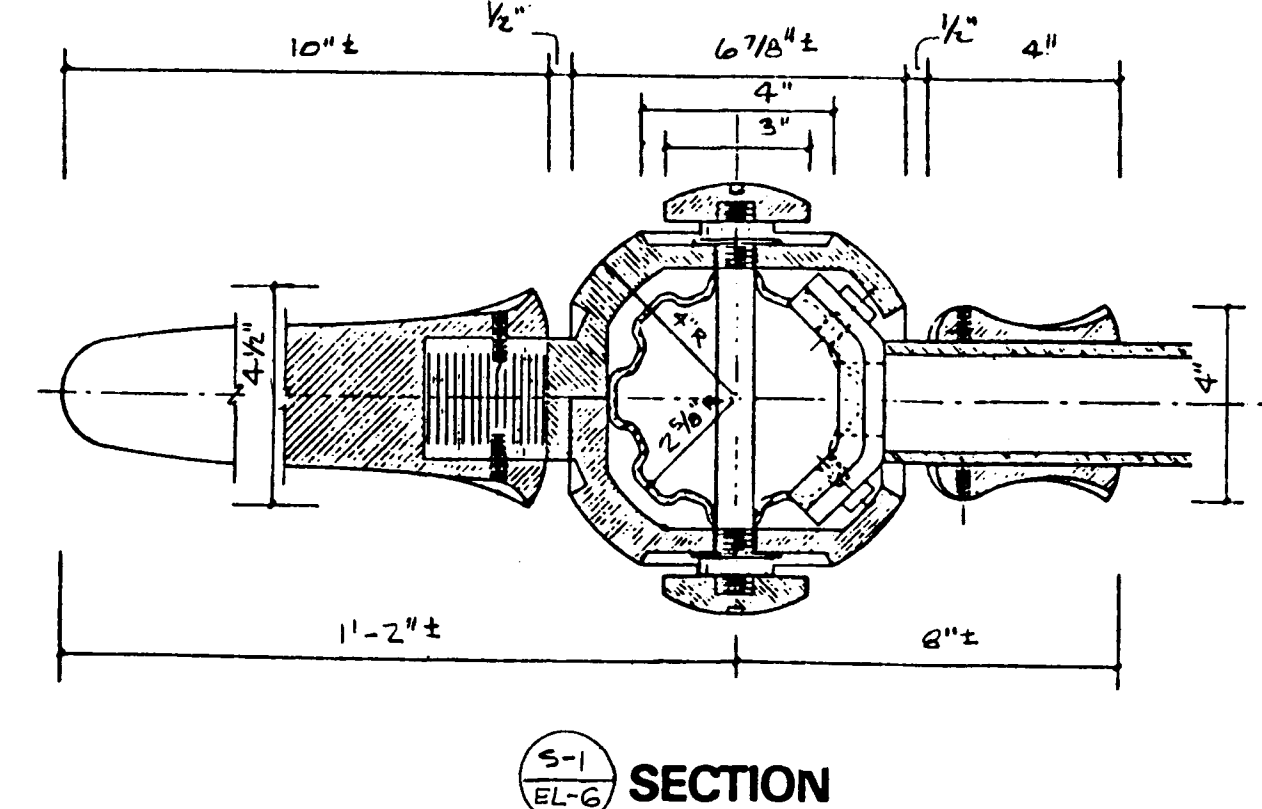
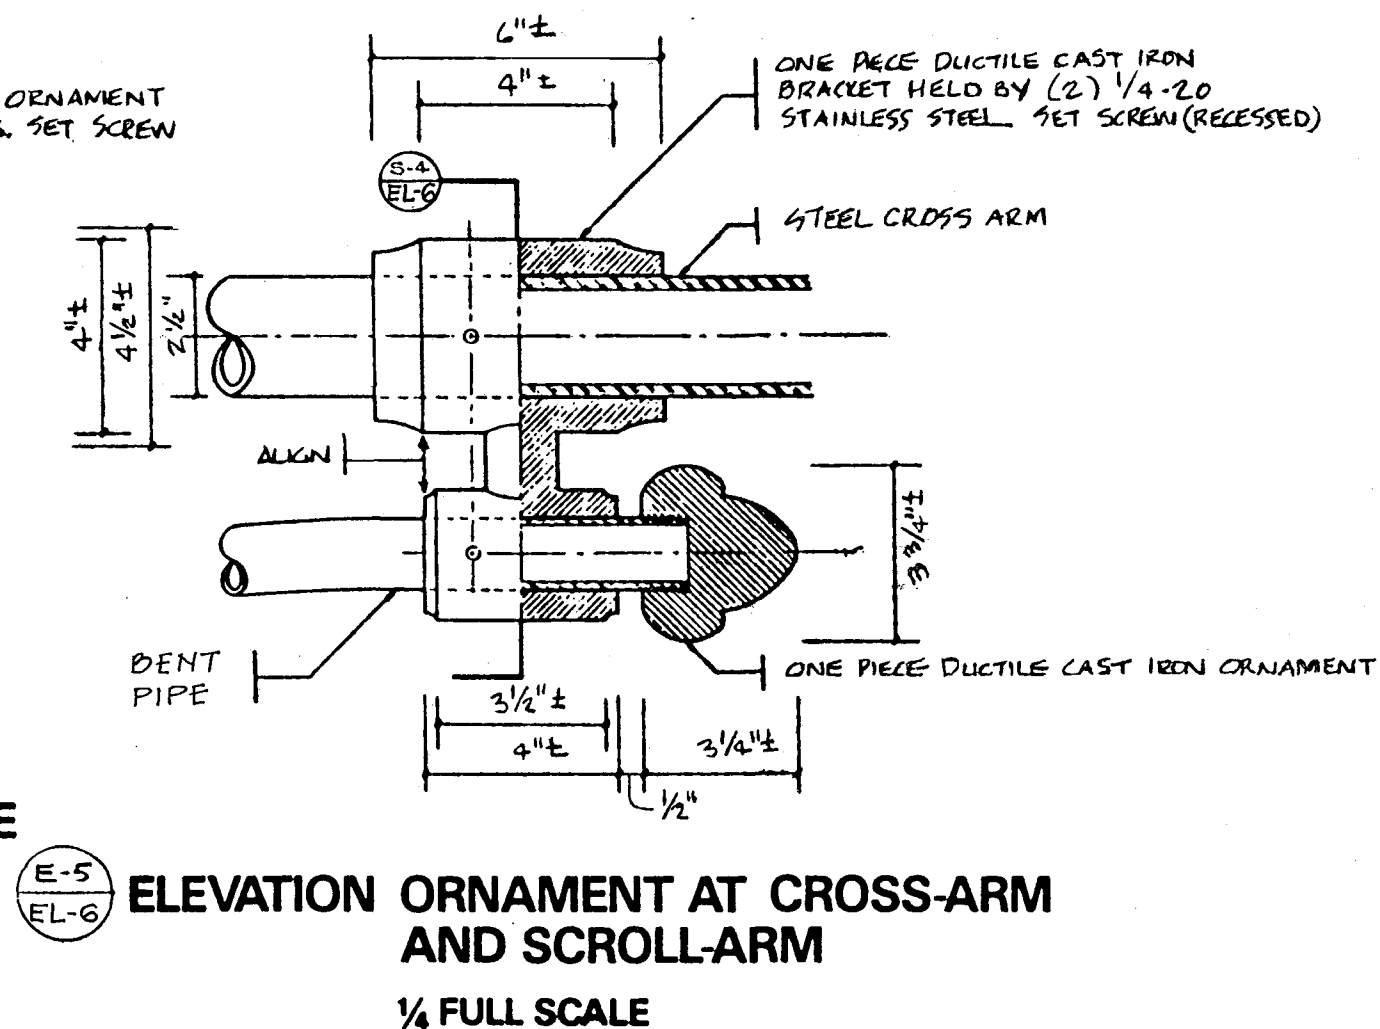
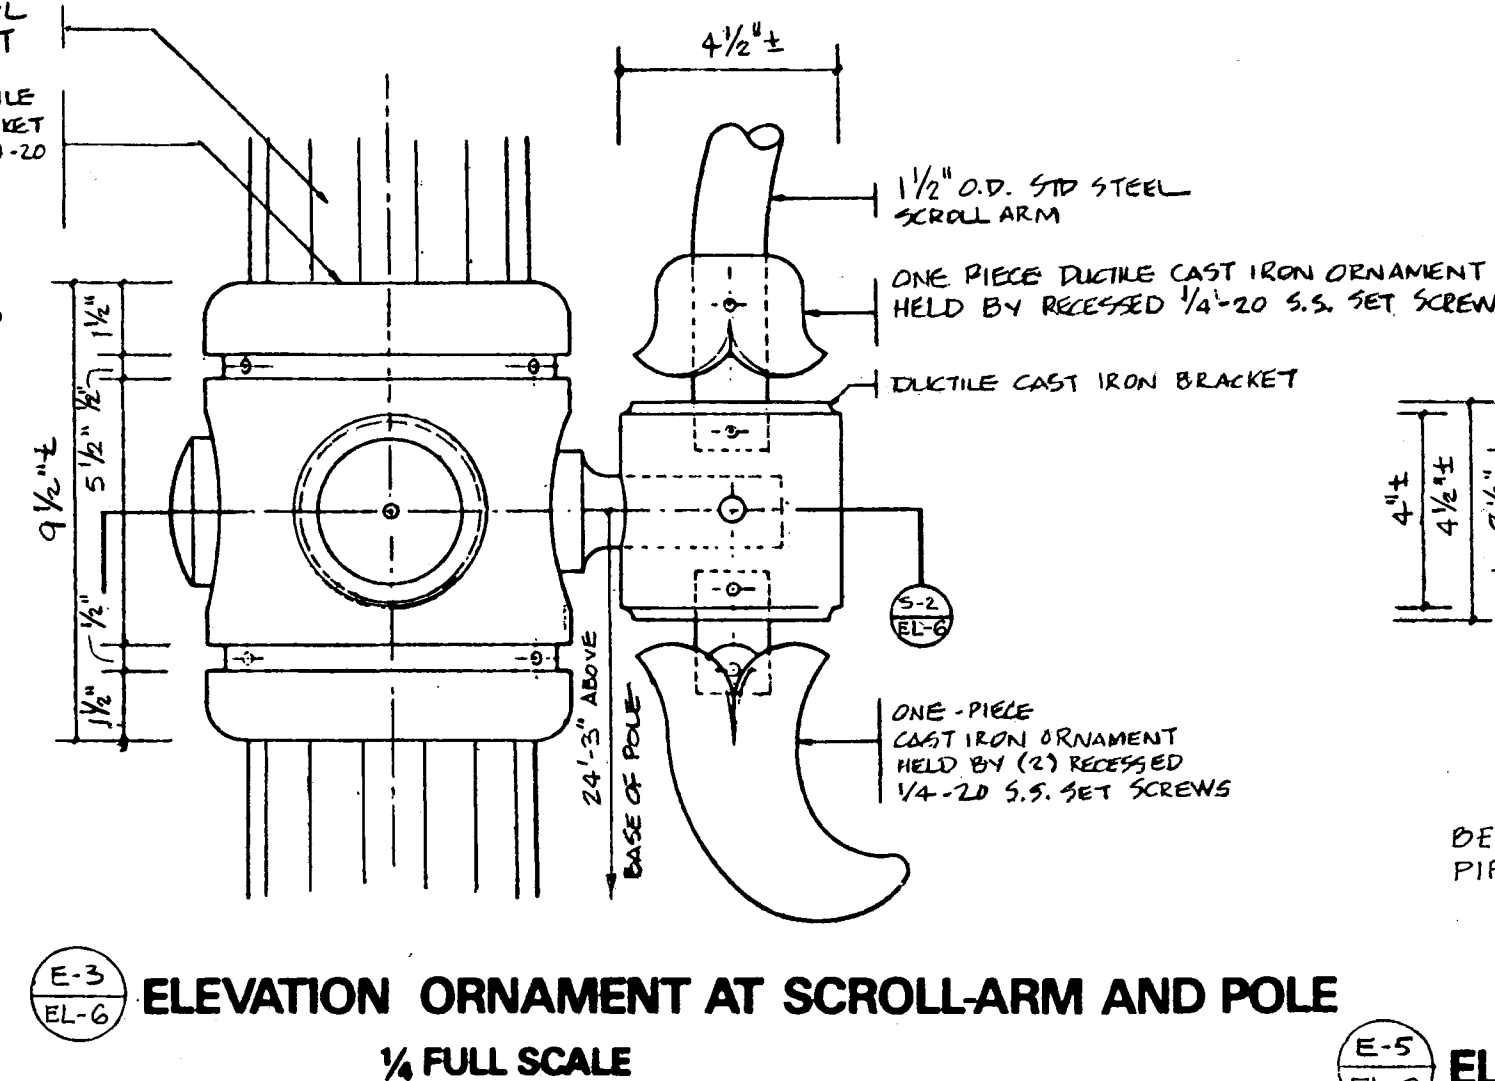
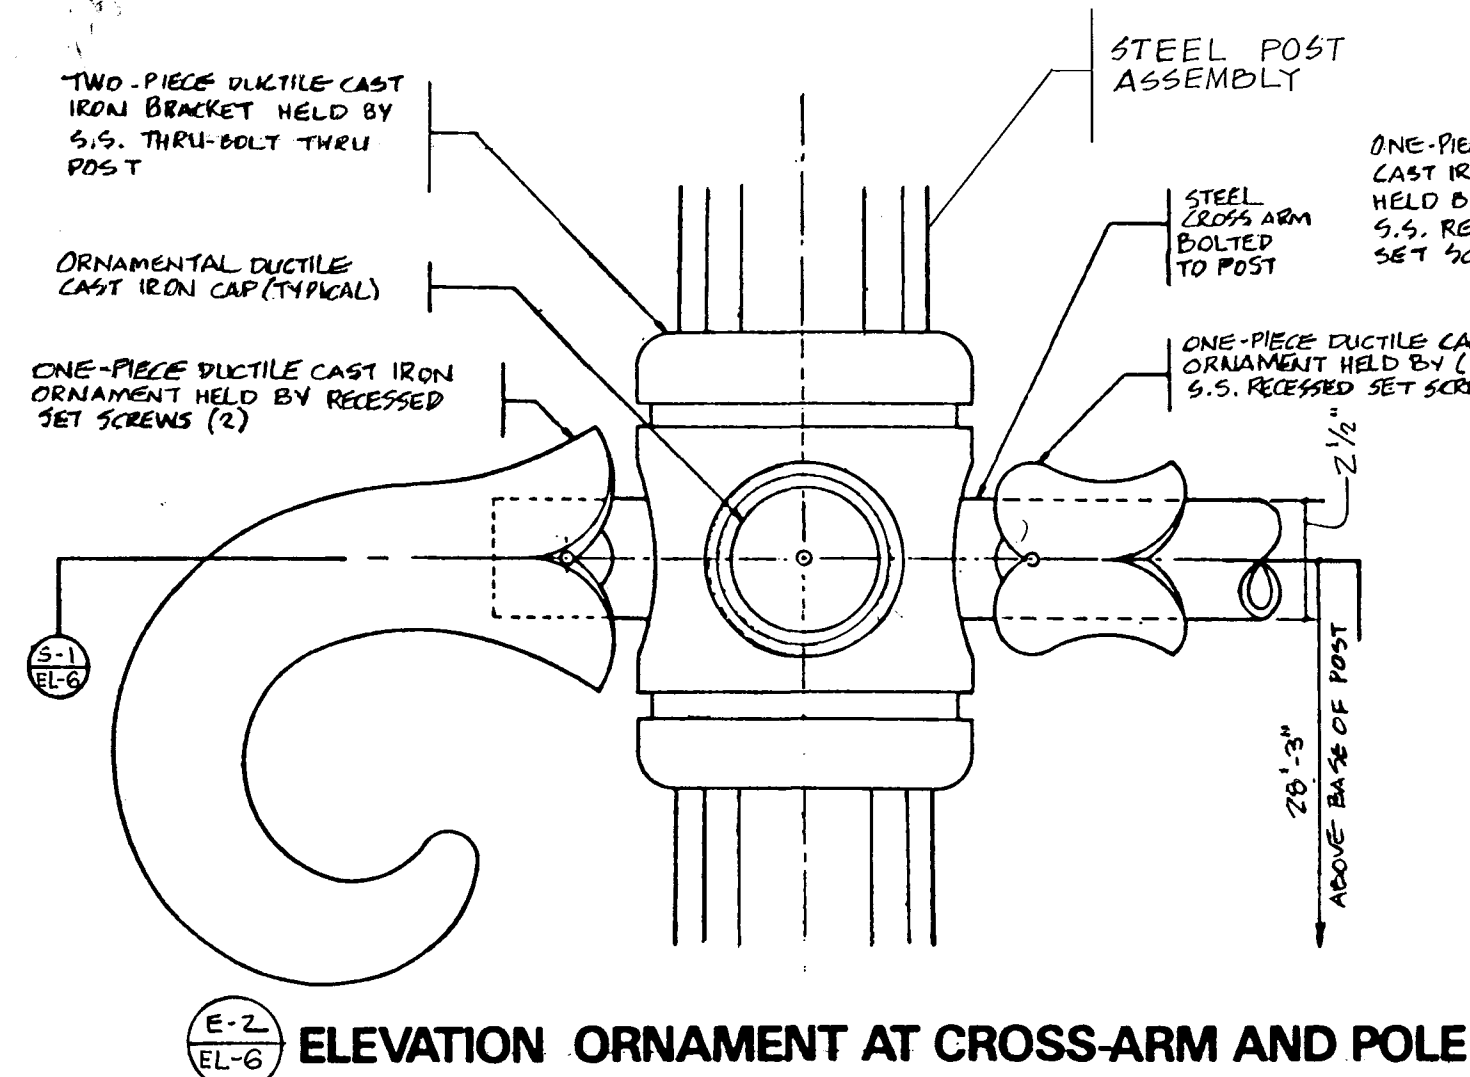
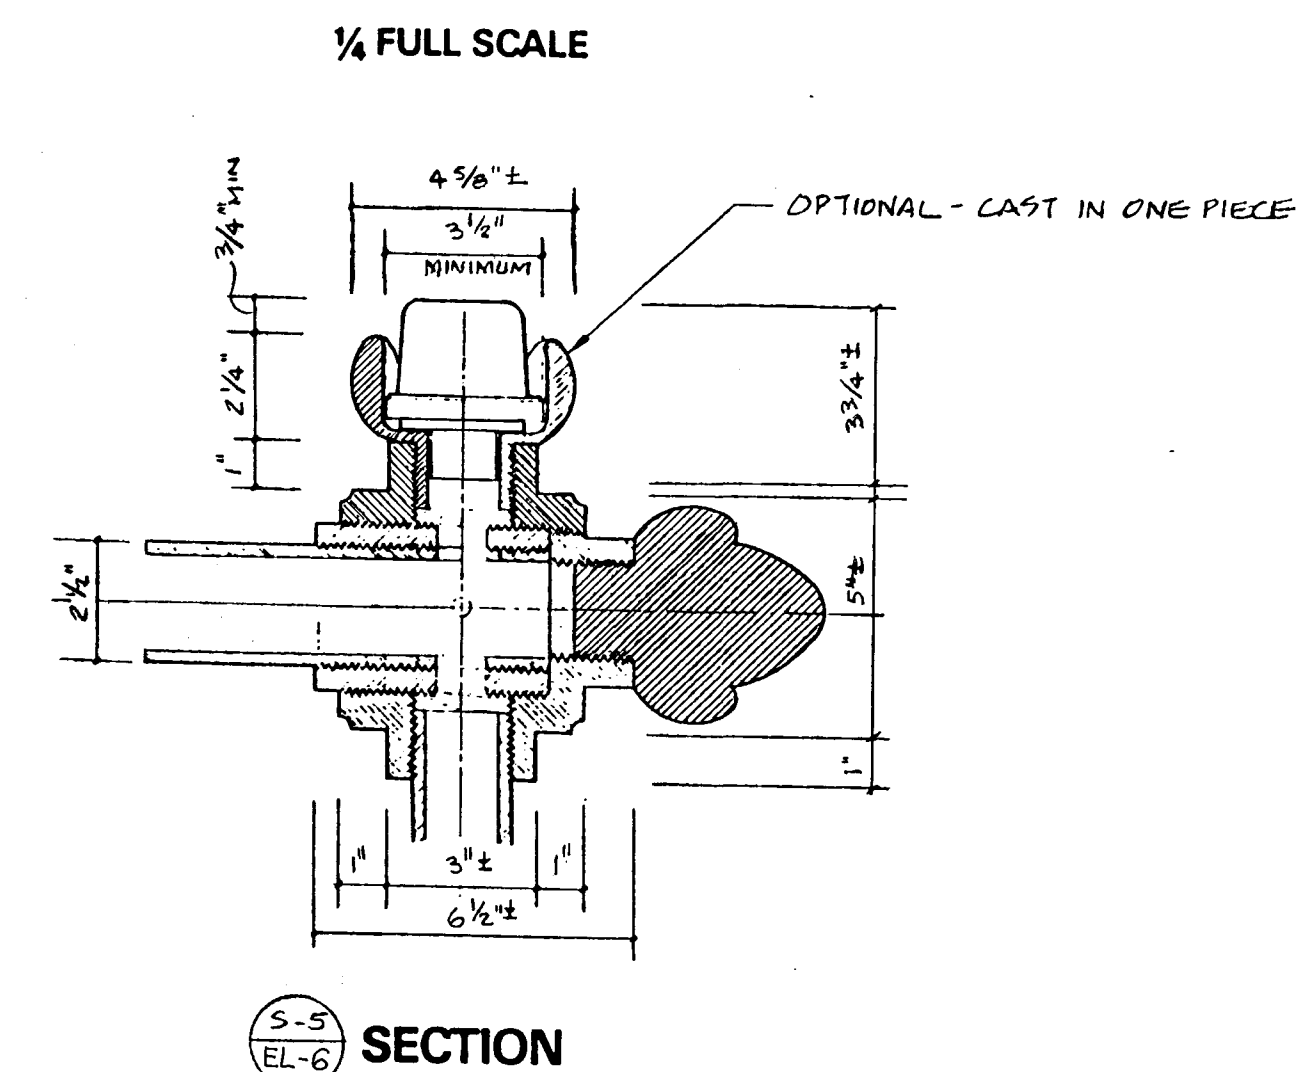
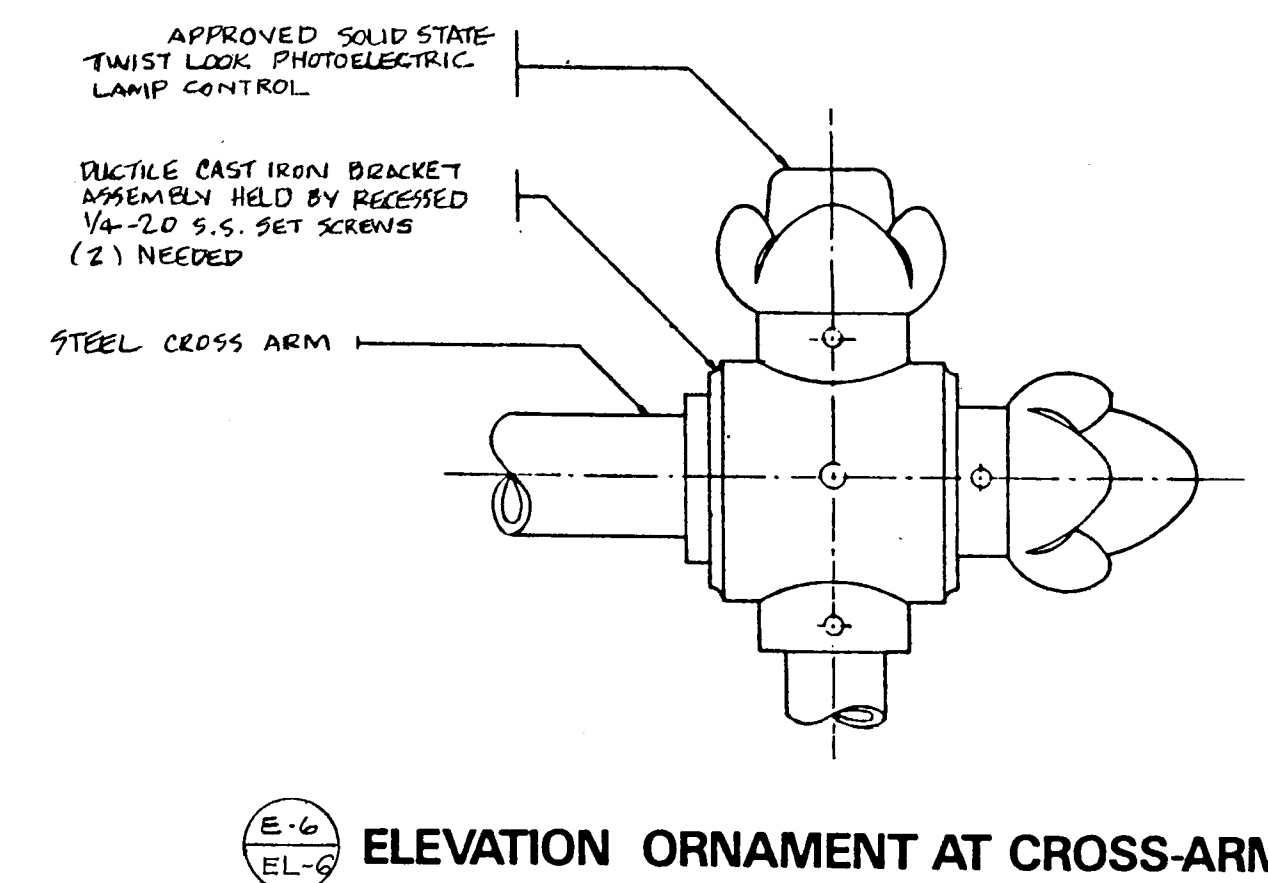
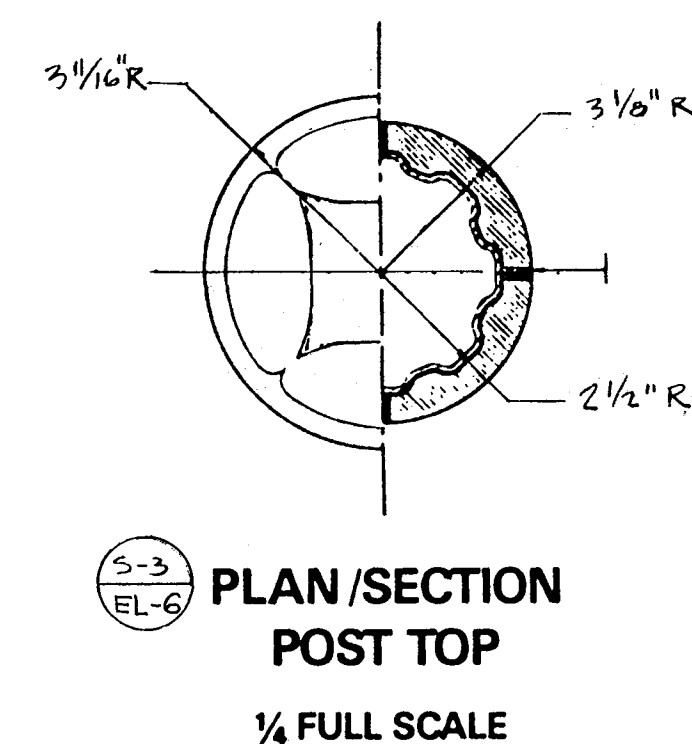
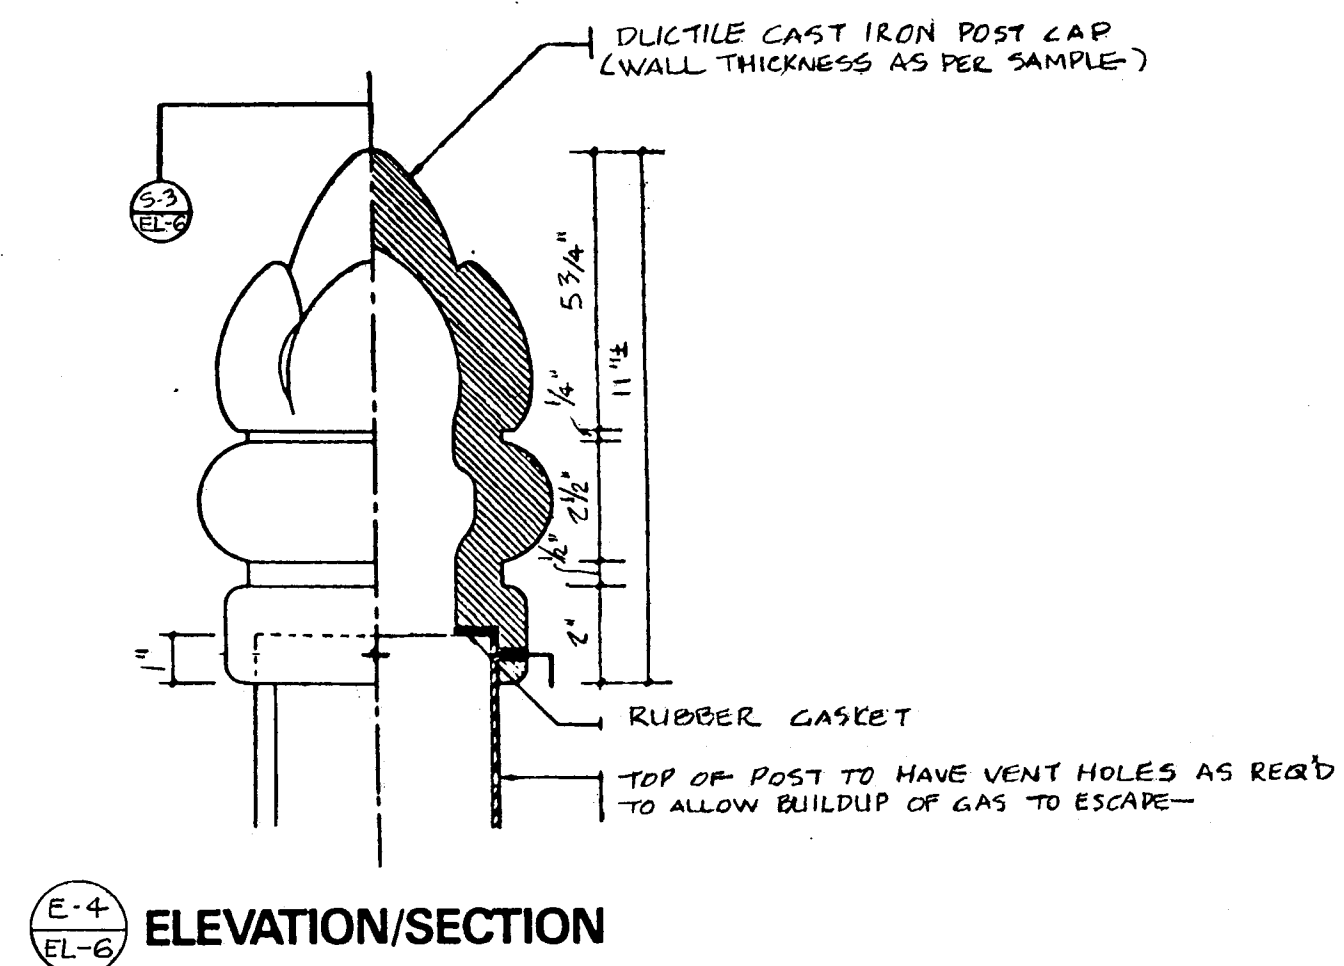


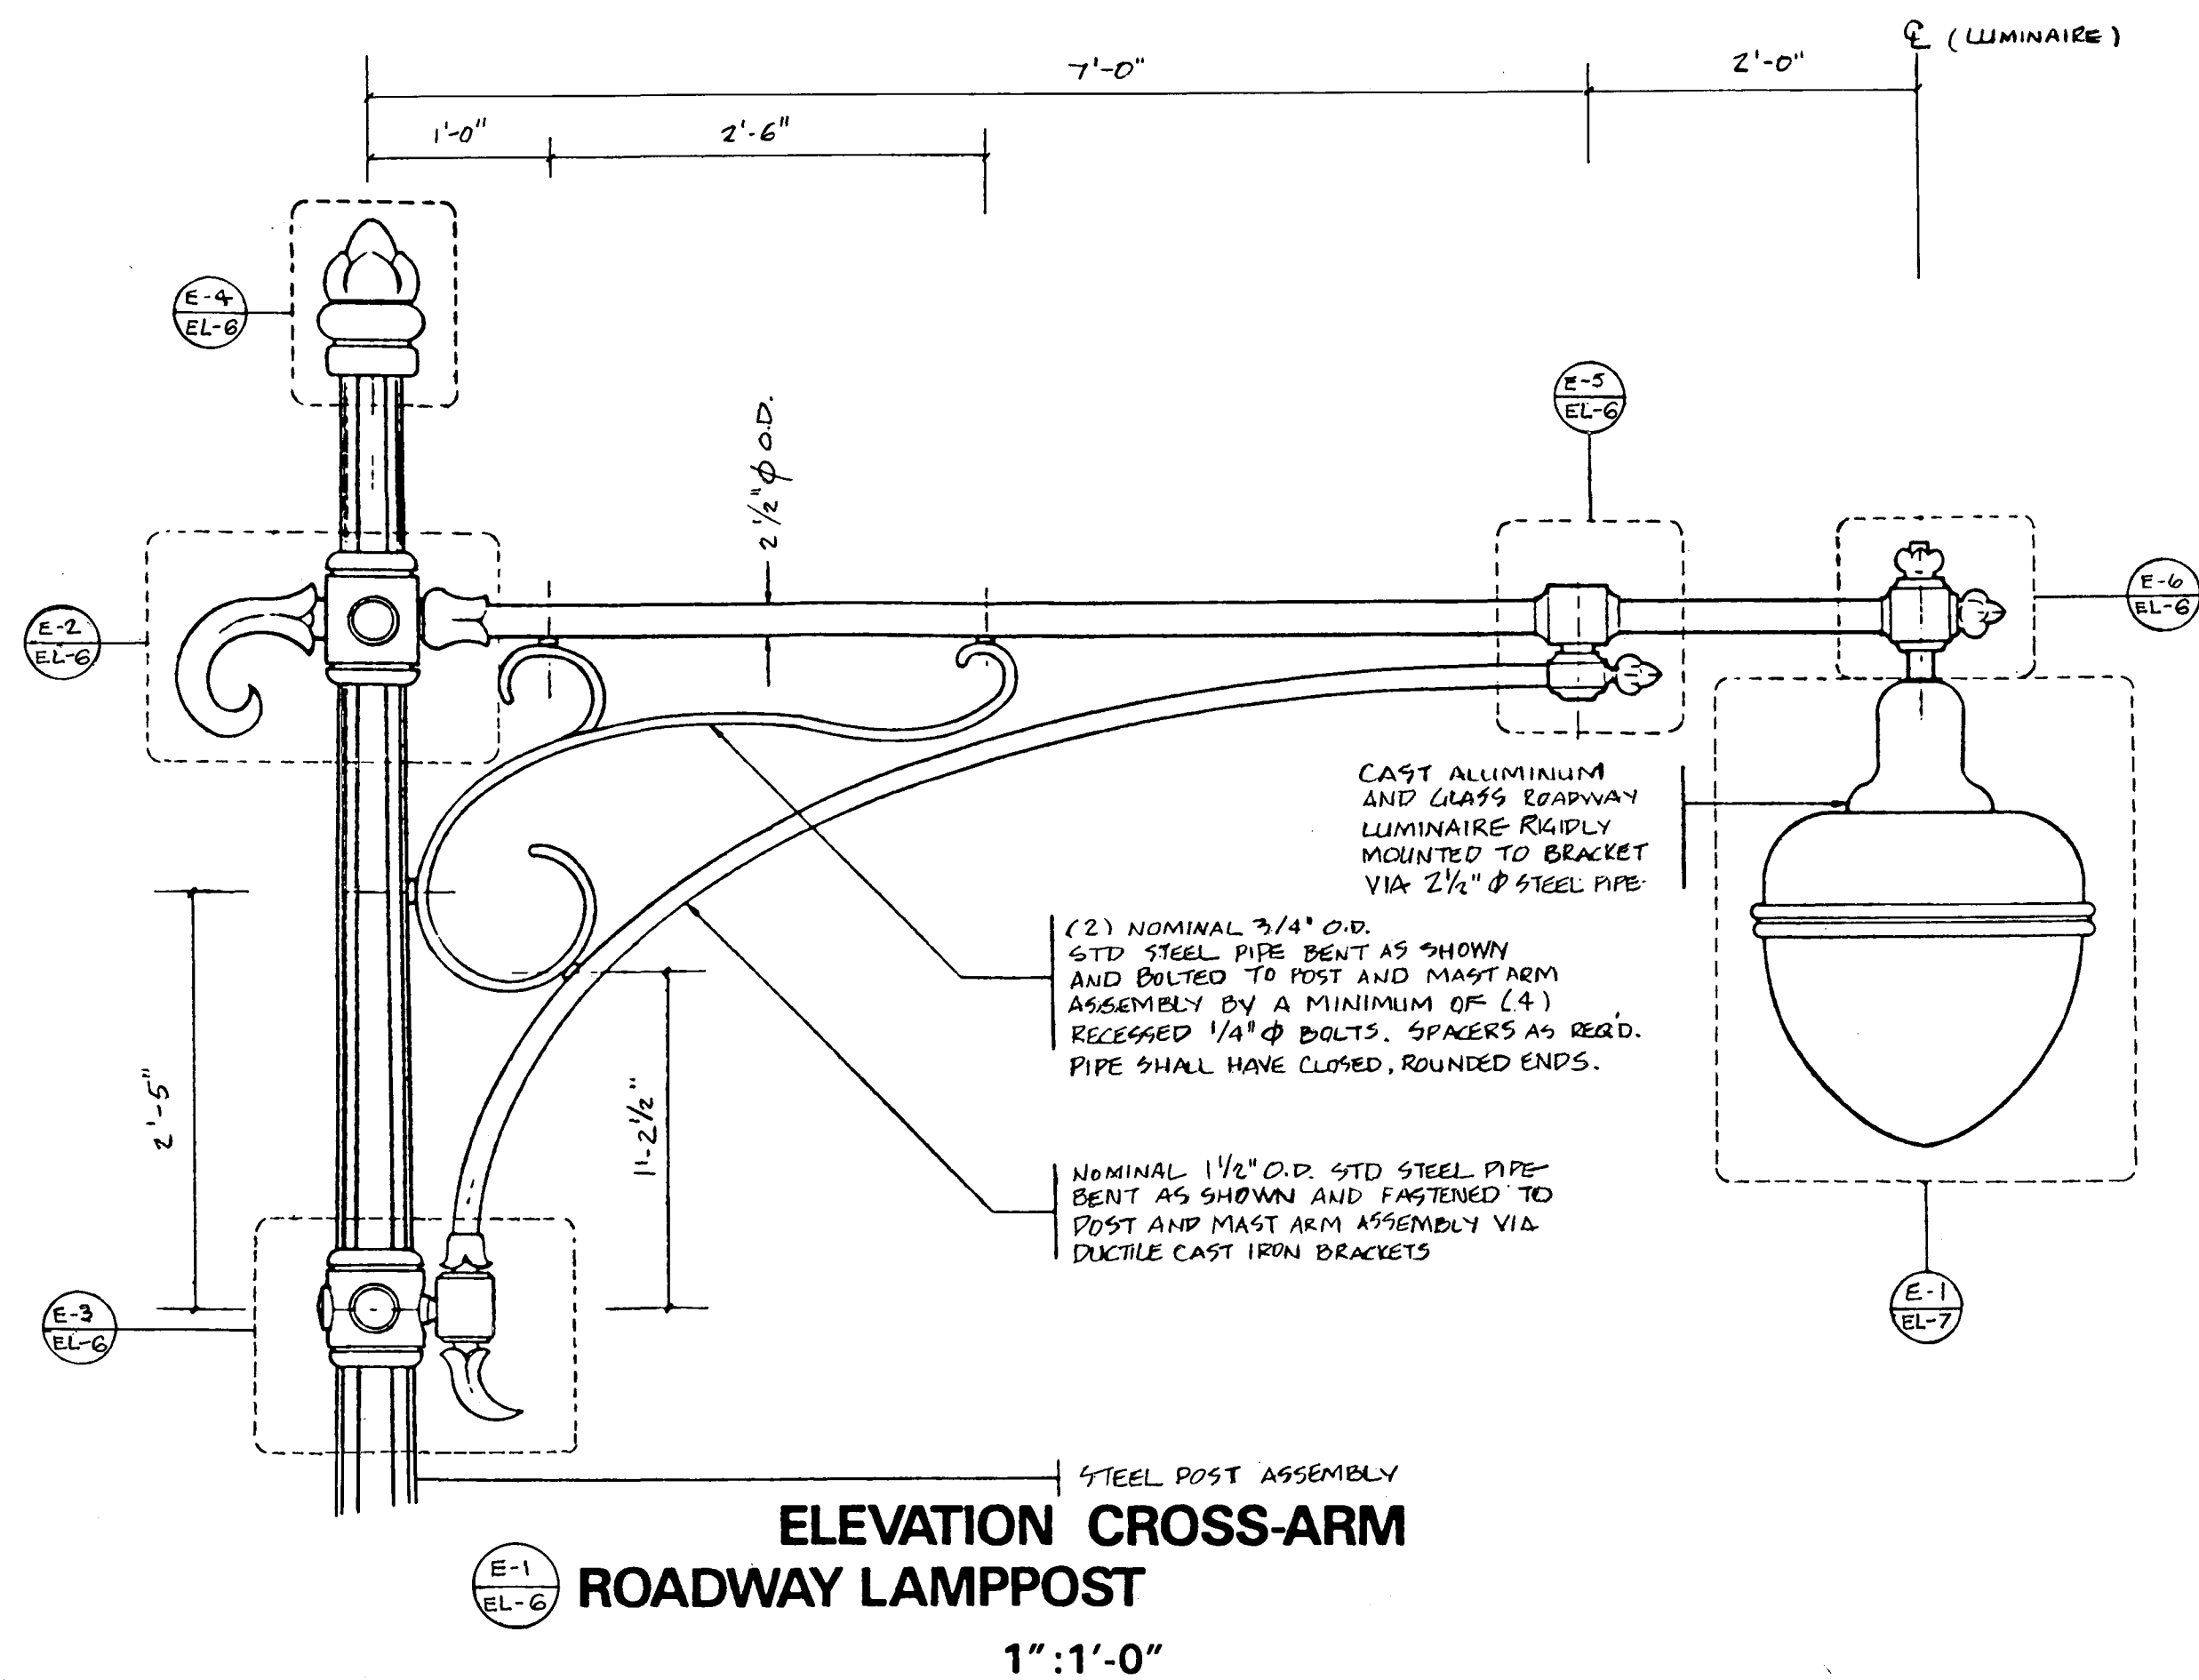

CITY OF HARTFORD, CONNECTICUT DEPARTMENT OF PUBLIC WORKS TRANSPORTATION SERVICES BUREAU	
HNTB HOWARD NEEDLES TAMMEN & BERGENDOFF Architects / Engineers / Planners	Pat Loheed, Landscape Architect L.C. Associates, Inc. - Surveyor
HARTFORD PEDESTRIAN TRANSIT PROJECT	
ELECTRICAL PLAN-6 LIGHTING STANDARD DETAILS	
DESIGN E.A. GAYAMAT DRAWN R.E. OWOO CHECKED E.A. GAYAMAT	SCALE: AS NOTED
DATE: 9-8-89	DAY BOOK NO.
REVISION	MADE BY
CHECKED BY	DESCRIPTION
SHEET NO. EL-6	