



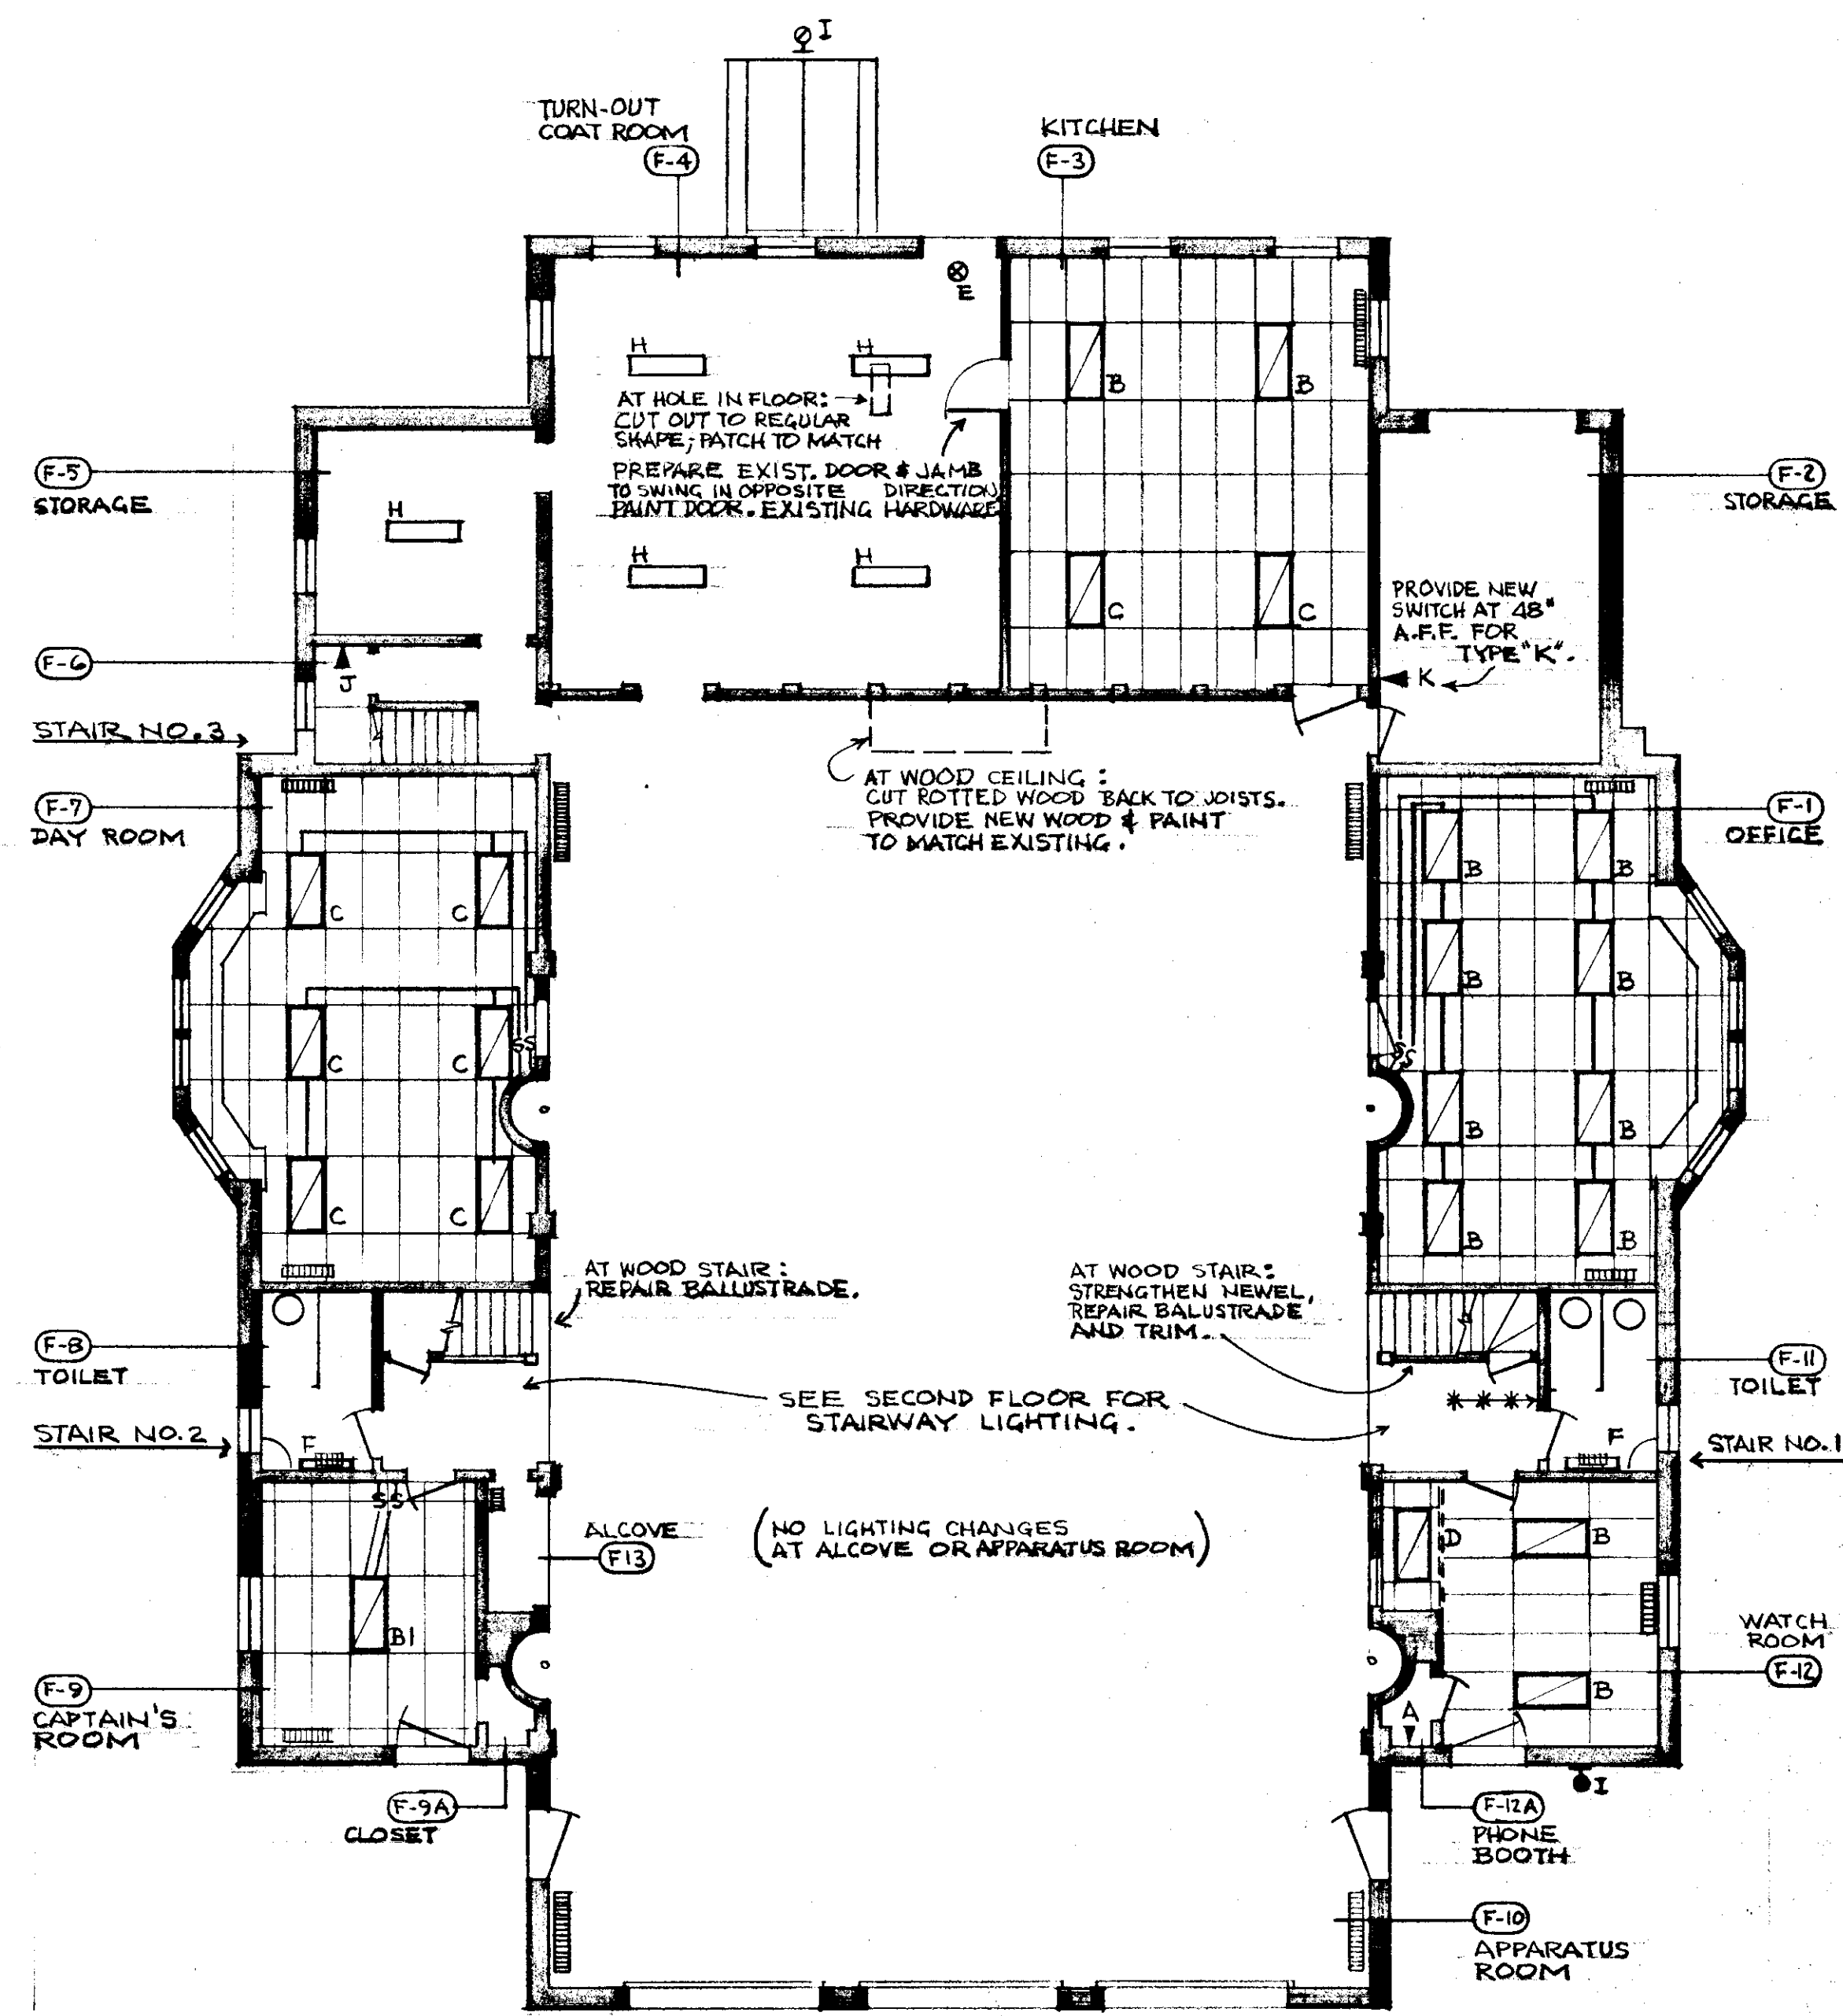


FIRST FLOOR PLAN
SCALE: 1/8" = 1'-0"

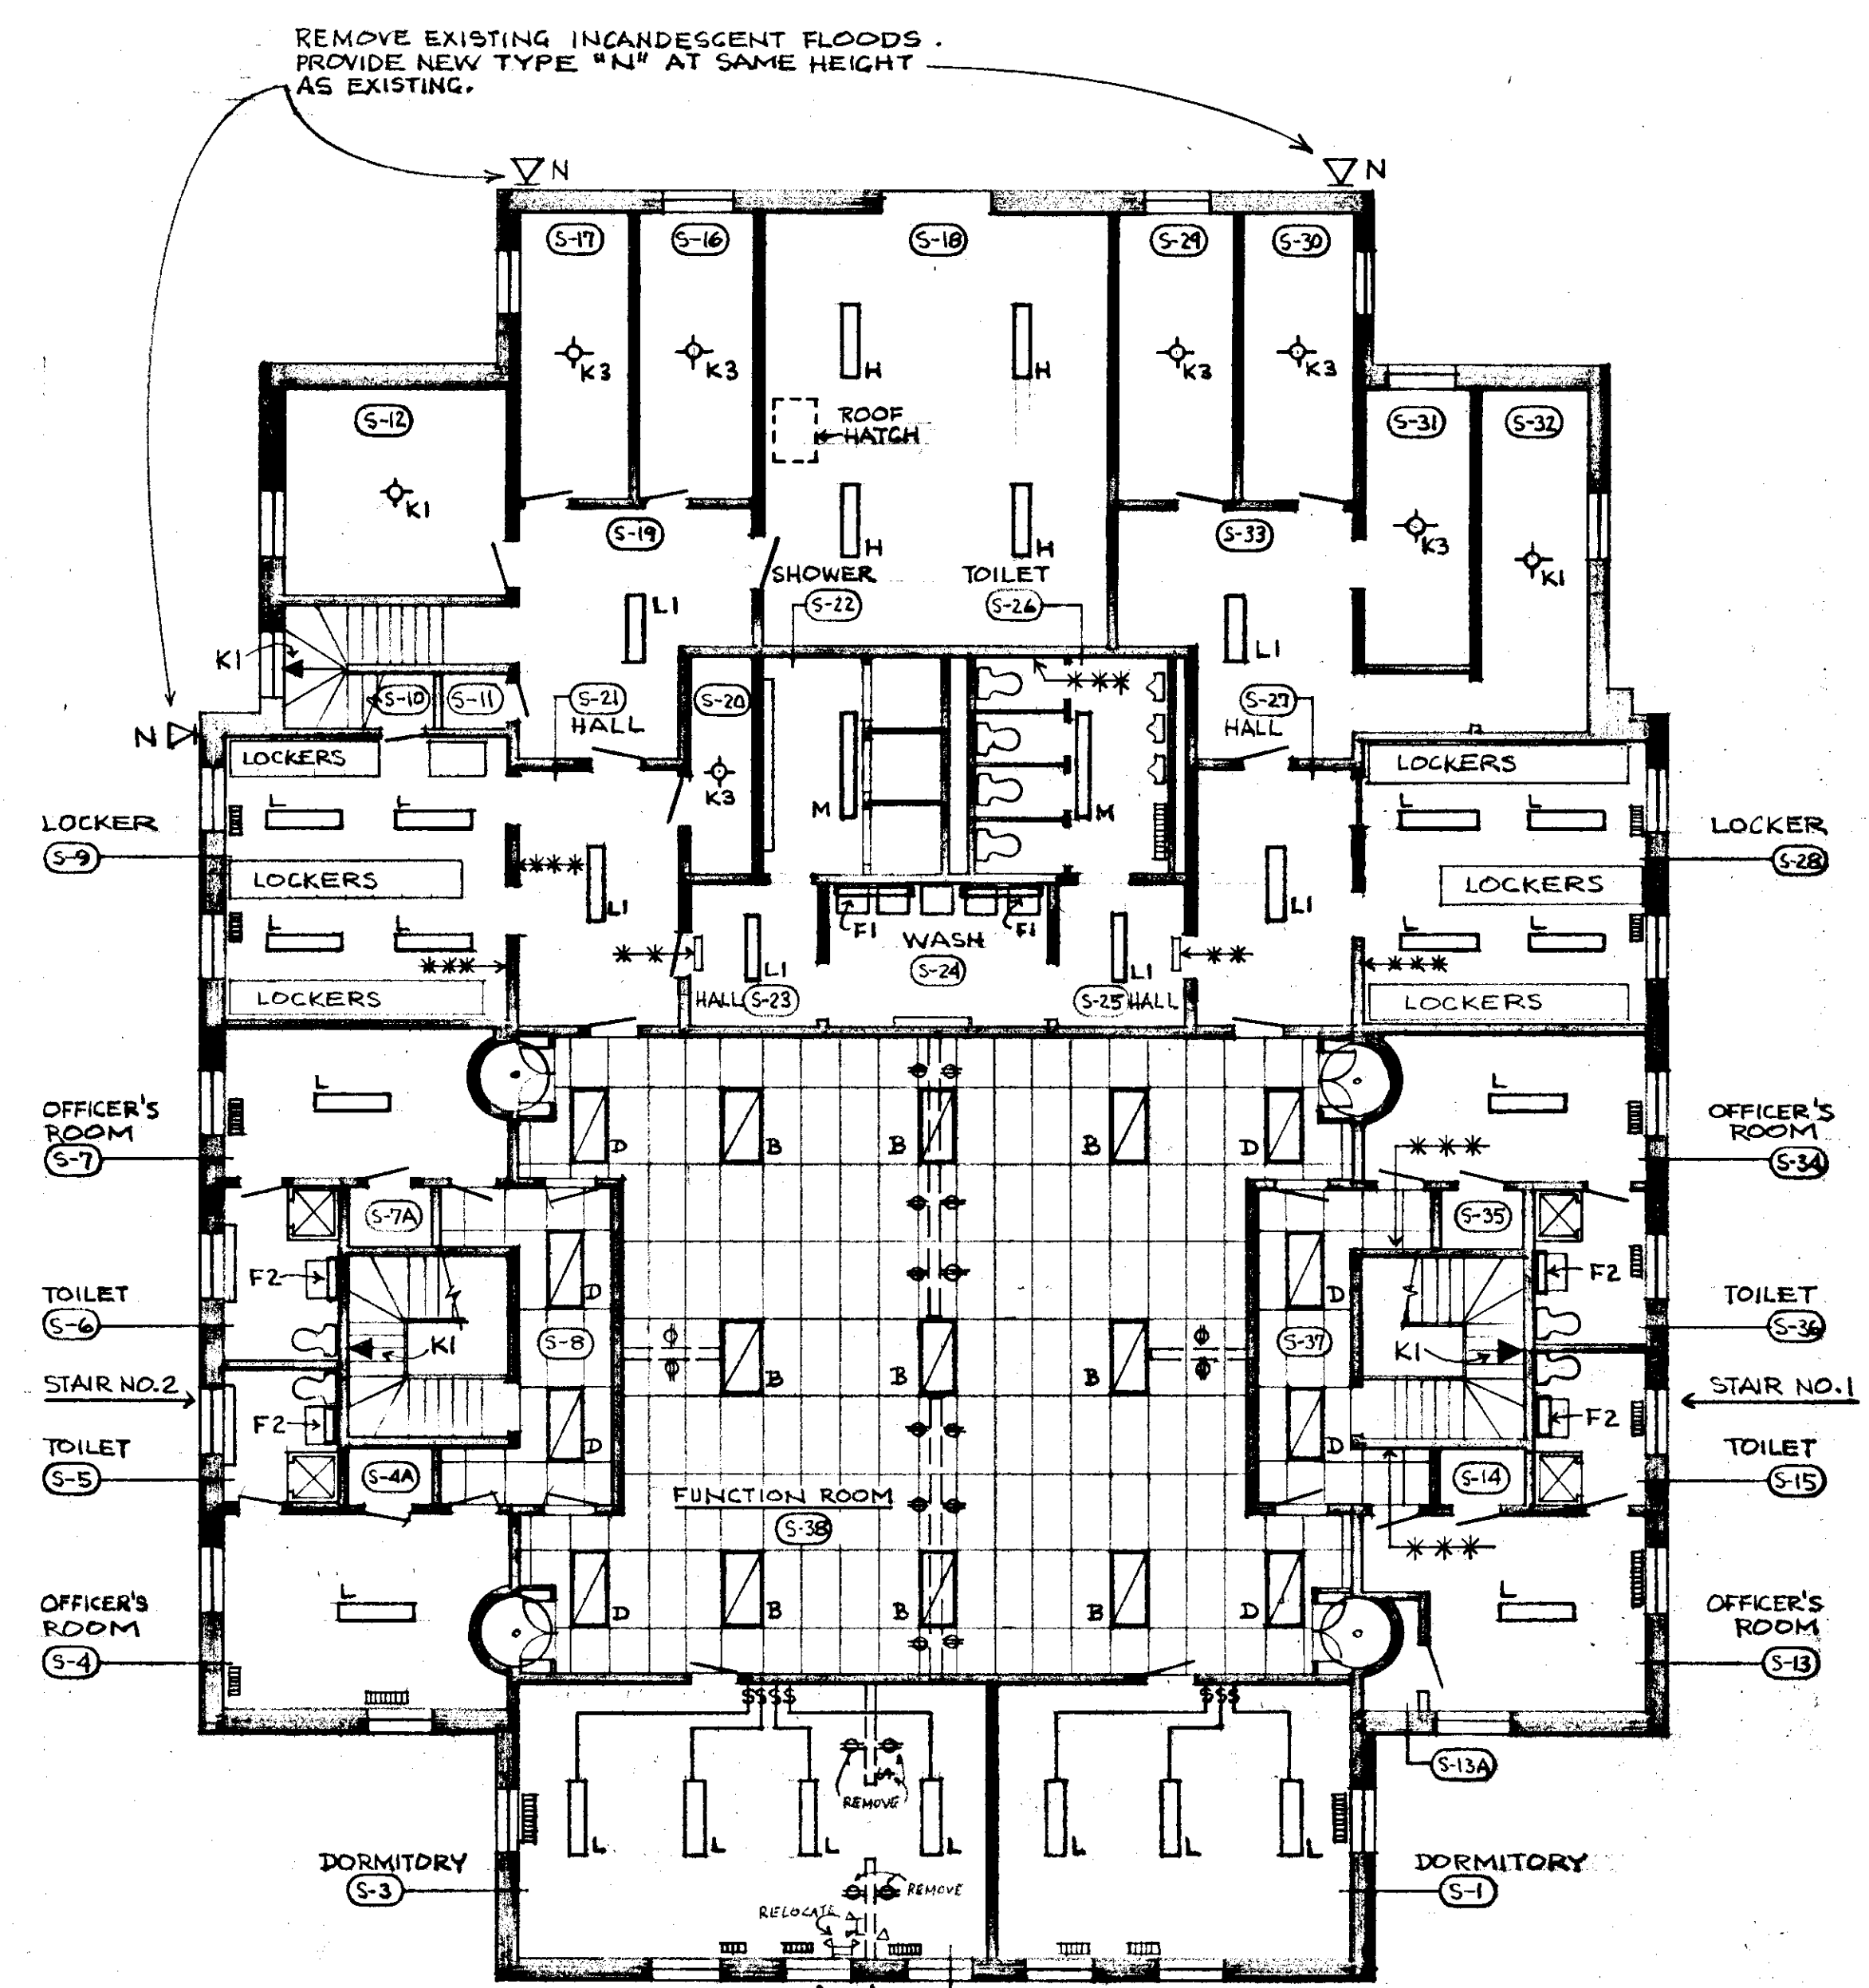


SECOND FLOOR PLAN
SCALE: 1/8" = 1'-0"

AT ROOMS S-2, S-3: EXIST. WALL SHOWN DOTTED:
REMOVE RECEPTACLES, SWITCH, WIRING, CONDUIT;
REMOVE AND RELOCATE EMERGENCY LIGHTING;
REMOVE WALL; PATCH FLOOR, WALLS & CEILING TO MATCH.

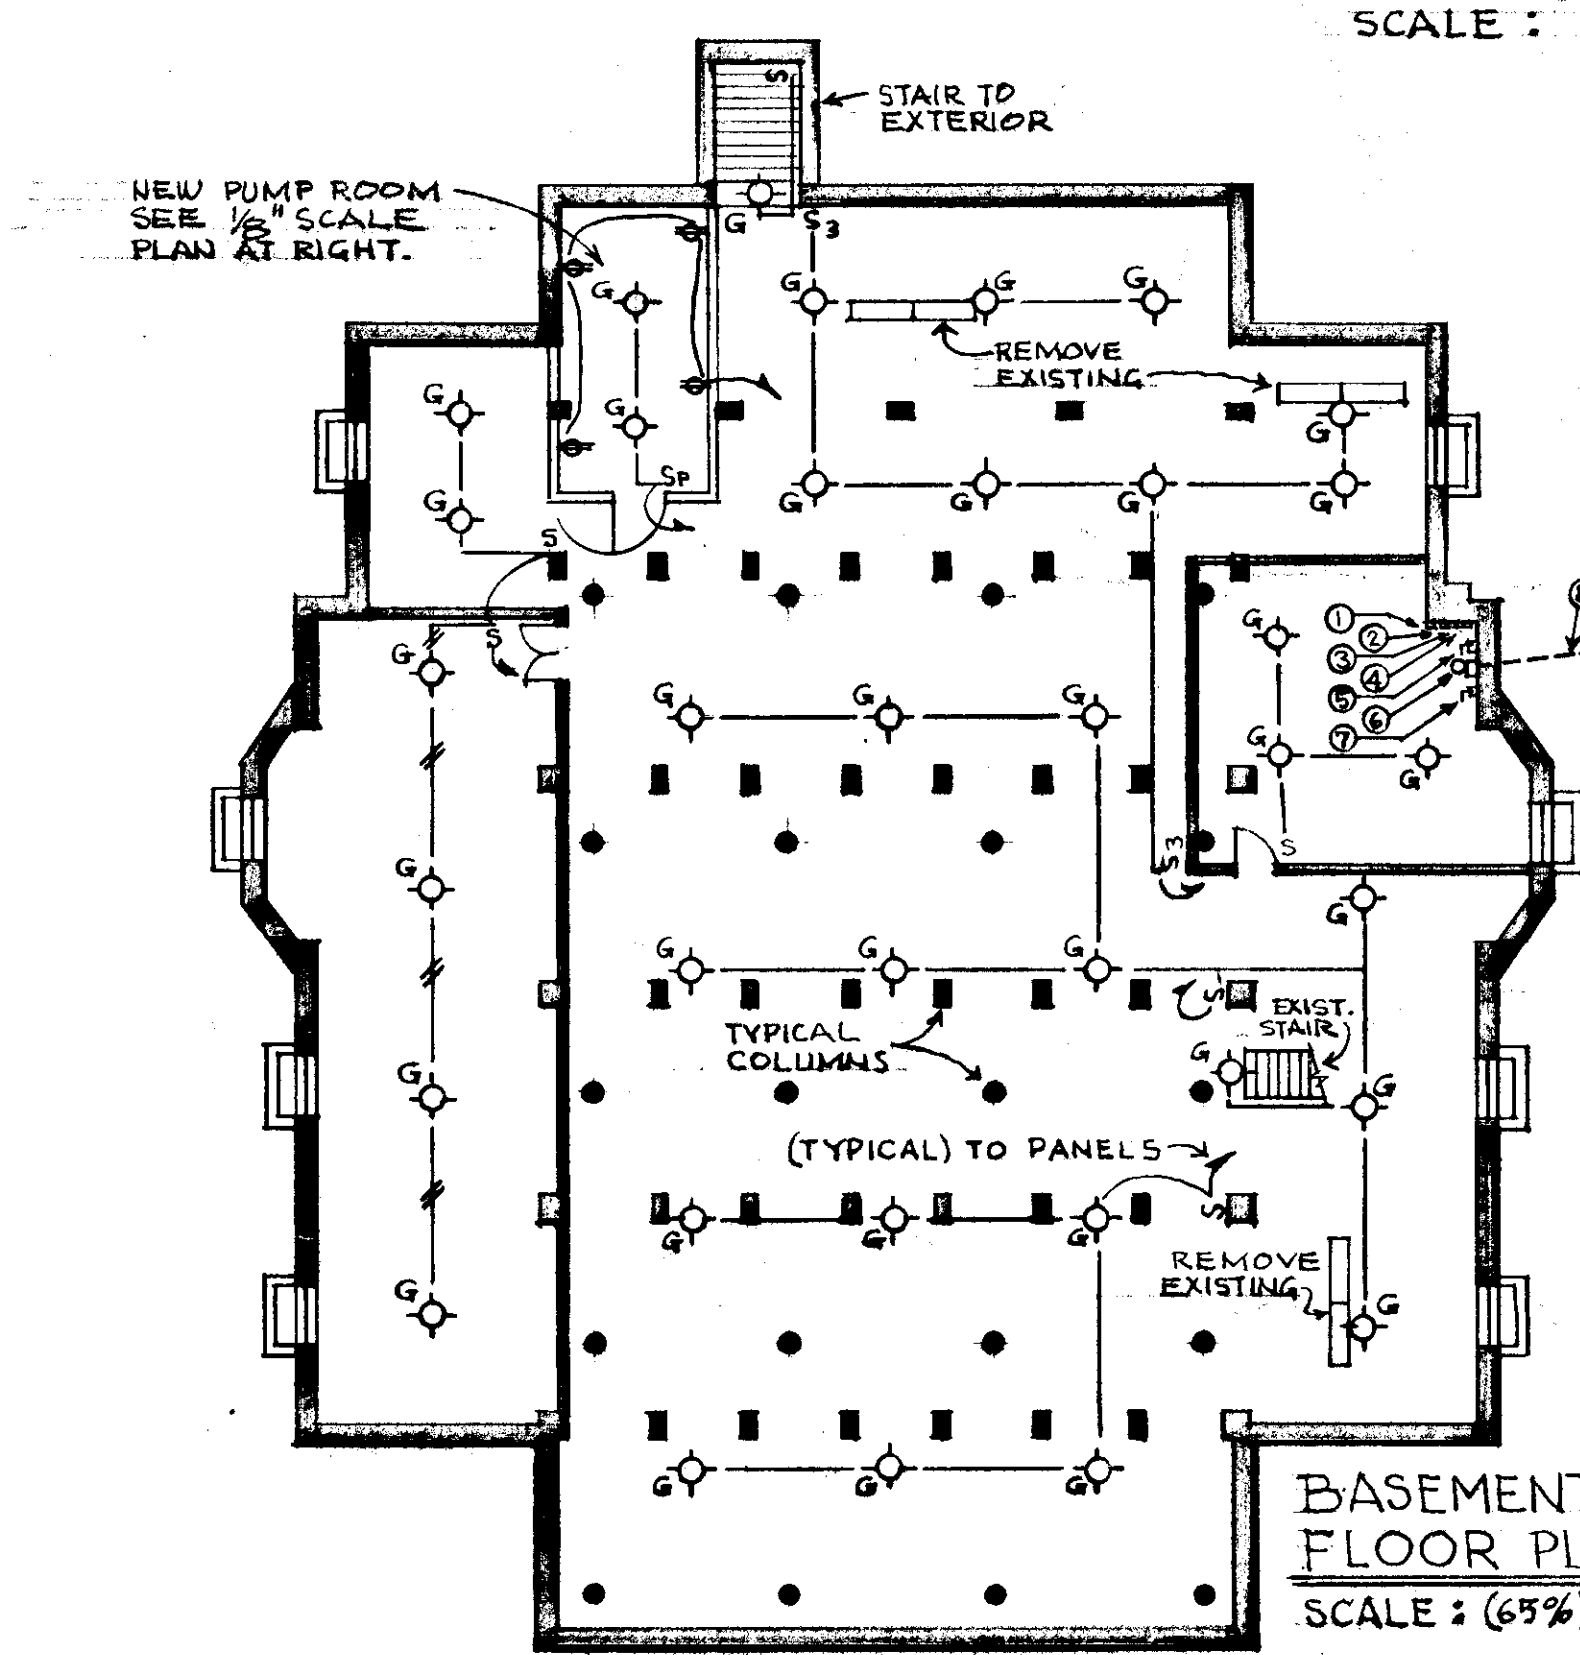

BASEMENT FLOOR PLAN
SCALE: (65%) 1/8" = 1'-0"

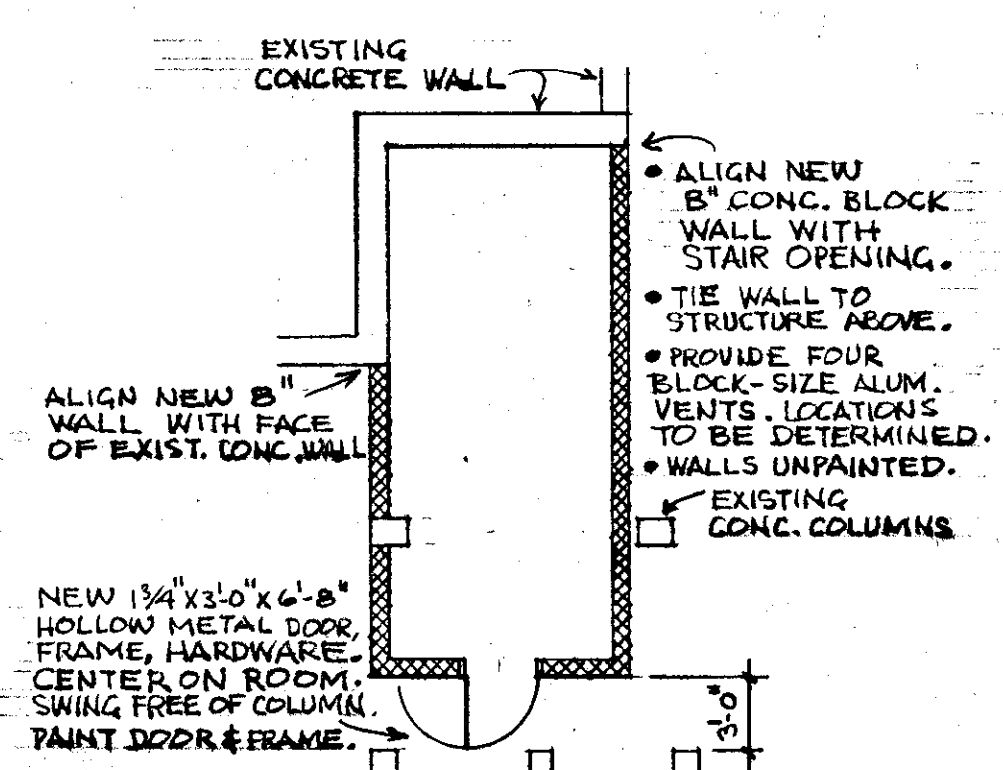


 
NEW PUMP ROOM
SCALE: 1/8" = 1'-0"
SEE BASEMENT FLOOR PLAN

GENERAL NOTES

1. RE: DOOR FROM RM. S-38 TO RM. S-21 1/2 DOOR SWING BINDS AT FLOOR. SHAVE DOOR BOTTOM TO ENABLE CLEAR SWING. PROVIDE DOOR CLOSURE HARDWARE.
2. RE: LOCKER RMS. S-9, S-20: EXISTING FIXED BENCHES, REQUIRING REFINISHING, ARE NOT SHOWN ON DRAWING.
3. RE: KITCHEN RM F-3: PROVIDE LABOR TO DISCONNECT/RECONNECT AND MOVE STOVE, DRINKING FOUNTAIN AND REFRIGERATOR AS REQUIRED TO PERFORM WORK.
4. ALL APPLICABLE ROOMS: PROVIDE LABOR TO MOVE FURNISHINGS AS REQUIRED TO PERFORM WORK.
5. SEE SPECIFICATION SECTION VII FOR ELECTRICAL NOTES AND LIGHT FIXTURE SCHEDULE.

FIRE STATION NO. 2
1515 MAIN STREET

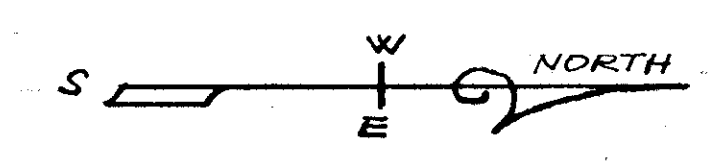

LEGEND		
	CAST IRON RADIATORS .	
	BASEBOARD RADIATION & WALL RADIATOR COVERS .	
	*** → LOCATION OF HOLE IN PLASTER WALL .	
	** → LOCATION OF HOLE IN CERAMIC TILE FLOOR .	
	LIGHTING FIXTURES (TYPICAL) (SEE ELECT. SPECIFICATION)	
CITY OF HARTFORD, CONNECTICUT DEPARTMENT OF PUBLIC WORKS		
FIRE STATION RENOVATIONS HARTFORD CONNECTICUT		
FIRE STATION NO.2		
SUBMITTED 	APPROVED 	APPROVED 
DESIGNED FJM, JAP	SCALE AS SHOWN	CITY ENGINEER
DRAWN FJM	DATE FEB. 28, 1991	DRAWING NO.
CHECKED FAV	DAYBOOK NO. 011208-C	3

CONTRACT NO. F91-12