

LOCATION PLAN

# CITY OF HARTFORD

## DEPARTMENT OF PUBLIC WORKS

### ENGINEERING SERVICES



## PLANS


### FOR

# INSTALLATION OF PLAYSCAPE AND FITNESS COURSE

## STRUCTURES AT MCDONOUGH SCHOOL

### HARTFORD , CONNECTICUT

### CONTRACT NO. E92-09

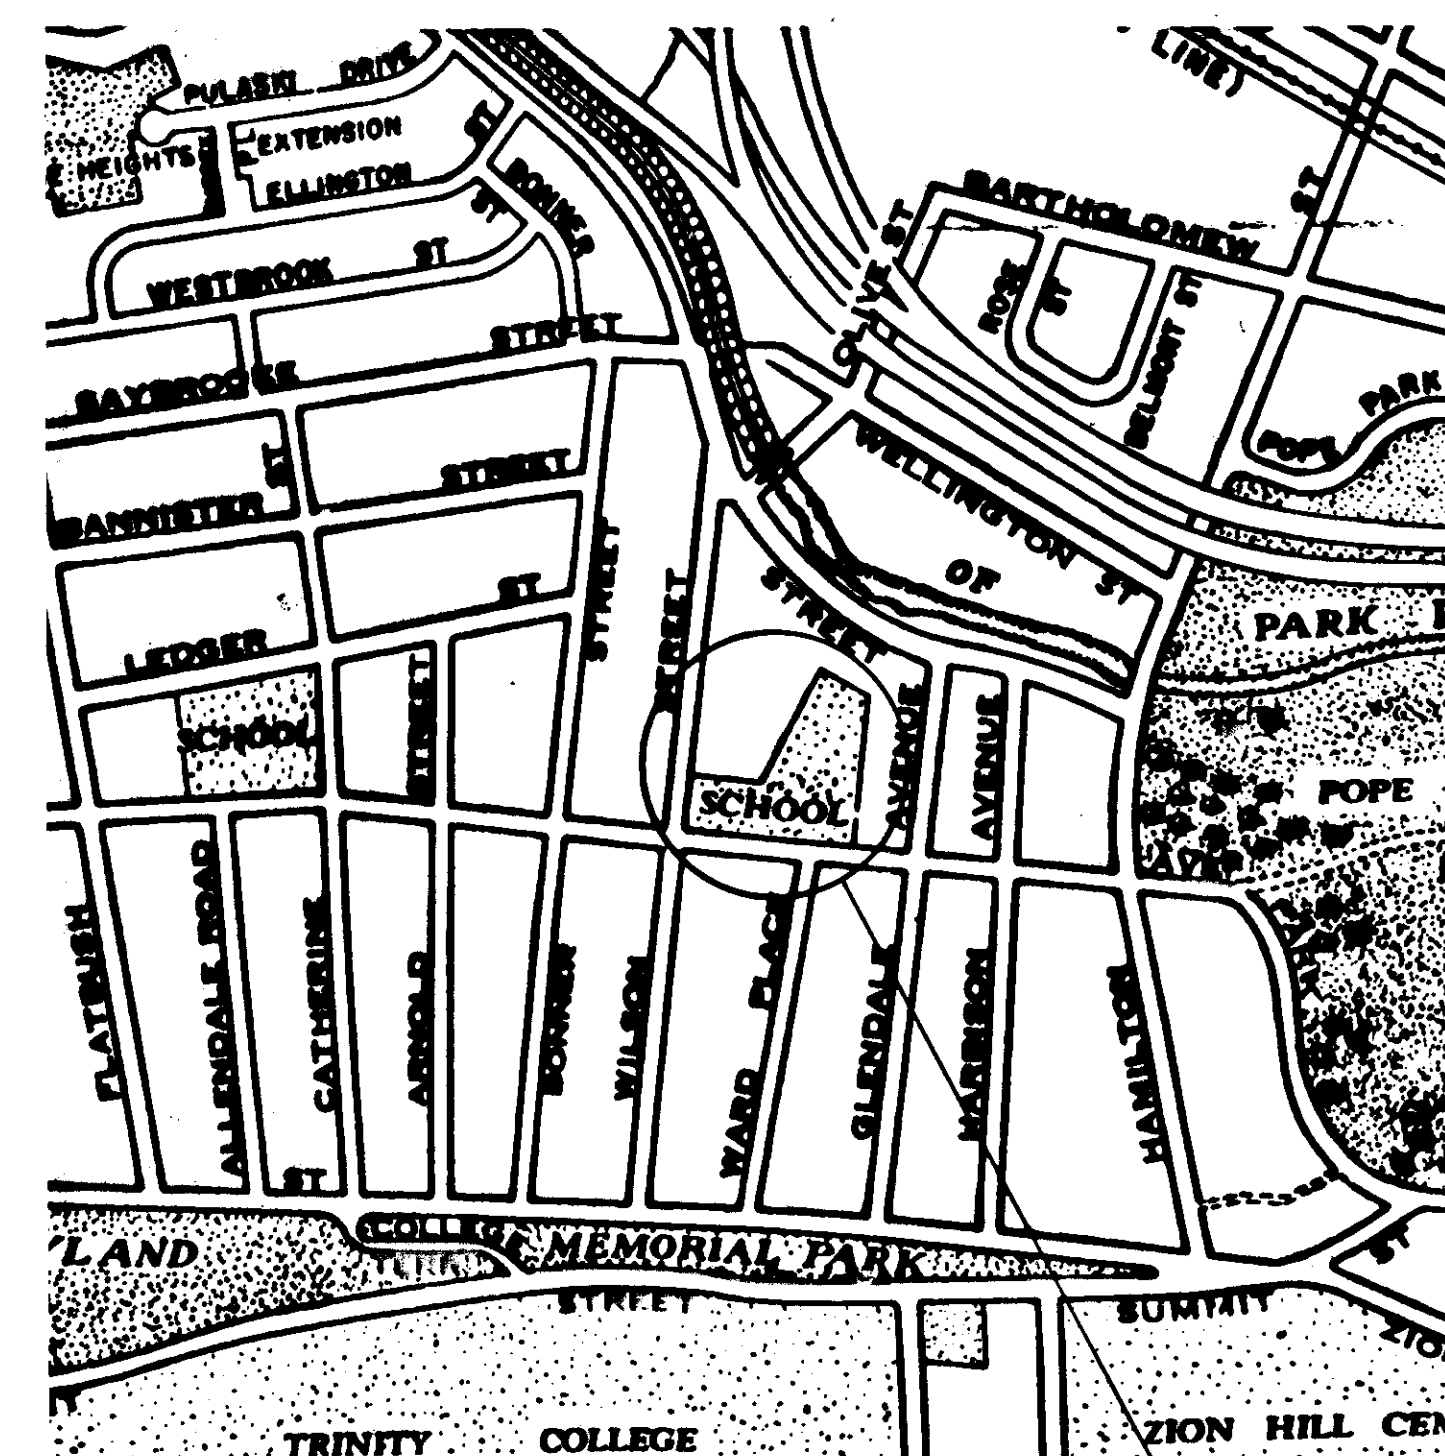

SITE PLAN  
Scale: 1"=500'

MOSEN KHOSHNEVISS  
Project Engineer

JEROME F. SHEA  
Manager  
Engineering Planning and Design

TITLE	CONTENTS	SHEET NO.
TITLE SHEET		1 OF 3
PLAN FOR INSTALLATION OF PLAYSCAPE AND FITNESS CORSE STRUCTURES AT MCDONOUGH SCHOOL		2 OF 3
DETAILS FOR PLAYSCAPE AND FITNESS COURSE STRUCTURES AT MCDONOUGH SCHOOL		3 OF 3

ANTHONY FERRARO  
Assistant Director of  
Public Works/ City Engineer

DELBERT F. KARMEIER  
Director of Public Works