




LOCATION PLAN  
Scale: 1"=3200'

# CITY OF HARTFORD

## DEPARTMENT OF PUBLIC WORKS


### BUREAU OF ENGINEERING SERVICES

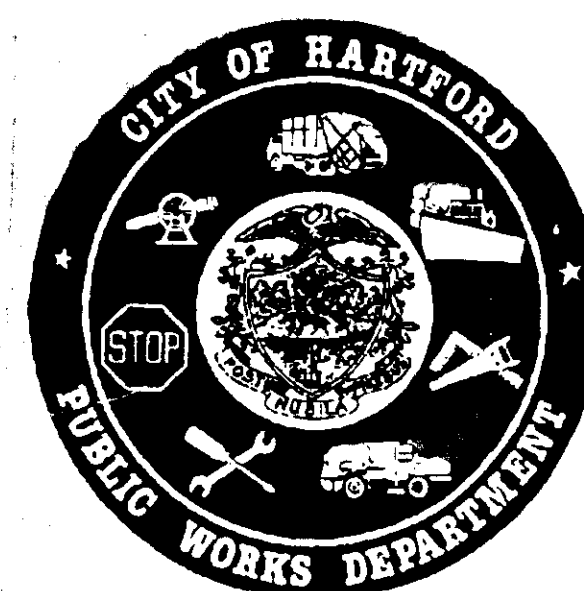

## PLANS

FOR

## RECONSTRUCTION OF WEST CLAY STREET CONTRACT NO. E91-24

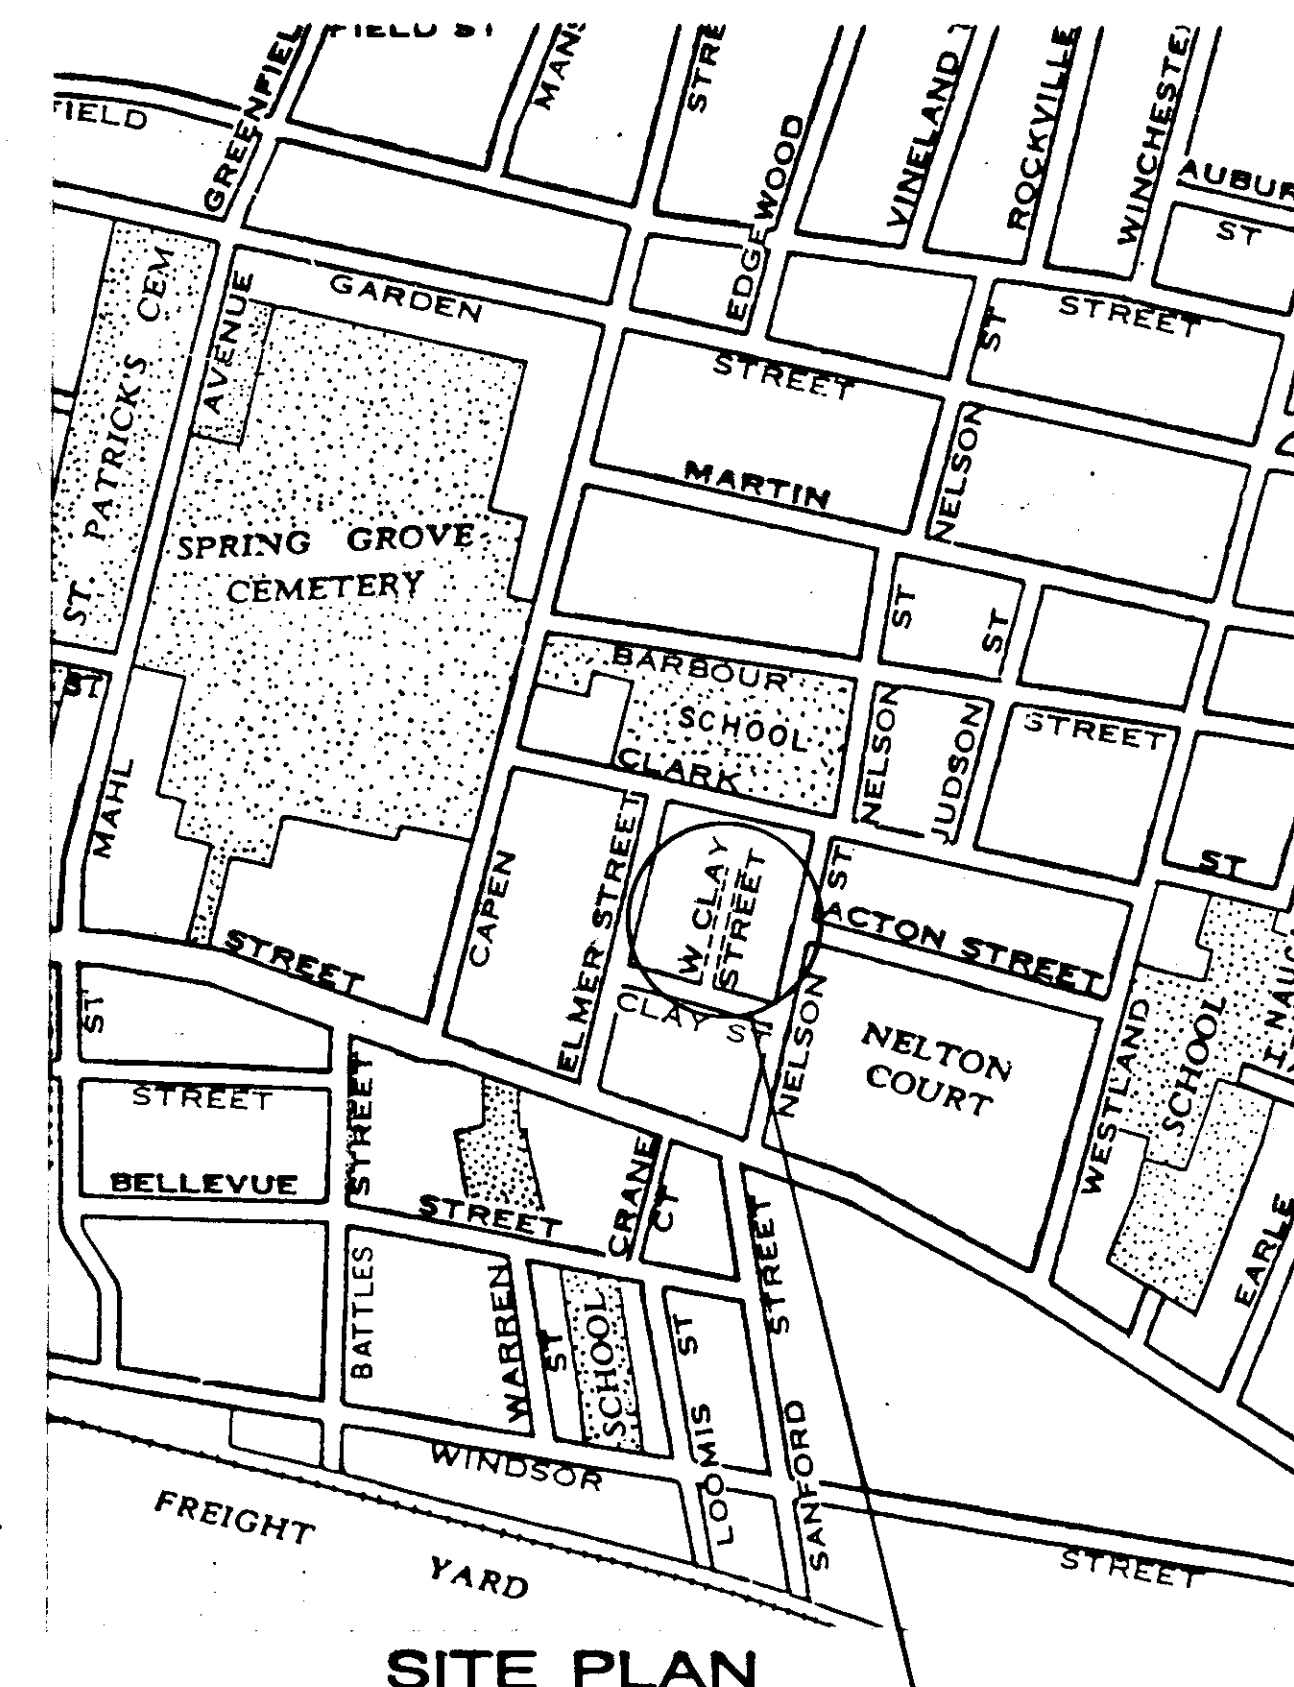

SITE PLAN  
Scale: 1"=500'

MOSEN KHOSHNEVISS  
Project Engineer

JEROME F. SHEA  
Division Manager  
Engineering Planning and Design

Contents	
TITLE	SHEET NO.
TITLE SHEET	1.
STANDARD TRANSPORTATION DETAILS FOR WEST CLAY STREET	2.
TYPICAL DETAILS FOR 8" WATER MAIN ON WEST CLAY STREET	3.
STANDARD DETAILS SHEET I	4.
STANDARD DETAILS SHEET II	5.
STANDARD DETAILS SHEET III	6.
WEST CLAY STREET PLAN AND PROFILE	7.

ANTHONY FERRARO  
Assistant Director of  
Public Works/ City Engineer

DELBERT F. KARMEIER  
Director of Public Works