

LOCATION PLAN

# CITY OF HARTFORD

## DEPARTMENT OF PUBLIC WORKS

### DIVISION OF ENGINEERING



## PLANS


## FOR

## RECONSTRUCTION OF CAPITOL AVENUE

## DRAINAGE INLET

## HARTFORD, CONNECTICUT

CONTRACT NO. E92-35

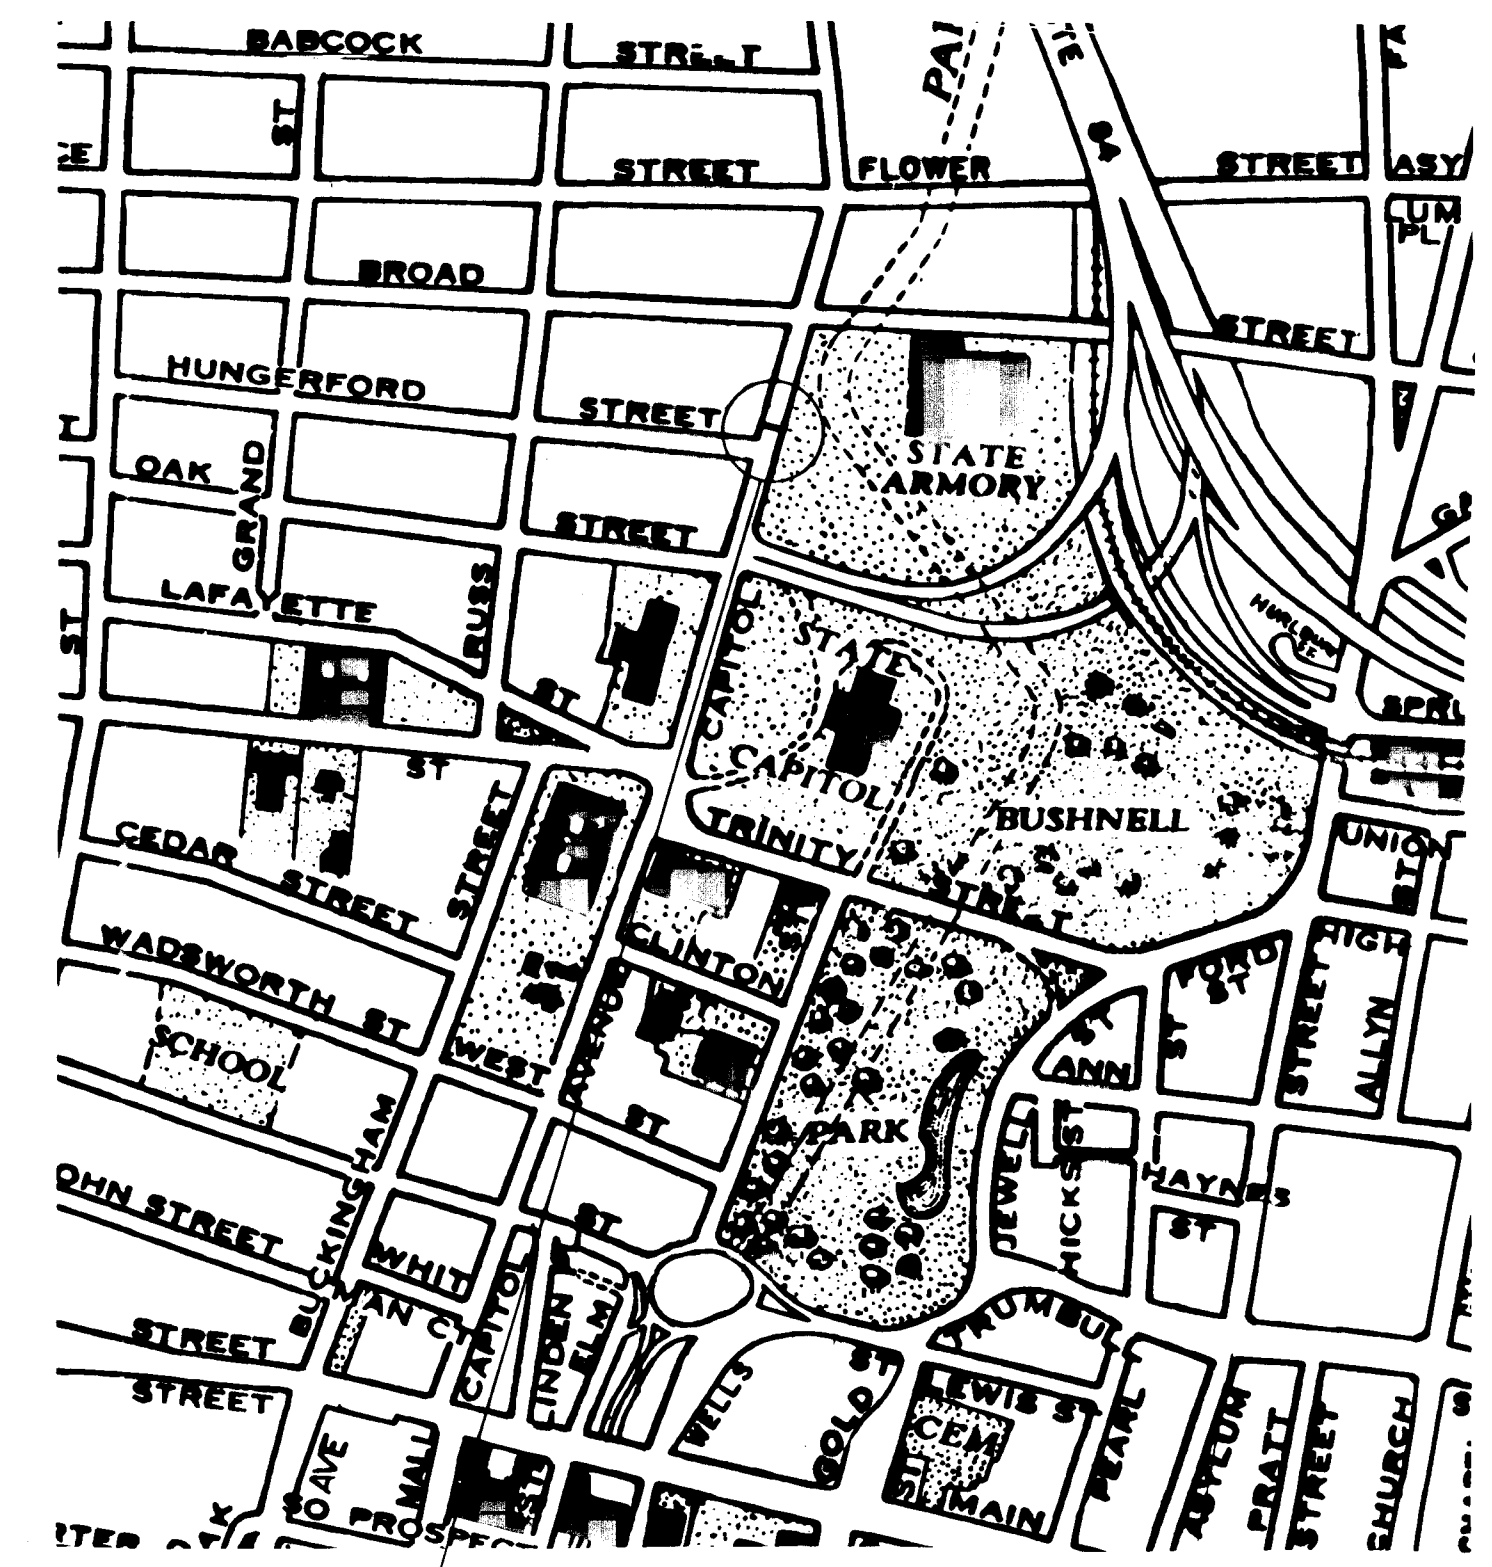

SITE PLAN  
Scale: 1"=500'

### CONTENTS

JOHN L. BERTOLI  
Project Engineer

JEROME F. SHEA  
Division Manager  
Engineering Planning and Design

#### SHEET NUMBER

#### DESCRIPTION

- |    |                           |
|----|---------------------------|
| 1. | COVER SHEET               |
| 2. | TRAFFIC DETAILS / SIGNAGE |
| 3. | STANDARD DETAILS          |
| 4. | MISCELLANEOUS DETAILS     |
| 5. | WORK PHASING PLAN         |
| 6. | PLAN AND PROFILE          |

ANTHONY FERRARO  
Assistant Director of  
Public Works/ City Engineer

DELBERT F. KARMEIER  
Director of Public Works