


The location of the underground utilities shown on this plan have been obtained from the best available sources. The actual location of these utilities should be verified in the field by the contractor.

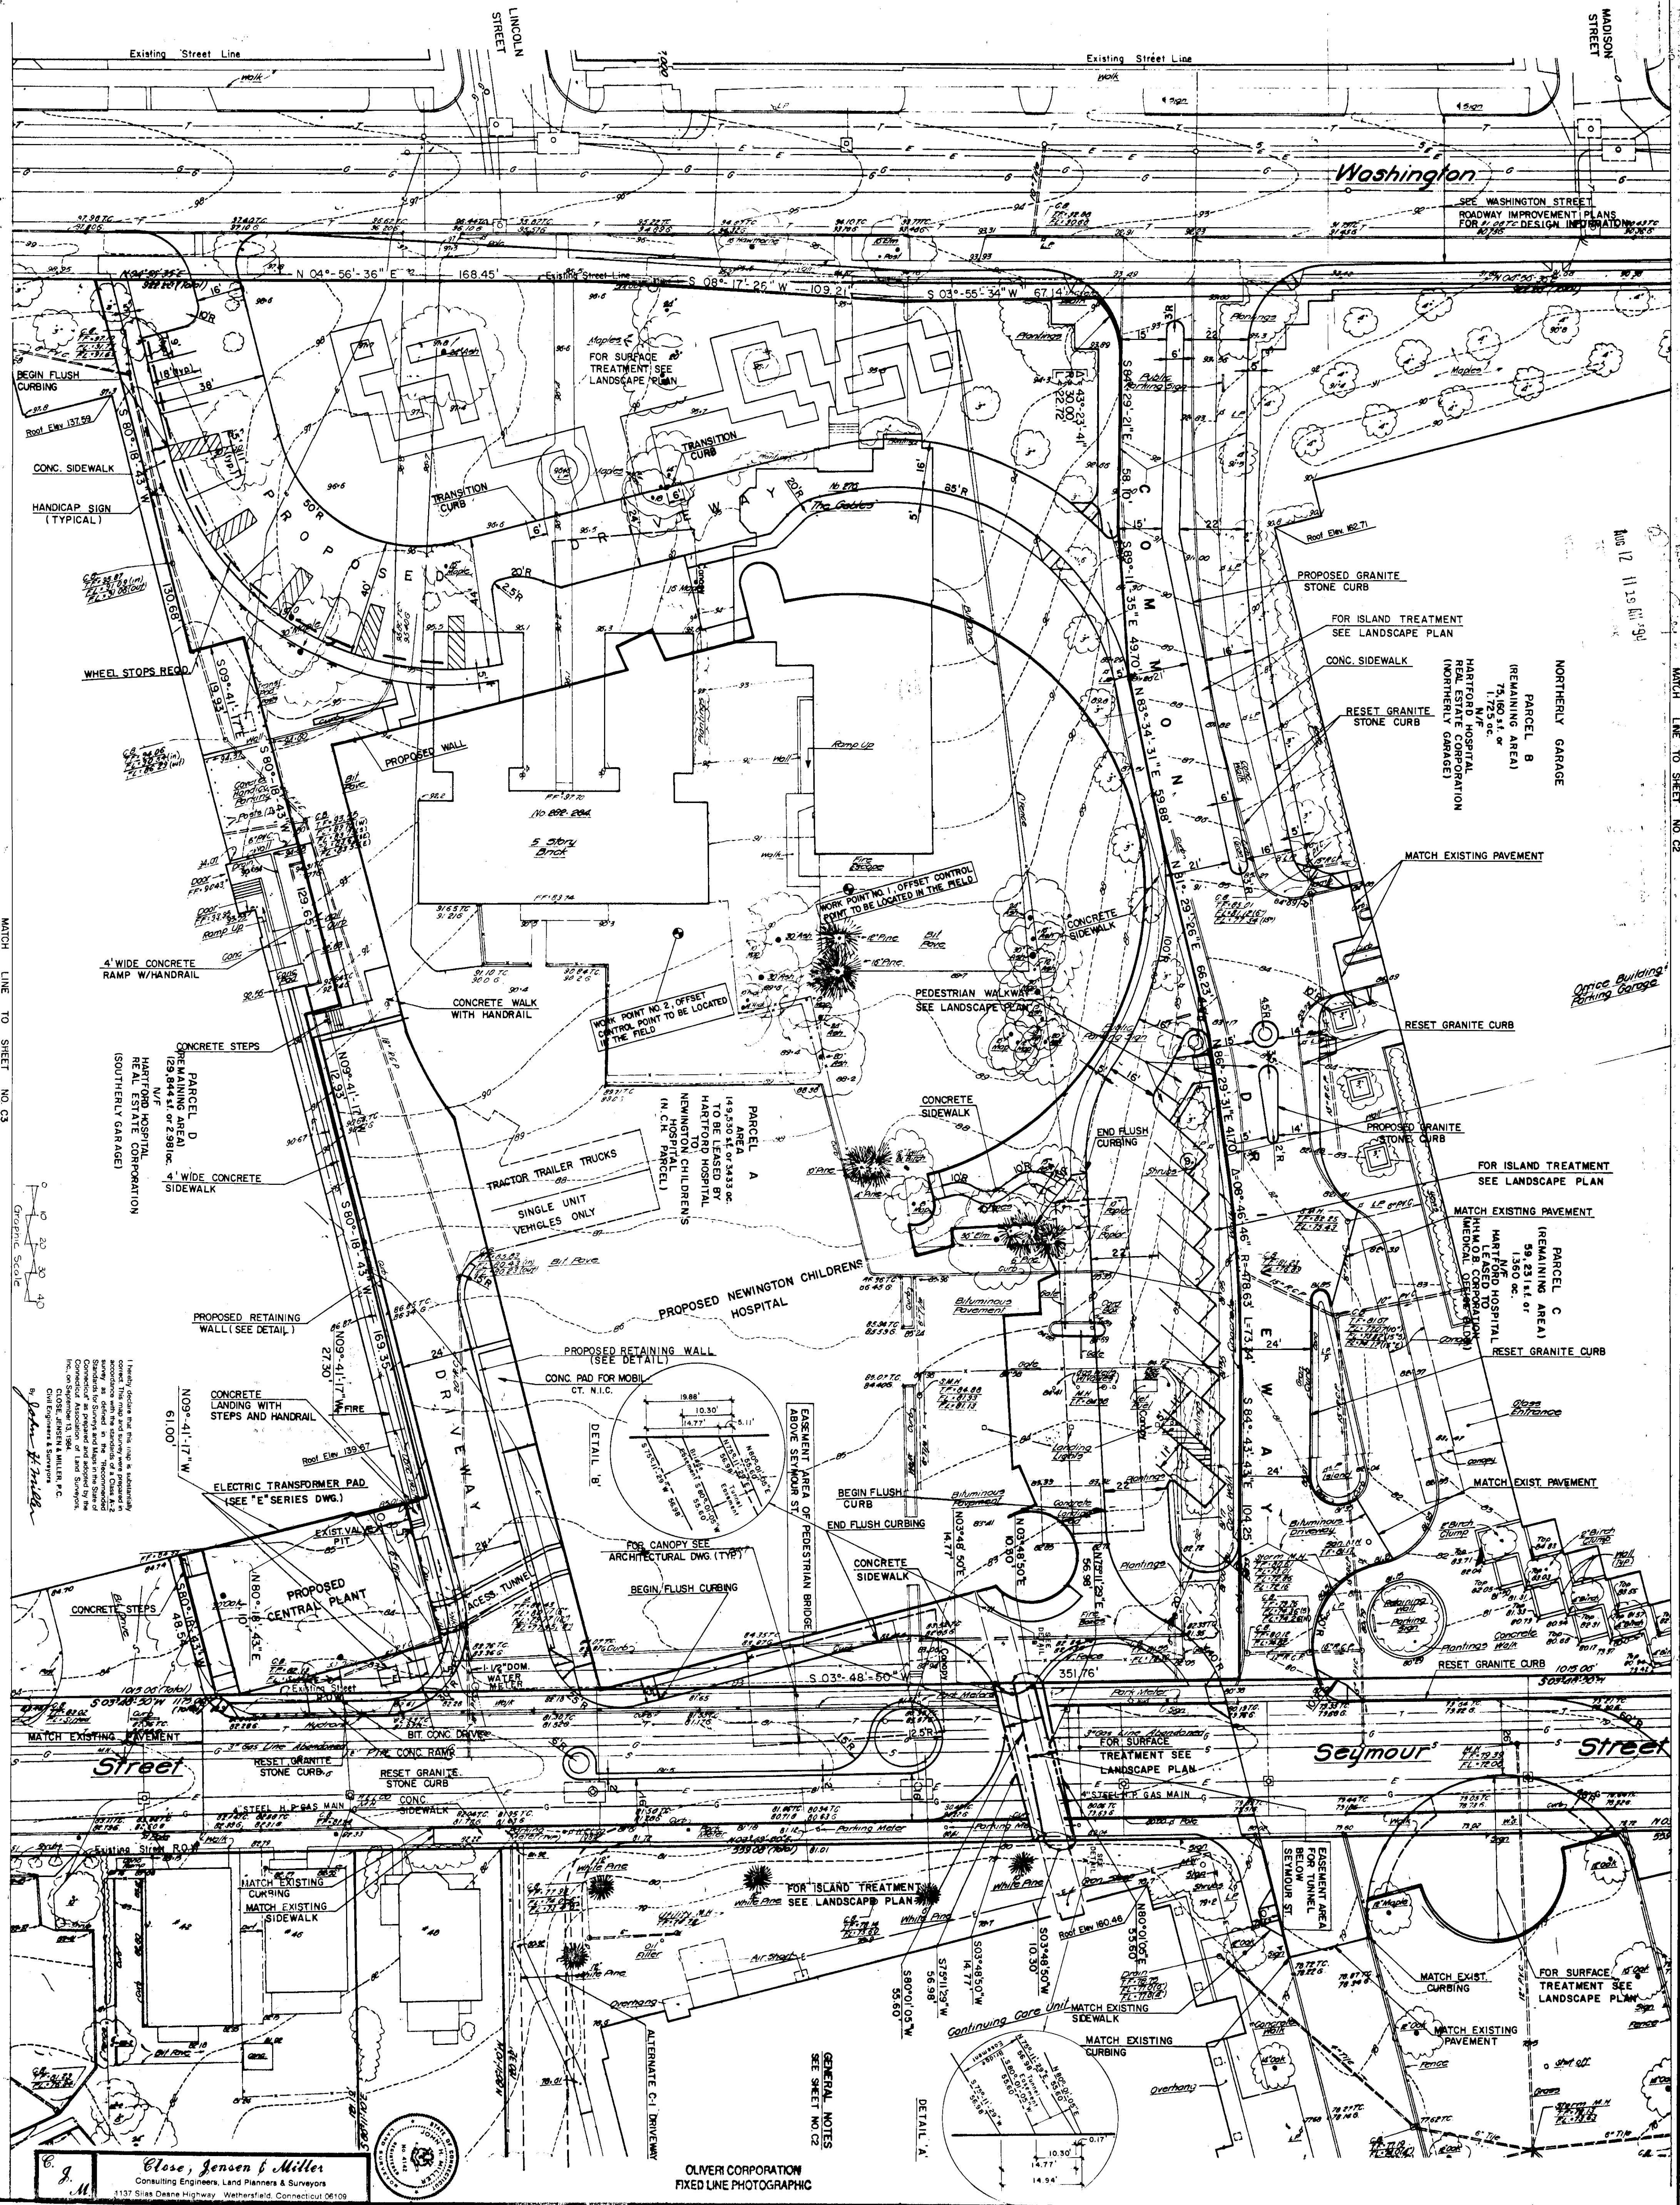

Close, Jensen & Miller
Consulting Engineers, Land Planners & Surveyors
1137 Silas Deane Highway, Wetherfield, Connecticut 06109

OLIVER CORPORATION
FIXED LINE PHOTOGRAPHIC

THE NEW NEWINGTON CHILDREN'S HOSPITAL HARTFORD, CT

HKS HKS Inc. Architects/Engineers/Planners
1111 Plaza of the Americas North, LB307
Dallas, Texas 75201 214/969-5599

PROPERTY TO BE
LEASED TO
NEWINGTON CHILDREN'S HOSPITAL

HARTFORD, CONNECTICUT

SITE PLAN

SCALE: 1" = 20'

5/13/94