


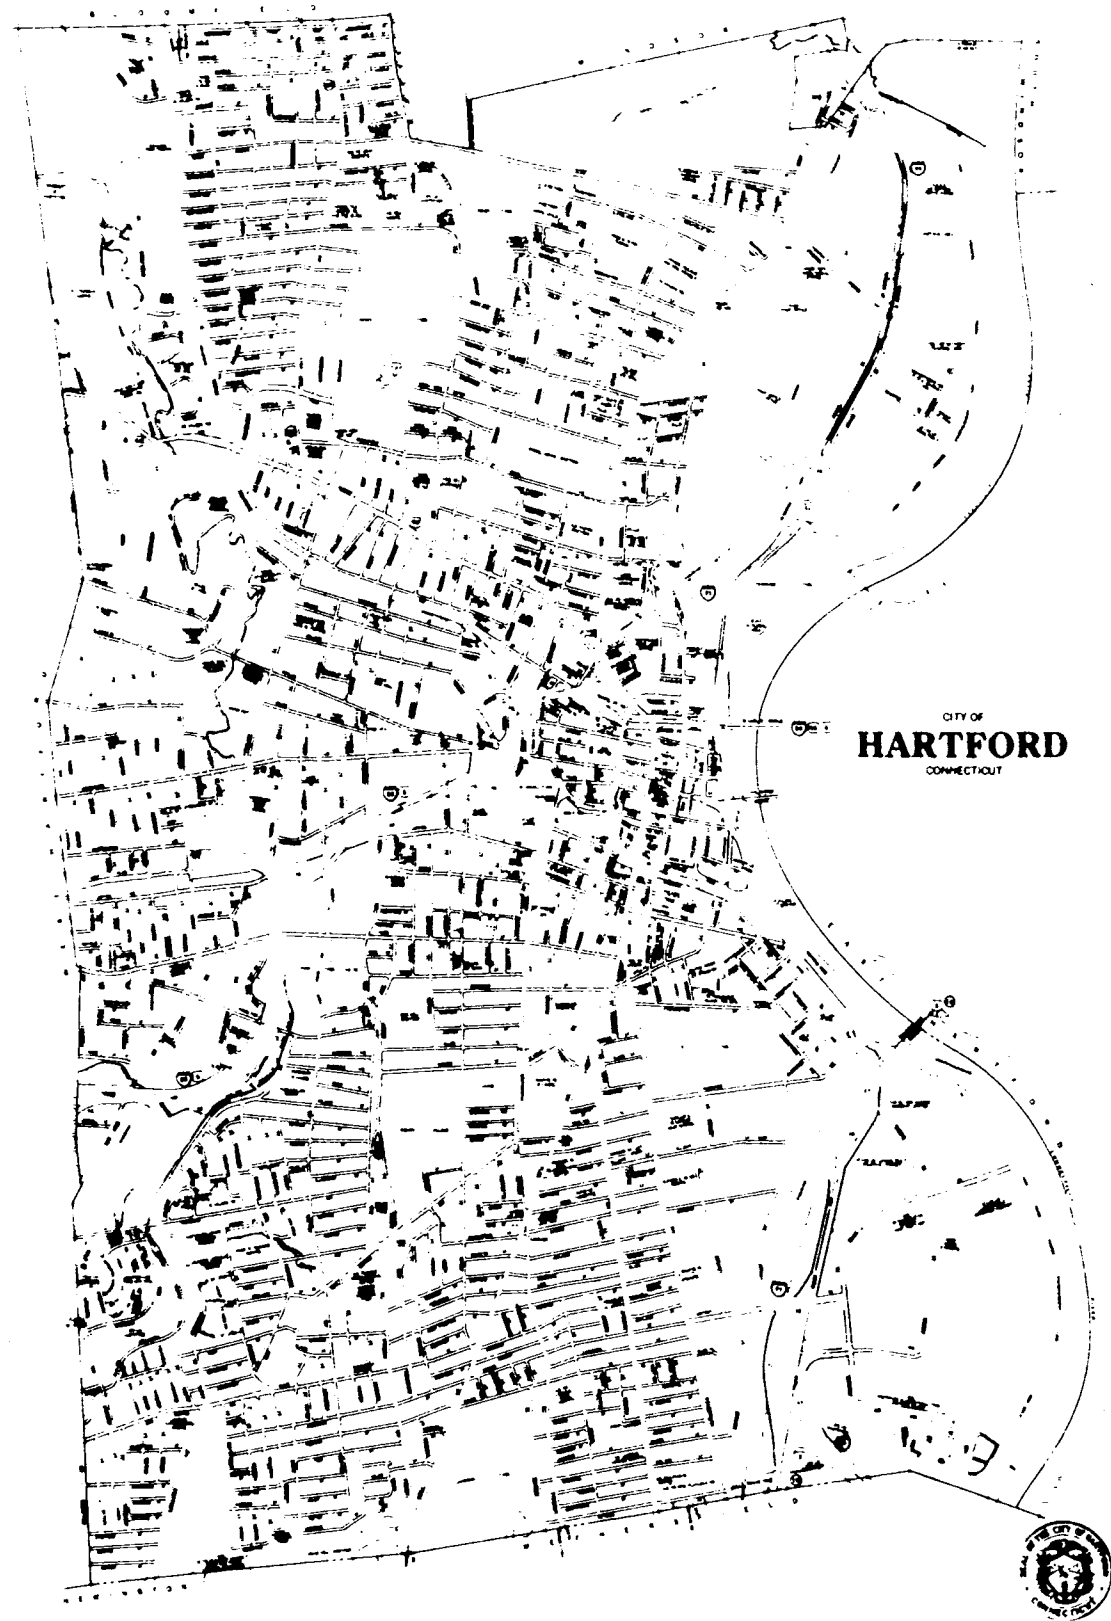


LOCATION PLAN
Scale: 1 in./3200 ft.

CITY OF HARTFORD

DEPARTMENT OF PUBLIC WORKS BUREAU OF ENGINEERING SERVICES



PLANS FOR POPE PARK NORTH PLAYGROUND IMPROVEMENTS HARTFORD, CONNECTICUT CONTRACT #E90-31R

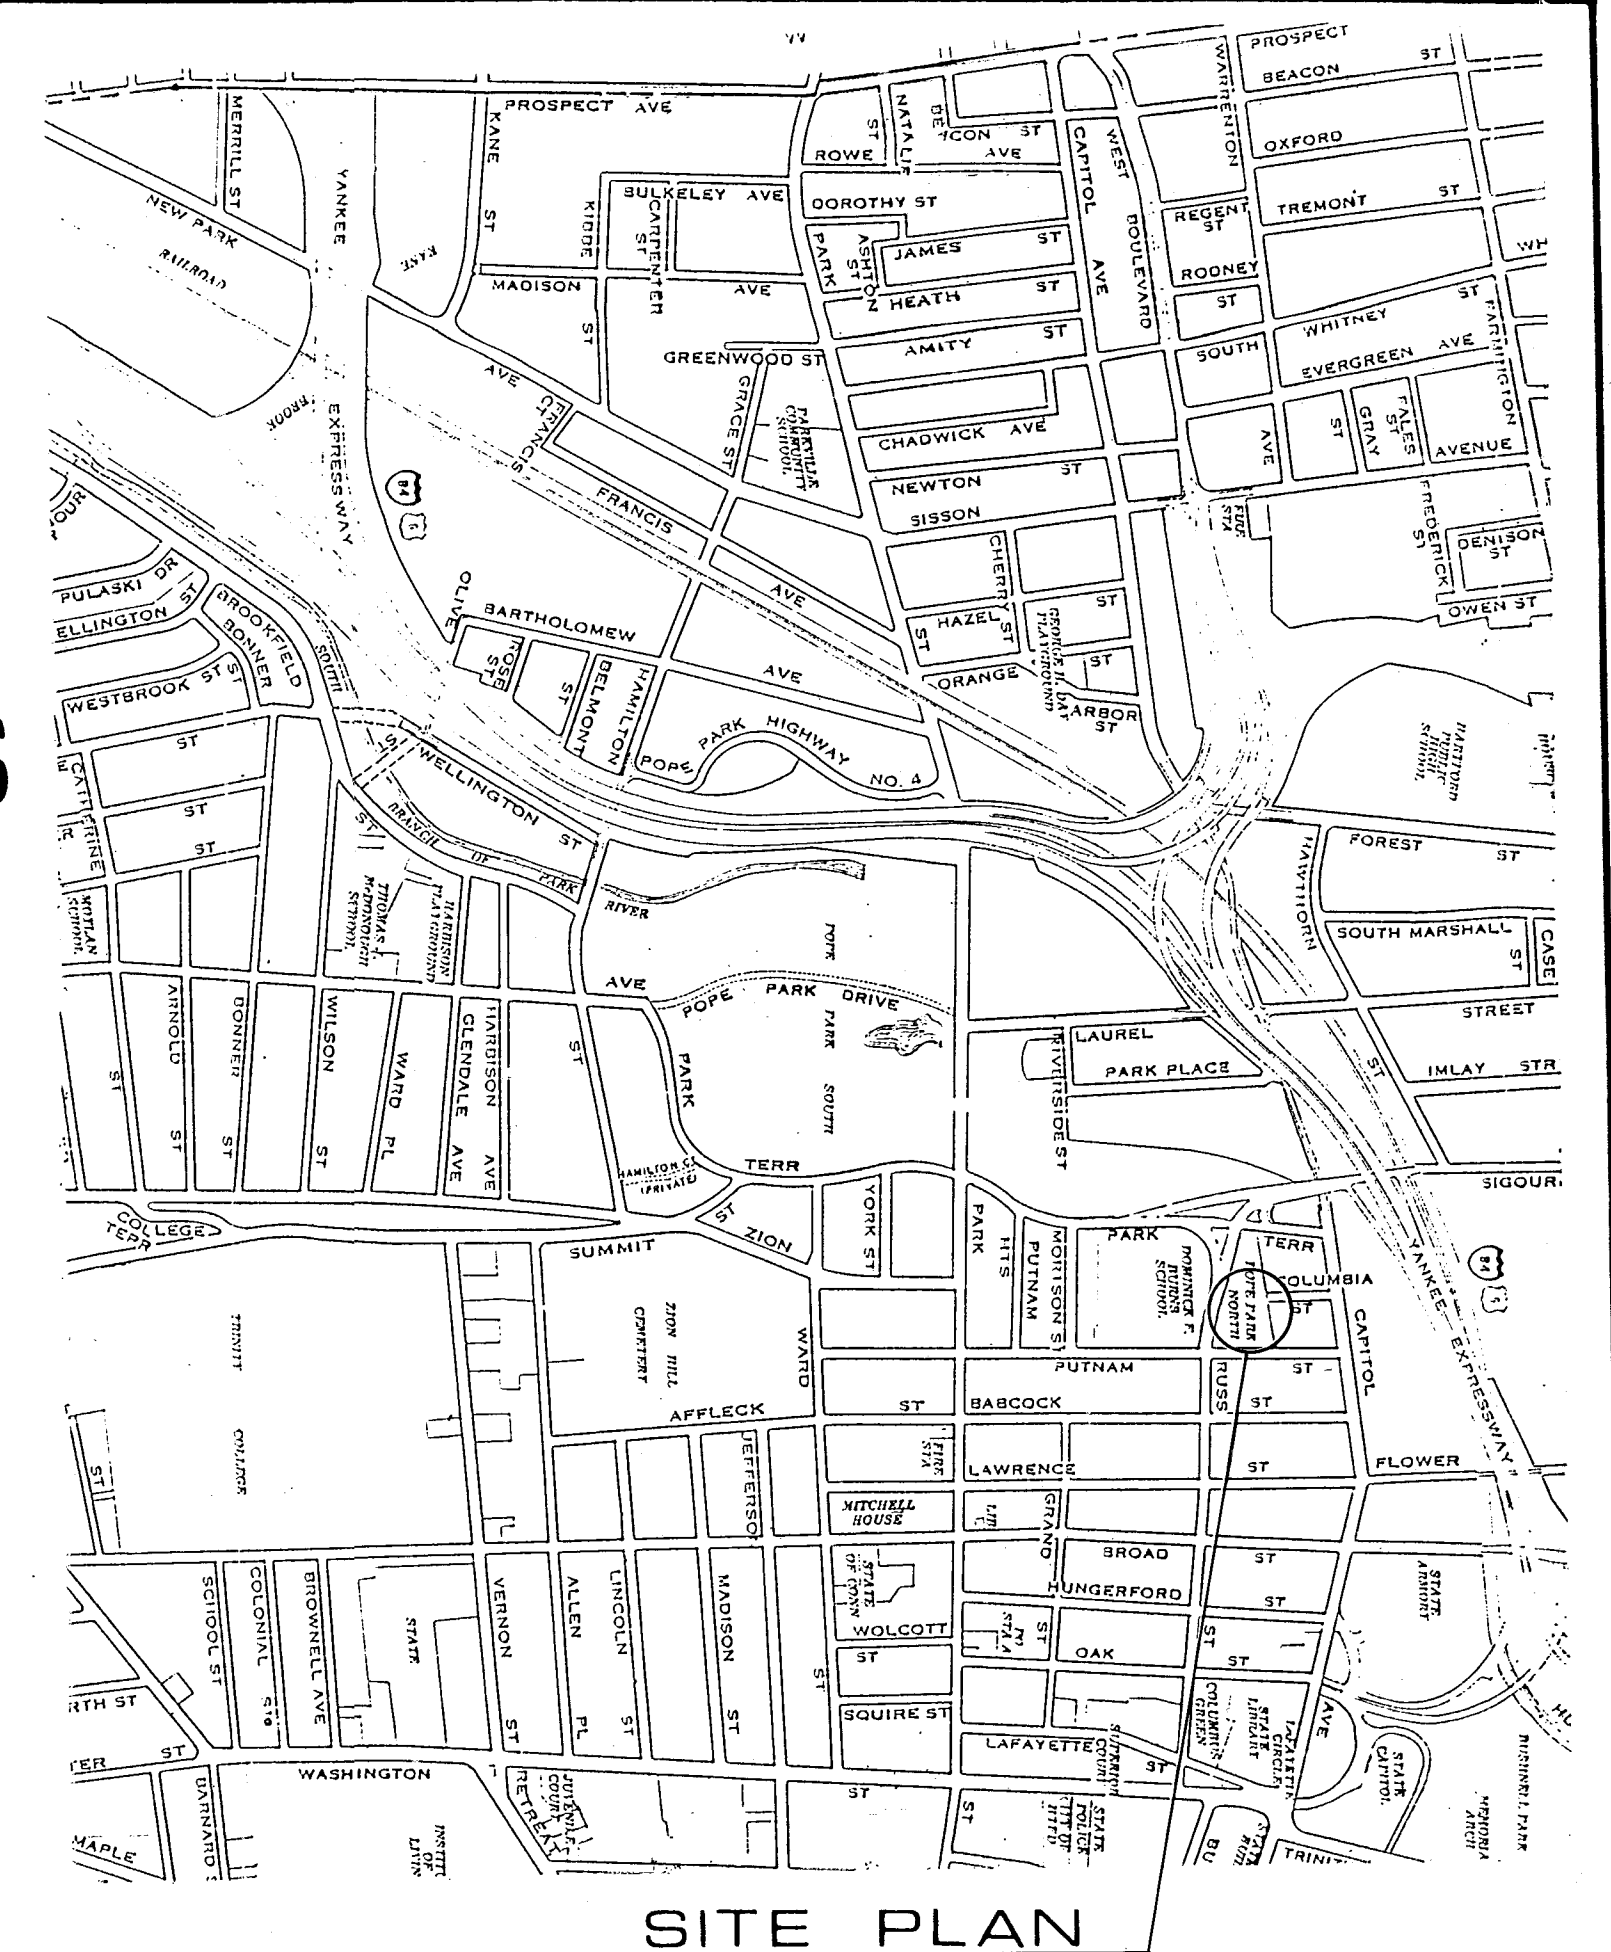

SITE PLAN
Scale: 1 in./1000 ft.

JOHN L. BERTOLI
Project Engineer

JEROME F. SHEA
Division Manager
Engineering Planning & Design

SHEET NO.	DESCRIPTION
S-1	POPE PARK NORTH SPRAY POOL DETAILS.
P-1	POPE PARK NORTH SPRAY POOL PIPING DETAILS.
S-1	POPE PARK NORTH SITE LAYOUT PLAN.

CONTENTS

SYMBOLS	DESCRIPTION
—x—x—	CHAIN-LINK FENCE
☁	TREES
—x—x—	APPROX. LIMIT OF CONST.
□ C.B.	CATCH BASIN
○ M.H.	MANHOLE
☁	BUSHES
○ L.P.	LIGHT POLE
—x—x—	AREA RESTORE WITH SOD
—x—x—	STORM DRAIN PIPE
—x—x—	WATER MAIN
—x—x—	EXISTING CONTOUR

LEGEND

ABBREVIATIONS	DESCRIPTION
APPROX.	APPROXIMATE
C.B.	CATCH BASIN
EL.	ELEVATION
CONC.	CONCRETE
C.L.F.	CHAIN LINK FENCE
C.L. & P.	CONNECTICUT LIGHT & POWER
MIN.	MINIMUM
INV.	INVERT
BIT.	BITUMINOUS
REQ'D	REQUIRED
FT.	FEET
AC 20	ASPHALTIC CEMENT

ANTHONY FERRARO
City Engineer

DELBERT KARMEIER
Director Public Works