








#FF-4 - ROOF MOUNTED EXHAUST FAN;
 SPUN ALUMINUM W/BACKDEAD DAMPER;
 BIRDSCREEN, & DISC SW. DIRECT DRIVE;
 TWO SPEED MOTOR, 2500 CM. @ 0.125" SQ.
 EQUAL TO LORE'S COOK MOD. 135C1MD;
 3/4 HP; 230V-1Ø-60 HZ. (SEE
 WIRING DIAGRAM). FIELD FABR CURD
 BY G.C.

#UH-2 UNIT HTR.
 WITH SPECIAL FLUE-SEE
 DETAIL ELSEWHERE THIS SHEET

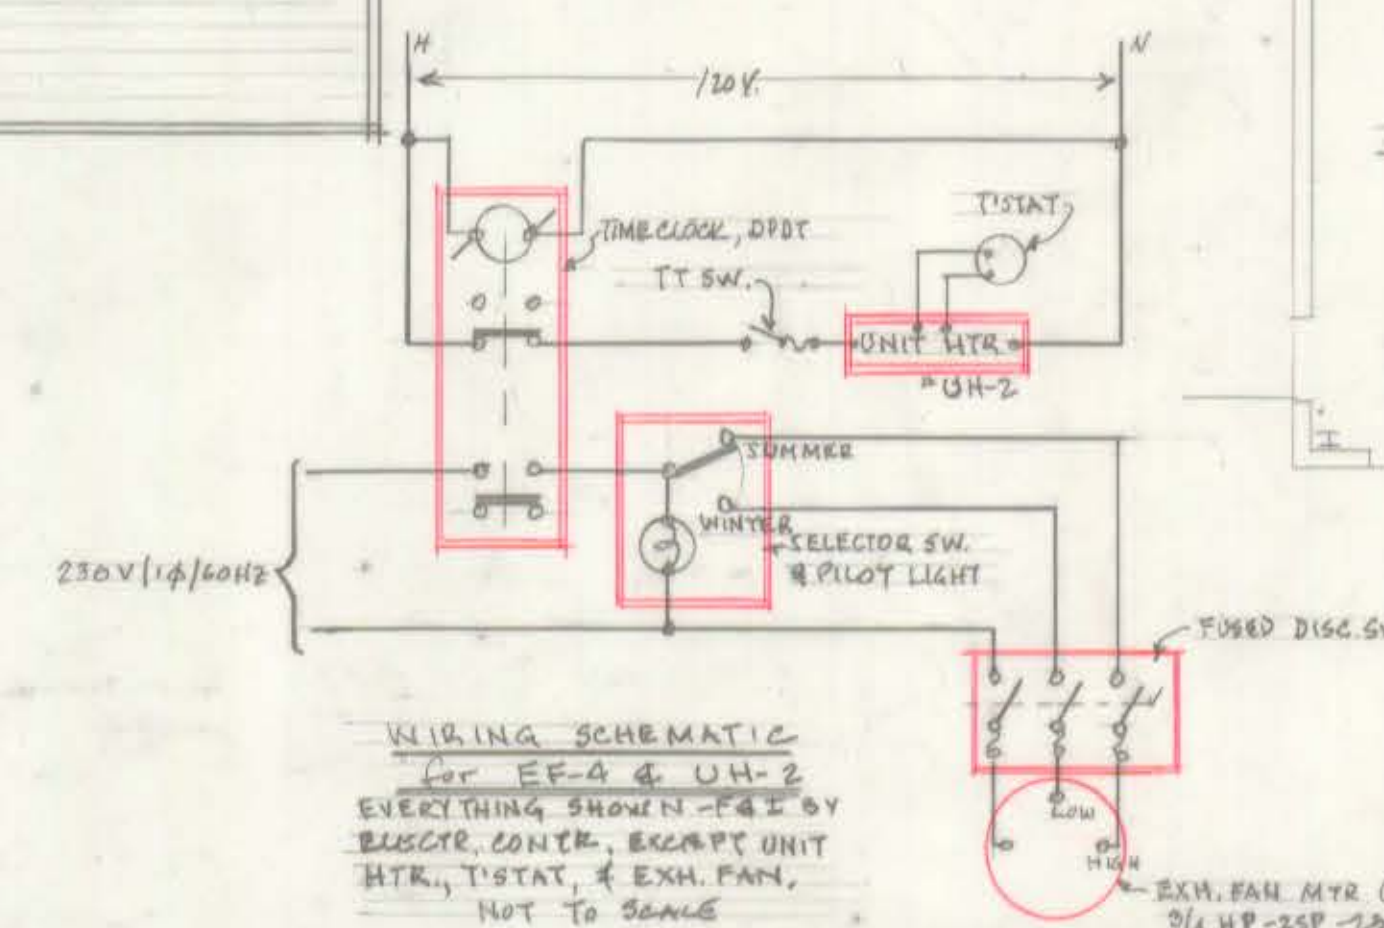

NOTES: (PLB, & HAV & SPKR.)

1. FOR PLB & FIXTURE & HEATING UNITS DESCRIPTION - SEE SPECIFICATIONS
2. PITCH ALL PIPING FOR PROPER DRAINAGE.
3. PROVIDE WATER HAMMER ARRESTOR IN SUPPLY WATER LINE.
4. PROVIDE WATER PRESSURE REDUCING VALVE, BACK FLOW PREVENTER, & VACUUM-BREAKERS AS REQUIRED.
5. PROVIDE HOSE BIB AT WATER PIPING LOW POINTS.
6. PROVIDE VALVES AND UNIONS IN PIPING FOR ISOLATION.
7. PROVIDE 115 VOLT POWER FOR WATER HEATER THERM PROTECTION KIT
8. LOCATE SPRINKLER WATER MOTOR ALARM GONG NEAR FRONT-NORTH SIDE OF BLDG.
9. COORDINATE EQUIPMENT & CEILING MOUNTED AIR OUTLETS WITH LIGHTING, PROVIDE SHOP DRAWINGS SHOWING PRE-INSTALLATION COORDINATION.

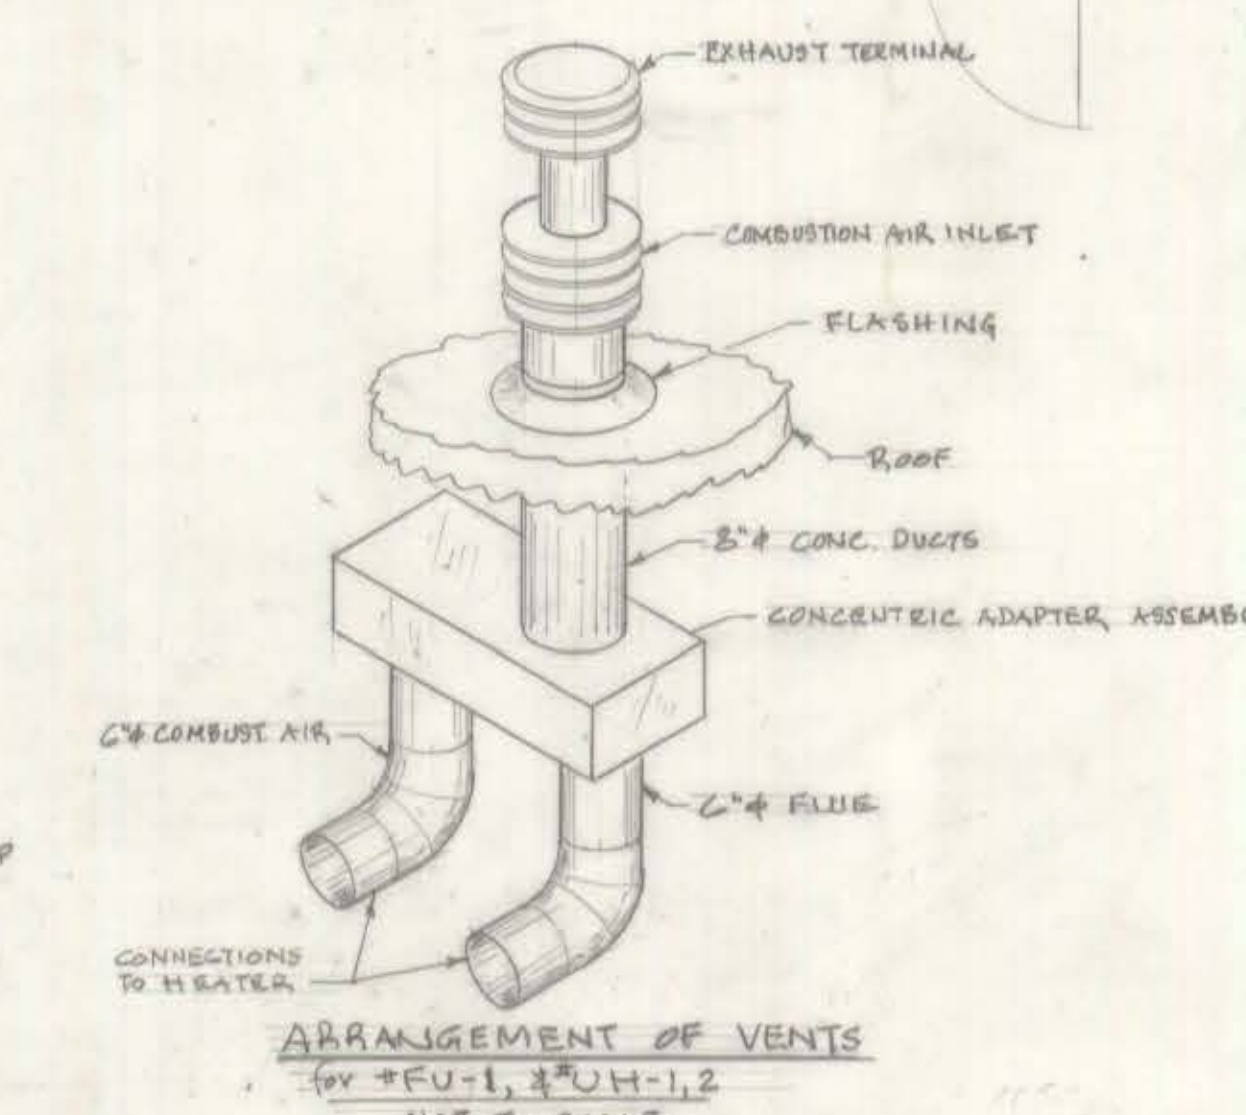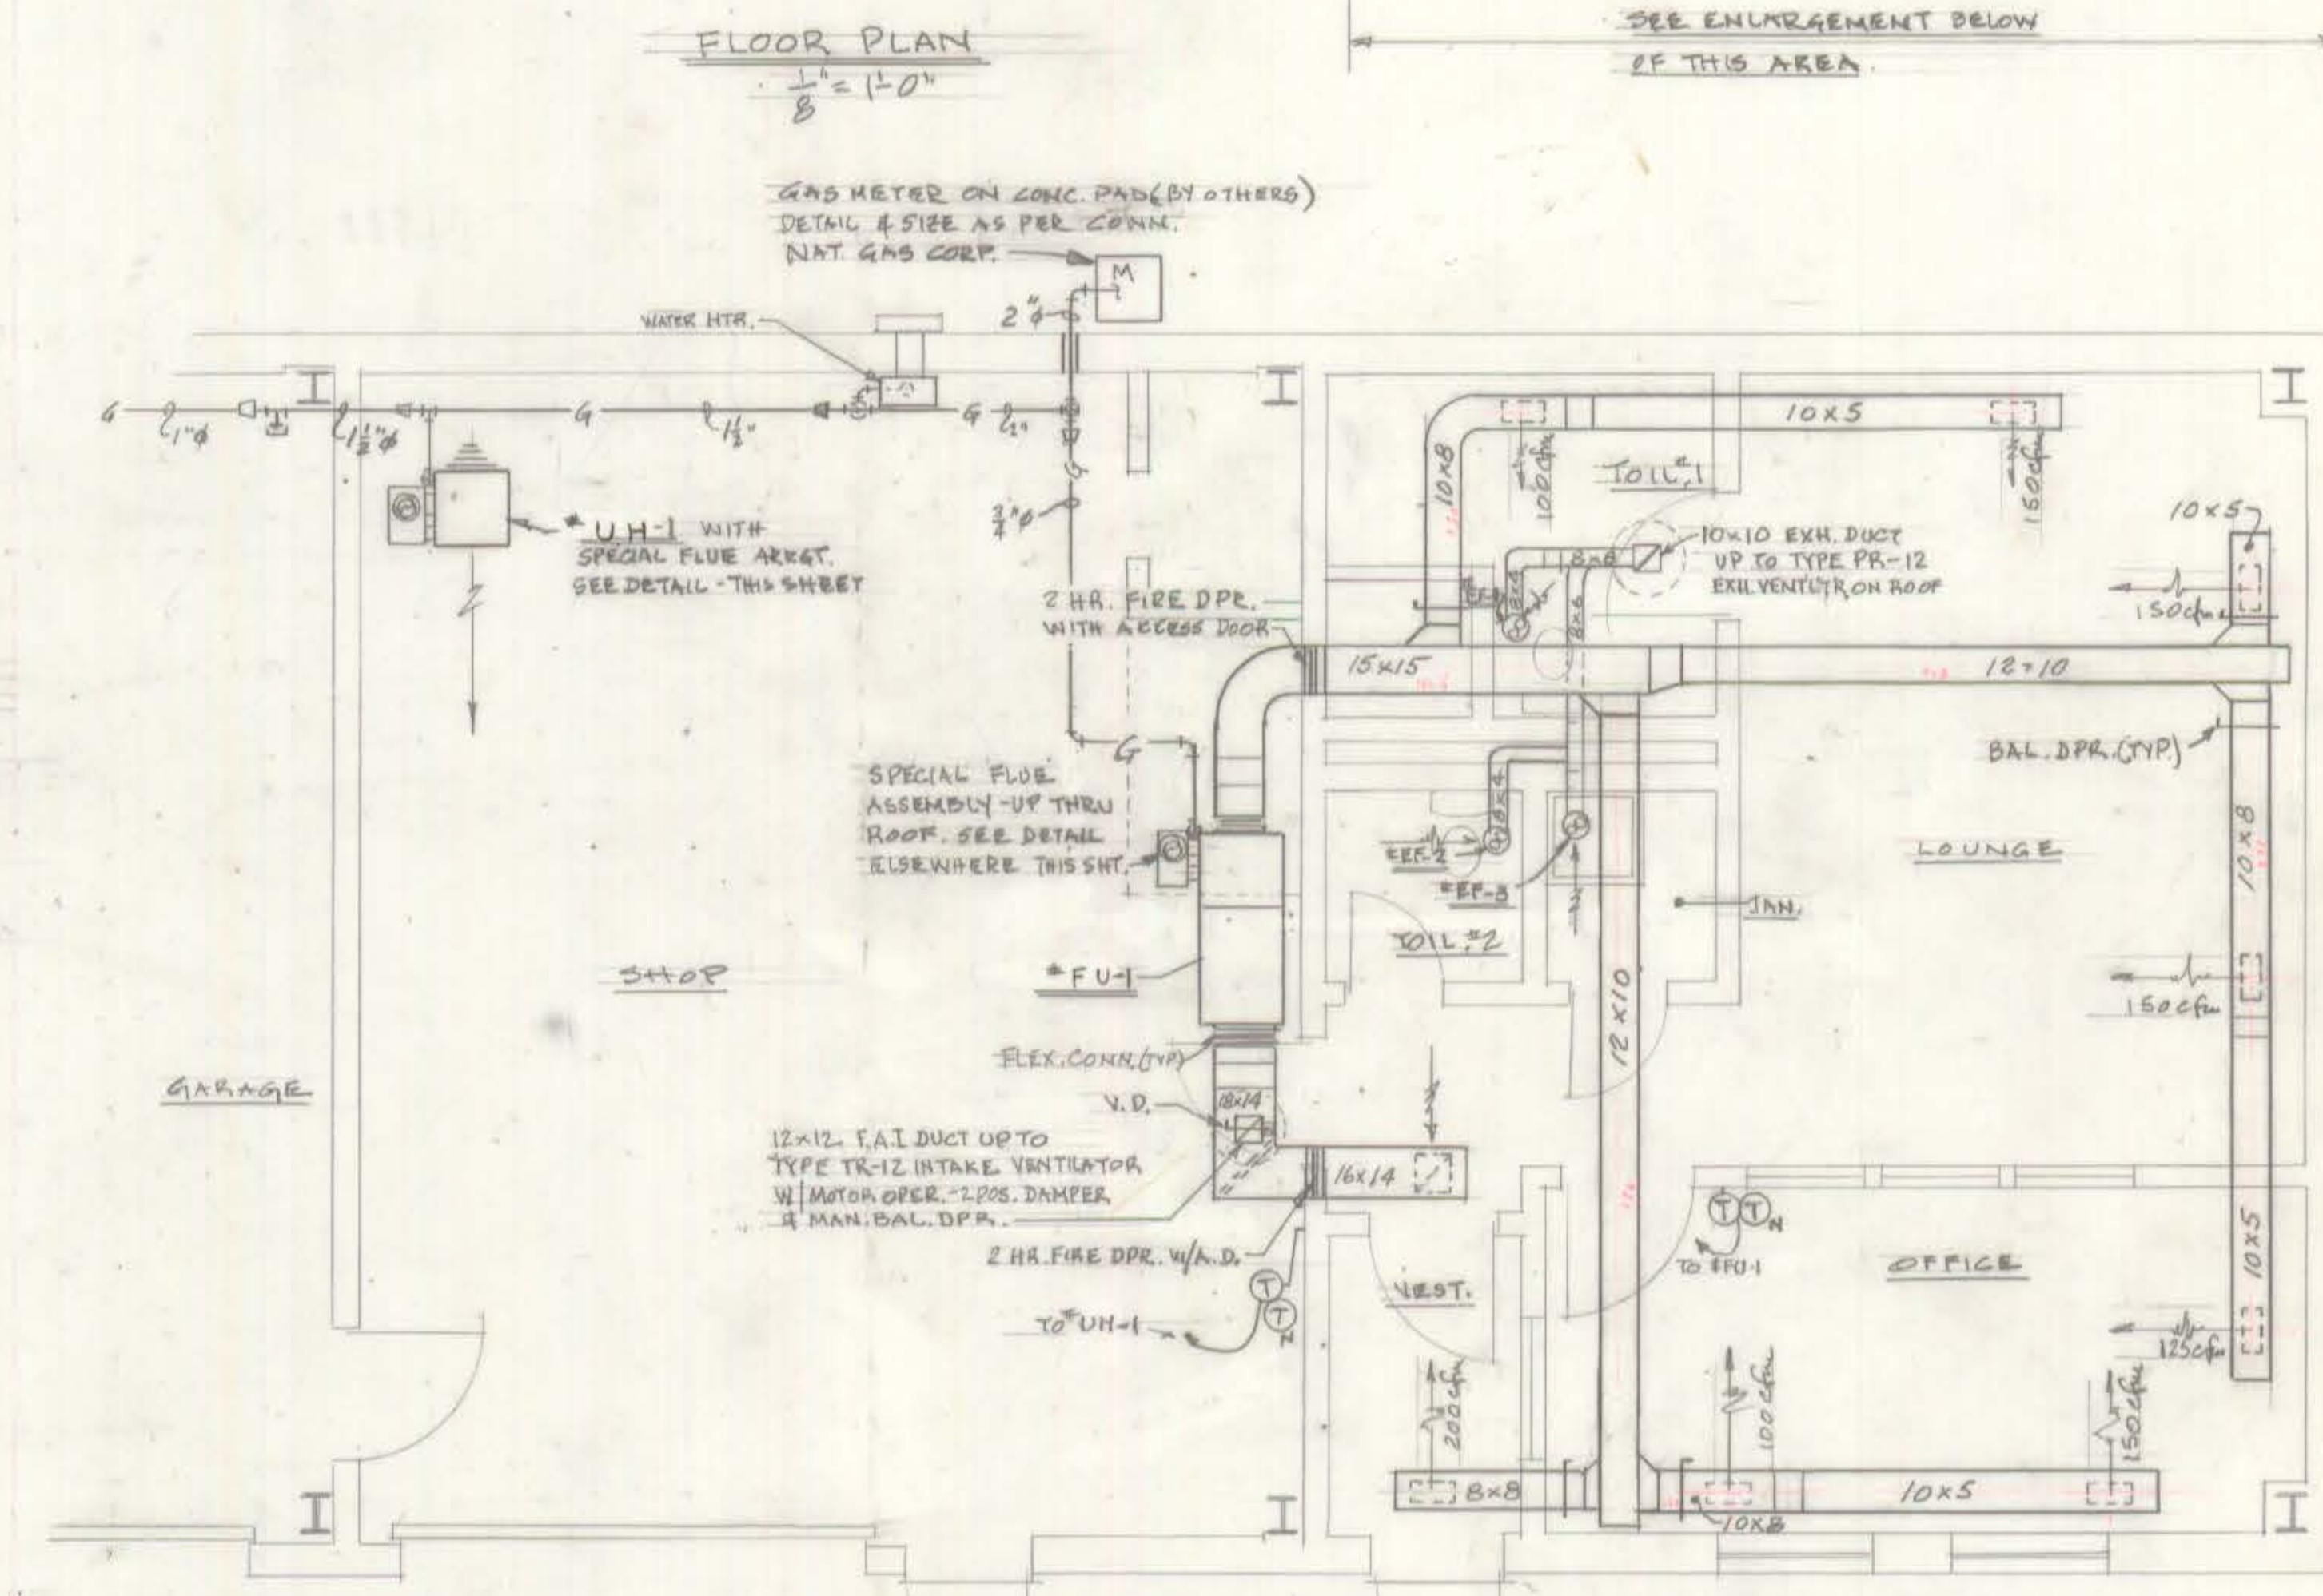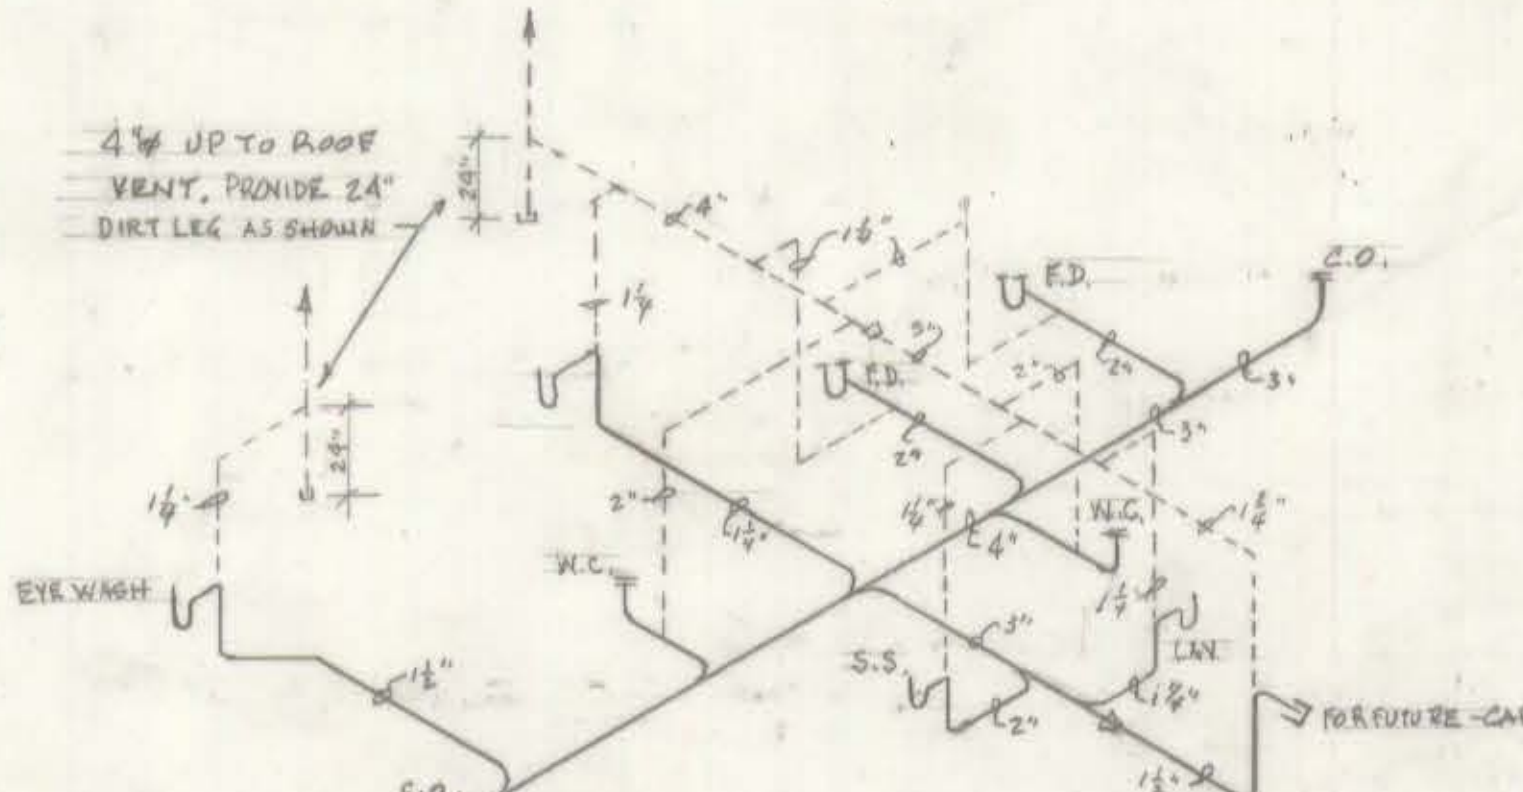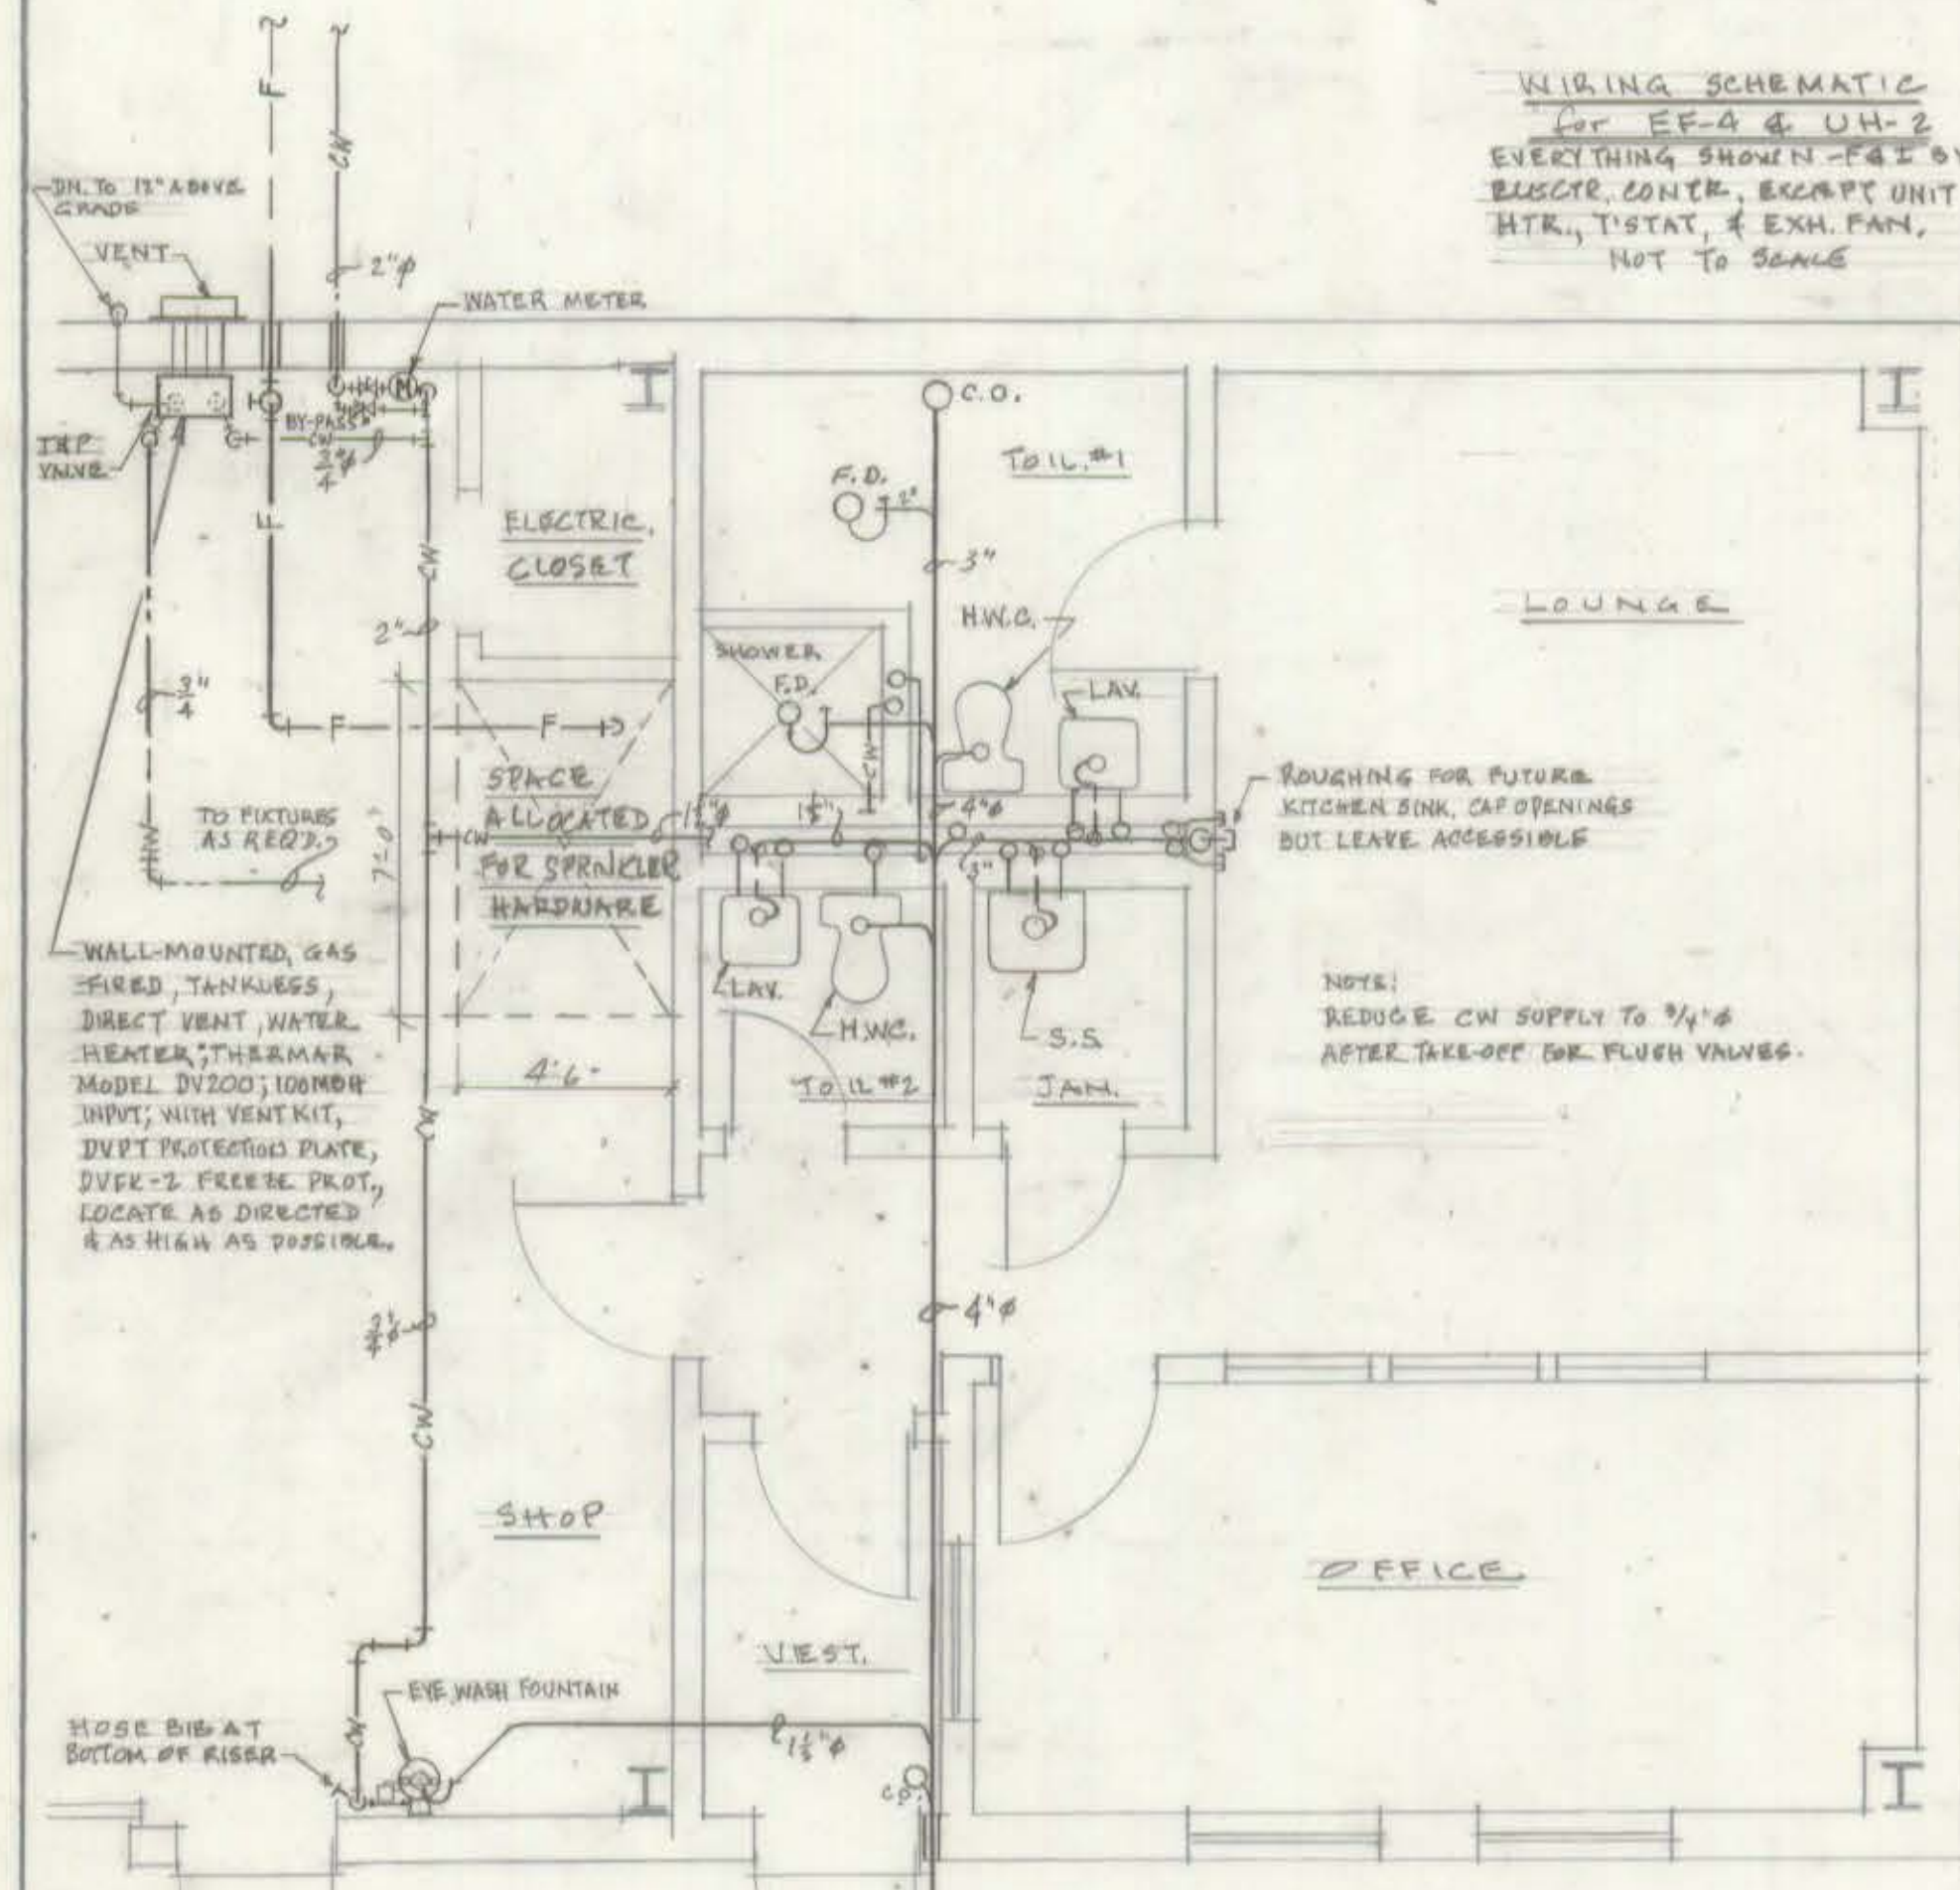

PARTIAL FLOOR PLAN - HEATING & VENTILATING
 1/4" = 1'-0"

CITY OF HARTFORD, CONNECTICUT
DEPARTMENT OF PUBLIC WORKS
FACILITY SERVICES BUREAU

GOODWIN PARK
STORAGE BUILDING
 RIDGE ROAD
 WETHERSFIELD/HARTFORD, CT.

SUBMITTED R.I. Miller	APPROVED Frank Vento	APPROVED [Signature]
DESIGNED R.I. MILLER	SCALE AS NOTED	DRAWING NO. PHV-1
DRAWN R.I. Miller	DATE JUNE 24, 1987	
CHECKED FAV	DAYBOOK NO. 01084-I	

CONTRACT NO. F87-B