


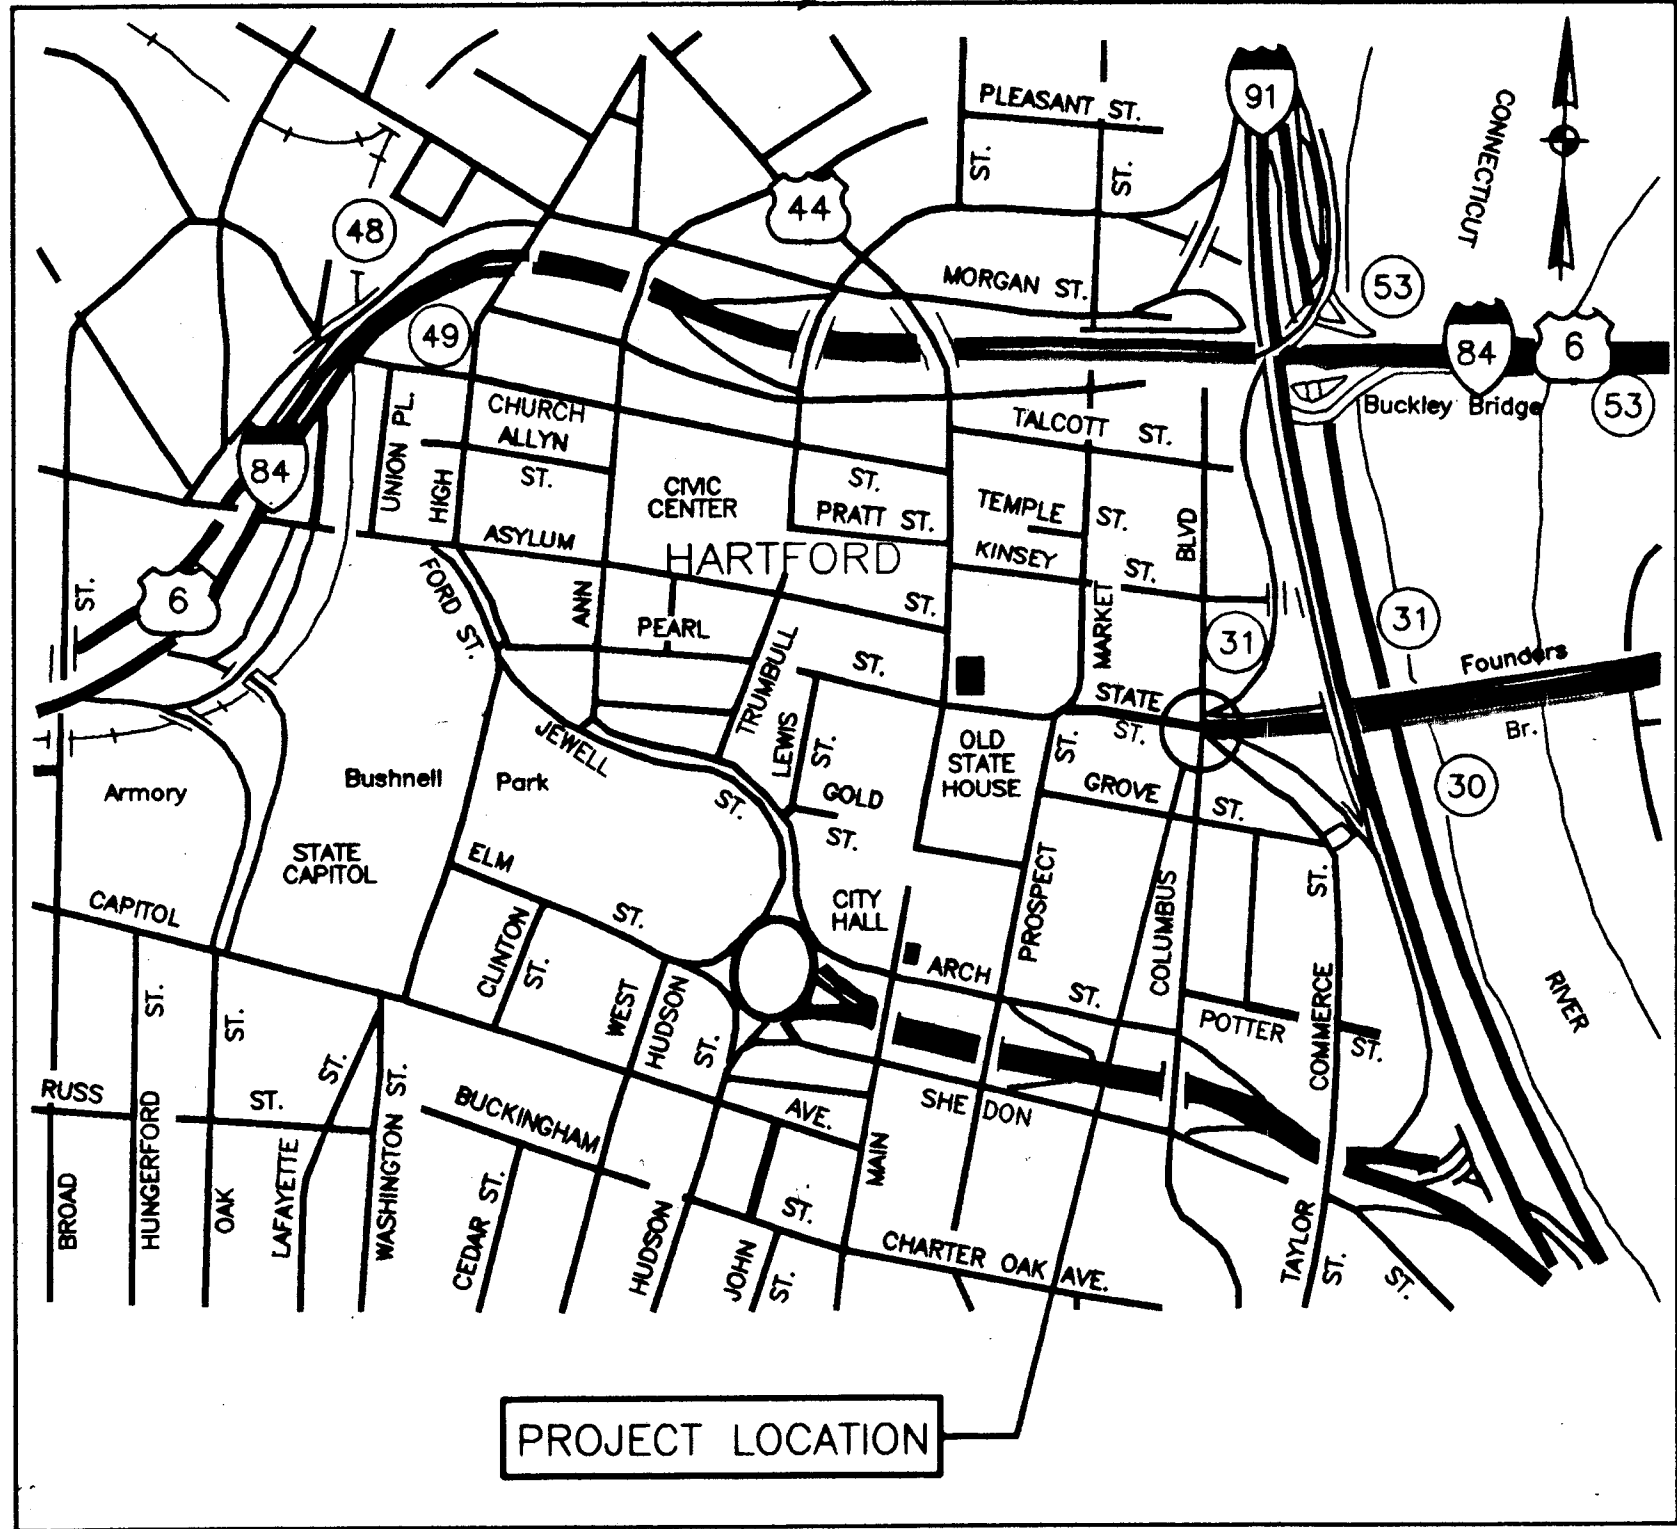


LOCATION MAP

CITY OF
HARTFORD
PLAN
FOR
PEDESTRIAN BRIDGE OVER
COLUMBUS BOULEVARD
AND
ACCESS RAMP TO
CONSTITUTION PLAZA


TOWNS	ROUTE NO.	FED. AID PROJ. NO.	PROJECT NO.	TOTAL LENGTH	DESCRIPTION
HARTFORD	TR	TEA-PEDS(40)	63-529	41 METERS	PEDESTRIAN BRIDGE O/COLUMBUS BLVD.

TO BE MAINTAINED BY THE CITY OF HARTFORD
SCALES AS NOTED

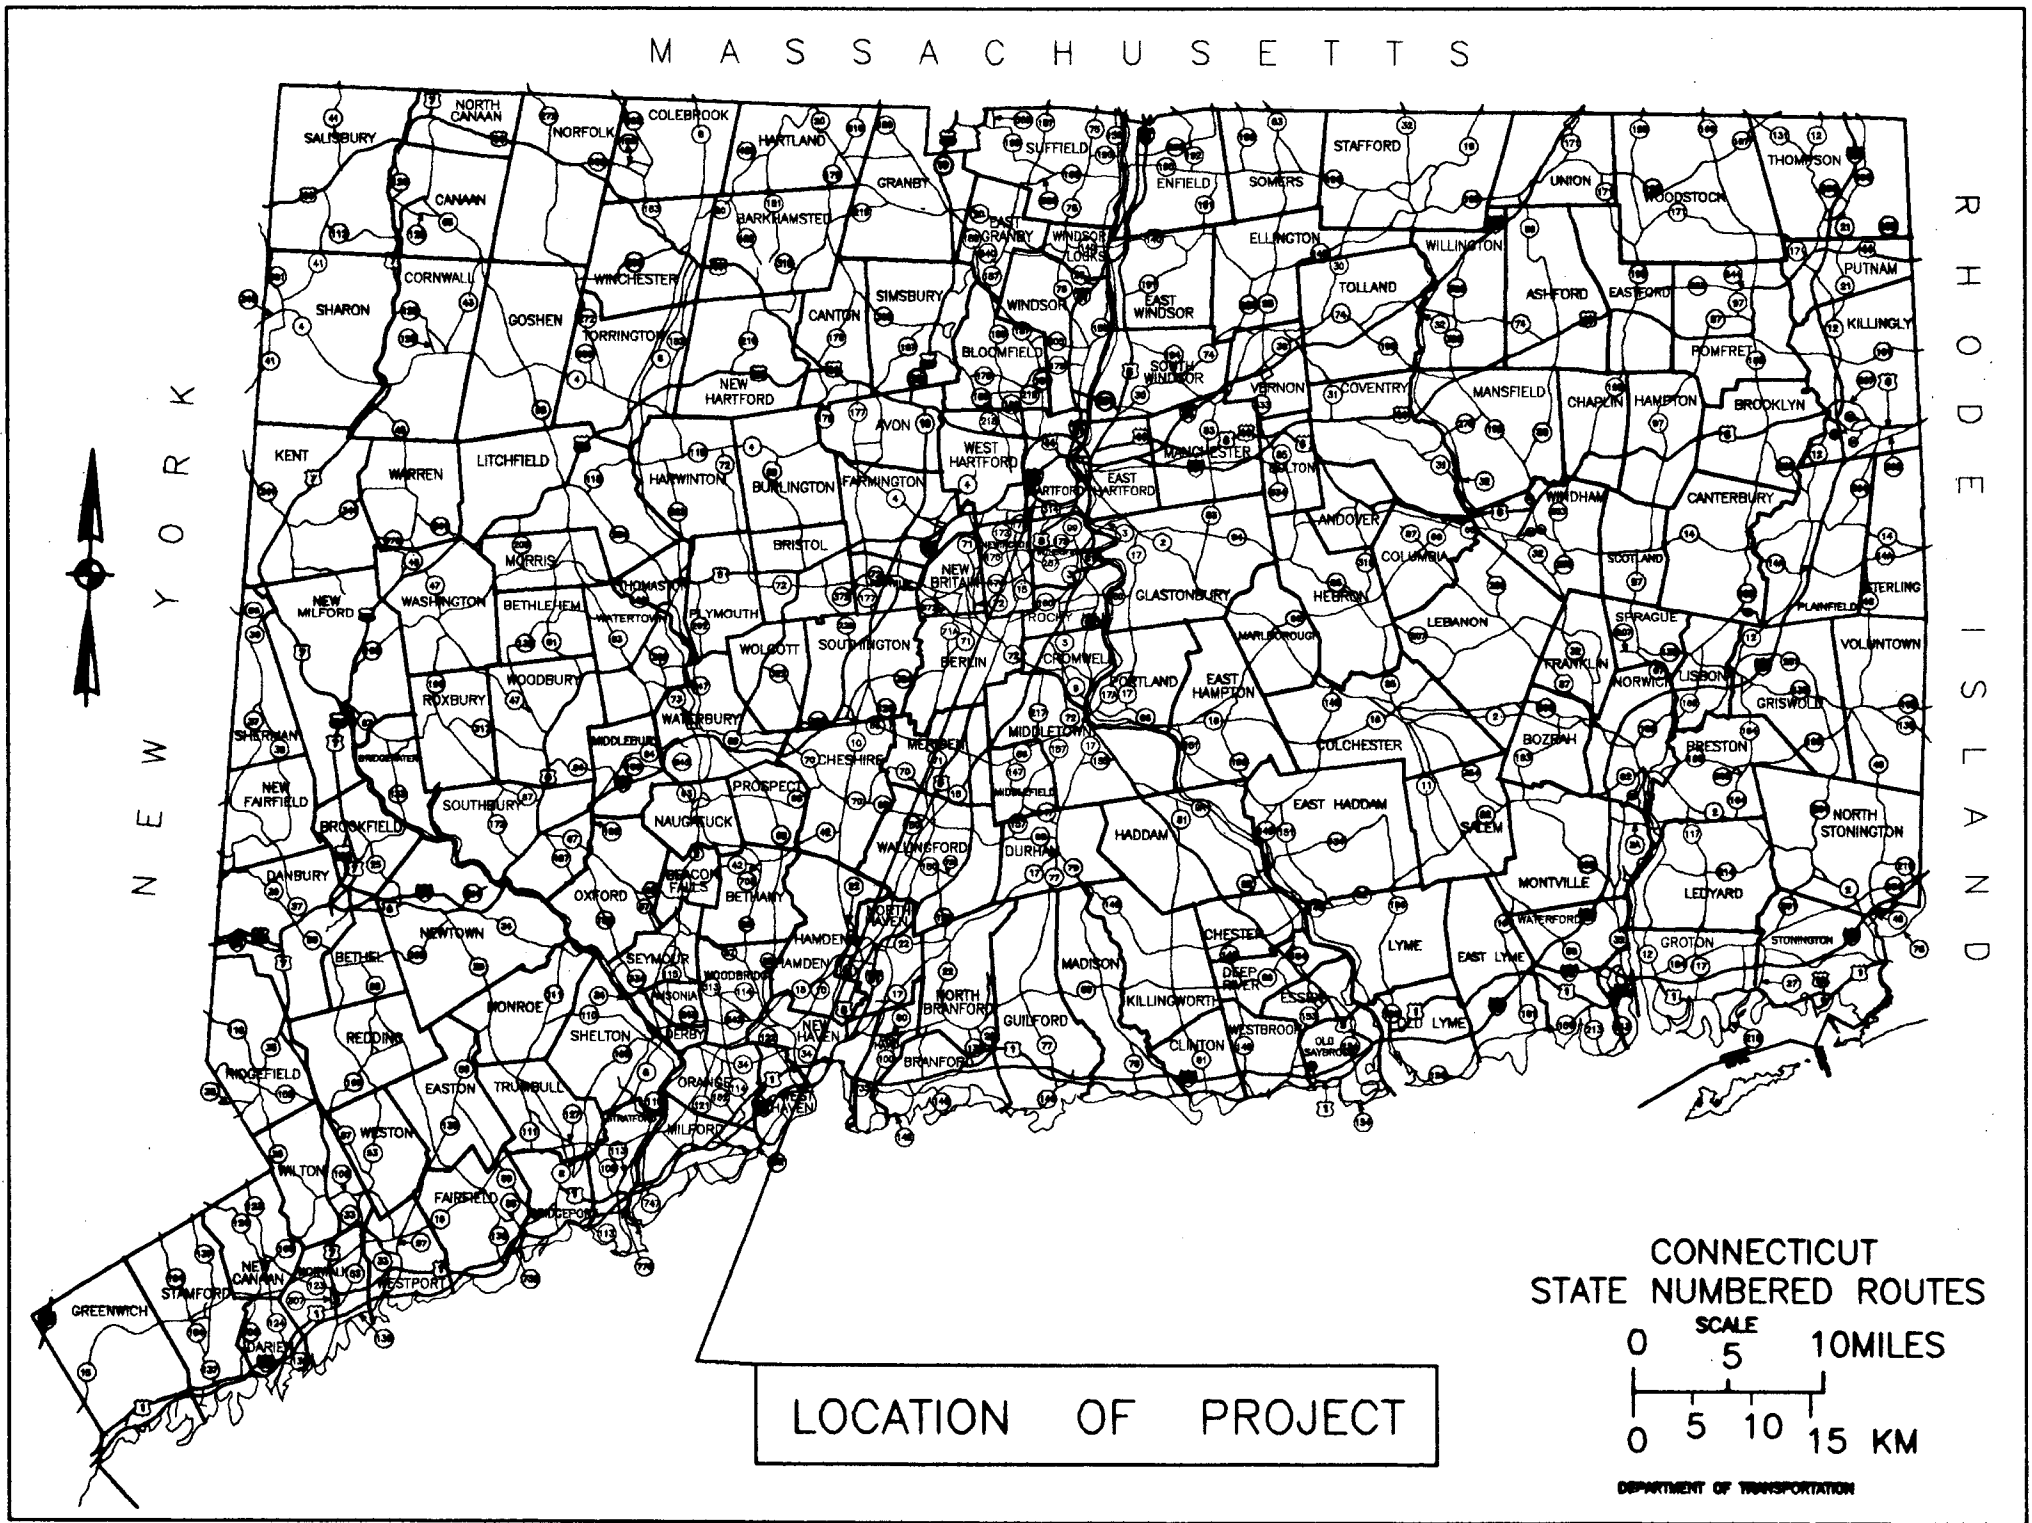

CONNECTICUT LOCATION PLAN


1995 SPECIFICATIONS, FORM 815 GOVERN, INCLUDING SUPPLEMENT DATED THERETO JULY 1999.
ALL ELEVATIONS ON THIS PROJECT BASED ON NATIONAL GEODETIC VERTICAL DATUM - 1929.

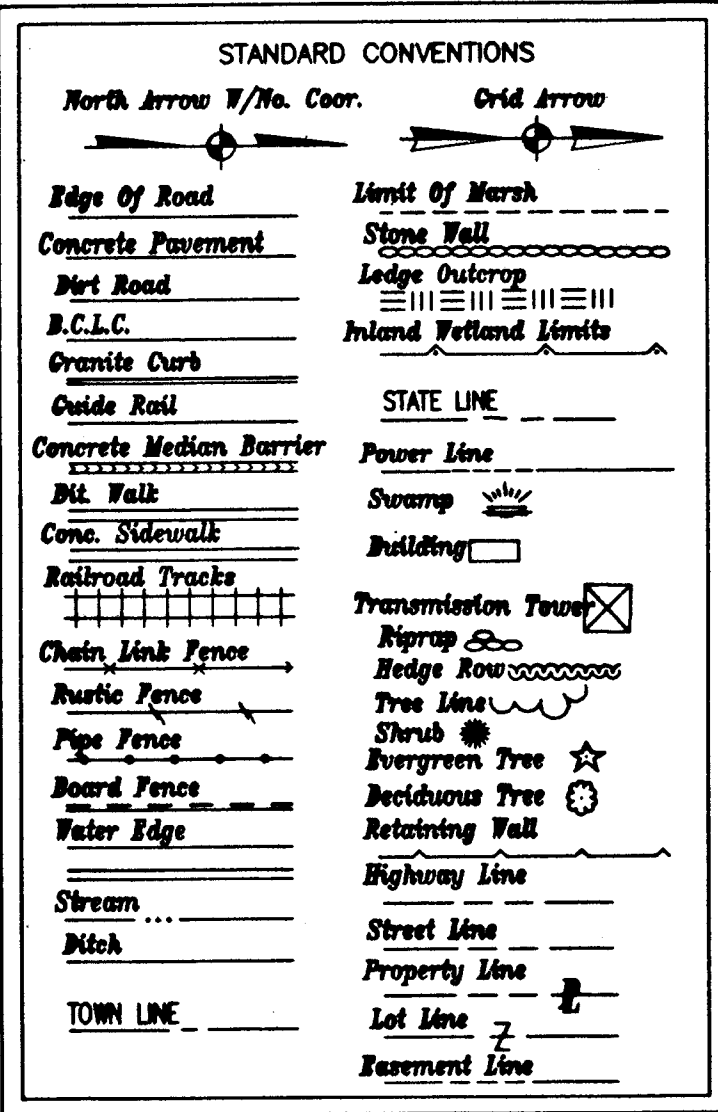

PEDESTRIAN BRIDGE - LIST OF DRAWINGS		HANDICAP ACCESS RAMP - LIST OF DRAWINGS		STANDARD DRAWINGS		F.H.W.A. APPROVAL DATE
SHEET NO.	TITLE	SHEET NO.	TITLE	DWG. NO.	TITLE	
1	TITLE SHEET	40	ACCESS RAMP - EXISTING SITE PLAN	M-601-A	FIGURES FOR DATES ON BRIDGE PARAPETS	9/21/95
2	DETAILED ESTIMATE SHEET	41	ACCESS RAMP - DEMOLITION PLAN	M-811-A	CURBING	9/21/95
3	PEDESTRIAN BRIDGE - SITE PLAN	42	ACCESS RAMP - PROPOSED SITE PLAN			
4-5	SIGN LAYOUT & DETOUR	43	BORING LOGS			
6	GENERAL PLAN 1	44	DEMOLITION SECTIONS			
7	GENERAL PLAN 2	45	FRAMING PLAN			
8	BORING LOGS	46	PROPOSED RAMP SECTIONS - I			
9	EXISTING EAST PIER #1	47	PROPOSED RAMP SECTIONS - II			
10	NEW WEST PIER	48	END OF RAMP SECTIONS AND DETAILS			
11	SUBSTRUCTURE DETAILS	49	SECTIONS AND DETAILS			
12	EXISTING PHOENIX BUILDING PLANS	50	GENERAL NOTES AND CAISSON DETAILS			
13	PHOENIX BUILDING DETAILS	51	PROPOSED SOUTH ELEVATION			
14	PRECAST DETAILS	52	PROPOSED NORTH ELEVATION			
15	FRAMING PLAN	53	EXISTING SOUTH ELEVATION			
16	GIRDER DETAILS	54	EXISTING NORTH ELEVATION			
17	STEEL DETAILS 1	55	PRECAST AND GUARDRAIL PLAN			
18	STEEL DETAILS 2	56	GUARDRAIL & CONCRETE WALL ELEVATIONS			
19	STEEL DETAILS 3	57	PRECAST AND GUARDRAIL DETAILS			
20	EXPANSION JOINT AND BEARING DETAILS	58	ACCESS RAMP ELECTRICAL PLAN			
21	SLAB PLAN					
22	SLAB DETAILS					
23	GRADING AND DRAINAGE PLAN					
24	SCUPPER DETAILS					
25	ARCHITECTURAL ANCHOR PLATE DETAILS					
26	TOWER CAP '1' DETAILS					
26a	TOWER CAP '2' DETAILS					
27-28	ARCHITECTURAL ELEVATION & DETAILS					
29	ALUMINUM FASCIA PANEL DETAILS					
30	ALUMINUM AND GLASS GUARD					
31	STONE AND ASPHALT PAVING					
32	LIGHTING PLAN					
33	SCHEDULE AND DETAILS					
34-39	MISCELLANEOUS DETAILS					

TOWN: 63
PROJECT: 529

METRIC PROJECT

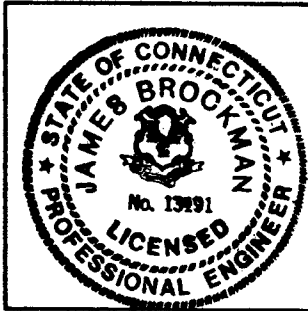

DESIGNED BY: MACCHI ENGINEERS, LLC
SUBMITTED *James Brookman* DATE 9-17-99

RIVERFRONT RECAPTURE, INC.
Joseph Marfugli EXECUTIVE DIRECTOR DATE 9/14/95