



1. THE CONTRACTOR SHALL BE RESPONSIBLE FOR FIELD VERIFICATION OF HAZARDOUS MATERIAL QUANTITIES. QUANTITIES PROVIDED IN THE SPECIFICATION ARE ESTIMATES ONLY. ACTUAL FIELD CONDITIONS MAY VARY.
2. THE CONTRACTOR SHALL BE RESPONSIBLE FOR PERFORMING ENOUGH DEMOLITION TO ACCESS AND REMOVE ALL ASBESTOS-CONTAINING PIPE AND PIPE FITTING INSULATION. DEMOLITION WORK WILL BE PERFORMED BY THE CONTRACTOR ONLY AFTER ENGINEERING CONTROLS HAVE BEEN ESTABLISHED AND ACTIVATED.
3. THE CONTRACTOR SHALL REMOVE ALL ASBESTOS-CONTAINING MATERIALS FROM THE BUILDING AND DISPOSE OF AS ASBESTOS WASTE.
4. THE CONTRACTOR SHALL REMOVE LAMPS AND BALLASTS FROM ALL FLUORESCENT LIGHT FIXTURES PRIOR TO ASBESTOS ABATEMENT IN EACH PHASE. THESE MATERIALS SHALL BE DISPOSED OF AS MERCURY AND PCB-CONTAINING WASTES RESPECTIVELY.

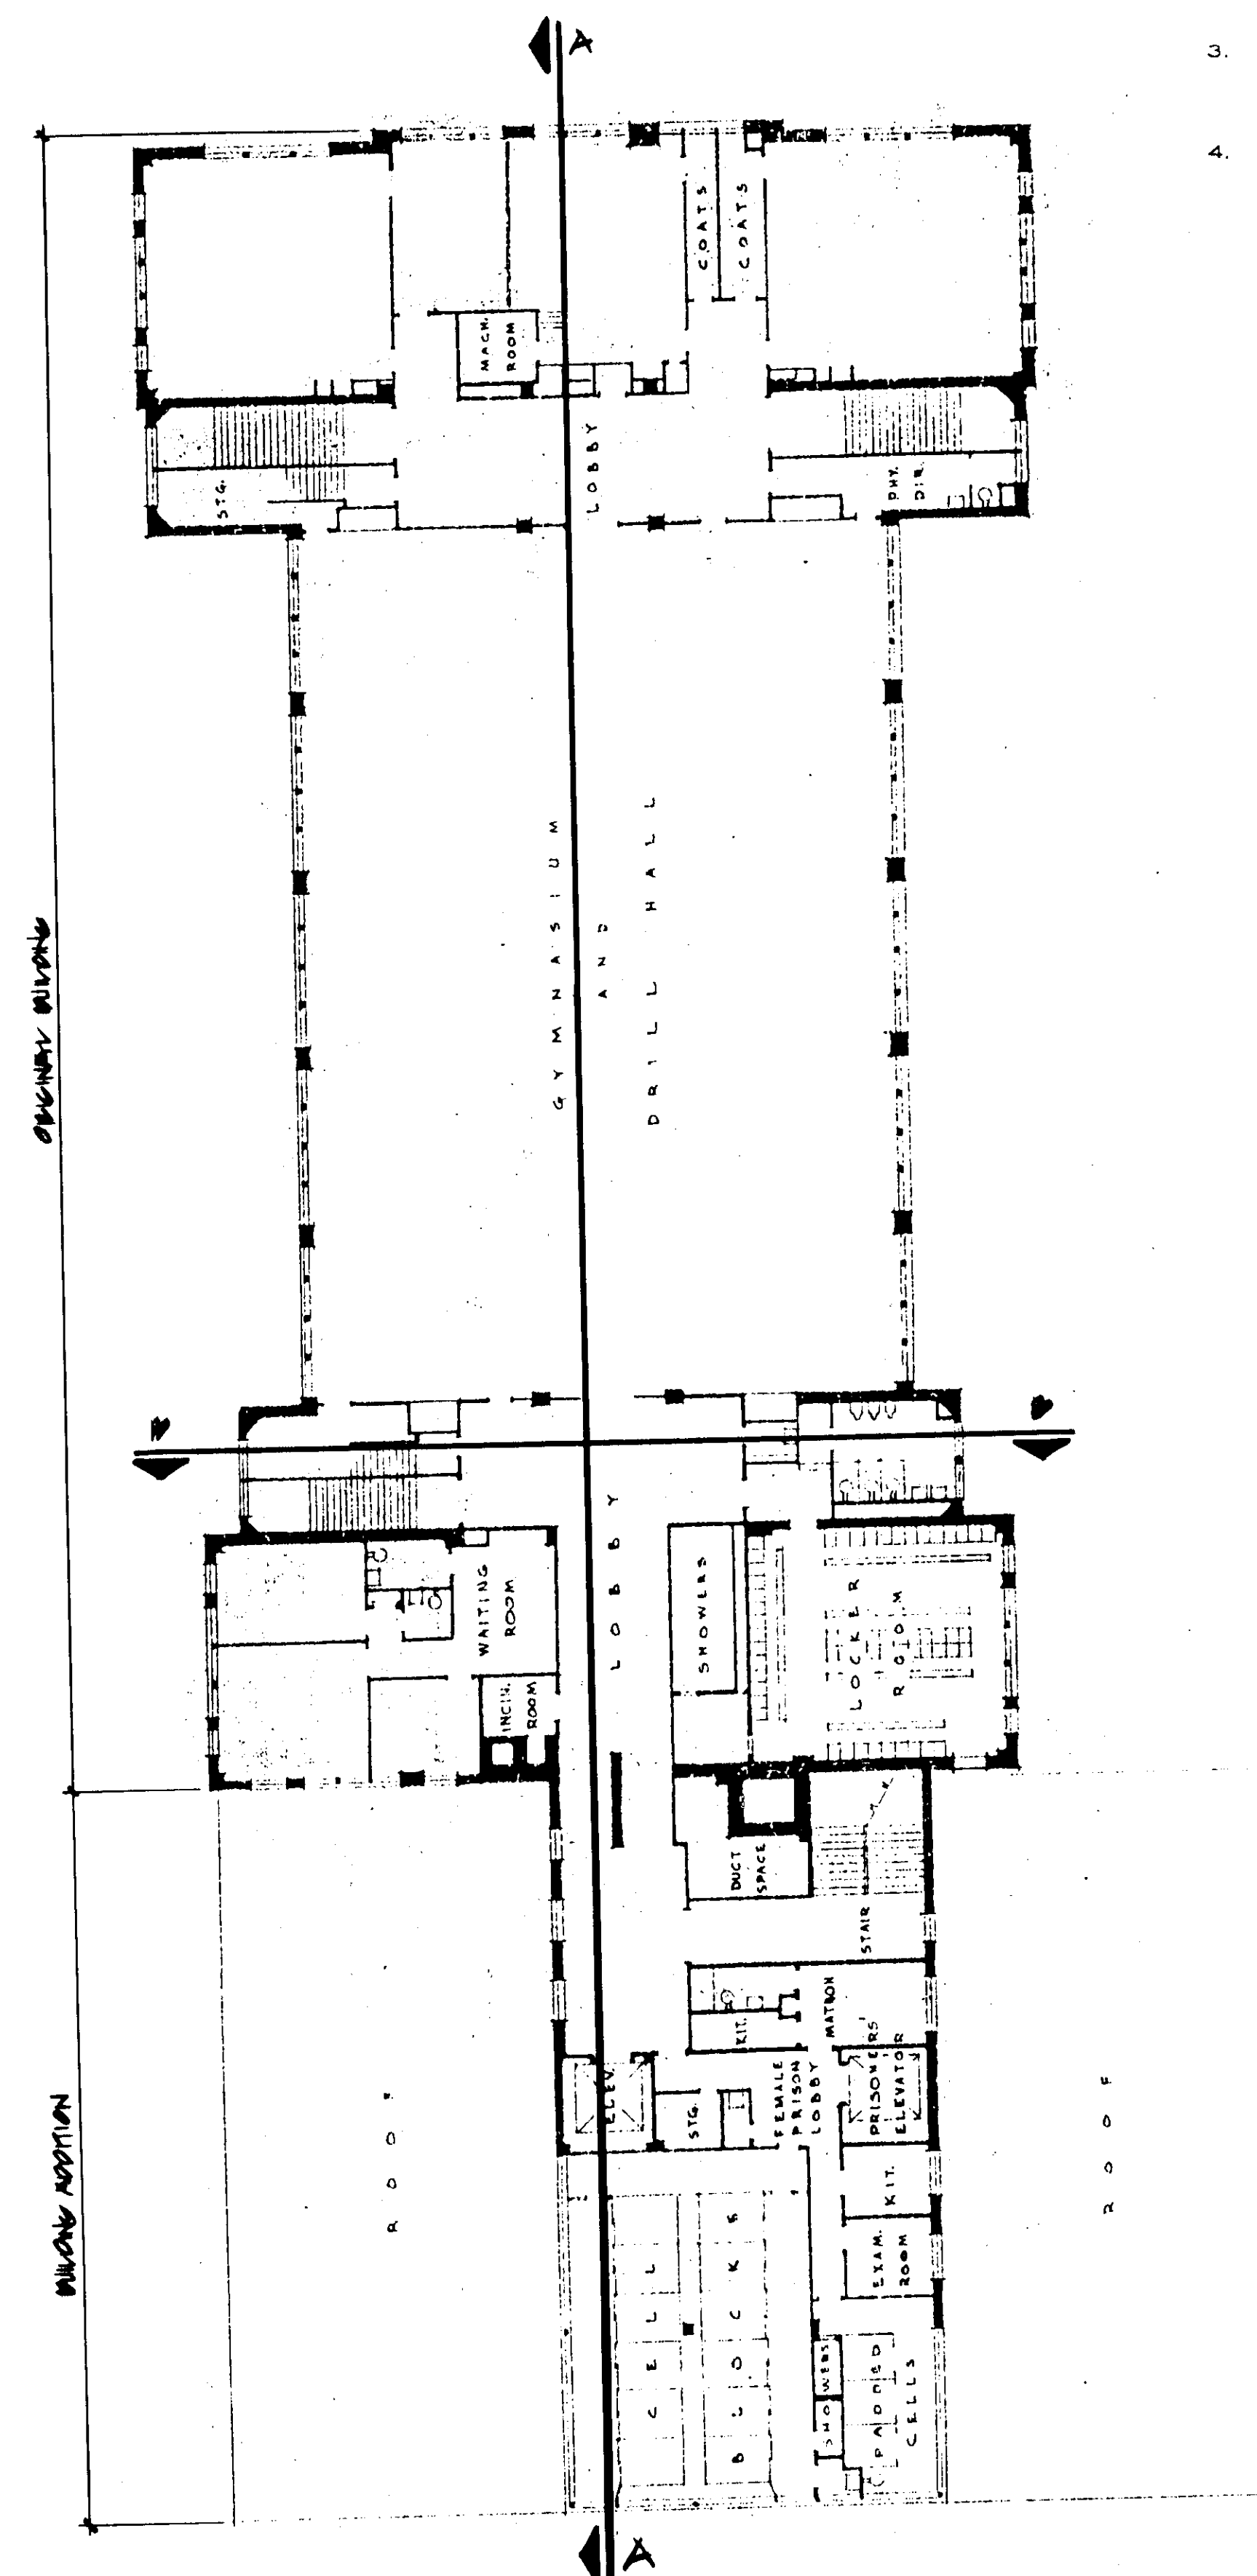

FOURTH FLOOR PLAN

SPECIAL NOTE:

CONTRACTOR SHALL BE RESPONSIBLE FOR THE RELOCATION OF ONE (1) STEEL CELL (APPROX. 7' w x 10' d x 8' h) TO THE CITY'S POLICE MUSEUM AT 101 PEARL STREET, HARTFORD, CT. RELOCATION INCLUDES CAREFUL CUTTING, DISMANTLING, MOVING, REASSEMBLY AND PAINTING OF THE STEEL WALLS, CEILING, AND BUNKS, ALONG WITH RELOCATION OF ELECTRICAL AND PLUMBING FIXTURES WITHIN A CELL, BUT WITH NO FUNCTIONAL RECONNECTION OF THESE FIXTURES. ANY NEW MASONRY, IF REQUIRED, SHALL BE PROVIDED THROUGH THE CITY DPW PROJECT ADMINISTRATOR.

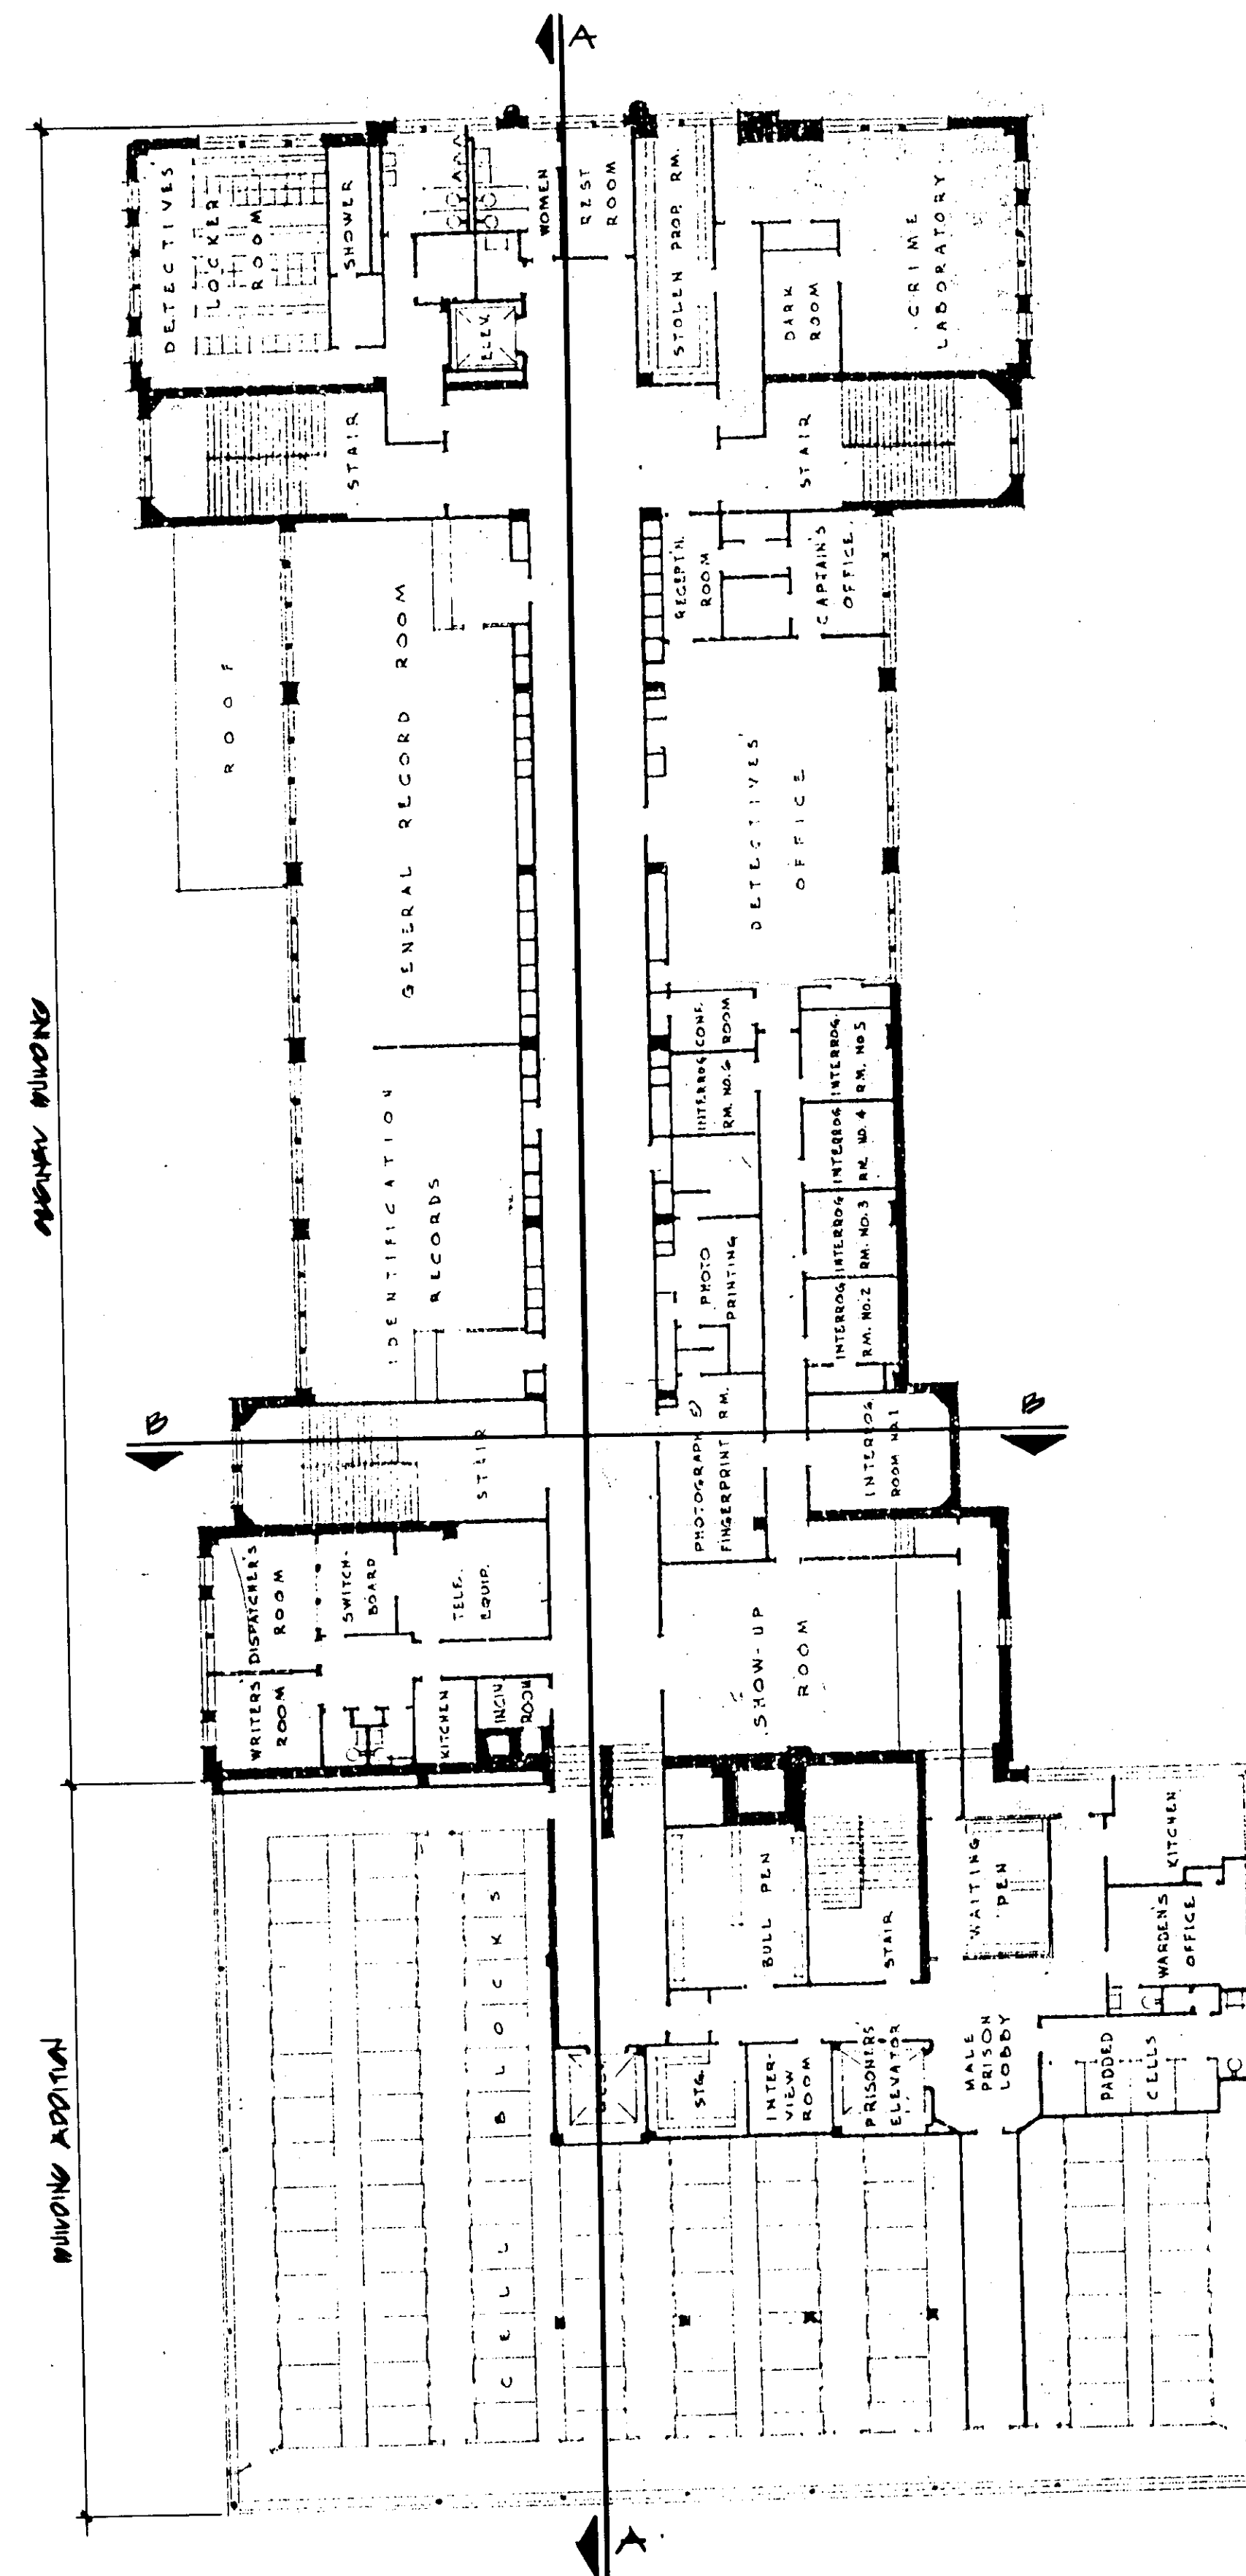

THIRD FLOOR PLAN



Clarke · Tamaccio
ARCHITECTS, P.C.
2074 • PARK • STREET
HARTFORD • CT • 06106 • (203) 233-6238

City of Hartford

**DEMOLITION OF 155 MORGAN STREET
HARTFORD, CT**

SHEET CONTENTS:

THIRD FLOOR PLAN

FOURTH FLOOR PLAN

DATE OF ISSUE: 1 JANUARY 1990

REVISIONS

DRWN BY/CHKD BY:	AUXILIARY No.:
MAT	

SCALE: $1/16" = 1' - 0"$ JOB No.: 90.21

	SHEET No. :

A-3

SHEET 3 OF 6

DAYBOOK NO. 011398