


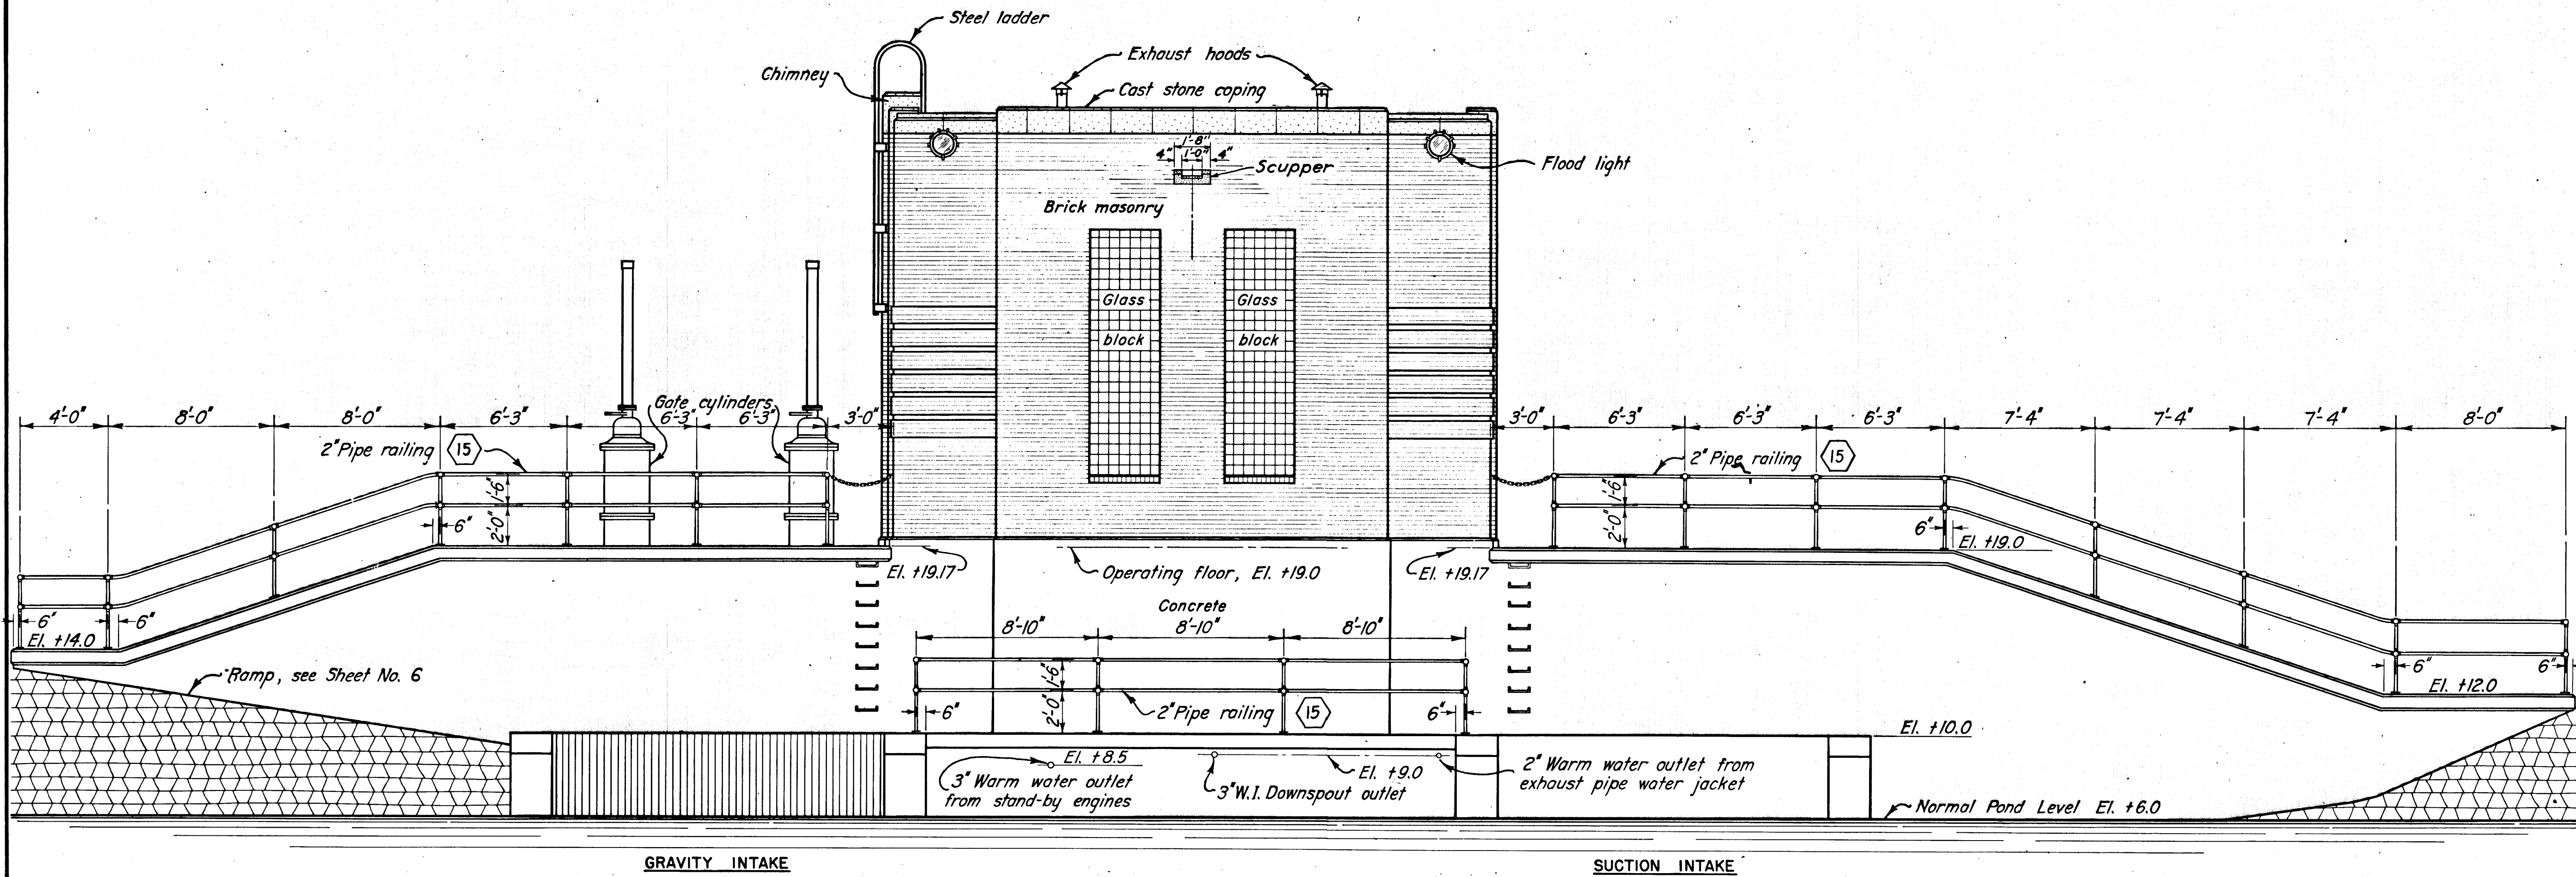

NORTH ELEVATION

SCALE: $\frac{1}{4}'' = 1'-0''$

12-31-45	As built				
DATE	REVISION	REV. BY	CK. BY	AP. BY	

CONNECTICUT RIVER FLOOD CONTROL		
NORTH MEADOWS PUMPING STATION		
FISCAL YEAR 1939 SECTION		
NORTH ELEVATION		
HARTFORD, CONN.		
CONNECTICUT RIVER	SCALE 1/4 IN. = 1 FT.	CONNECTICUT
IN 62 SHEETS		SHEET NO. 11
U.S. ENGINEER OFFICE, PROVIDENCE, R.I. FEB. 1939		
SUBMITTED: David B. Nelson	APPROVAL RECOMMENDED: J. S. Osburne	APPROVED: J. S. Osburne
DESIGNED: E. M. Vetter	CHIEF, P.C. ENGINEERING DIV.	LT. COL. CORPS OF ENGINEERS
DRAWN BY: M. B. Mc	TRACED BY: L. F. D.	FILE NO. CT-4-1259
CHECKED BY: J. B. Mc		