
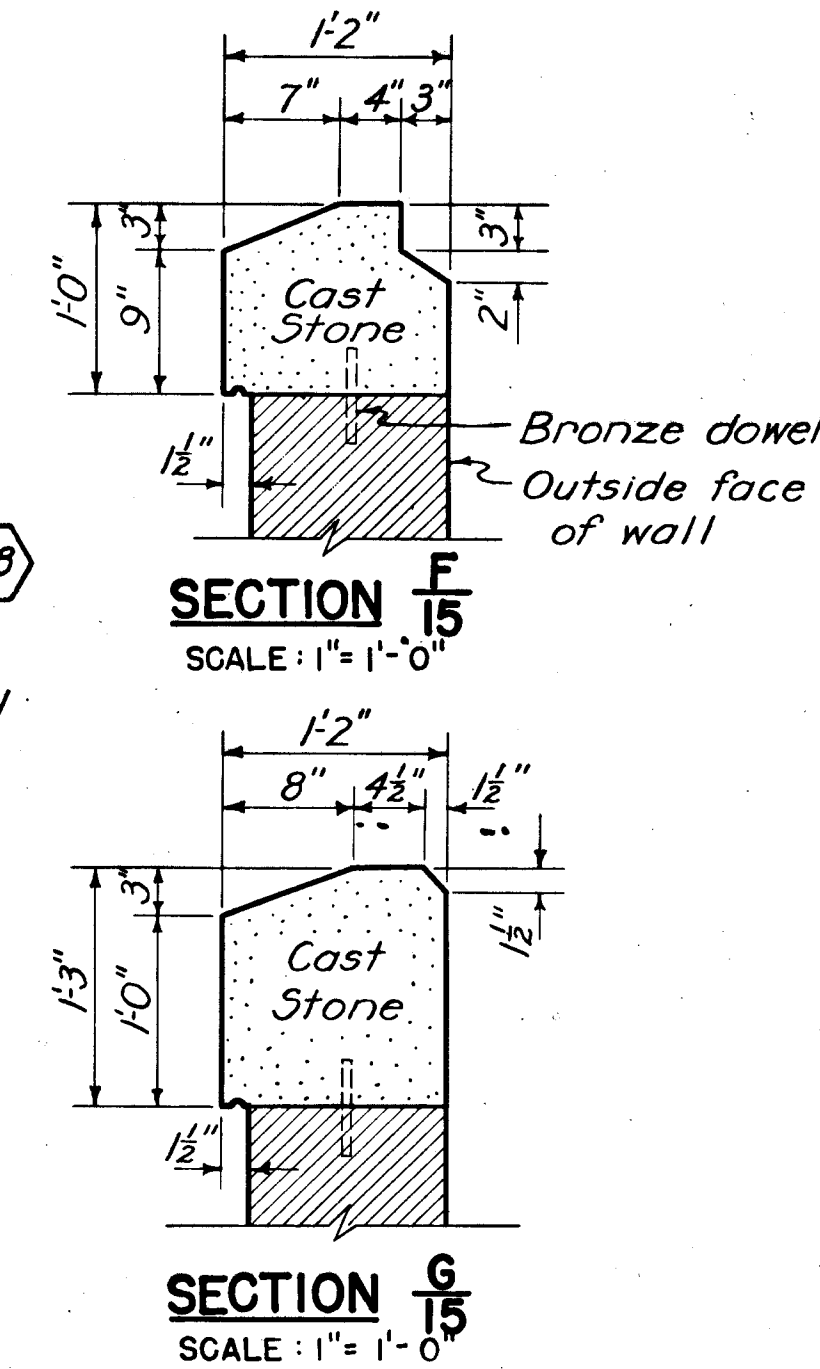
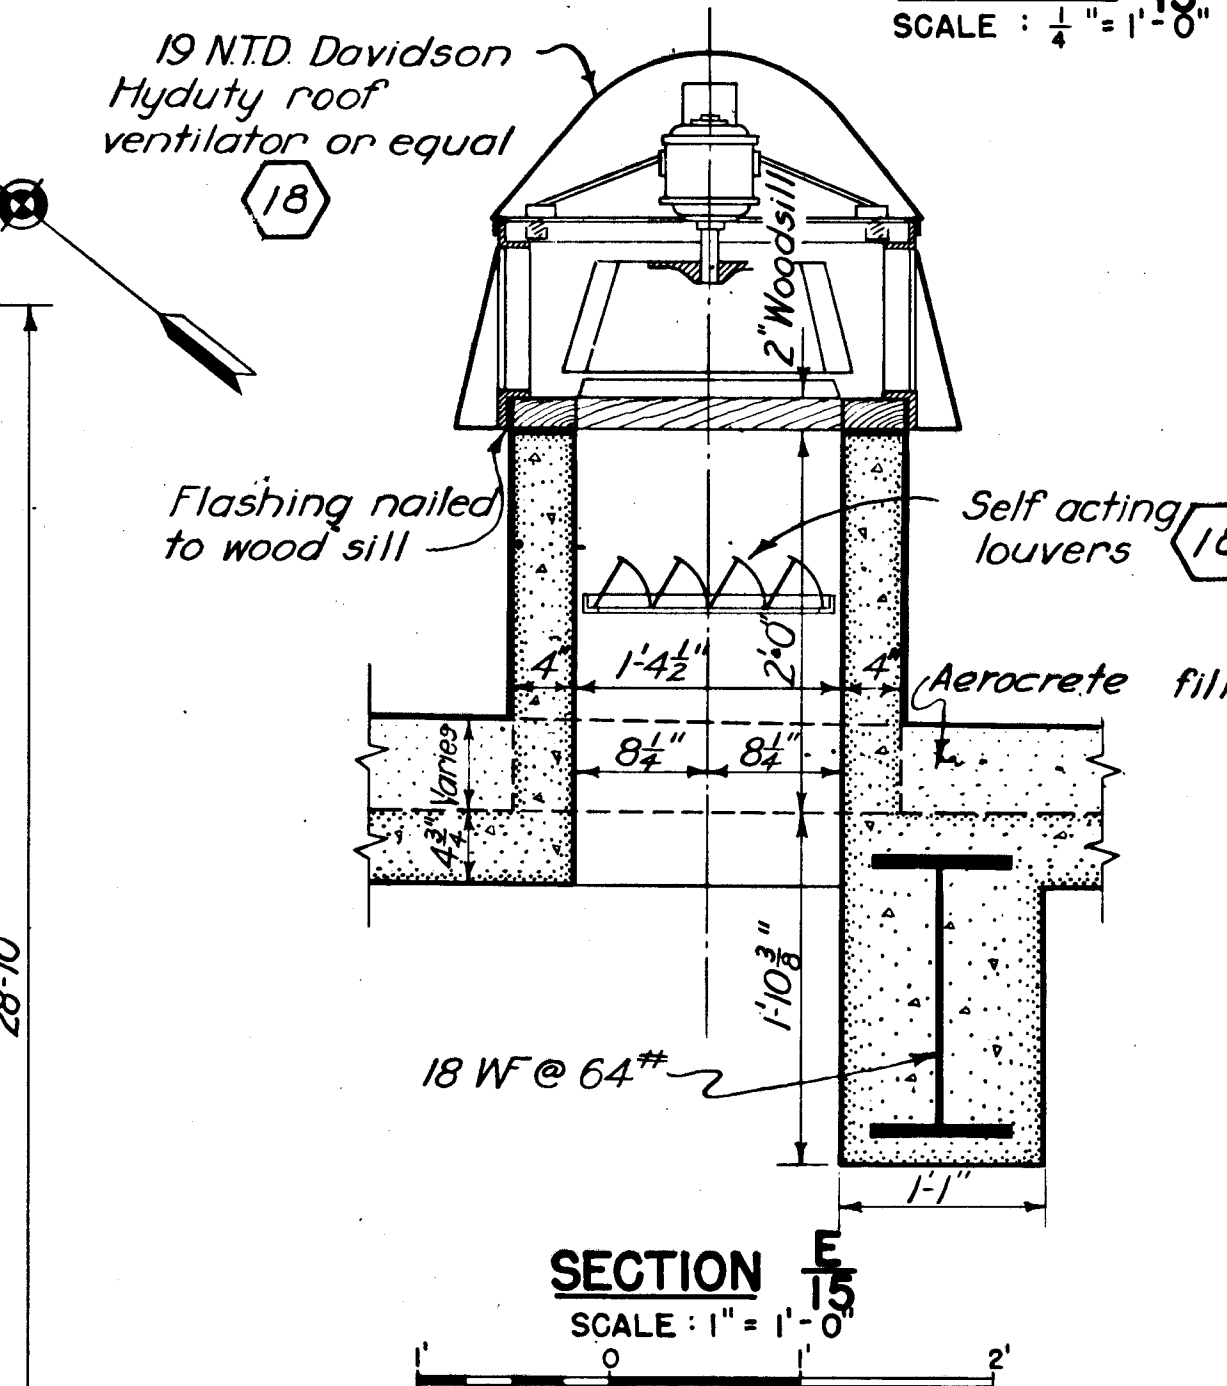
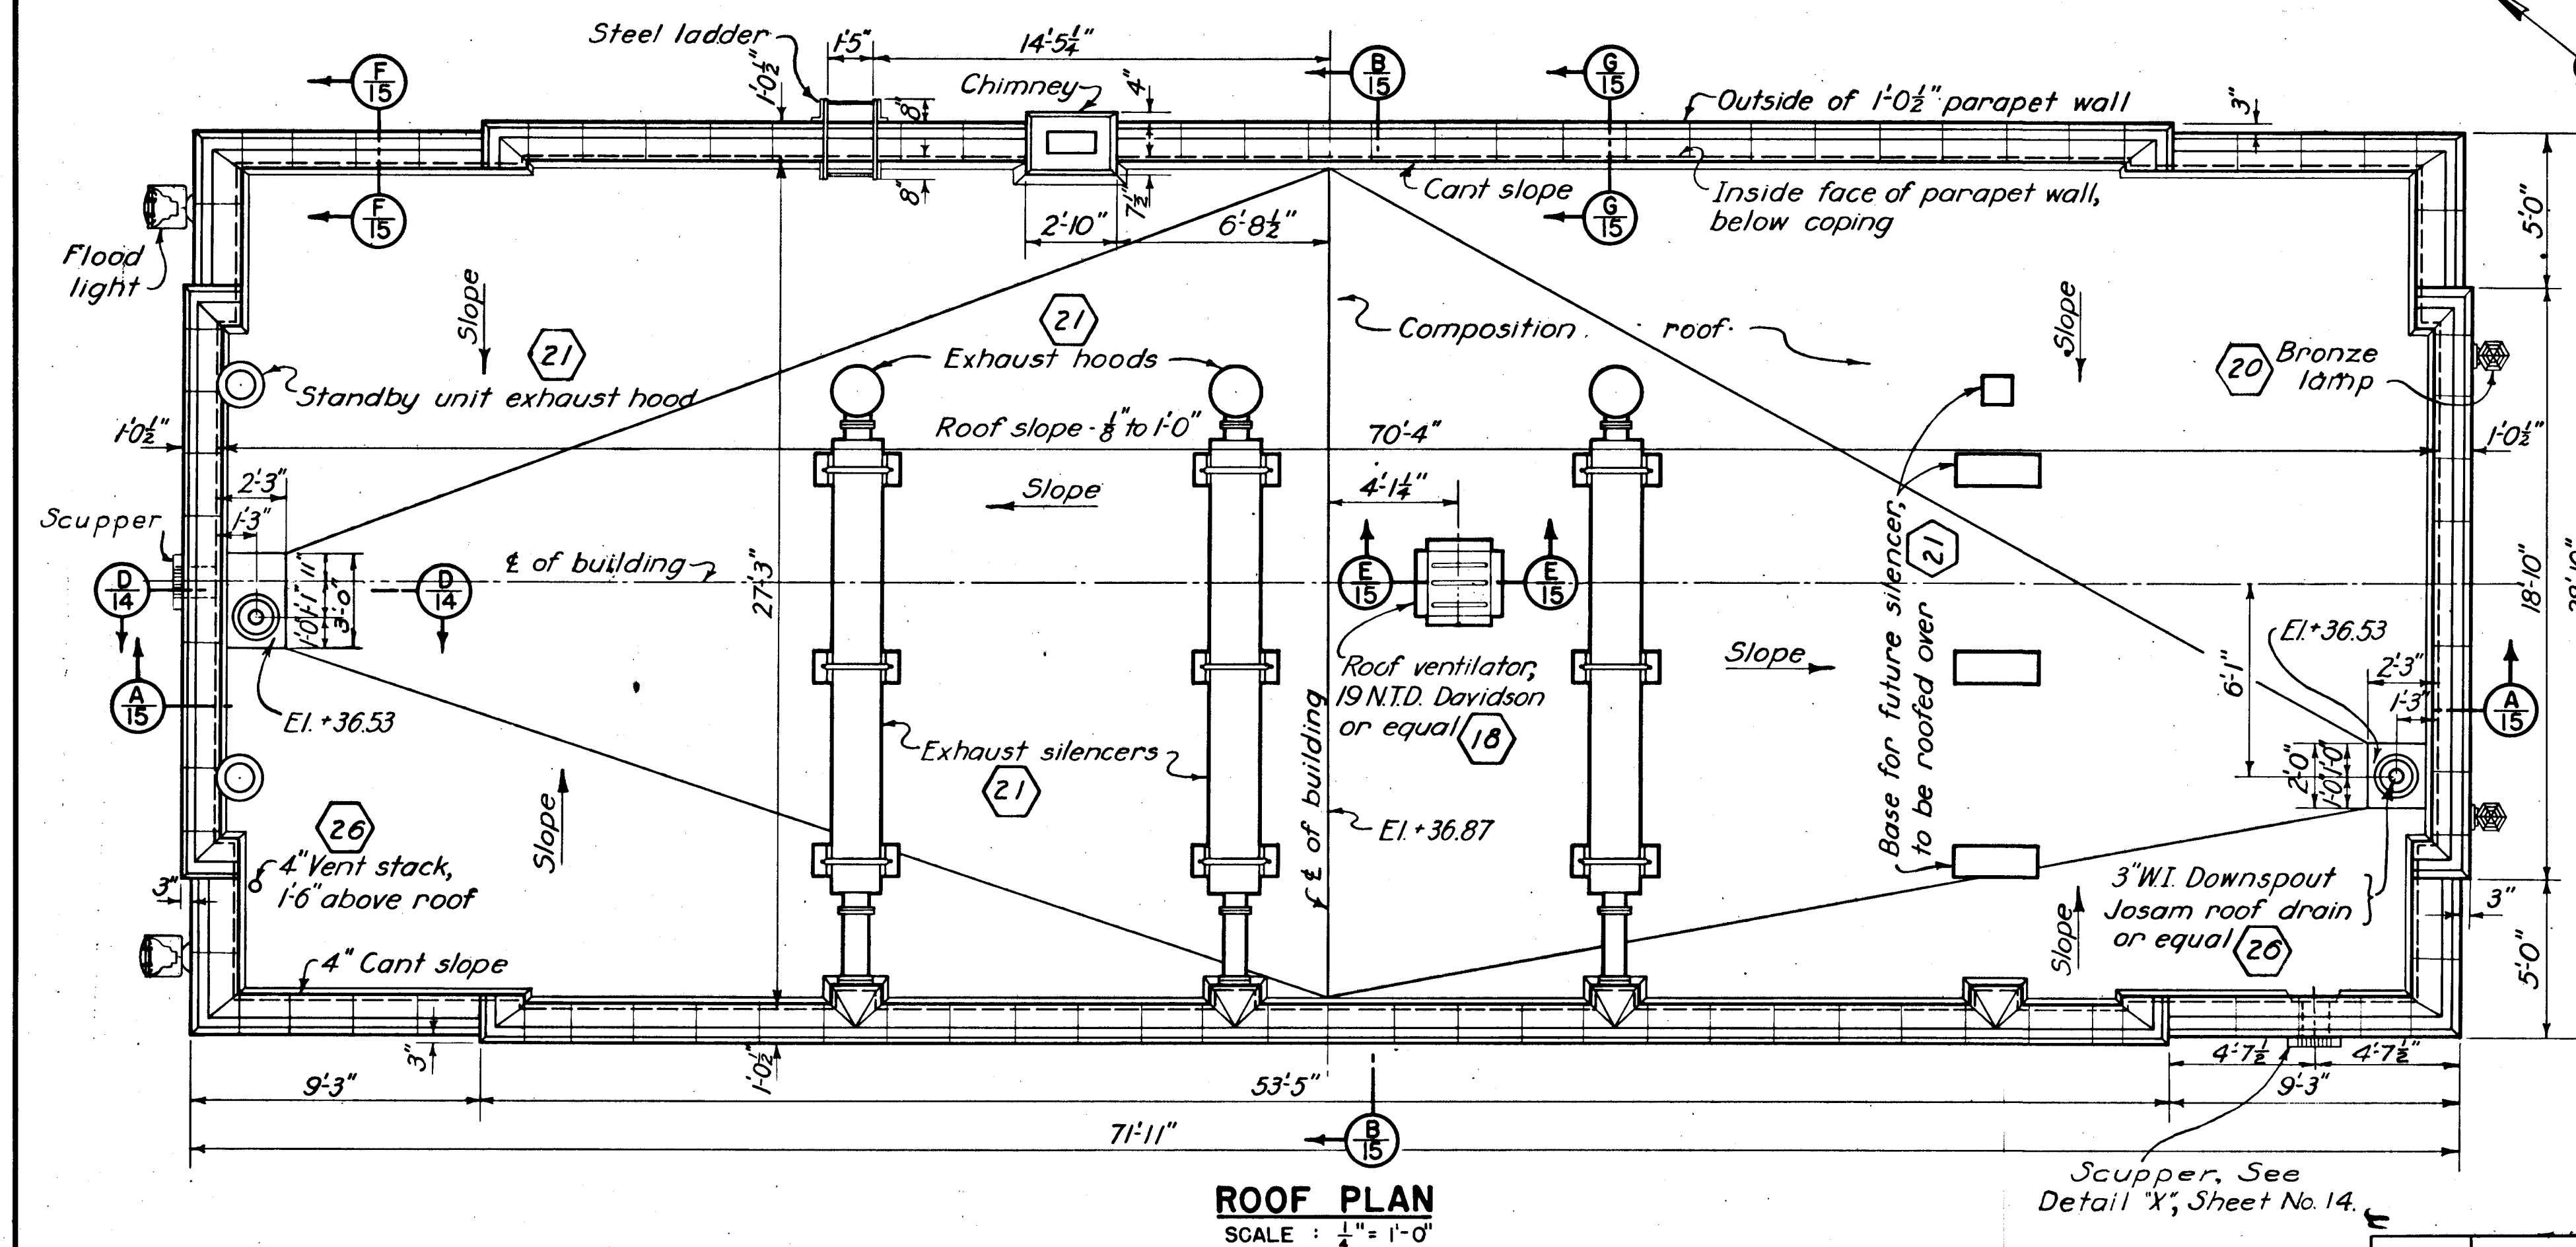
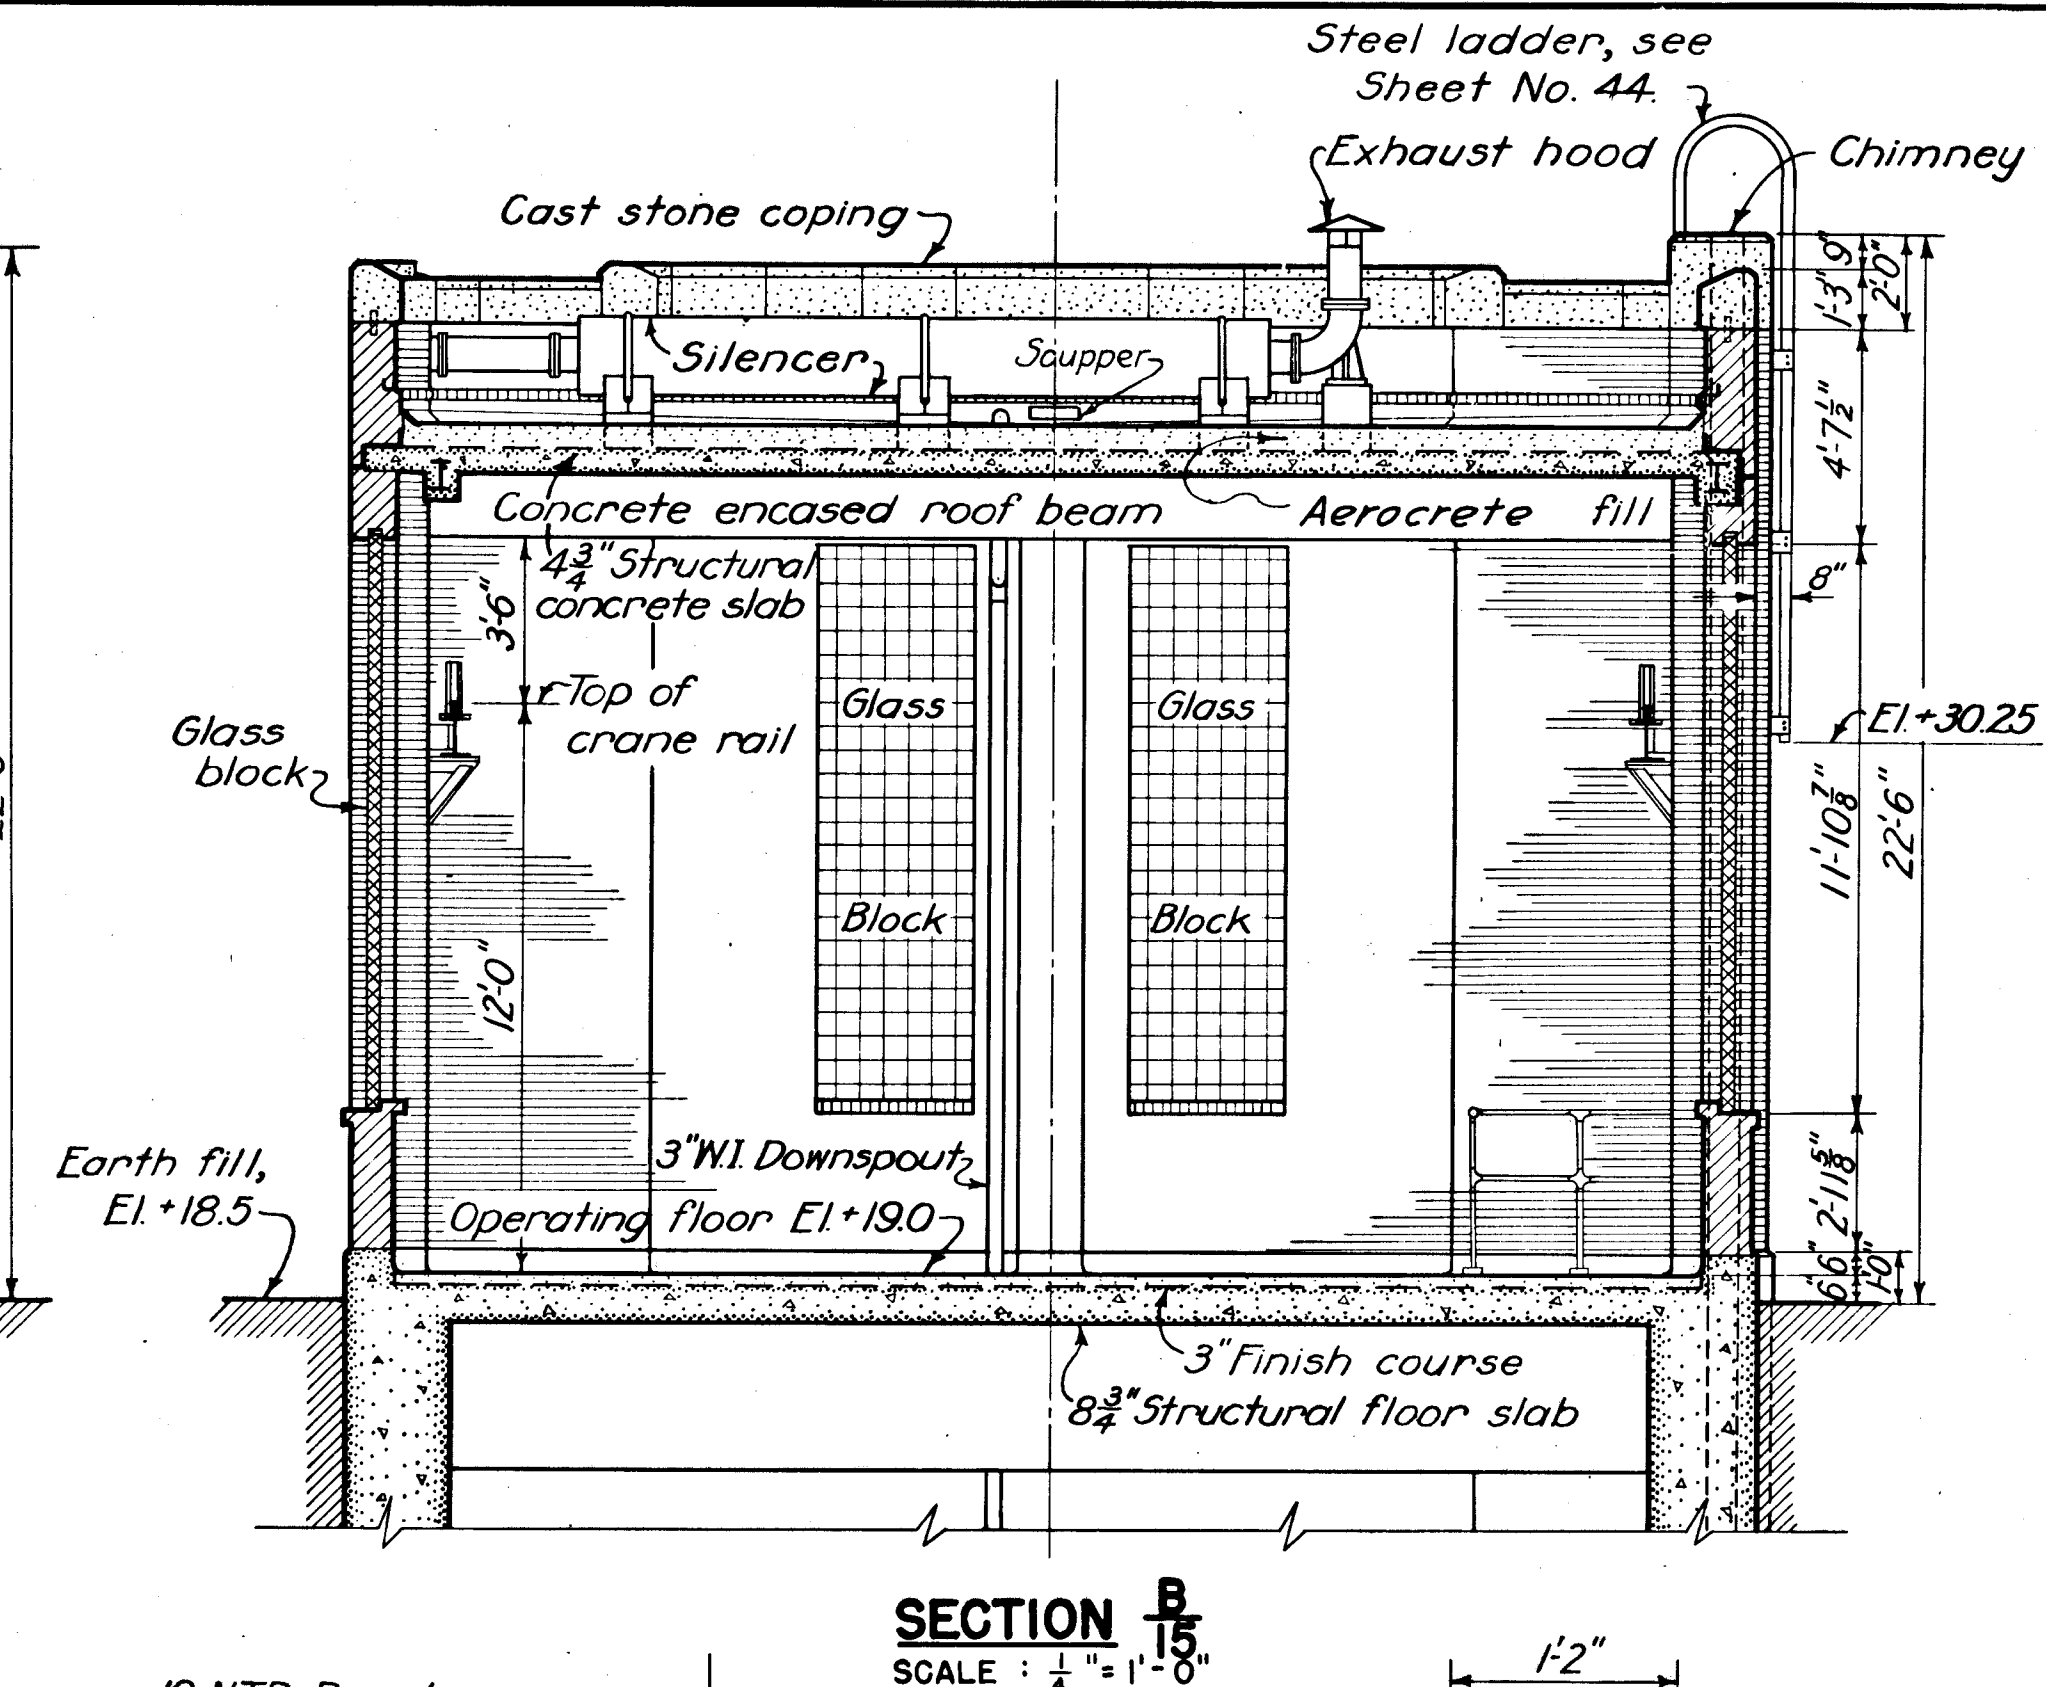


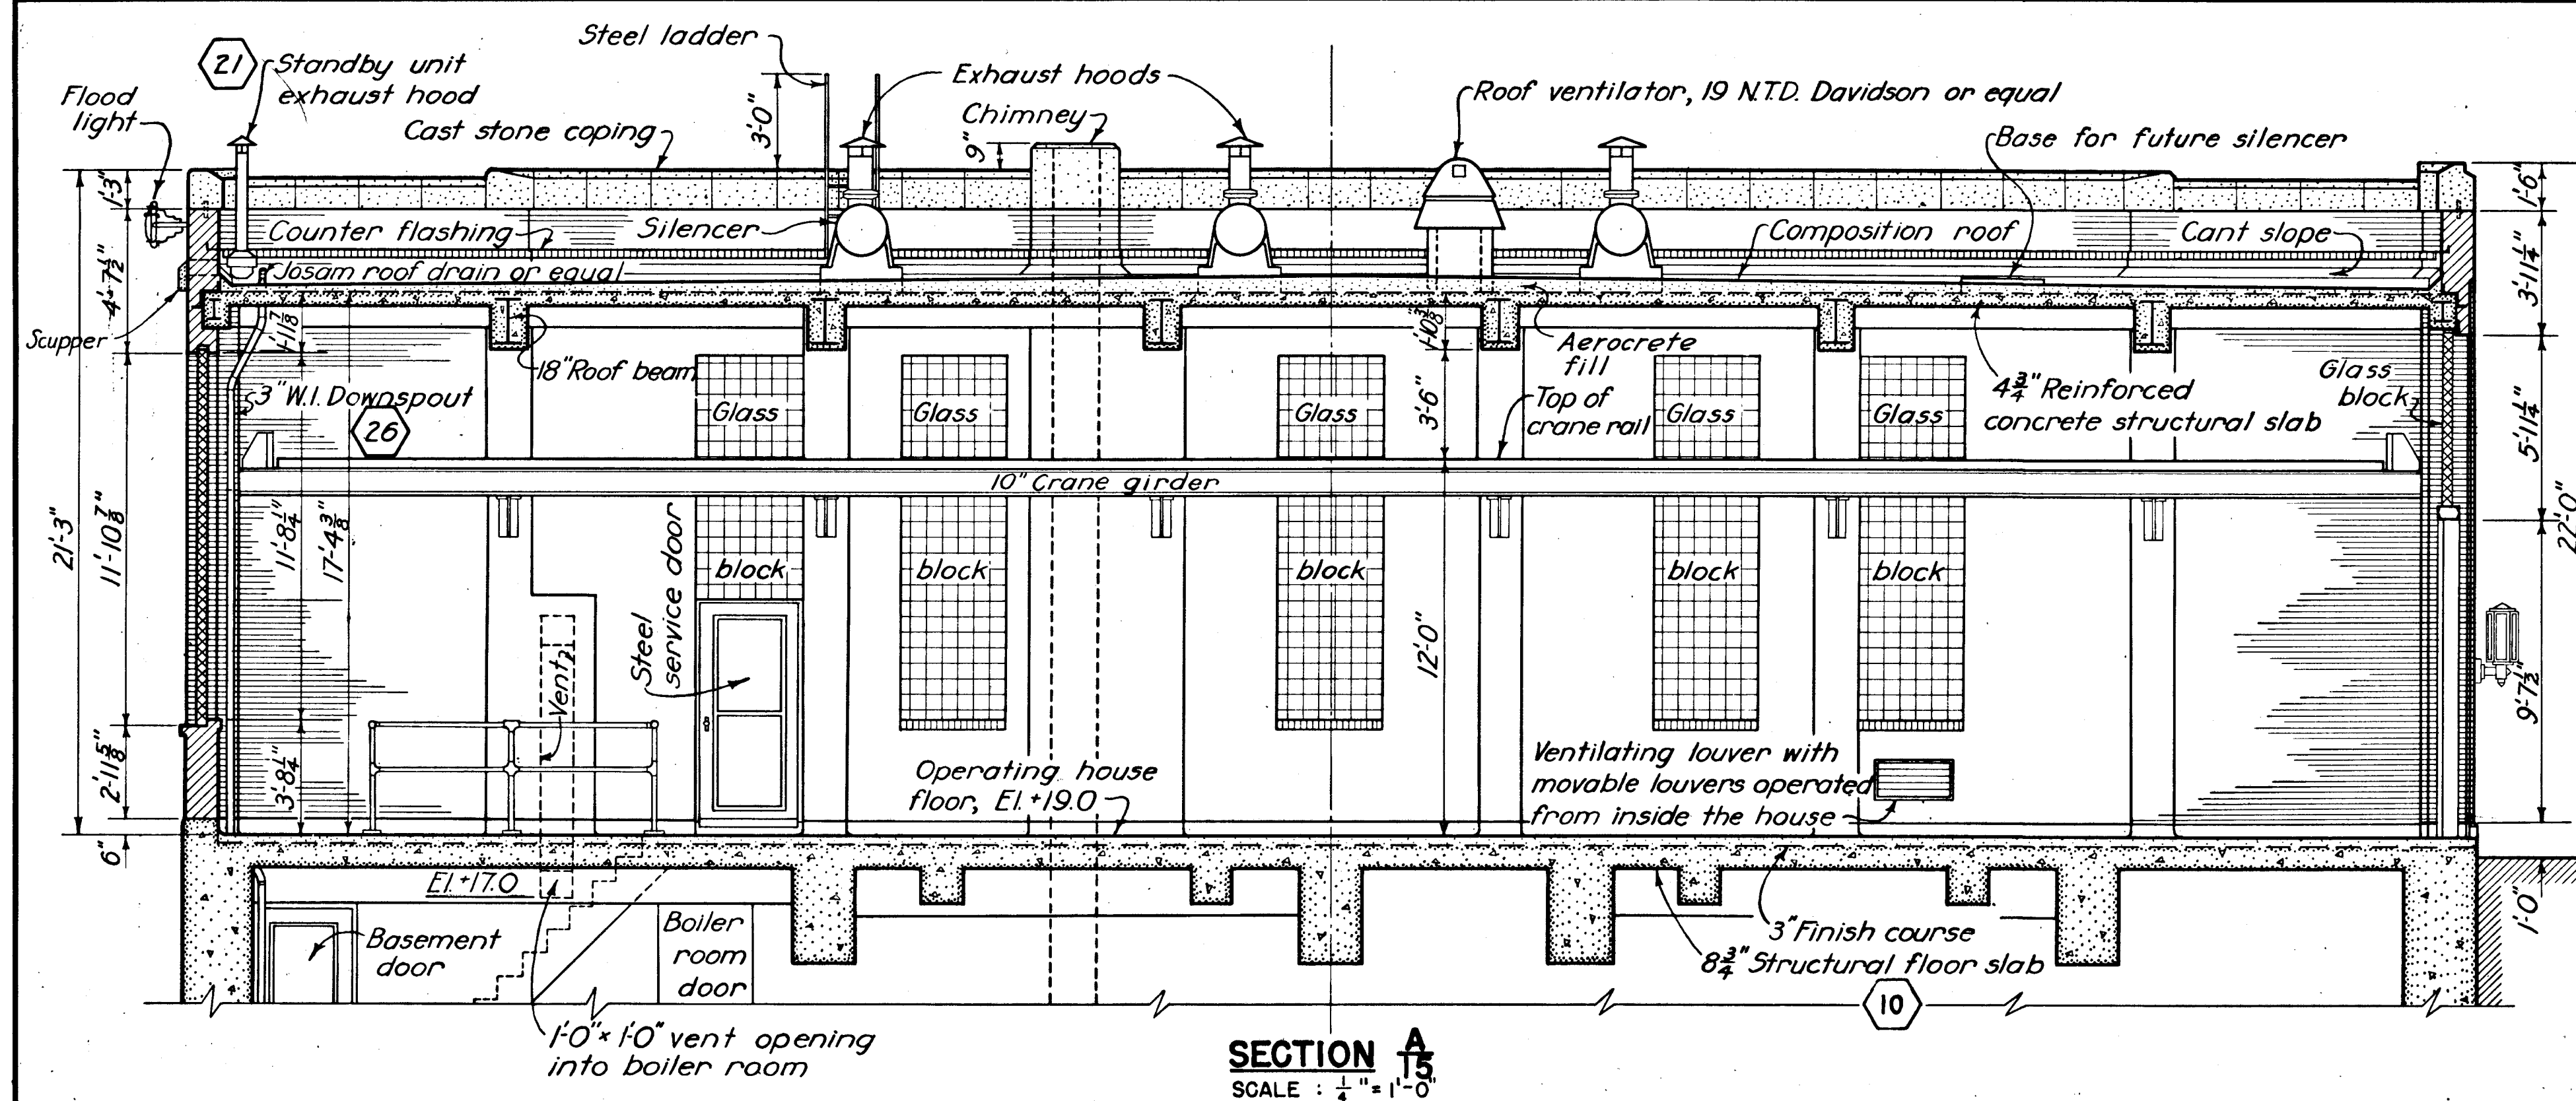

NOTE
Payments to be made under Item No. 12 except as noted.

12/31/45	As built revisions				
DATE	REVISION	REV. BY	CK. BY	AP. BY	

CONNECTICUT RIVER FLOOD CONTROL					
NORTH MEADOWS PUMPING STATION					
FISCAL YEAR 1939 SECTION					
SECTIONS, ROOF PLAN AND DETAILS					
HARTFORD, CONN.					
CONNECTICUT RIVER			CONNECTICUT		
IN 62 SHEETS			SCALE: $\frac{1}{4}'' = 1'-0''$		
U.S. ENGINEER OFFICE, PROVIDENCE, R.I.			FEB. 1939		
SUBMITTED: <i>Edward B. Sullivan</i>		APPROVED: <i>John B. Sullivan</i>		APPROVED: <i>John B. Sullivan</i>	
HEAD, DESIGN SECTION		PRINCIPAL ENGINEER		LT. COL., CORPS OF ENGINEERS	
DESIGNED: <i>E. M. Sullivan</i>		DRAWN BY: <i>N. B. Mc</i>		FILE NO. CT-4-1263	
ASSOC. ENGINEER		CHECKED BY: <i>W. B. Mc</i>			